


L:\Engineering\0318050 SVFDG Summit View Forms 3rd Plat\DRAWINGS\CONSTRUCTION DRAWINGS\PAV-PLANS\PAV-INT-02.dwg, 7/20/2018 10:29:06 AM, DAN MCGHEE, LAMP RYNEARSON & ASSOCIATES

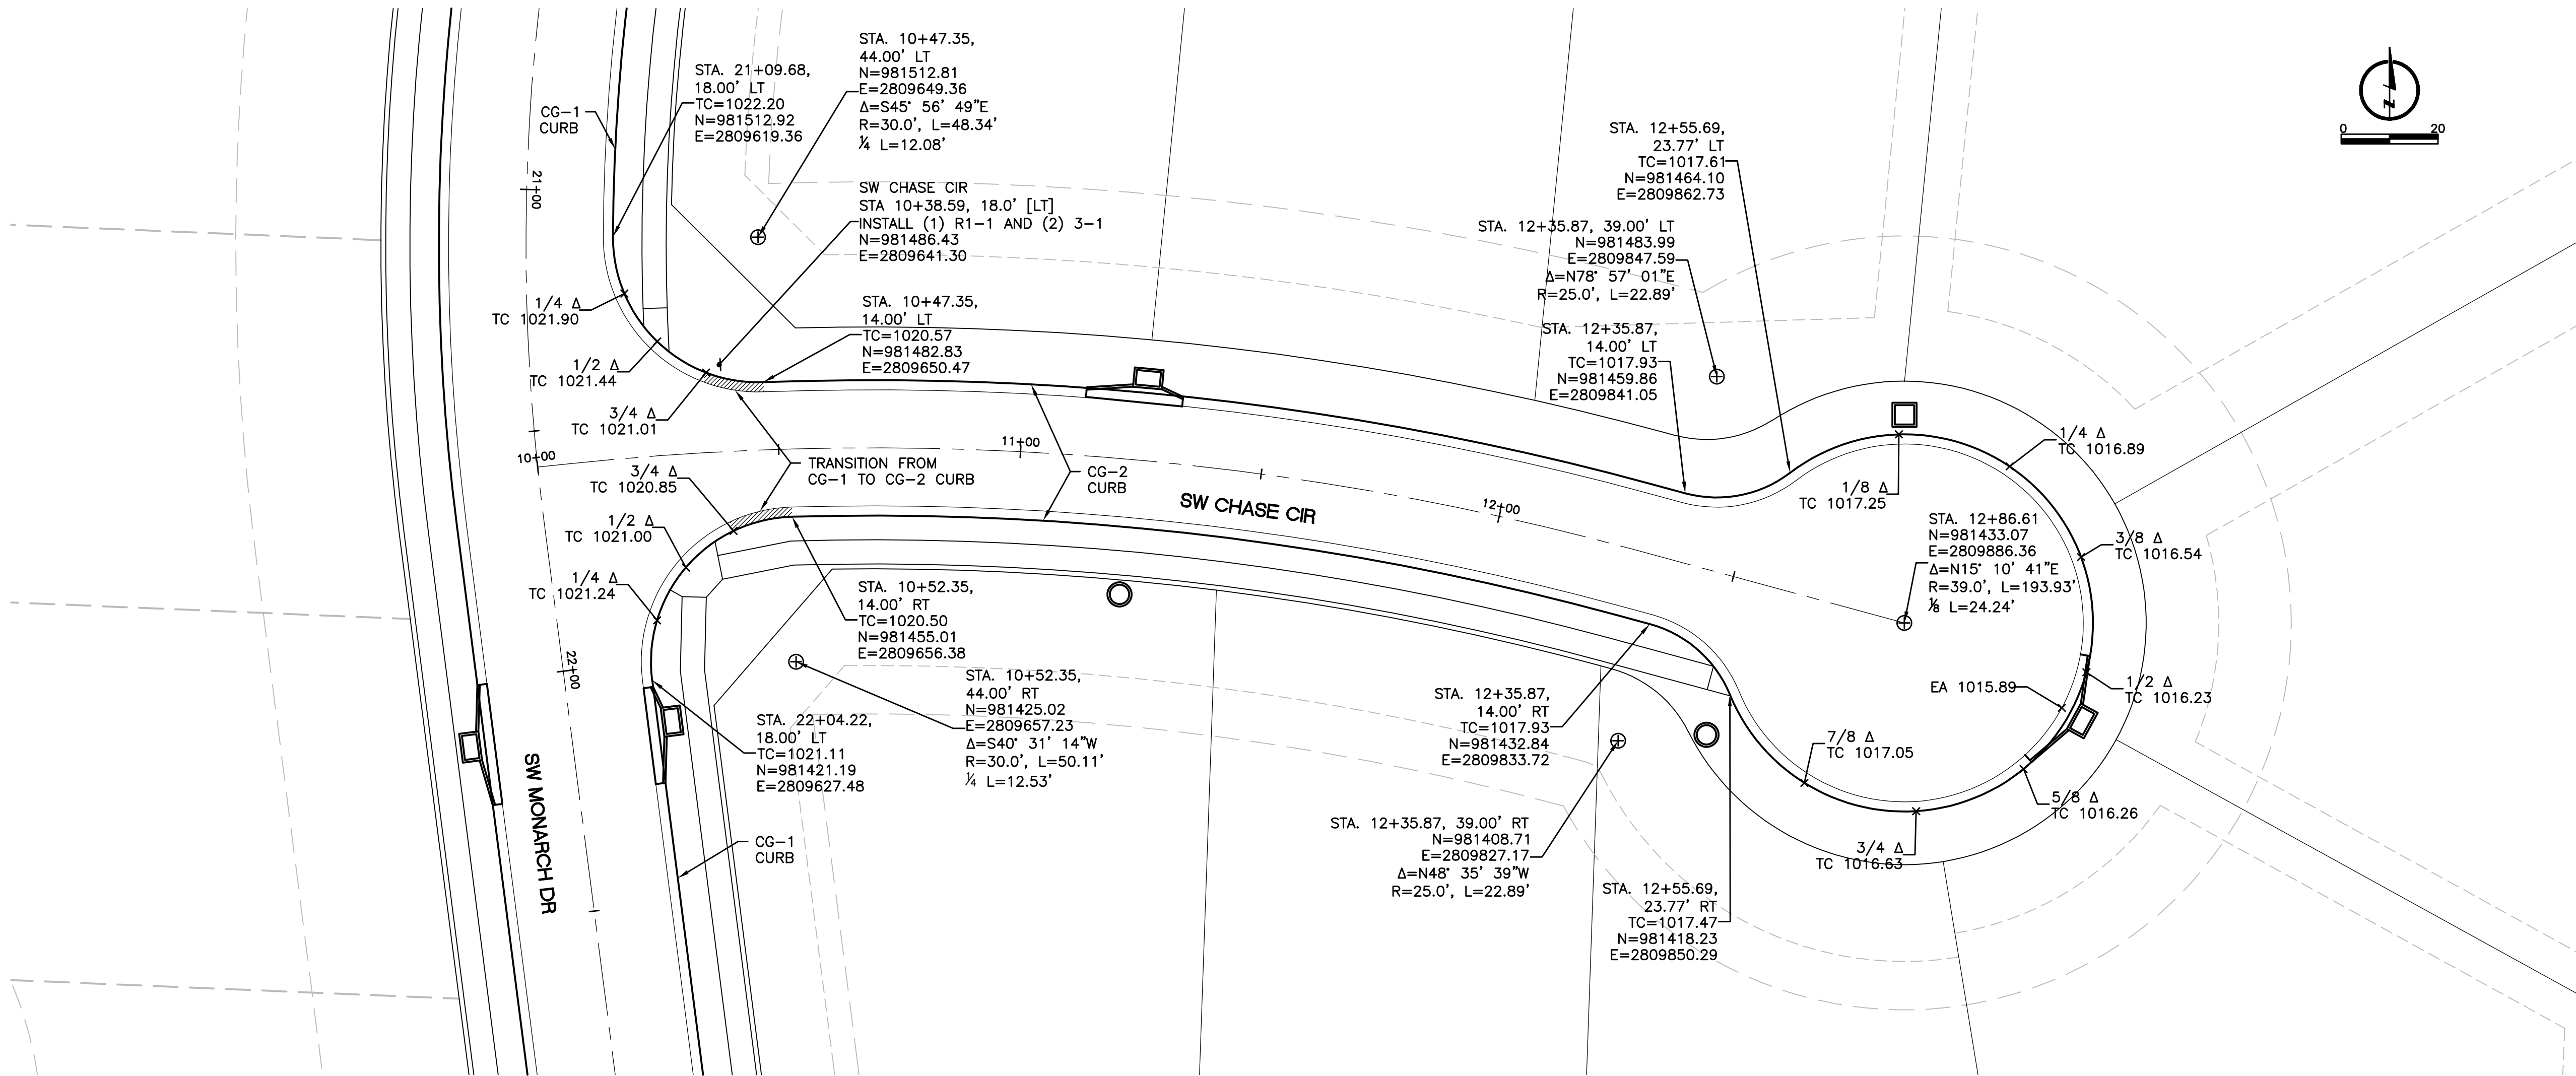

- NOTES
1. R1-1 IS STOP SIGN AND 3-1 IS STREET SIGN. REFER TO CITY STANDARD DETAILS FOR MOUNTING AND SIGN REQUIREMENTS. TWO STREET SIGNS REQUIRED FOR EACH SIDE OF POST, PER STREET NAME.

DRAWN BY	AM	DESIGNED BY	NJM	DATE	JULY 20, 2018	JOB NUMBER-TASKS	0318050.01	BOOK AND PAGE	
REVISIONS									
9001 State Line Rd., Suite 200 816.361.0440 P Kansas City, Missouri 64114 816.361.0045 F www.LRA-inc.com									
LARKIN/ LAMP RYNEARSON					SUMMIT VIEW FARMS 3RD PLAT LEE'S SUMMIT, MISSOURI				
PAVING, STORM AND SANITARY PLANS INTERSECTION LAYOUT PLAN									
LARKIN LAMP RYNEARSON - ENGINEERS MO Certificate of Authority No. 2013011903									
FOR REVIEW									
NOT RELEASED FOR CONSTRUCTION									
MARK DANIEL MCGHEE JR. PE - 2008019568									
SHEET									
09 OF 18									