

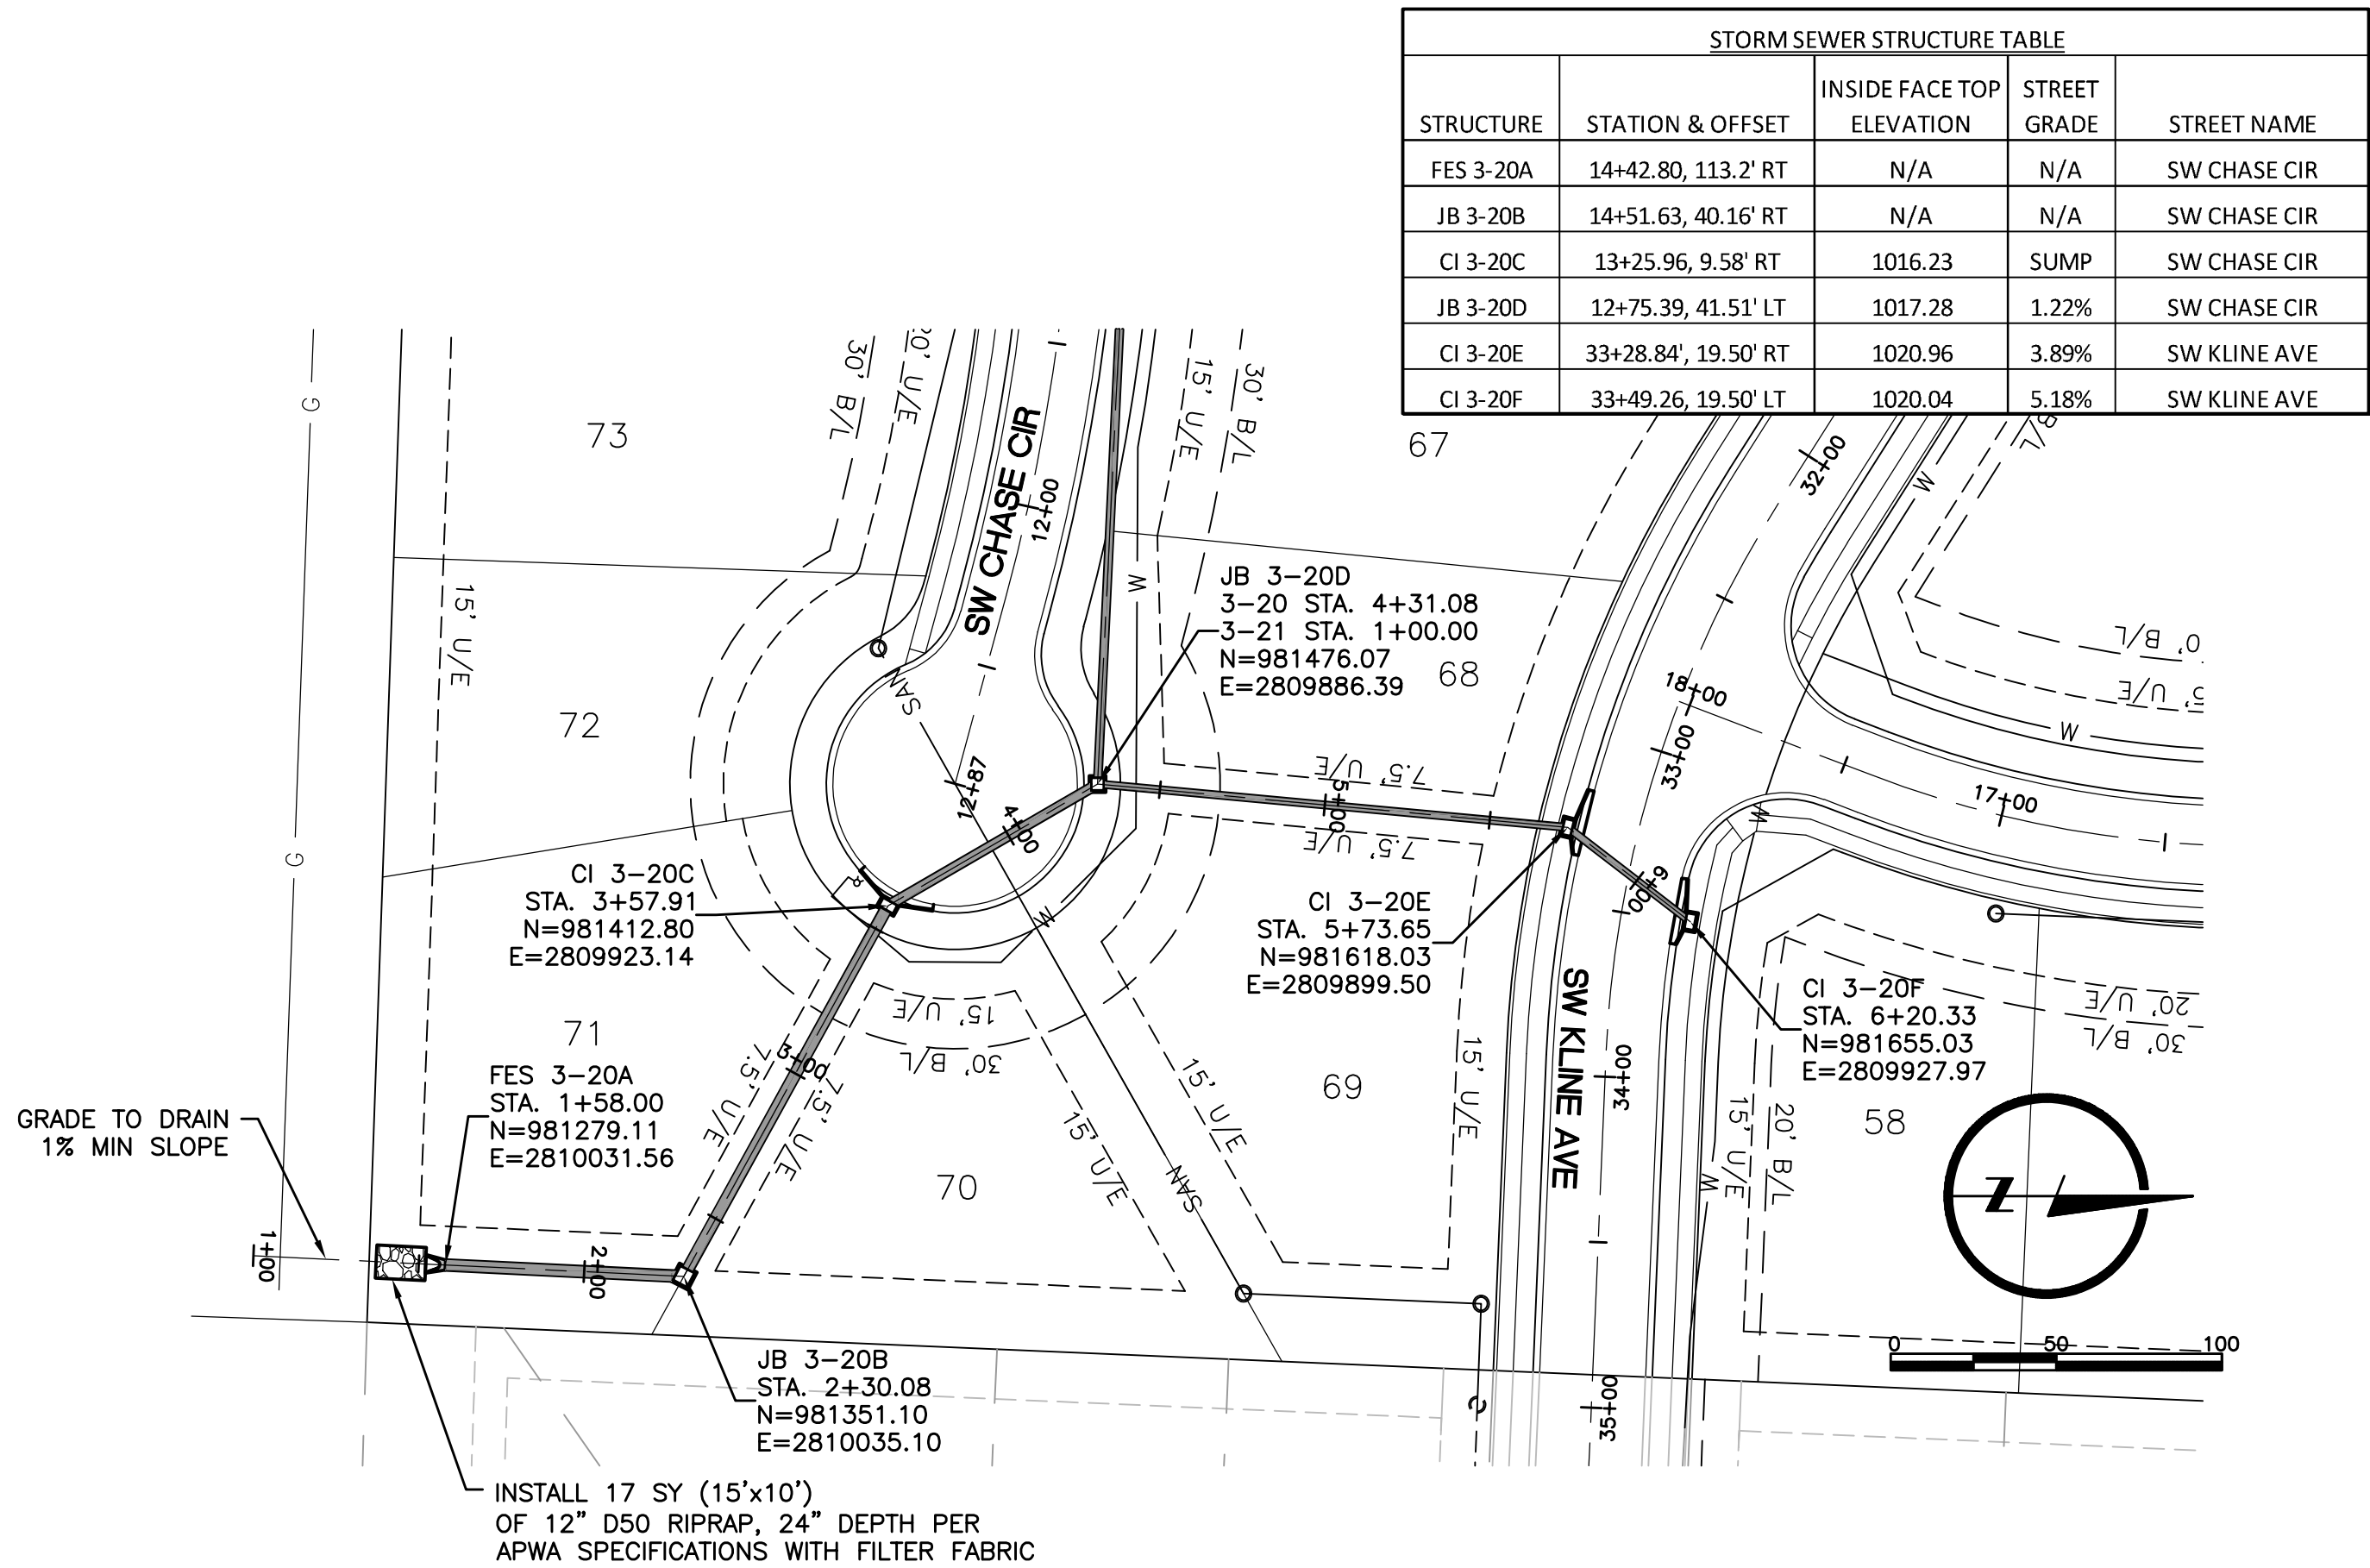


L:\Engineering\031850 SVFDG Summit View Form 3rd Plan\DRAWINGS\CONSTRUCTION DRAWINGS\PAV-PLANS\PAV-STM-PMP-02.dwg, 7/20/2018 8:28:13 AM, DAN MCGHEE, LAMP RYNEARSON & ASSOCIATES

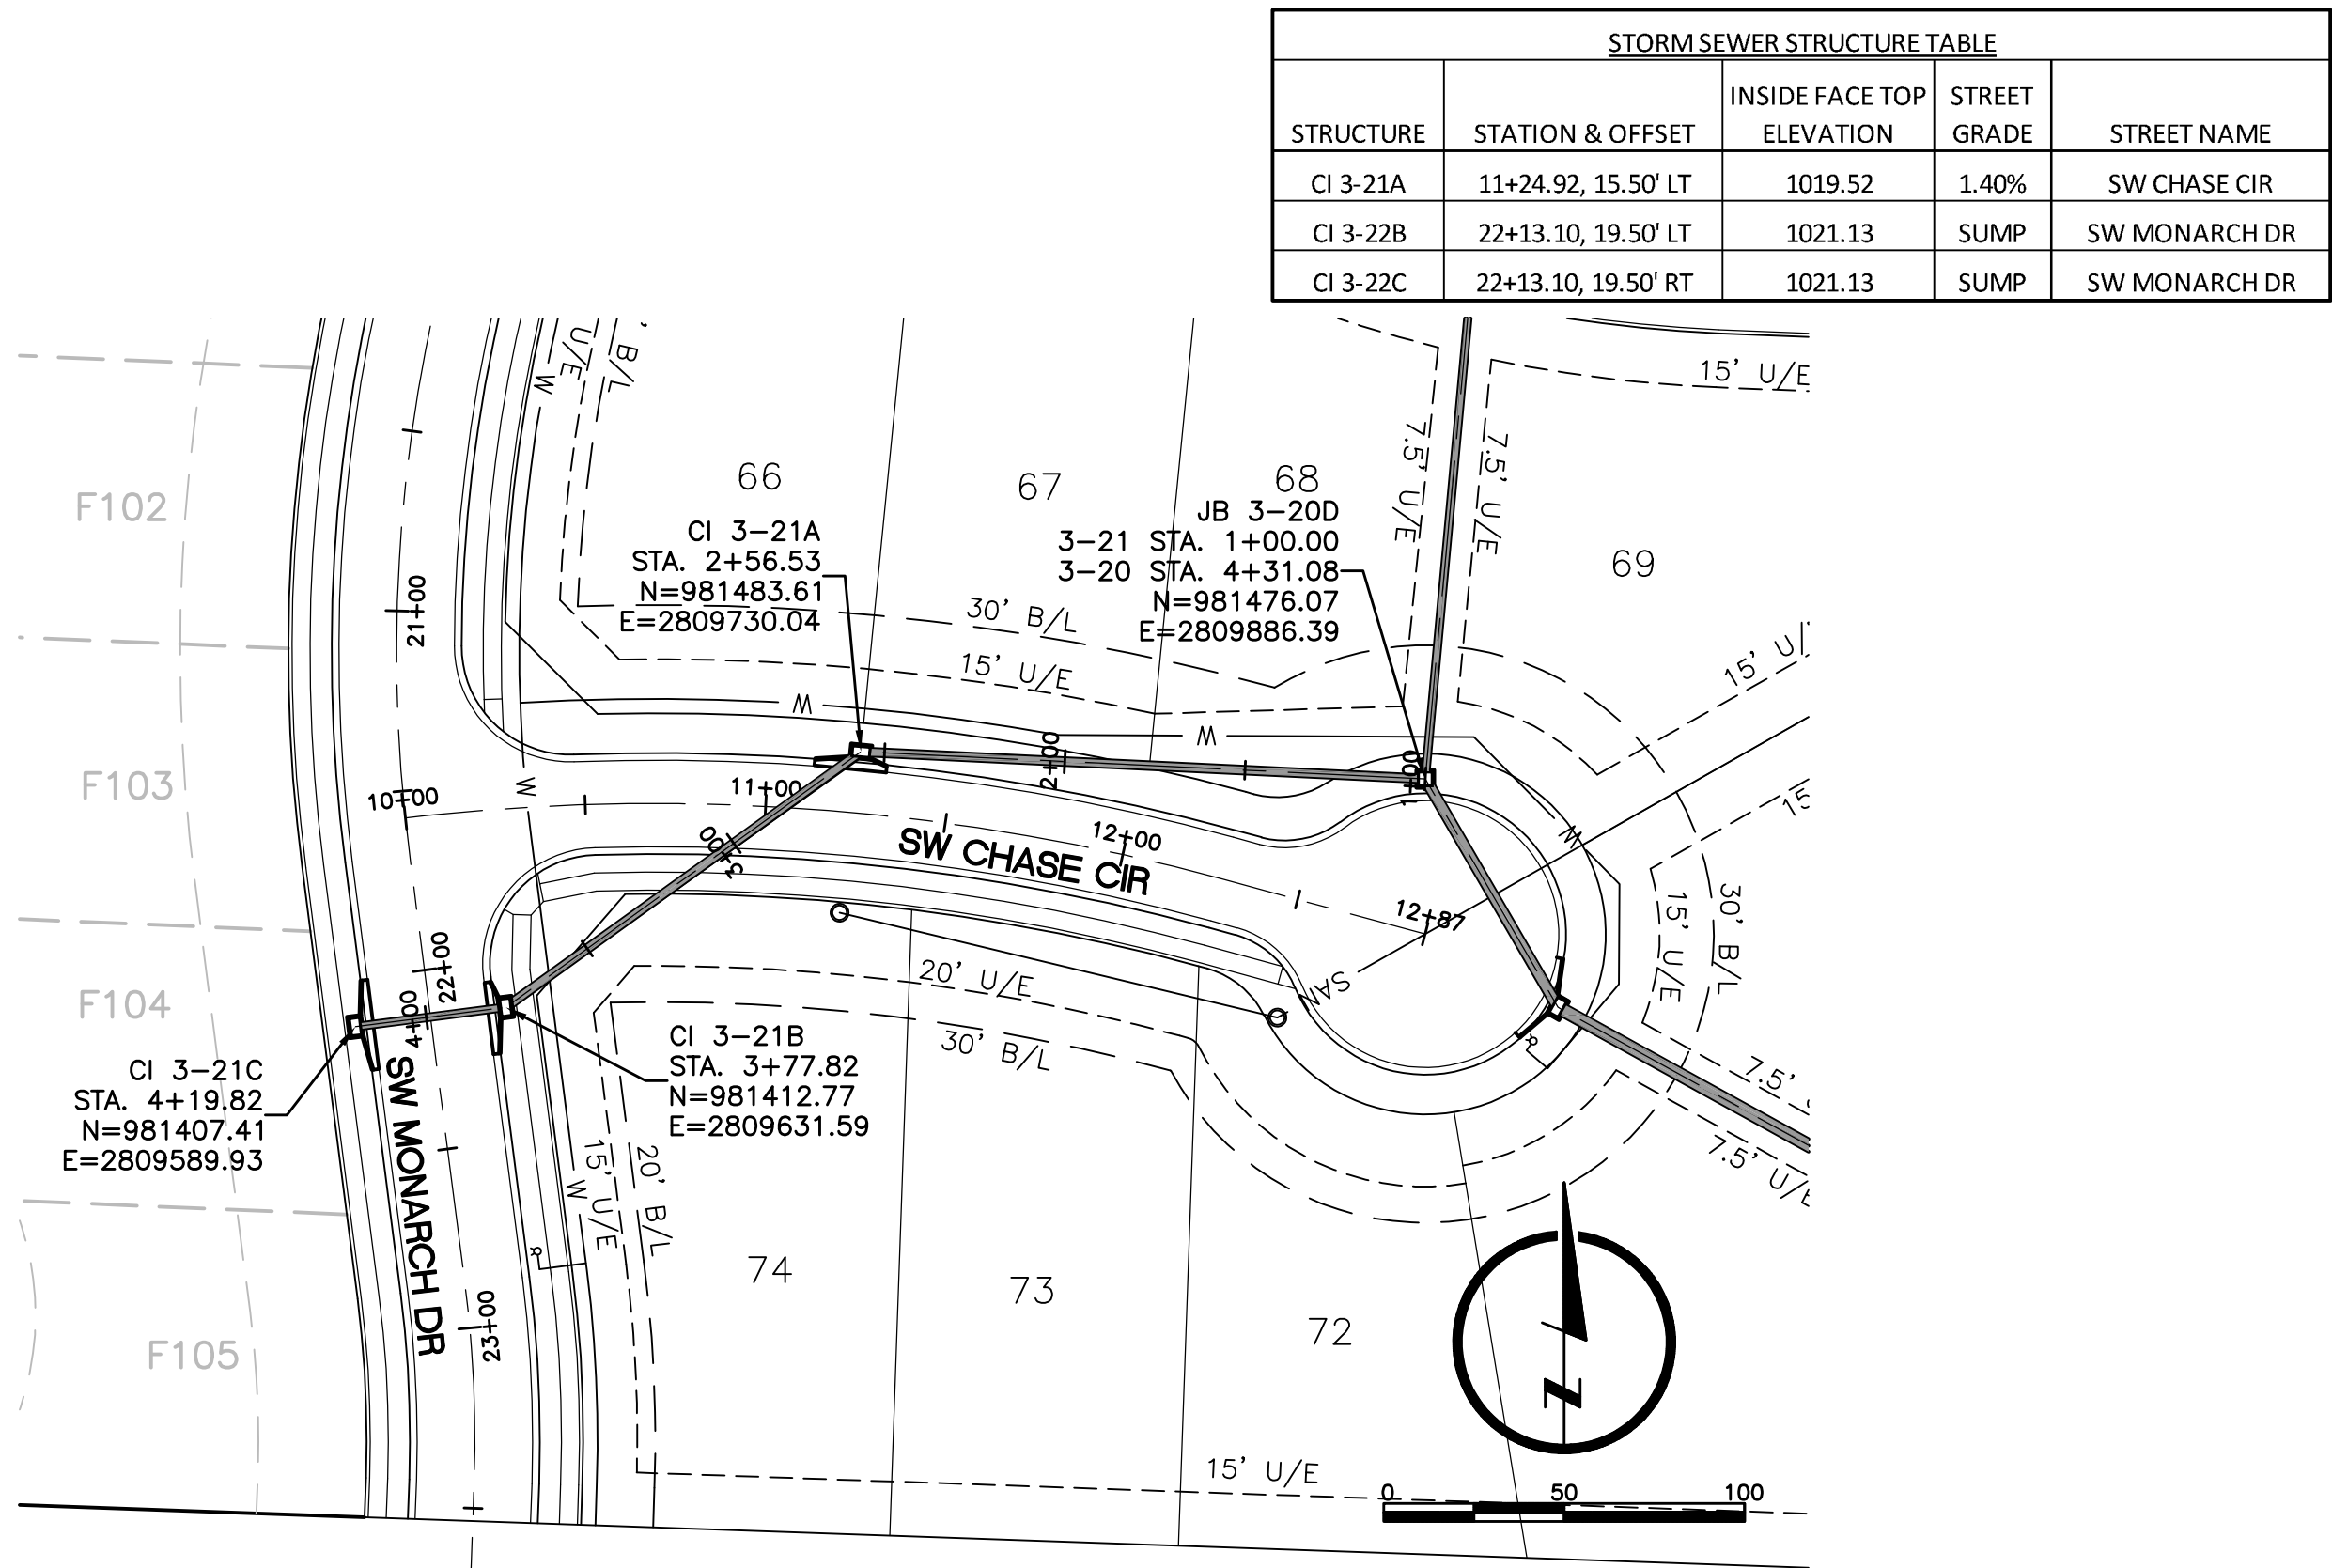


STORM LINE 3-20

Scales: 1"=50 HOR.
1"=10 VERT.

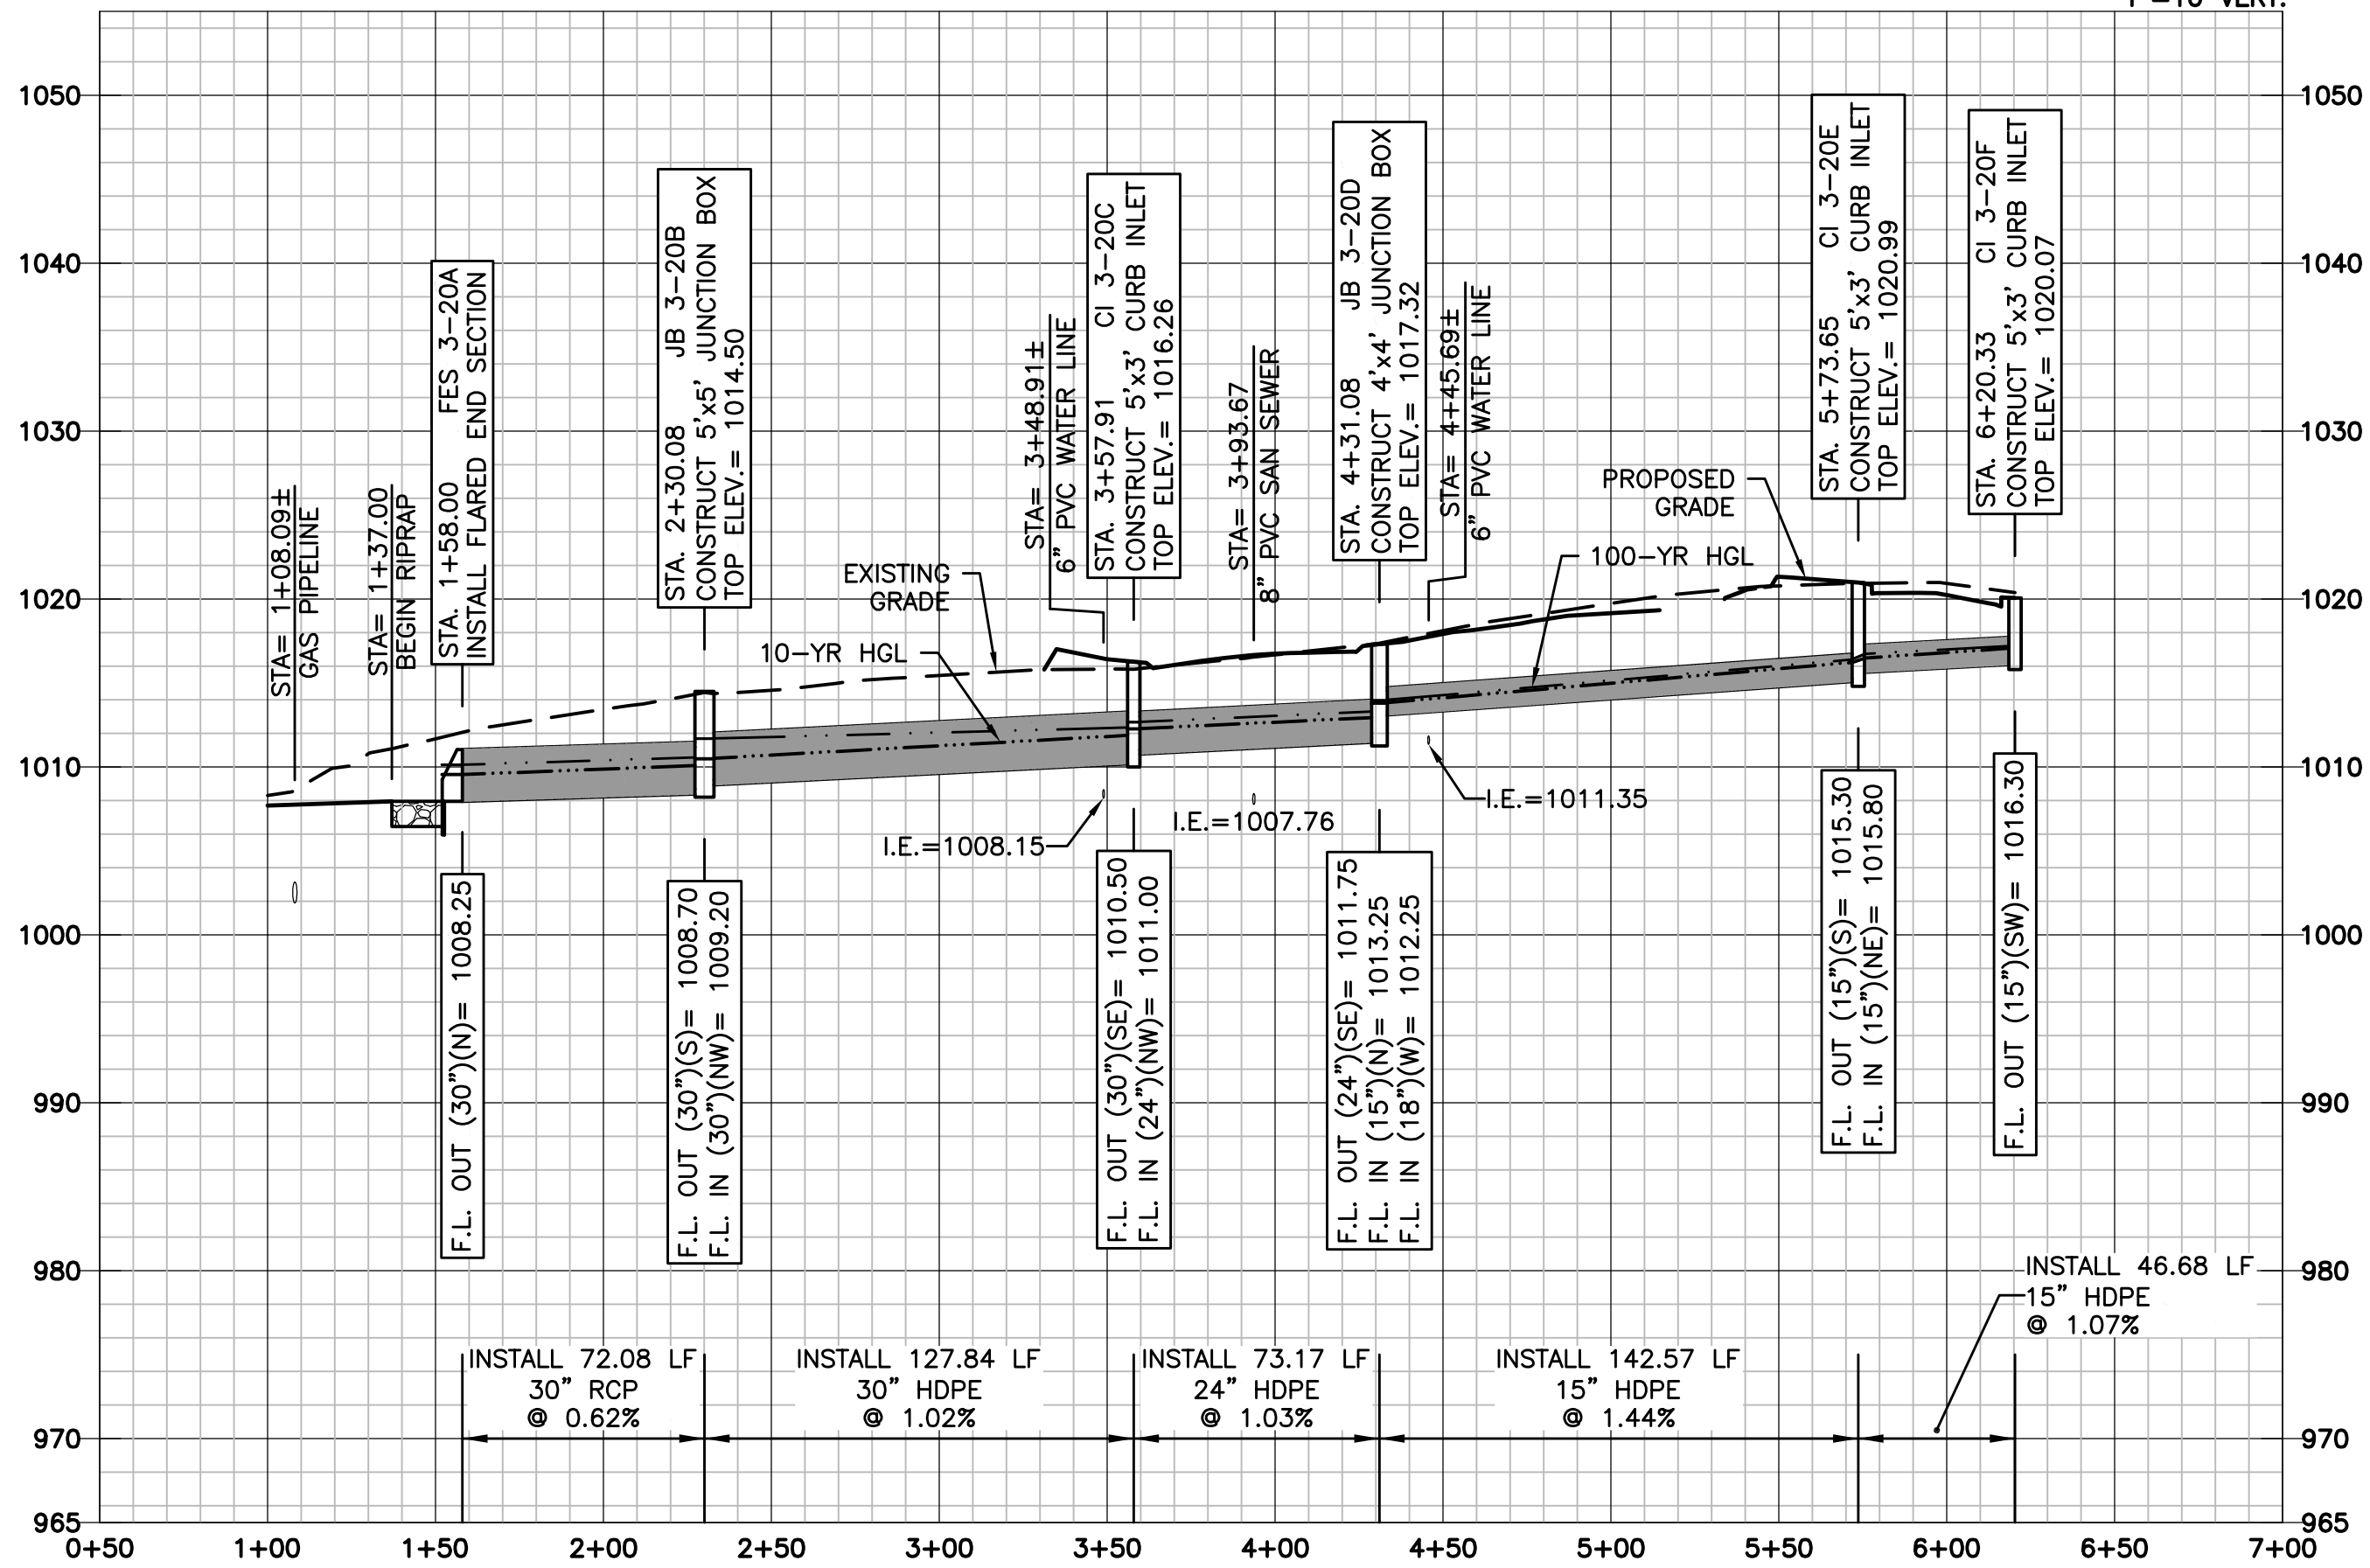

STORM LINE 3-21

Scales: 1"=50 HOR.
1"=10 VERT.

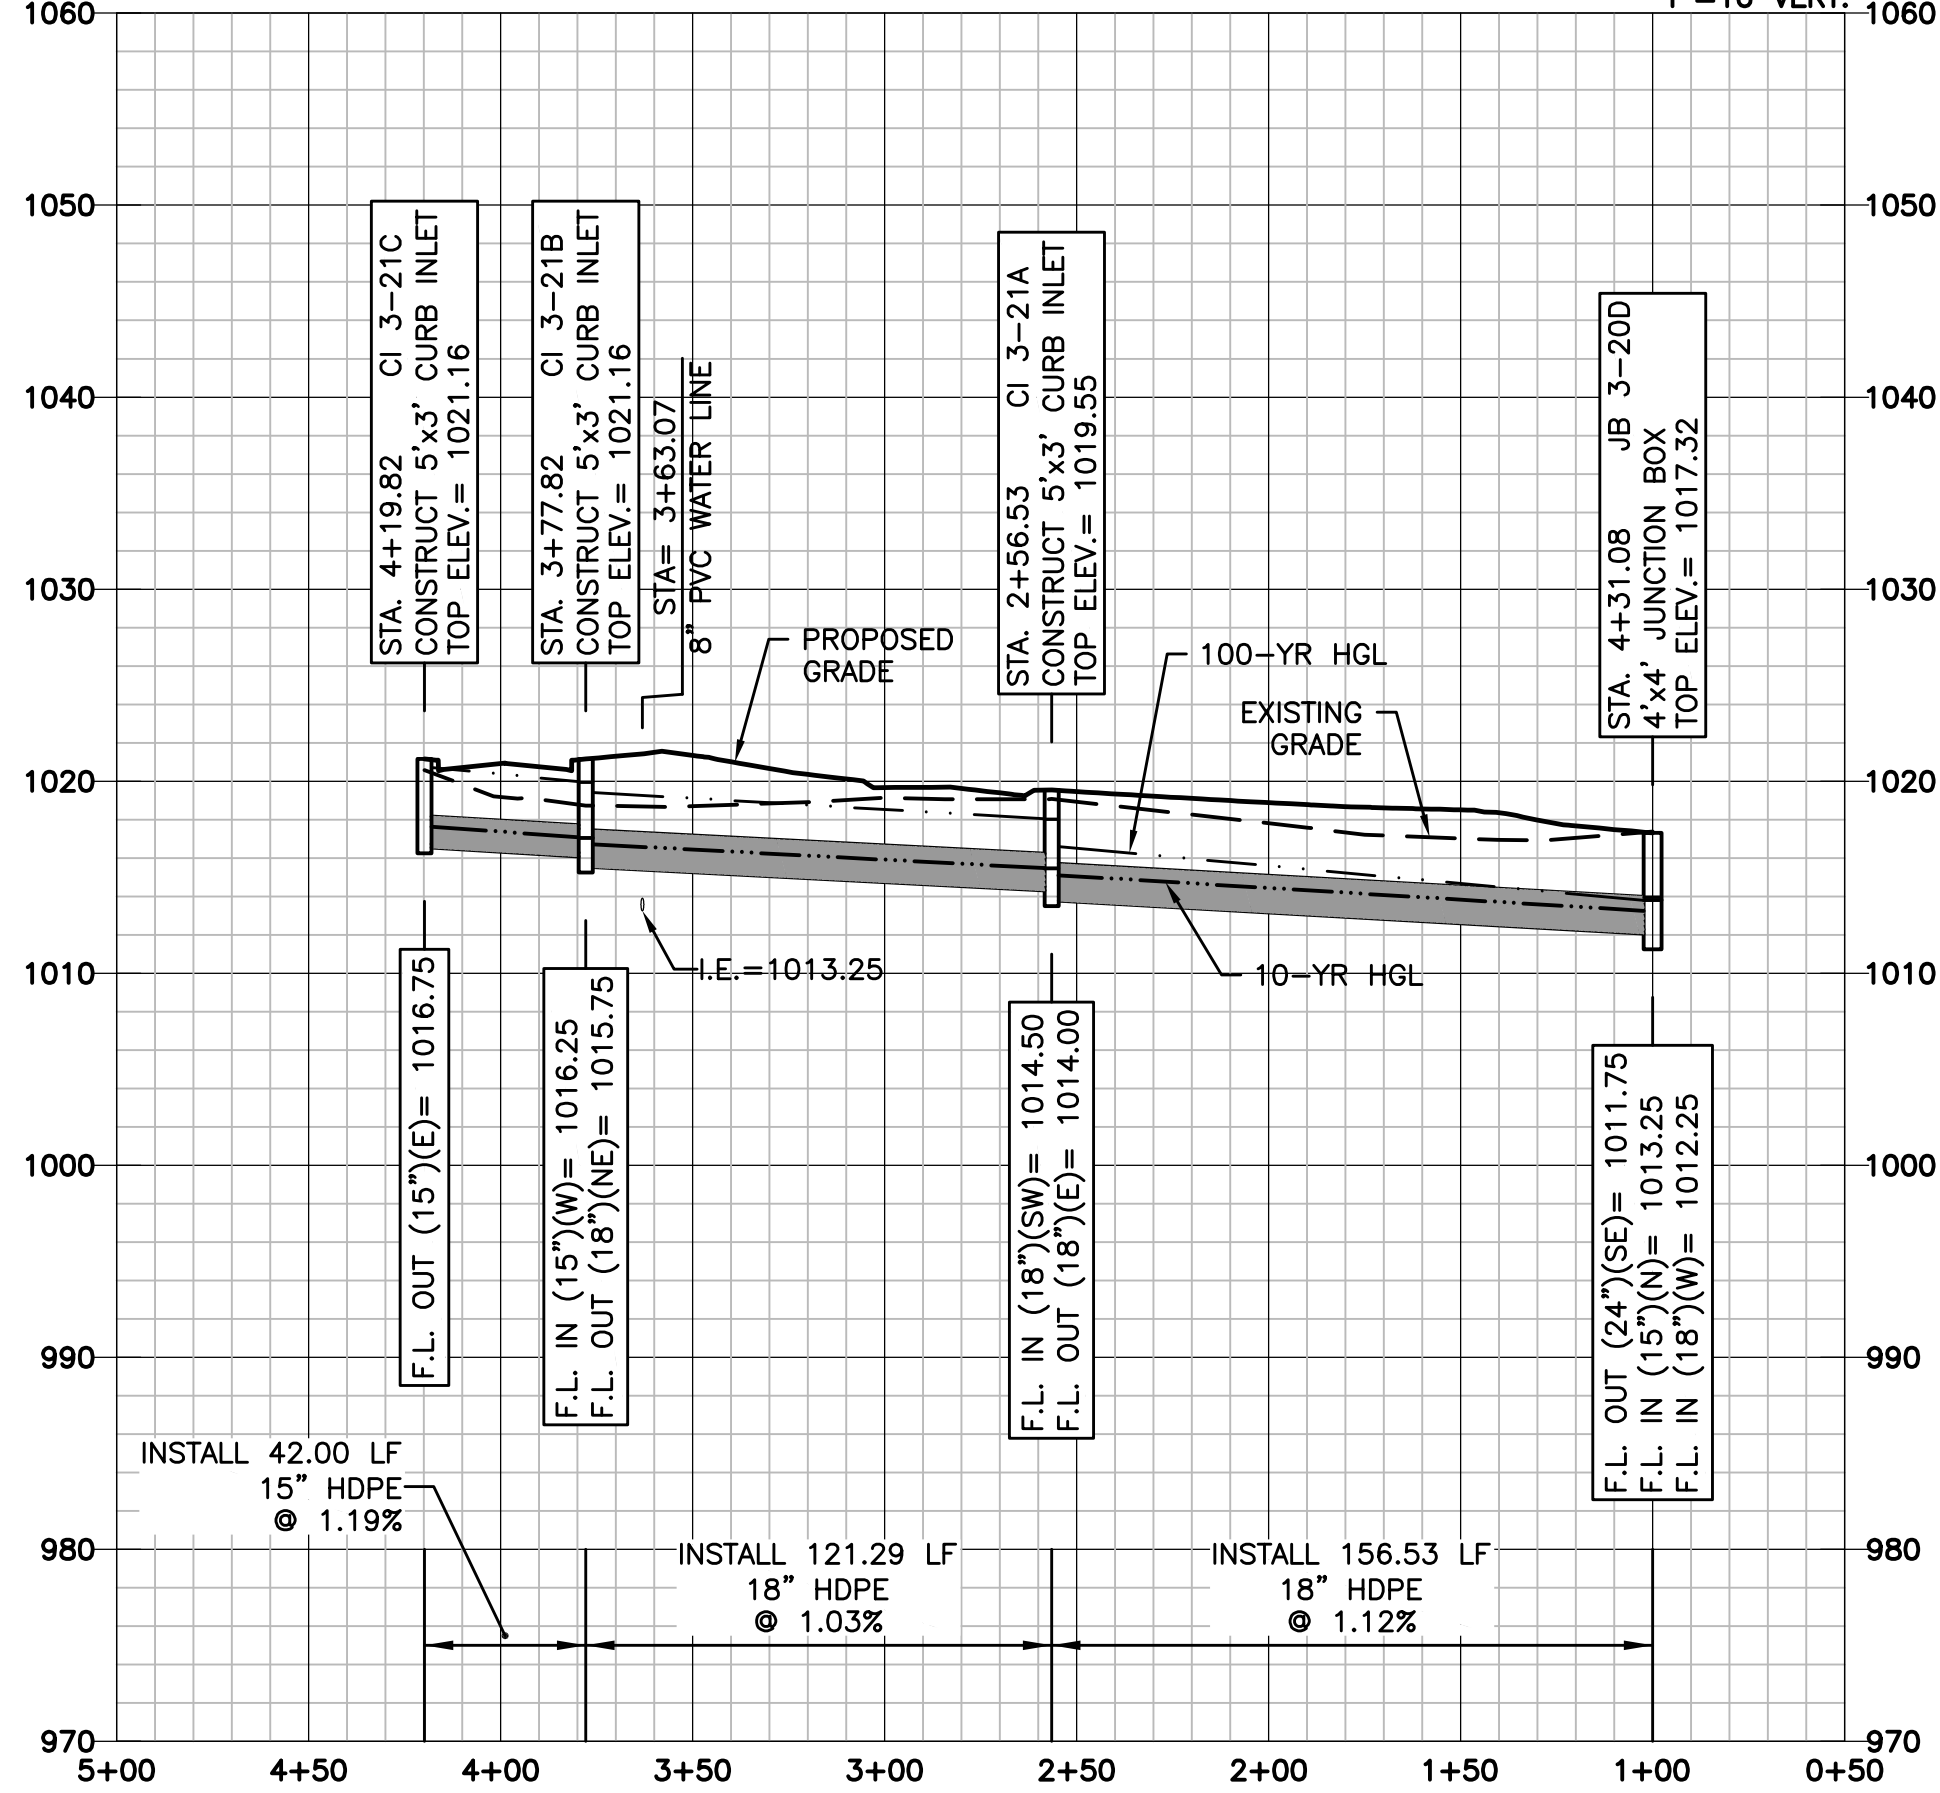

PAVING, STORM AND SANITARY PLANS

STORM SEWER PLAN AND PROFILE

LINES 3-20 AND 3-21

LARKIN LAMP RYNEARSON - ENGINEERS
NO Certificate of Authority No. 2013011903

FOR REVIEW

NOT RELEASED FOR CONSTRUCTION

MARK DANIEL MCGHEE JR.
PE - 2008019568

SHEET

13 OF 18

Summit View Farms 3rd Plat
Lee's Summit, Missouri

LARKIN LAMP RYNEARSON

9001 State Line Rd., Suite 200
Kansas City, Missouri 64114
www.LRA-inc.com

816.361.0440 | P
816.361.0045 | F

DRAWN BY: JAW
DESIGNED BY: NDM
DATE: JULY 20, 2018
JOB NUMBER-TASKS: 0318050.01
BOOK AND PAGE: