



L:\Engineering\0318050 SVFDC Summit View Farms 3rd Plat\DRAWINGS\CONSTRUCTION DRAWINGS\PAV-PLANS\0318050-PAV-SAN-PNP-02.dwg, 7/20/2018 8:36:25 AM, DAN MCGHEE, LAMP RYNEARSON & ASSOCIATES

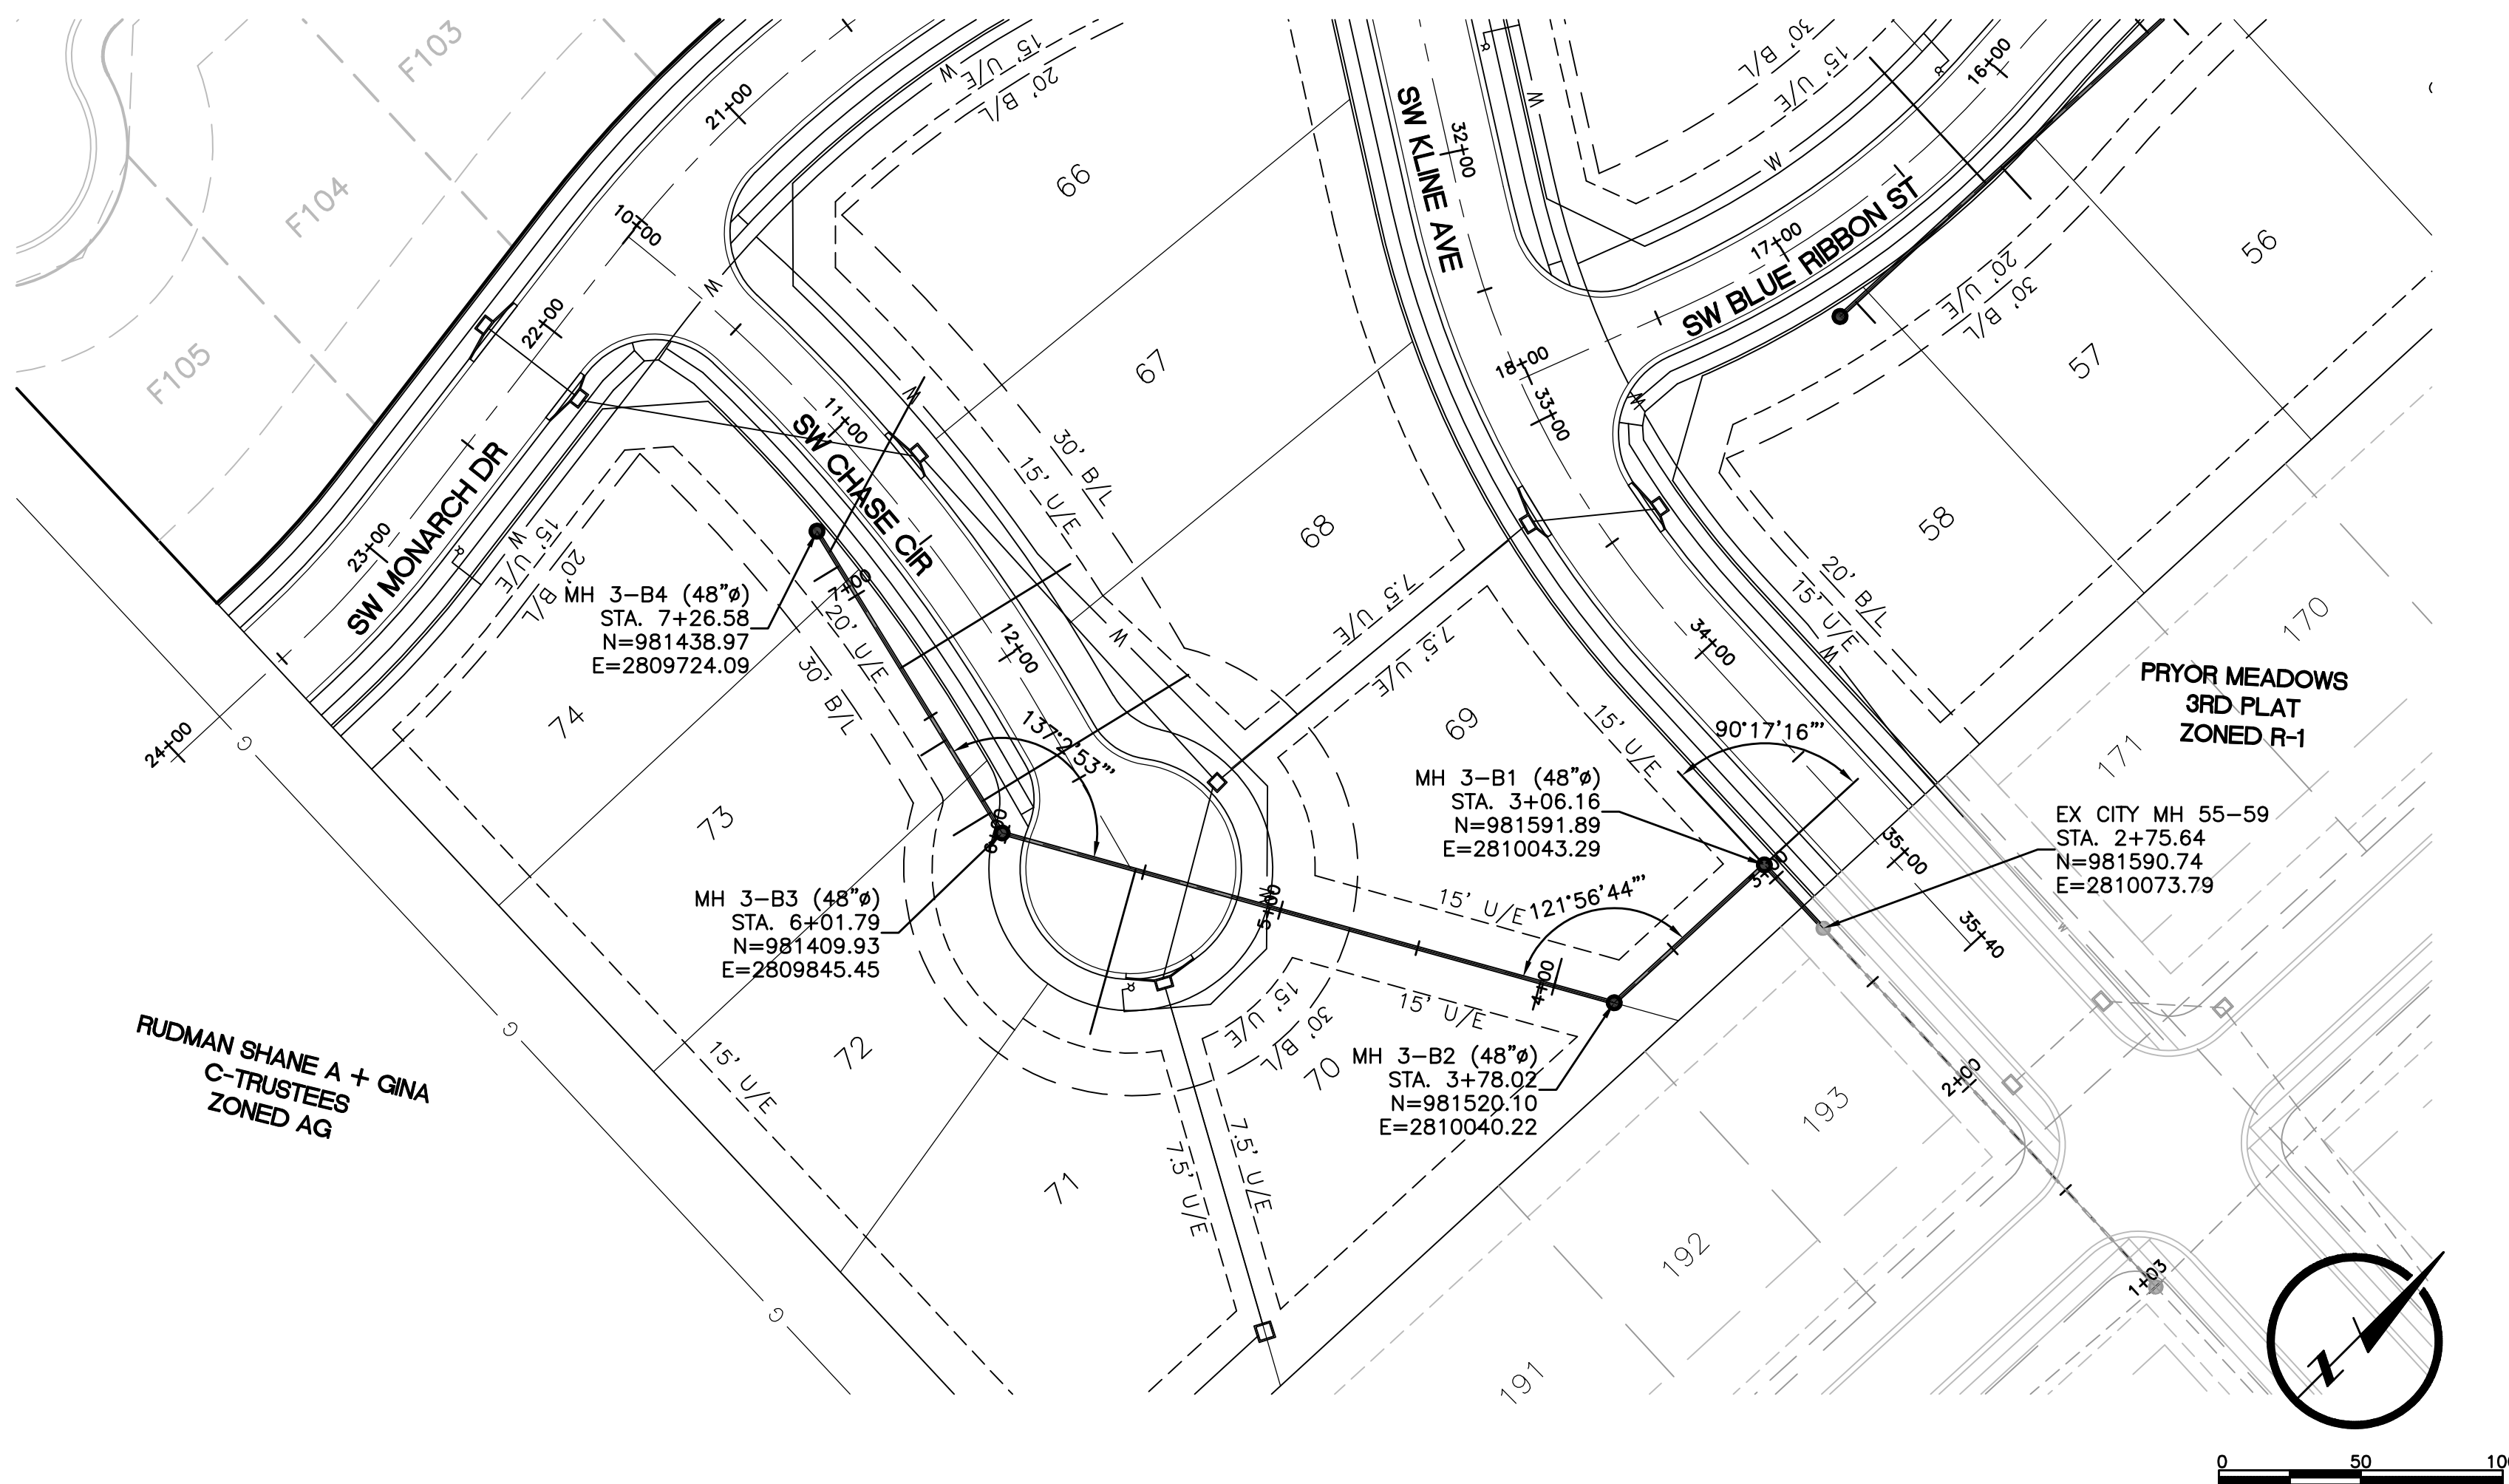

SAN LINE 3-B

Scales: 1"=50 HOR.
1"=10 VERT.

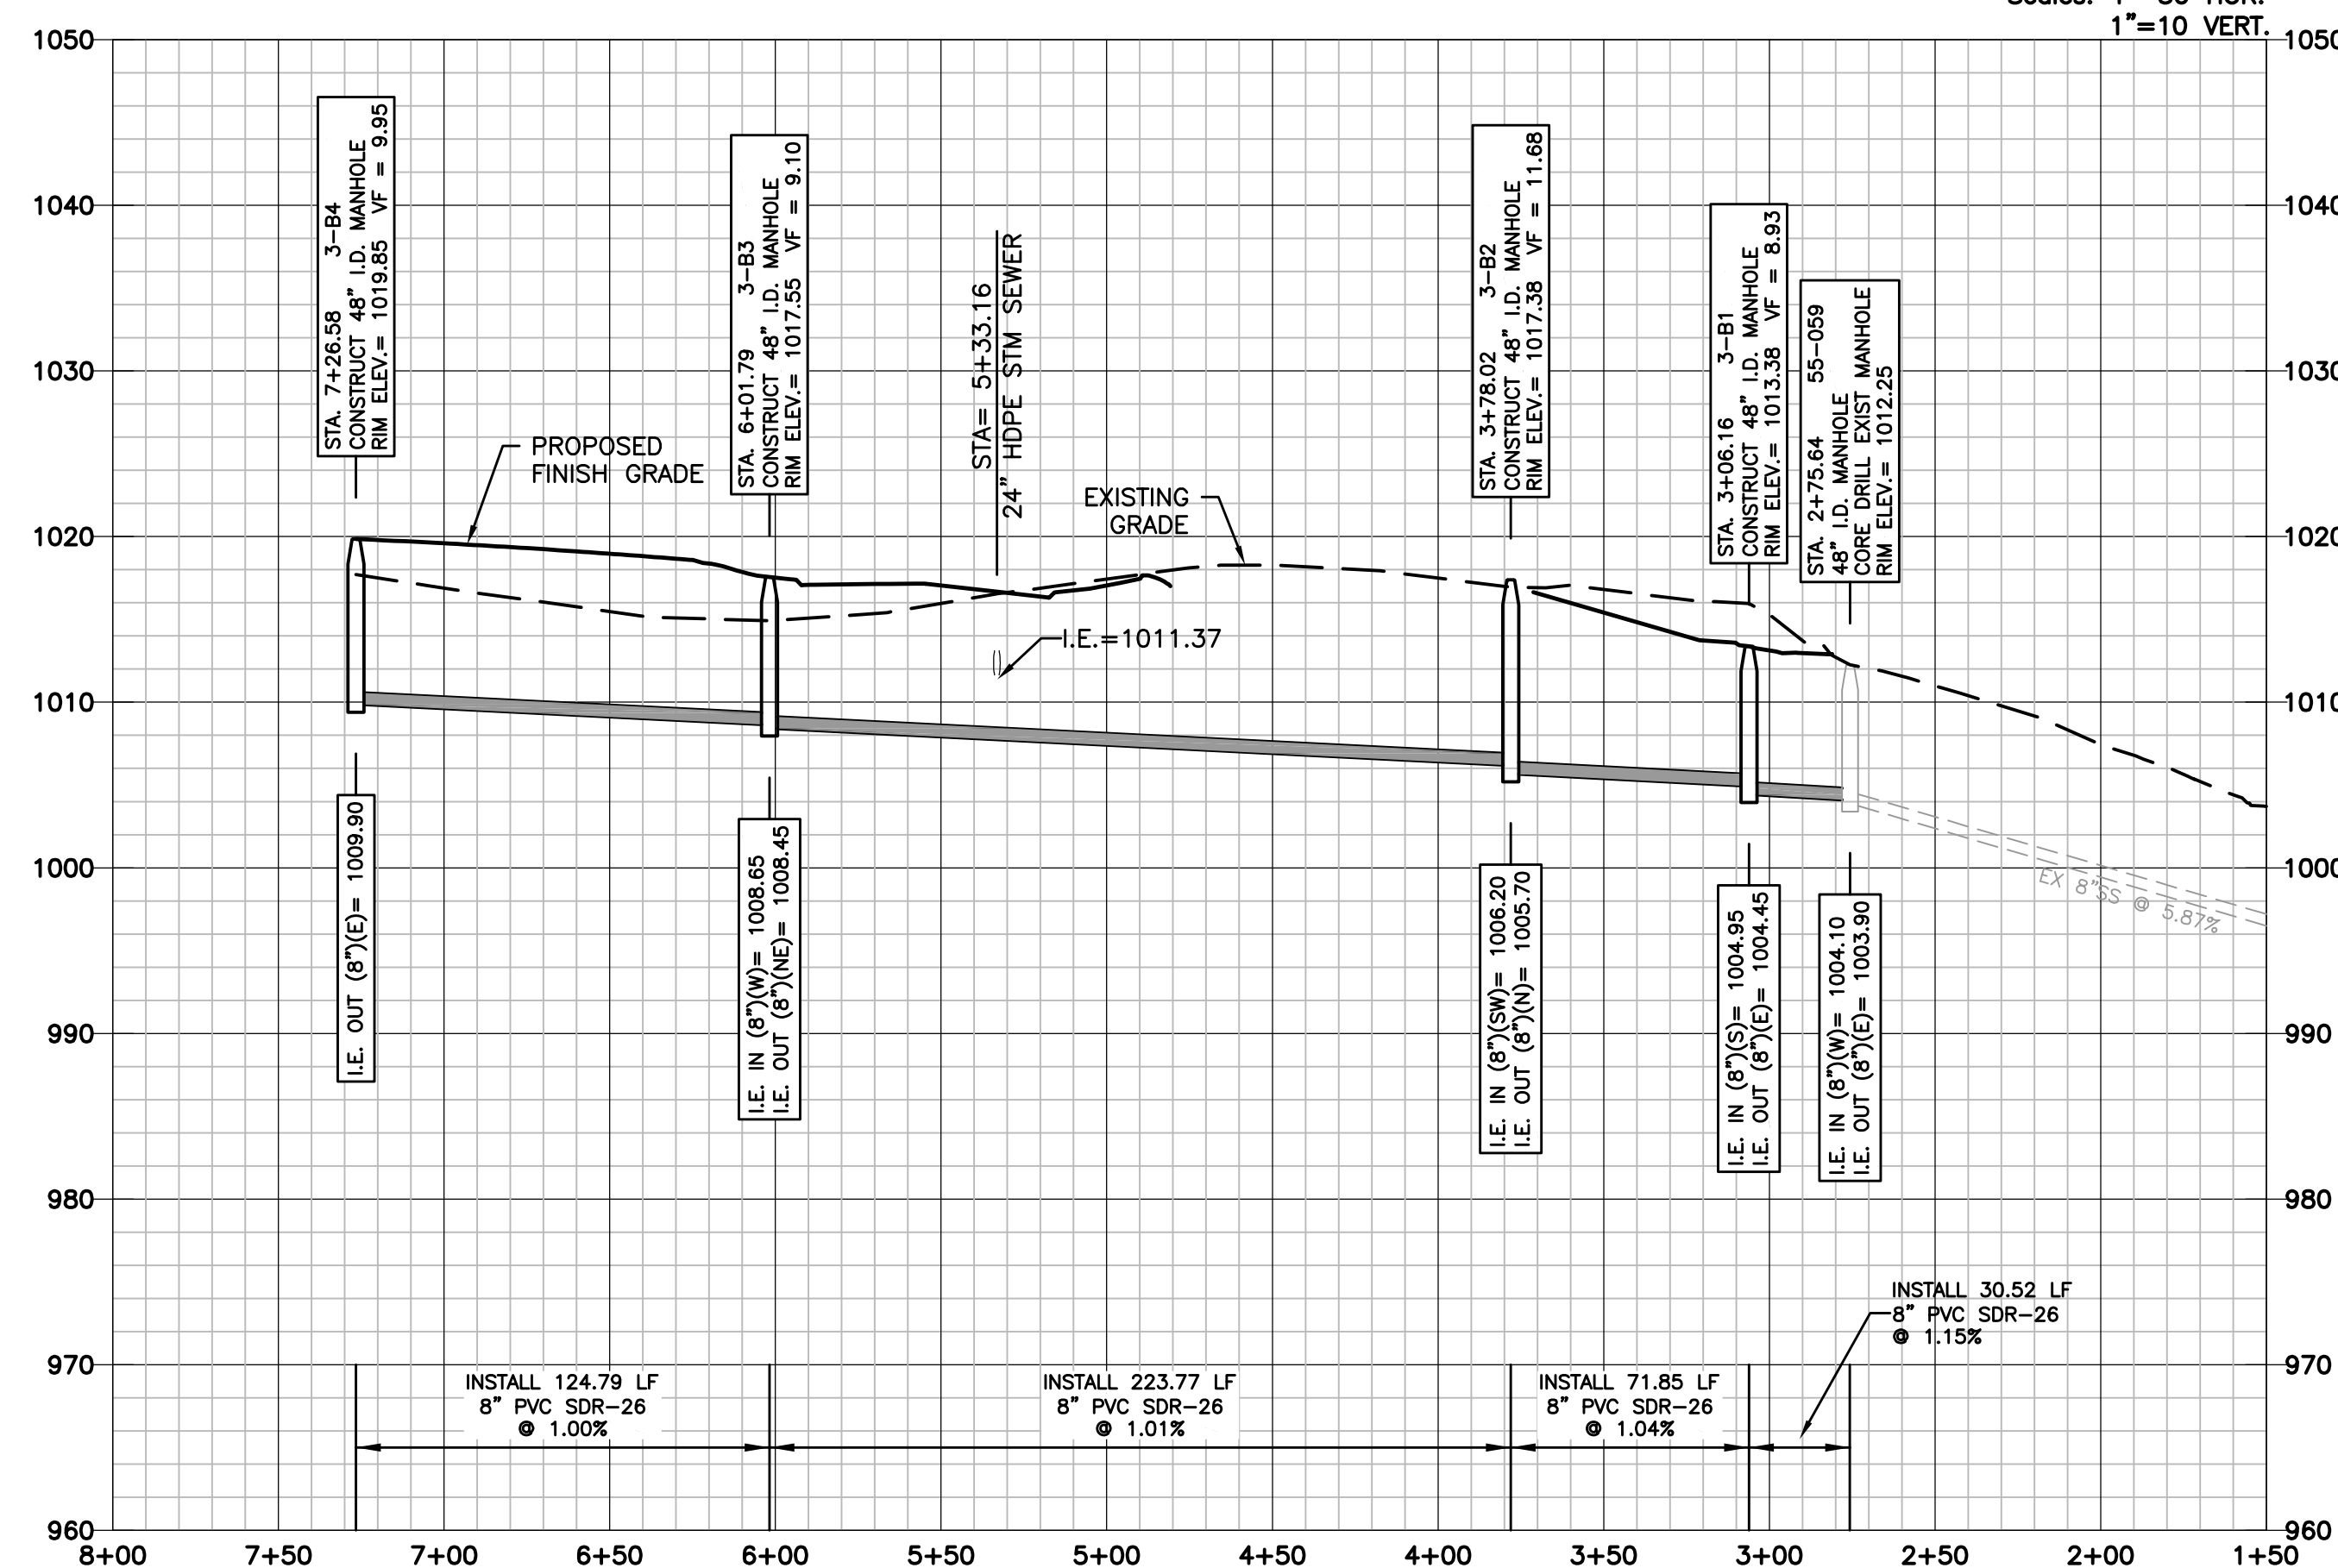

SANITARY SEWER STRUCTURE TABLE		
STRUCTURE	STATION & OFFSET	STREET NAME
MH 3-B1	34+69.99, 34.53' RT	SW KLINE AVE
MH 3-B2	34+69.90, 106.38' RT	SW KLINE AVE
MH 3-B3	12+53.19, 33.04' RT	SW CHASE CIR
MH 3-B4	11+23.03, 28.00' RT	SW CHASE CIR

Sewer Line	Main Station	Sewer Main Invert Elevation	Lateral Stub Length	Minimum Lateral Stub Elevation	Minimum Service Floor Elevation	Lot
3-B	4+00	1006.42	10	1007.95	1009.80	69
3-B	4+05	1006.47	10	1008.00	1009.80	70
3-B	5+53	1008.00	60	1010.53	1012.45	71
3-B	6+10	1008.73	15	1010.36	1012.60	72
3-B	6+15	1008.78	85	1011.81	1013.85	68
3-B	6+40	1009.03	10	1010.56	1012.30	73
3-B	6+70	1009.33	70	1012.06	1013.95	67
3-B	7+12	1009.75	10	1011.28	1013.10	74
3-B	7+18	1009.81	70	1012.54	1014.45	66

DRAWN BY: JLM
 DESIGNED BY: JLM
 DATE: JULY 20, 2018
 JOB NUMBER/TASKS: 0318050.01
 BOOK AND PAGE:

9001 State Line Rd., Suite 200
 Kansas City, Missouri 64114
 www.LRA-inc.com

LAMP RYNEARSON
 LARKIN/RYNEARSON-ENGINEERS

SUMMIT VIEW FARMS 3RD PLAT
 LEE'S SUMMIT, MISSOURI

PAVING, STORM AND SANITARY PLANS
 SANITARY SEWER PLAN AND PROFILE
 LINE 3-B

LARKIN RYNEARSON - ENGINEERS
 MDO Certificate of Authority No. 2013011933

FOR REVIEW

NOT RELEASED FOR CONSTRUCTION

MARK DANIEL MCGHEE, JR.
PE - 2008019568

SHEET

15 OF 18