
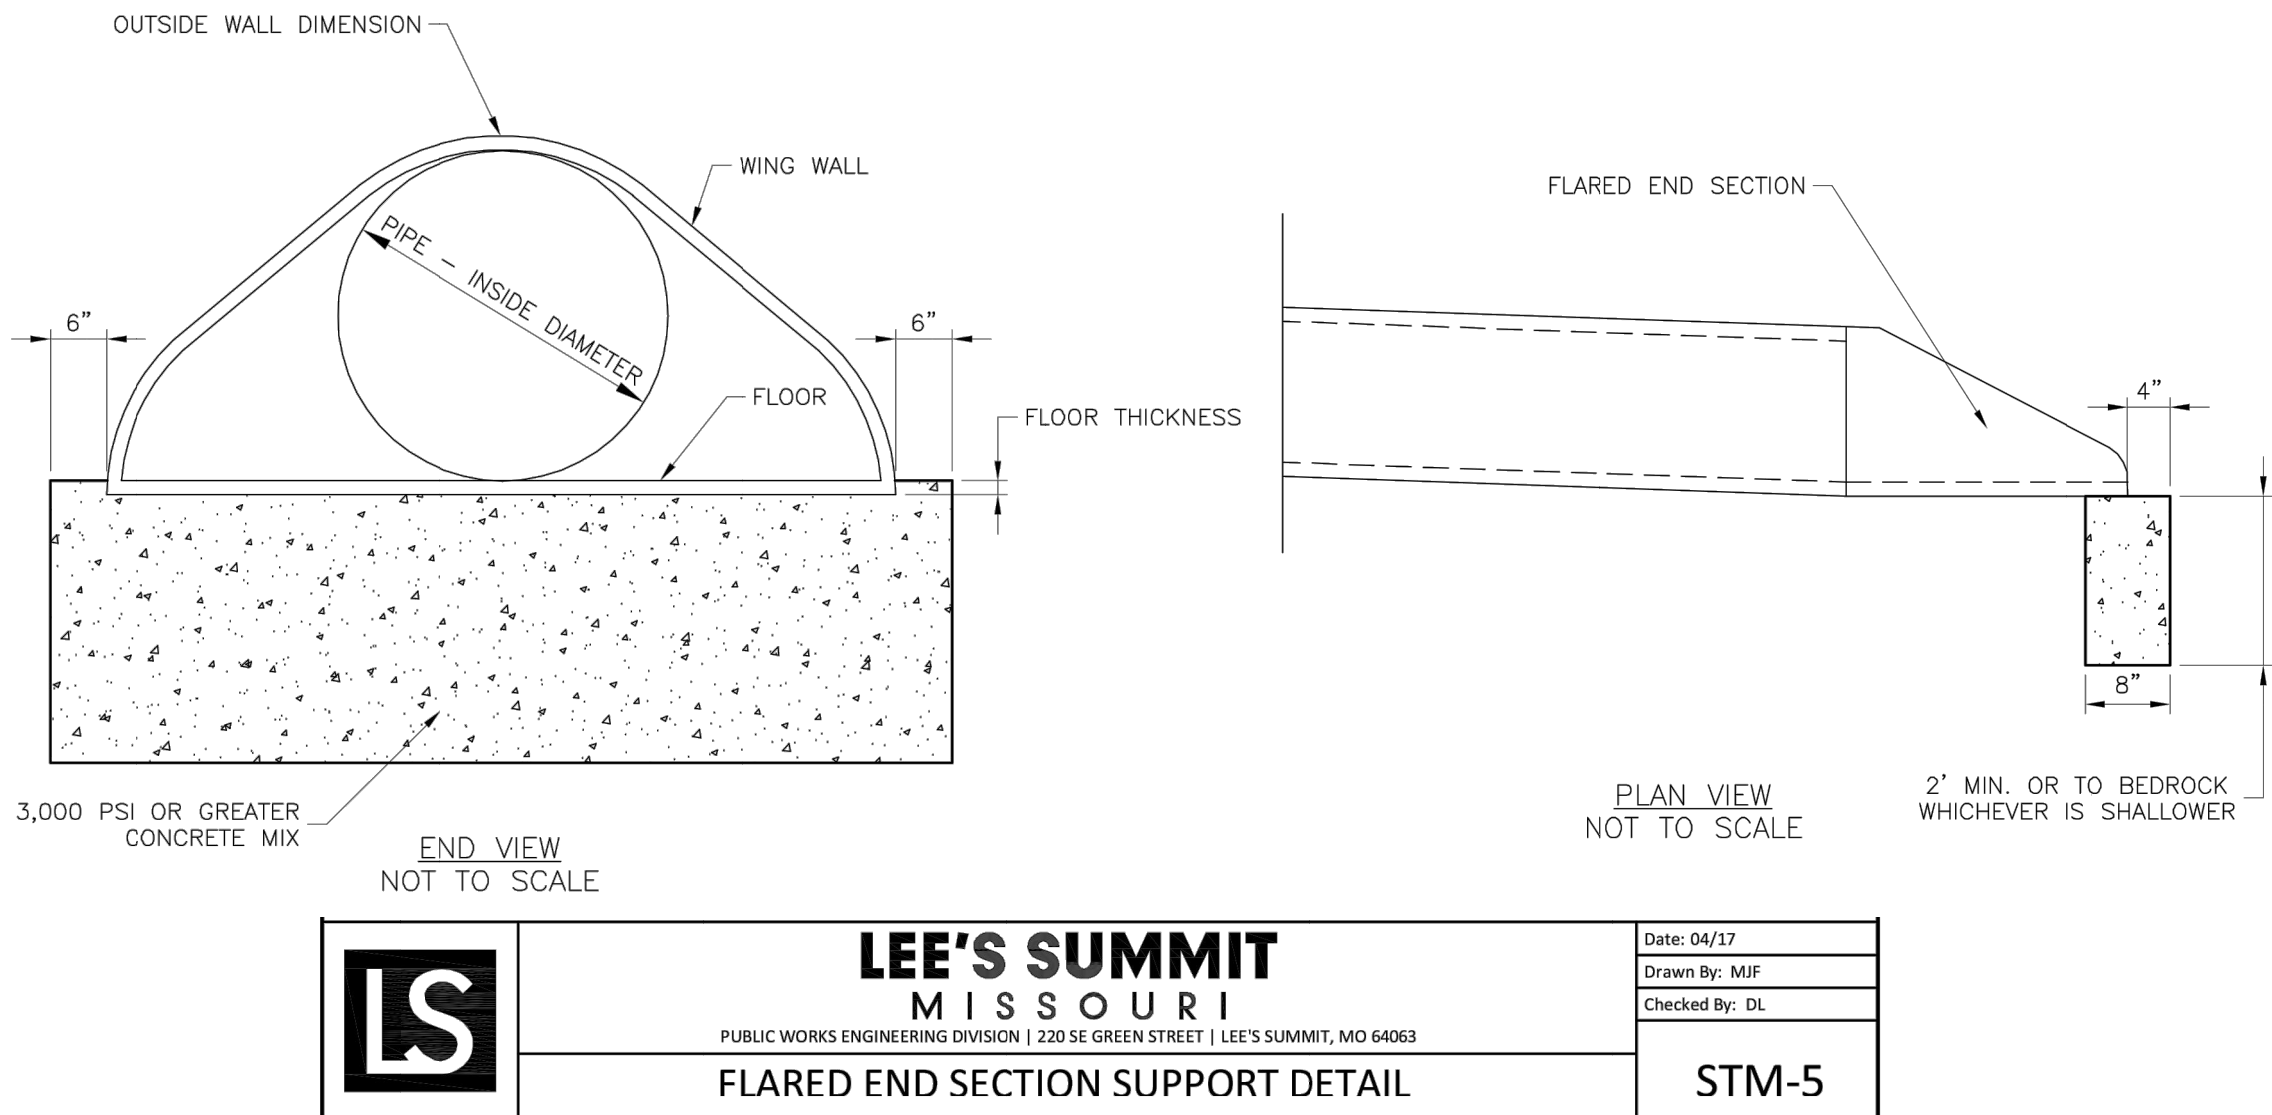
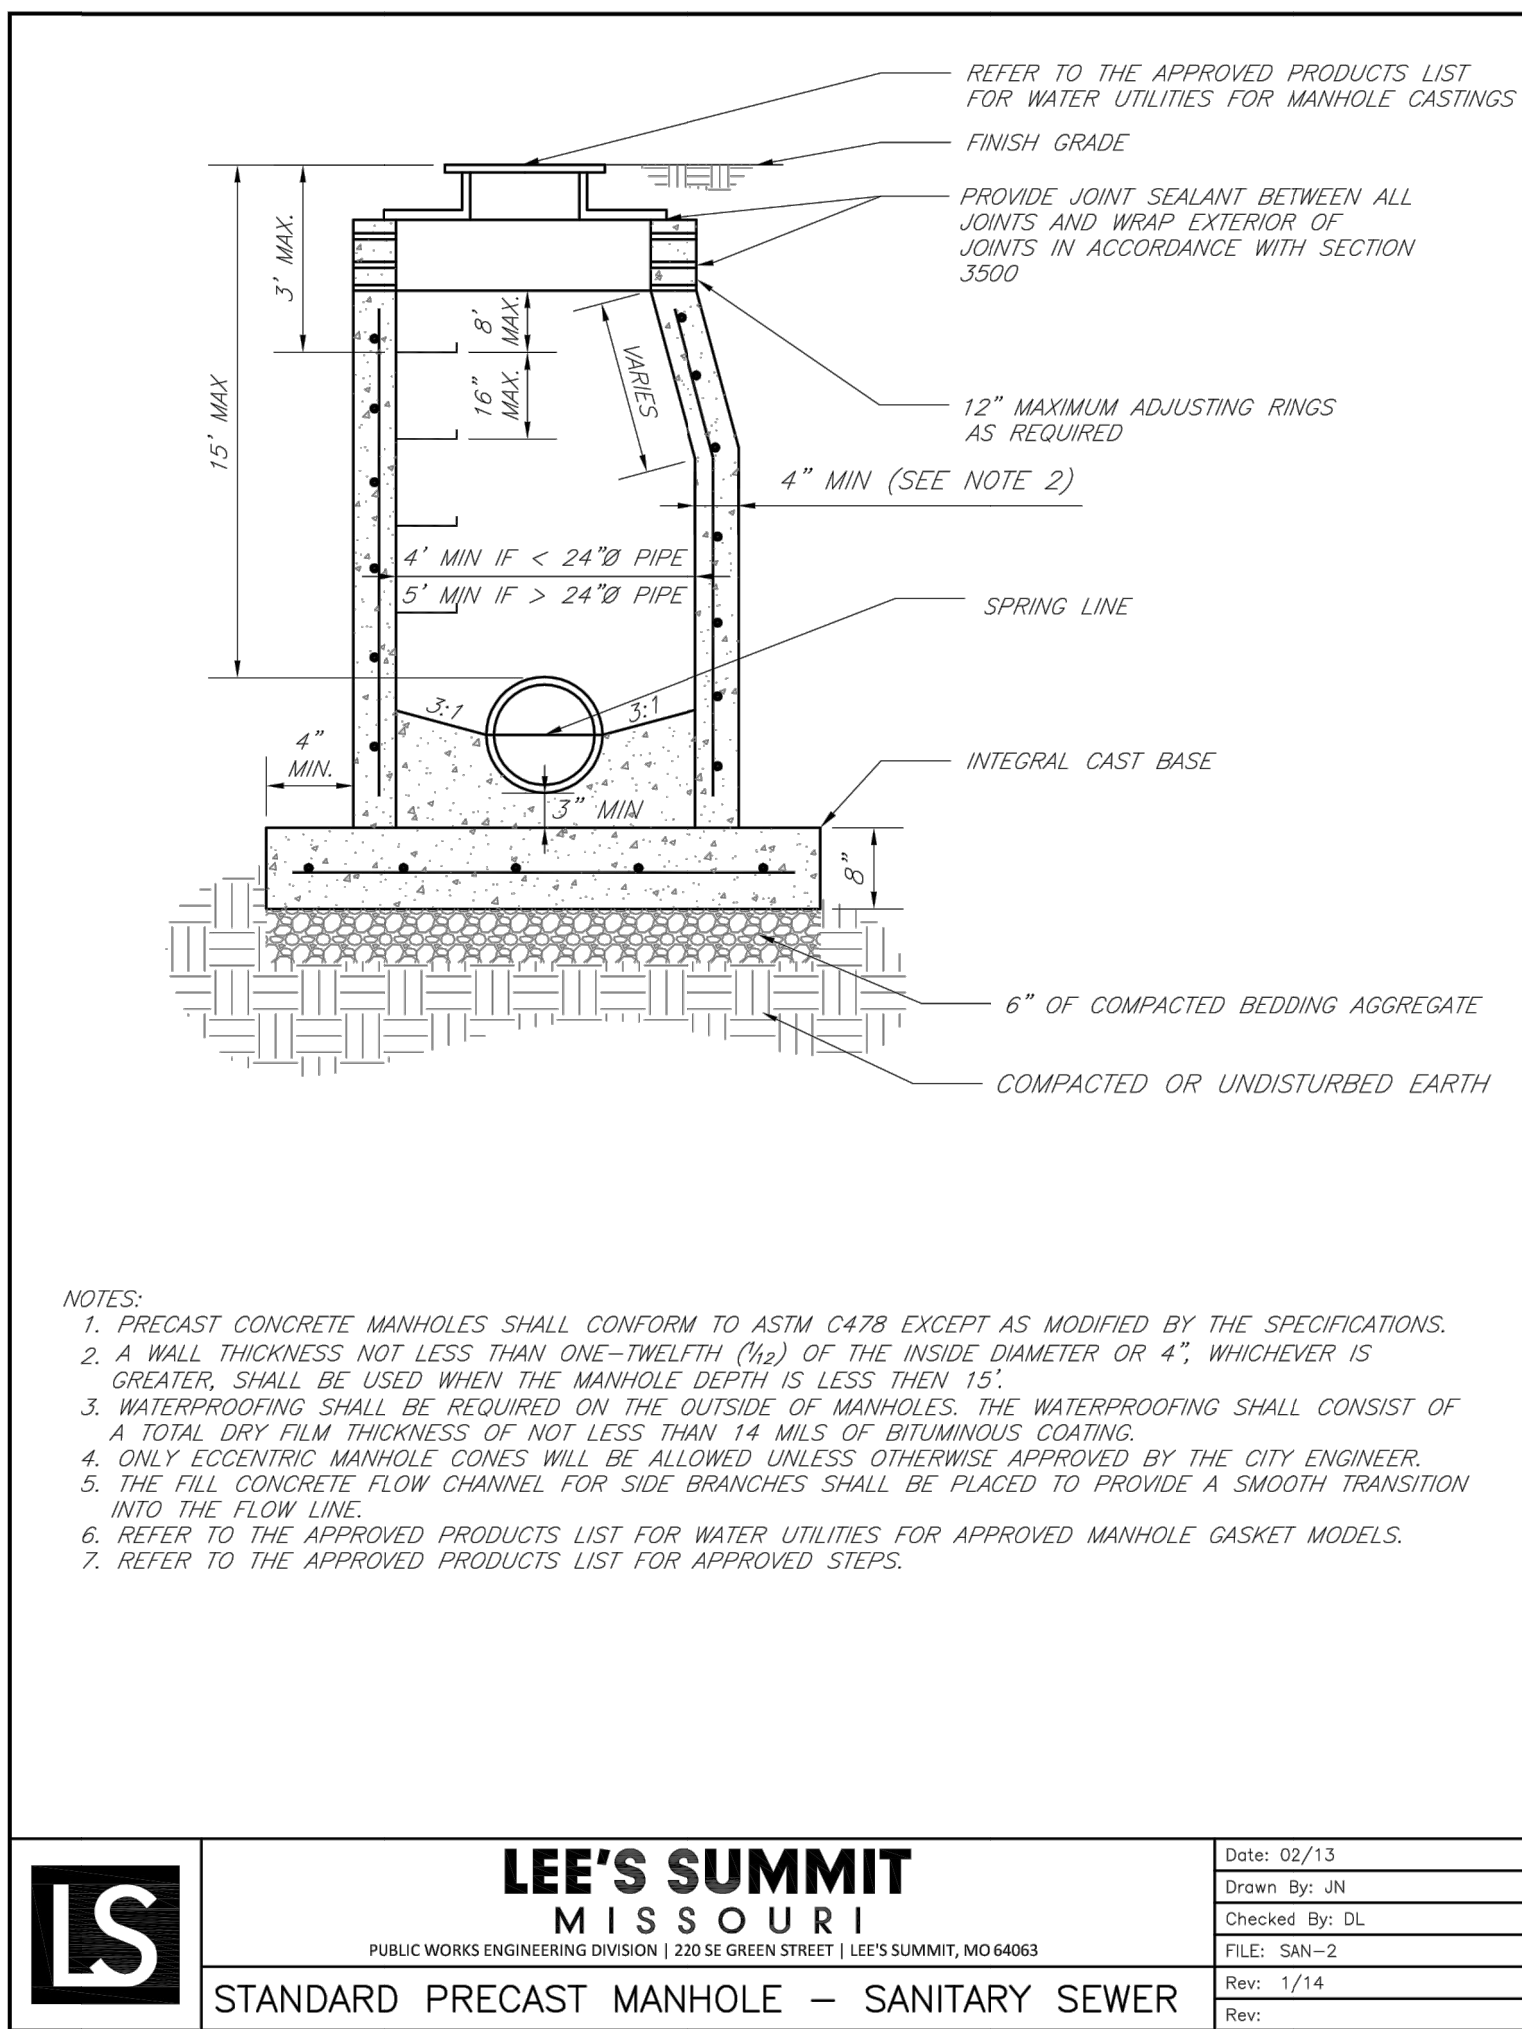
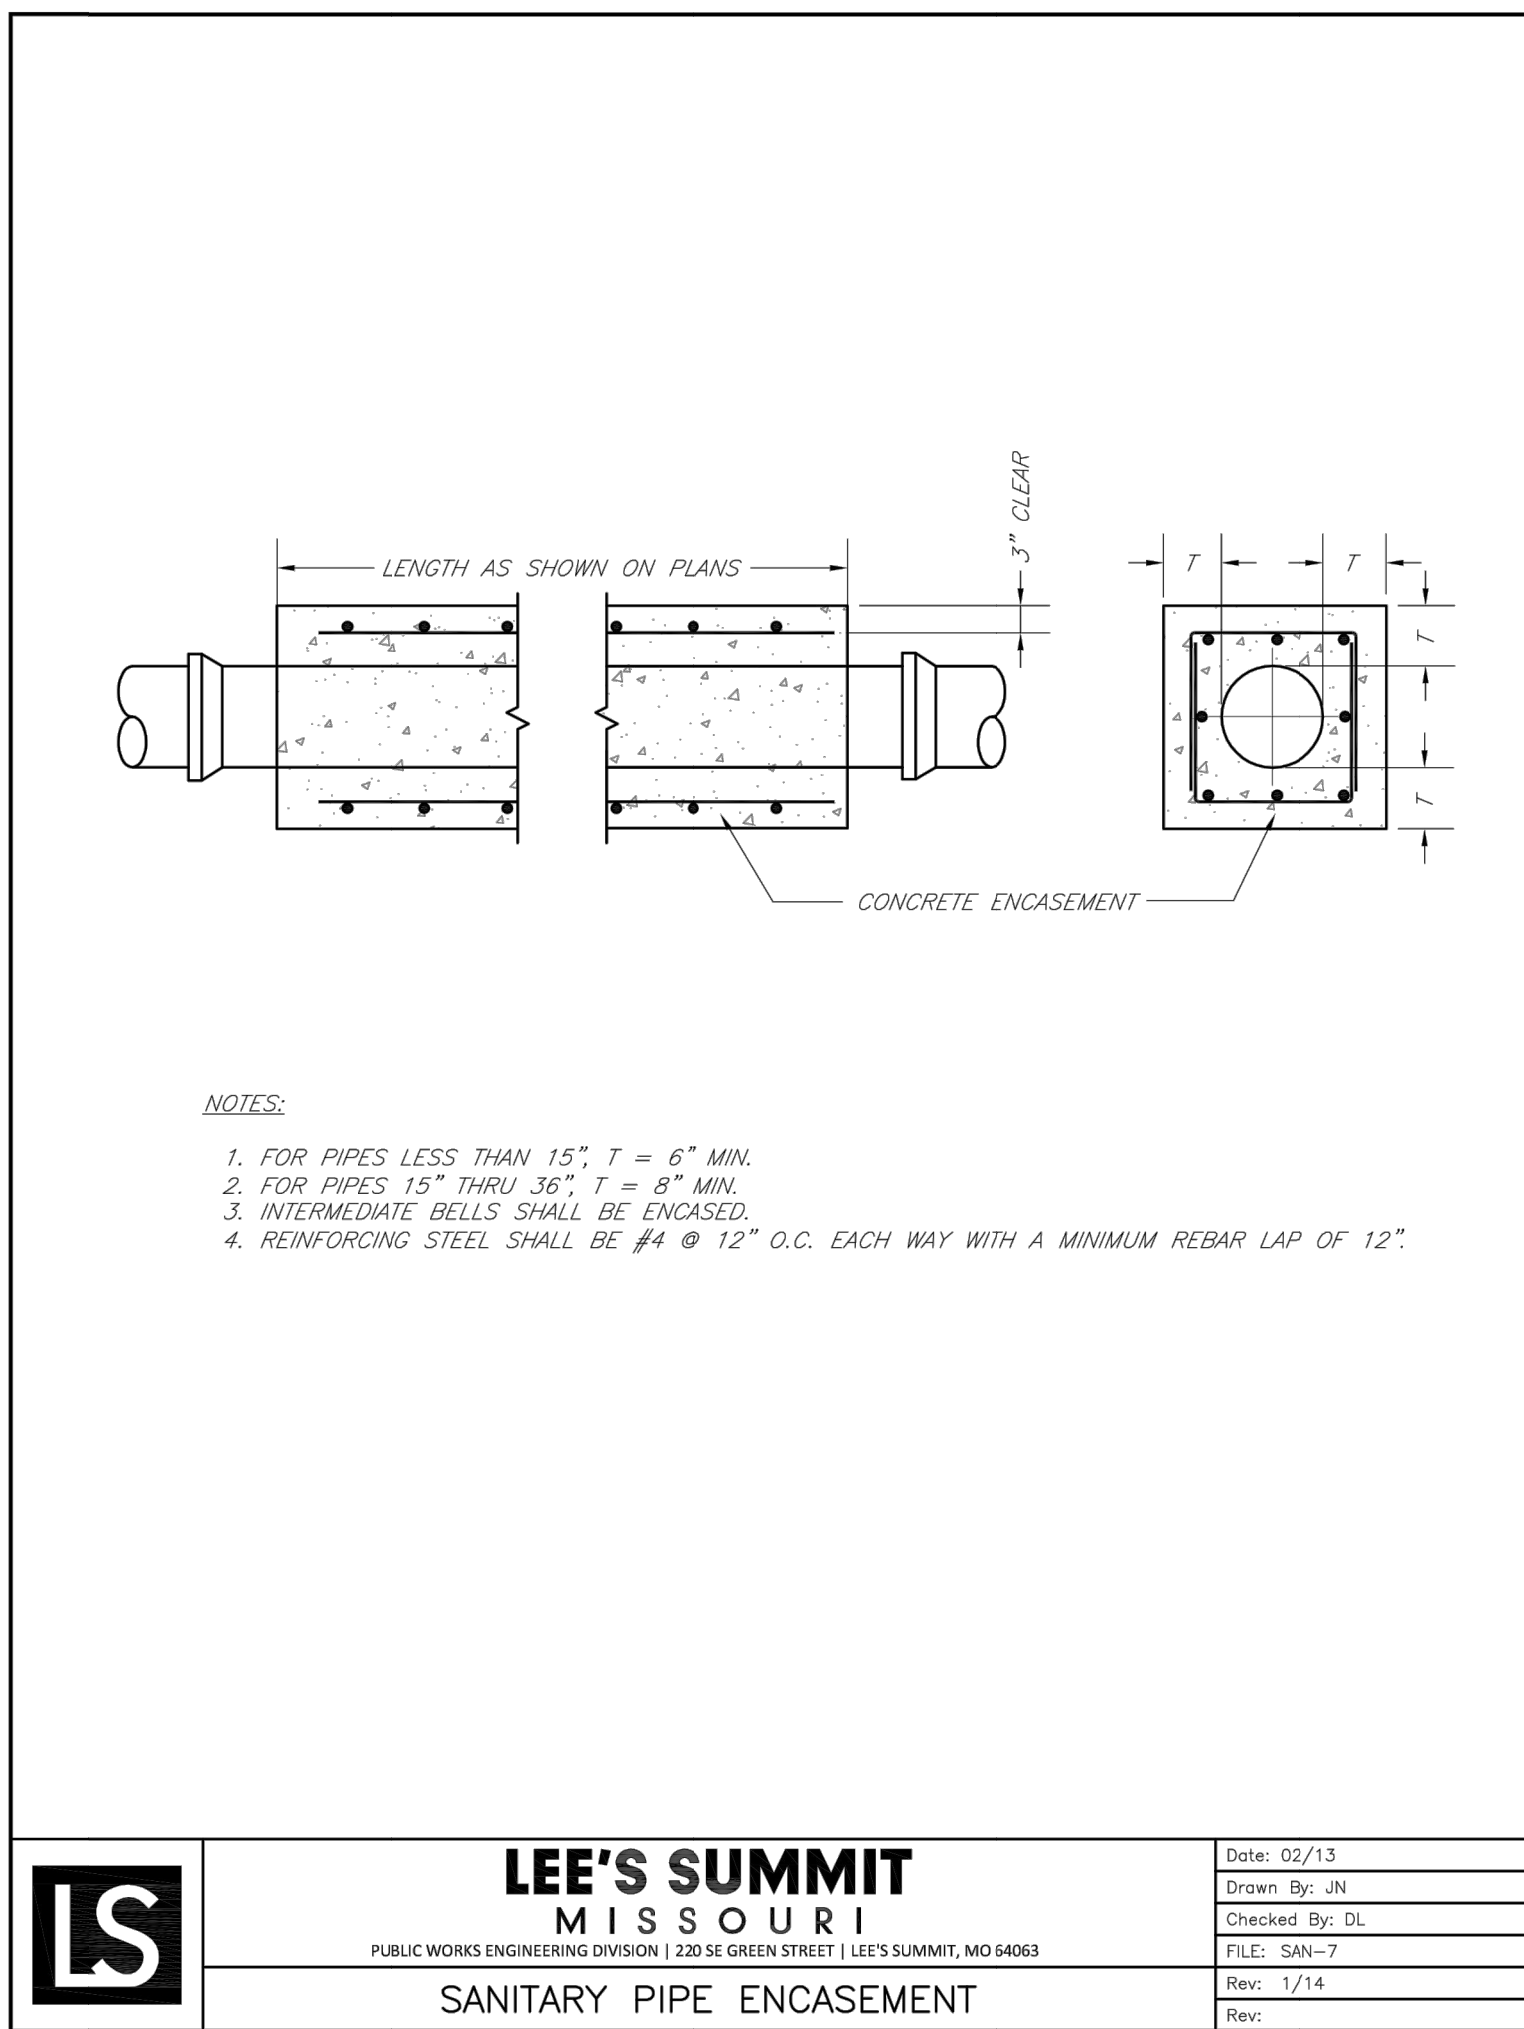
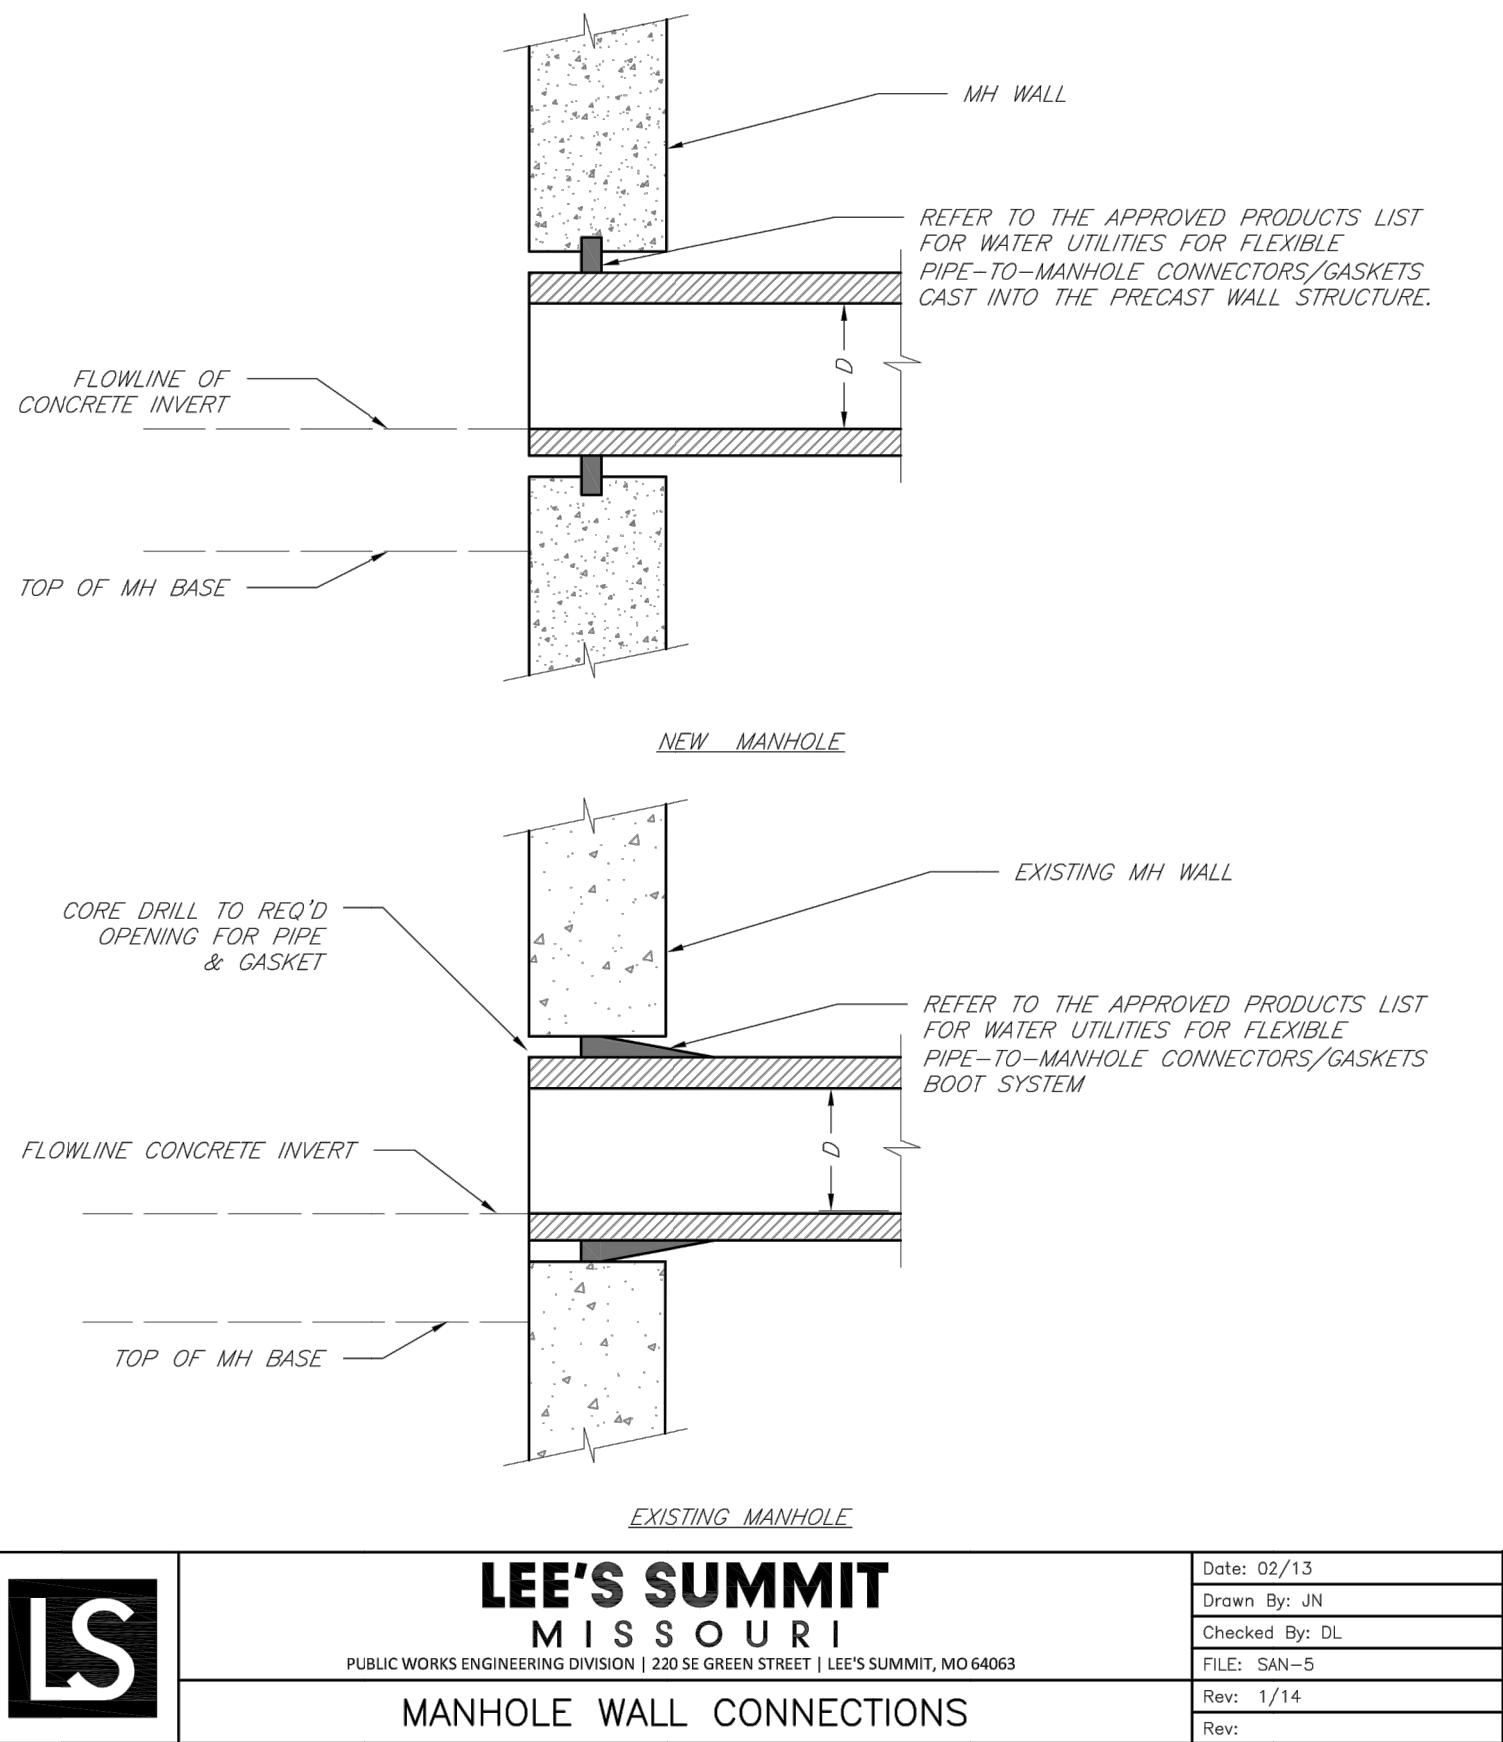


L:\Engineering\0316050 SVFD00 Summit View Forms 3rd Plat\DRAWINGS\CONSTRUCTION DRAWINGS\PAV-PLANS\0316050-DETAILS.dwg, 7/20/2018 7:42:38 AM, JAMIE MCKURRY, LAMP RYNEARSON & ASSOCIATES

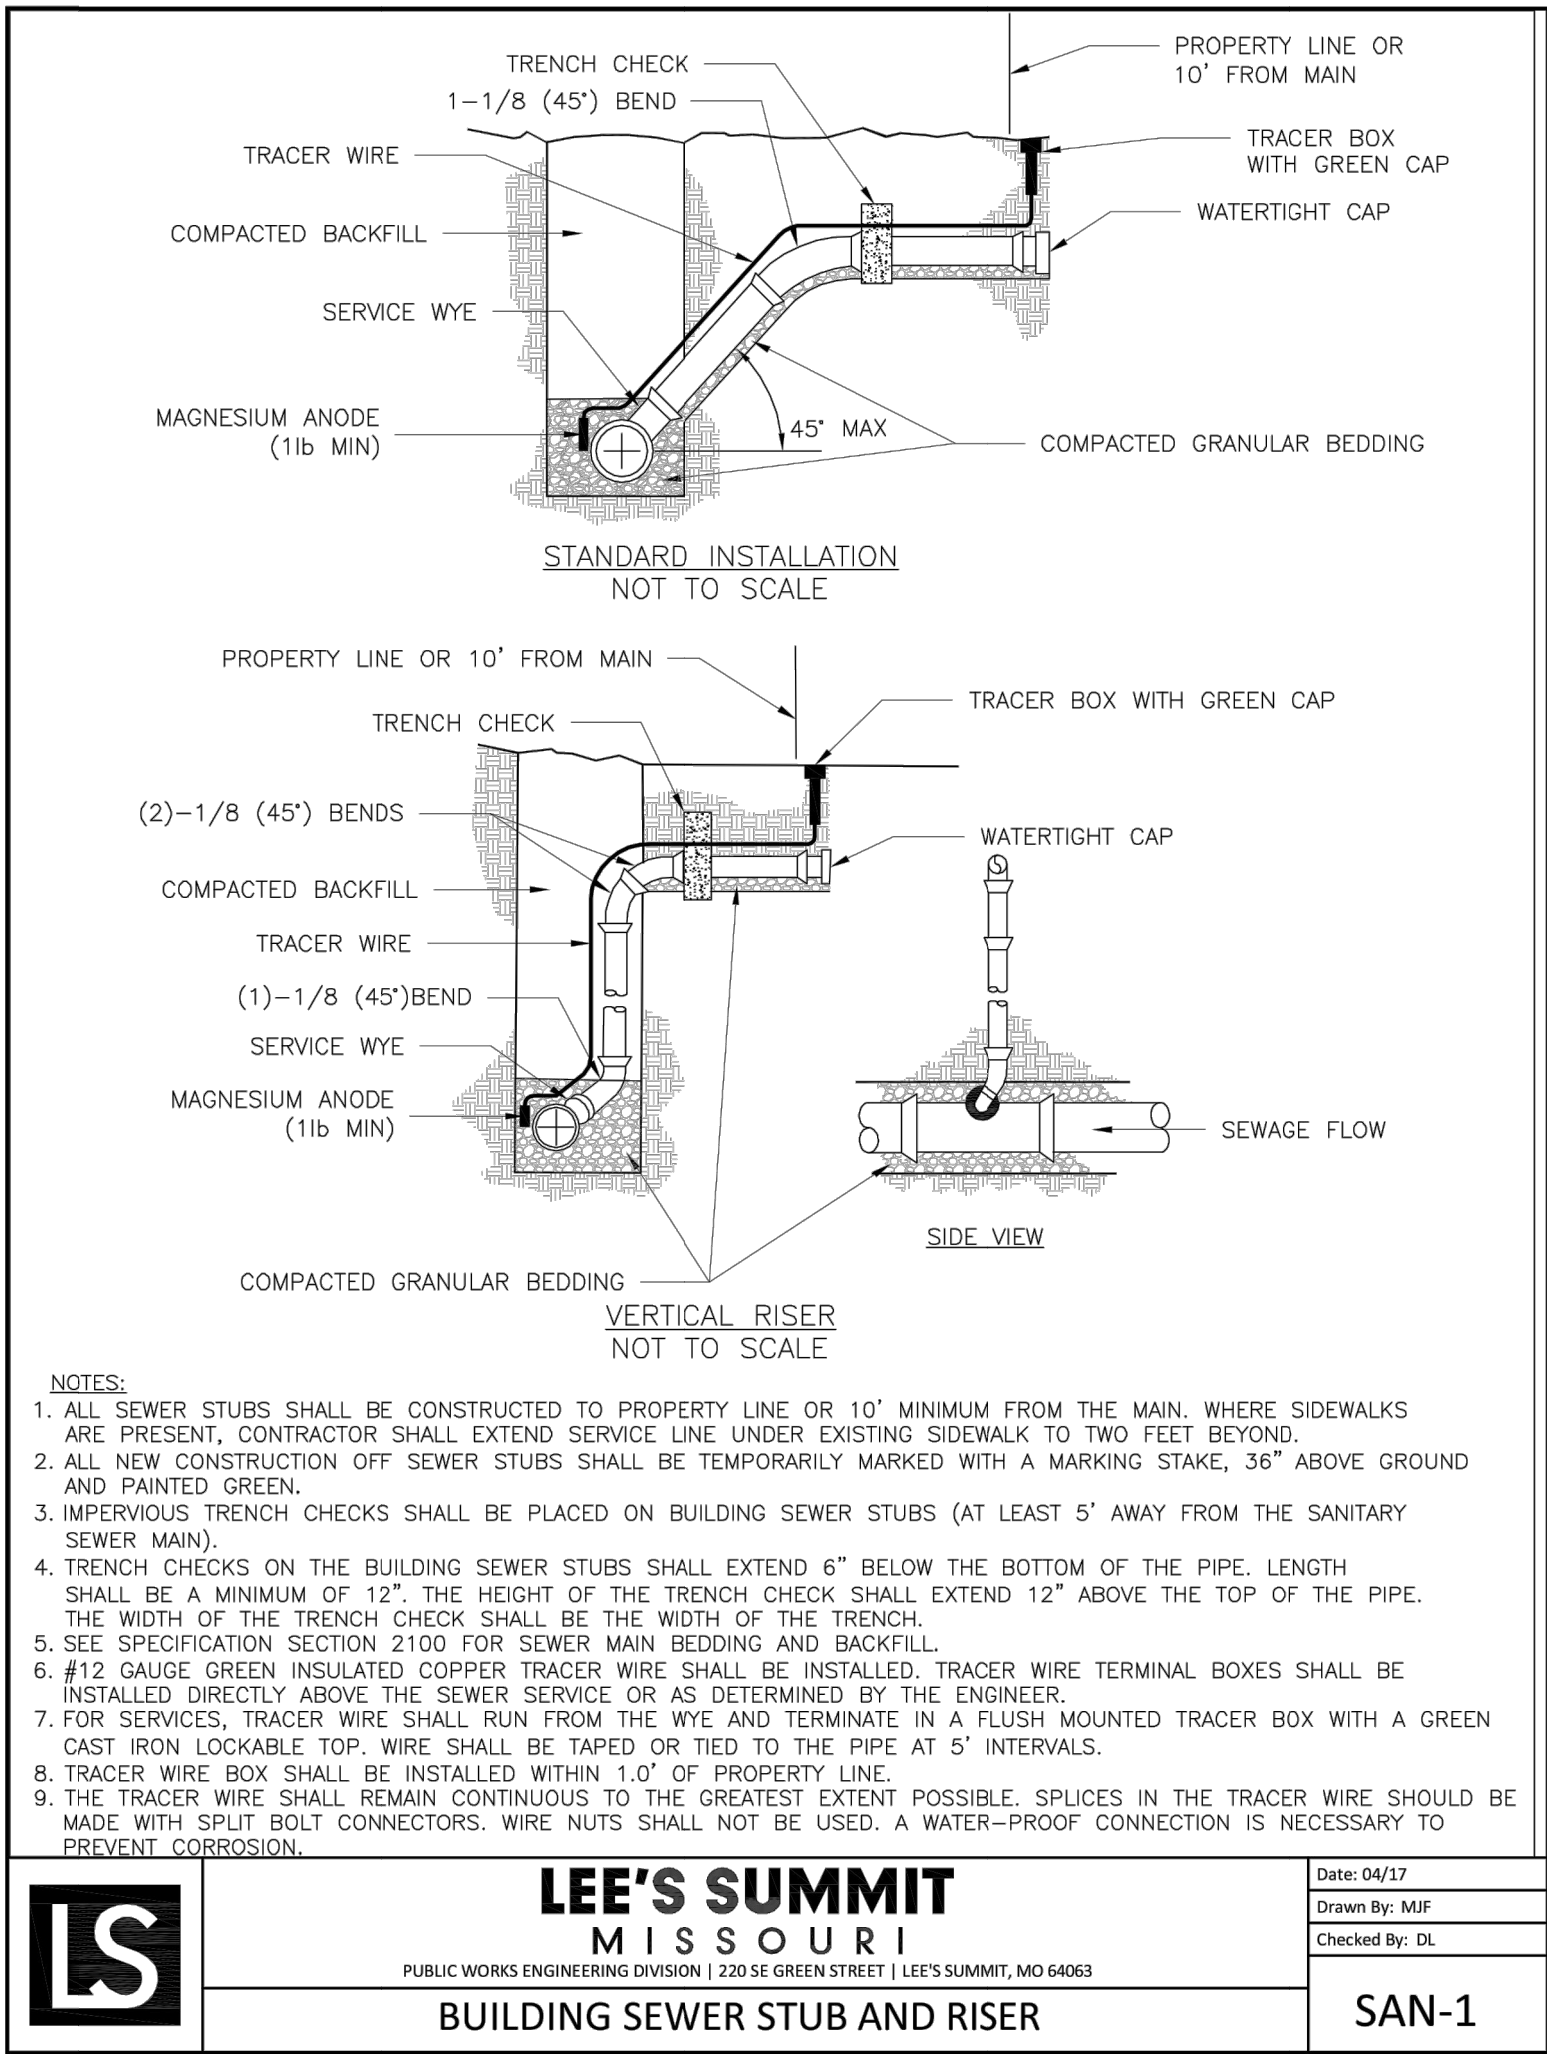

DRAWN BY JN	DESIGNED BY JN	DATE JULY 20, 2018	JOB NUMBER-TASKS 0316050.01	BOOK AND PAGE
9001 State Line Rd., Suite 200   816.361.0440   P Kansas City, Missouri 64114   816.361.0045   F www.LRA-INC.com				
<b>LARKIN/LAMP RYNEARSON</b>				
SUMMIT VIEW FARMS 3RD PLAT LEE'S SUMMIT, MISSOURI				
PAVING, STORM AND SANITARY PLANS DETAIL SHEET				
LARKIN LAMP RYNEARSON - ENGINEERS MO Certificate of Authority No. 2013011803				
FOR REVIEW				
NOT RELEASED FOR CONSTRUCTION				
MARK DANIEL MCGHEE JR. PE - 2008019568				
SHEET				
18 OF 18				