
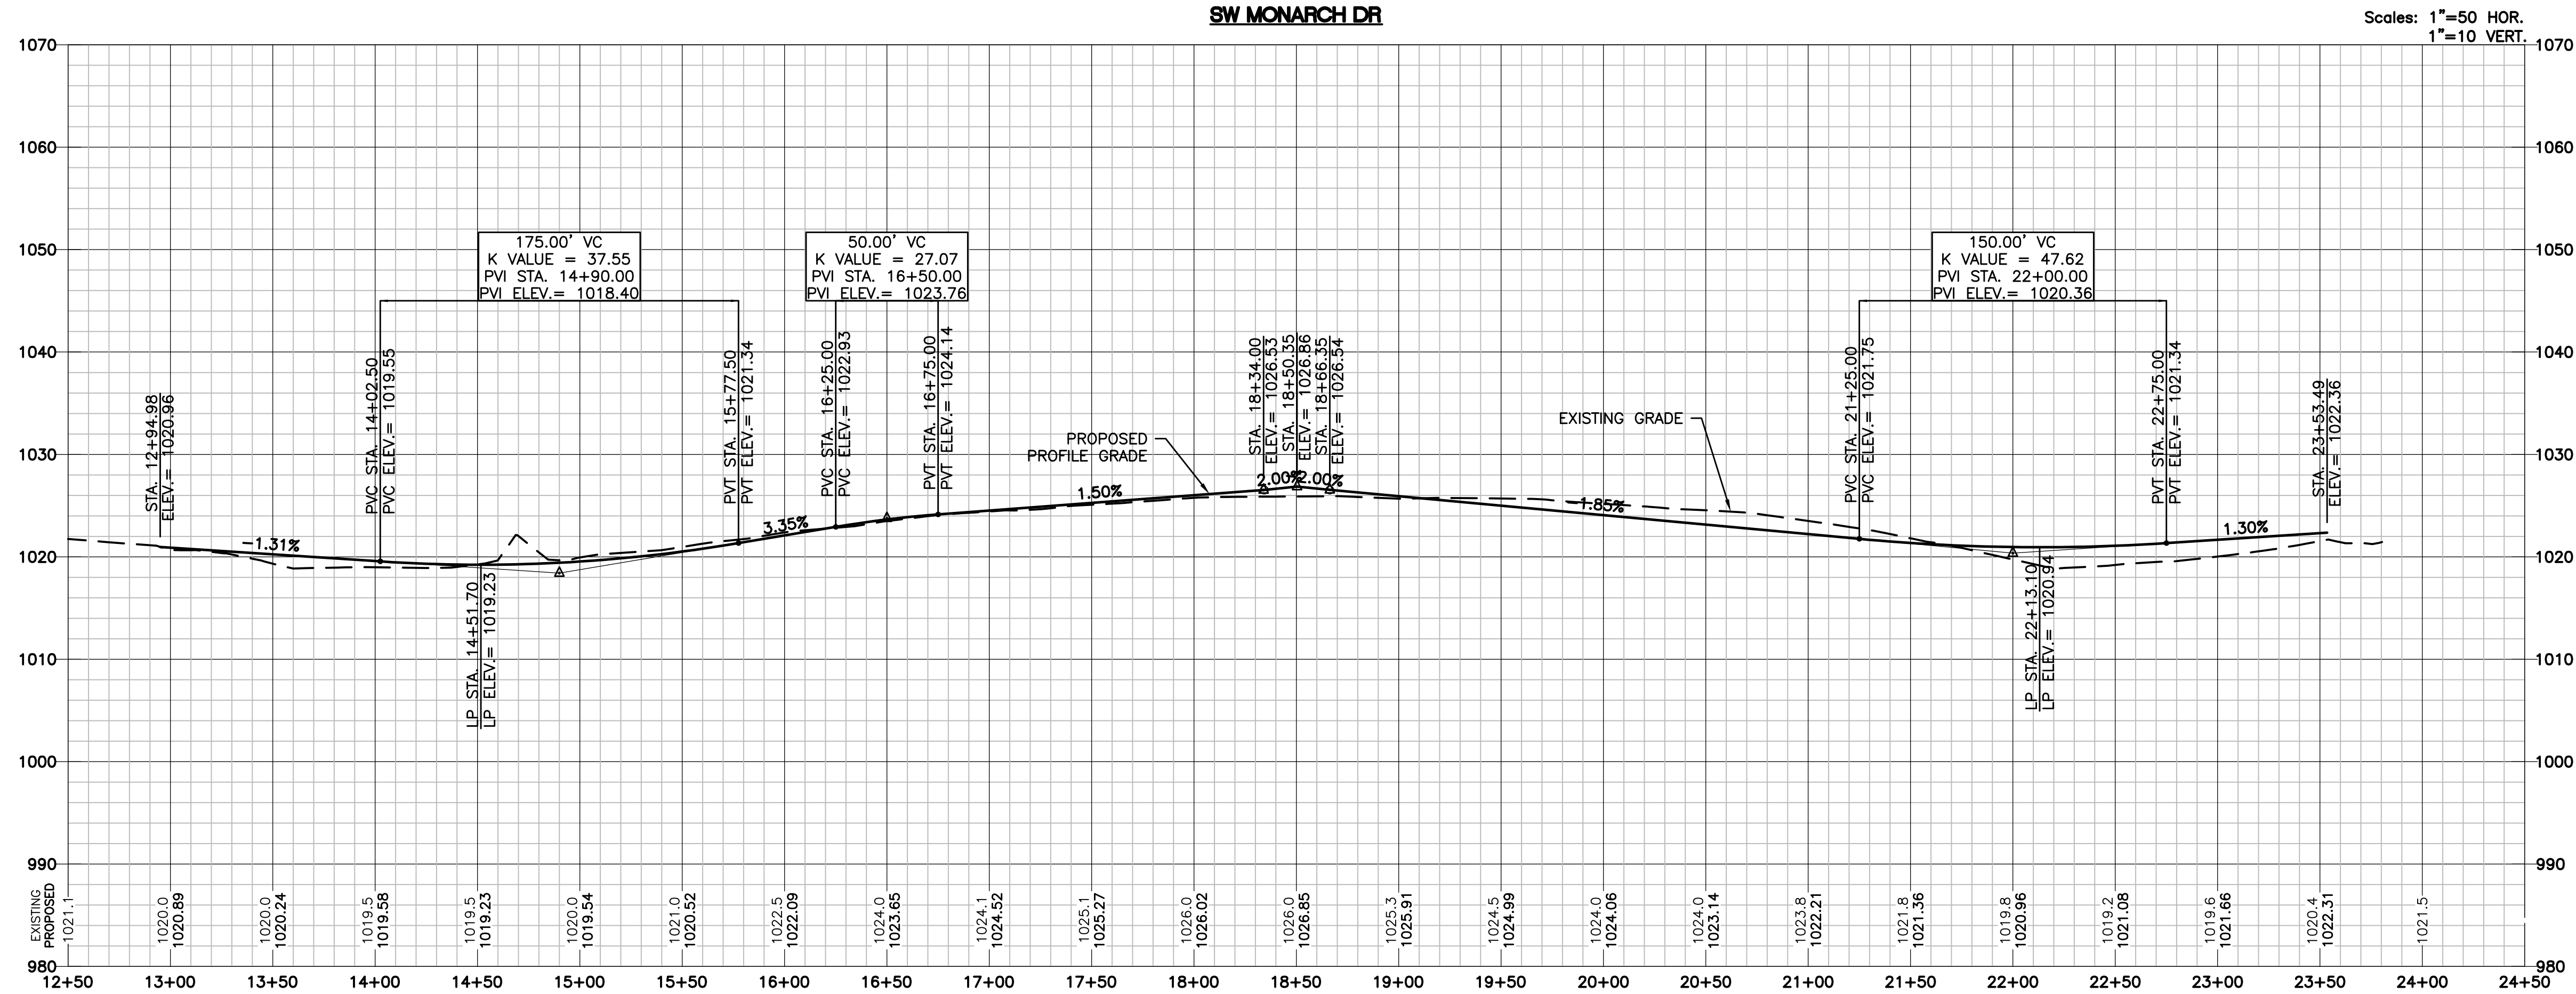


L:\Engineering\031850 SVFD Summit View Farms 3rd Plat\Drawings\CONSTRUCTION DRAWINGS\PAV-PLANS\PAV-PNP-01.dwg, 7/20/2018 9:20:12 AM, JAMIE MCURRY, LAMP RYNEARSON & ASSOCIATES

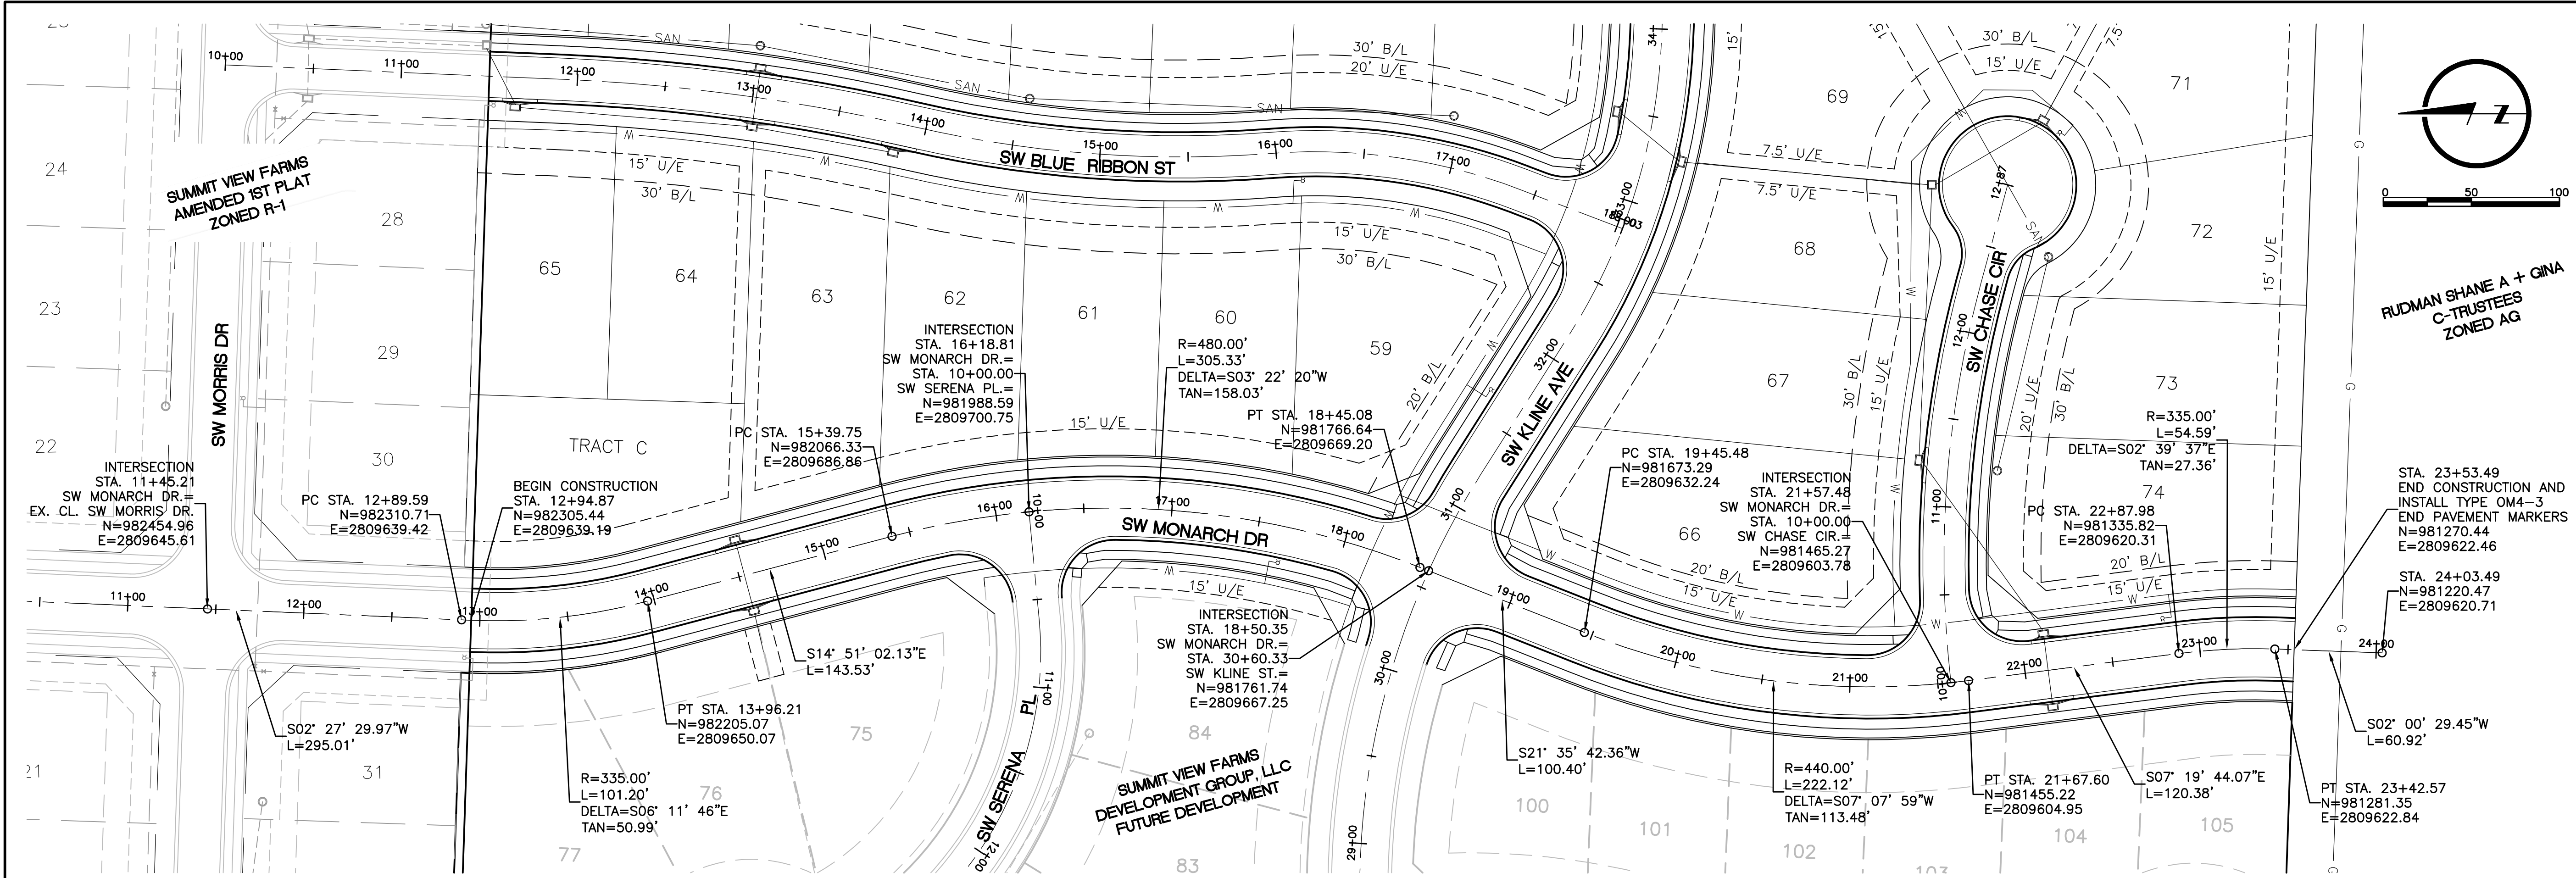

DRAWN BY		JAM		DESIGNED BY		JAM		DATE		JULY 20, 2018		JOB NUMBER-TASKS		031850.01		BOOK AND PAGE	
VERSIONS																	
9001 State Line Rd., Suite 200 Kansas City, Missouri 64114 www.LRA-inc.com																	
LARKIN/LAMP RYNEARSON																	
SUMMIT VIEW FARMS 3RD PLAT LEE'S SUMMIT, MISSOURI																	
PAVING, STORM AND SANITARY PLANS																	
SW MONARCH DRIVE STREET PLAN/PROFILE SHEET																	
LARKIN LAMP RYNEARSON - ENGINEERS MO Certificate of Authority No. 2013011903																	
FOR REVIEW																	
NOT RELEASED FOR CONSTRUCTION																	
MARK DANIEL MCGHEE JR. PE - 2008019568																	
SHEET																	
05 OF 18																	