

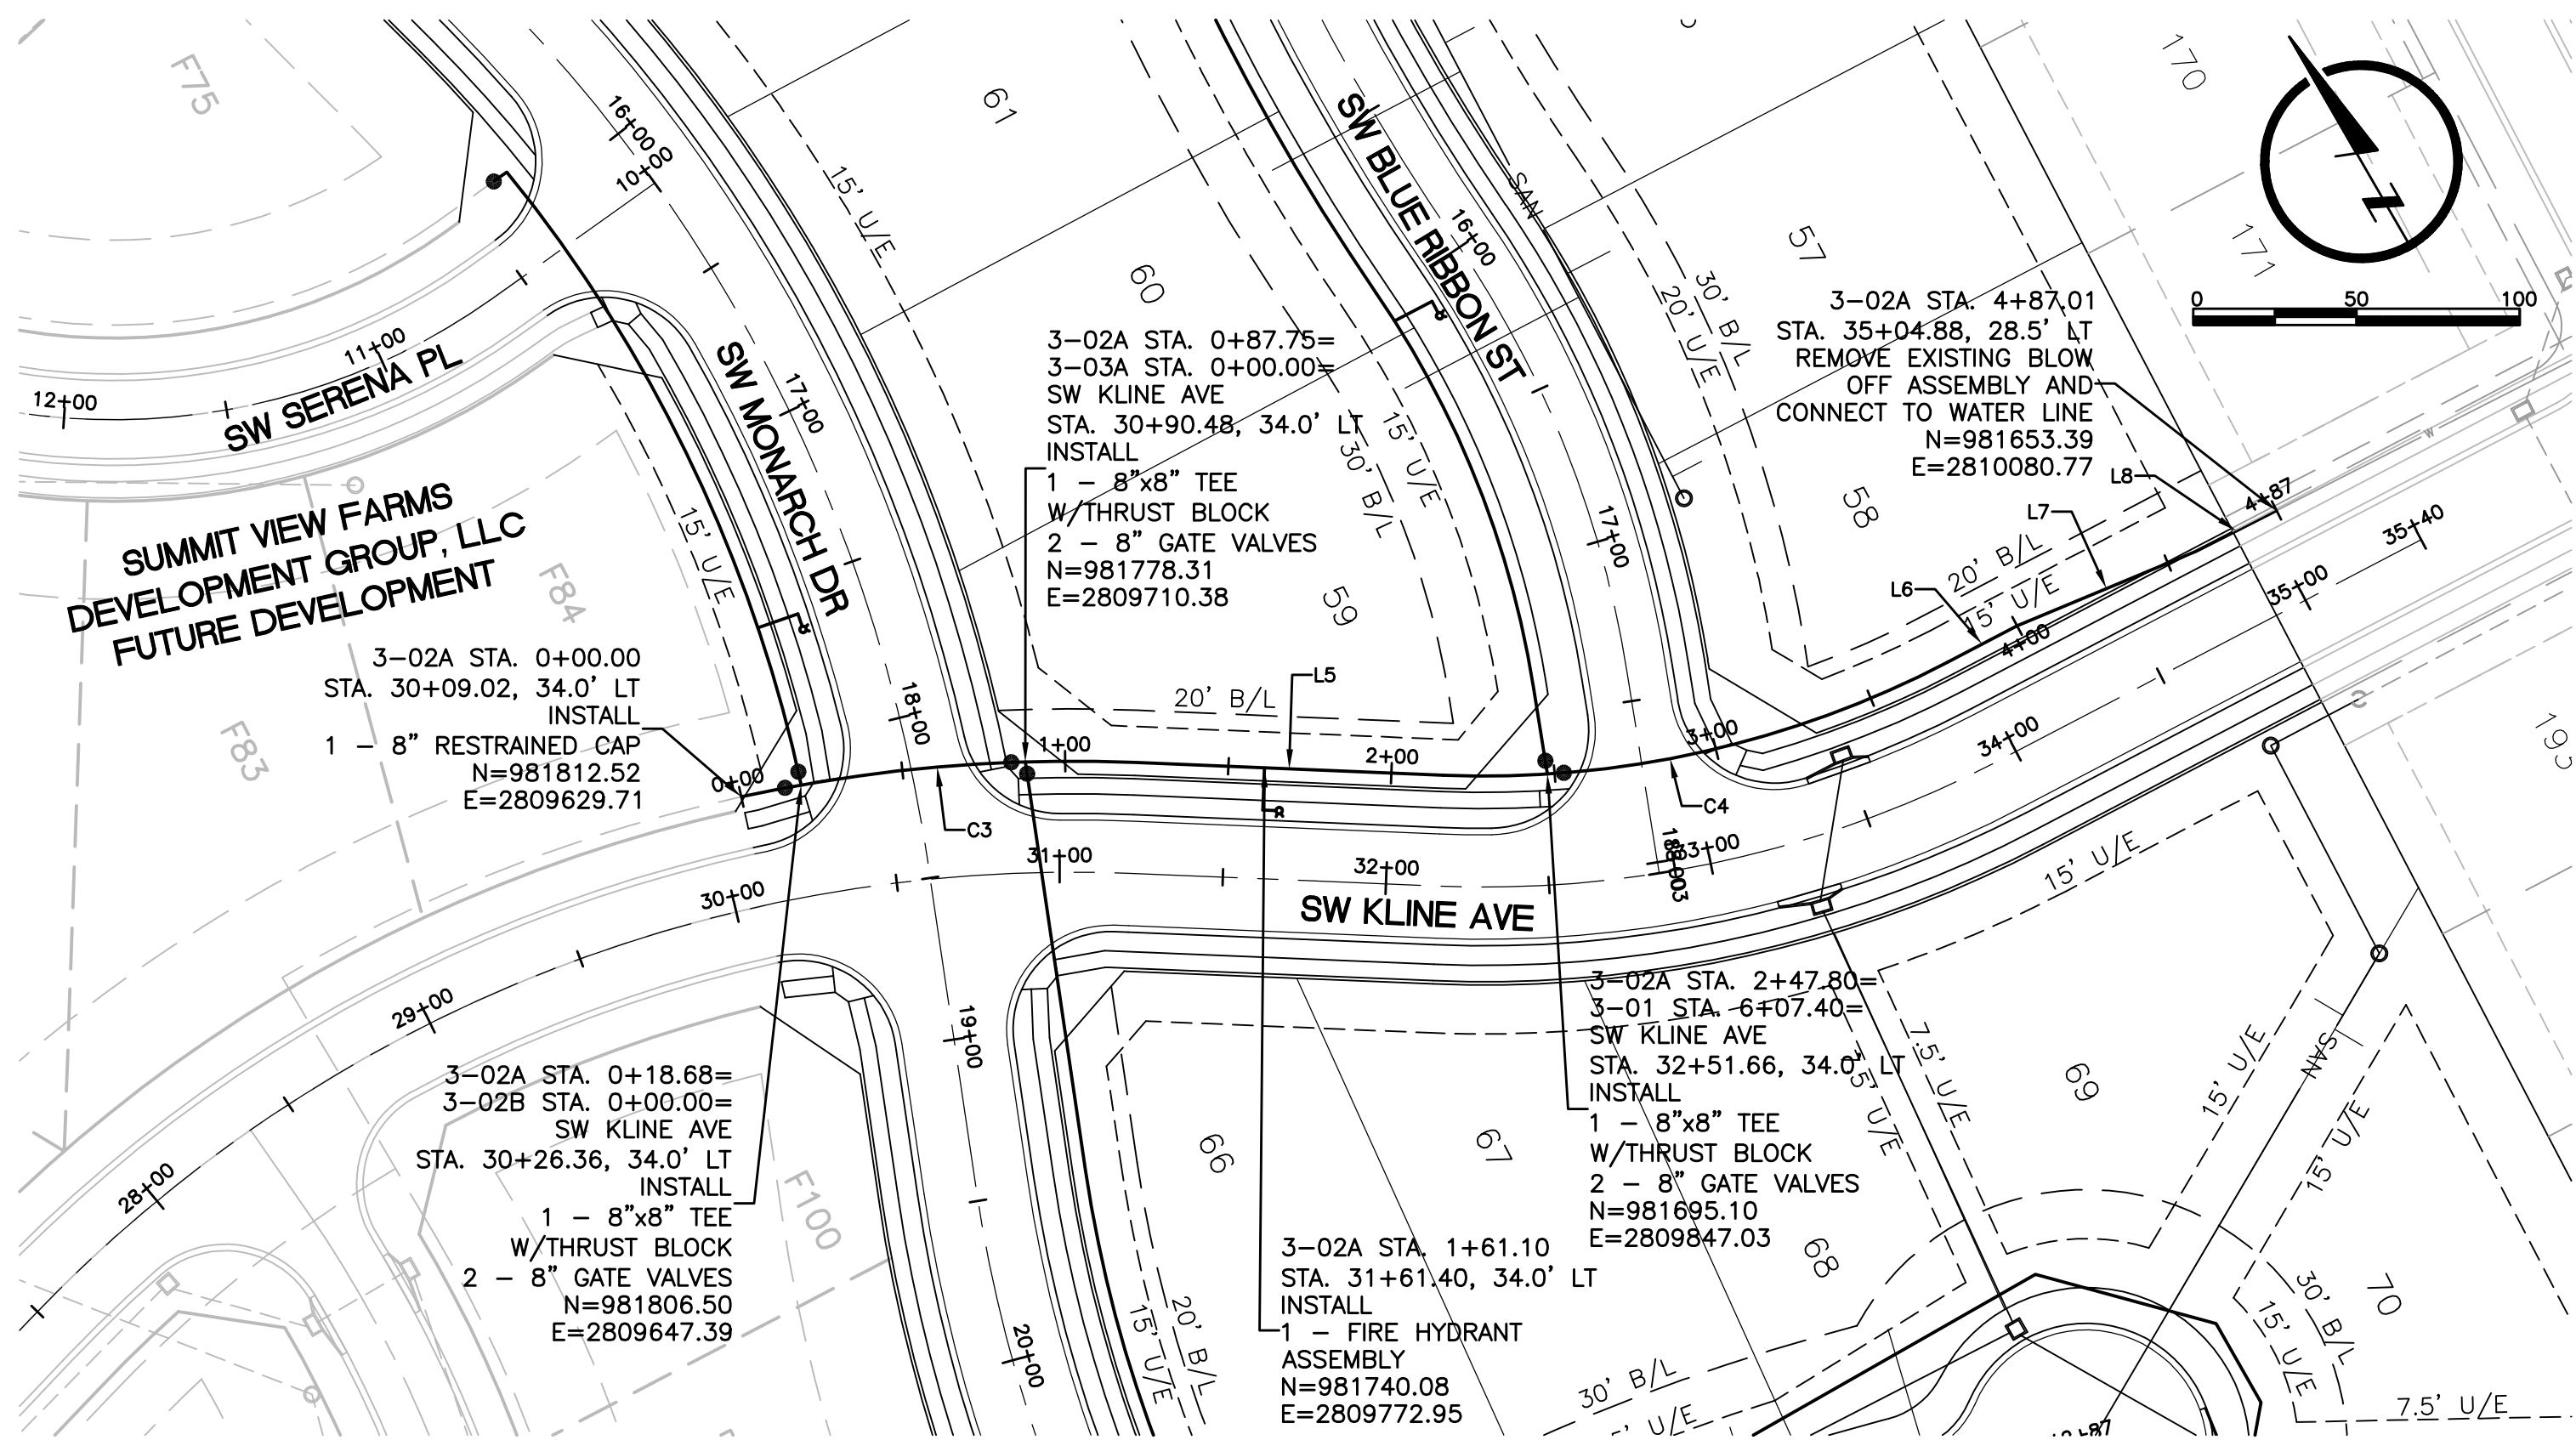



L:\Engineering\0318050 SVFDG Summit View Farms 3rd Plat\Drawings\CONSTRUCTION DRAWINGS\WATER PLANS\WATER LINE 3-02A.dwg, 7/20/2018 8:22:04 AM, JAMIE MCURRY, LAMP RYNEARSON & ASSOCIATES

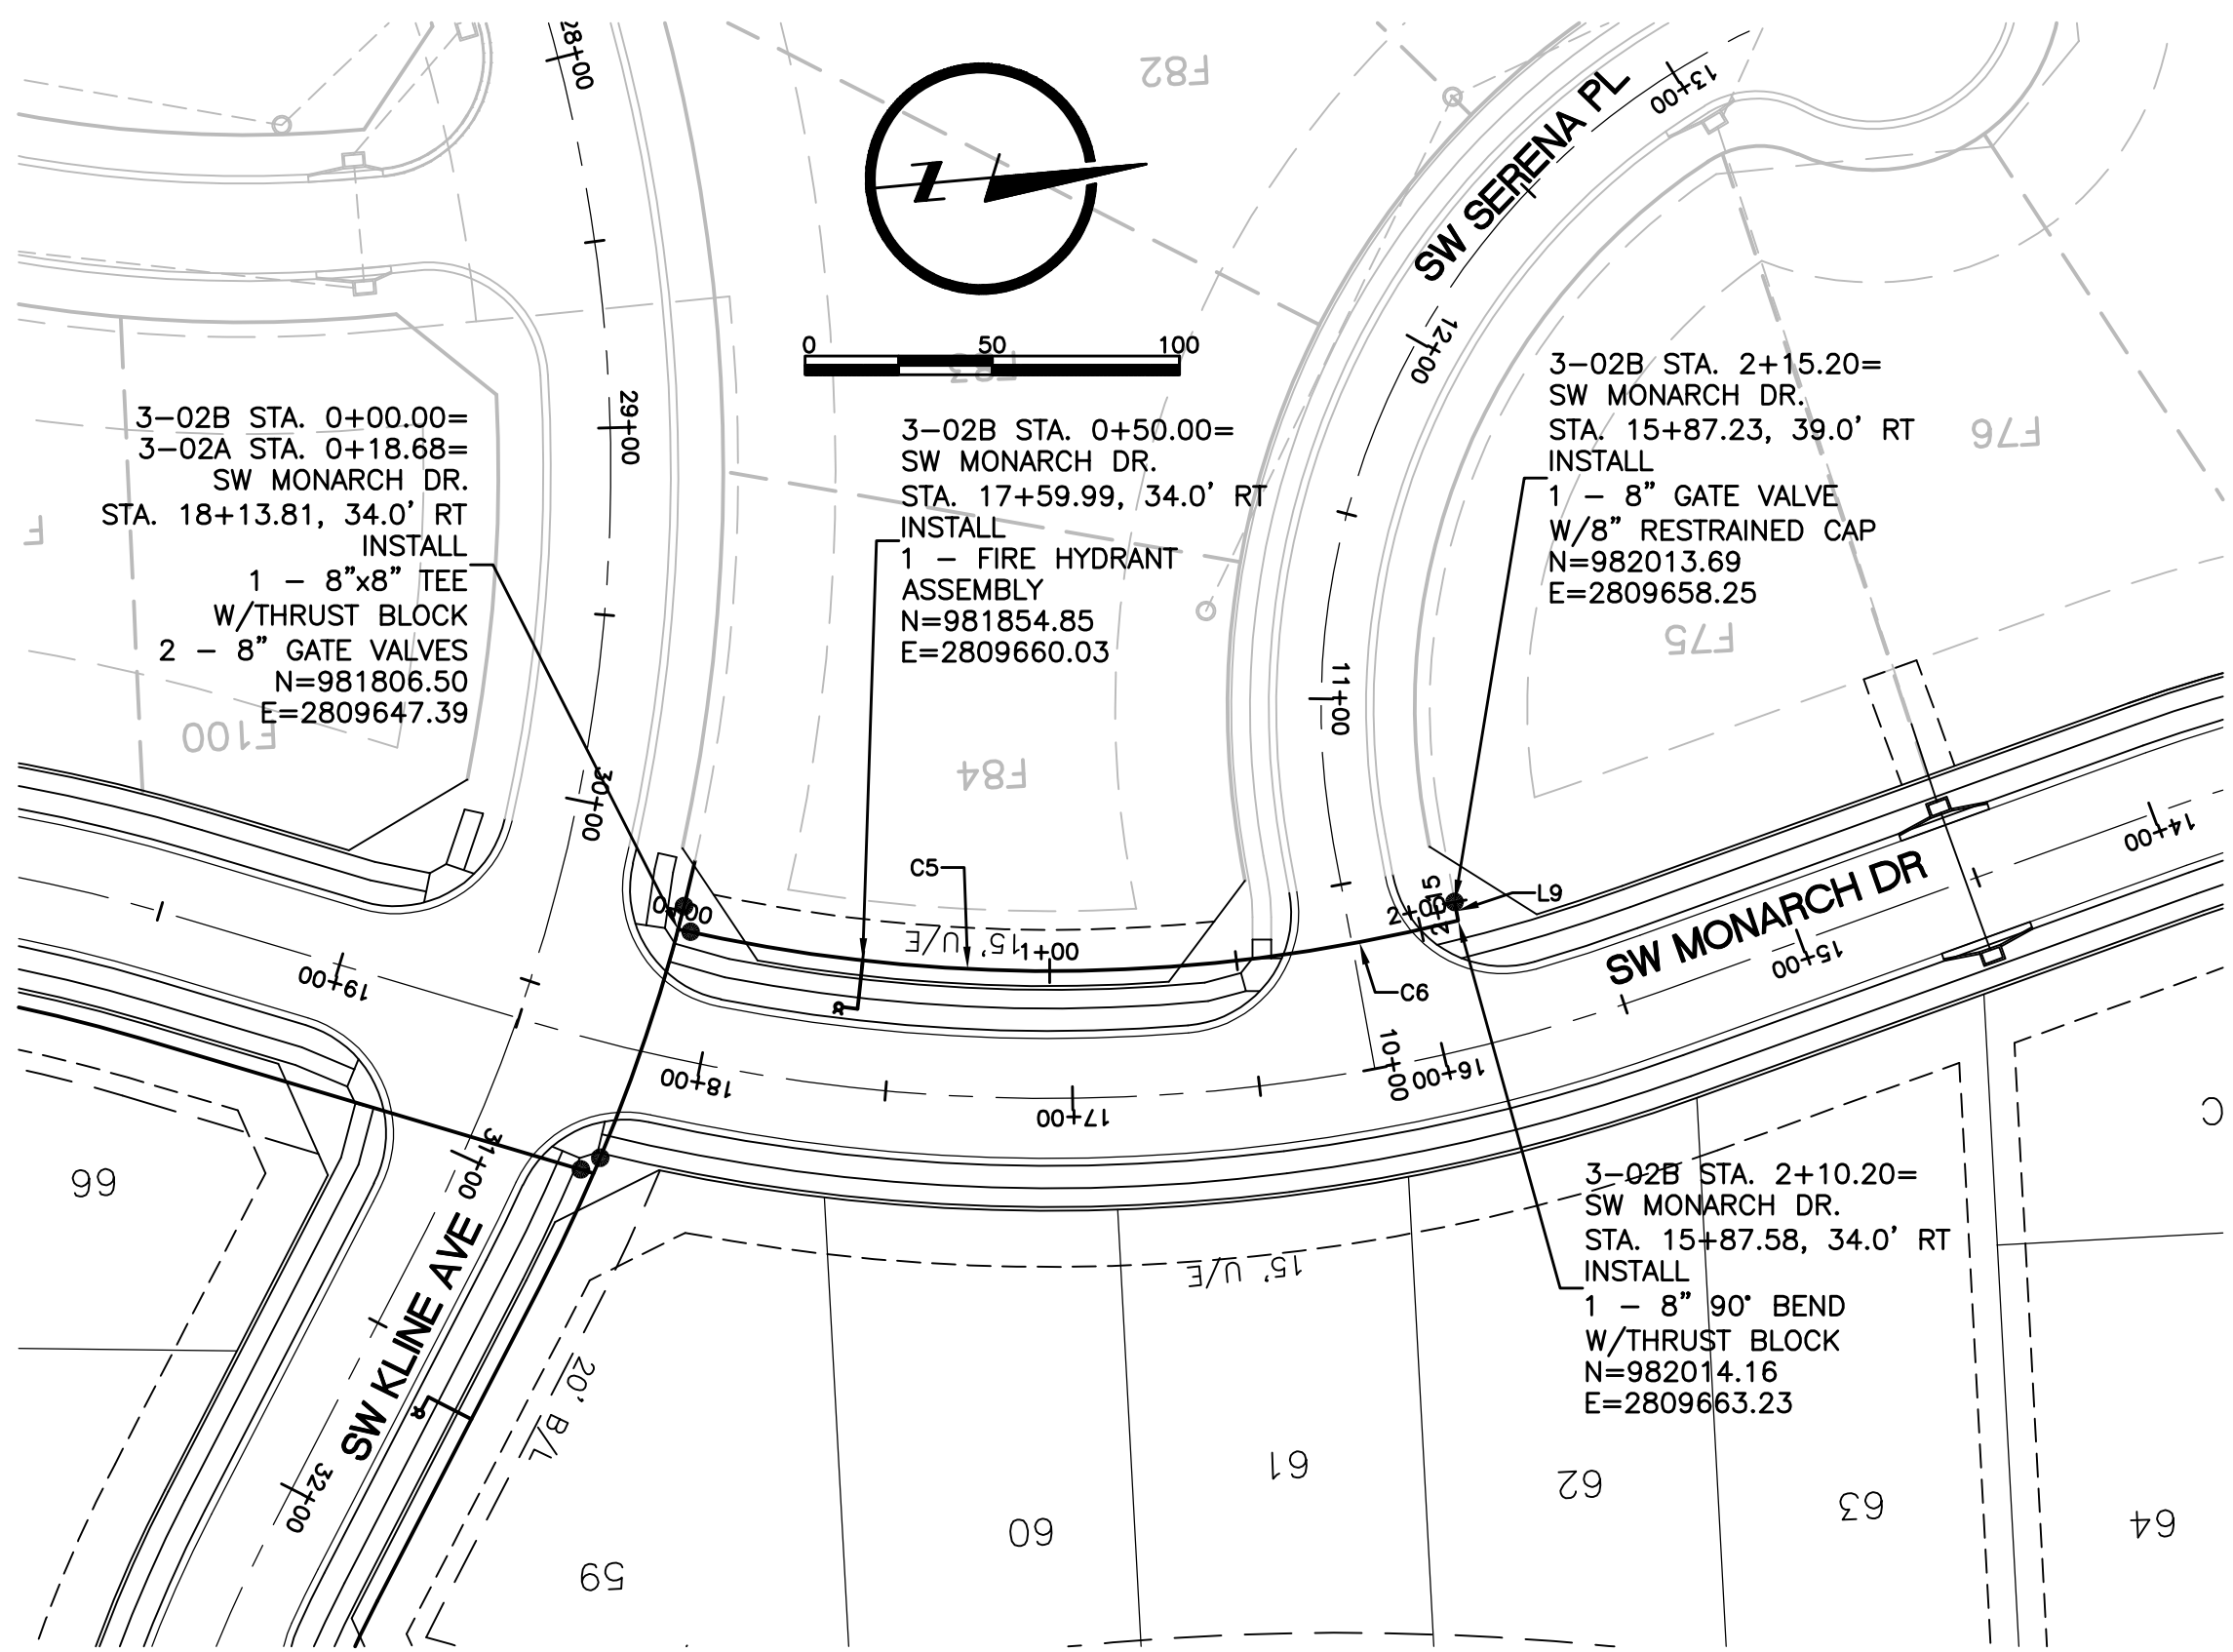

ALIGNMENT TABLE					
Line #/Curve #	Length	Direction/Delta	Radius	BEGIN NORTHING/EASTING	END NORHTING/EASTING
C3	121.52	014.69	474.00	N=981812.52/E=2809629.71	N=981761.26/E=2809739.52
L5	94.28	S57° 37' 59.10"E		N=981761.26/E=2809739.52	N=981710.79/E=2809819.15
C4	160.14	029.99	306.00	N=981710.79/E=2809819.15	N=981663.52/E=2809970.25
L6	24.06	S87° 37' 05.61"E		N=981663.52/E=2809970.25	N=981662.52/E=2809994.29
L7	59.40	S82° 37' 05.61"E		N=981662.52/E=2809994.29	N=981654.89/E=2810053.20
L8	27.61	S86° 53' 44.47"E		N=981654.89/E=2810053.20	N=981653.39/E=2810080.77

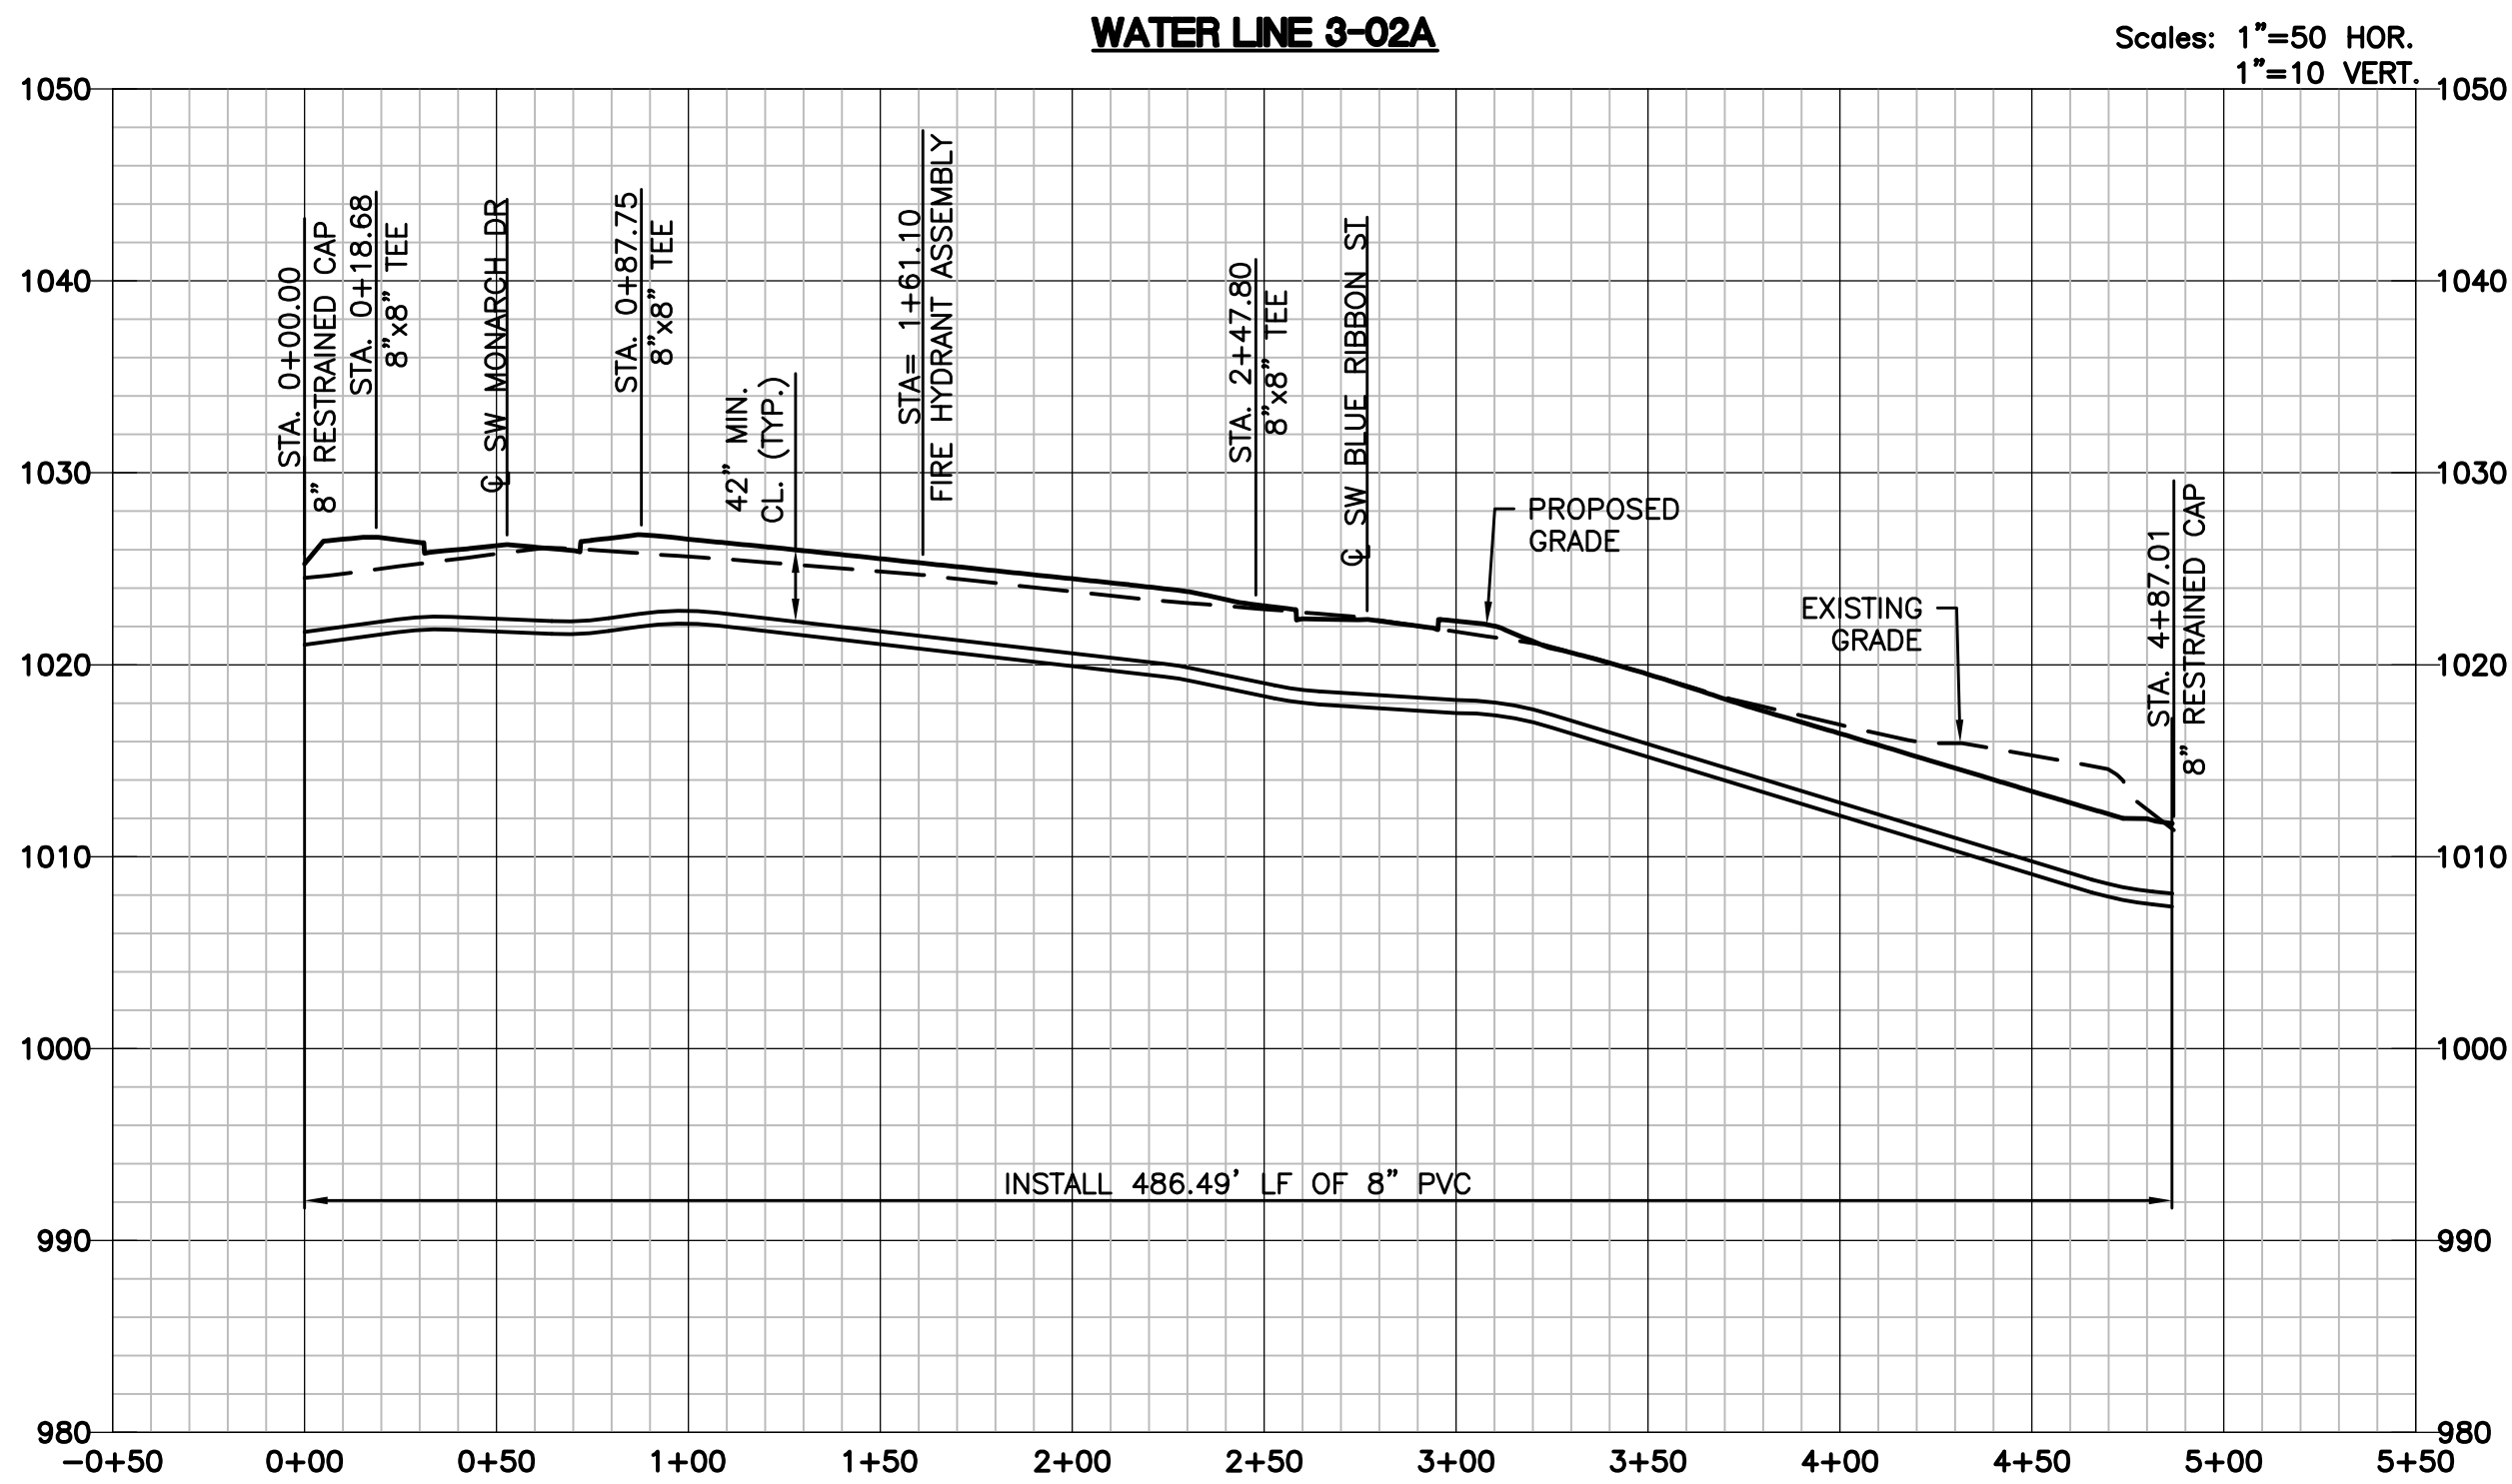

ALIGNMENT TABLE					
Line #/Curve #	Length	Direction/Delta	Radius	BEGIN NORTHING/EASTING	END NORHTING/EASTING
C5	156.24	020.07	446.00	N=981806.50/E=2809647.39	N=981960.50/E=2809668.56
C6	53.96	007.24	427.03	N=981960.50/E=2809668.56	N=982014.16/E=2809663.23
L9	5.00	S84° 35' 12.87"W		N=982014.16/E=2809663.23	N=982013.69/E=2809658.25

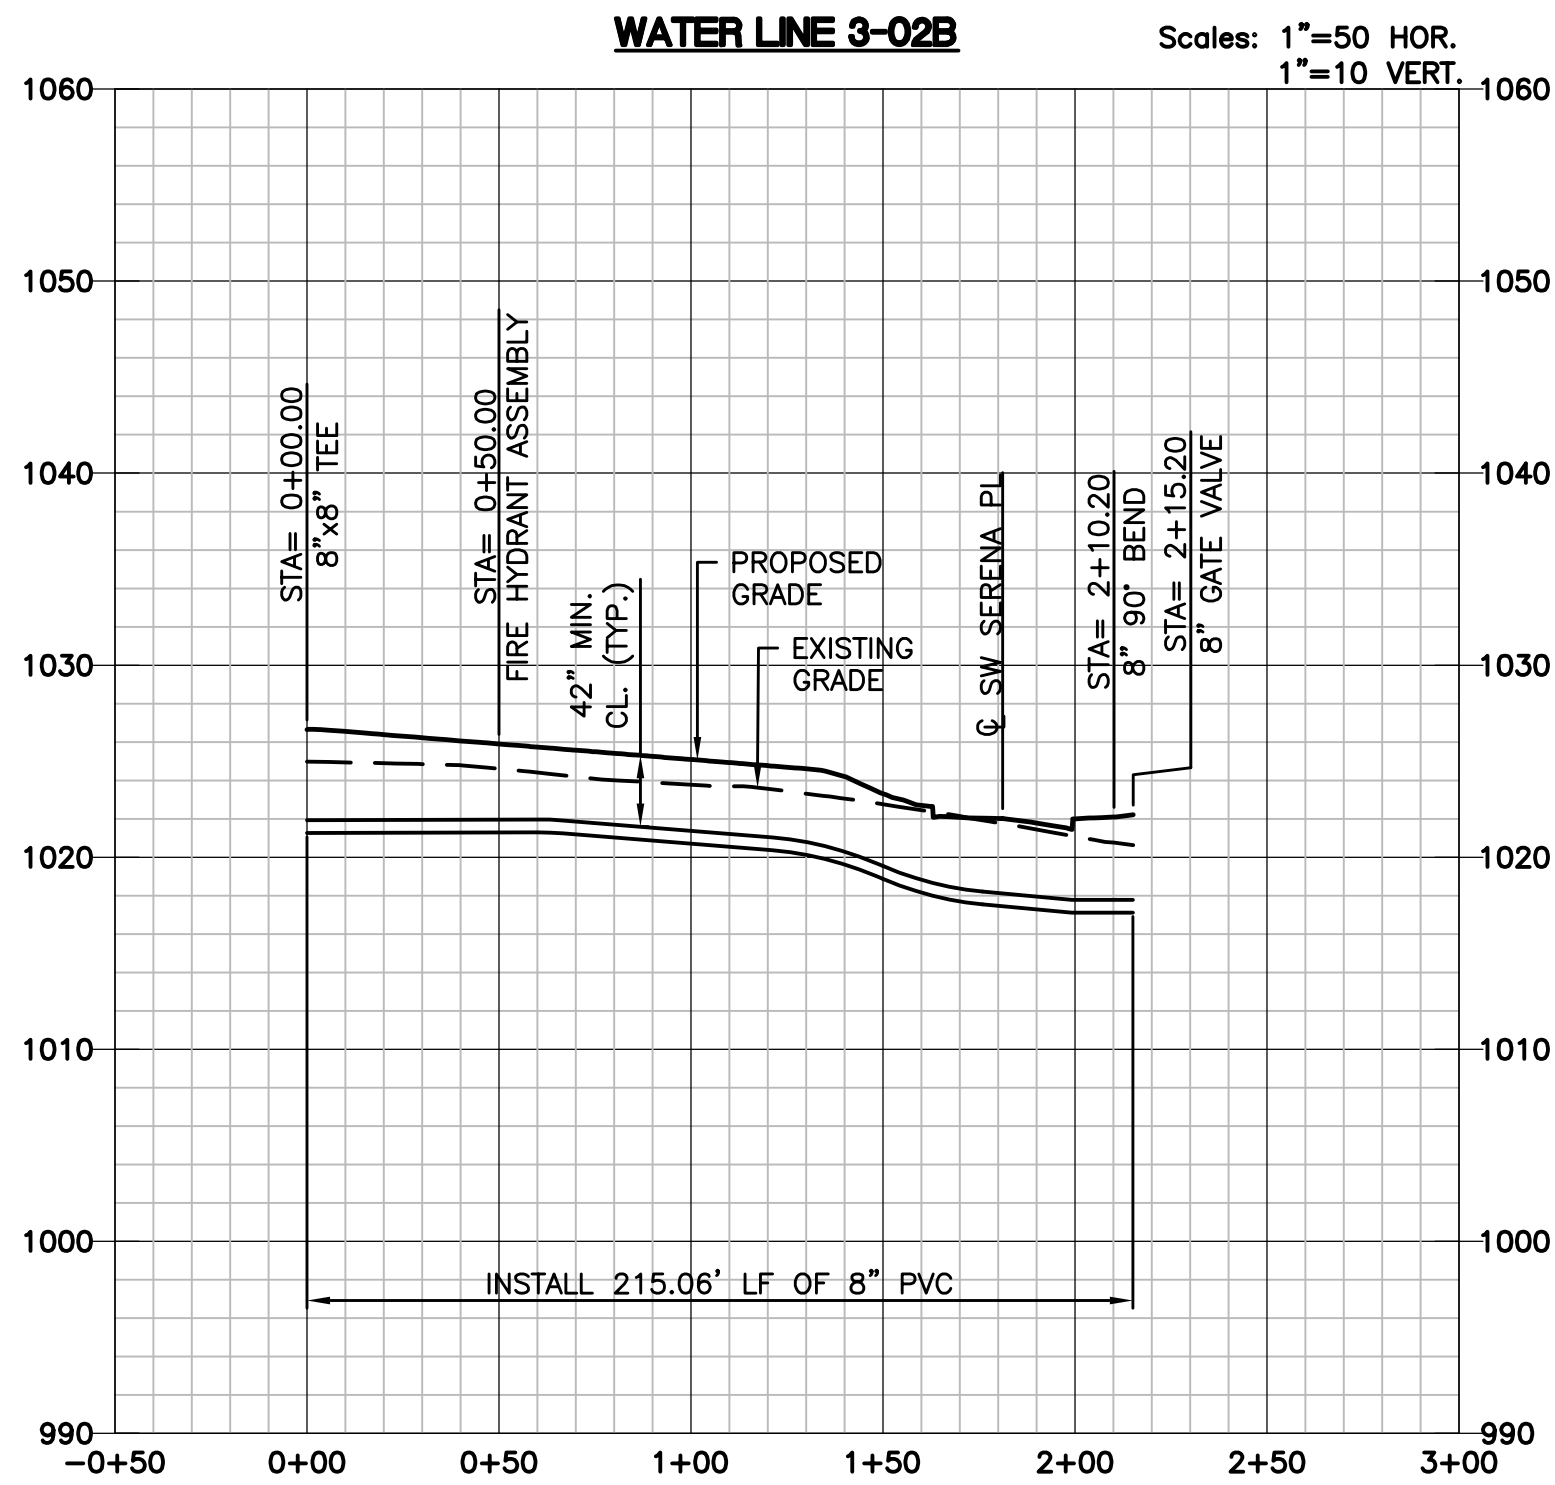

DRAWN BY
JLM

DESIGNED BY
MDM

DATE
JULY 20, 2018

JOB NUMBER-TASKS
0318050.01

BOOK AND PAGE

VERSIONS

9001 State Line Rd., Suite 200
Kansas City, Missouri 64114
www.LRA-inc.com

816.361.0440 | P
816.361.0045 | F

LARKIN/
LAMP RYNEARSON

SUMMIT VIEW FARMS 3RD PLAT
LEES SUMMIT, MISSOURI

WATER LINE PLANS

WATER LINE PLAN AND PROFILE

WATER LINE 3-02A AND 3-02B

LARKIN LAMP RYNEARSON - ENGINEERS

MO Certificate of Authority No. 2013011903

FOR REVIEW

NOT RELEASED FOR CONSTRUCTION

MARK DANIEL MCGHEE JR.
PE - 2008019568

SHEET

4 OF 6