

L:\Engineering\031850 SVFDG Summit View Farms 3rd Plat\DRAWINGS\CONSTRUCTION DRAWINGS\GRD-ERC-PLANS\031850-MG-PLN.dwg, 7/20/2018 7:50:45 AM, JAMIE MCMURRY, LAMP RYNEARSON & ASSOCIATES

GENERAL NOTES:


1. SLOPES SHALL BE GRADED AS SHOWN ON THE PLANS WITH A MAXIMUM SLOPE OF 3:1 UNLESS NOTED OTHERWISE.
2. CONTOURS SHOWN ARE AT 1-FOOT INTERVALS.
3. DISTURBED AREAS SHALL HAVE SURFACES ROUGHENED PER KCAPWA SPECIFICATIONS.
4. ALL PROPOSED GRADES SHOWN ARE TO FINISH GRADE. THE CONTRACTOR IS RESPONSIBLE FOR ADJUSTMENTS TO ACCOUNT FOR PAVEMENT SECTION, SUBBASE, AND TOPSOIL REMOVAL AND REPLACEMENT.
5. EMBANKMENTS SHALL BE CONSTRUCTED TO 90% OF MAXIMUM DRY DENSITY OUTSIDE RIGHT-OF-WAY AND TO 95% WITHIN RIGHT-OF-WAY IN 8-INCH MAXIMUM LIFTS IN ACCORDANCE WITH APWA SECTION 2102.6 REQUIREMENTS.

LEGEND

- PROPOSED MAJOR CONTOUR
- PROPOSED MINOR CONTOUR
- EXISTING MAJOR CONTOUR
- EXISTING MINOR CONTOUR

NOTE:

REFER TO SEPARATE PAVING, STORM AND SANITARY PLANS AND WATER LINE PLANS FOR IMPROVEMENTS. THIS PLAN SET ONLY DETAILS MASS GRADING AND EROSION CONTROL.

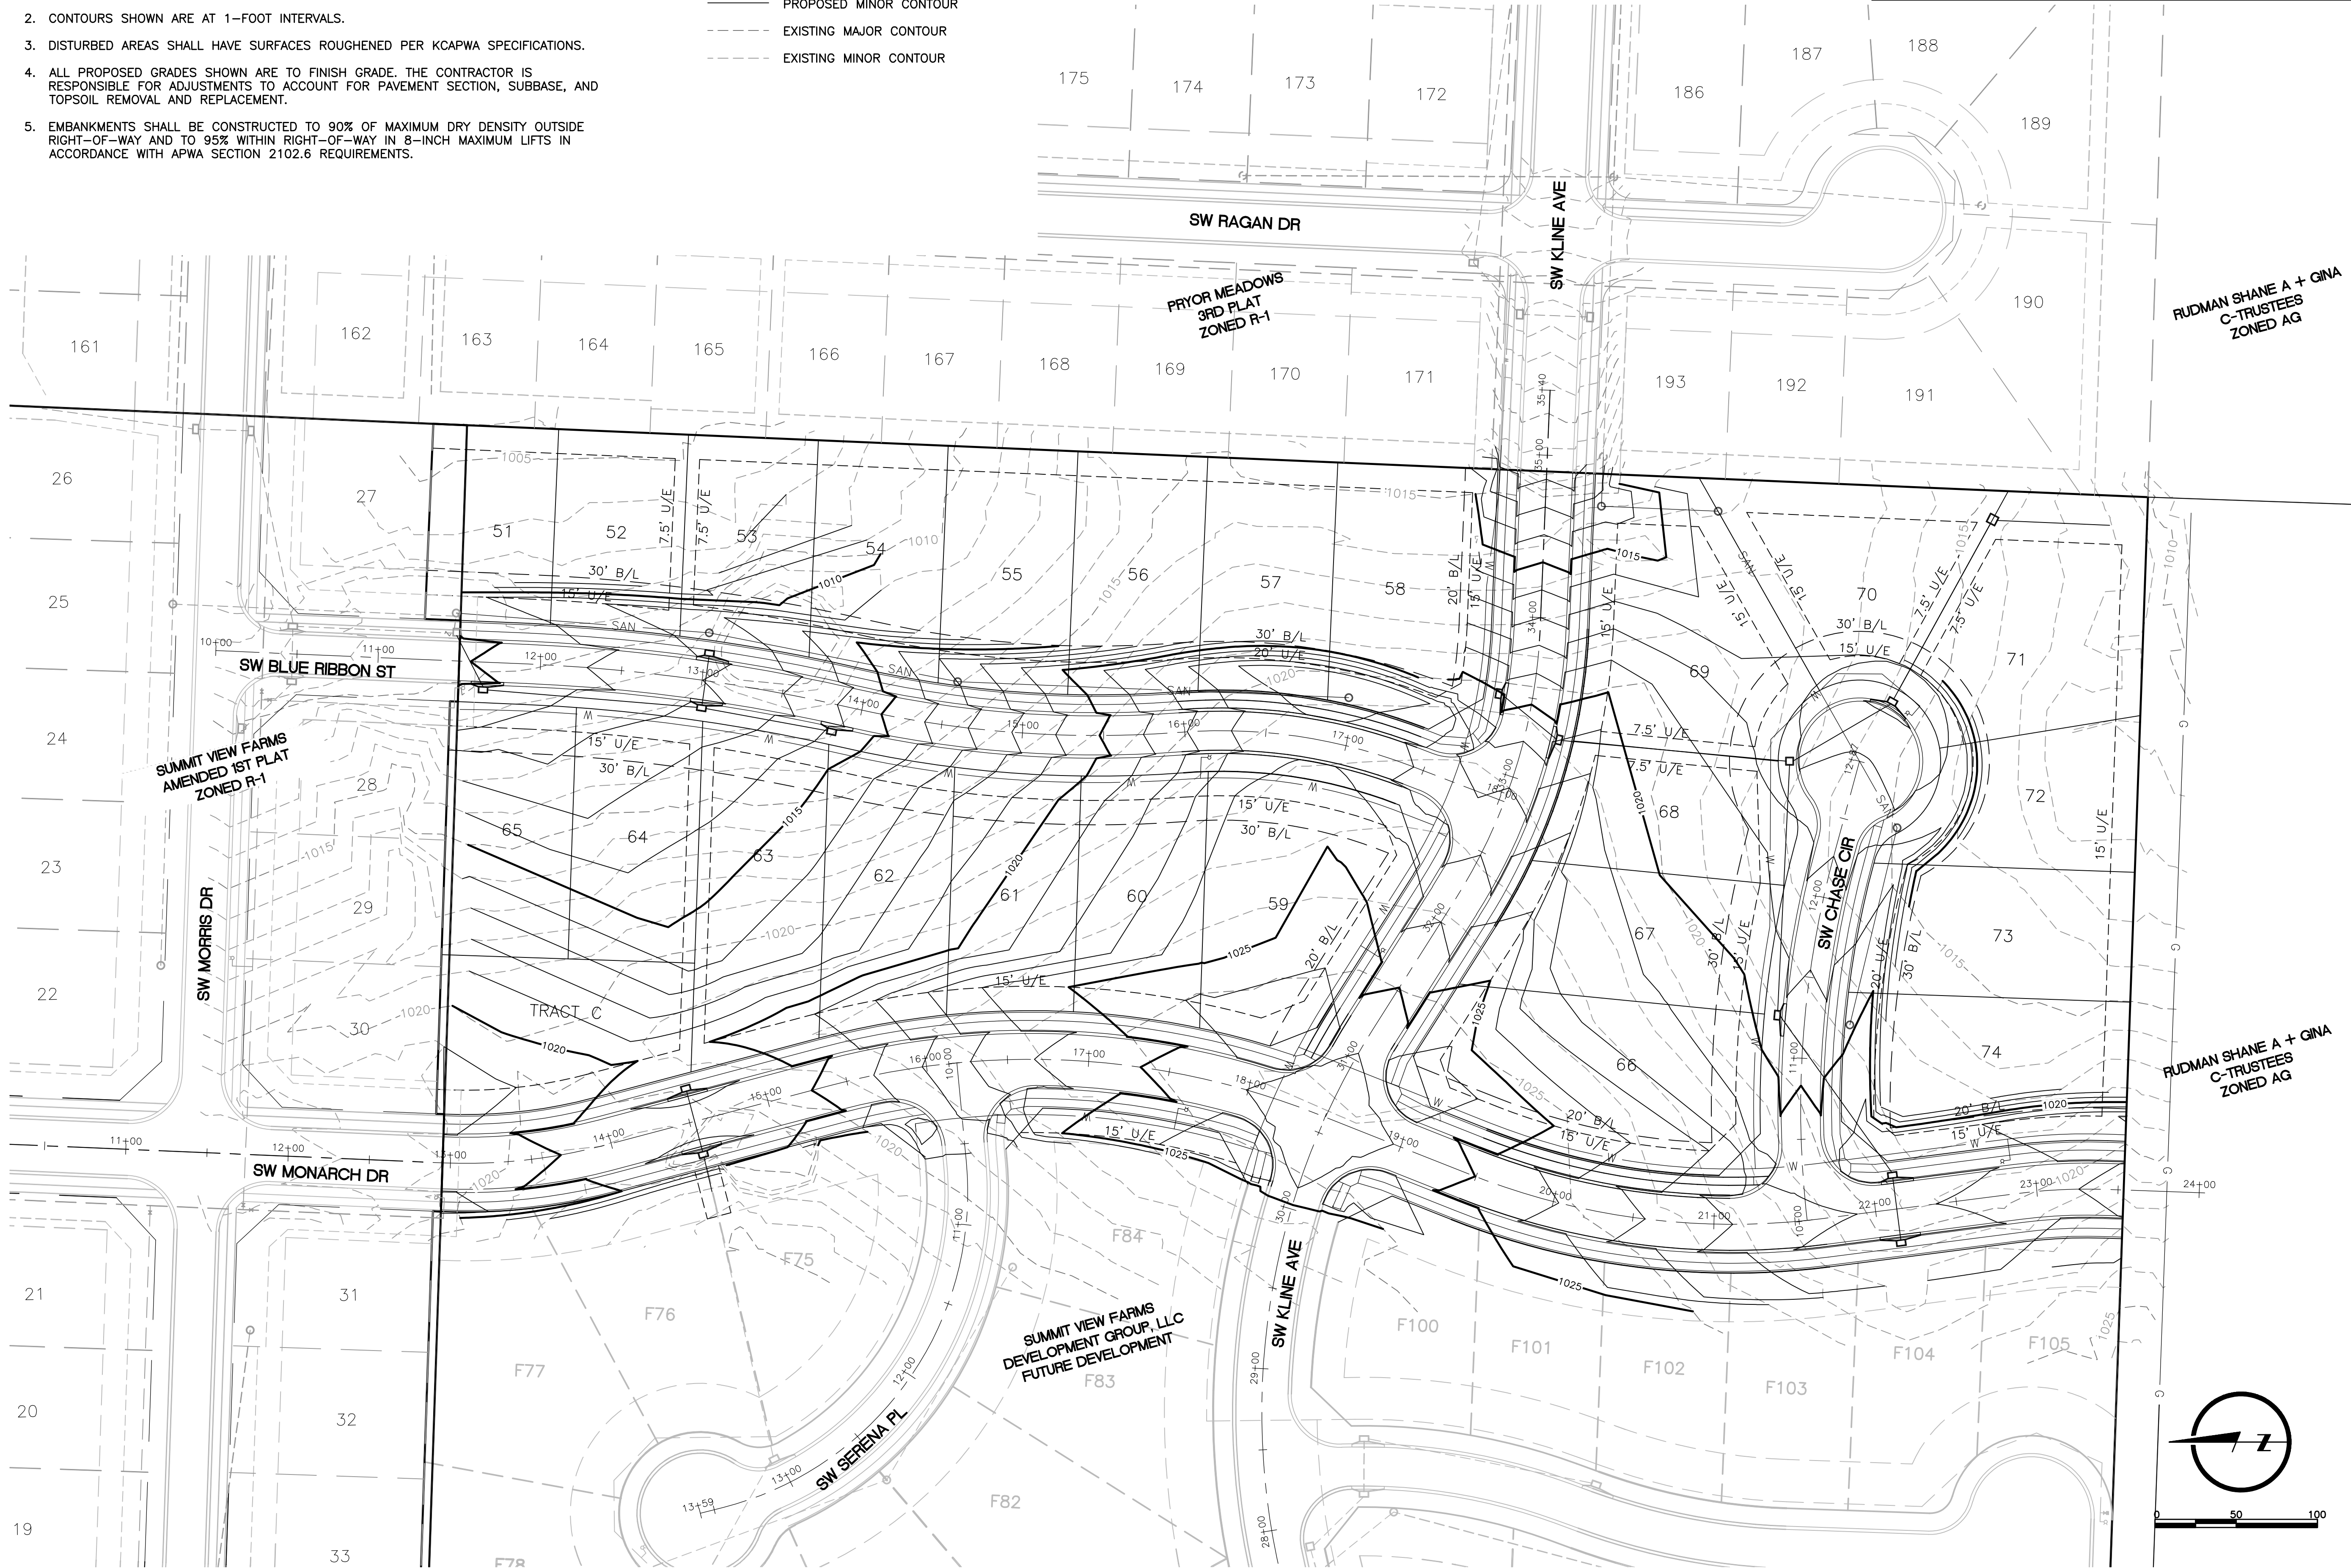

DRAWN BY	JAM	DESIGNED BY	NJM	DATE	JULY 20, 2018	JOB NUMBER-TASKS	031850.01	BOOK AND PAGE	
REVISIONS									
LARKIN/LAMP RYNEARSON									
9001 State Line Rd., Suite 200 Kansas City, Missouri 64114 www.LRA-inc.com									
SUMMIT VIEW FARMS 3RD PLAT LEE'S SUMMIT, MISSOURI									
MASS GRADING AND EROSION CONTROL PLANS									
MASS GRADING PLAN									
LARKIN LAMP RYNEARSON - ENGINEERS MO Certificate of Authority No. 2013011963									
FOR REVIEW									
NOT RELEASED FOR CONSTRUCTION									
MARK DANIEL MCGHEE JR. PE - 2008019568									
SHEET									
03 OF 11									