


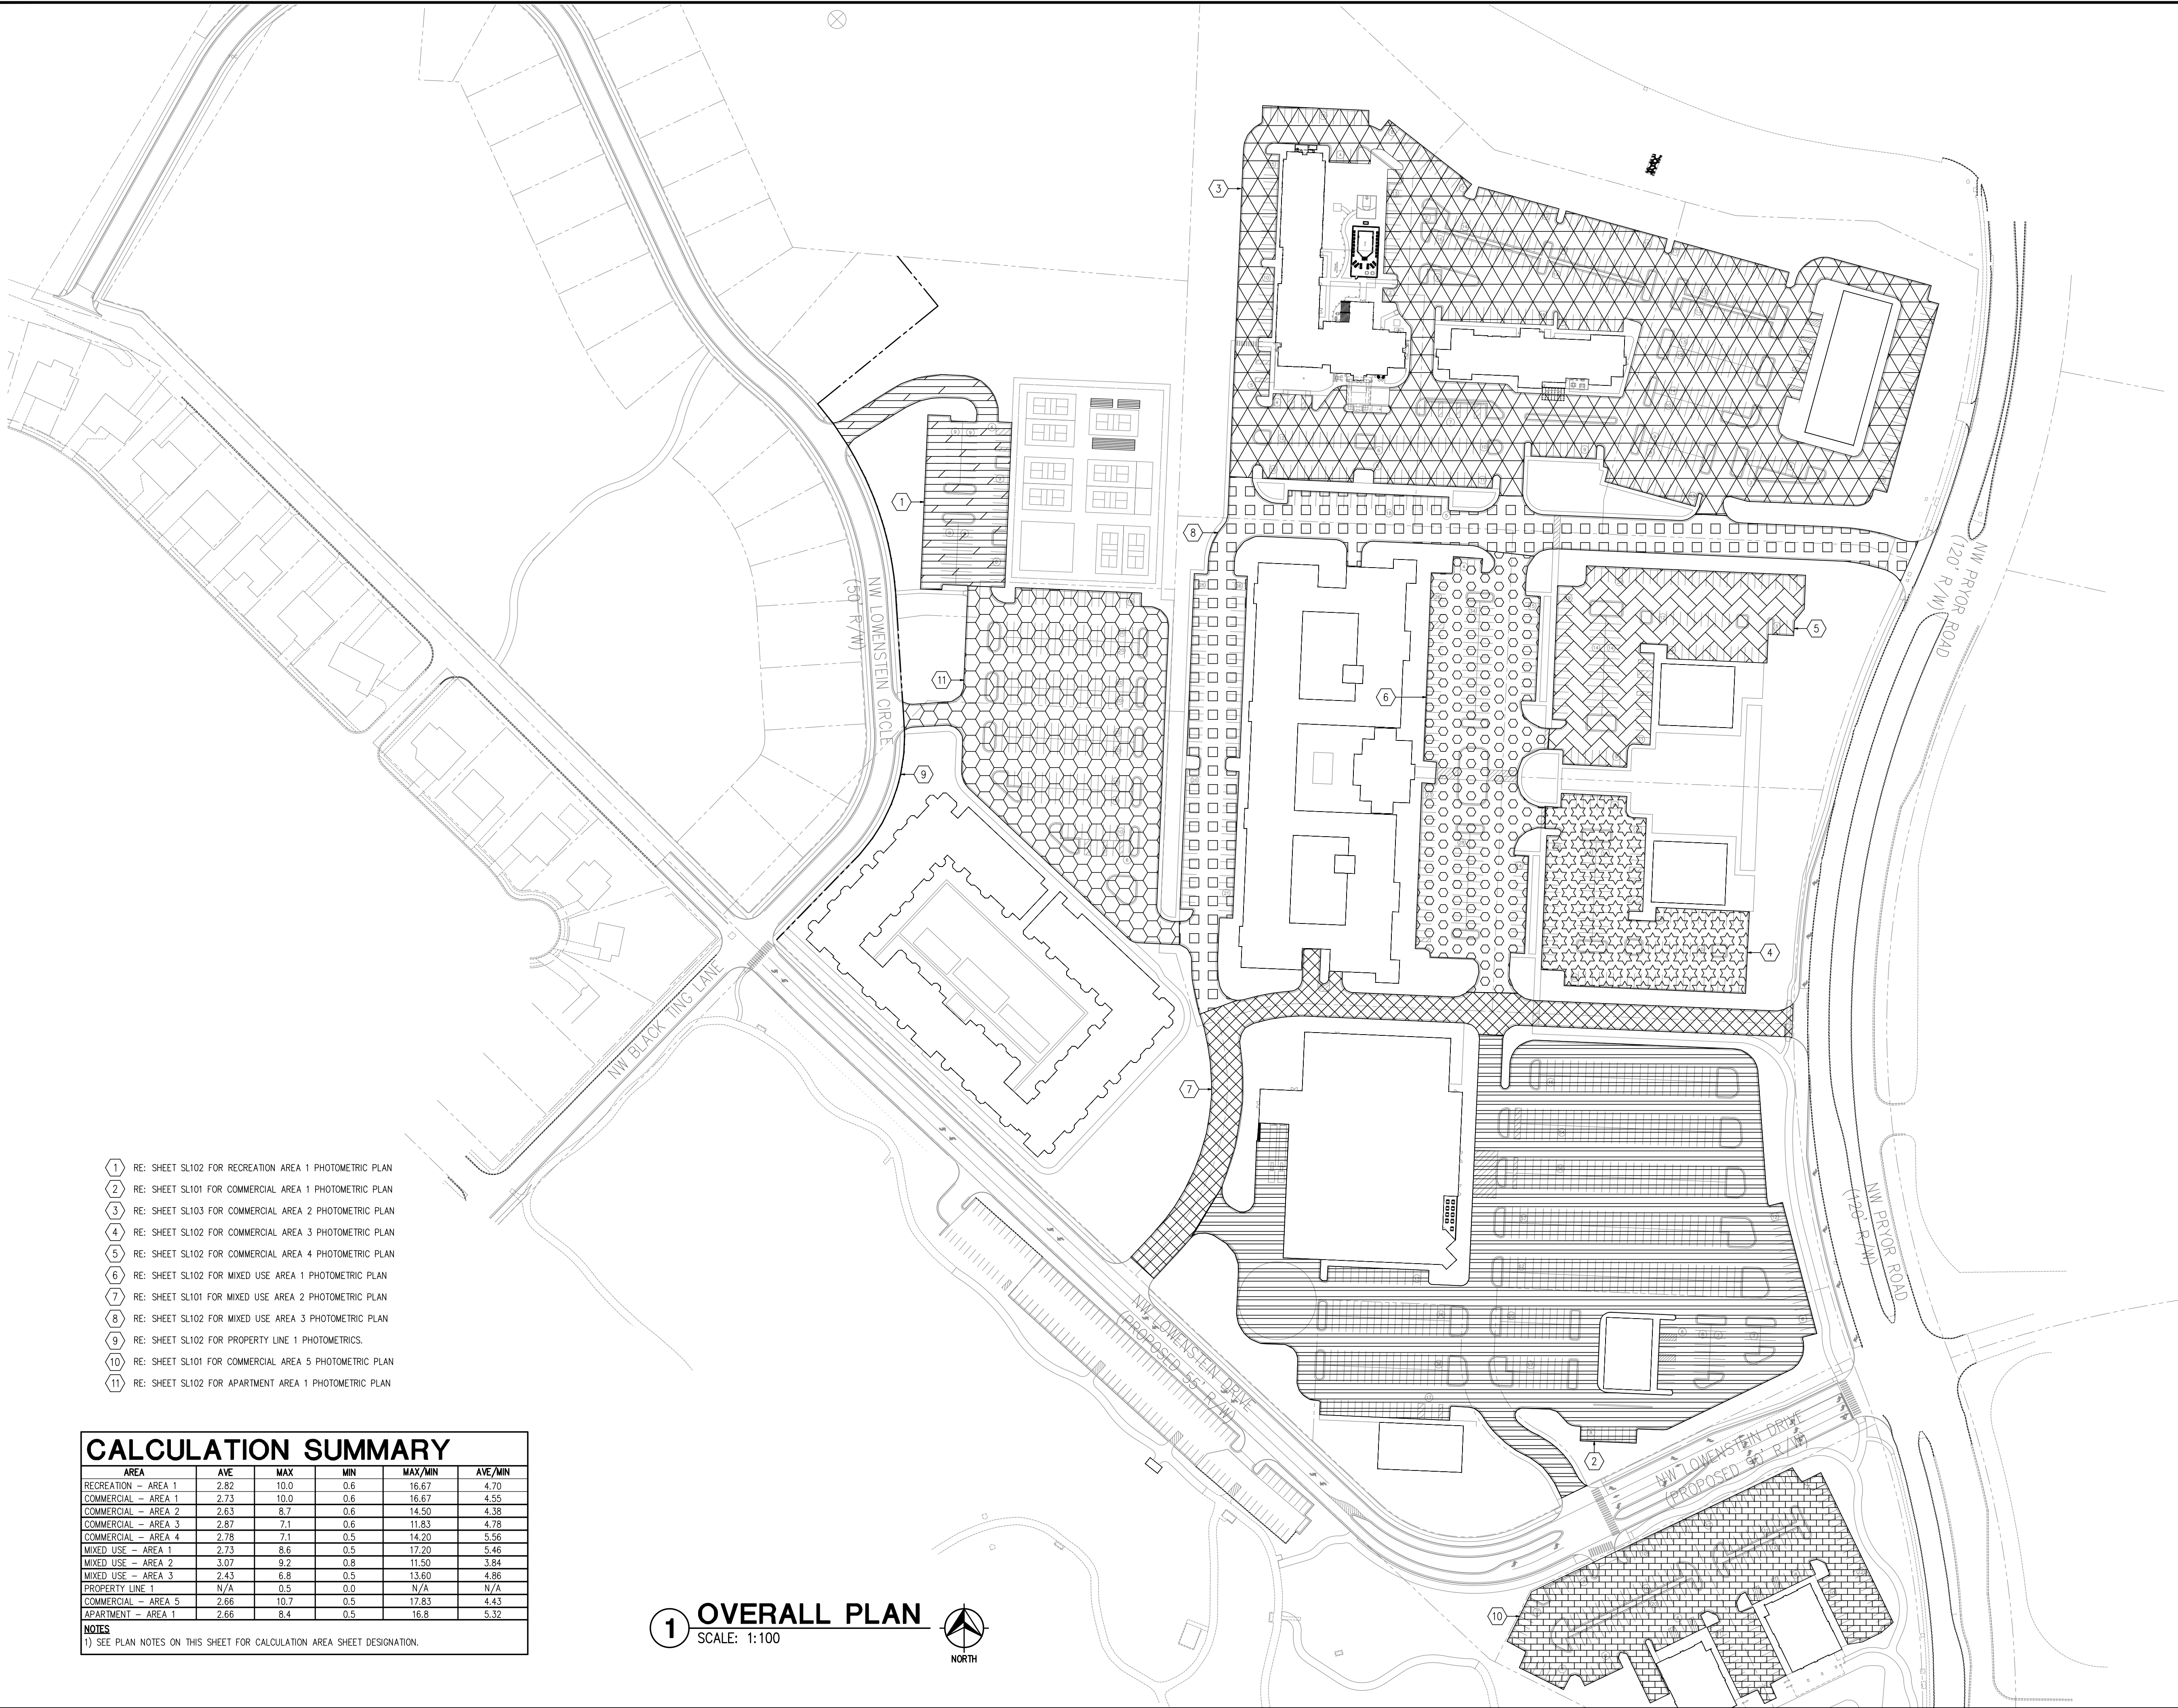

- 1) RE: SHEET SL102 FOR RECREATION AREA 1 PHOTOMETRIC PLAN
2) RE: SHEET SL101 FOR COMMERCIAL AREA 1 PHOTOMETRIC PLAN
3) RE: SHEET SL103 FOR COMMERCIAL AREA 2 PHOTOMETRIC PLAN
4) RE: SHEET SL102 FOR COMMERCIAL AREA 3 PHOTOMETRIC PLAN
5) RE: SHEET SL102 FOR COMMERCIAL AREA 4 PHOTOMETRIC PLAN
6) RE: SHEET SL102 FOR MIXED USE AREA 1 PHOTOMETRIC PLAN
7) RE: SHEET SL101 FOR MIXED USE AREA 2 PHOTOMETRIC PLAN
8) RE: SHEET SL102 FOR MIXED USE AREA 3 PHOTOMETRIC PLAN
9) RE: SHEET SL102 FOR PROPERTY LINE 1 PHOTOMETRICS.
10) RE: SHEET SL101 FOR COMMERCIAL AREA 5 PHOTOMETRIC PLAN
11) RE: SHEET SL102 FOR APARTMENT AREA 1 PHOTOMETRIC PLAN

CALCULATION SUMMARY

AREA	AVE	MAX	MIN	MAX/MIN	AVE/MIN
RECREATION - AREA 1	2.82	10.0	0.6	16.67	4.70
COMMERCIAL - AREA 1	2.73	10.0	0.6	16.67	4.55
COMMERCIAL - AREA 2	2.63	8.7	0.6	14.50	4.38
COMMERCIAL - AREA 3	2.87	7.1	0.6	11.83	4.78
COMMERCIAL - AREA 4	2.78	7.1	0.5	14.20	5.56
MIXED USE - AREA 1	2.73	8.6	0.5	17.20	5.46
MIXED USE - AREA 2	3.07	9.2	0.8	11.50	3.84
MIXED USE - AREA 3	2.43	6.8	0.5	13.60	4.86
PROPERTY LINE 1	N/A	0.5	0.0	N/A	N/A
COMMERCIAL - AREA 5	2.66	10.7	0.5	17.83	4.43
APARTMENT - AREA 1	2.66	8.4	0.5	16.8	5.32

NOTES
1) SEE PLAN NOTES ON THIS SHEET FOR CALCULATION AREA SHEET DESIGNATION.

1) OVERALL PLAN
SCALE: 1:100



InSite Group
2400 NE 10th Street, Suite 200, Fort Lauderdale, FL 33304
(954) 228-1877 | www.insitegroup.net

THIS DRAWING is provided as an instrument of service by the Engineer, and is intended for use on the Project ONLY. This drawing represents the property of the Engineer, and shall be returned to him upon completion and or expiration of the term of the contract. Any reproduction, use or disclosure of the proprietary information contained herein without the prior written consent of the Engineer is strictly prohibited.

ISO PROJECT NUMBER
16-5419-1

STREETS OF WEST PRYOR
NWQ NW PRYOR ROAD & NW LOWENSTEIN DRIVE
LEE'S SUMMIT, MISSOURI
PRELIMINARY DEVELOPMENT PLAN
GRADING PLAN

PROJ. NO.	A14-7067-1
DESIGNER	WRA
DRAWN BY	WRA
CFN	5419-1 - SL100
SHEET	SL100
REV	2

KAW VALLEY ENGINEERING
KAW VALLEY ENGINEERING, INC. IS AUTHORIZED TO OFFER ENGINEERING SERVICES IN THE STATE OF MISSOURI. EXPIRES 12/31/18.

2319 N. JACKSON | P.O. BOX 1304
JUNCTION CITY, KANSAS 66441
PH: (785) 782-5040 | FAX: (785) 782-7744
jc@kveg.com | www.kveg.com

CURTIS L. BRUNGARDT
ENGINEER
MO # 2003016693




REV	DATE	DESCRIPTION
2	9-18-18	REVISED PER CITY COMMENT
0	8-20-18	INITIAL ISSUE

WRA	WRA	CLB
WRA	WRA	CLB
DSN	DWN	CHK




STREETS OF WEST PRYOR NWQ NW PRYOR ROAD & NW LOWENSTEIN DRIVE LEE'S SUMMIT, MISSOURI		2319 N. JACKSON P.O. BOX 1304 JENNIFER, MISSOURI 64501 PH (785) 782-5040 FAX (785) 782-7744 j2@kvweng.com www.kvweng.com									
		 KAW VALLEY ENGINEERING KAW VALLEY ENGINEERING, INC., IS AUTHORIZED TO OFFER ENGINEERING SERVICES BY MISSOURI STATE CERTIFICATE OF AUTHORITY # 000842. EXPIRES 12/31/18		CURTIS L. BRUNGARDT ENGINEER MO # 2003016693							
PRELIMINARY DEVELOPMENT PLAN GRADING PLAN		PROJ. NO. A14-7067-1 DESIGNER WRA DRAWN BY WRA CFN _____ SHEET SL101 - SL100		REV _____		REV _____		REV _____		REV _____	
				REV _____		REV _____		REV _____		REV _____	

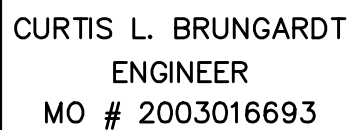

PROJ. NO.		A14_7067-1	
DESIGNER WRA		DRAWN BY WRA	
CFN			
5419-1 - SL100			
SHEET		REV	
SL102		2	

PROJ. NO.		A14_7067-1	
DESIGNER WRA		DRAWN BY WRA	
CFN			
5419-1 - SL100			
SHEET		REV	
SL102		2	

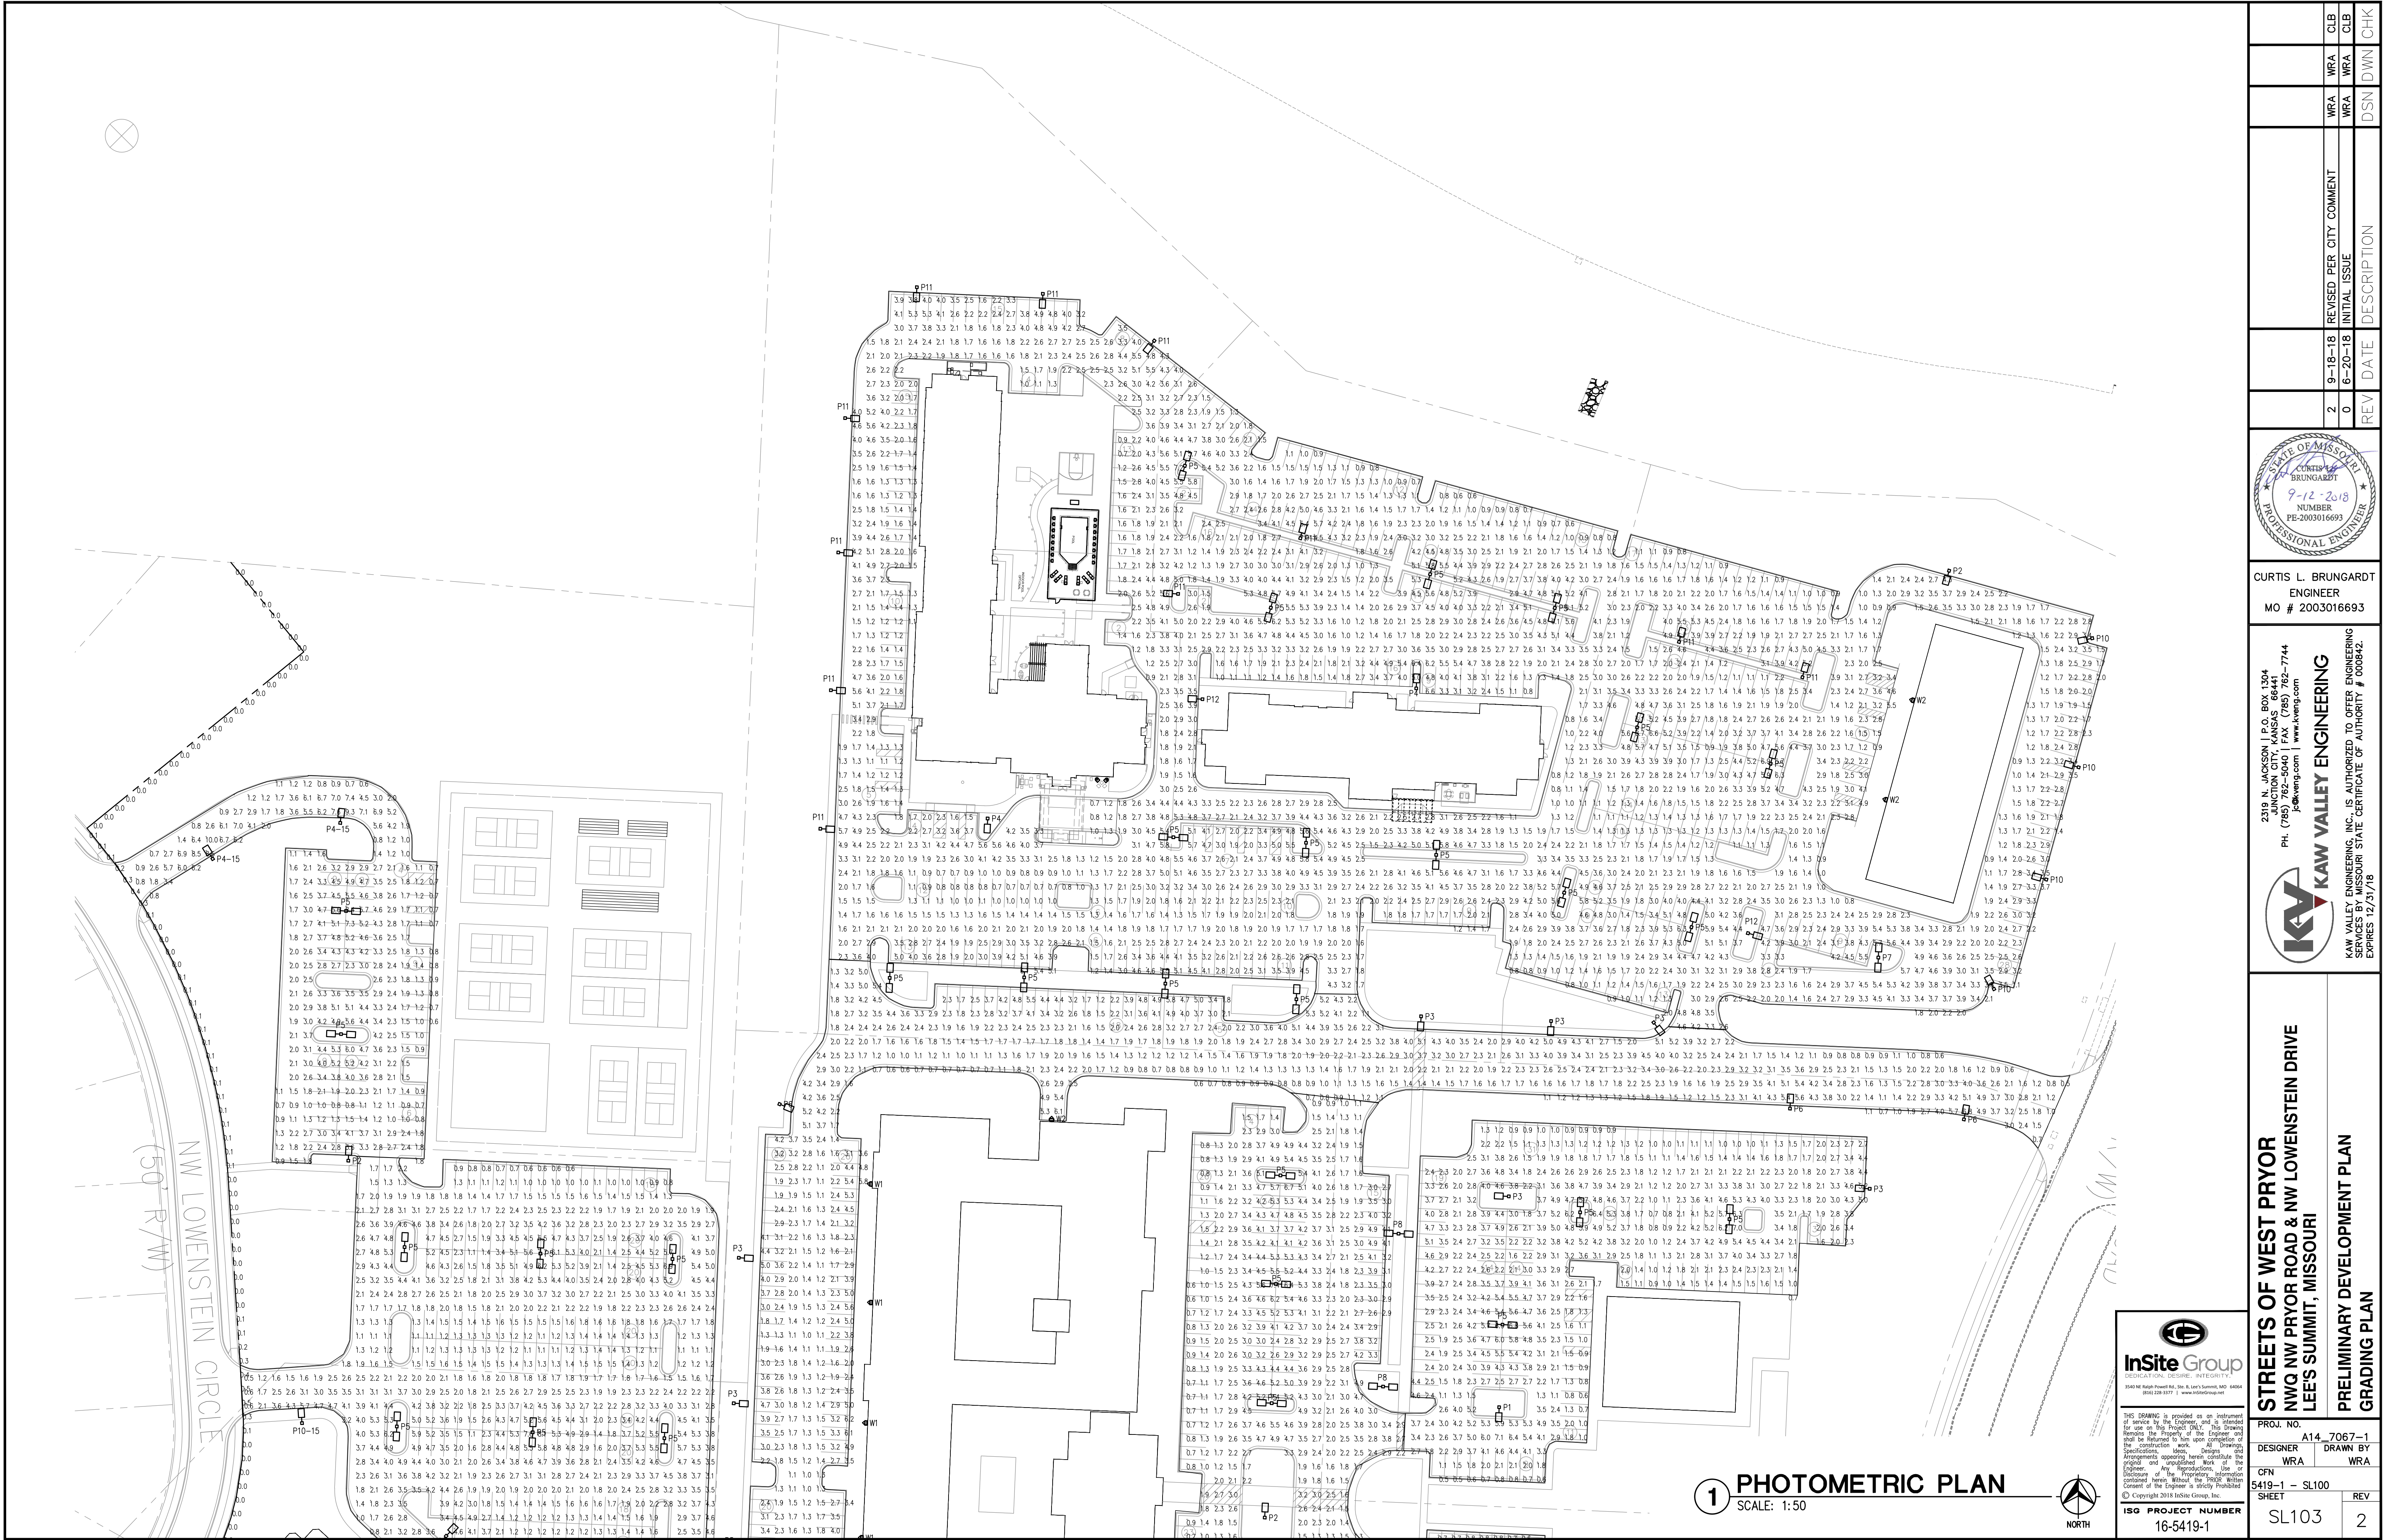

THIS DRAWING SHALL NOT BE UTILIZED BY ANY PERSON, FIRM, OR CORPORATION IN WHOLE OR IN PART WITHOUT THE SPECIFIC PERMISSION OF KAW VALLEY ENGINEERING, INC.

InSite Group
DEDICATION, DESIRE, INTEGRITY
2400 W. 12th Street, Suite 100, Lee's Summit, MO 64063
(816) 228-1877 | www.insitegroup.net

THIS DRAWING is provided on an instrument of service by the Engineer, and is intended for use on the Project ONLY. This drawing depicts the Project, and the Engineer, and is not to be used for any other purpose. All drawings are the property of the Engineer, and are to be returned to him upon completion of the Project. No part of this drawing may be reproduced or transmitted in any form or by any means electronic, mechanical, photocopying, recording, or by any information storage and retrieval system, without the prior written permission of the Engineer. All drawings are the property of the Engineer, and are to be returned to him upon completion of the Project. No part of this drawing may be reproduced or transmitted in any form or by any means electronic, mechanical, photocopying, recording, or by any information storage and retrieval system, without the prior written permission of the Engineer.

ISO PROJECT NUMBER
16-5419-1

PHOTOMETRIC PLAN

SCALE: 1:50



STREETS OF WEST PRYOR NWQ NW PRYOR ROAD & NW LOWENSTEIN DRIVE LEE'S SUMMIT, MISSOURI		PRELIMINARY DEVELOPMENT PLAN GRADING PLAN	
PROJ. NO.	A14-7067-1	DESIGNER	WRA
CFN	5419-1 - SL100	DRAWN BY	WRA
SHEET	SL103	REV	2
KAW VALLEY ENGINEERING, INC. IS AUTHORIZED TO OFFER ENGINEERING SERVICES IN MISSOURI STATE CERTIFICATE OF AUTHORITY # 000842. EXPIRES 12/31/18		KAW VALLEY ENGINEERING 2319 N. JACKSON P.O. BOX 1304 JUNCTION CITY, KANSAS 66441 PH (785) 762-5040 FAX (785) 762-7744 joe@kvweng.com www.kvweng.com	
CURTIS L. BRUNGARDT ENGINEER MO # 2003016693		STATE OF MISSOURI CURTIS L. BRUNGARDT 9-12-2018 NUMBER PE-2003016693 PROFESSIONAL ENGINEER	
REV	DATE	DESCRIPTION	CHK
2	9-18-18	REVISED PER CITY COMMENT	WRA
0	8-20-18	INITIAL ISSUE	WRA
			DSN
			DWN
			CHK


LIGHTING FIXTURE SCHEDULE

MARK	MANUFACTURER *	FIXTURE DESCRIPTION	MODEL NUMBER	MOUNTING	COLOR	LAMP			DRIVE CURRENT (QUANTITY/TYPE)	VOLTS	WATTS PER/POLE	NOTES
						QTY	TYPE	CODE				
P1	McGRAW-EDISON	DARK SKY COMPLIANT AREA LIGHT FIXTURE WITH DIRECT ARM MOUNT AT 90 DEGREES AND 20FT ALUMINUM POLE WITH VIBRATION DAMPER	FIXTURE: GLEON-AF-04-LED-E1-T3	POLE	4000K	1 PER POLE	LED	-	(1) 1000mA	MVOLT	225	1-3
P2	McGRAW-EDISON	DARK SKY COMPLIANT AREA LIGHT FIXTURE WITH DIRECT ARM MOUNT AT 90 DEGREES AND 20FT ALUMINUM POLE WITH VIBRATION DAMPER	FIXTURE: GLEON-AF-02-LED-E1-SL2	POLE	4000K	1 PER POLE	LED	-	(1) 1000mA	MVOLT	113	1-3
P3	McGRAW-EDISON	DARK SKY COMPLIANT AREA LIGHT FIXTURE WITH DIRECT ARM MOUNT AT 90 DEGREES AND 20FT ALUMINUM POLE WITH VIBRATION DAMPER	FIXTURE: GLEON-AF-03-LED-E1-SL4-BZ	POLE	4000K	1 PER POLE	LED	-	(1) 1000mA	MVOLT	166	1-3
P4	McGRAW-EDISON	DARK SKY COMPLIANT AREA LIGHT FIXTURE WITH DIRECT ARM MOUNT AT 90 DEGREES AND 20FT ALUMINUM POLE WITH VIBRATION DAMPER	FIXTURE: GLEON-AF-03-LED-E1-SL2	POLE	4000K	1 PER POLE	LED	-	(1) 1000mA	MVOLT	166	1-3
P4-15	McGRAW-EDISON	DARK SKY COMPLIANT AREA LIGHT FIXTURE WITH DIRECT ARM MOUNT AT 90 DEGREES AND 15FT ALUMINUM POLE WITH VIBRATION DAMPER	FIXTURE: GLEON-AF-03-LED-E1-SL2	POLE	4000K	1 PER POLE	LED	-	(1) 1000mA	MVOLT	166	1-3
P5	McGRAW-EDISON	DARK SKY COMPLIANT AREA LIGHT FIXTURE WITH DIRECT ARM MOUNT AT 90 DEGREES, 2 FIXTURES ORIENTED AT 180 DEGREES AND 20FT ALUMINUM POLE WITH VIBRATION DAMPER	FIXTURE: 2-GLEON-AF-03-LED-E1-SL4	POLE	4000K	2 PER POLE (AT 180deg)	LED	-	(1) 1000mA (PER FIXTURE)	MVOLT	332	1-3
P6	McGRAW-EDISON	DARK SKY COMPLIANT AREA LIGHT FIXTURE WITH DIRECT ARM MOUNT AT 90 DEGREES AND 20FT ALUMINUM POLE WITH VIBRATION DAMPER	FIXTURE: GLEON-AF-03-LED-E1-SL3	POLE	4000K	1 PER POLE	LED	-	(1) 1000mA	MVOLT	166	1-3
P7	McGRAW-EDISON	DARK SKY COMPLIANT AREA LIGHT FIXTURE WITH DIRECT ARM MOUNT AT 90 DEGREES, 2 FIXTURES ORIENTED AT 180 DEGREES AND 20FT ALUMINUM POLE WITH VIBRATION DAMPER	FIXTURE: 2-GLEON-AF-03-LED-E1-SL3	POLE	4000K	2 PER POLE (AT 180deg)	LED	-	(1) 1000mA (PER FIXTURE)	MVOLT	332	1-3
P8	McGRAW-EDISON	DARK SKY COMPLIANT AREA LIGHT FIXTURE WITH DIRECT ARM MOUNT AT 90 DEGREES, 2 FIXTURES ORIENTED AT 180 DEGREES AND 20FT ALUMINUM POLE WITH VIBRATION DAMPER	FIXTURE: 2-GLEON-AF-02-LED-E1-SL2-BZ	POLE	4000K	1 PER POLE	LED	-	(1) 1000mA (PER FIXTURE)	MVOLT	226	1-3
P9	McGRAW-EDISON	DARK SKY COMPLIANT AREA LIGHT FIXTURE WITH DIRECT ARM MOUNT AT 90 DEGREES, 2 FIXTURES ORIENTED AT 180 DEGREES AND 20FT ALUMINUM POLE WITH VIBRATION DAMPER	FIXTURE: 2-GLEON-AF-04-LED-E1-SL4	POLE	4000K	1 PER POLE	LED	-	(1) 1000mA (PER FIXTURE)	MVOLT	450	1-3
P10	McGRAW-EDISON	DARK SKY COMPLIANT AREA LIGHT FIXTURE WITH DIRECT ARM MOUNT AT 90 DEGREES AND 20FT ALUMINUM POLE WITH VIBRATION DAMPER	FIXTURE: GLEON-AF-02-LED-E1-SL4	POLE	4000K	1 PER POLE	LED	-	(1) 1000mA	MVOLT	113	1-3
P10-15	McGRAW-EDISON	DARK SKY COMPLIANT AREA LIGHT FIXTURE WITH DIRECT ARM MOUNT AT 90 DEGREES AND 15FT ALUMINUM POLE WITH VIBRATION DAMPER	FIXTURE: GLEON-AF-02-LED-E1-SL4	POLE	4000K	1 PER POLE	LED	-	(1) 1000mA	MVOLT	113	1-3
P11	McGRAW-EDISON	DARK SKY COMPLIANT AREA LIGHT FIXTURE WITH DIRECT ARM MOUNT AT 90 DEGREES AND 20FT ALUMINUM POLE WITH VIBRATION DAMPER	FIXTURE: GLEON-AF-03-LED-E1-14FT	POLE	4000K	1 PER POLE	LED	-	(1) 1000mA	MVOLT	166	1-3
P12	McGRAW-EDISON	DARK SKY COMPLIANT AREA LIGHT FIXTURE WITH DIRECT ARM MOUNT AT 90 DEGREES AND 20FT ALUMINUM POLE WITH VIBRATION DAMPER	FIXTURE: GLEON-AF-02-LED-E1-SL3	POLE	4000K	1 PER POLE	LED	-	(1) 1000mA	MVOLT	113	1-3
W1	McGRAW-EDISON	DARK SKY COMPLIANT AREA LIGHT FIXTURE, WITH WALL MOUNT AT 90 DEGREES AND 15FT MOUNTING HEIGHT.	FIXTURE: GWC-AF-02-LED-E1-T3	WALL	4000K	1	LED	-	(1) 1000mA	MVOLT	113	1-3
W2	McGRAW-EDISON	DARK SKY COMPLIANT AREA LIGHT FIXTURE, WITH WALL MOUNT AT 90 DEGREES AND 15FT MOUNTING HEIGHT.	FIXTURE: GWC-AF-02-LED-E1-14FT	WALL	4000K	1	LED	-	(1) 1000mA	MVOLT	113	1-3

NOTES

- 1) CONTRACTOR SHALL COORDINATE FINAL FIXTURE/POLE COLORS WITH OWNER.
- 2) CONTRACTOR SHALL PROVIDE SQUARE POLE PER INFORMATION PROVIDED IN SCHEDULE.
- 3) CONTRACTOR SHALL COORDINATE SITE LIGHTING FIXTURE VOLTAGE WITH FINAL DESIGN PACKAGE.

* OR PRIOR APPROVED EQUAL

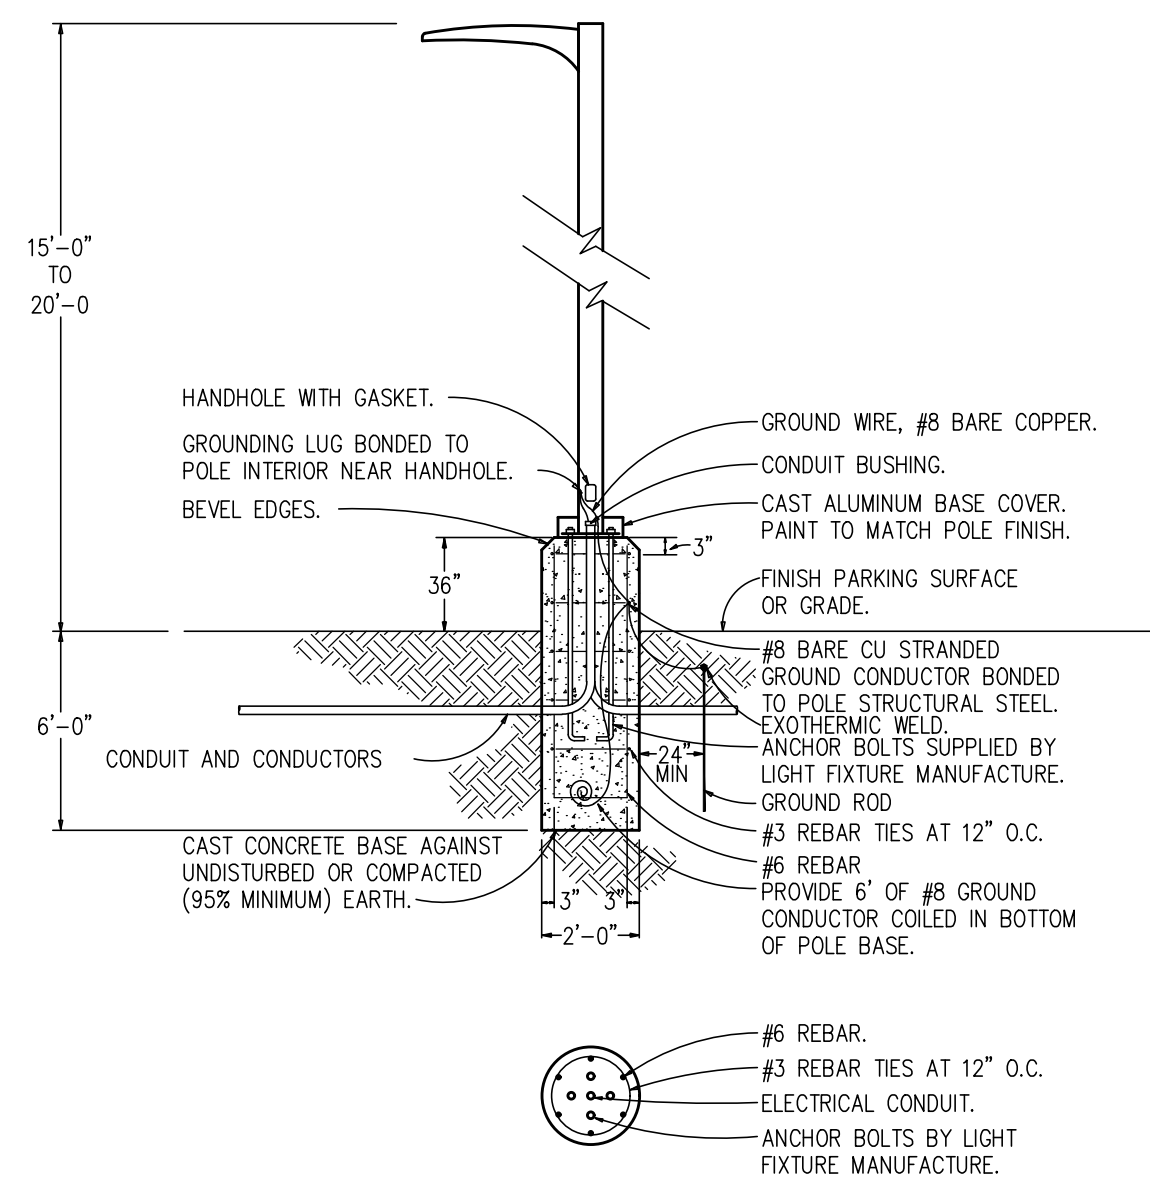

1 LIGHT POLE BASE DETAIL



THIS DRAWING is provided as an instrument of service by the Engineer, and is intended for use on this Project ONLY. This Drawing Remains the Property of the Engineer and shall be Returned to him upon completion of the construction work. All Drawing Specifications, Notes, Details, and Arrangements appearing herein constitute the original and unpublished Work of the Engineer. Any Reproductions, Use, or Disclosure of the Proprietary Information contained herein Without the PRIOR Written Consent of the Engineer is strictly Prohibited.


© Conviqst 2018 InSite Group, Inc.

ISG PROJECT NUMBER
16-5419-1


STREETS OF WEST PRYOR
NWQ NW PRYOR ROAD & NW LOWENSTEIN DRIVE
LEE'S SUMMIT, MISSOURI

PRELIMINARY DEVELOPMENT PLAN GRADING PLAN

PROJ. NO.		A14_7067-1	
DESIGNER		DRAWN BY	
WRA		WRA	
CFN			
5419-1 - SL100			
SHEET		REV	
SL200		2	

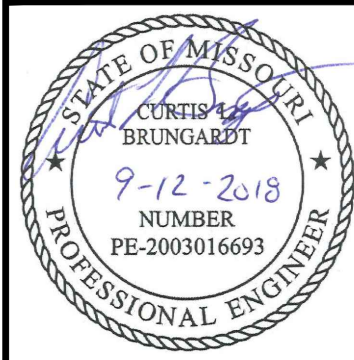

 CURTIS L. BRUNGARDT
ENGINEER
MO # 2003016693

 2319 N. JACKSON | P.O. BOX 1304
FUNCTION CITY, KANSAS 66442-7144
PH. (785) 843-7142-7144
www.kveng.com

KAW VALLEY ENGINEERING

KAW VALLEY ENGINEERING, INC. IS AUTHORIZED TO OFFER ENGINEERING
BY MISSOURI STATE CERTIFICATE OF AUTHORITY # 000842.
EXPIRES 12/31/18

REV	DATE	DESCRIPTION	WRA	WRA	WRA	CLB	CHK
			INITIAL	ISSUE	COMMENT	CLB	
2	9-18-18						
0	6-20-18						

