

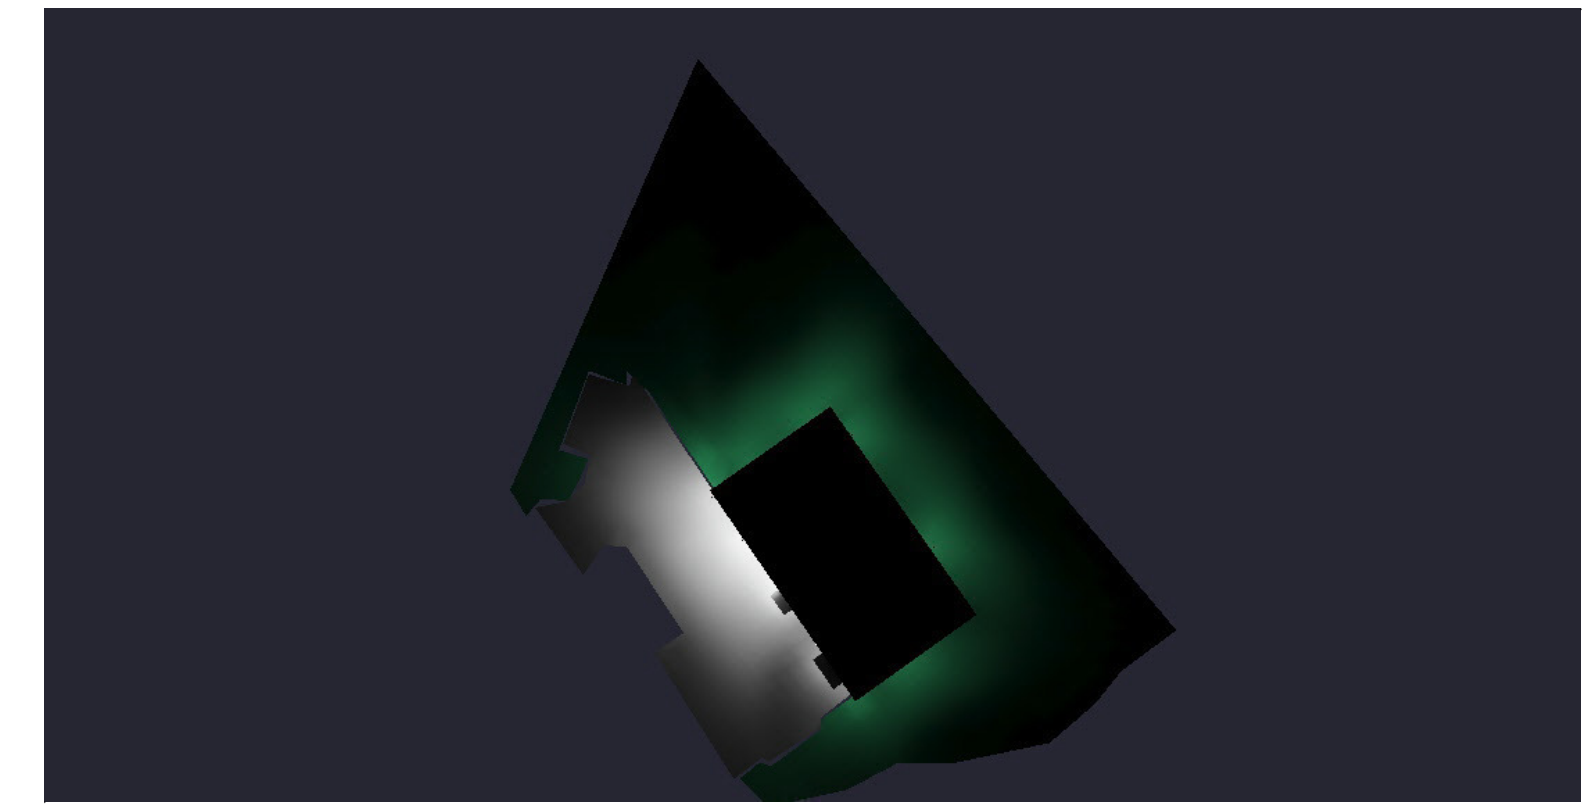


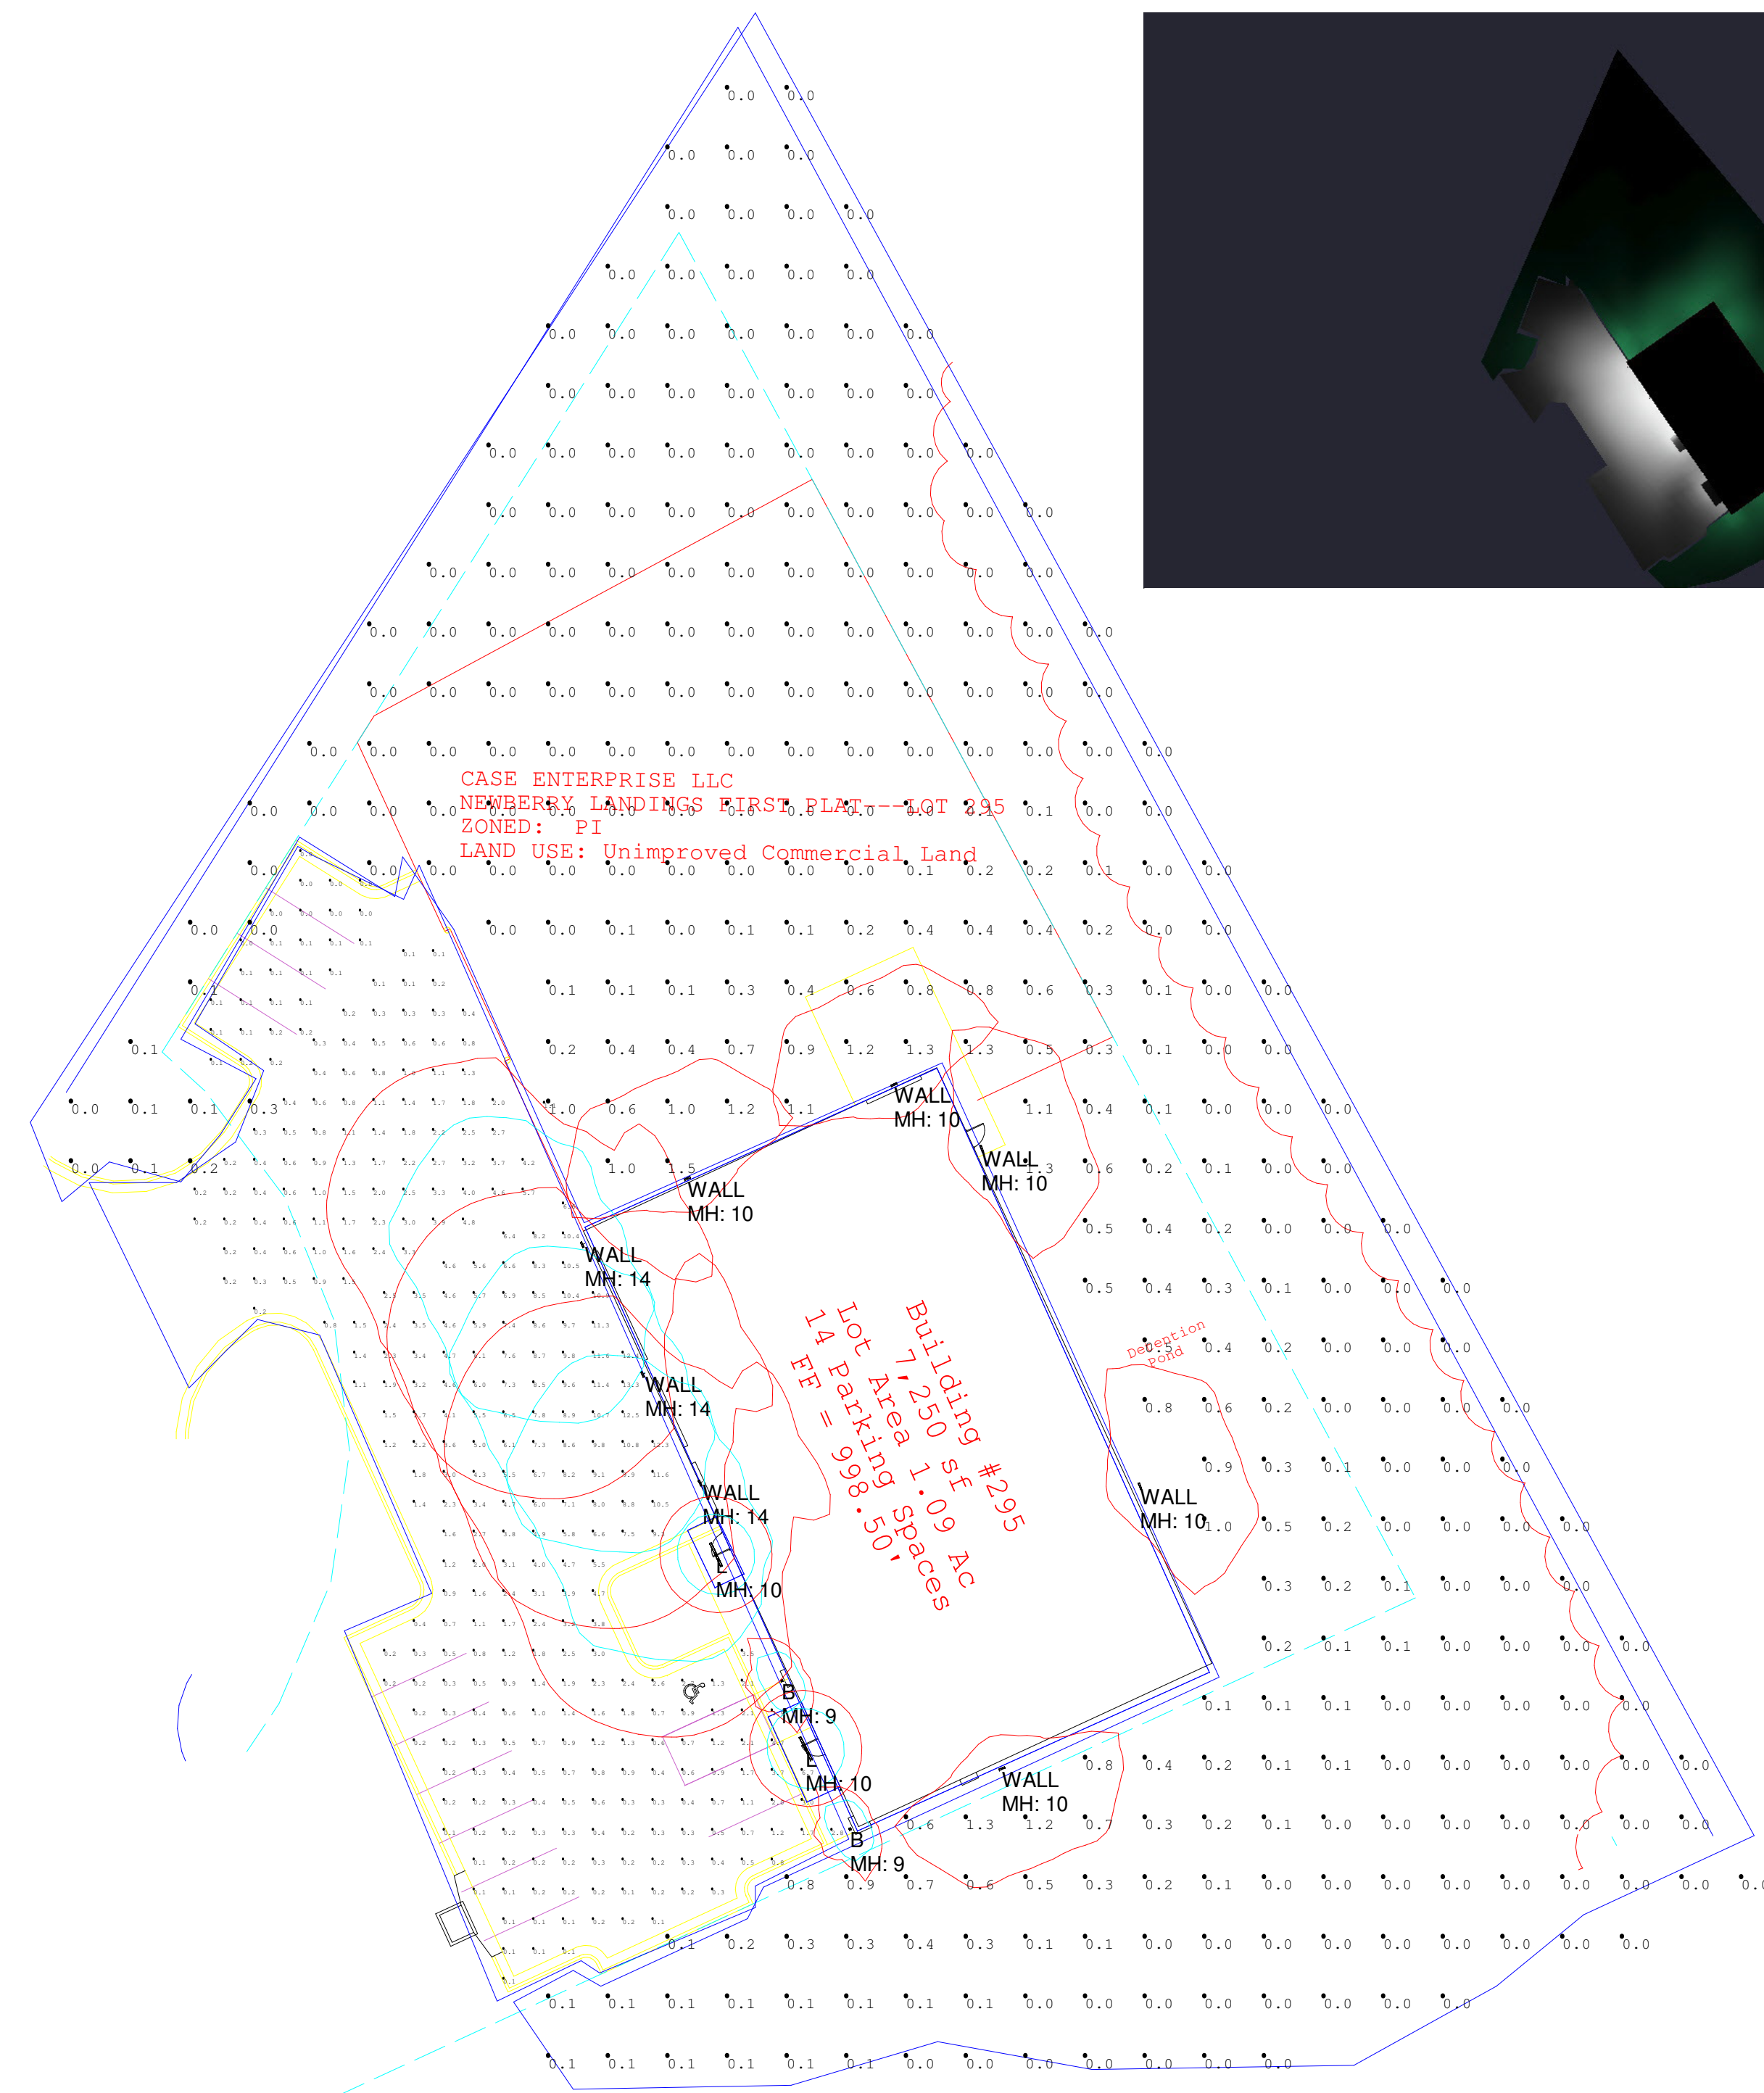

Luminaire Schedule							
Symbol	Qty	Label	Arrangement	Total Lamp Lumens	LLF	Description	Total Watts
	5	DSXW1_LED_10C_350_30K_T3M_MVO	SINGLE	N.A.	0.920	LITHONIA DSXW1 LED 10C 350 30K T3M MVOLT	66.5
	2	CGF_LED_1_30K_120_PE	SINGLE	N.A.	0.920	CGF LOUISEVILLE SCONCE	37.4
	2	EX3B-WET-O-30-30-4-ITL86507	SINGLE	N.A.	0.920	PINNACLE EX3B-WET-O-30-30-4	69.2
	3	DSXW2_LED_30C_1000_30K_T4M_MV	SINGLE	N.A.	0.920	LITHONIA DSXW2 LED 30C 1000 30K T4M MVOLT	327

Numeric Summary							
Label	CalcType	Units	Avg	Max	Min	Avg/Min	Max/Min
AROUND BUILDING	Illuminance	Fc	1.10	1.1	1.1	1.00	1.00
BEYOND PROPERTY LINE	Illuminance	Fc	0.00	0.0	0.0	N.A.	N.A.
DRIVEWAY	Illuminance	Fc	1.32	5.7	0.1	13.20	57.00
entire	Illuminance	Fc	0.14	1.5	0.0	N.A.	N.A.
N PARKING	Illuminance	Fc	0.08	0.2	0.0	N.A.	N.A.
S PARKING	Illuminance	Fc	3.27	13.3	0.1	32.70	133.00

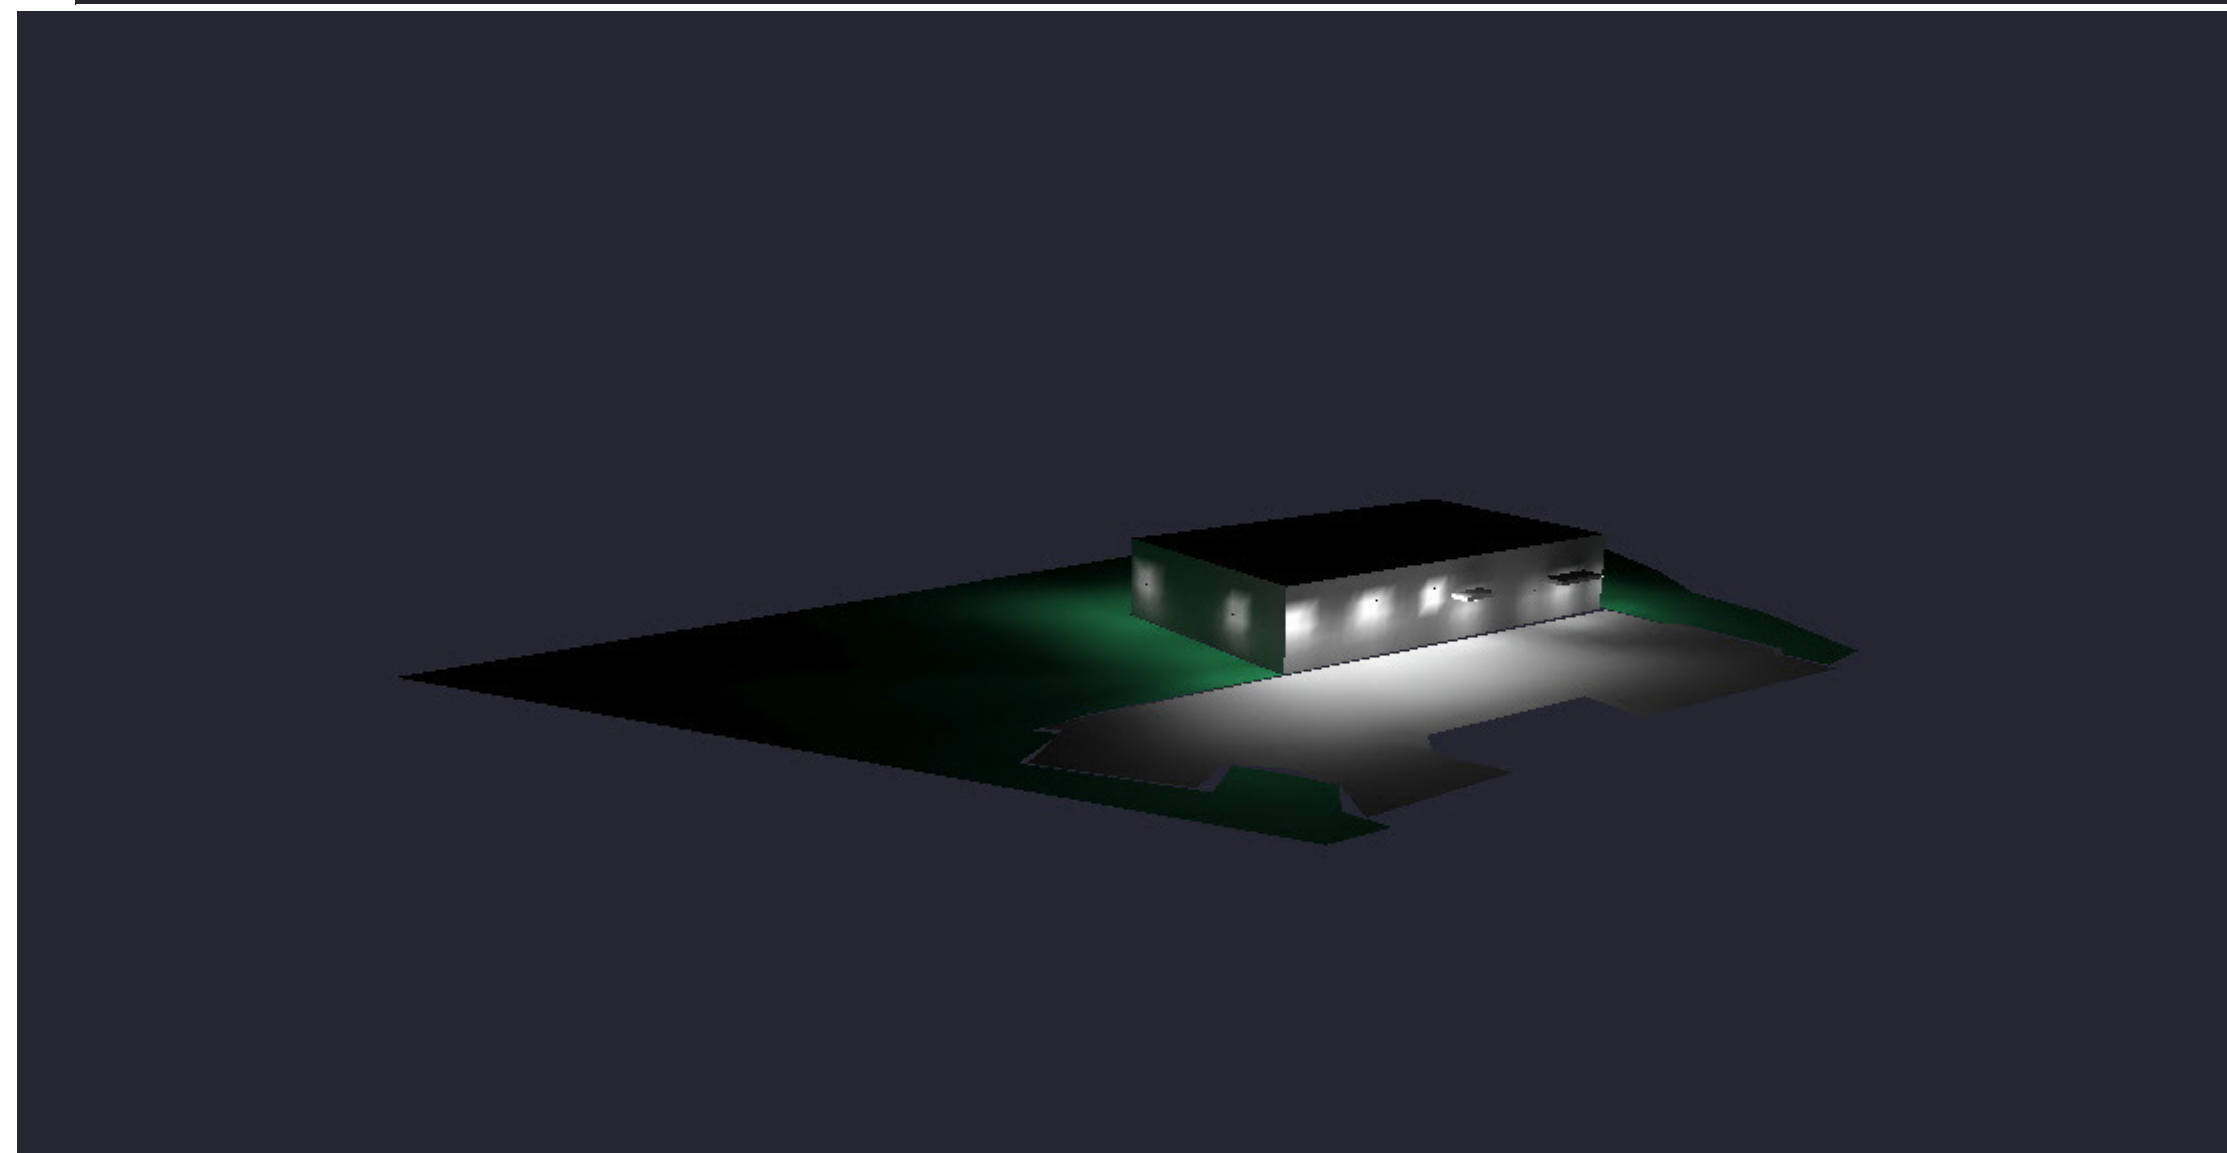

Revisions		
#	Date	Comments

Drawn By: GREGG GARNER

Checked By:

Date: 9/20/2018

Scale:

PREMIER LIGHTING