


SUMMIT VIEW FARMS 3RD PLAT
LOTS 51-74 AND TRACT C

WATER LINE PLANS
LEE'S SUMMIT, JACKSON COUNTY, MISSOURI
SECTION 26, TOWNSHIP 47 N, RANGE 32 W
LRA NO. 0318050.01

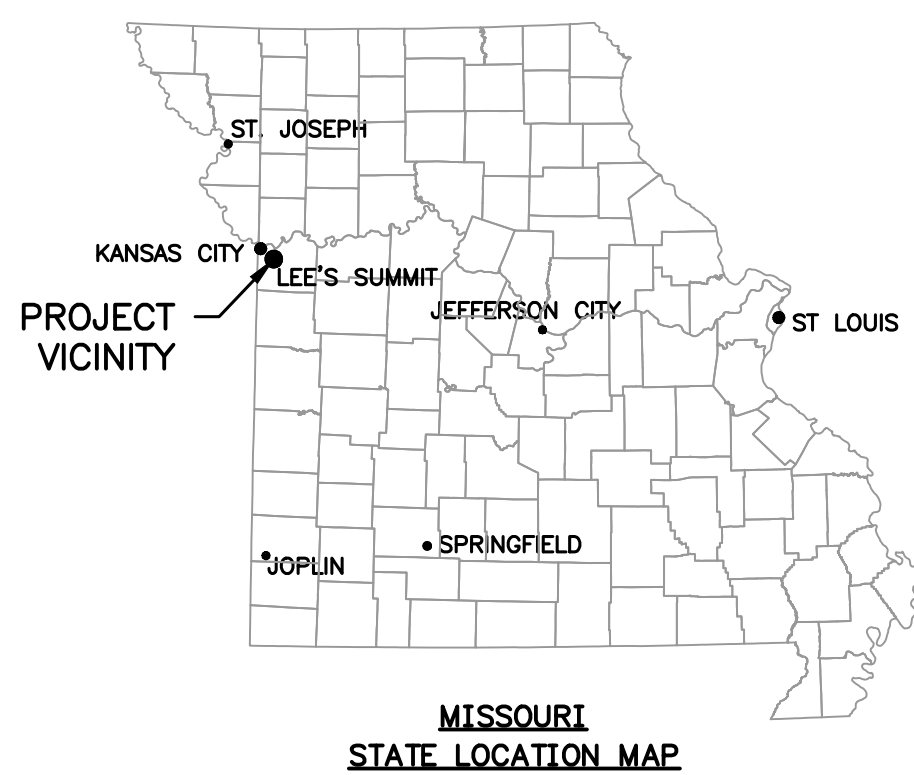


OWNER CONTACT
BILL KENNEY
SUMMIT VIEW FARMS DEVELOPMENT GROUP, LLC
P.O. BOX 291
LEE'S SUMMIT, MO 64063
billkenney9@gmail.com
(816) 838-0552

CONSULTANT CONTACT
DAN MCGHEE
LARKIN LAMP RYNEARSON
9001 STATE LINE ROAD, SUITE 200
KANSAS CITY, MO 64114
Dan.McGhee@LRA-inc.com
(816) 361-0440



ALL UTILITIES ARE SHOWN BASED ON THE INFORMATION AVAILABLE TO THE ENGINEER. THERE IS NO GUARANTEE ALL FACILITIES ARE SHOWN OR THAT THE LOCATION, DEPTH, AND SIZE OF EACH FACILITY IS CORRECT. THE CONTRACTOR IS RESPONSIBLE FOR LOCATING ALL UTILITIES AND SERVICE LINES PRIOR TO CONSTRUCTION. COORDINATE NECESSARY RELOCATIONS WITH UTILITY COMPANIES.

UTILITIES		
ELECTRIC:	KCP&L	(816) 471-5275
GAS:	SPIRE ENERGY	(816) 756-5252
TELEPHONE:	AT&T	(816) 325-5607
CABLE:	SPECTRUM	(816) 358-8833
WATER:	LEE'S SUMMIT WATER UTILITIES	(816) 969-1900
SEWER:	LEE'S SUMMIT WATER UTILITIES	(816) 969-1900

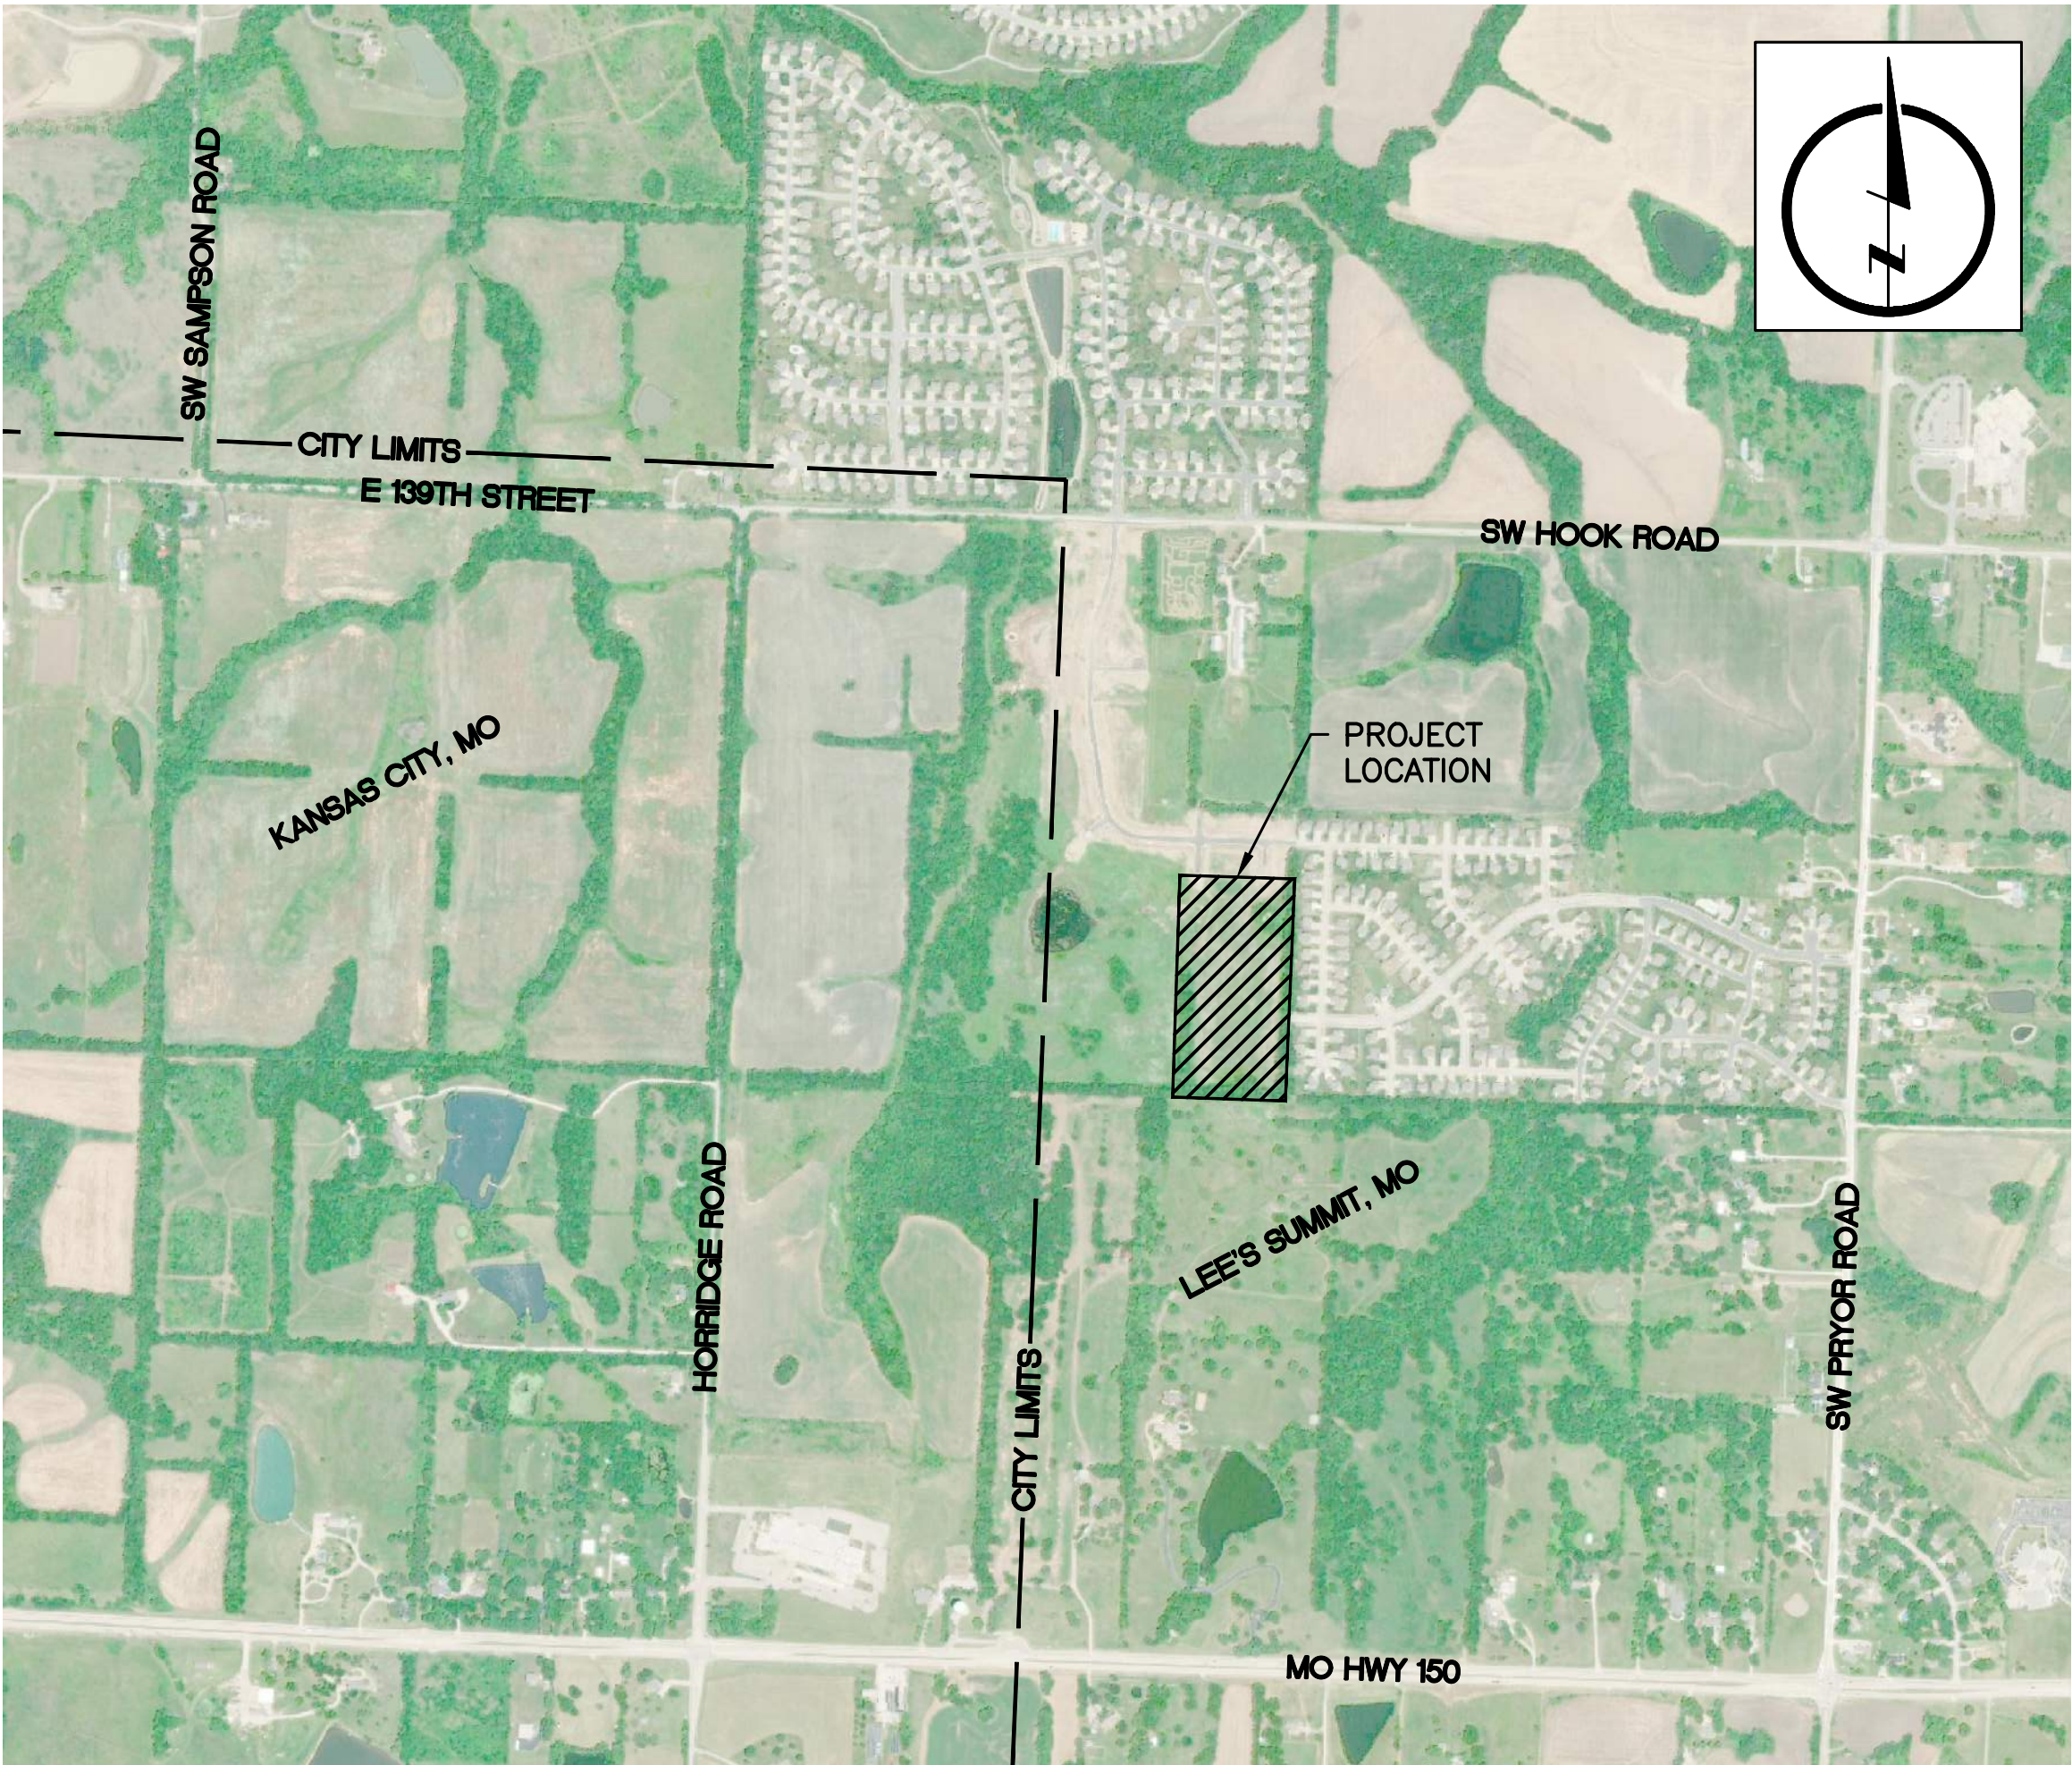

LOCATION MAP

INDEX OF SHEETS

- 01 COVER SHEET
- 02 GENERAL LAYOUT PLAN SHEET
- 03 WATER LINE PLAN AND PROFILE LINE 3-01
- 04 WATER LINE PLAN AND PROFILE LINES 3-02A AND 3-02B
- 05 WATER LINE PROFILE LINES 3-03A AND 3-03B
- 06 WATER DETAILS



APPROVED: MARK DANIEL MCGHEE JR., PE


DATE: 09-19-2018



LARKIN
LAMP RYNEARSON

9001 State Line Rd., Suite 200 816.361.0440 | P
Kansas City , Missouri 64114 816.361.0045 | F
www.LRA-Inc.com

L:\Engineering\0316050 SVFD06 Summit View Farms 3rd Plat\Drawings\CONSTRUCTION DRAWINGS\WAT-PLANS\0316050-WAT-GEN.dwg, 9/19/2018 7:23:37 AM, JAMIE MCNULTY, LAMP RYNEARSON & ASSOCIATES

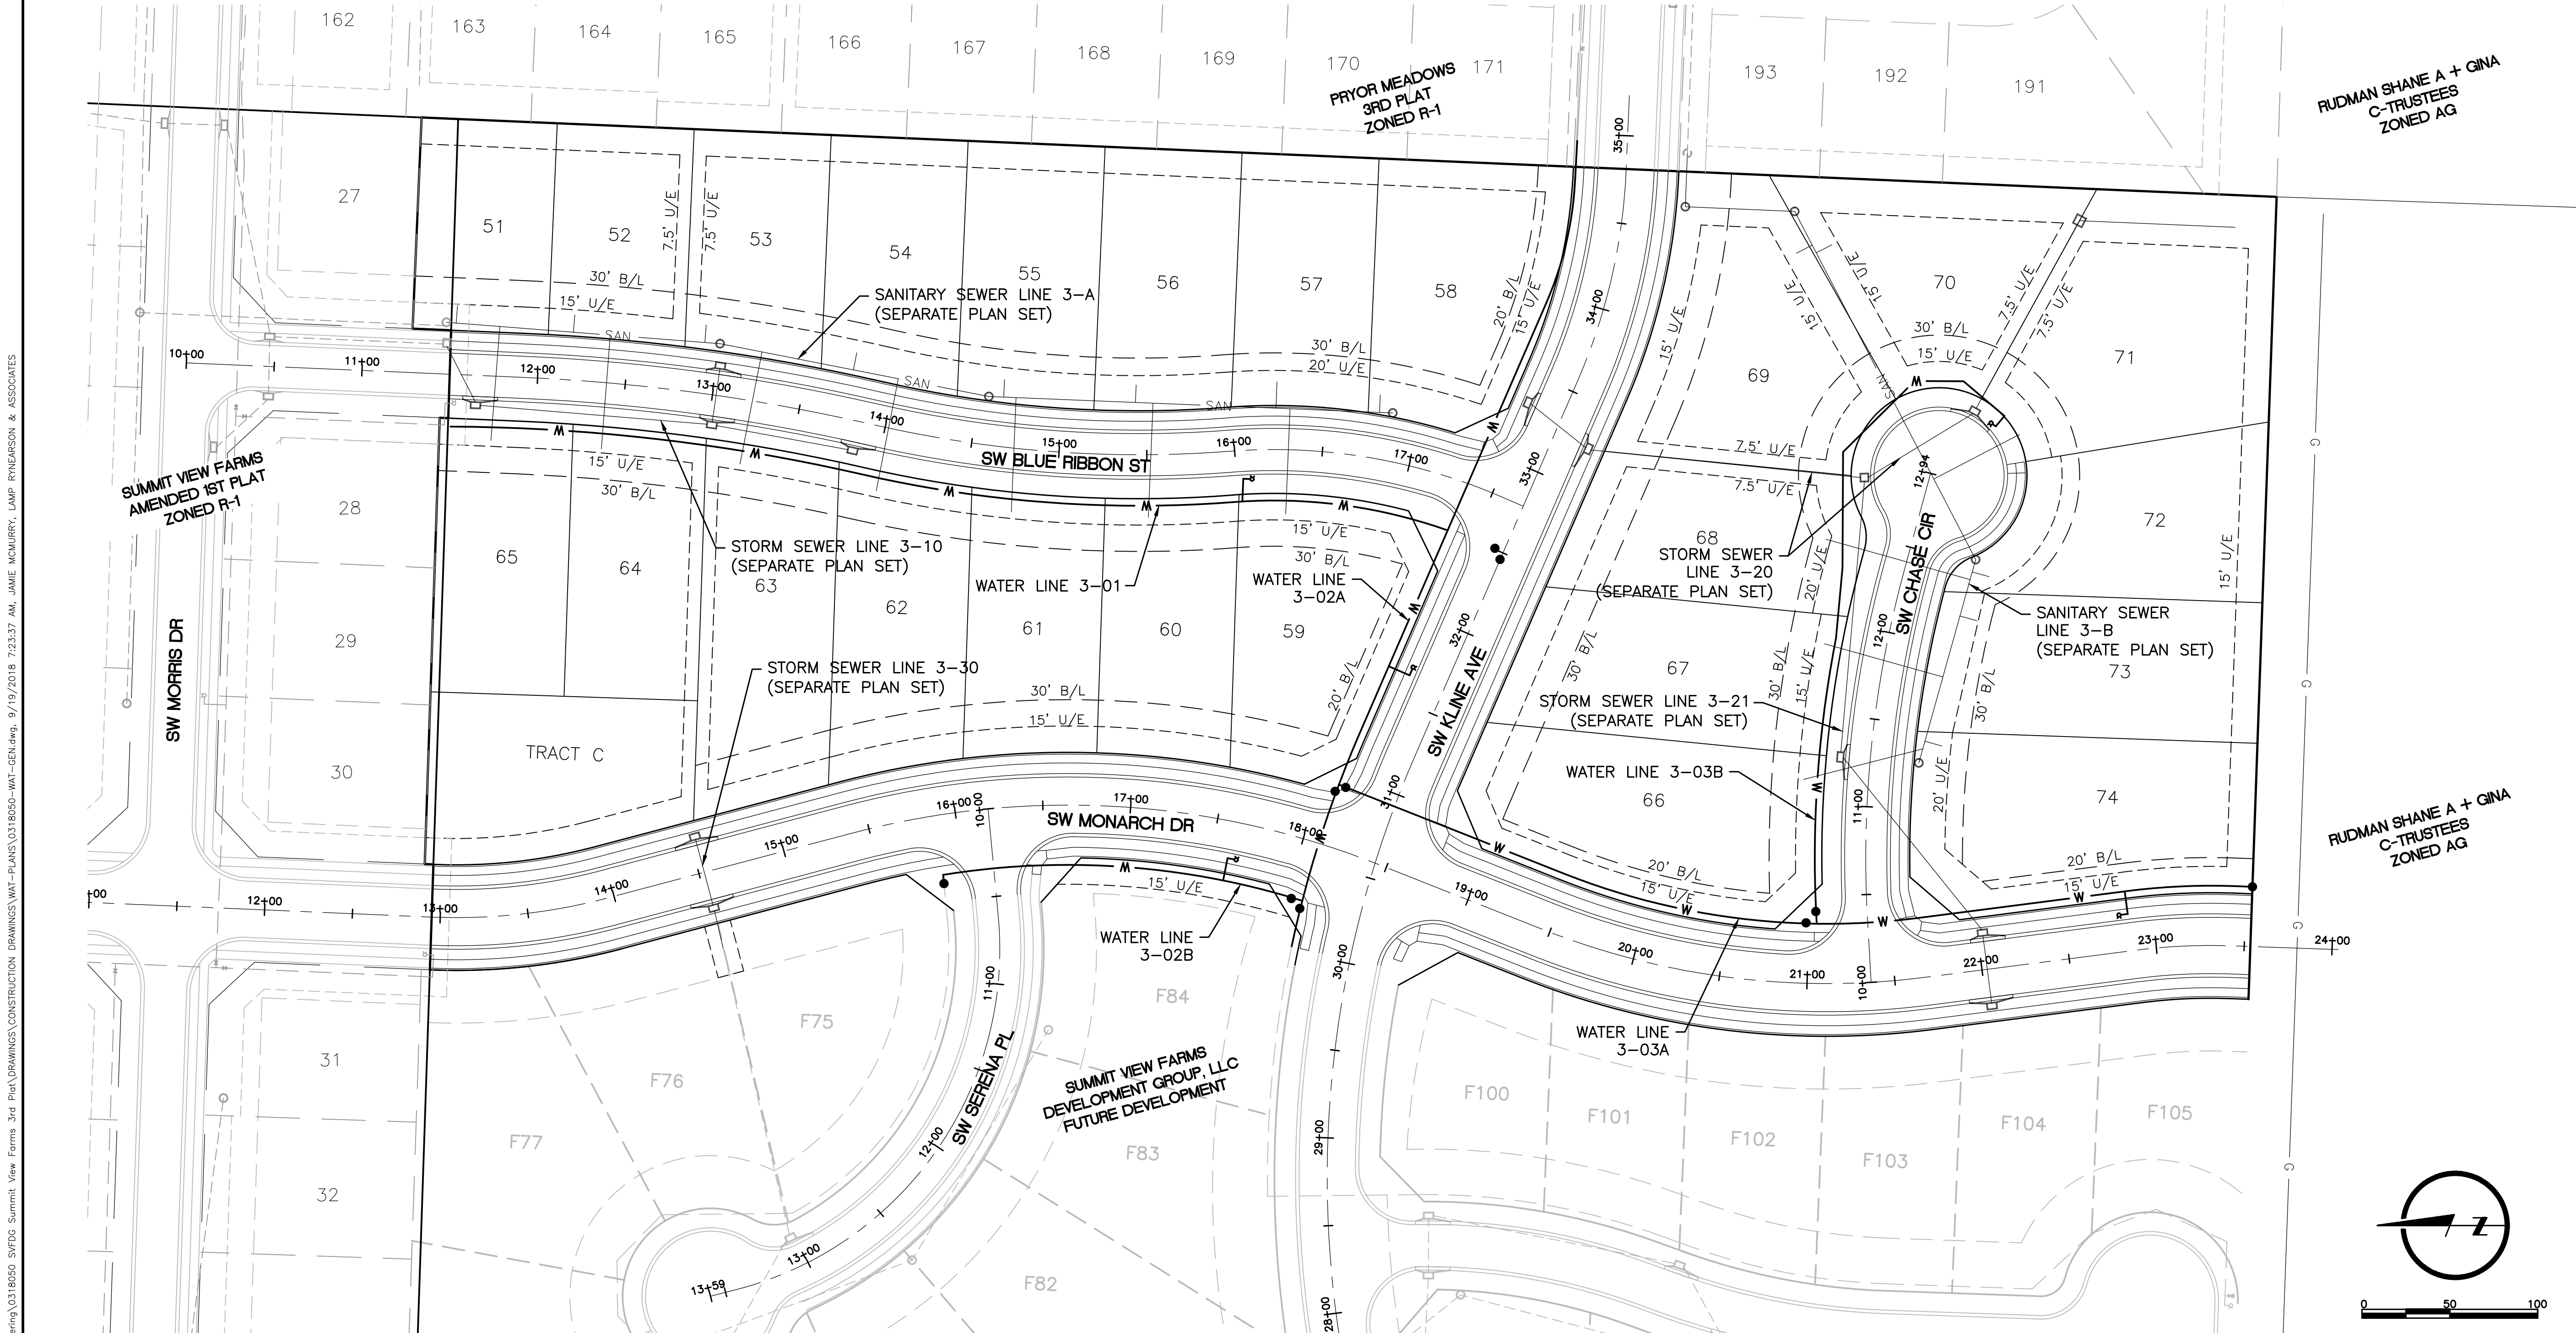


GENERAL NOTES:

1. ALL CONSTRUCTION TO FOLLOW THE CITY OF LEE'S SUMMIT DESIGN AND CONSTRUCTION MANUAL AS ADOPTED BY ORDINANCE 5813.
2. ALL WORKMANSHIP AND MATERIALS SHALL BE SUBJECT TO THE INSPECTION AND APPROVAL OF THE ENGINEERING DEPARTMENT OF THE CITY OF LEE'S SUMMIT, MISSOURI.
3. LINEAL FOOT MEASUREMENTS SHOWN ON THE PLANS ARE HORIZONTAL MEASUREMENTS, NOT SLOPE MEASUREMENTS.
4. NO GEOLOGICAL INVESTIGATION THIS BEEN PERFORMED ON THIS PLAT.
5. THE UTILITY LOCATIONS SHOWN ON THESE PLANS ARE TAKEN FROM UTILITY COMPANY RECORDS AND APPARENT FIELD LOCATIONS. THE CONTRACTOR SHALL VERIFY THE LOCATION AND DEPTH OF ALL UTILITIES PRIOR TO CONSTRUCTION.
6. THE CONTRACTOR SHALL ADHERE TO THE PROVISIONS OF THE SENATE BILL NUMBER 583, 78TH GENERAL ASSEMBLY OF THE STAT OF MISSOURI. THE BILL REQUIRES THAT ANY PERSON OR FIRM DOING EXCAVATION ON PUBLIC RIGHT-OF-WAY DO SO ONLY AFTER GIVING NOTICE TO, AND OBTAINING INFORMATION FROM, UTILITY COMPANIES. STATE LAW REQUIRES 72 HOURS ADVANCE NOTICE. THE CONTRACTOR MAY ALSO UTILIZE THE FOLLOWING TOLL FREE PHONE NUMBER PROVIDED BY "MISSOURI ONE CALL SYSTEM, INC.": 1-(800)-DIG-RITE OR 811. THIS PHONE NUMBER IS APPLICABLE ANYWHERE WITHIN THE STATE OF MISSOURI PRIOR TO COMMENCEMENT OF WORK, THE CONTRACTOR SHALL NOTIFY ALL THOSE COMPANIES WHICH ARE FACILITIES IN THE NEAR VICINITY OF THE CONSTRUCTION TO BE PERFORMED.
7. THE CONTRACTOR SHALL PROTECT ALL MAJOR TREES FROM DAMAGE. NO TREE SHALL BE REMOVED WITHOUT PERMISSION OF THE OWNER, UNLESS SHOWN OTHERWISE.
8. ALL EXCAVATION SHALL BE UNCLASSIFIED.
9. THE CONTRACTOR SHALL CONTROL THE EROSION AND SILTATION DURING ALL PHASES OF CONSTRUCTION, AND SHALL KEEP THE STREETS CLEAN OF MUD AND DEBRIS.
10. ALL MANHOLES, CATCH BASINS, UTILITY VALVES AND METER PITS TO BE ADJUSTED OR REBUILT TO GRADE AS REQUIRED. ALL EXISTING UTILITIES SHALL BE ADJUSTED AS REQUIRED.
11. THE CONTRACTOR SHALL CONTACT PUBLIC WORKS INSPECTIONS AT 816-969-1800 TO OBTAIN A PUBLIC WORKS CONSTRUCTION PERMIT. PERMITS ARE ISSUED BY THE DEVELOPMENT ENGINEERING DIVISION AFTER PLANS ARE APPROVED FOR PERMITTING AND FEES ARE PAID.
12. THE CONTRACTOR SHALL CONTACT THE CITY'S DEVELOPMENT ENGINEERING FIELD ENGINEERING INSPECTORS AT 816-969-1200 PRIOR TO ANY LAND DISTURBANCE.
13. THE CONTRACTOR SHALL CONTACT THE CITY'S RIGHT-OF-WAY INSPECTOR AT 816-969-1800 PRIOR TO ANY LAND DISTURBANCE ACTIVITIES WITHIN THE RIGHT-OF-WAY. THESE ACTIVITIES MAY REQUIRE A PERMIT.
14. THE CONTRACTOR SHALL PROVIDE AND MAINTAIN ALL TRAFFIC HANDLING MEASURES NECESSARY TO ENSURE THAT THE GENERAL PUBLIC IS PROTECTED AT ALL TIMES. TRAFFIC CONTROL SHALL CONFORM TO THE MANUAL ON UNIFORM TRAFFIC CONTROL DEVICES (MUTCD - LATEST EDITION).



DRAWN BY JAM	DESIGNED BY MDM	DATE 09-19-2018	JOB NUMBER-TASKS 0316050.01	BOOK AND PAGE
PERSONS 09/19/18 - RESUBMITAL PER ADJUSTED LAYOUT 09/19/18 - RESUBMITAL PER CITY COMMENTS				
9001 State Line Rd., Suite 200 816.361.0440 P Kansas City, Missouri 64114 816.361.0445 F www.LRA-INC.com				
LARKIN/ LAMP RYNEARSON				
SUMMIT VIEW FARMS 3RD PLAT LEES SUMMIT, MISSOURI				
WATER LINE PLANS GENERAL LAYOUT PLAN SHEET				
LARKIN LAMP RYNEARSON - ENGINEERS TMO Certificate of Authority No. 2013011903				
STATE OF MISSOURI MARK DANIEL MCGHEE JR. JULY 2008 PE-2008019568 PROFESSIONAL ENGINEER 09-19-2018				
MARK DANIEL MCGHEE JR. PE - 2008019568				
SHEET				
2 OF 6				

L:\Engineering\0318050 SVFDG Summit View Farms 3rd Plat\DRAWINGS\CONSTRUCTION DRAWINGS\WAT-PLANS\0318050-WAT-RNP-01.dwg, 9/19/2018 7:25:38 AM, JAMIE MCURRY, LAMP RYNEARSON & ASSOCIATES

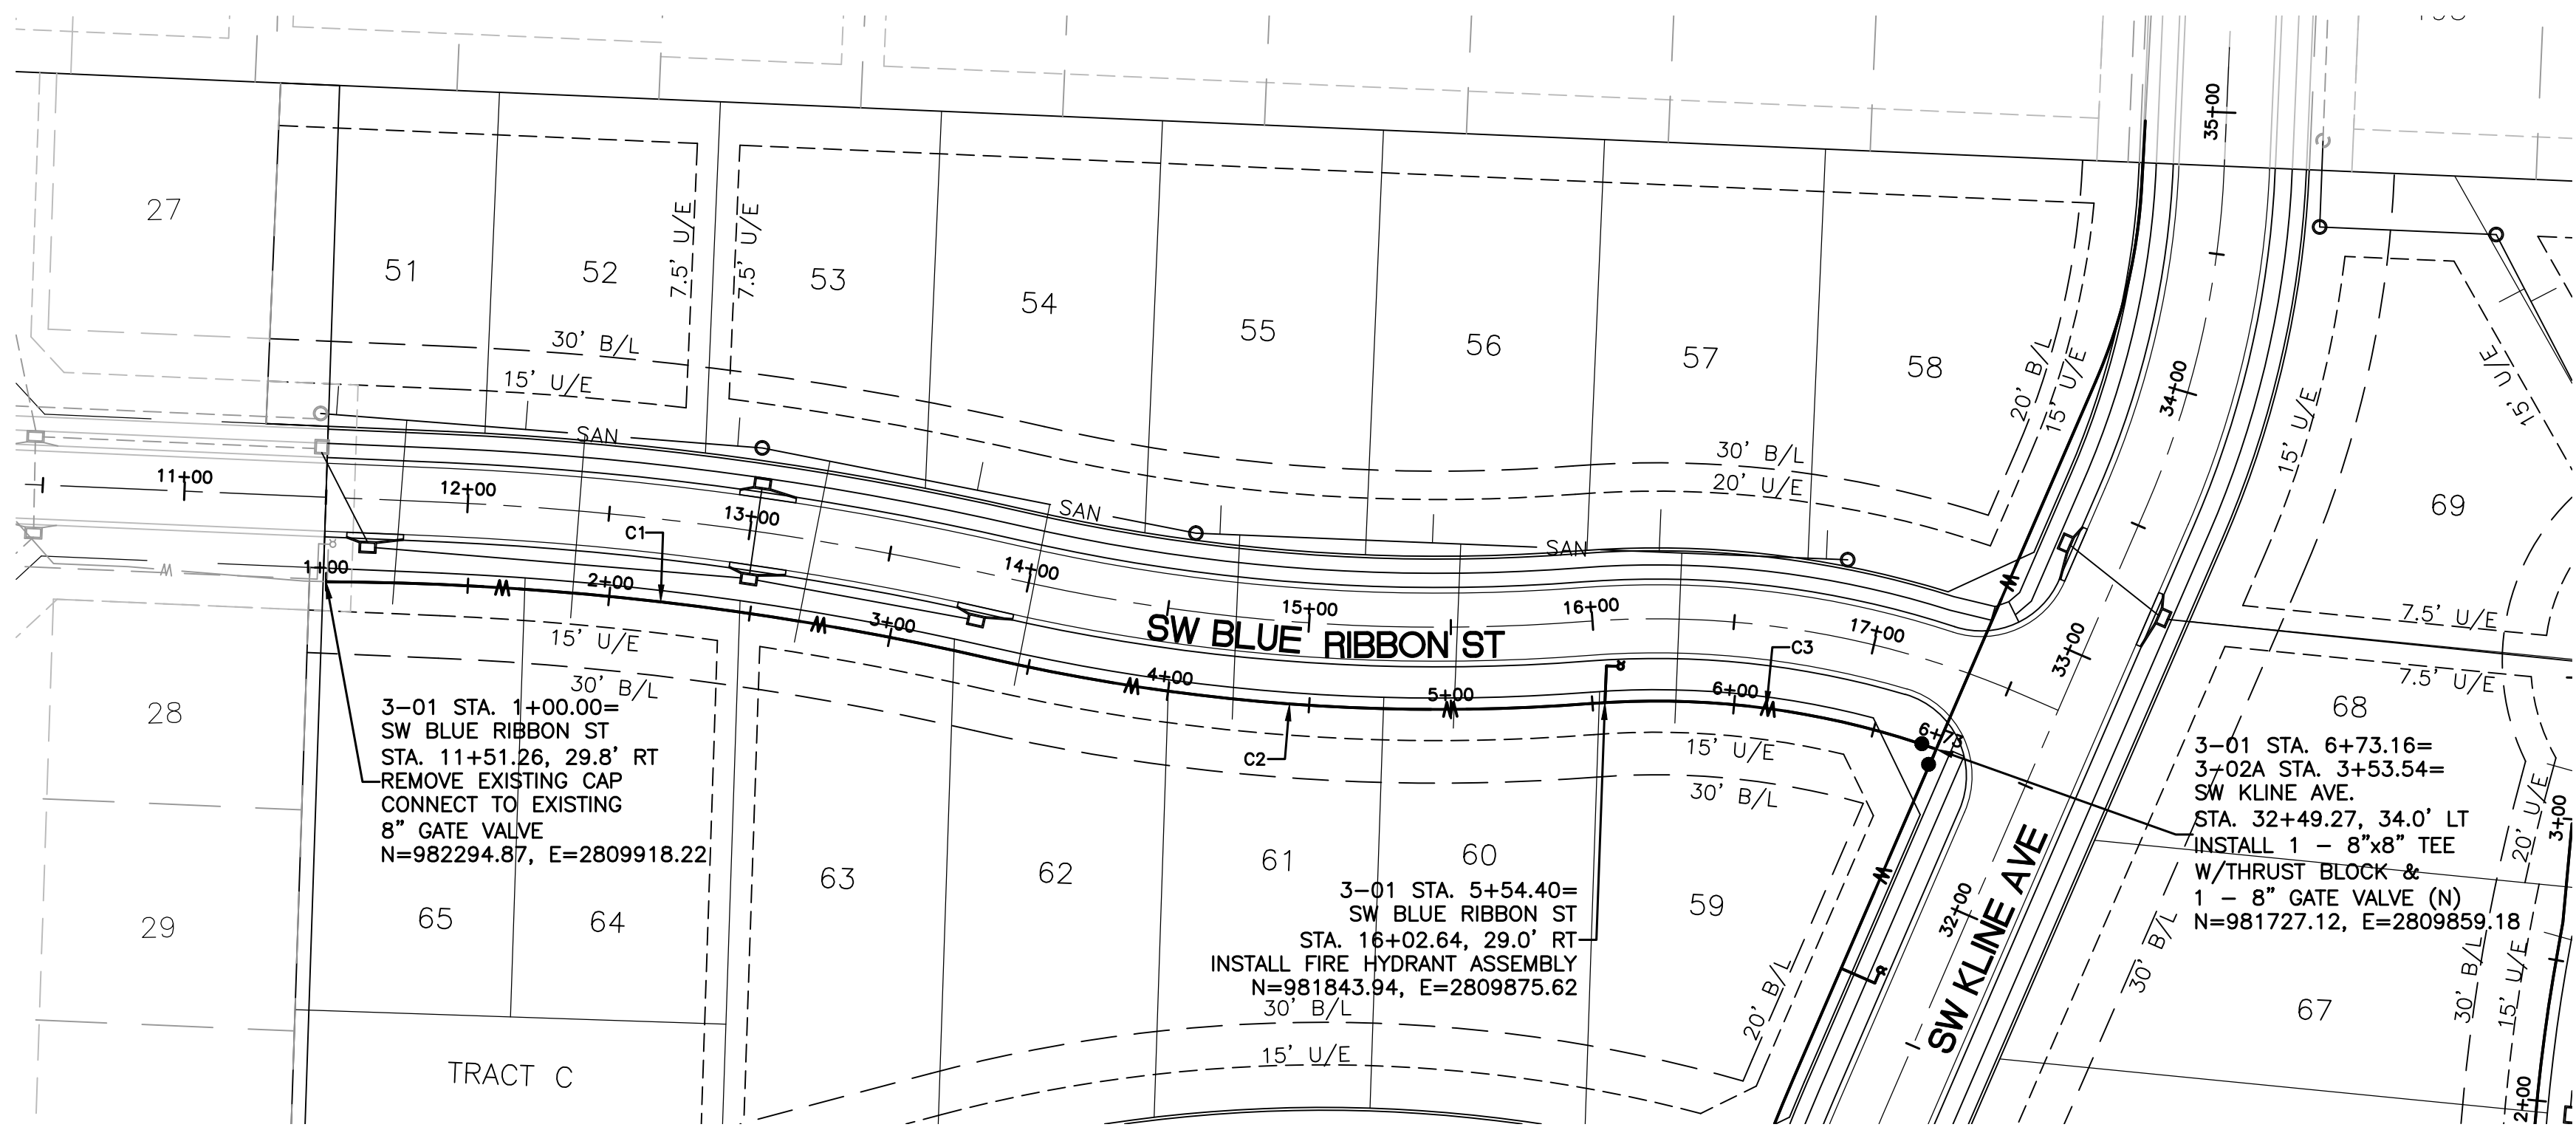

ALIGNMENT TABLE						
Line #/Curve #	Length	Direction/Delta	Radius	BEGIN NORTHING/EASTING	END NORHTING/EASTING	
C1	236.50	012.65	1071.00	N=982294.87/E=2809918.22	N=982060.42/E=2809891.06	
C2	213.12	017.35	704.00	N=982060.42/E=2809891.06	N=981848.70/E=2809875.29	
C3	123.53	023.91	296.00	N=981848.70/E=2809875.29	N=981727.12/E=2809859.18	

- WATER MAIN NOTES (APPLICABLE TO ALL WATER MAIN PLAN AND PROFILE SHEETS):
1. WATER MAINS AND SANITARY SEWER MAINS (INCLUDING STRUCTURES) SHALL HAVE AT LEAST 10-FT OF HORIZONTAL SEPARATION FROM EDGE OF WATER PIPE TO EDGE OF SEWER PIPE OR SEWER STRUCTURE.
 2. WATER MAINS AND SANITARY SEWERS SHALL HAVE AT LEAST 18-INCHES OF VERTICAL SEPARATION FROM EDGE OF PIPE TO EDGE OF PIPE. THE CROSSING SHALL BE ARRANGED SO THAT THE WATER MAIN JOINTS WILL BE EQUIDISTANT AND AS FAR AS POSSIBLE FROM THE SEWER MAIN JOINTS.
 3. CONCRETE THRUST BLOCKS SHALL BE INSTALLED AT ALL HORIZONTAL FITTING, VERTICAL FITTING, AND FIRE HYDRANT ASSEMBLY LOCATIONS IN ACCORDANCE WITH CITY STANDARD DETAILS WAT-1, WAT-2, AND WAT-8.

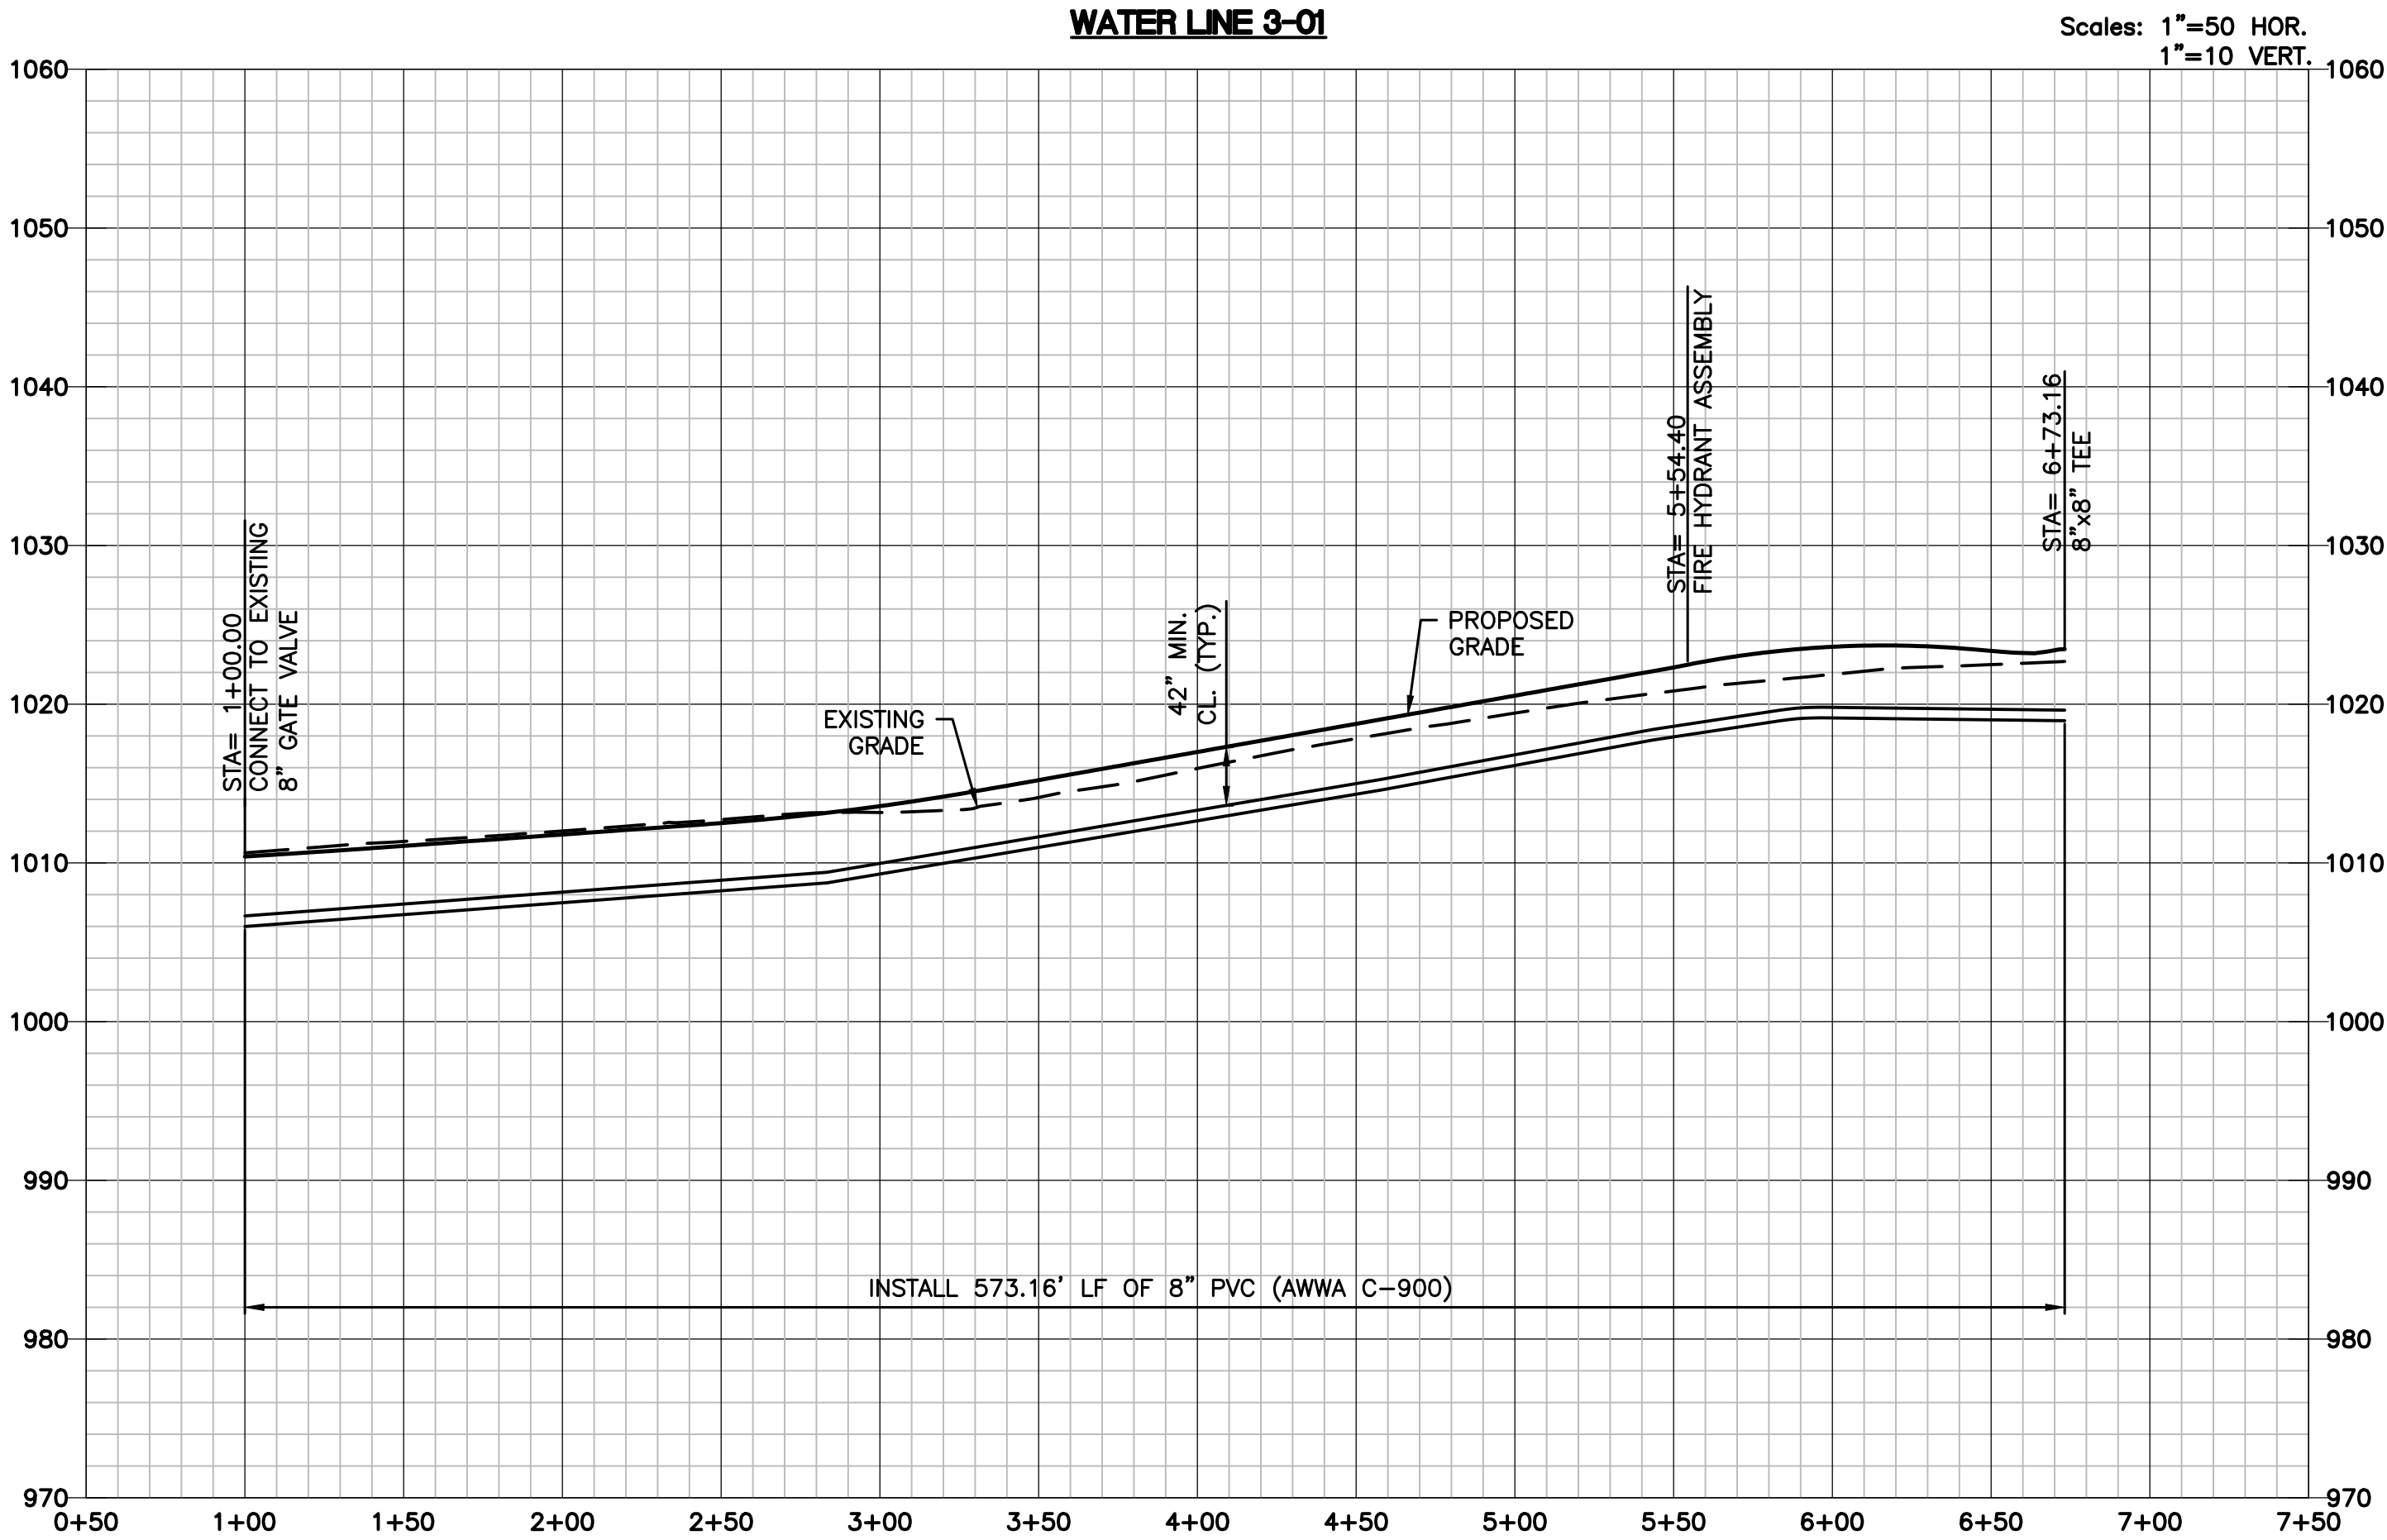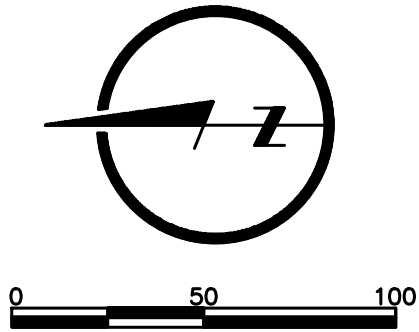

DRAWN BY
JAM

DESIGNED BY
MDM

DATE
09-19-2018

JOB NUMBER-TASKS
0318050.01

BOOK AND PAGE

REVISIONS

08/19/18 - RESUBMITAL PER ADJUSTED LAYOUT

09/19/18 - RESUBMITAL PER CITY COMMENTS

LARKIN/
LAMP RYNEARSON

9001 State Line Rd., Suite 200
Kansas City, Missouri 64114
www.LRA-INC.com

SUMMIT VIEW FARMS 3RD PLAT
LEES SUMMIT, MISSOURI

WATER LINE PLANS

WATER LINE PLAN AND PROFILE

WATER LINE 3-01

LARKIN LAMP RYNEARSON - ENGINEERS
MEO Certificate of Authority No. 2013011803

STATE OF MISSOURI

MARK DANIEL MCGHEE JR.

REGISTERED PROFESSIONAL ENGINEER

09-19-2018


MARK DANIEL MCGHEE JR.

PE - 2008019568



SHEET

3 OF 6


L:\Engineering\031859 SVF03 Summit View Farms 3rd Plat\Drawings\CONSTRUCTION DRAWINGS\WAT-PLANS\031859-WAT-PWP-02.dwg, 9/19/2018 7:27:31 AM, JAMIE MCMAURY, LAMP RYNARSON & ASSOCIATES

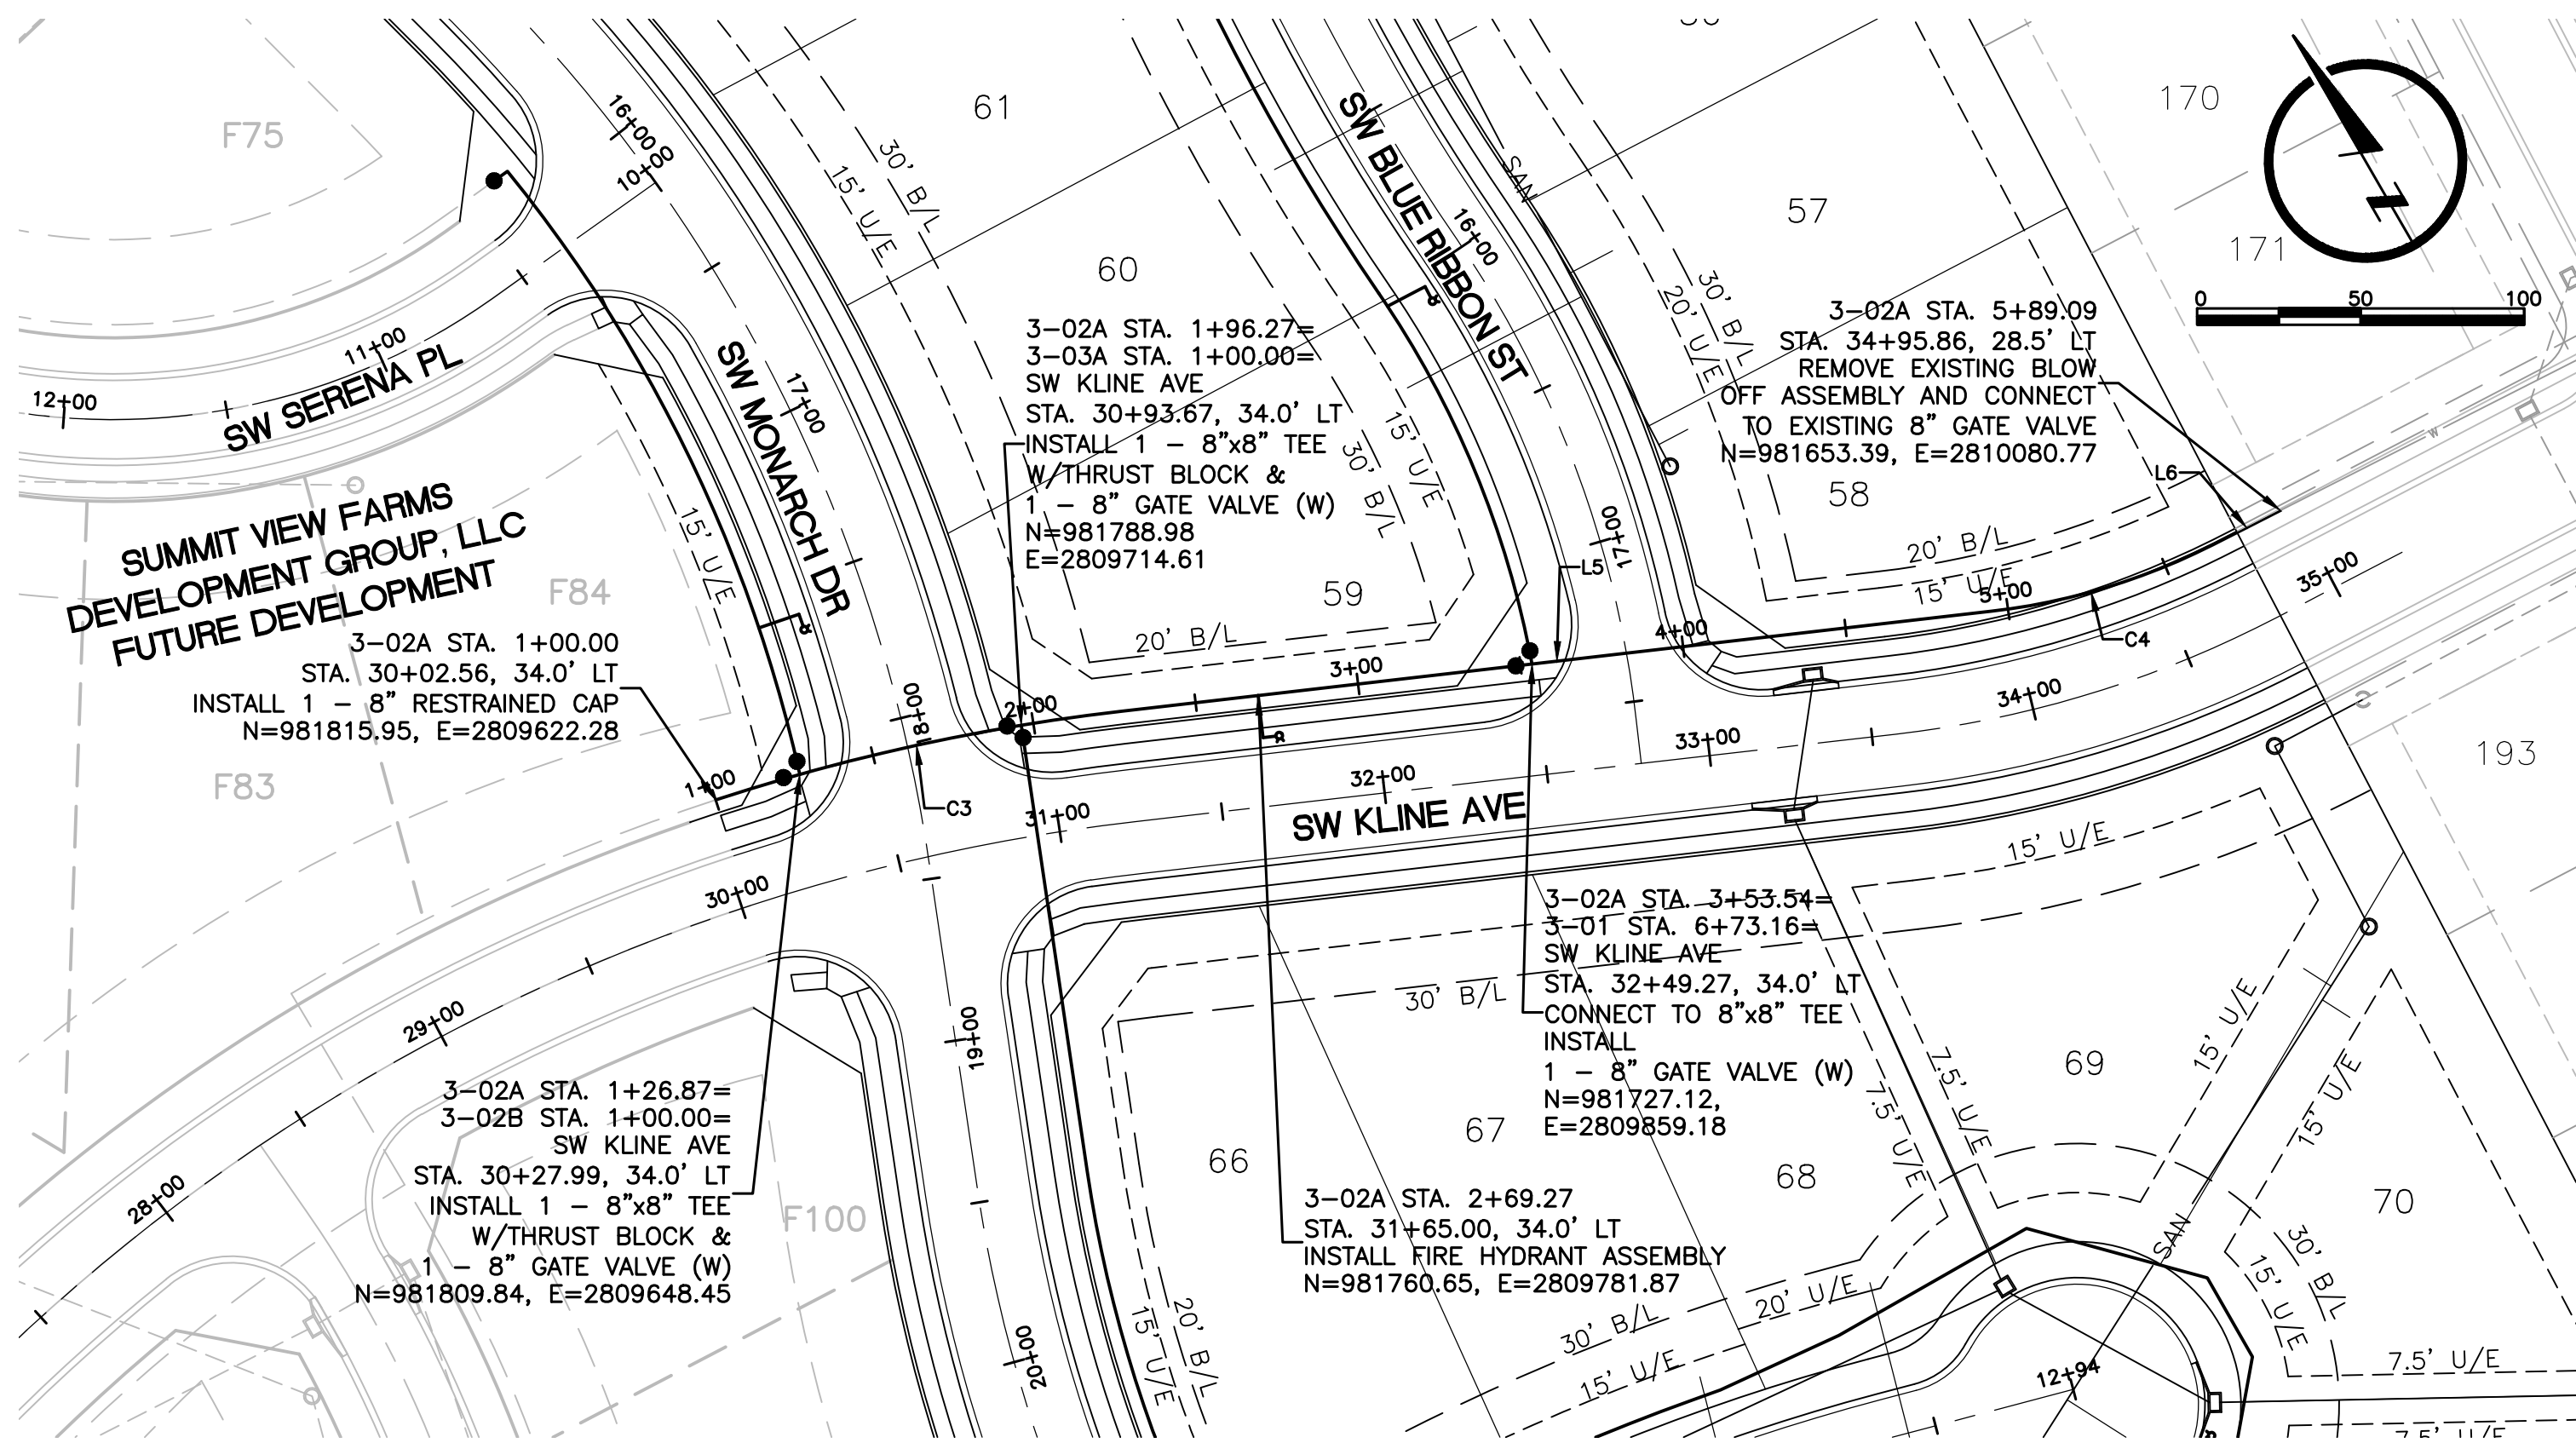

ALIGNMENT TABLE					
Line #/Curve #	Length	Direction/Delta	Radius	BEGIN NORTHING/EASTING	END NORHTING/EASTING
C3	127.40	011.51	634.00	N=981815.95/E=2809622.28	N=981777.31/E=2809743.45
L5	267.57	S66° 33' 24.07"E		N=981777.31/E=2809743.45	N=981670.86/E=2809988.93
C4	71.00	020.34	199.98	N=981670.86/E=2809988.93	N=981654.64/E=2810057.67
L6	23.13	S86° 53' 44.47"E		N=981654.64/E=2810057.67	N=981653.39/E=2810080.77

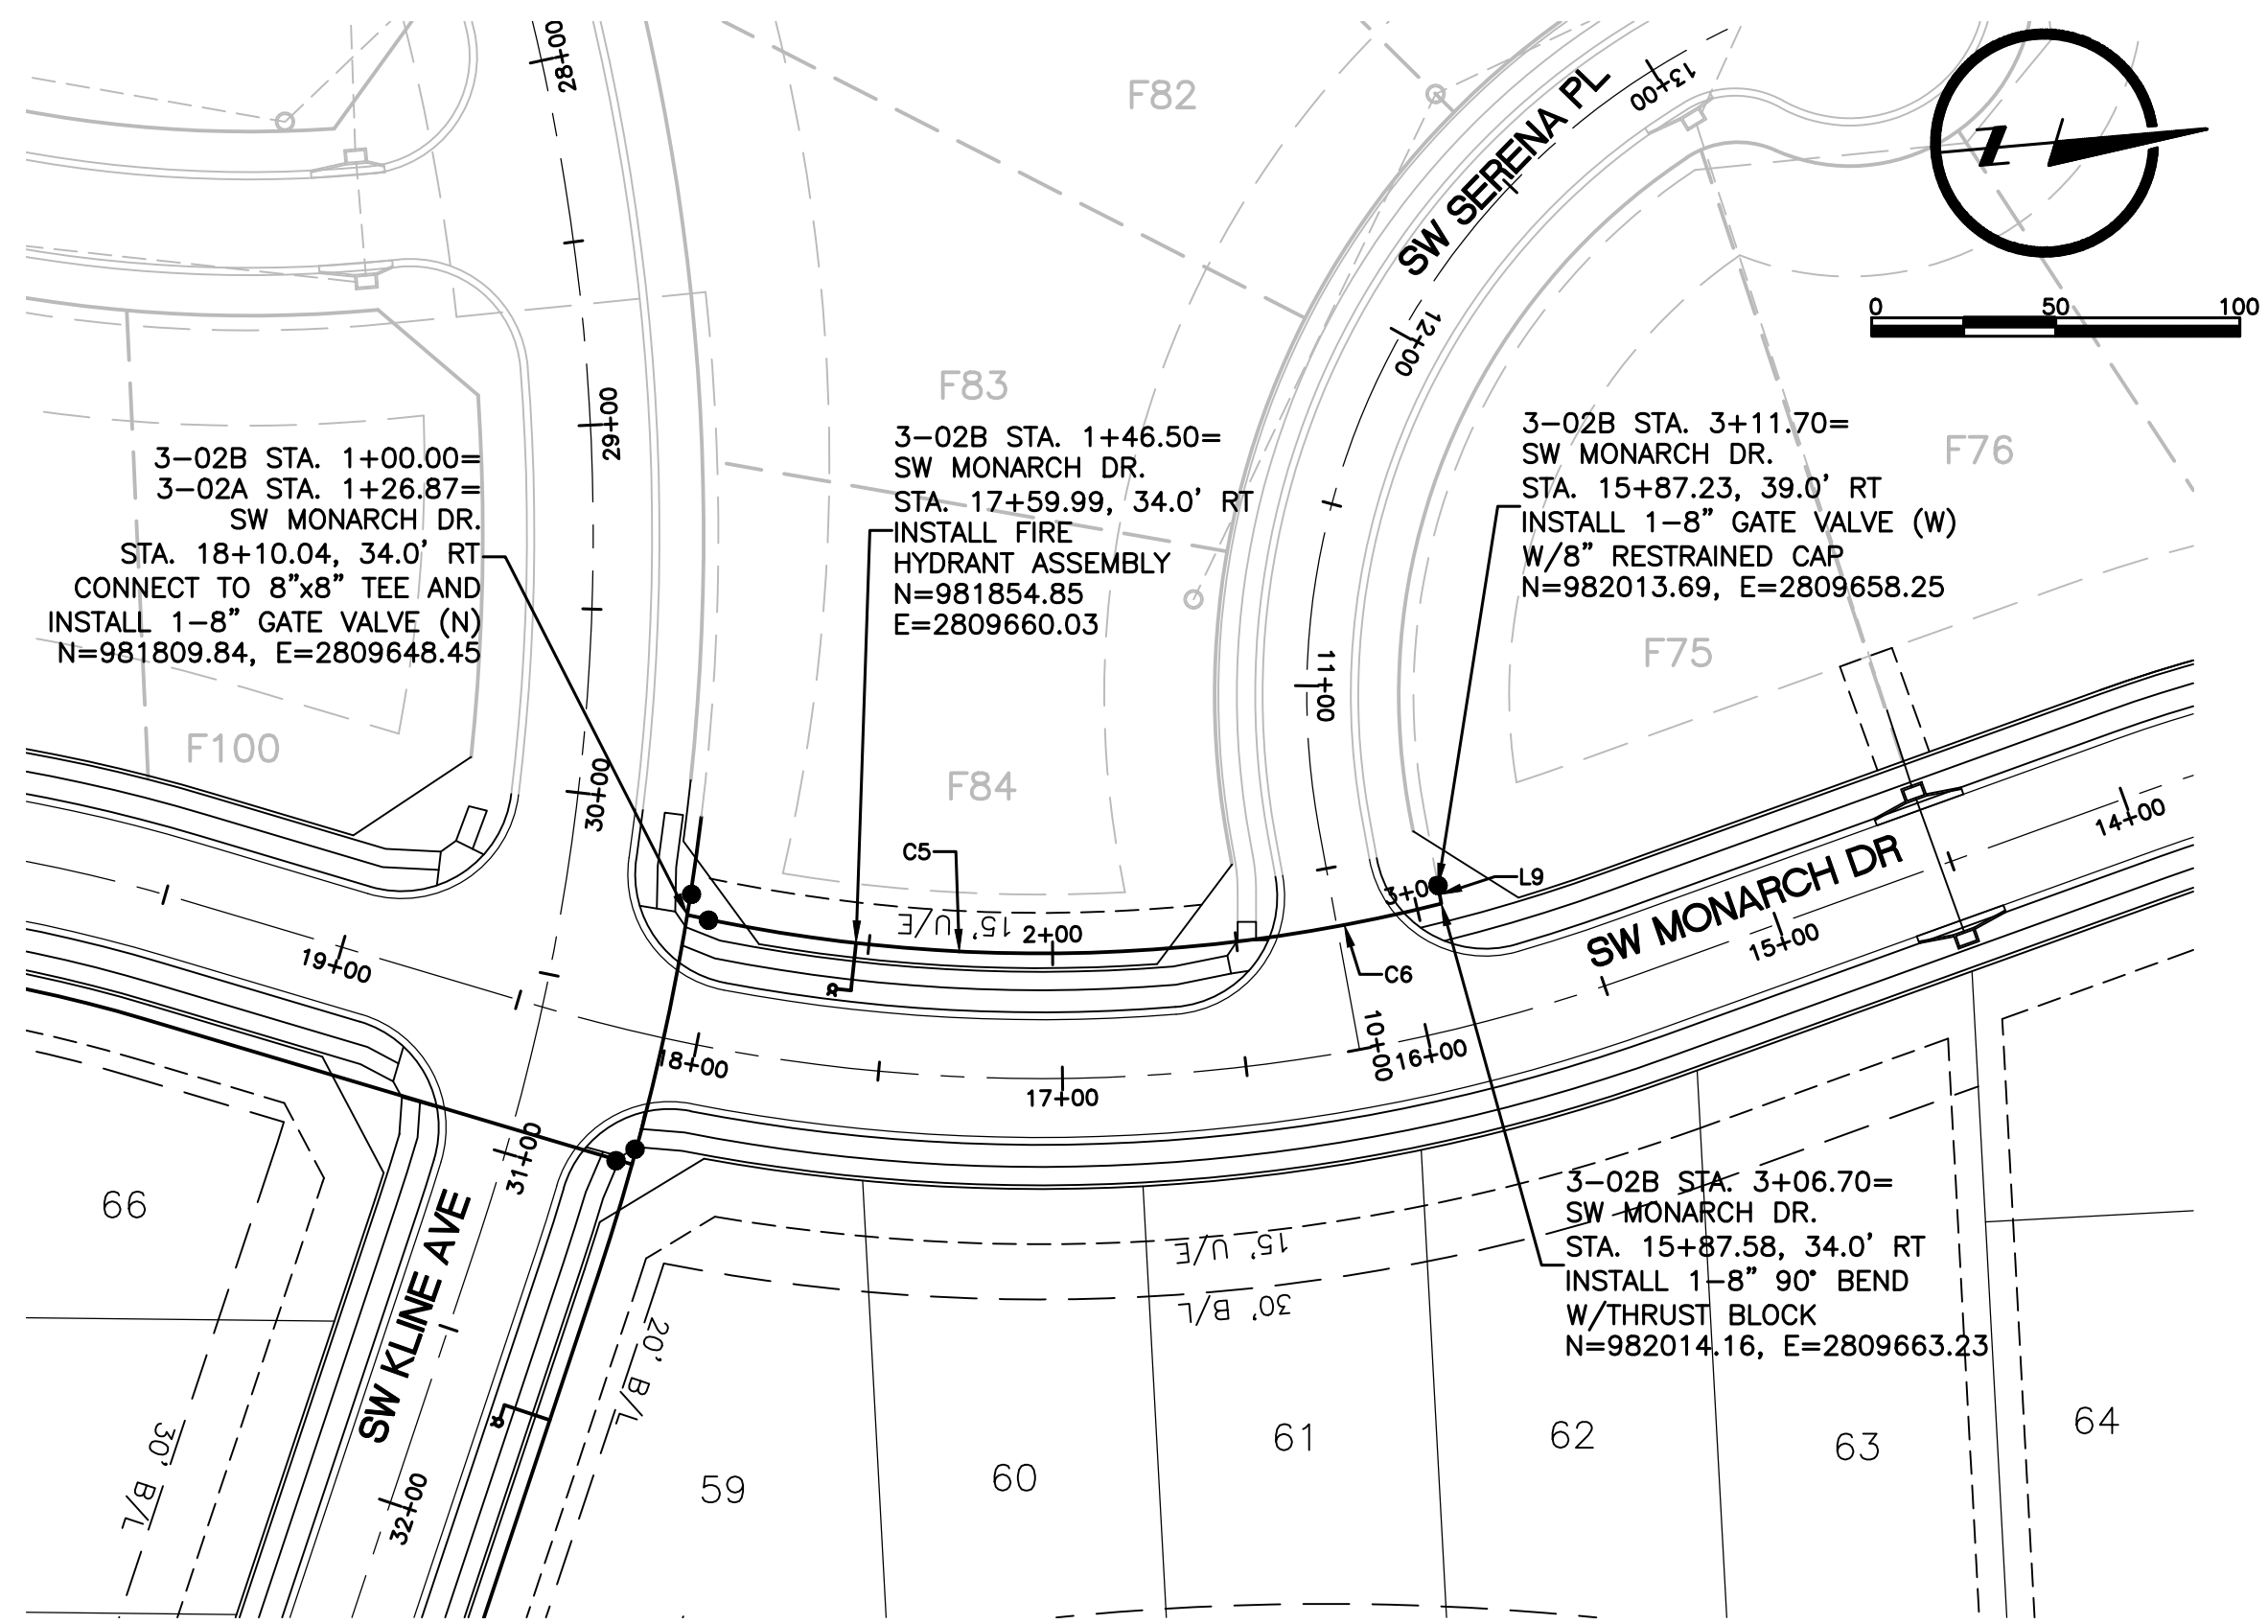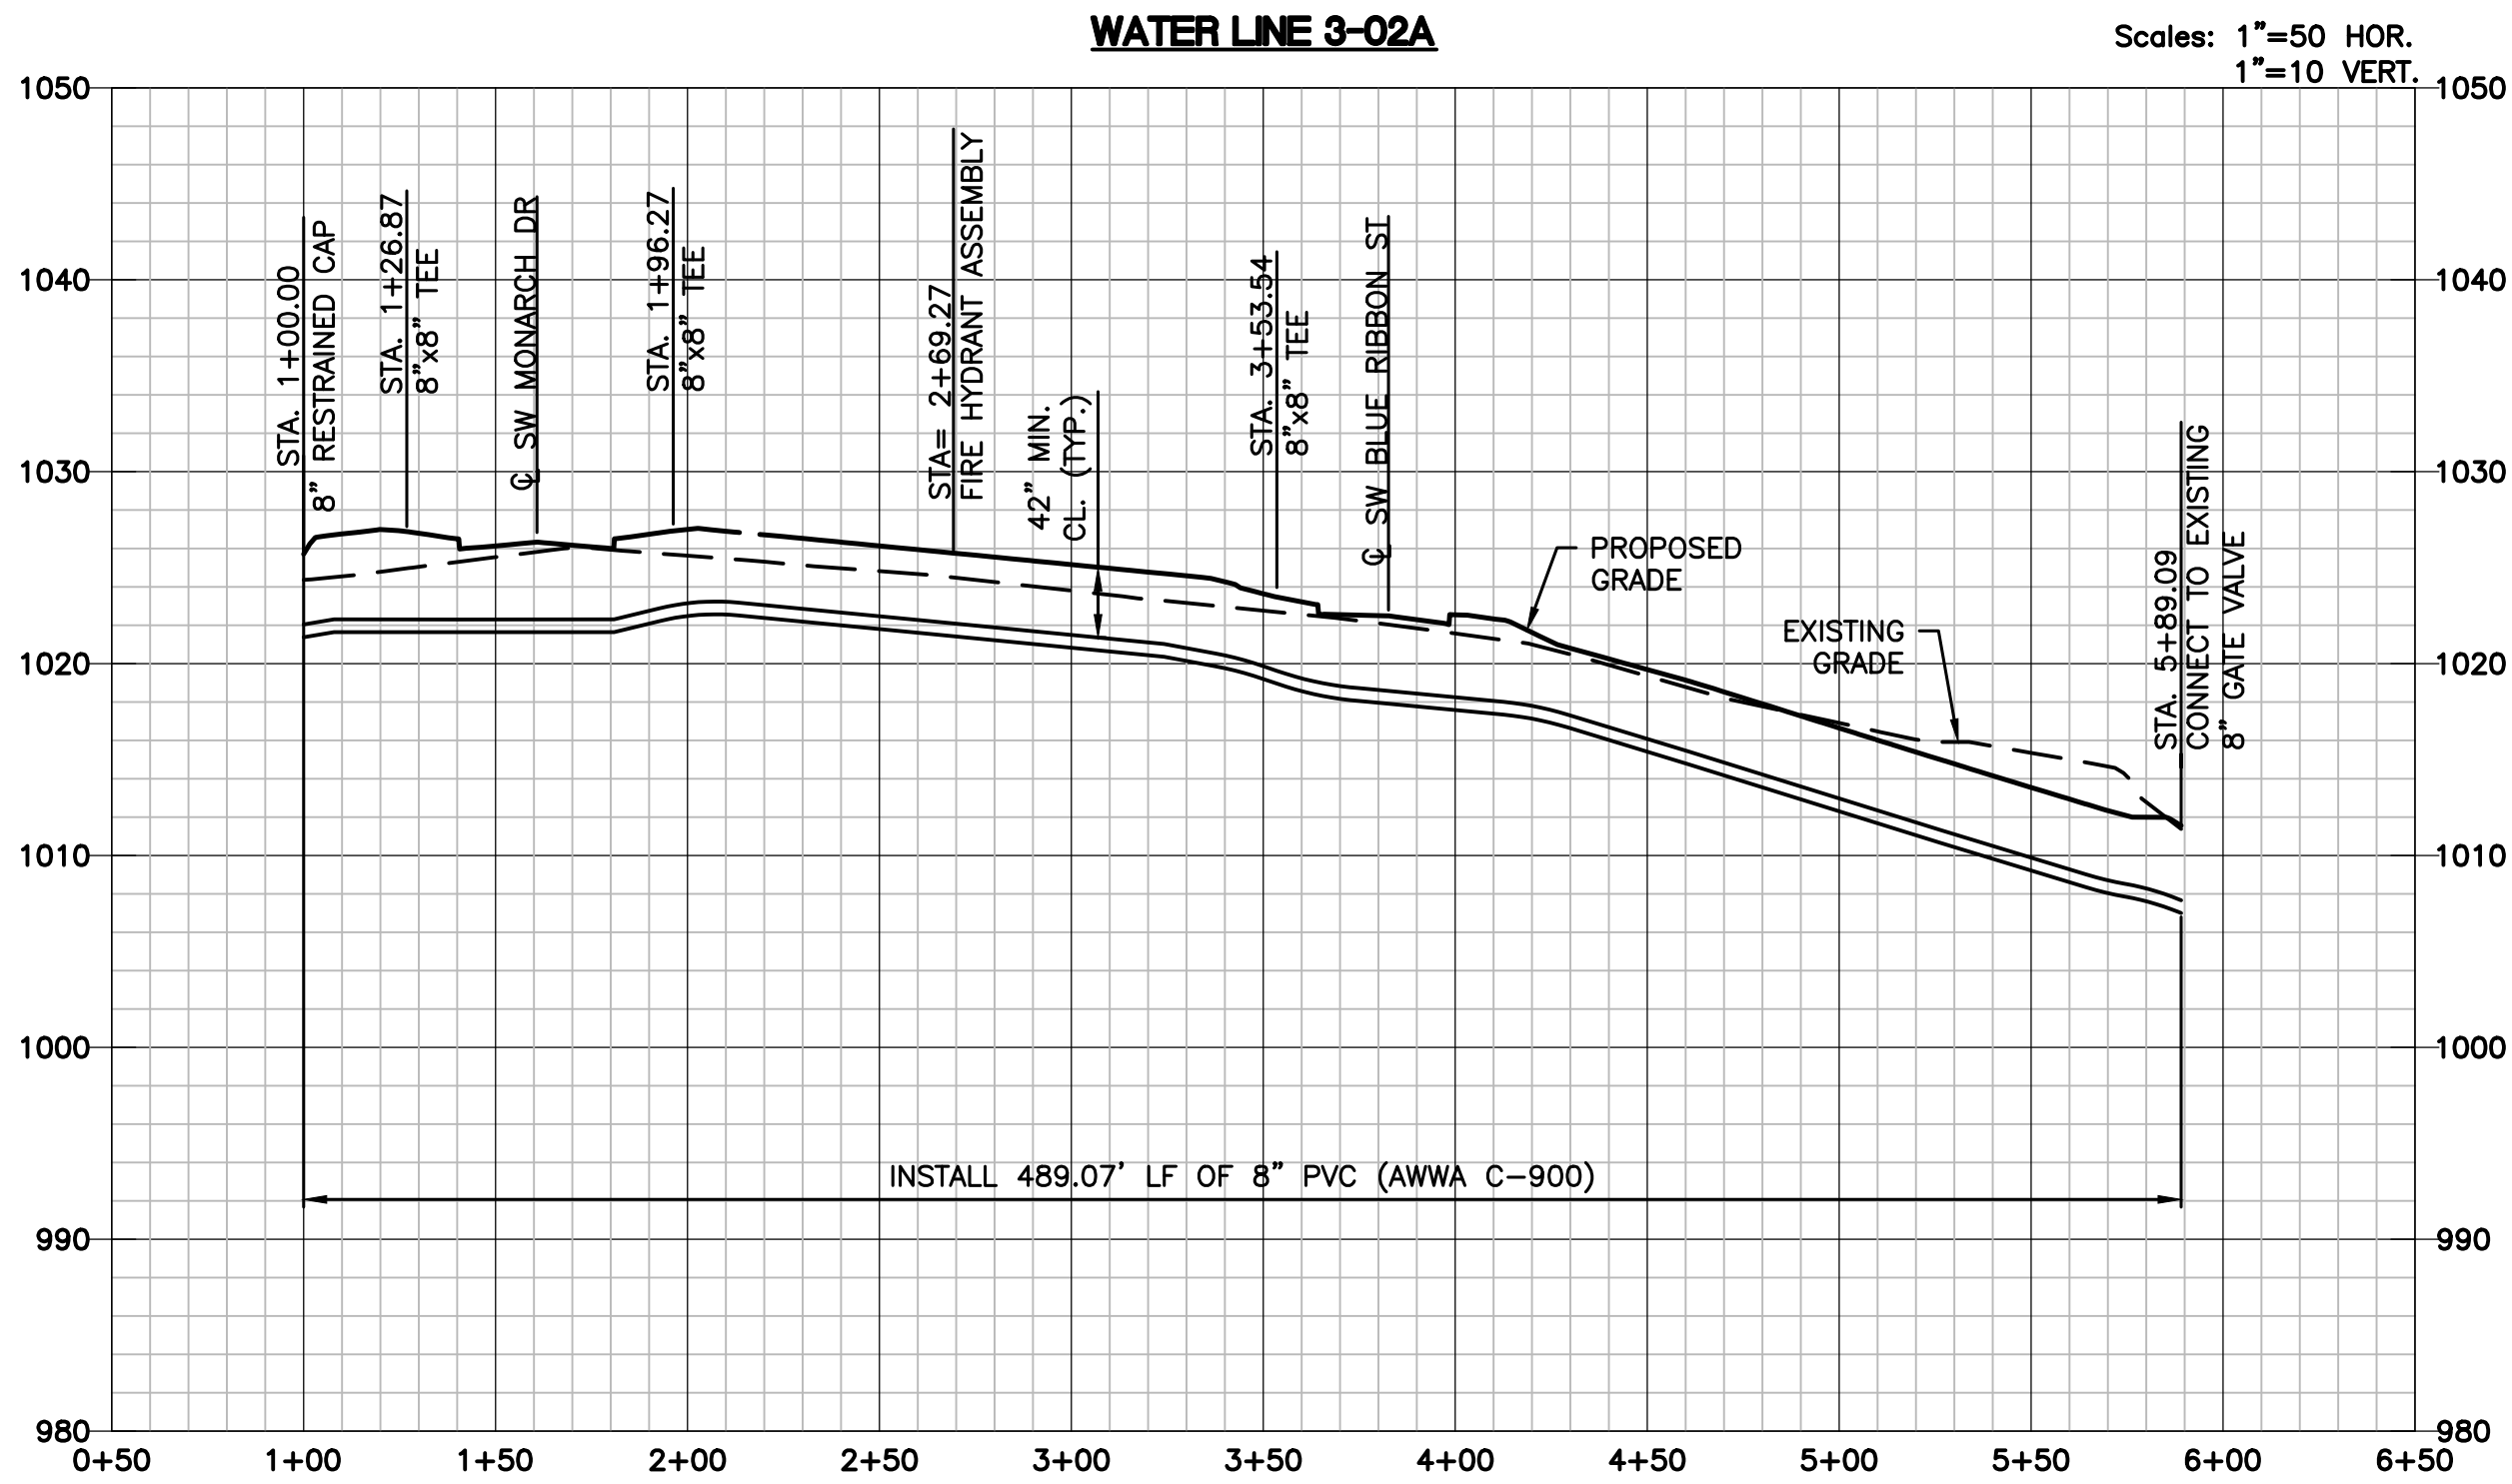


ALIGNMENT TABLE					
Line #/Curve #	Length	Direction/Delta	Radius	BEGIN NORTHING/EASTING	END NORHTING/EASTING
C5	156.24	020.07	446.00	N=981806.50/E=2809647.39	N=981960.50/E=2809668.56
C6	53.96	007.24	427.03	N=981960.50/E=2809668.56	N=982014.16/E=2809663.23
L9	5.00	S84° 35' 12.87"W		N=982014.16/E=2809663.23	N=982013.69/E=2809658.25

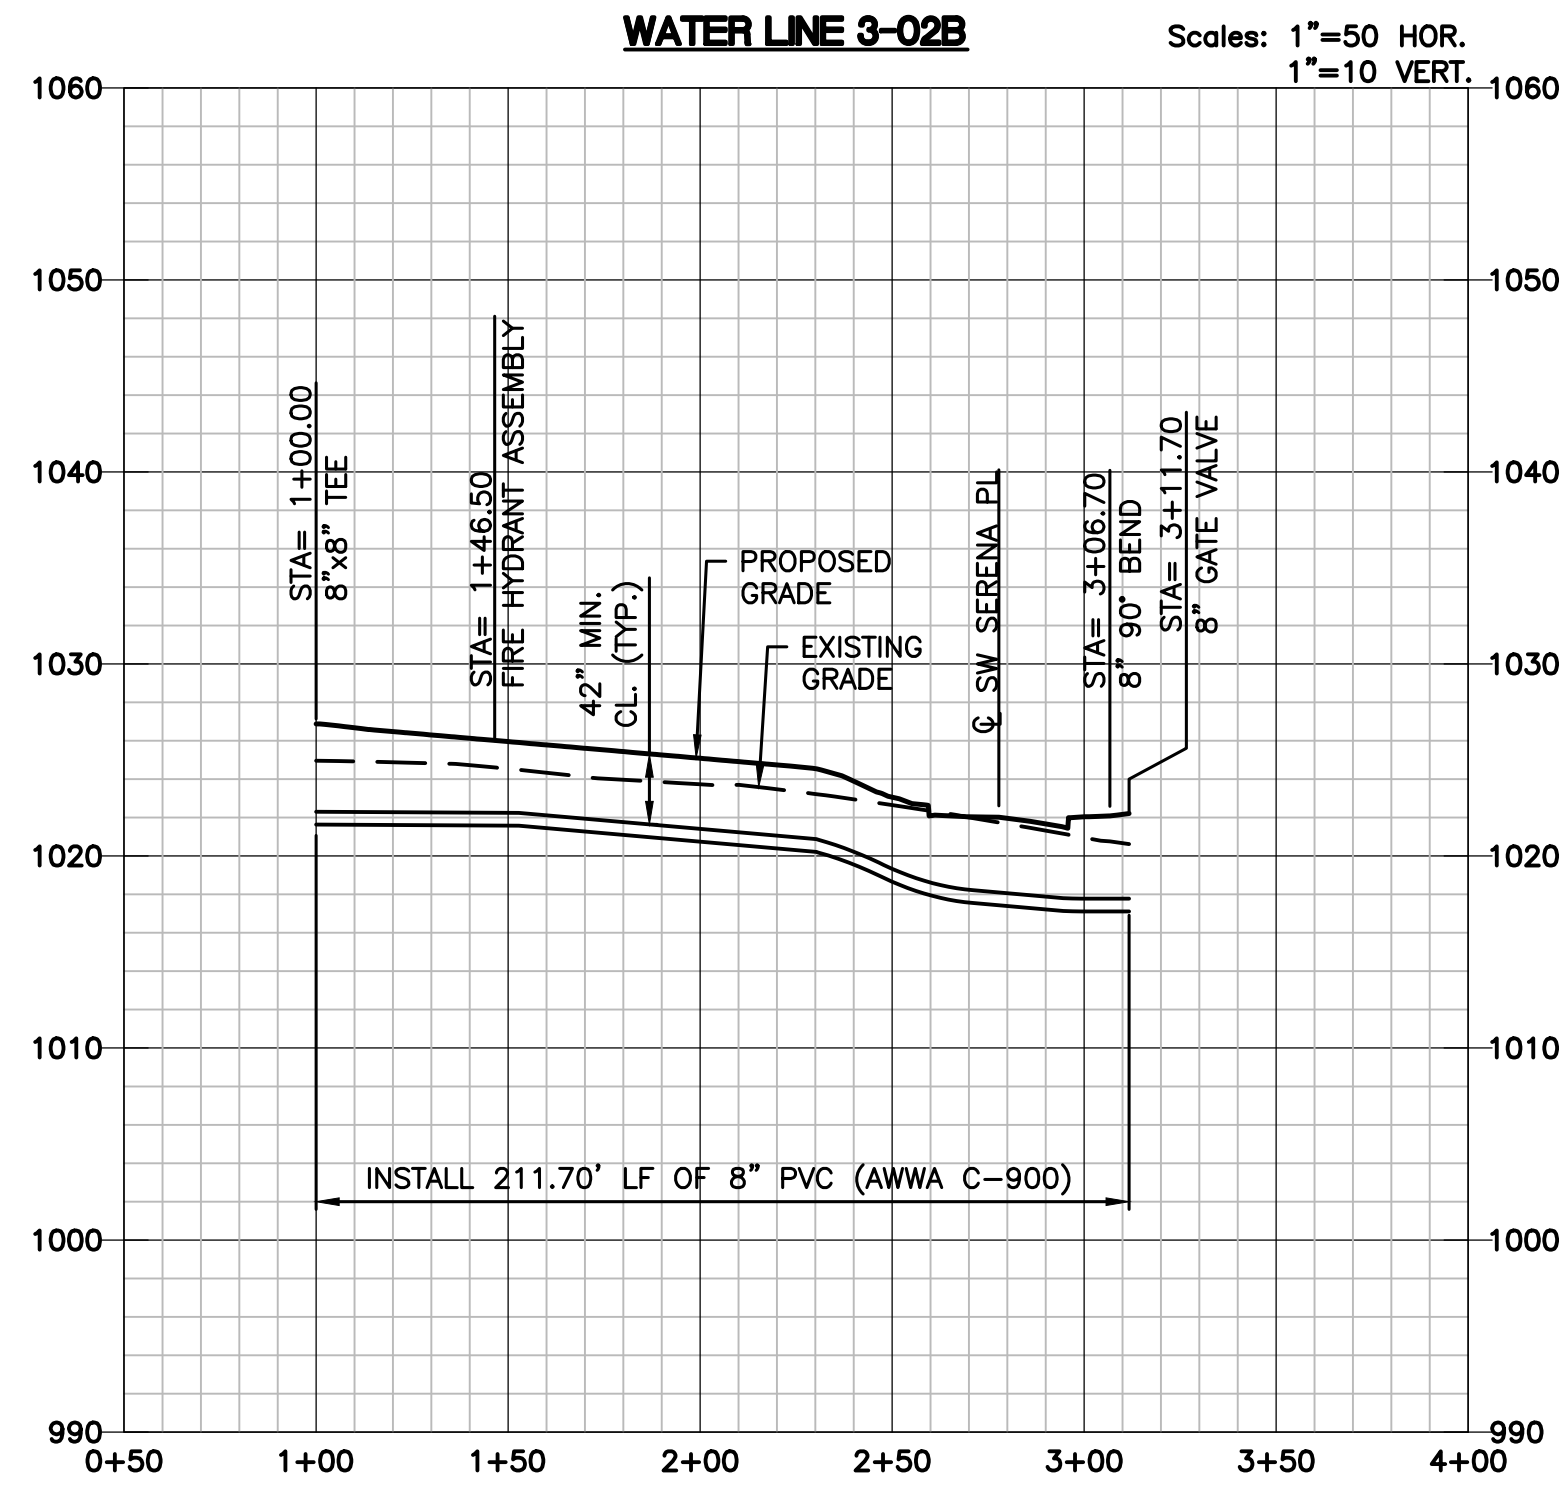


DESIGNED BY MDM	DESIGNED BY MDM	DATE 09-19-2018	JOB NUMBER-TASKS 031859.01	BOOK AND PAGE
REVISIONS				
08/19/18 - RESUBMITAL PER ADJUSTED LAYOUT				
09/19/18 - RESUBMITAL PER CITY COMMENTS				
9001 State Line Rd., Suite 200, 816.361.0440 P Kansas City, Missouri 64114 816.361.0045 F www.LRA-inc.com				
LARKIN/ LAMP RYNARSON				
SUMMIT VIEW FARMS 3RD PLAT LEES SUMMIT, MISSOURI				
WATER LINE PLANS				
WATER LINE PLAN AND PROFILE				
WATER LINE 3-02A AND 3-02B				
LARKIN LAMP RYNARSON - ENGINEERS MEO Certificate of Authority No. 2013011803				
STATE OF MISSOURI MARK DANIEL MCGHEE JR. Professional Engineer 09-19-2018				
MARK DANIEL MCGHEE JR. PE - 2008019568				
SHEET				
4 OF 6				

L:\Engineering\031850 SVF03 Summit View Farms 3rd Plat\Drawings\CONSTRUCTION DRAWINGS\WATER PLANS\WATER LINE 3-03A.dwg, 9/19/2018 7:29:02 AM, JAMIE MCMAURY, LAMP RYNARSON & ASSOCIATES


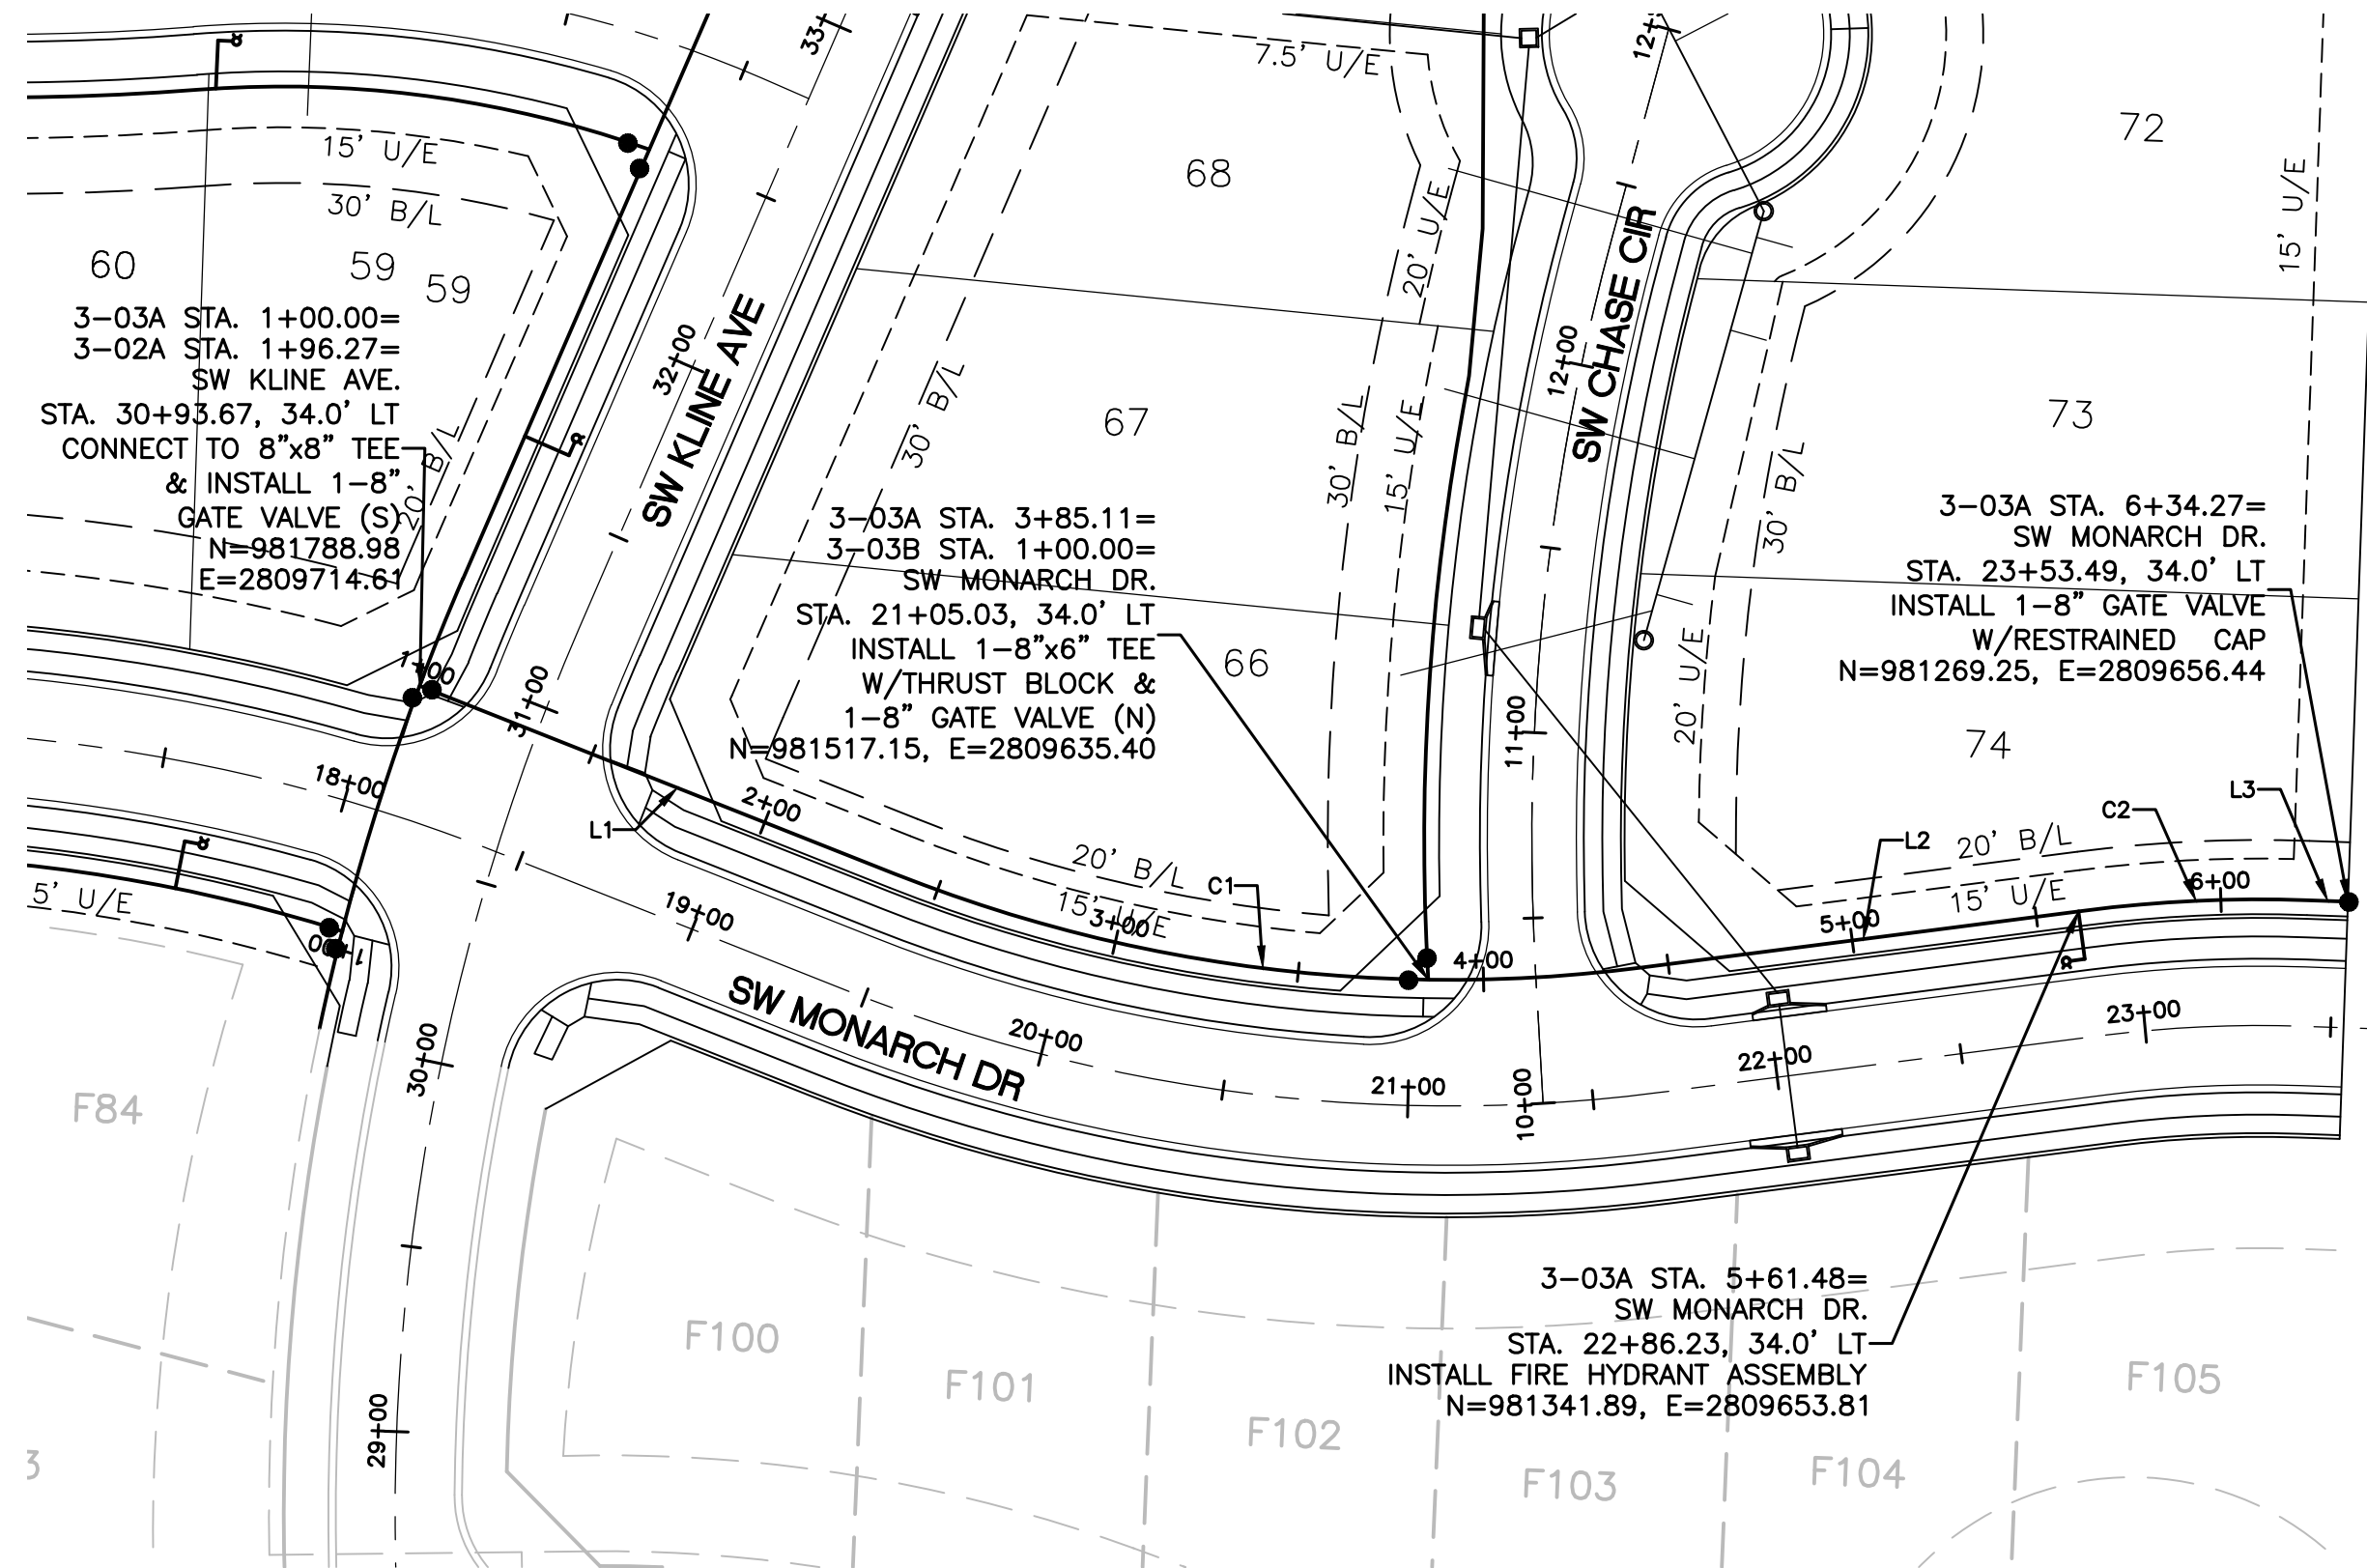


ALIGNMENT TABLE					
Line #/Curve #	Length	Direction/Delta	Radius	BEGIN NORTHING/EASTING	END NORHTING/EASTING
L1	126.41	S21° 35' 42.36"W		N=981778.31/E=2809710.38	N=981660.77/E=2809663.86
C1	204.95	028.92	406.00	N=981660.77/E=2809663.86	N=981459.56/E=2809638.68
L2	120.38	S07° 19' 44.07"E		N=981459.56/E=2809638.68	N=981340.16/E=2809654.03
C2	60.13	009.34	369.00	N=981340.16/E=2809654.03	N=981280.16/E=2809656.82
L3	10.92	S02° 00' 29.45"W		N=981280.16/E=2809656.82	N=981269.25/E=2809656.44

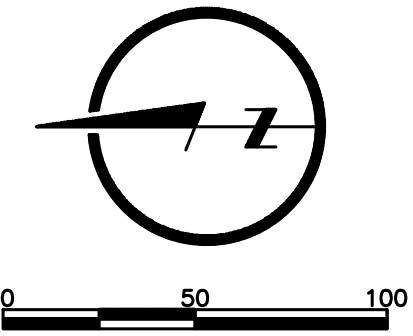


WATER LINE 3-03A

Scales: 1"=50 HOR.
1"=10 VERT.

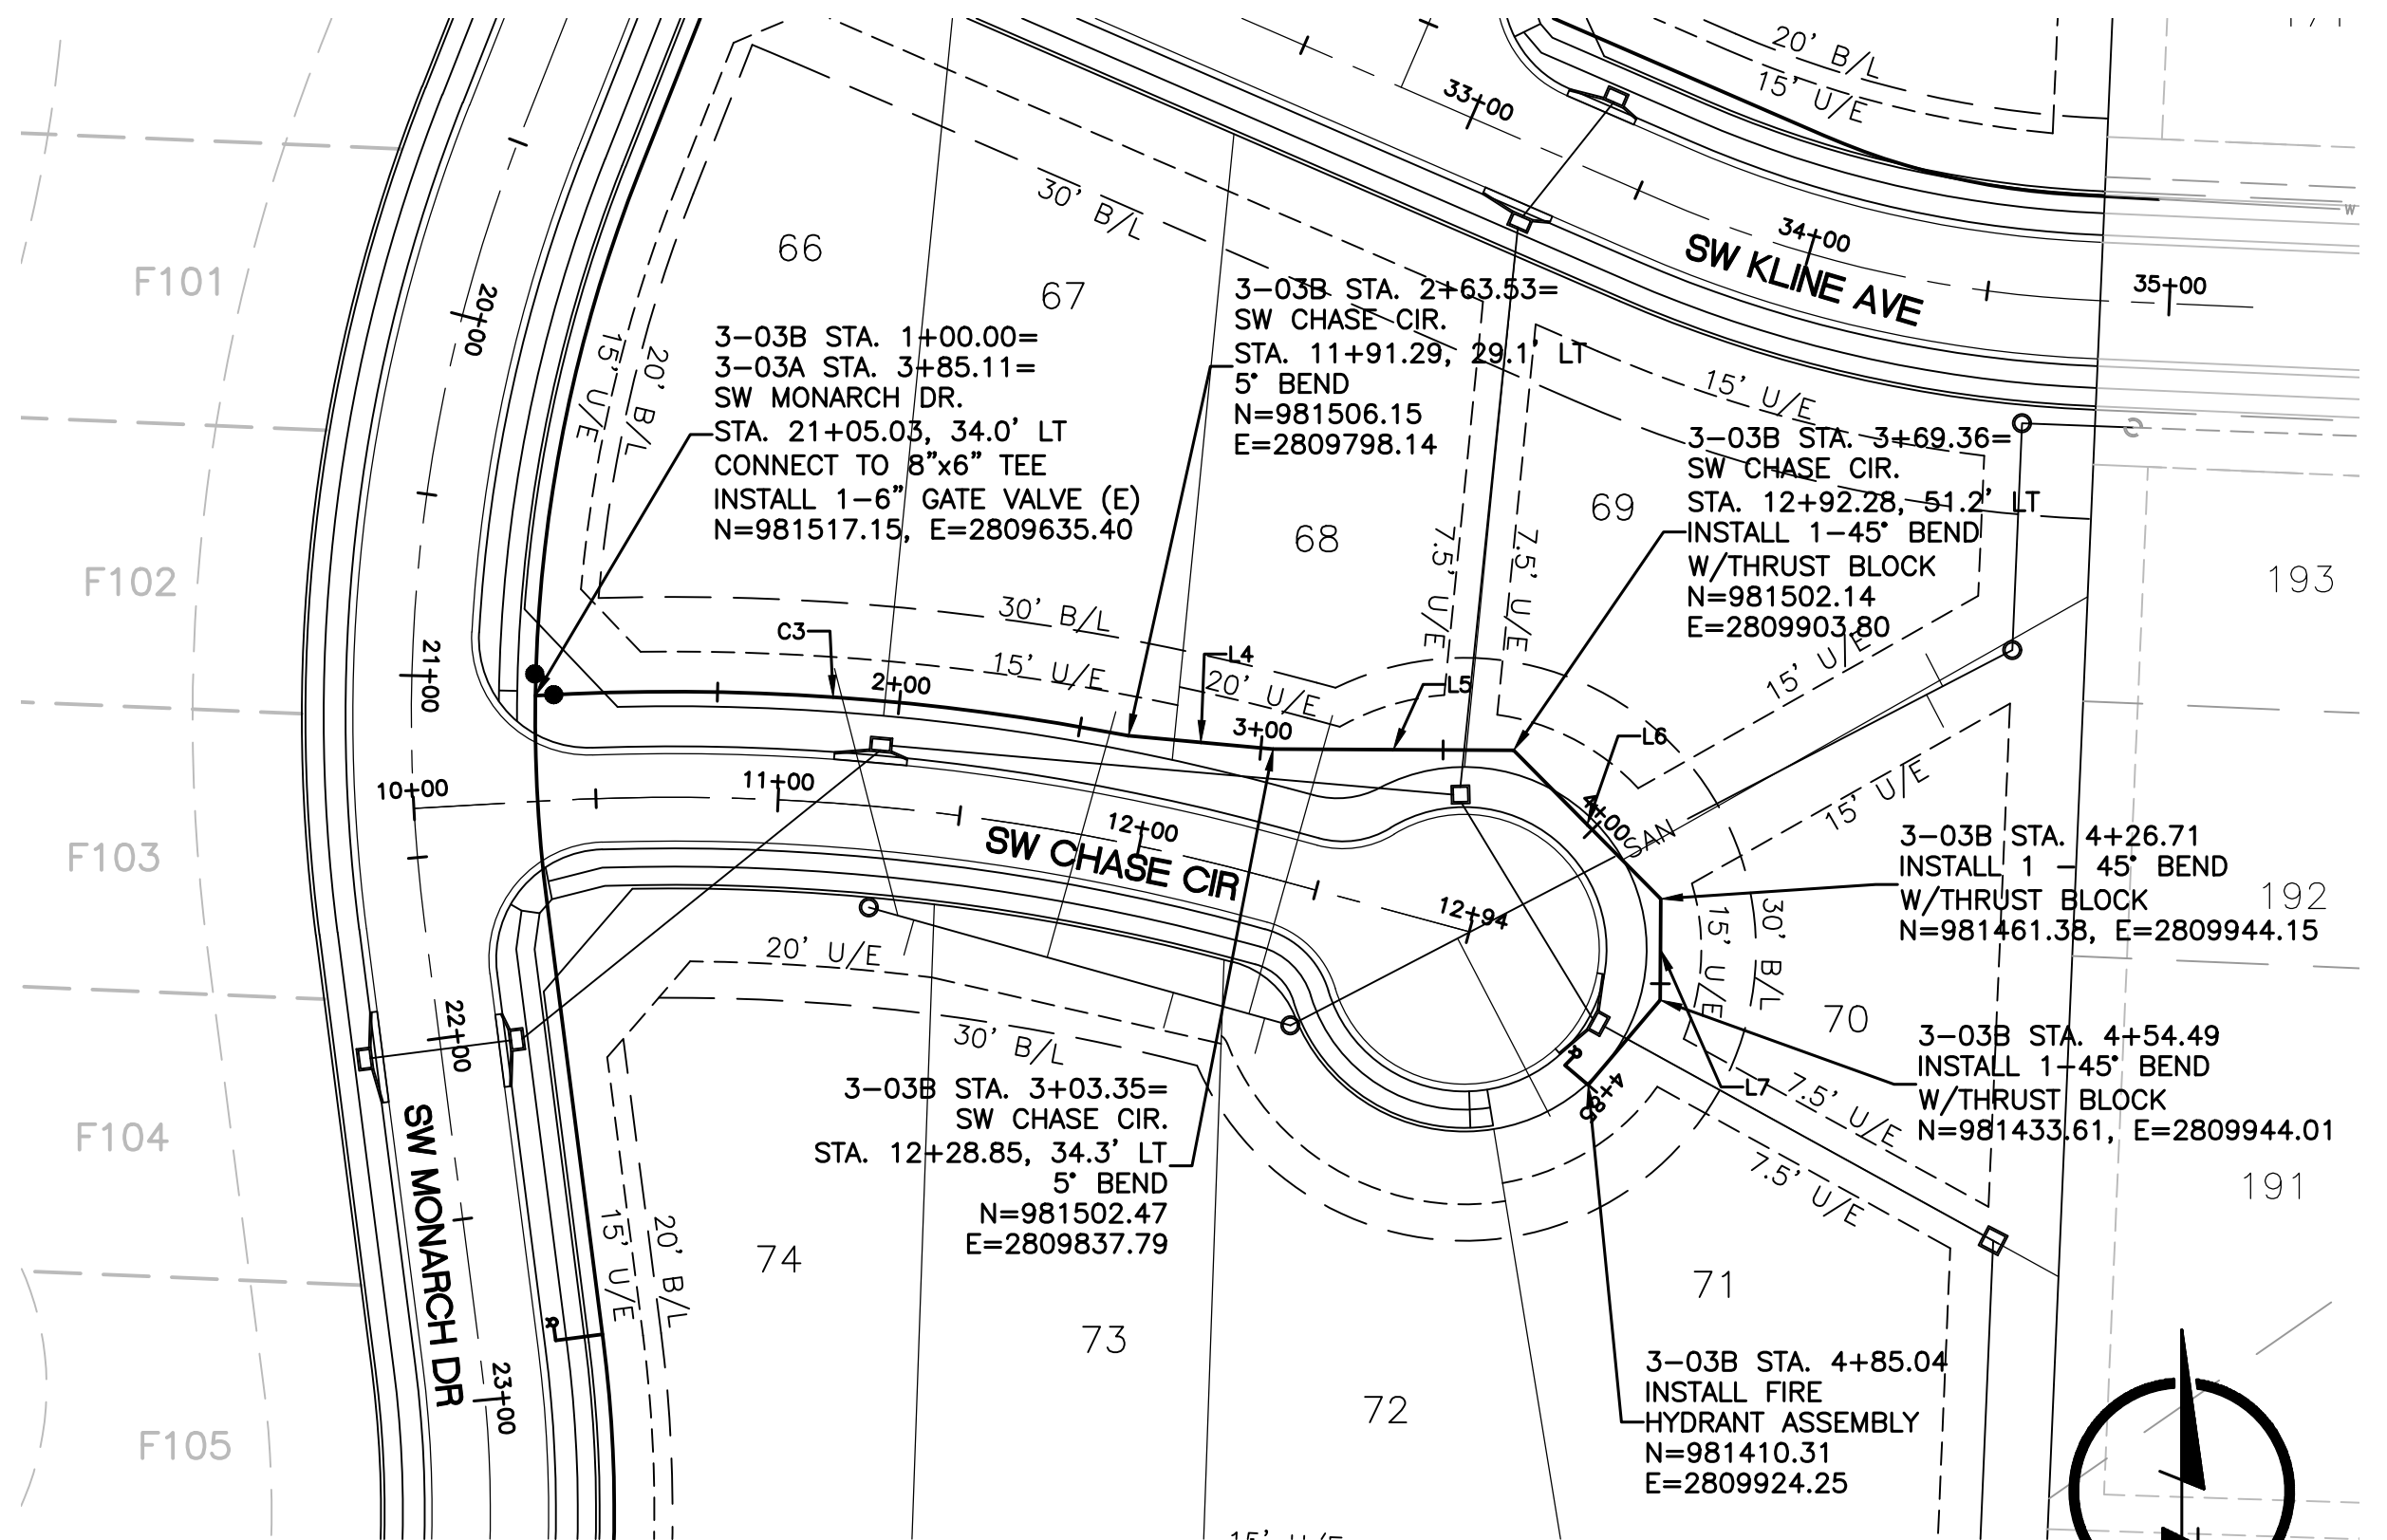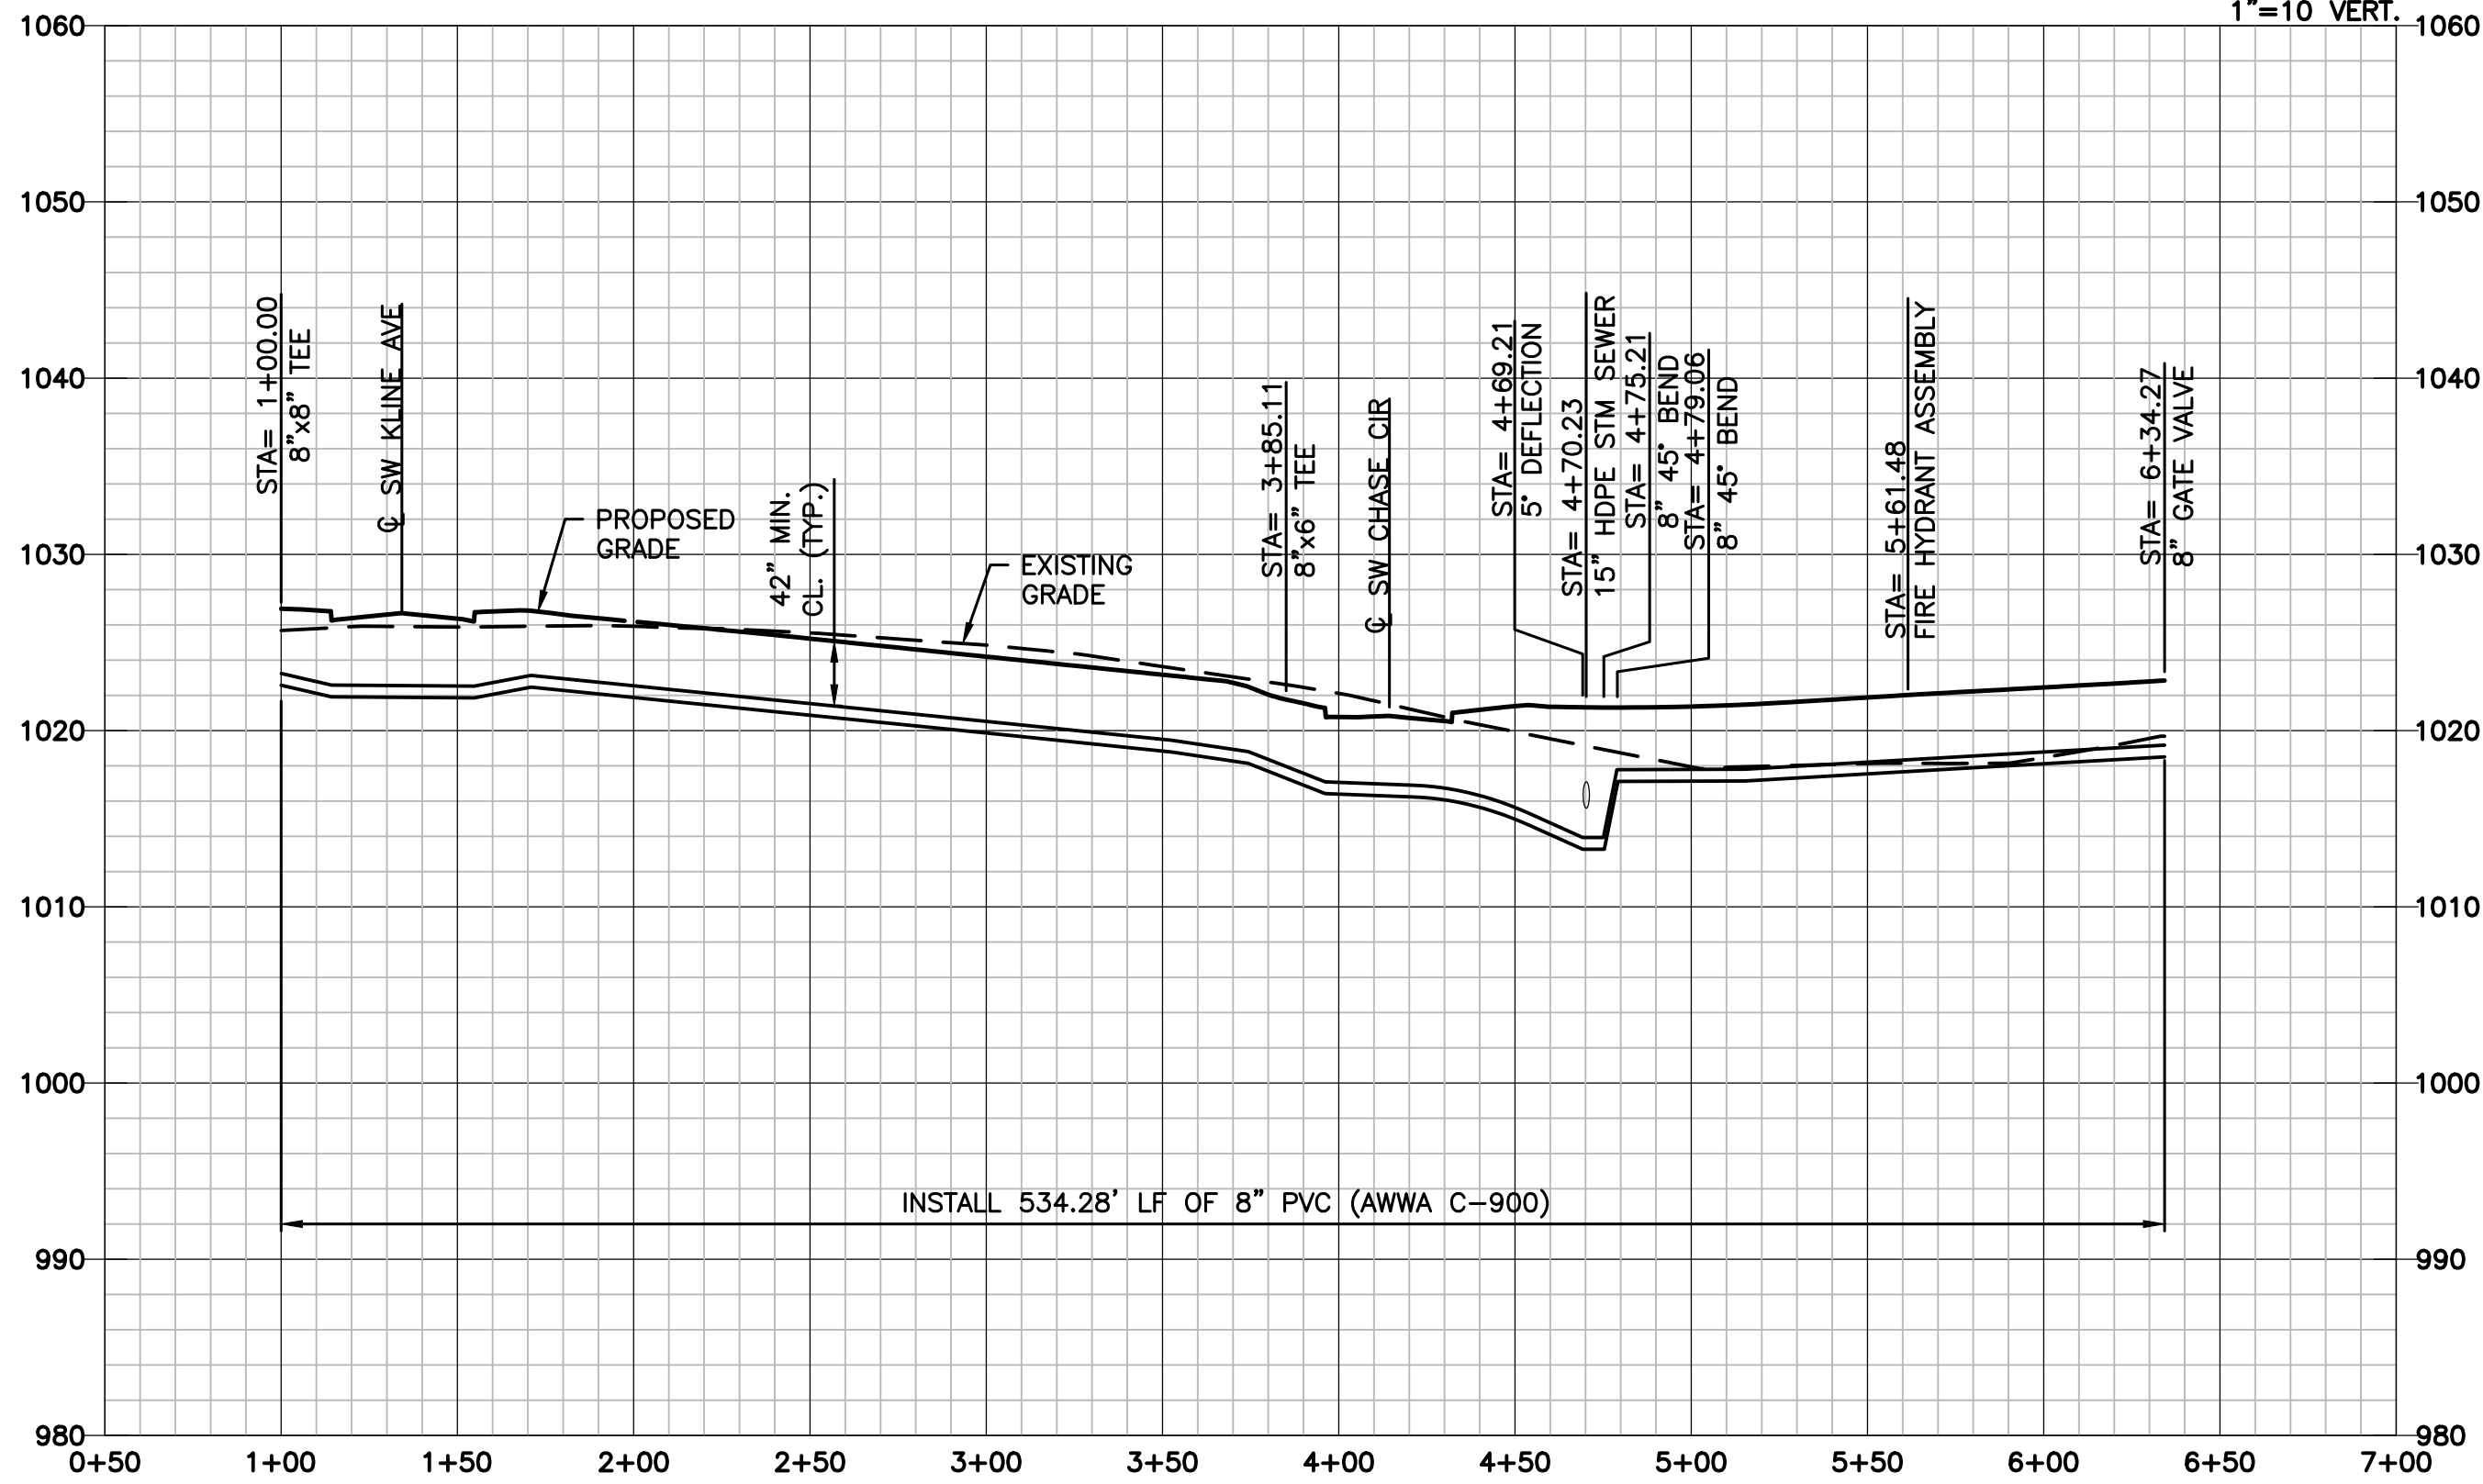


ALIGNMENT TABLE					
Line #/Curve #	Length	Direction/Delta	Radius	BEGIN NORTHING/EASTING	END NORHTING/EASTING
C3	163.53	014.28	655.91	N=981517.15/E=2809635.40	N=981506.15/E=2809798.14
L4	39.82	S84° 42' 40.38"E		N=981506.15/E=2809798.14	N=981502.47/E=2809837.79
L5	66.01	S89° 42' 40.38"E		N=981502.47/E=2809837.79	N=981502.14/E=2809903.80
L6	57.35	S44° 42' 40.38"E		N=981502.14/E=2809903.80	N=981461.38/E=2809944.15
L7	27.77	S00° 17' 19.62"W		N=981461.38/E=2809944.15	N=981433.61/E=2809944.01

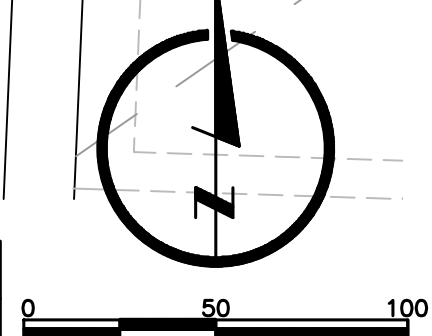

WATER LINE 3-03B

Scales: 1"=50 HOR.
1"=10 VERT.

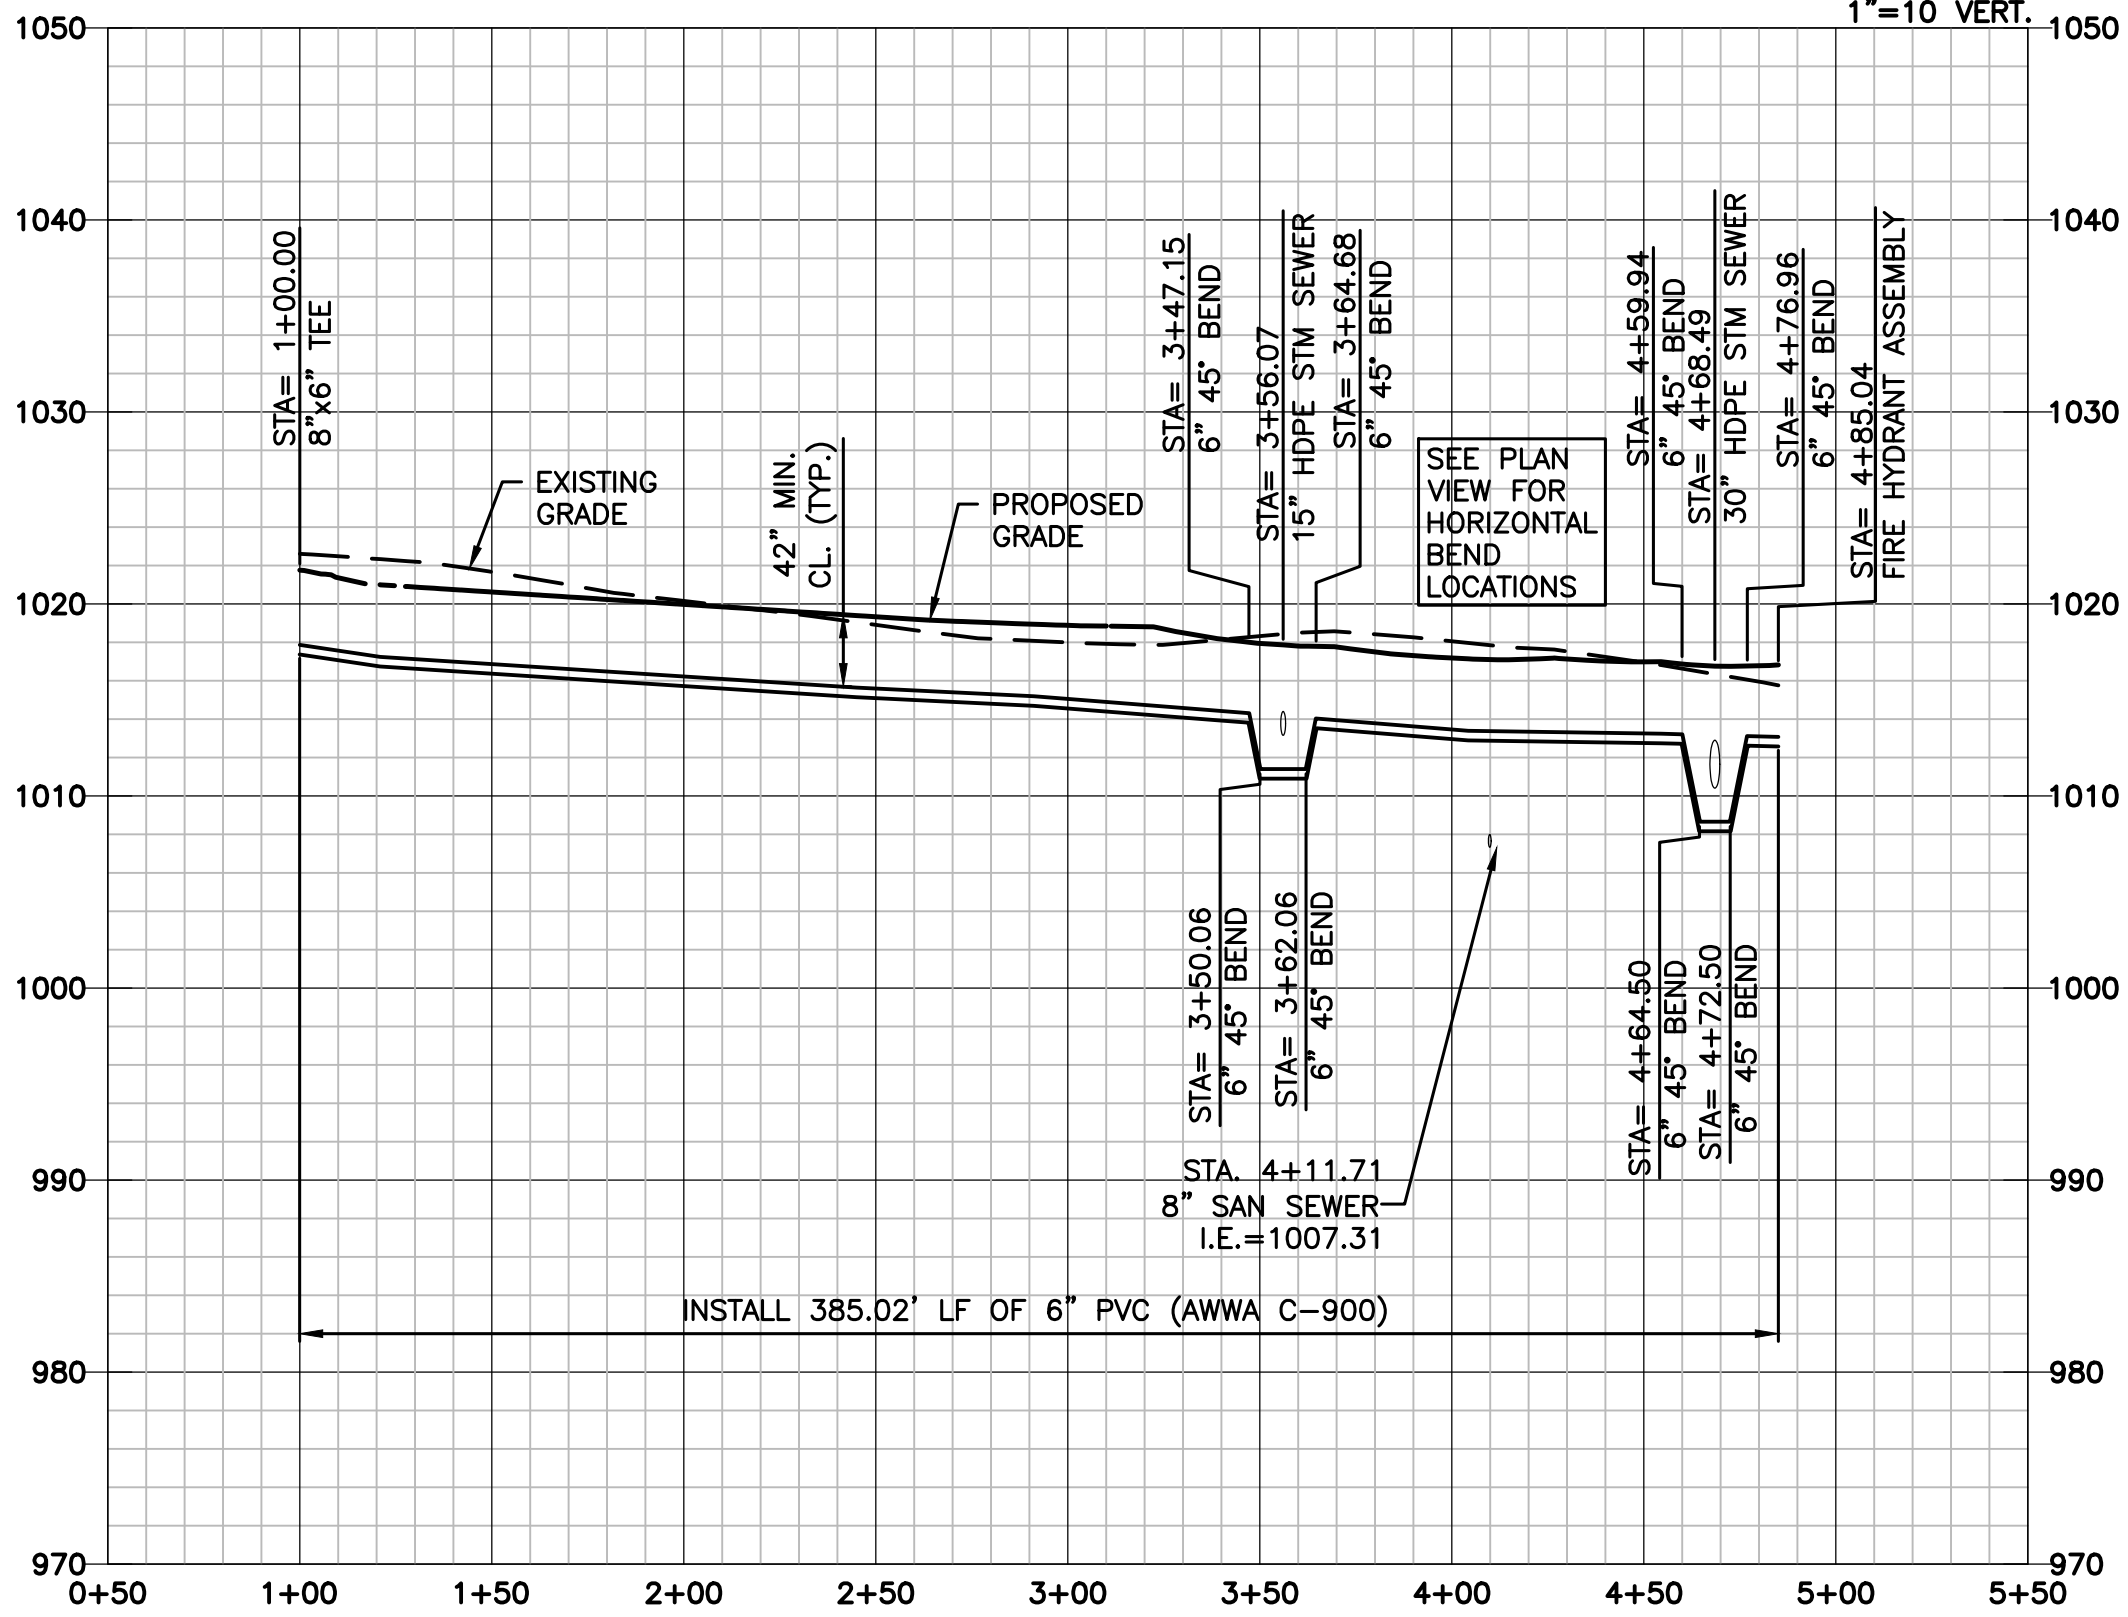

DRAWN BY
JAM

DESIGNED BY
MDM

DATE
09-19-2018

JOB NUMBER-TASKS
031850.01

BOOK AND PAGE

REVISIONS

08/19/18 - RESUBMITAL PER ADJUSTED LAYOUT
09/19/18 - RESUBMITAL PER CITY COMMENTS

9001 State Line Rd., Suite 200
Kansas City, Missouri 64114
www.LRA-inc.com

LARKIN/
LAMP RYNARSON

SUMMIT VIEW FARMS 3RD PLAT
LEES SUMMIT, MISSOURI

WATER LINE PLANS

WATER LINE PLAN AND PROFILE

WATER LINE 3-03A AND 3-03B

LARKIN LAMP RYNARSON - ENGINEERS
MIO Certificate of Authority No. 2013011803






STATE OF MISSOURI
MARK DANIEL MCGHEE JR.
REGISTERED PROFESSIONAL ENGINEER
NO. 0008019568
09-19-2018

MARK DANIEL MCGHEE JR.
PE - 2008019568

SHEET

5 OF 6

L:\Engineering\031950 SVF05 Summit View Forms 3rd Plat\DRAWINGS\CONSTRUCTION DRAWINGS\WAT-PLANS\0318050-WAT-BET.dwg, 9/19/2018 7:20:00 AM, JAMIE MCJURRY, LAMP RYNEARSON & ASSOCIATES

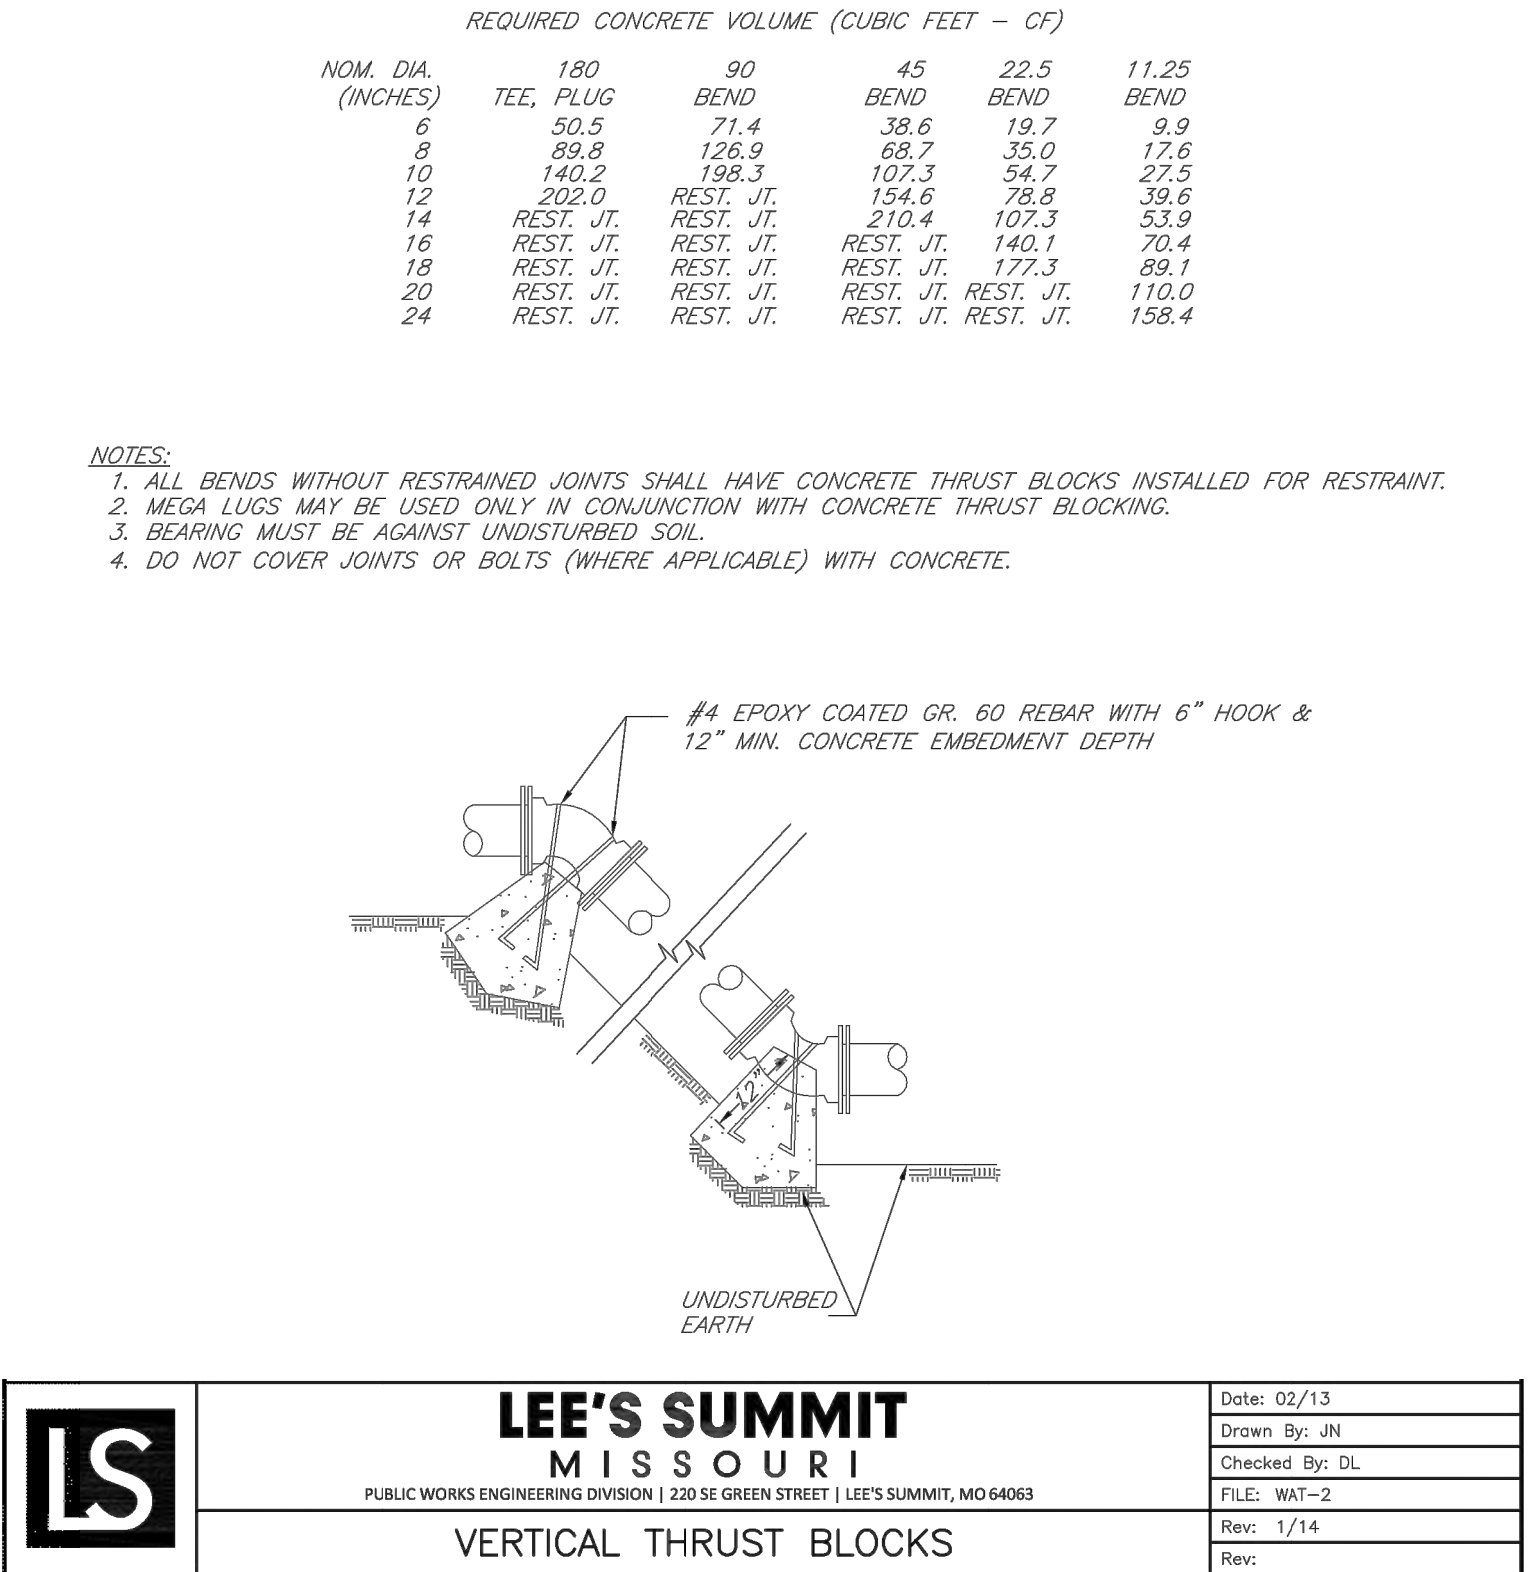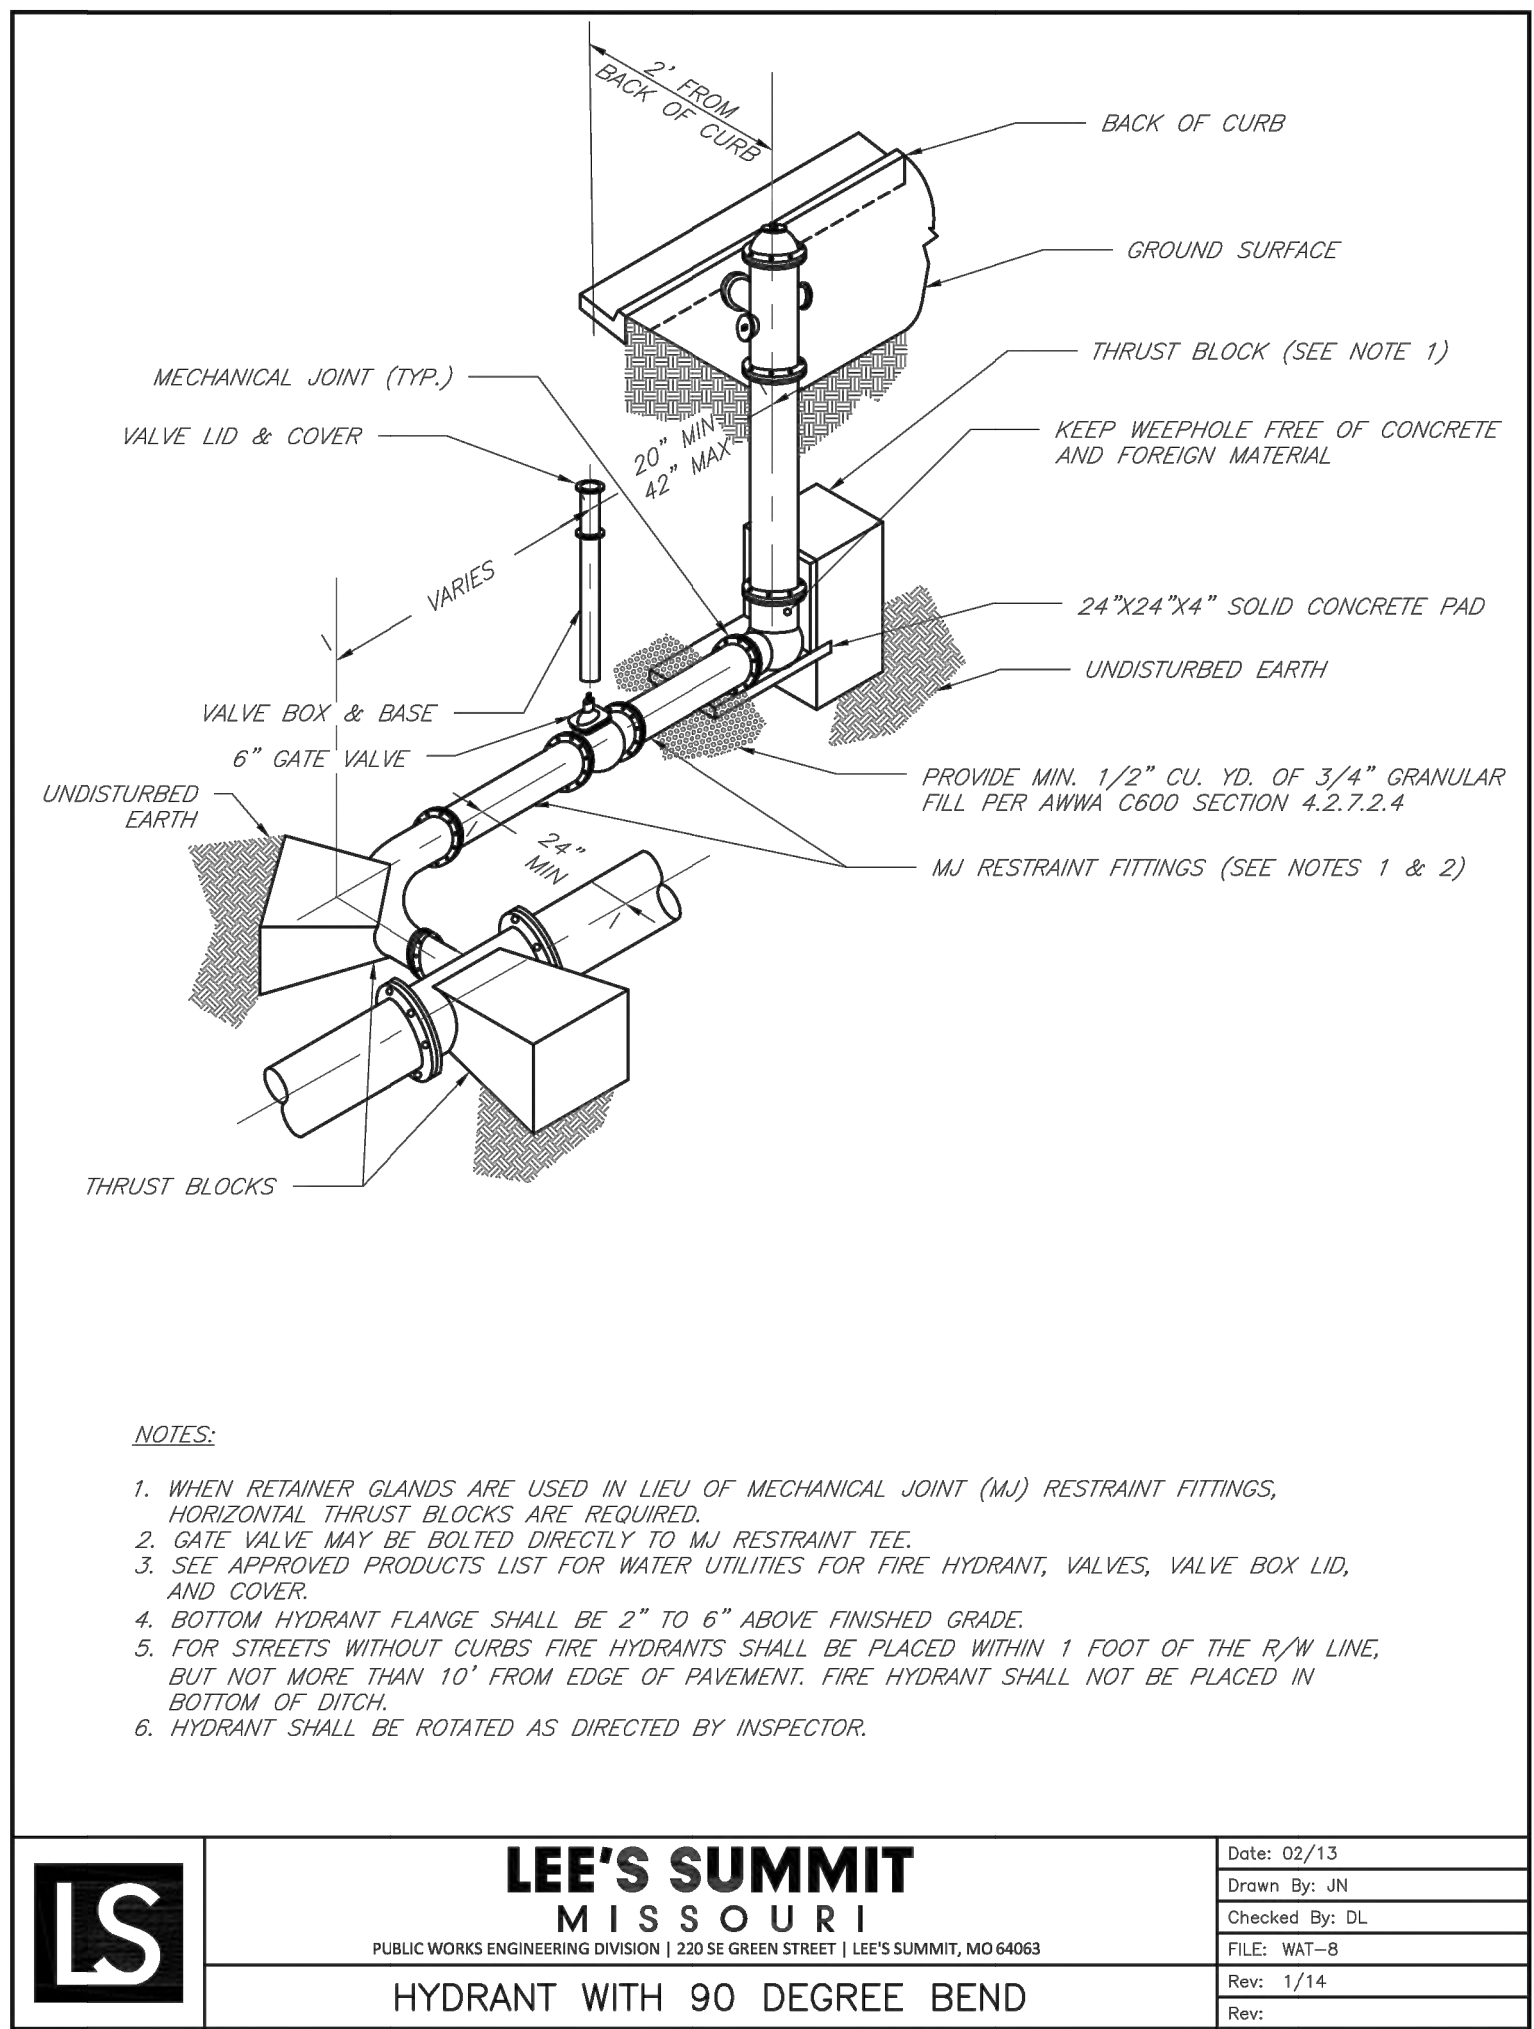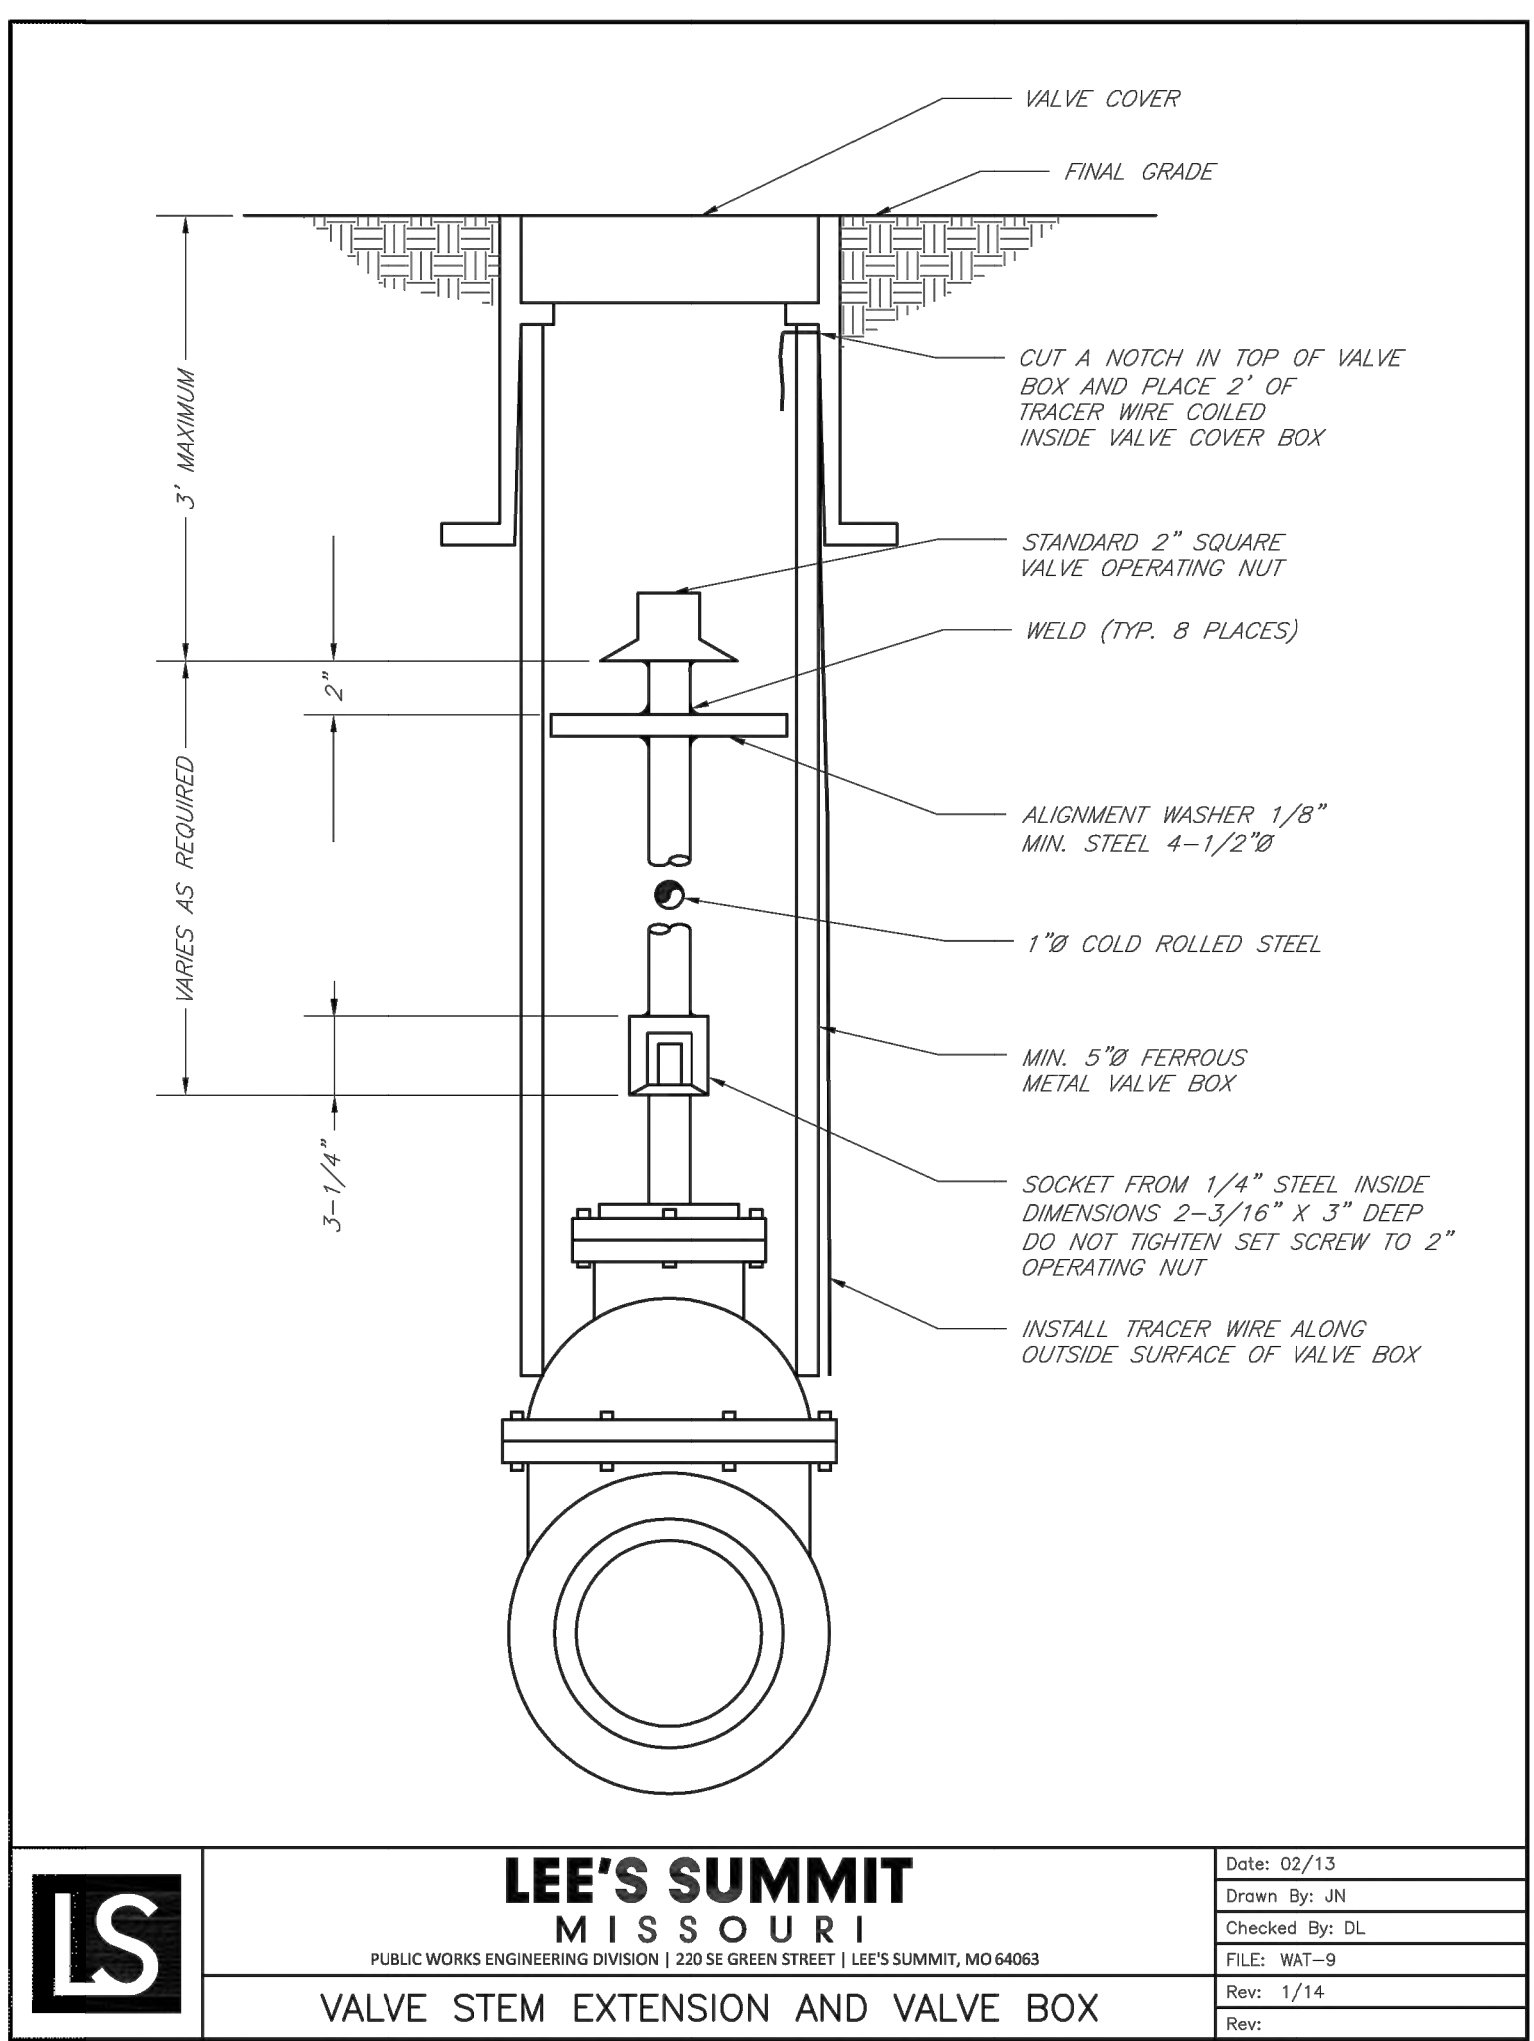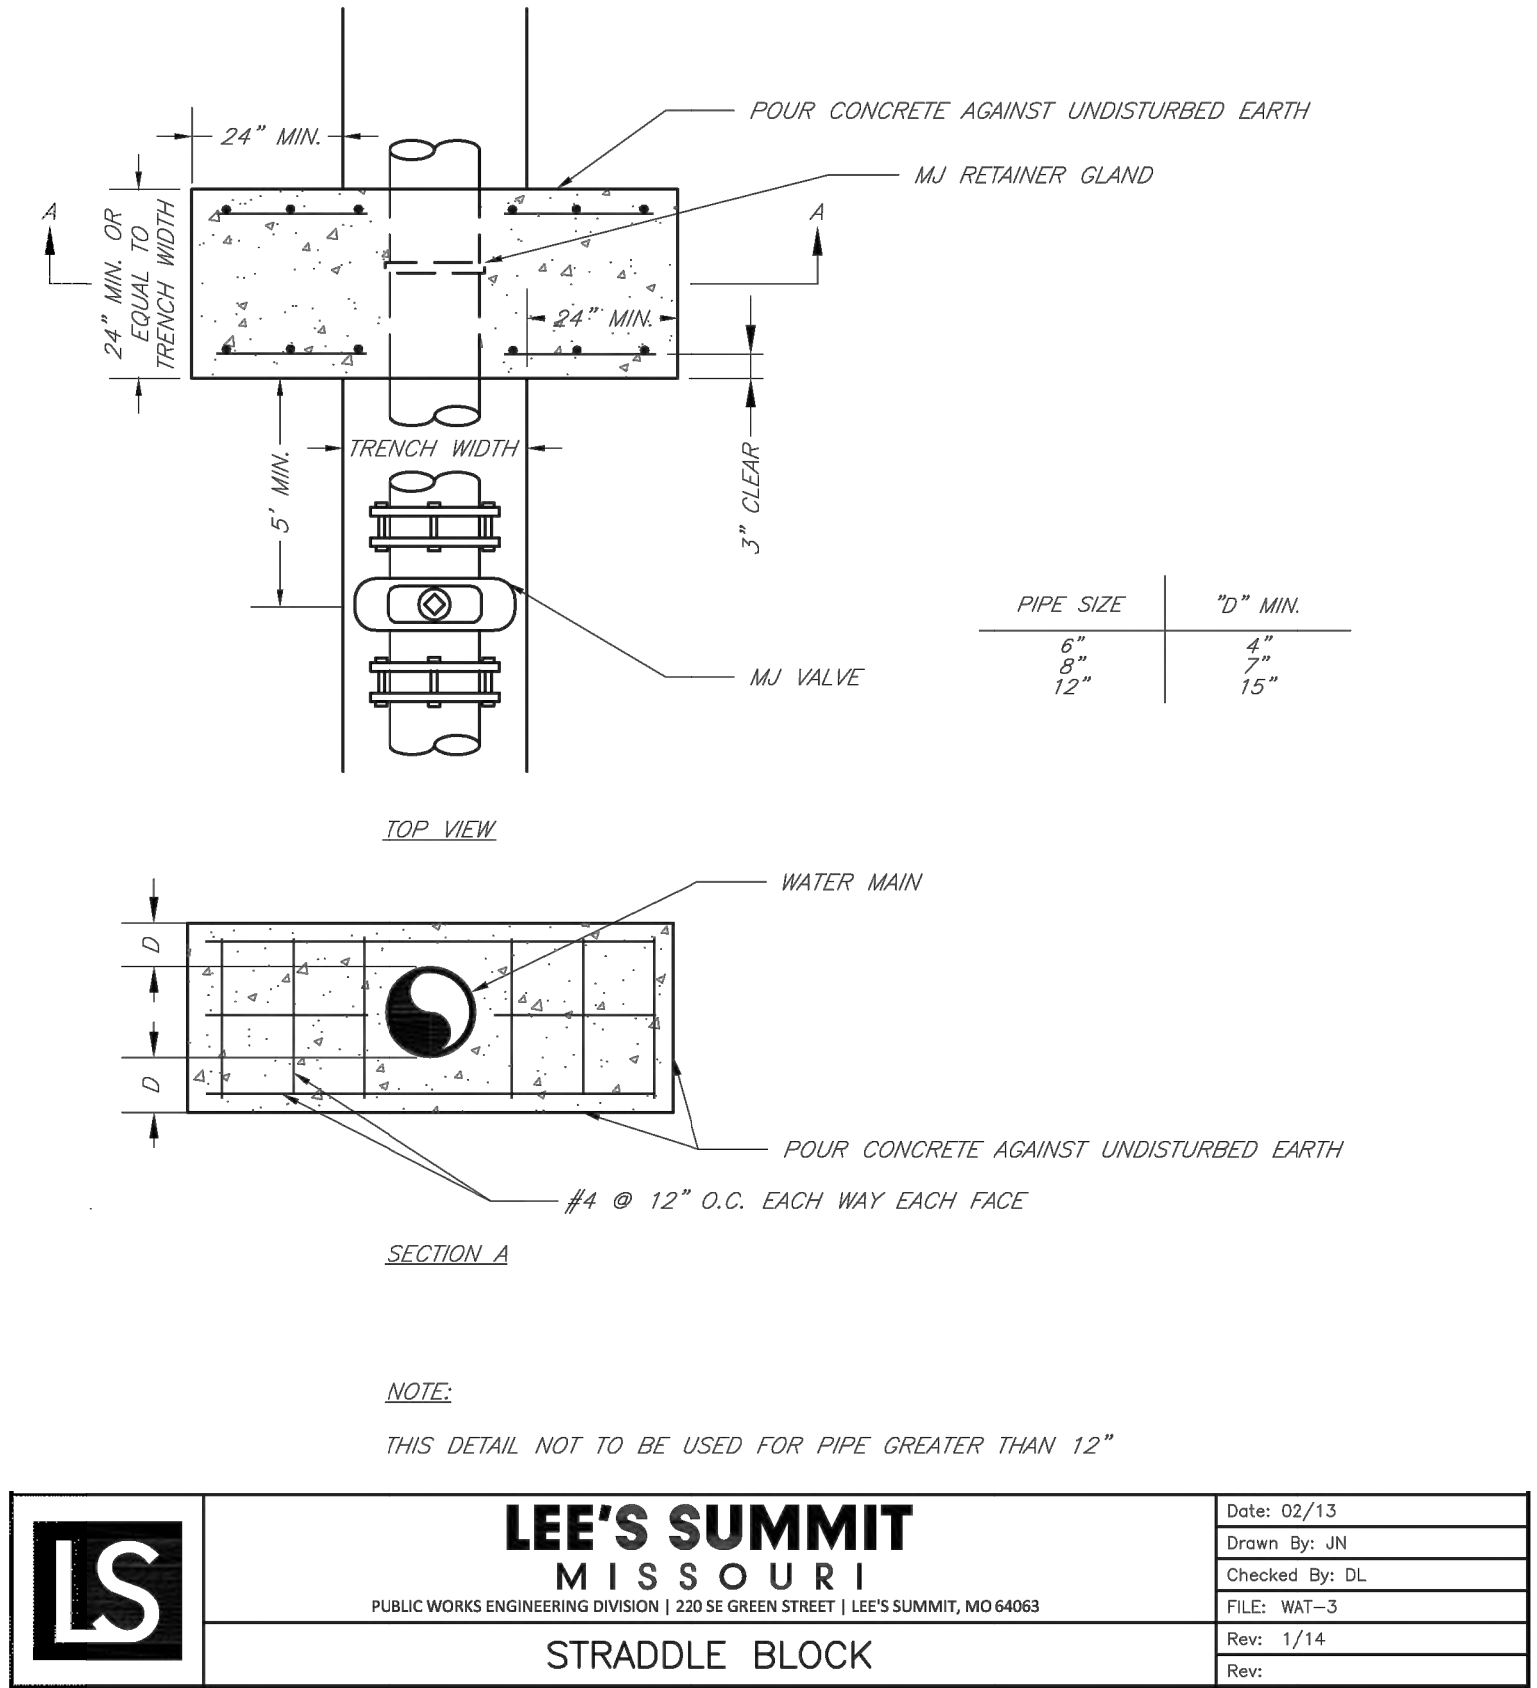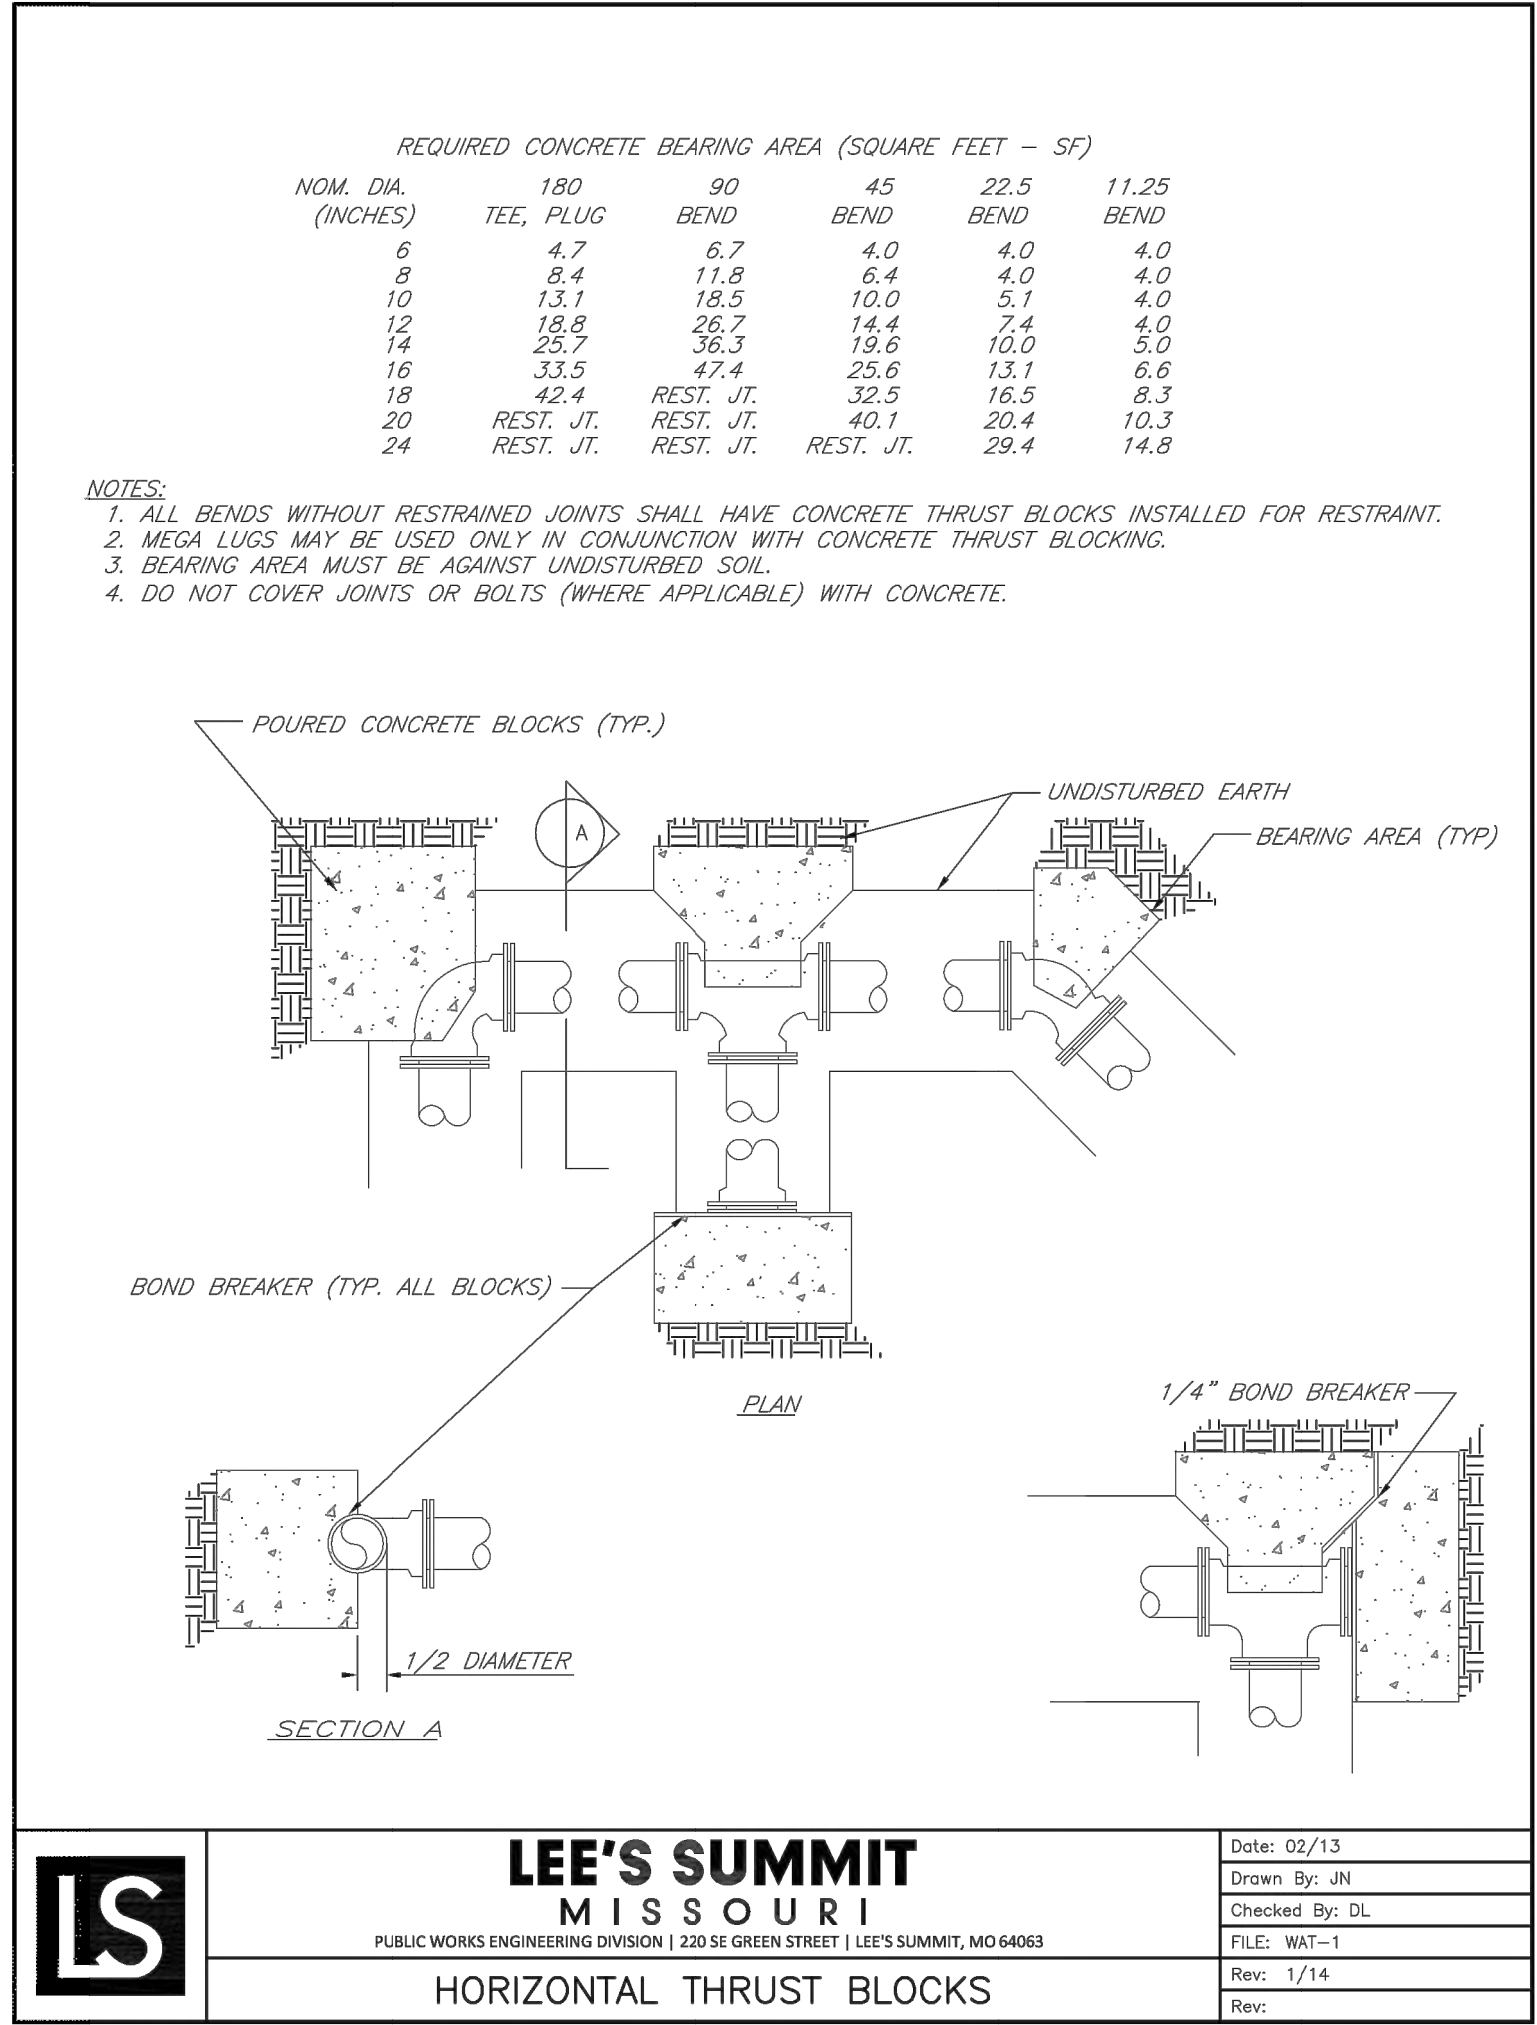

DRAWN BY		DESIGNED BY		DATE		JOB NUMBER-TASKS		BOOK AND PAGE	
JLN		MDM		09-19-2018		031950.01			
REVISIONS		RESUBMITAL PER ADJUSTED LAYOUT		RESUBMITAL PER CITY COMMENTS					
08/19/18		816.961.0440 P		816.961.0045 F					
09/19/18		9001 State Line Rd., Suite 200 Kansas City, Missouri 64114 www.LRA-INC.com							
LARKIN/		LAMP RYNEARSON							
SUMMIT VIEW FARMS 3RD PLAT		LEES SUMMIT, MISSOURI							
WATER LINE PLANS		WATER DETAILS							
LARKIN LAMP RYNEARSON - ENGINEERS		IAC Certificate of Authority No. 2013011903							
STATE OF MISSOURI		MARK DANIEL MCGHEE JR.		09-19-2018					
PE - 2008019568									
MARK DANIEL MCGHEE JR.		PE - 2008019568							
SHEET									
6		OF		6					