


KEYPLAN

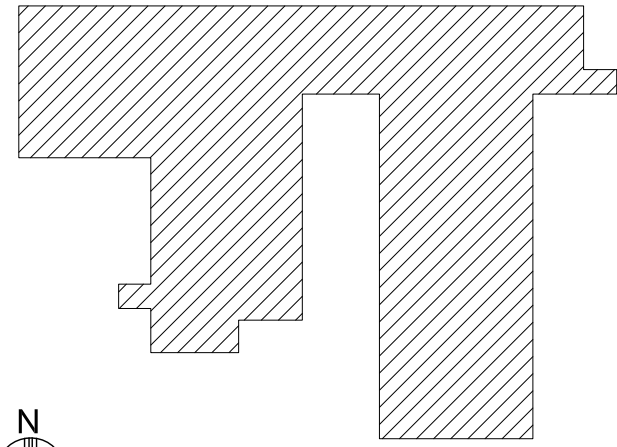

GENERAL NOTES

FDP SUBMITTAL

PROJECT TITLE



VAL 400

**SFC****S** Architecture  
Engineering  
Planning  
Interiors


SFCS Inc. • 1927 South Tryon St., Ste 207  
Charlotte, North Carolina 28203  
704.372.7327 • Fax 704.372.7369  
www.sfcs.com

PROJECT DESIGNER	:	
PROJECT ARCHITECT	:	
PROJECT ENGINEER	:	
DRAWN BY	:	
CHECKED BY	:	
APPROVED BY	:	

NO.	REVISION	DESCRIPTION	DATE

DRAWING TITLE  
**SITE PLAN**

COMM. NO. 1710600	DATE SEPTEMBER 5, 2018
DRAWING <b>A1.0</b>	SHEET ____ OF ____

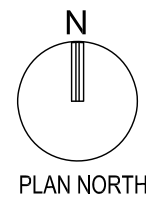

MENU


CADD VERSION
PLOT SCALE
PLOT DATE
COMM NO.
DRAWING NO.

**1 SITE PLAN**  
1/16" = 1'-0"