
 


GENERAL NOTE:
1 - ALL CONSTRUCTION SHALL CONFORM TO THE CITY OF LEE'S SUMMIT DESIGN AND CONSTRUCTION MANUAL AS ADOPTED BY ORDINANCE 5813.
2 - TRENCH CHECKS SHALL BE INSTALL AT ALL SANITARY WYES LOCATION.

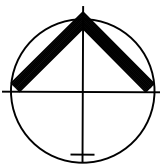


North



0 25' 50' 100'


SANITARY PLAN & PROFILE

SCALE: 1" = 50'

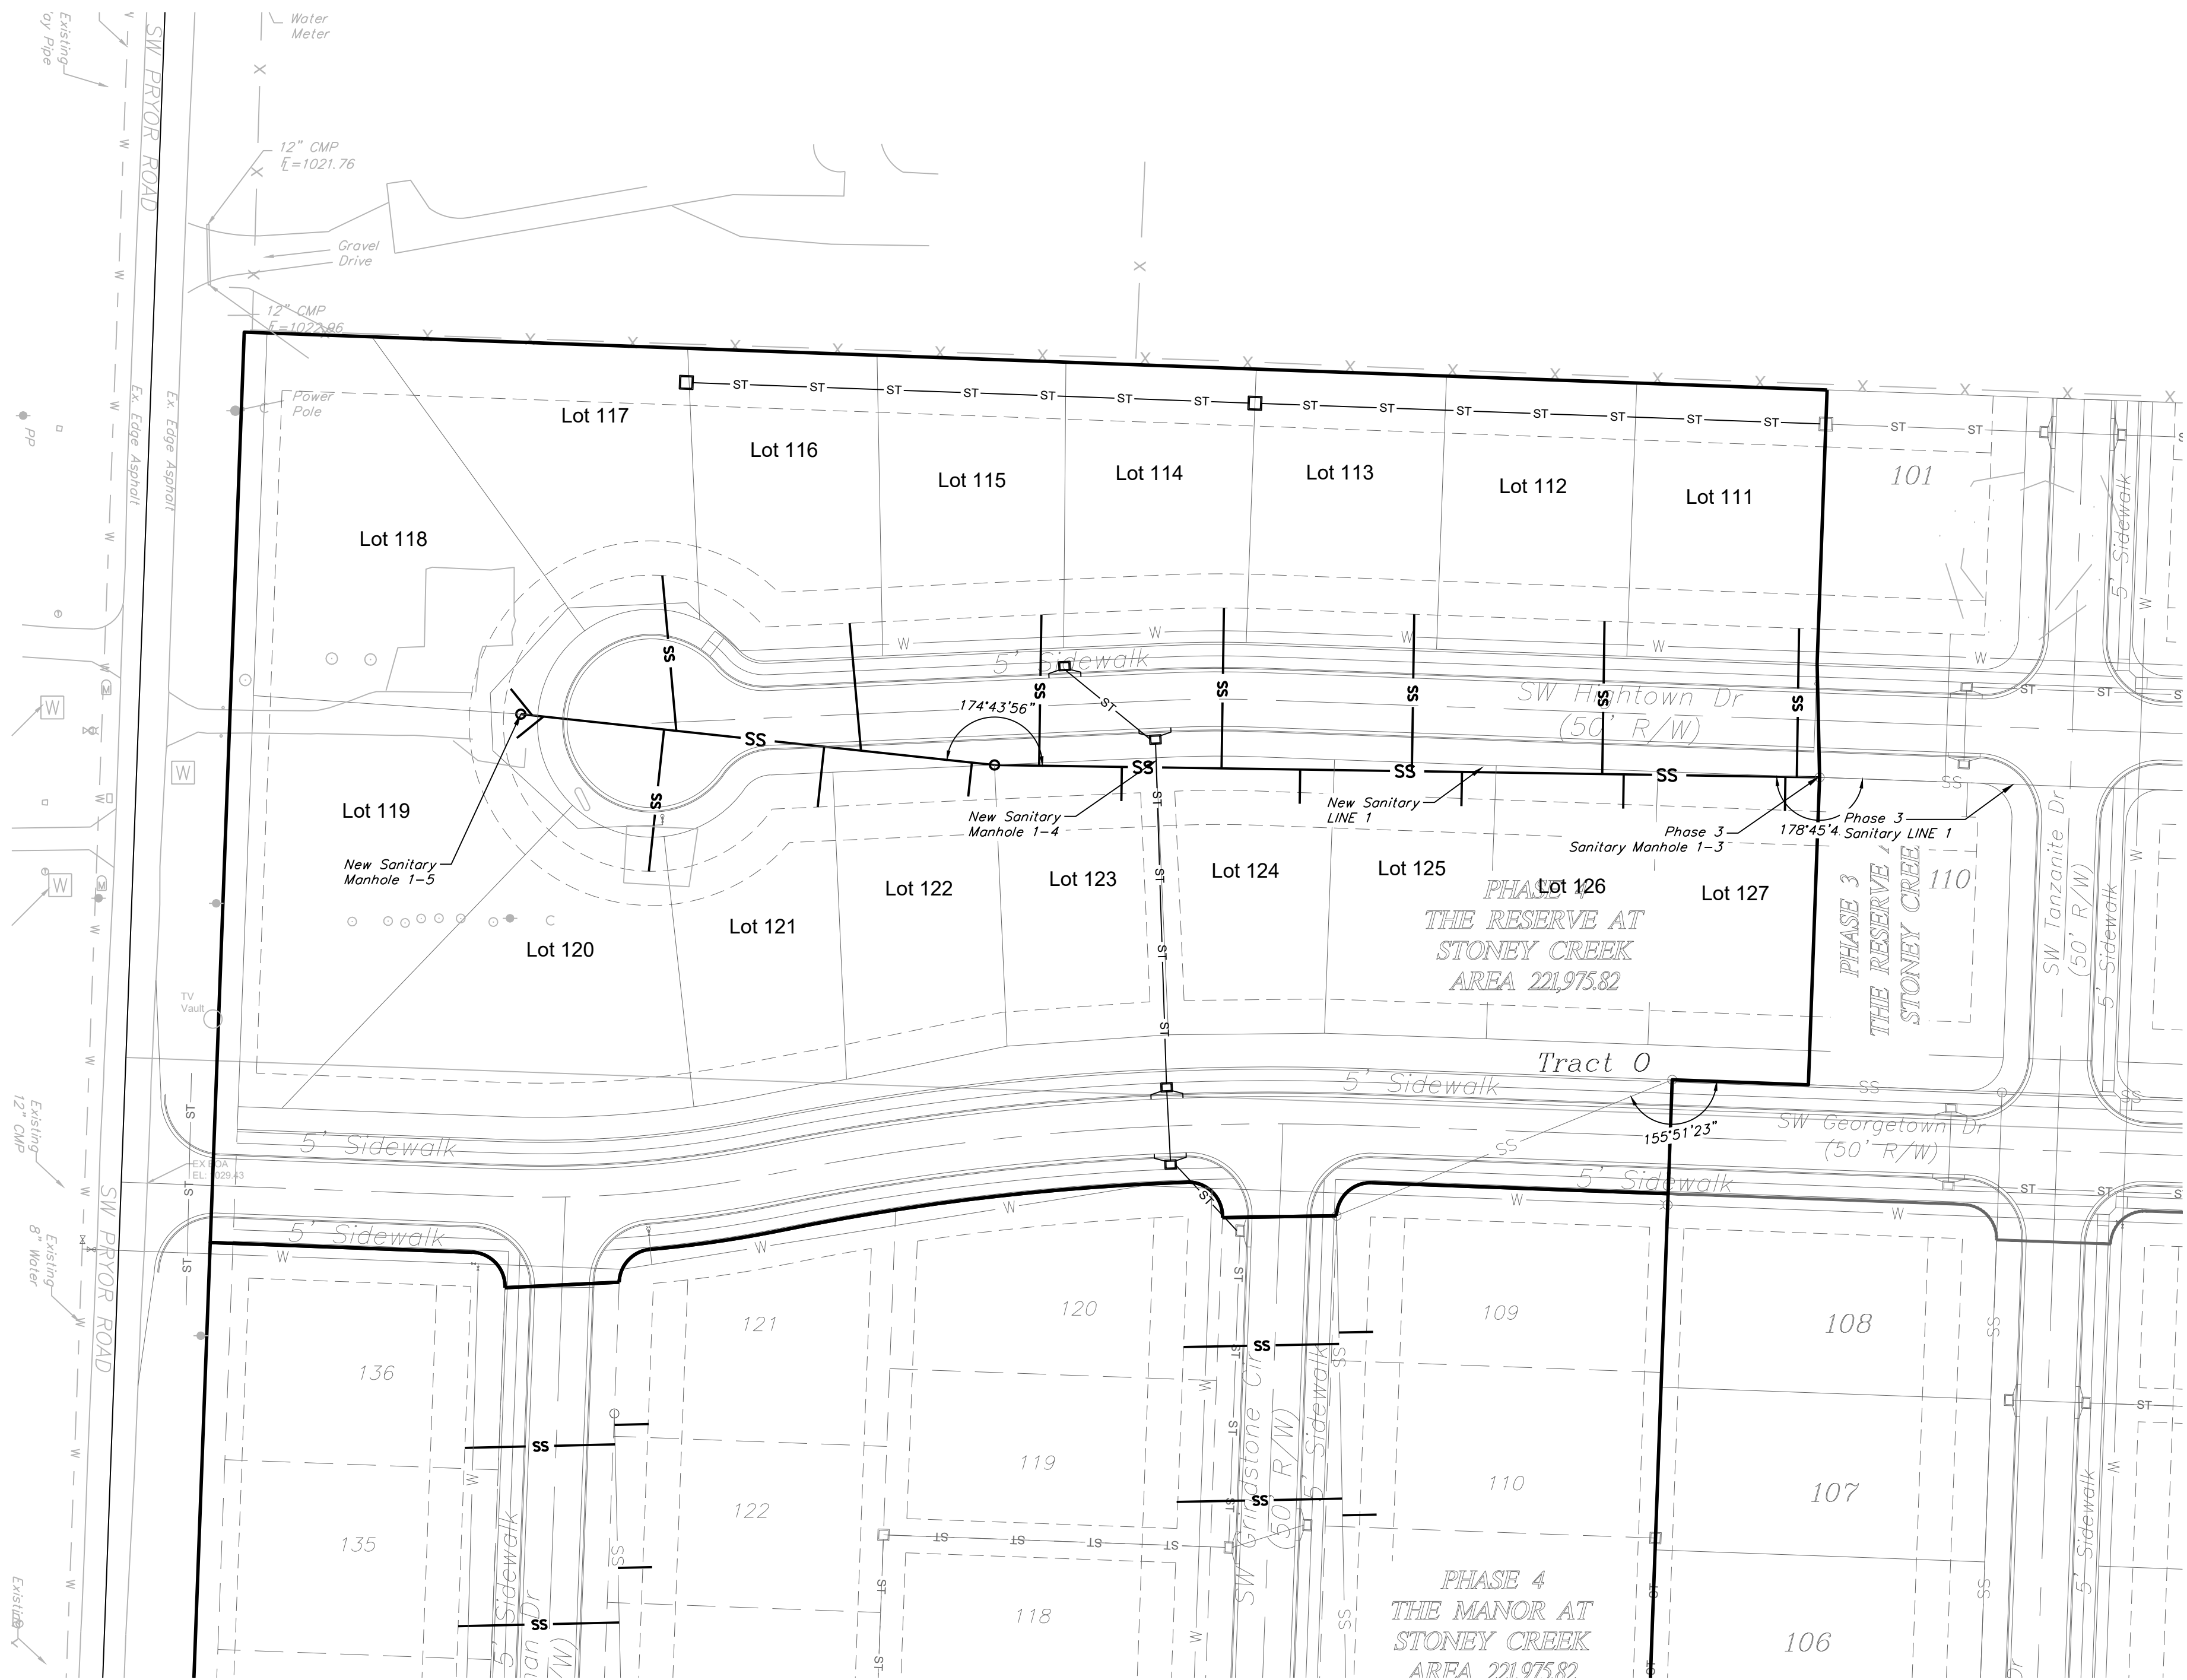

The Reserve at Stoney Creek - 4th Plat
Lee's Summit, Jackson County, Missouri

Sanitary Sewer General Layout
Construction Plans for:
The Reserve at Stoney Creek - 4th Plat
Lee's Summit, Jackson County, Missouri

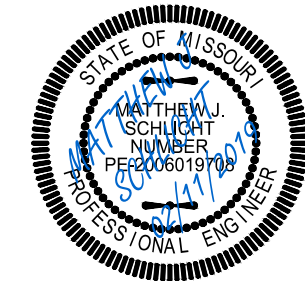

Matthew J. Schlicht
MO PE 2006019708
KS PE 19071
OK PE 25526

REVISIONS	
△	REV. 1-4-19
△	REV. 2-11-19