


SITE LIGHTING FIXTURE SCHEDULE									
TYPE	MANUFACTURER/MODEL #	LAMPS		INPUT WATTS	INPUT VA	DESCRIPTION	NOTES		
NO.	NO.	LED	VOLTS	INPUT	INPUT				
SL1	EATON (MCGRAW-EDISON) GLEON AF-05LED-480-74W-BZ MOUNT: 1 HEAD (STANDARD ARM)	-	LED	480	162	382	SINGLE HEAD POLE MOUNTED LED PARKING LOT FIXTURE WITH A FULL CUTOFF FLAT LENS, TYPE 4 WIDE DISTRIBUTION, LISTED FOR WET LOCATIONS WITH FACTORY BRONZE COLOR.		
	POLE: REFER TO DESCRIPTION, NOTES AND SPECIFICATIONS						20'-9" TALL, ROUND TAPERED STEEL OR ALUMINUM POLE WITH BASE COVER AND DRILL MOUNTINGS FOR LUMINAIRE CONFIGURATION INDICATED. POLE THICKNESS/GAUGE AS REQUIRED TO MEET COMPLETE LUMINAIRE/POLE ASSEMBLY REQUIREMENTS FOR LOCAL SITE CONDITIONS. FACTORY FINISH TO MATCH FIXTURE HEAD, SUITABLE FOR MOUNTING TO A CONCRETE BASE.		
SL2	EATON (MCGRAW-EDISON) GLEON AF-05LED-480-74W-BZ MOUNT: 2 HEADS @ 180 DEGREES (STANDARD ARM)	-	LED	480	324	364	180 DEGREE DOUBLE HEAD POLE MOUNTED LED PARKING LOT FIXTURE WITH A FULL CUTOFF FLAT LENS, TYPE 4 WIDE DISTRIBUTION, LISTED FOR WET LOCATIONS WITH FACTORY BRONZE COLOR.		
	POLE: REFER TO DESCRIPTION, NOTES AND SPECIFICATIONS						20'-9" TALL, ROUND TAPERED STEEL OR ALUMINUM POLE WITH BASE COVER AND DRILL MOUNTINGS FOR LUMINAIRE CONFIGURATION INDICATED. POLE THICKNESS/GAUGE AS REQUIRED TO MEET COMPLETE LUMINAIRE/POLE ASSEMBLY REQUIREMENTS FOR LOCAL SITE CONDITIONS. FACTORY FINISH TO MATCH FIXTURE HEAD, SUITABLE FOR MOUNTING TO A CONCRETE BASE.		
SL3	EATON (MCGRAW-EDISON) GLEON AF-05LED-480-74W-BZEA MOUNT: 3 HEADS @ 90 DEGREES (10' EXTENDED ARM)	-	LED	480	486	546	90 DEGREE TRIPLE HEAD POLE MOUNTED LED PARKING LOT FIXTURE WITH A FULL CUTOFF FLAT LENS, TYPE 4 WIDE DISTRIBUTION, LISTED FOR WET LOCATIONS WITH FACTORY BRONZE COLOR.		
	POLE: REFER TO DESCRIPTION, NOTES AND SPECIFICATIONS						20'-9" TALL, ROUND TAPERED STEEL OR ALUMINUM POLE WITH BASE COVER AND DRILL MOUNTINGS FOR LUMINAIRE CONFIGURATION INDICATED. POLE THICKNESS/GAUGE AS REQUIRED TO MEET COMPLETE LUMINAIRE/POLE ASSEMBLY REQUIREMENTS FOR LOCAL SITE CONDITIONS. FACTORY FINISH TO MATCH FIXTURE HEAD, SUITABLE FOR MOUNTING TO A CONCRETE BASE.		
GENERAL NOTES:									
A. ALL SITE LIGHTING FIXTURES, POLES AND POLE BASES SHALL BE PROVIDED BY THE BUILDING CONTRACTOR AND SPECIFIED AS PART OF THE BUILDING CONSTRUCTION DOCUMENTS. THE INFORMATION SHOWN IN THIS SCHEDULE IS FOR REFERENCE ONLY AND AS SHOWN TO SUPPLEMENT THE SITE LIGHTING PHOTOMETRIC CALCULATIONS.									
B. EQUIVALENT MET LISTED LIGHT FIXTURES MAY BE ACCEPTABLE FOR SUBSTITUTION PERKINS OWNER, TENANT AND ENGINEER APPROVAL.									
C. ALL LAMP/SAMPLES SHALL BE PROVIDED AS CLOSE AS POSSIBLE TO THE COLOR TEMPERATURE SCHEDULED ABOVE UNLESS OTHERWISE APPROVED BY OWNER, TENANT AND ENGINEER.									
D. THE QUALITY AND MAXIMUM TALL MOUNTING OF THE LIGHT FIXTURES SPECIFIED ARE DESIGNED TO COMPLY WITH LOCAL ENERGY CODE AND SHALL NOT BE INCREASED WITHOUT APPROVAL OF ENGINEER.									
E. THE SITE LIGHTING POLES SHALL MEET THE FOLLOWING MINIMUM LOADS: THE COMPLETE LIGHTING SYSTEM SHALL BE DESIGNED TO WITHSTAND WIND WITH A 13 MPH GUST. THE POLES MUST BE HIGH STRENGTH STEEL, OR ALUMINUM AND SHALL BE NON-BREAKAWAY TYPE. EACH STANDARD SHALL BE PROTECTED AGAINST LIGHTNING WITH AN INTERCONNECTED GROUND ROD AND BONDED PER THE NEC AND LOCAL REQUIREMENTS. POLE HEIGHTS SHALL BE FACTORY PROVIDED TO THE LENGTHS LISTED IN THE ABOVE DESCRIPTION TO ACHIEVE DESIRED HEAD MOUNTING HEIGHT.									
F. ALL POLES SHALL BE FACTORY FURNISHED WITH VIBRATION DAMPERS, UNO.									
NOTES:									
1. NOT USED									

GENERAL NOTES:

- A. ALL SITE LIGHTING FIXTURES, POLES AND POLE BASES SHALL BE PROVIDED BY THE BUILDING CONTRACTOR AND SPECIFIED AS PART OF THE BUILDING CONSTRUCTION DOCUMENTS. THE INFORMATION PROVIDED IN THIS SCHEDULE IS FOR REFERENCE ONLY AND AS SHOWN TO SUPPLEMENT THE SITE LIGHTING PHOTOMETRIC CALCULATIONS.
- B. EQUIVALENT NRTL LISTED LIGHT FIXTURES MAY BE ACCEPTABLE FOR SUBSTITUTION PENDING OWNER, TENANT AND ENGINEER APPROVAL.
- C. ALL LAMP/SLIDES SHALL BE PROVIDED AS CLOSE AS POSSIBLE TO THE COLOR TEMPERATURE SCHEDULED ABOVE UNLESS OTHERWISE APPROVED BY OWNER, TENANT AND ENGINEER.
- D. THE QUANTITY AND MAXIMUM RATED WATTAGE OF THE LIGHT FIXTURES SPECIFIED ARE DESIGNED TO COMPLY WITH LOCAL ENERGY CODE AND SHALL NOT BE INCREASED WITHOUT APPROVAL OF ENGINEER.
- E. THE SITE LIGHTING POLES SHALL MEET THE FOLLOWING MINIMUM STANDARD: THE COMPLETE LIGHTING STANDARD AND FOOTING SHALL BE DESIGNED TO WITHSTAND 100MPH WINDS WITH A 1.3 MPH GUST FACTOR. ALL POLES MUST BE PROTECTED AGAINST LIGHTNING BY AN INTERCONNECTED GROUND ROD AND BONDING PER THE NEC AND LOCAL REQUIREMENTS. POLE HEIGHTS SHALL BE FACTORY PROVIDED TO THE LENGTH LISTED IN THE ABOVE DESCRIPTION TO ACHIEVE DESIRED HEAD MOUNTING HEIGHT.
- F. ALL POLES SHALL BE FACTORY FURNISHED WITH VIBRATION DAMPENERS, UNO.

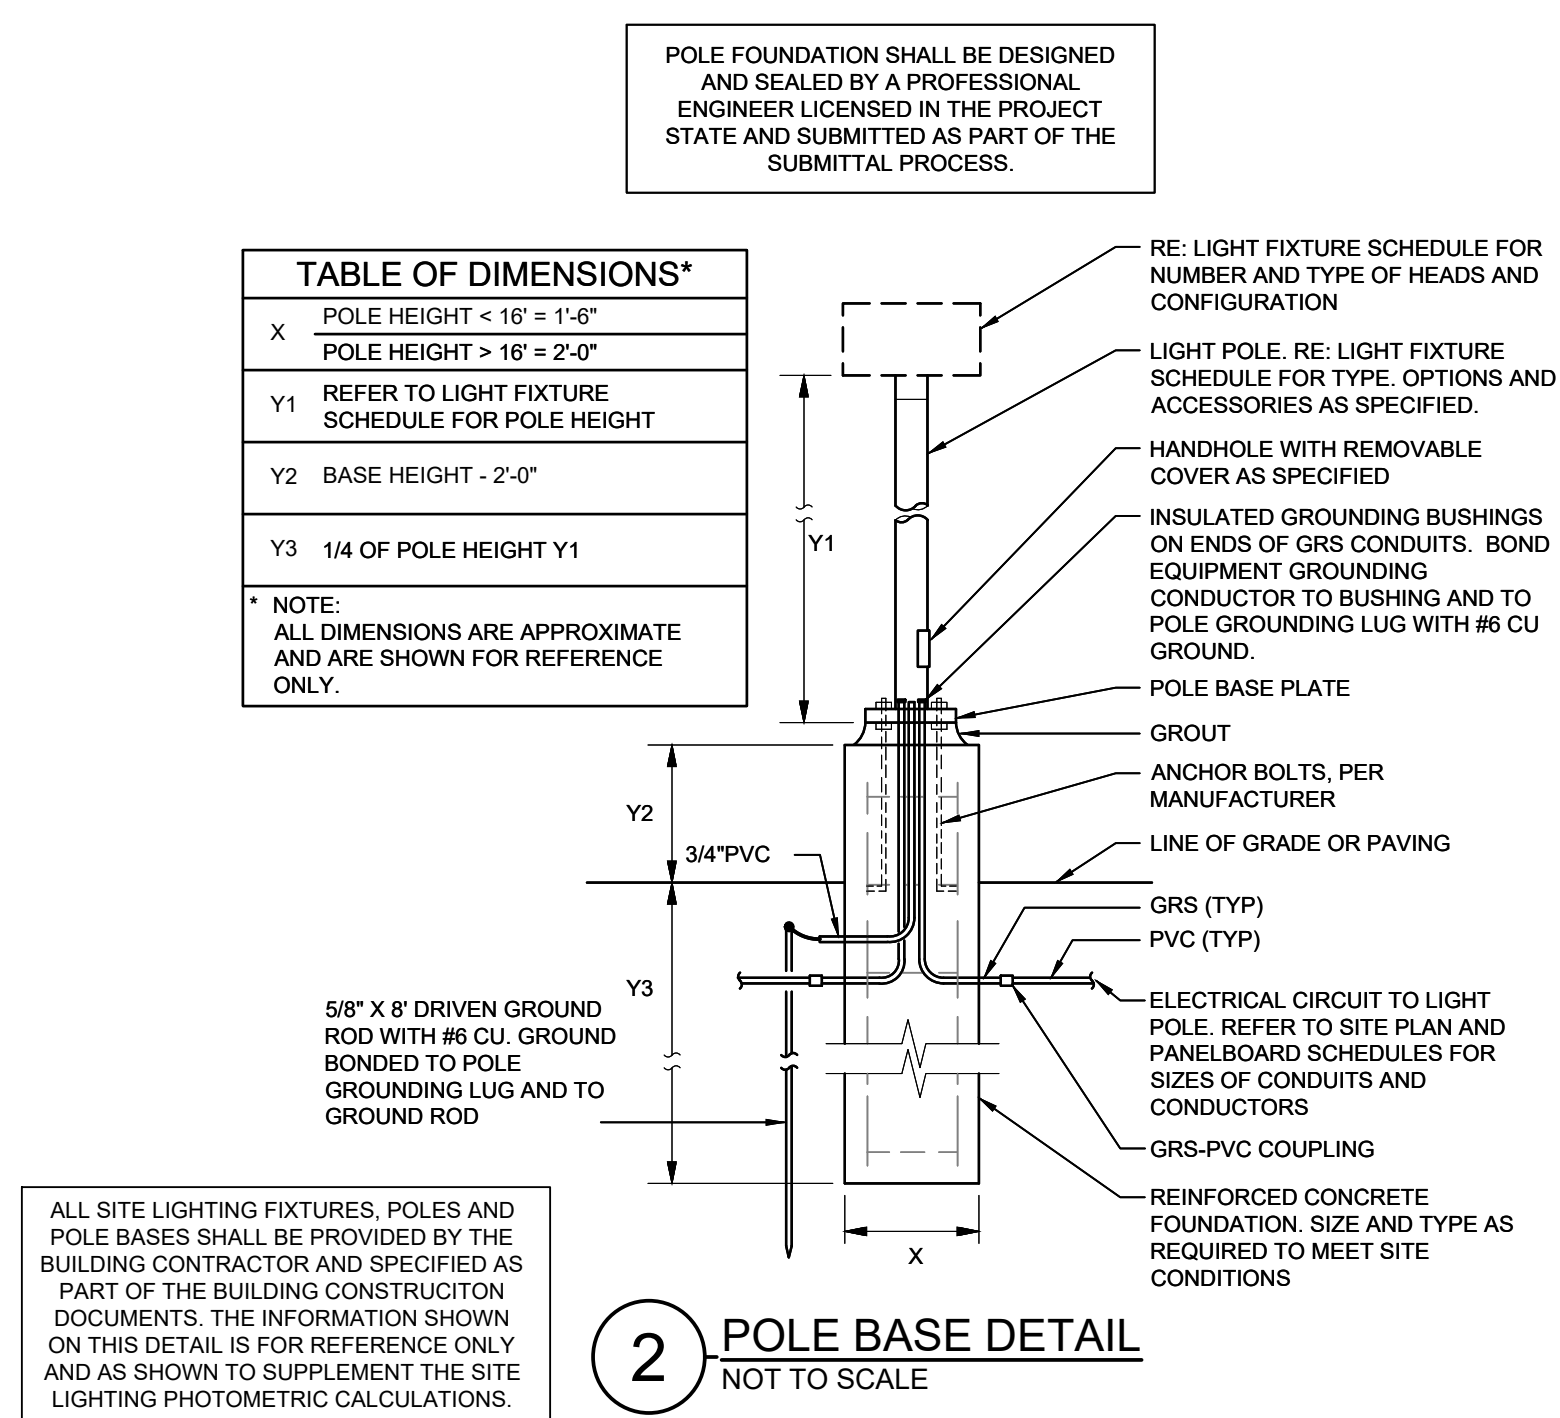

SITE LIGHTING GENERAL NOTES:

1. REFER TO BUILDING CONSTRUCTION DOCUMENTS FOR LIGHT FIXTURE AND POLE TYPES, CIRCUITING AND RELATED INFORMATION. COORDINATE WITH ELECTRICAL AND MECHANICAL ALL SITE LIGHTING POLES WITH OTHER TRADES PRIOR TO INSTALLATION.
2. THE SITE LIGHTING IS DESIGNED TO MEET THE FOLLOWING CRITERIA AND REQUIREMENTS:
 - a. MEET ALL CITY AND STATE CONSTRAINTS, LANDSCAPING AND LOCAL REQUIREMENTS.
 - b. MINIMUM MAINTAINED HORIZONTAL ILLUMINATION LEVEL AT FINISHED GRADE SHALL BE AT ALL ADJACENT SIDEWALKS AND DRIVE SURFACES.
 - c. AVERAGE MAINTAINED HORIZONTAL ILLUMINATION LEVEL AT FINISHED GRADE OF 8 FC AT FRONT FRIEZE.
 - d. MAINTAINED HORIZONTAL ILLUMINATION LEVEL AT FINISHED GRADE OF 7 FC AT TRUCKWELL.
 - e. MAINTAINED HORIZONTAL ILLUMINATION LEVEL AT FINISHED GRADE OF 5 FC AT MAIN PARKING AREAS.
 - f. MAINTAINED HORIZONTAL ILLUMINATION LEVEL AT FINISHED GRADE OF 5 FC AT OTHER AREAS.
 - g. MAXIMUM RATIO FOR EACH AREA SHALL BE LESS THAN 20:1.
3. THE TOTAL LIGHT LOSS FACTOR SHALL USED FOR THE CALCULATIONS SHALL BE 1.50 AND NOT LESS THAN 1.00.


HENDERSON
ENGINEERS
8345 LENEXA DRIVE, SUITE 300
LENEXA, KS 66214
TEL 913.742.5000/FAX 913.742.5001
WWW.HENDERSONENGINEERS.COM
18500011330
MO. CORPORATE NUMBER: E-556D
EXPIRES 12/31/20

DEAN W. CHANDLER
LICENSE # PE-2017036652

NOTE:
ALL SUBCONTRACTORS SHALL BE
RESPONSIBLE FOR REVIEWING ALL
DRAWINGS IN THE SET PRIOR TO
PLACING BID.

A New Store for:
McKeever's Market & Eatery #950

NW Pryor Road
Lee's Summit, Missouri
© J. Price Architecture, Inc. 2019 All Rights Reserved

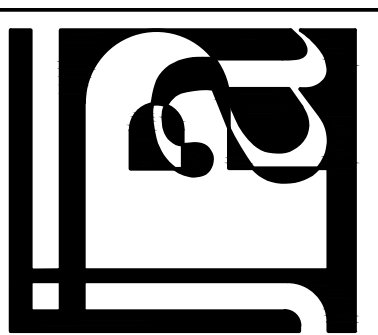

REVISIONS:

SITE LIGHTING
PHOTOMETRIC PLAN

PROJECT: 17-001	DATE: APRIL 30, 2019
--------------------	-------------------------

SHEET NUMBER:
E1.3