


PARKING LOT LIGHTING FIXTURE SCHEDULE												
NOTES:												
1.	FIXTURE SHALL BE RATED FOR OUTDOOR USE.											
2.	PROVIDE 20' SQUARE POLE.											
TYPE MARK	MANUFACTURER	MODEL NUMBER	DRIVER	FINISH	VOLTAGE	LAMP TYPE	LAMP QTY	COLOR TEMP	TOTAL WATTAGE	NOTES	EQUIVALENTS	
PL01	SIGNIFY	ECF-S-32L-1.2A-NW-G2-AR-2-208-HIS-MGY	STD	MEDIUM GRAY	208	LED		4000	122	1,2		
PL03	SIGNIFY	ECF-S-48L-1.2A-NW-G2-AR-3-208-HIS-MGY	STD	MEDIUM GRAY	208	LED		4000	183	1,2		
PL04	SIGNIFY	ECF-S-48L-1.2A-NW-GR-AR-4-208-HIS-MGY	STD	MEDIUM GRAY	208	LED		4000	183	1,2		

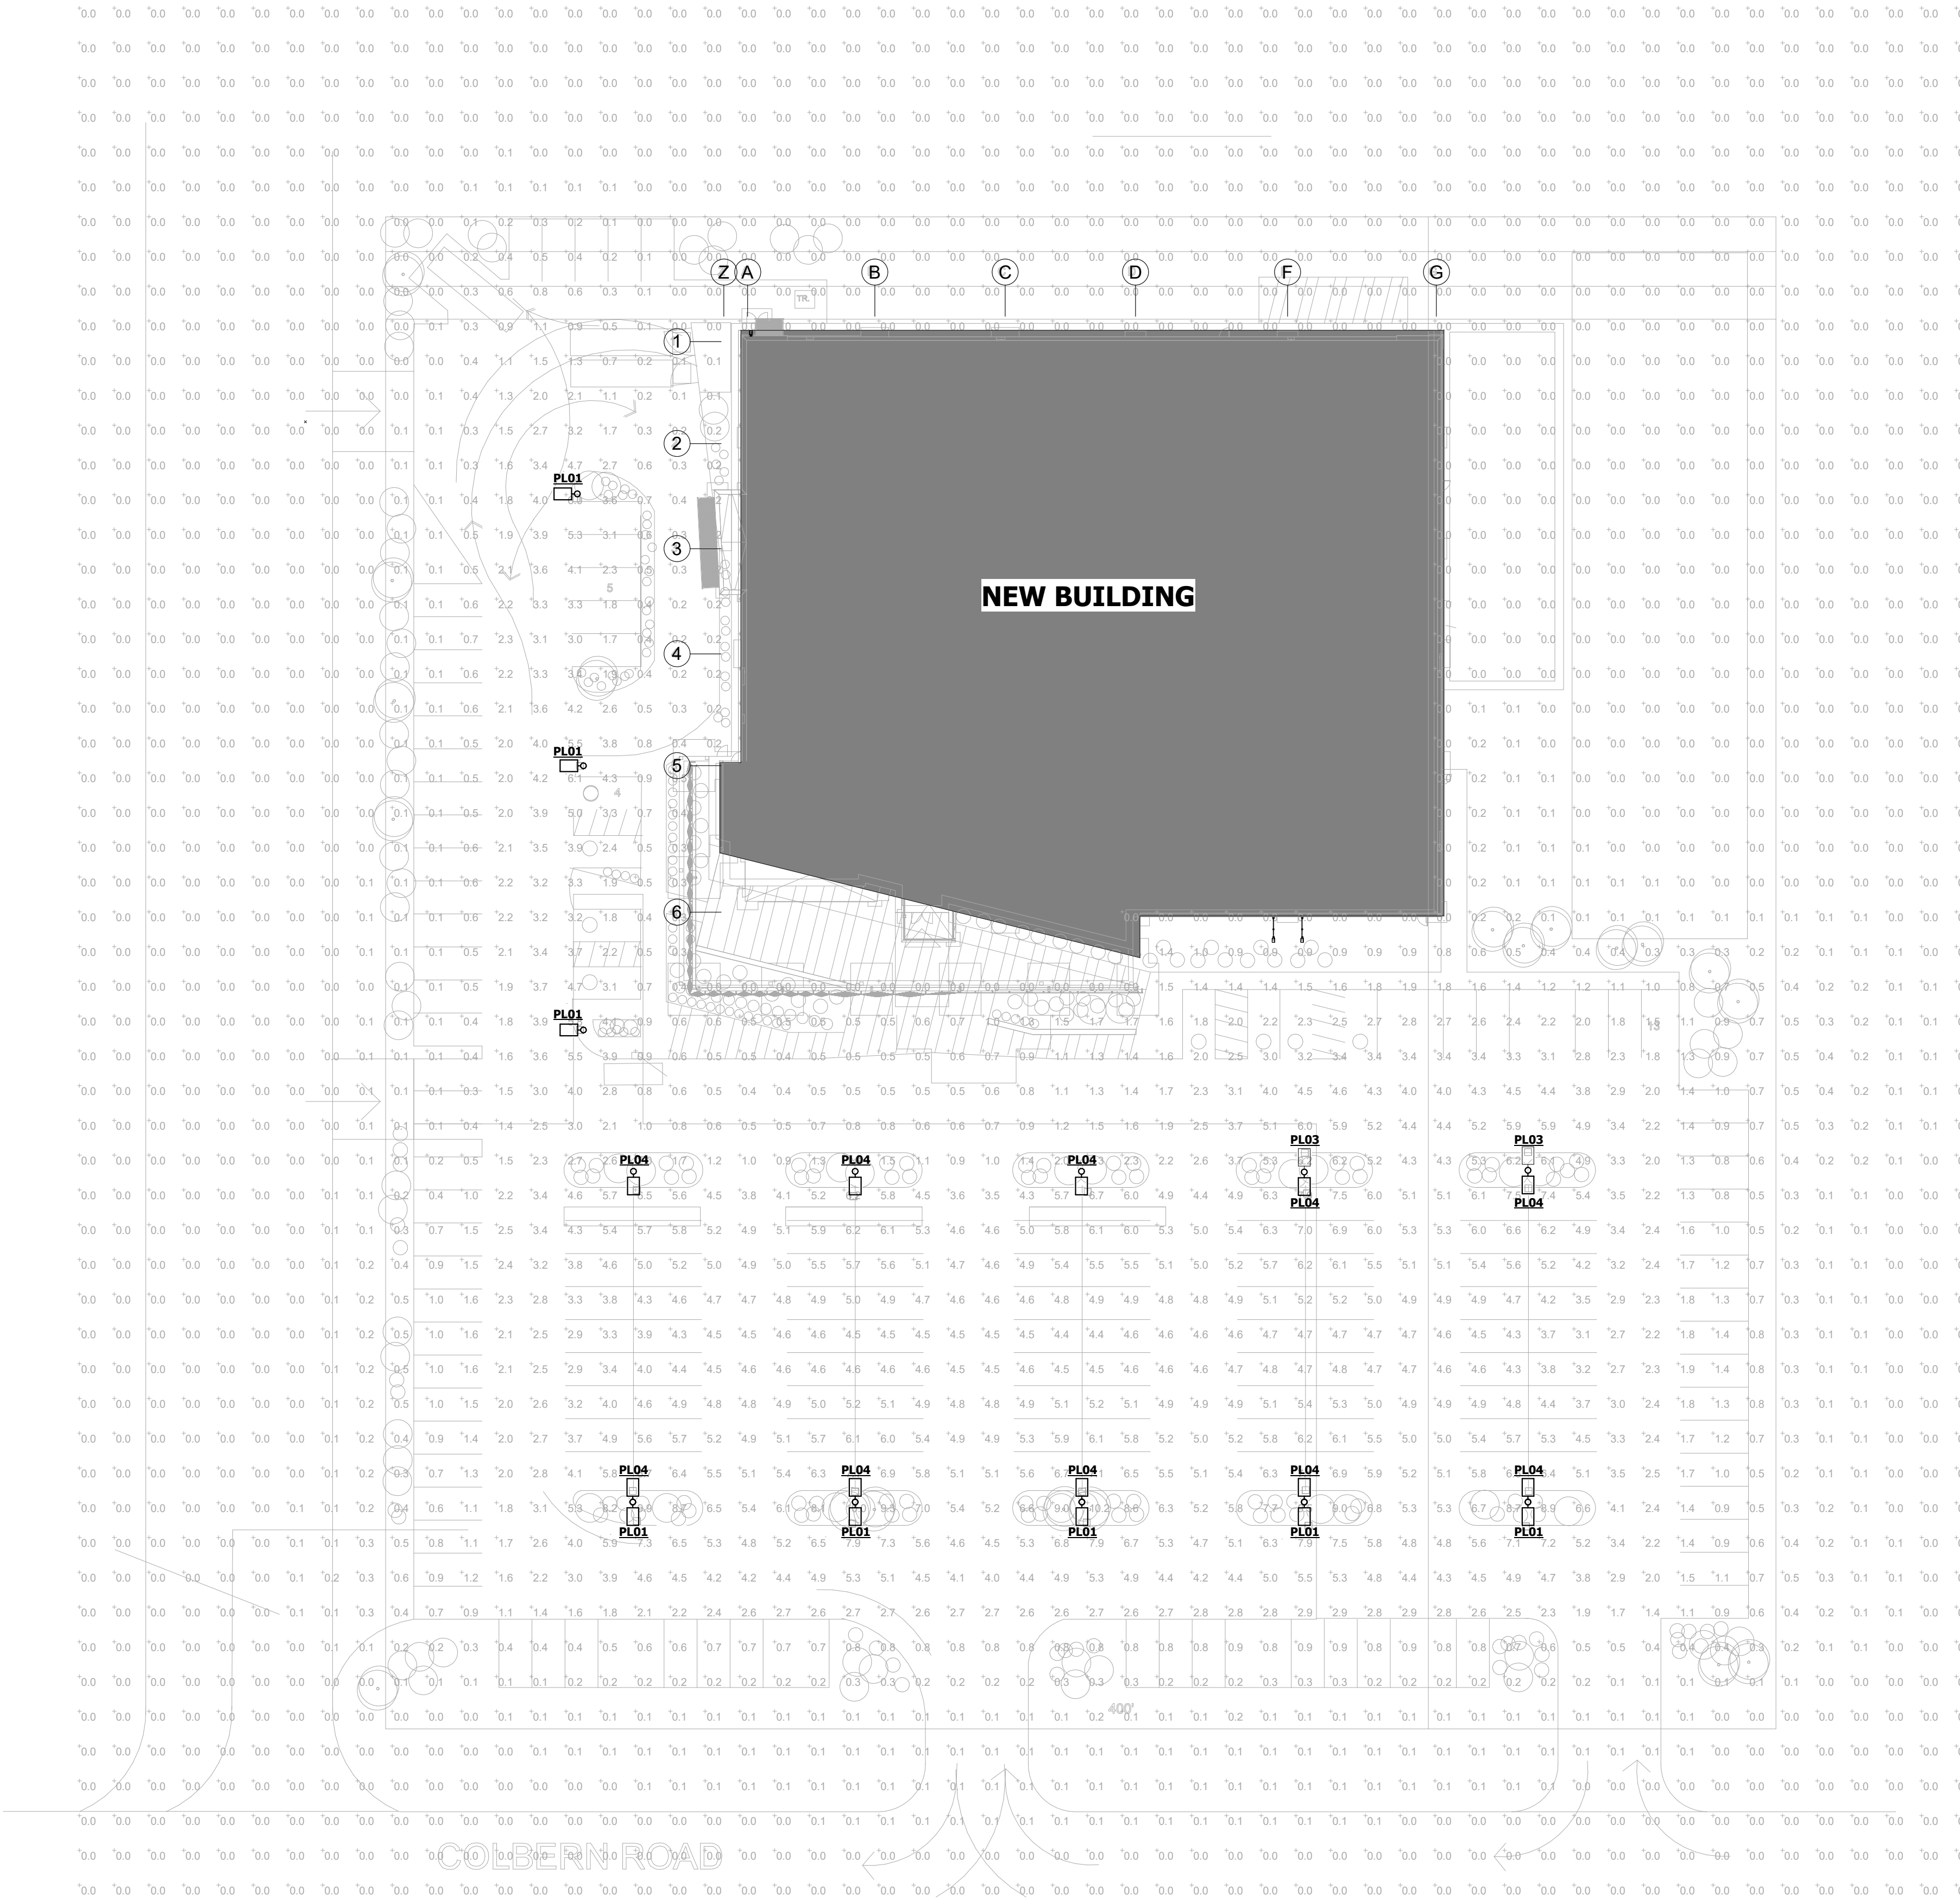

1

SITE PHOTOMETRIC PLAN

1" = 30'-0"

SAPP
DESIGN
ARCHITECTS

3750 S. Fremont Ave.
Springfield, MO 65804

417.877.9600

Sapp Design Associates Architects, P.C.
Missouri State Certificate of Authority #000607

1629 Walnut
Kansas City, MO 64108

816.300.0300

Company Name
Missouri State Certificate of Authority #

helix.

SPECIAL NOTICES

In the event the client consents to, allows, authorizes or approves of changes to any plans, specifications or other construction documents, and these changes are not approved in writing by the design professional, the client recognizes that such changes and the results thereof are not the responsibility of the design professional. Therefore, the client agrees to release the design professional from any liability arising from the construction, use or result of such changes. In addition, the client agrees to the fullest extent permitted by law, to indemnify and hold the design professional harmless from any damage, liability or cost (including reasonable attorney's fees and costs of defense) arising from such changes.

The personal seal of the registered Architect or Engineer shall be the legal equivalent of his signature whenever & wherever used, and the owner of the seal shall authenticate this sheet and the specification sections pertaining to this sheet. Responsibility shall be disclaimed for all other plans, specifications, estimates, reports or other documents or instruments relating to or intended to be used for any part or parts of the architectural project.

Mid-Continent Public Library
NEW BRANCH LIBRARY

COLBERN ROAD BRANCH

1000 NE COLBERN RD
LEE'S SUMMIT, MO 64086
JACKSON COUNTY

Engineer of Record

PRELIMINARY:
UNCERTIFIED FOR
PRE-DEVELOPMENT
PLAN REVIEW

11/08/2019

JACOB A NELSON, PE MO PE-2009018758

TRUE
ENGINEERING
MECHANICAL • ELECTRICAL • PLUMBING

3659 SOUTH AVENUE
SPRINGFIELD, MO 65807
417.708.7252
WWW.TRUE-MEP.COM

True Engineering Group LLC
Missouri State Certificate of Authority #E-2016000752

Revision No. | Description | Date

Project No.
WP10

Date
11/08/2019

Drawn
JN

Drawing No.

E102

SITE PHOTOMETRIC PLAN

© Copyright 2019 - Sapp Design Associates, Architects, P.C.