
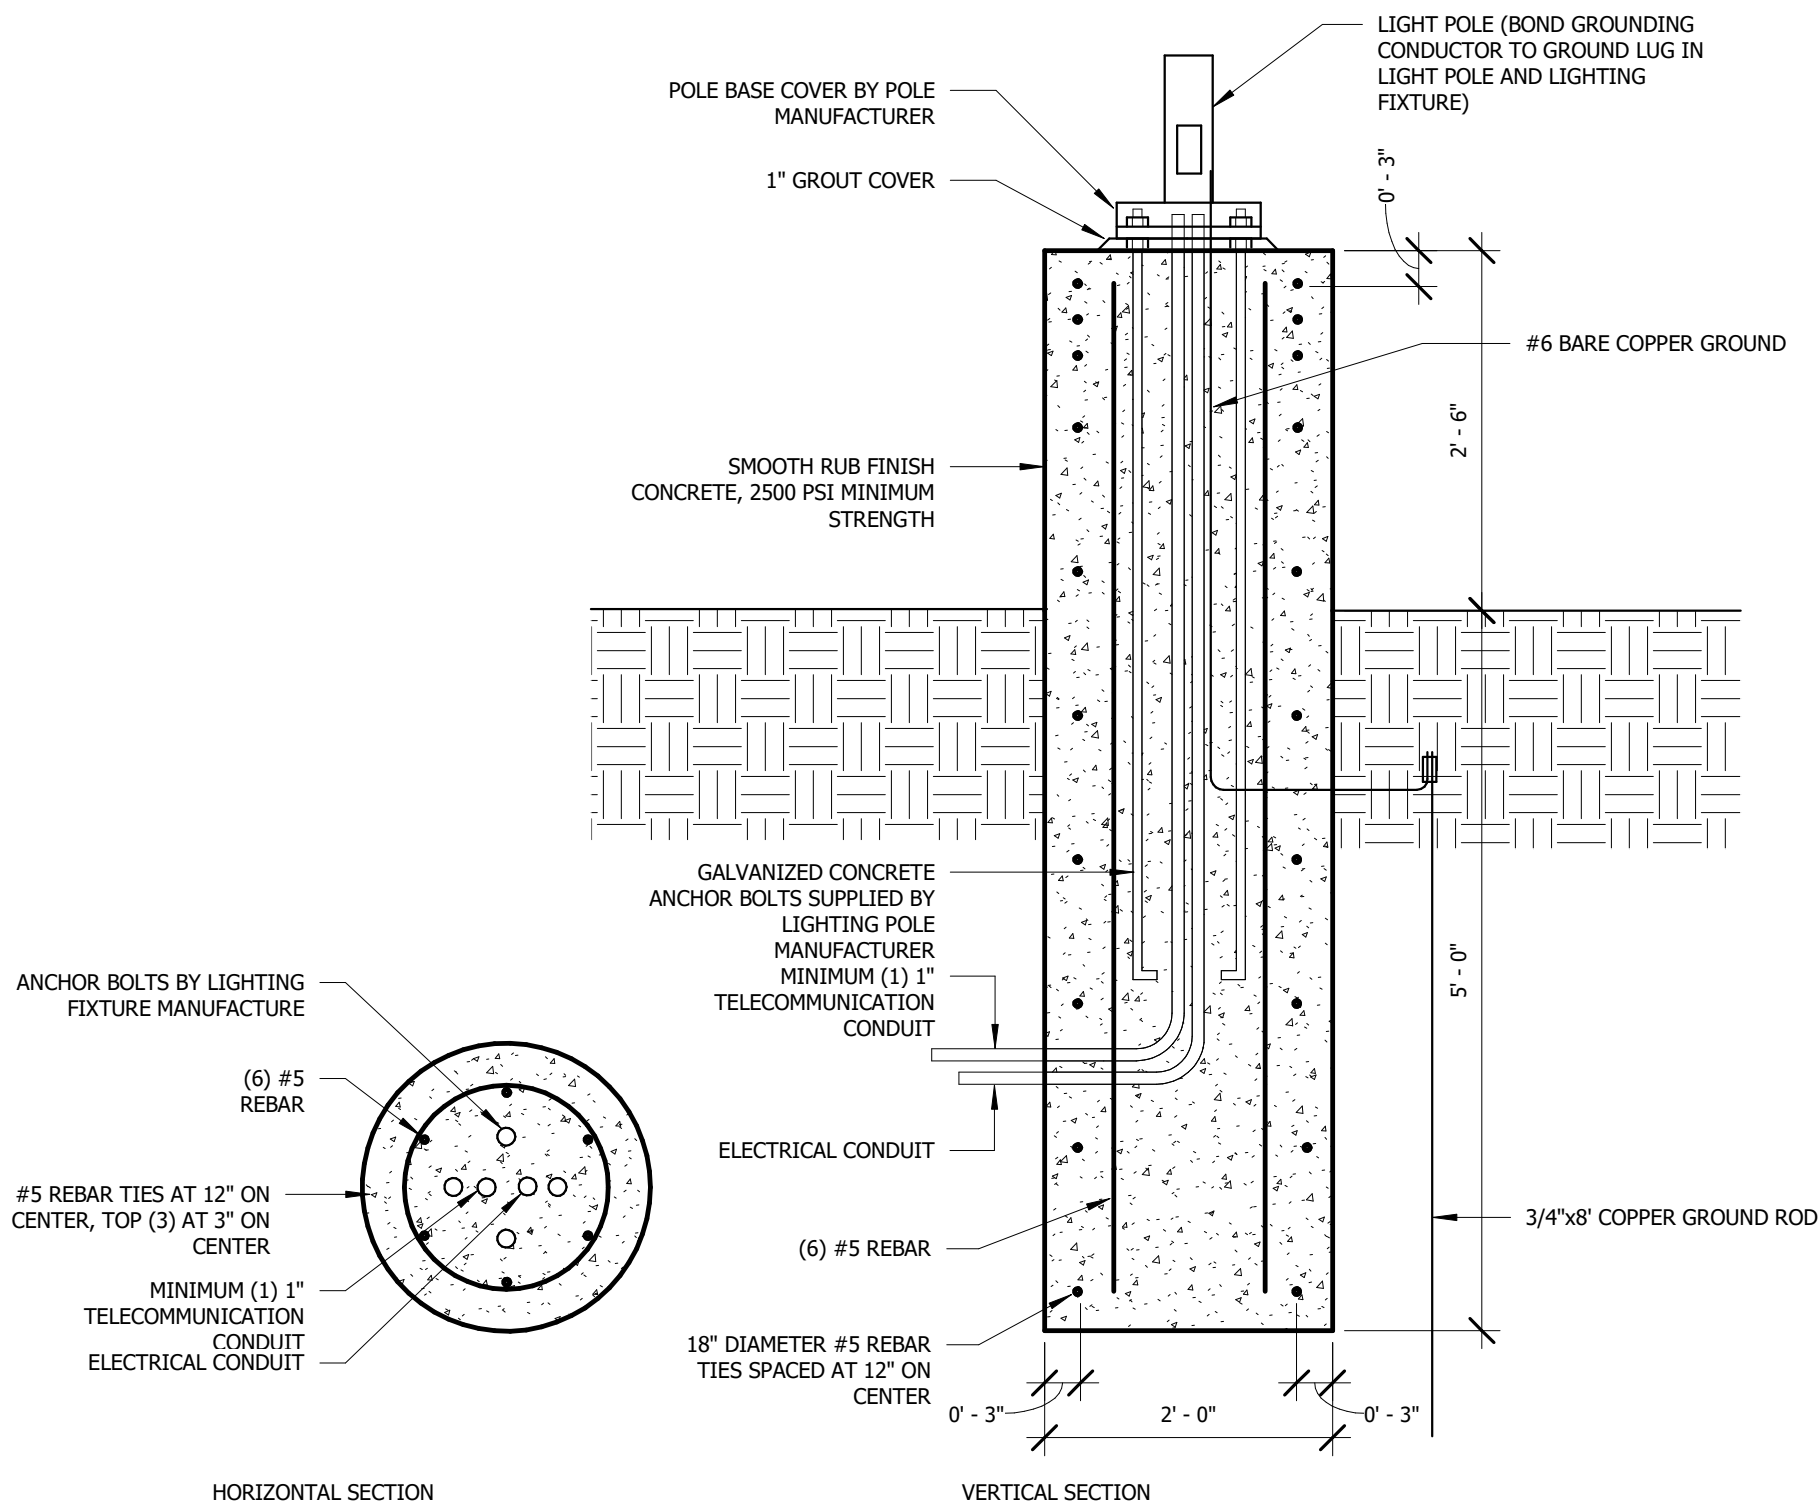


PARKING LOT LIGHTING FIXTURE SCHEDULE												
NOTES:												
1. FIXTURE SHALL BE RATED FOR OUTDOOR USE.												
2. PROVIDE 20' SQUARE POLE.												
TYPE MARK	MANUFACTURER	MODEL NUMBER	DRIVER	FINISH	VOLTAGE	LAMP TYPE	LAMP QTY	COLOR TEMP	TOTAL WATTAGE	NOTES	EQUIVALENTS	
PL01	SIGNIFY	ECF-S-32L-1.2A-NW-G2-AR-2-UNV-MGY	STD	MEDIUM GRAY	UNV	LED	4000	122		1,2		
PL02	SIGNIFY	ECF-S-48L-1.2A-NW-G2-AR-2-UNV-MGY	STD	MEDIUM GRAY	UNV	LED	4000	122		1,2		
PL02H	SIGNIFY	ECF-S-48L-1.2A-NW-G2-AR-2-UNV-HIS-MGY	STD	MEDIUM GRAY	UNV	LED	4000	122		1,2		
PL03	SIGNIFY	ECF-S-48L-1.2A-NW-G2-AR-3-UNV-MGY	STD	MEDIUM GRAY	UNV	LED	4000	183		1,2		
PL04	SIGNIFY	ECF-S-48L-1.2A-NW-GR-AR-4-UNV-MGY	STD	MEDIUM GRAY	UNV	LED	4000	183		1,2		
PL04H	SIGNIFY	ECF-S-32L-1.2A-NW-G2-AR-2-UNV-HIS-MGY	STD	MEDIUM GRAY	UNV	LED	4000	122		1,2		
PL05	SIGNIFY	ECF-S-32L-1.2A-NW-G2-AR-5-UNV-MGY	STD	MEDIUM GRAY	UNV	LED	4000	183		1,2		
PL-SG01	BEGA	BEGA-24509K4	DIM	BY ARCH	120	LED		4000	56	1		
PL-WP01	EATON	ENC-E02-LED-E1-BL2 (FINISH)	-	BY ARCH	120	LED		4000	47	1		
PL-WP02	EATON	ENC-E01-LED-E1-BL2 (FINISH)	-	BY ARCH	120	LED		4000	25	1		

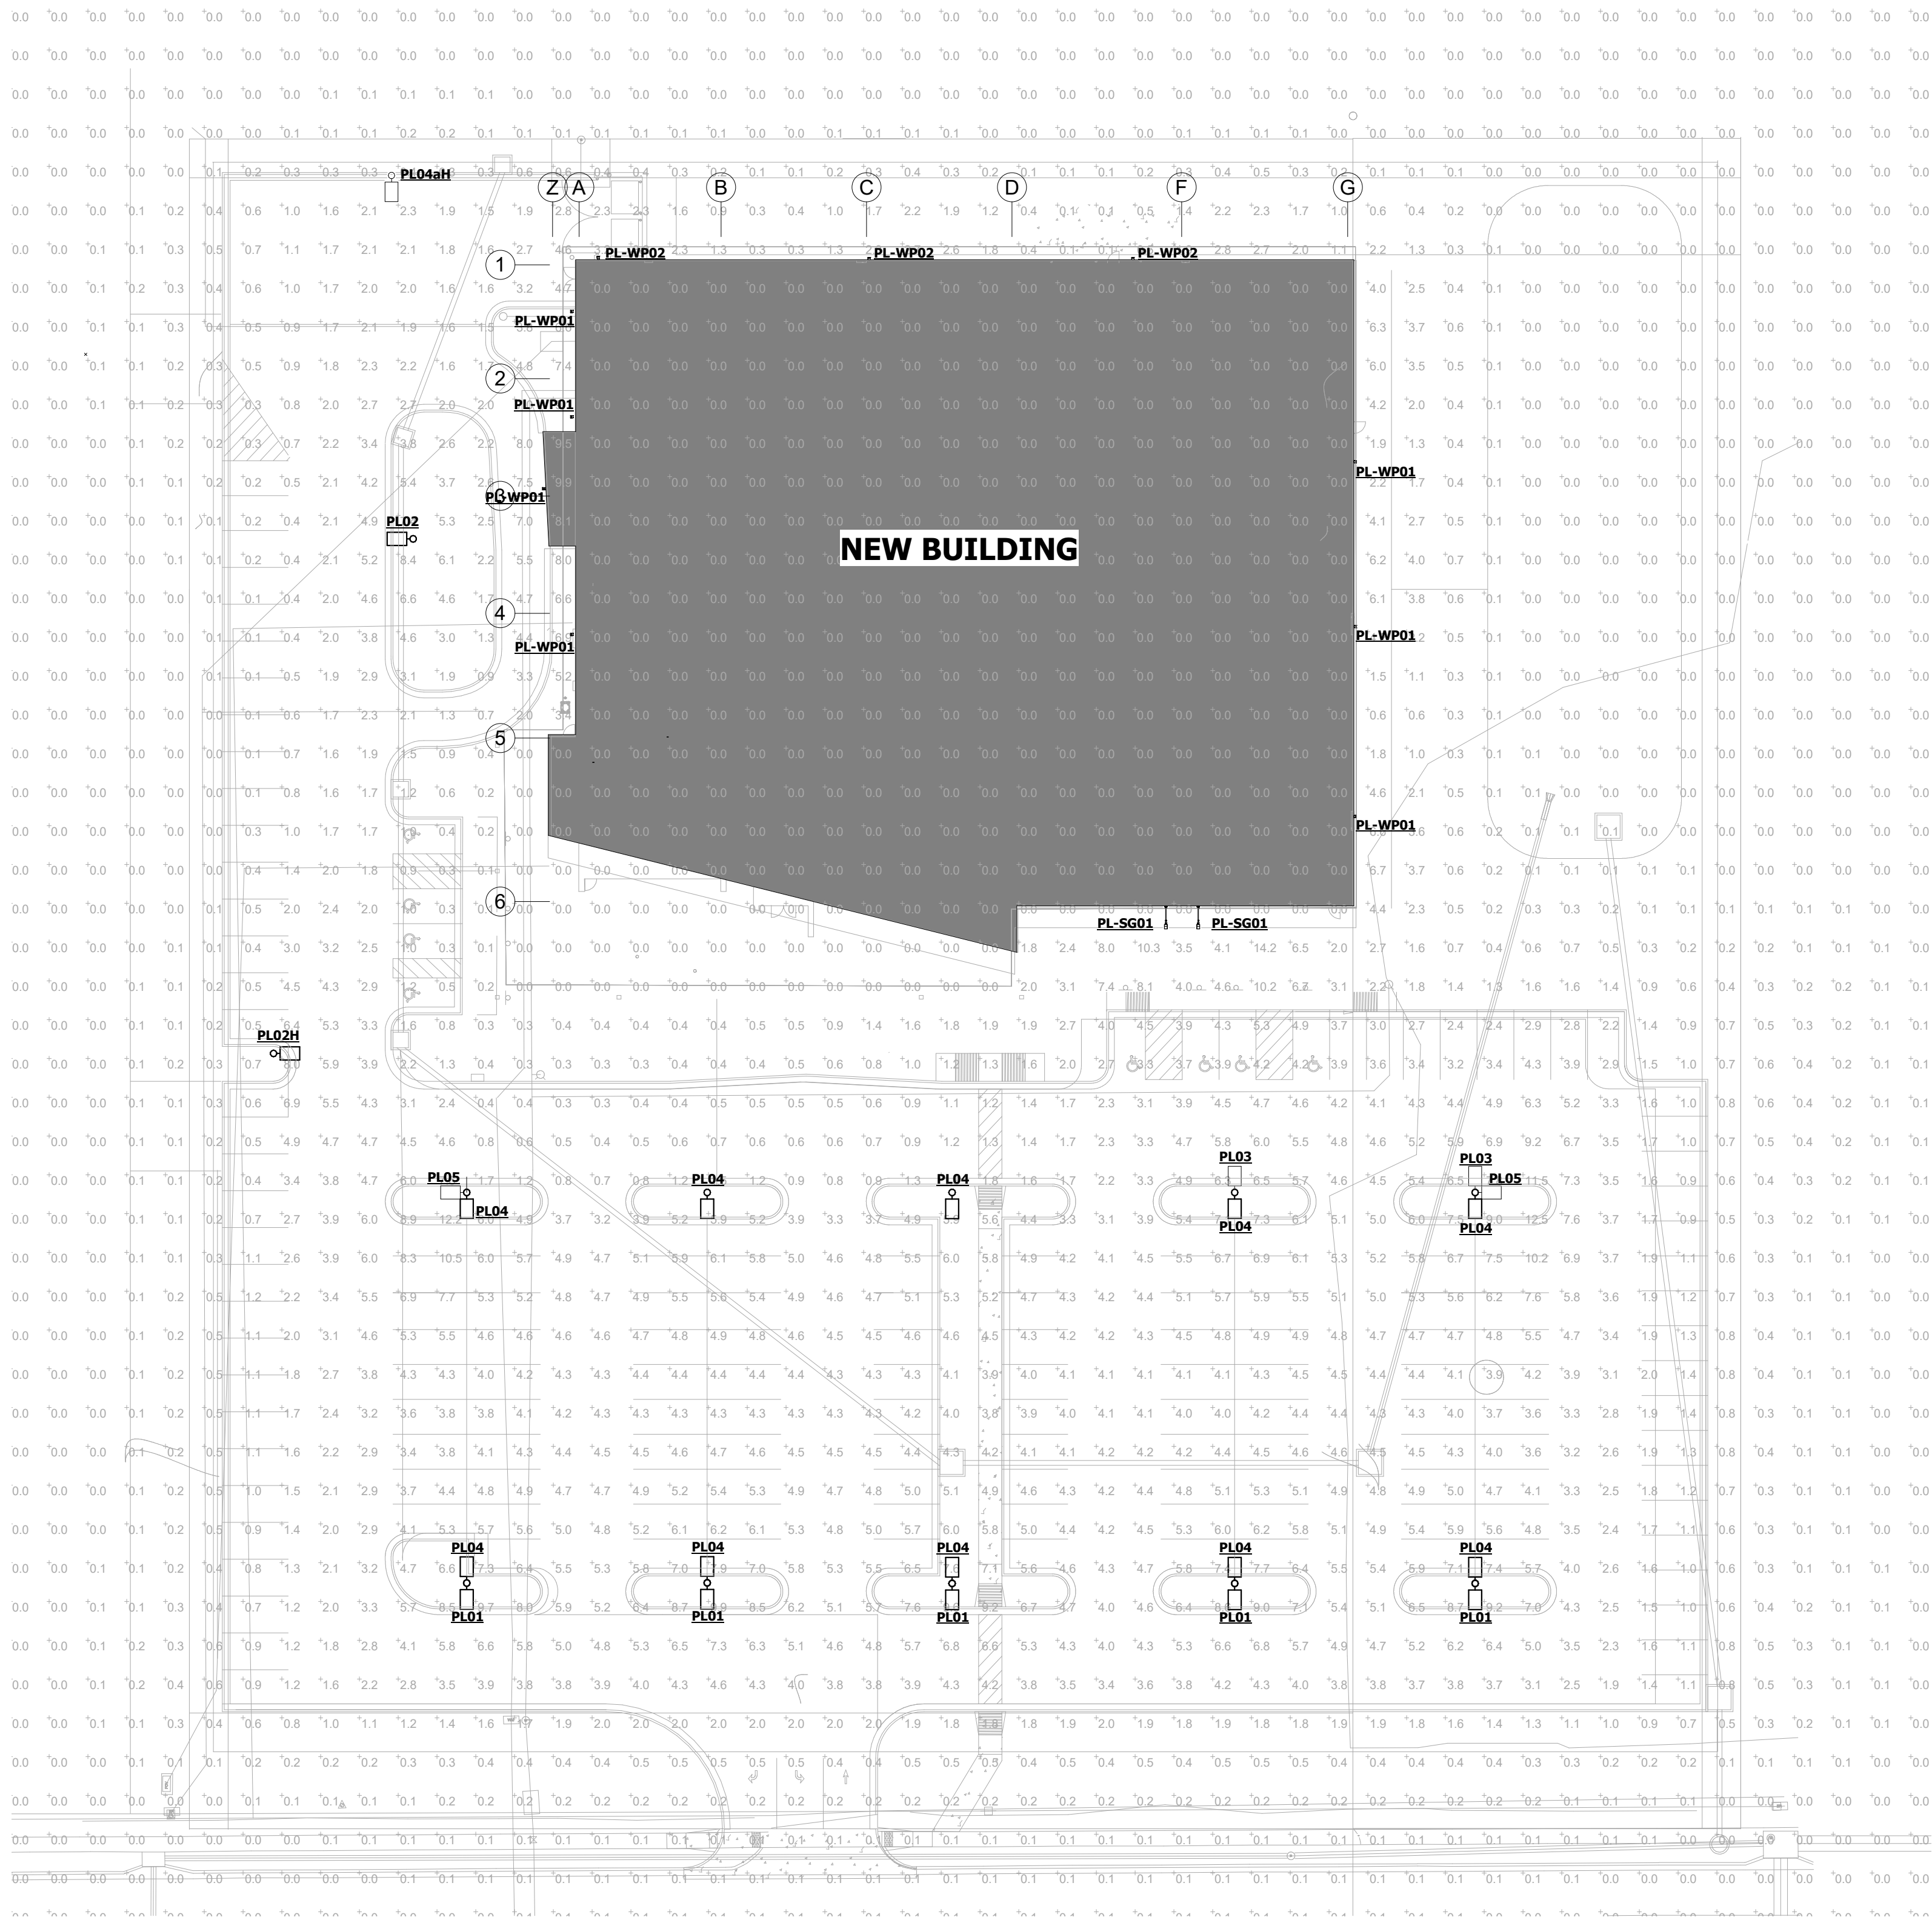

2

PARKING LOT LIGHT POLE BASE

NOT TO SCALE

1

SITE PHOTOMETRIC PLAN

1" = 30'-0"

