


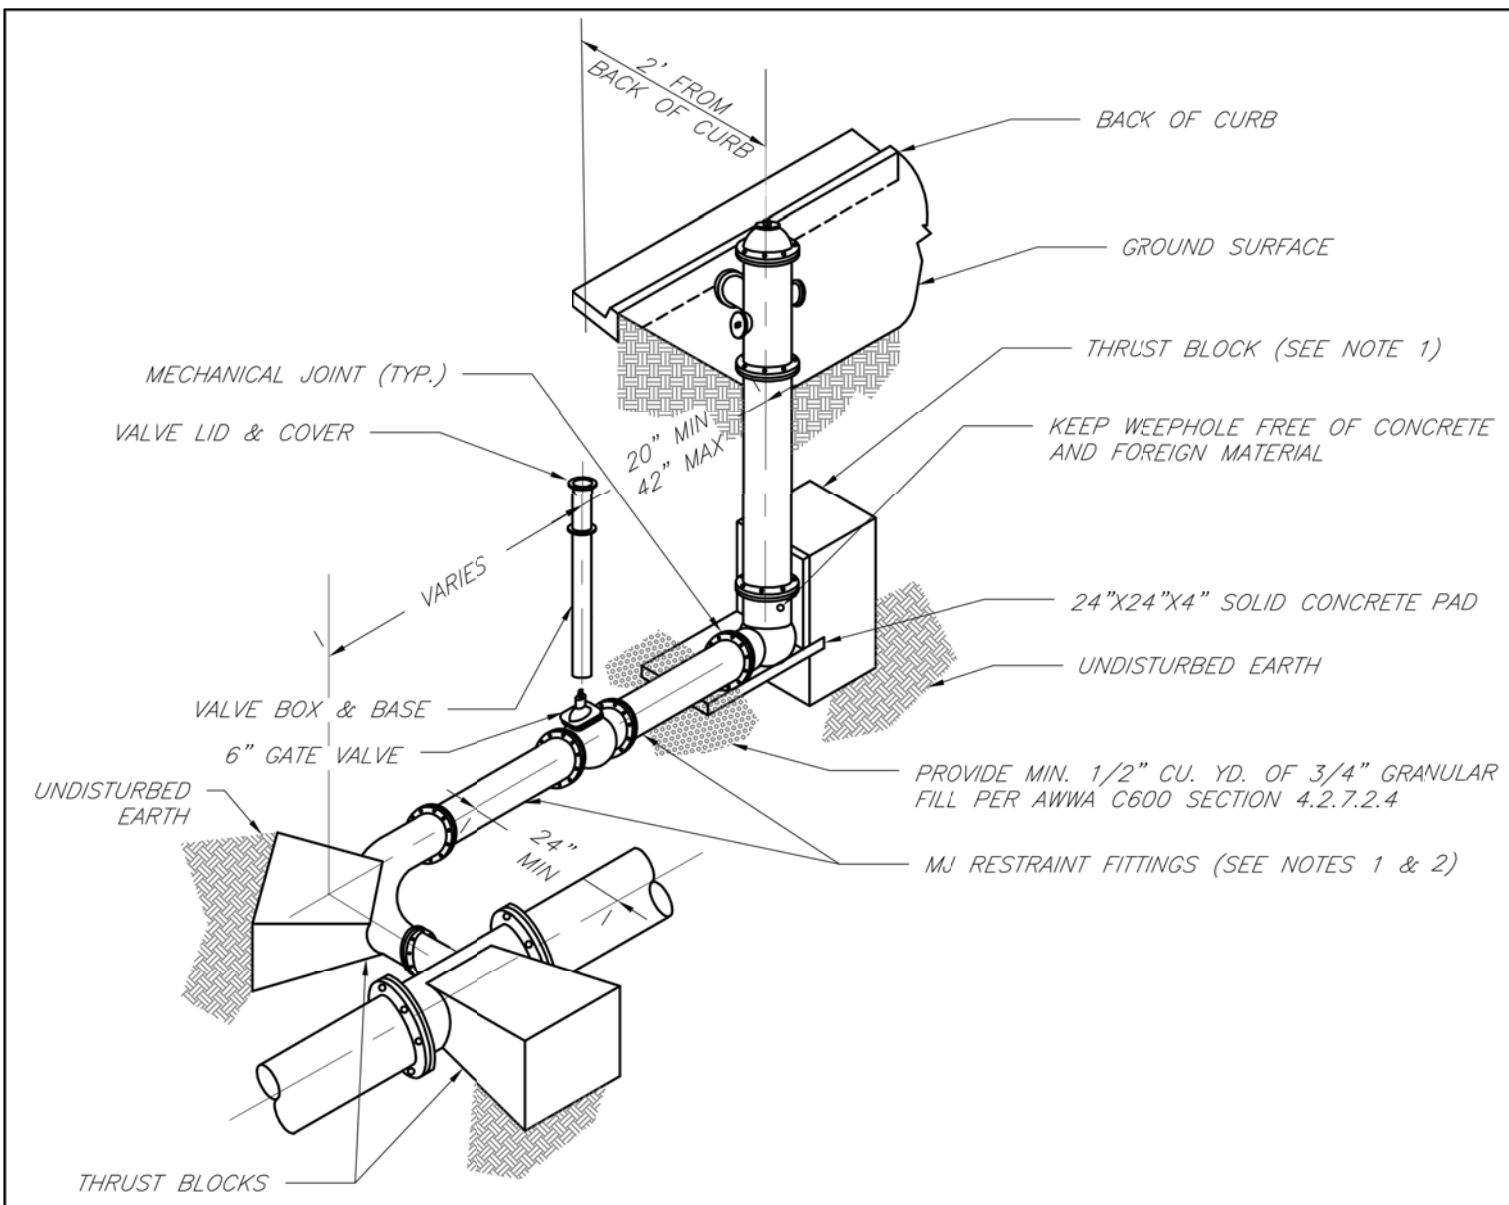

NOTES:


1. WHEN RETAINER GLANDS ARE USED IN LIEU OF MECHANICAL JOINT (MJ) RESTRAINT FITTINGS, HORIZONTAL THRUST BLOCKS ARE REQUIRED.
2. GATE VALVE MAY BE BOLTED DIRECTLY TO MJ RESTRAINT TEE.
3. SEE APPROVED PRODUCTS LIST FOR WATER UTILITIES FOR FIRE HYDRANT, VALVES, VALVE BOX LID, AND COVER.
4. BOTTOM HYDRANT FLANGE SHALL BE 2" TO 6" ABOVE FINISHED GRADE.
5. FOR STREETS WITHOUT CURBS FIRE HYDRANTS SHALL BE PLACED WITHIN 1 FOOT OF THE R/W LINE, BUT NOT MORE THAN 10' FROM EDGE OF PAVEMENT. FIRE HYDRANT SHALL NOT BE PLACED IN BOTTOM OF DITCH.
6. HYDRANT SHALL BE ROTATED AS DIRECTED BY INSPECTOR.

LS

LEE'S SUMMIT
MISSOURI
HYDRANT WITH 90 DEGREE BEND

Date: 02/13
Drawn By: JN
Checked By: DL
File: WAT-6
Rev: 1/14

Rev:

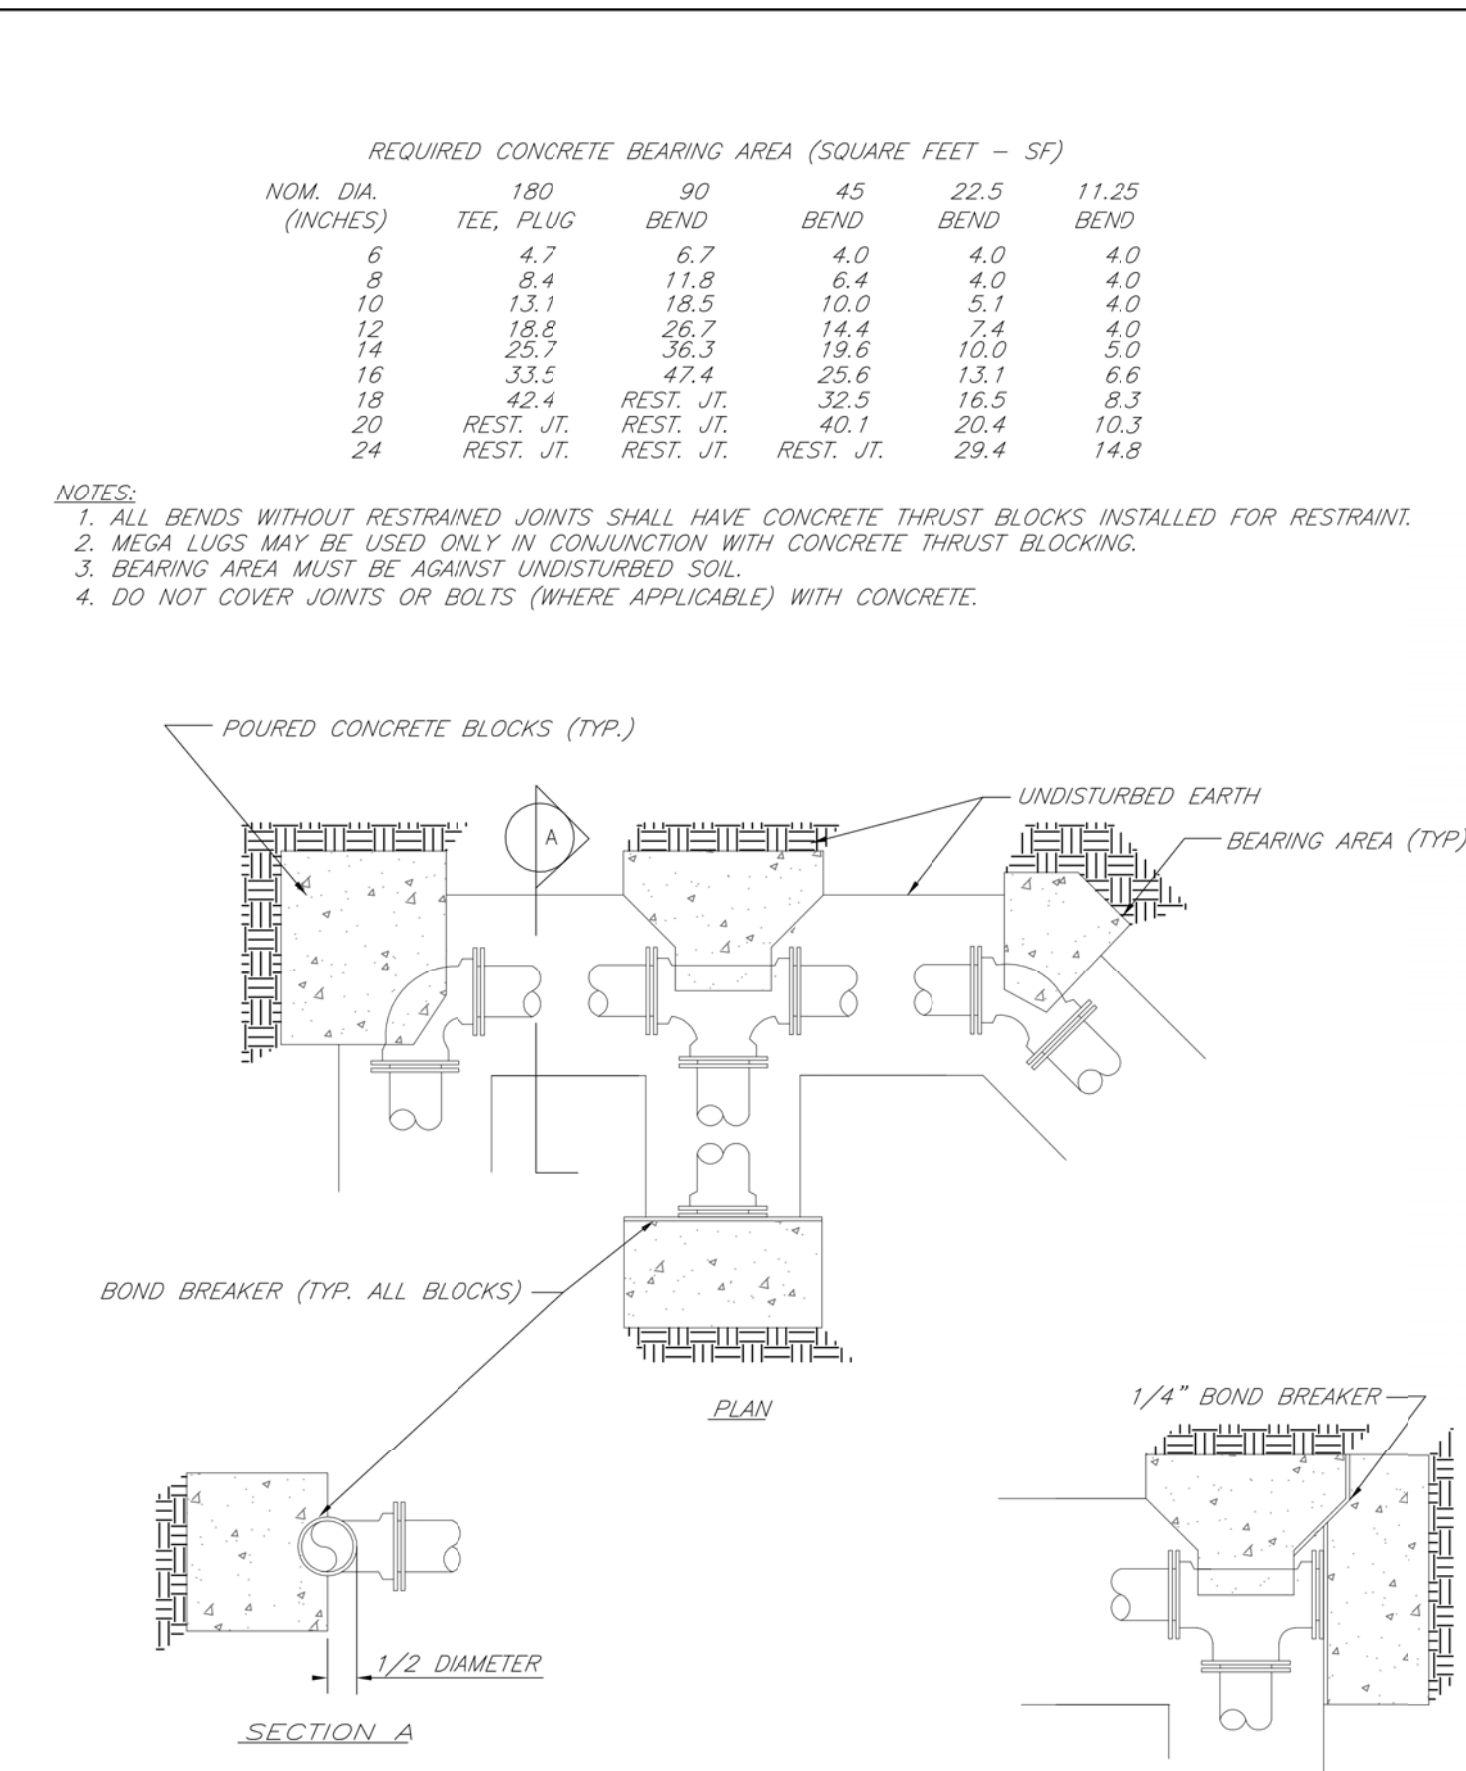


LS

LEE'S SUMMIT
MISSOURI
HORIZONTAL THRUST BLOCKS

Date: 02/13
Drawn By: JN
Checked By: DL
File: WAT-1
Rev: 1/14

Rev:

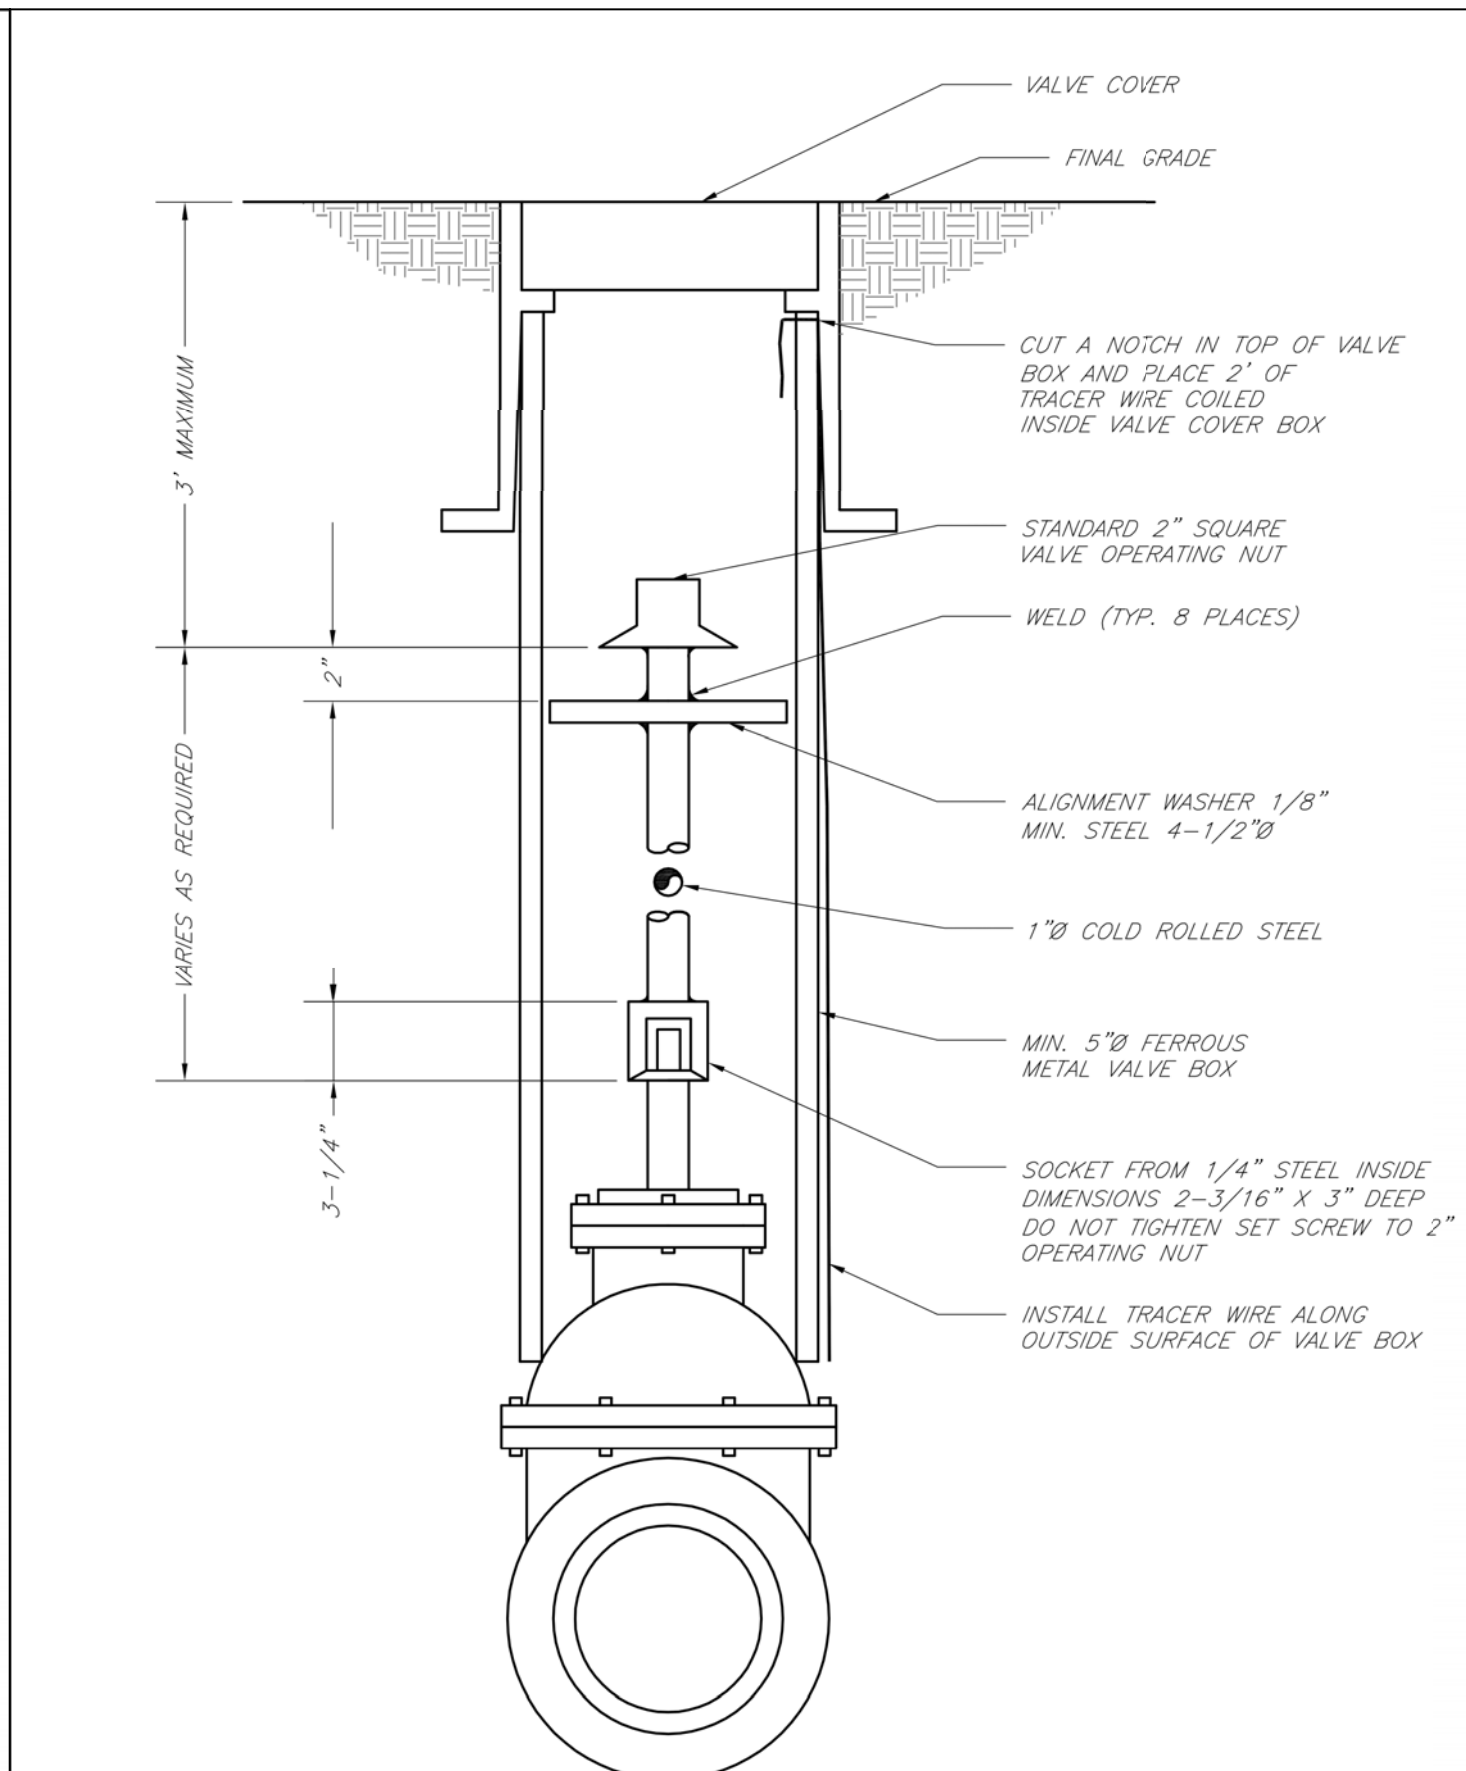


LS

LEE'S SUMMIT
MISSOURI
VALVE STEM EXTENSION AND VALVE BOX

Date: 02/13
Drawn By: JN
Checked By: DL
File: WAT-9
Rev: 1/14

Rev:

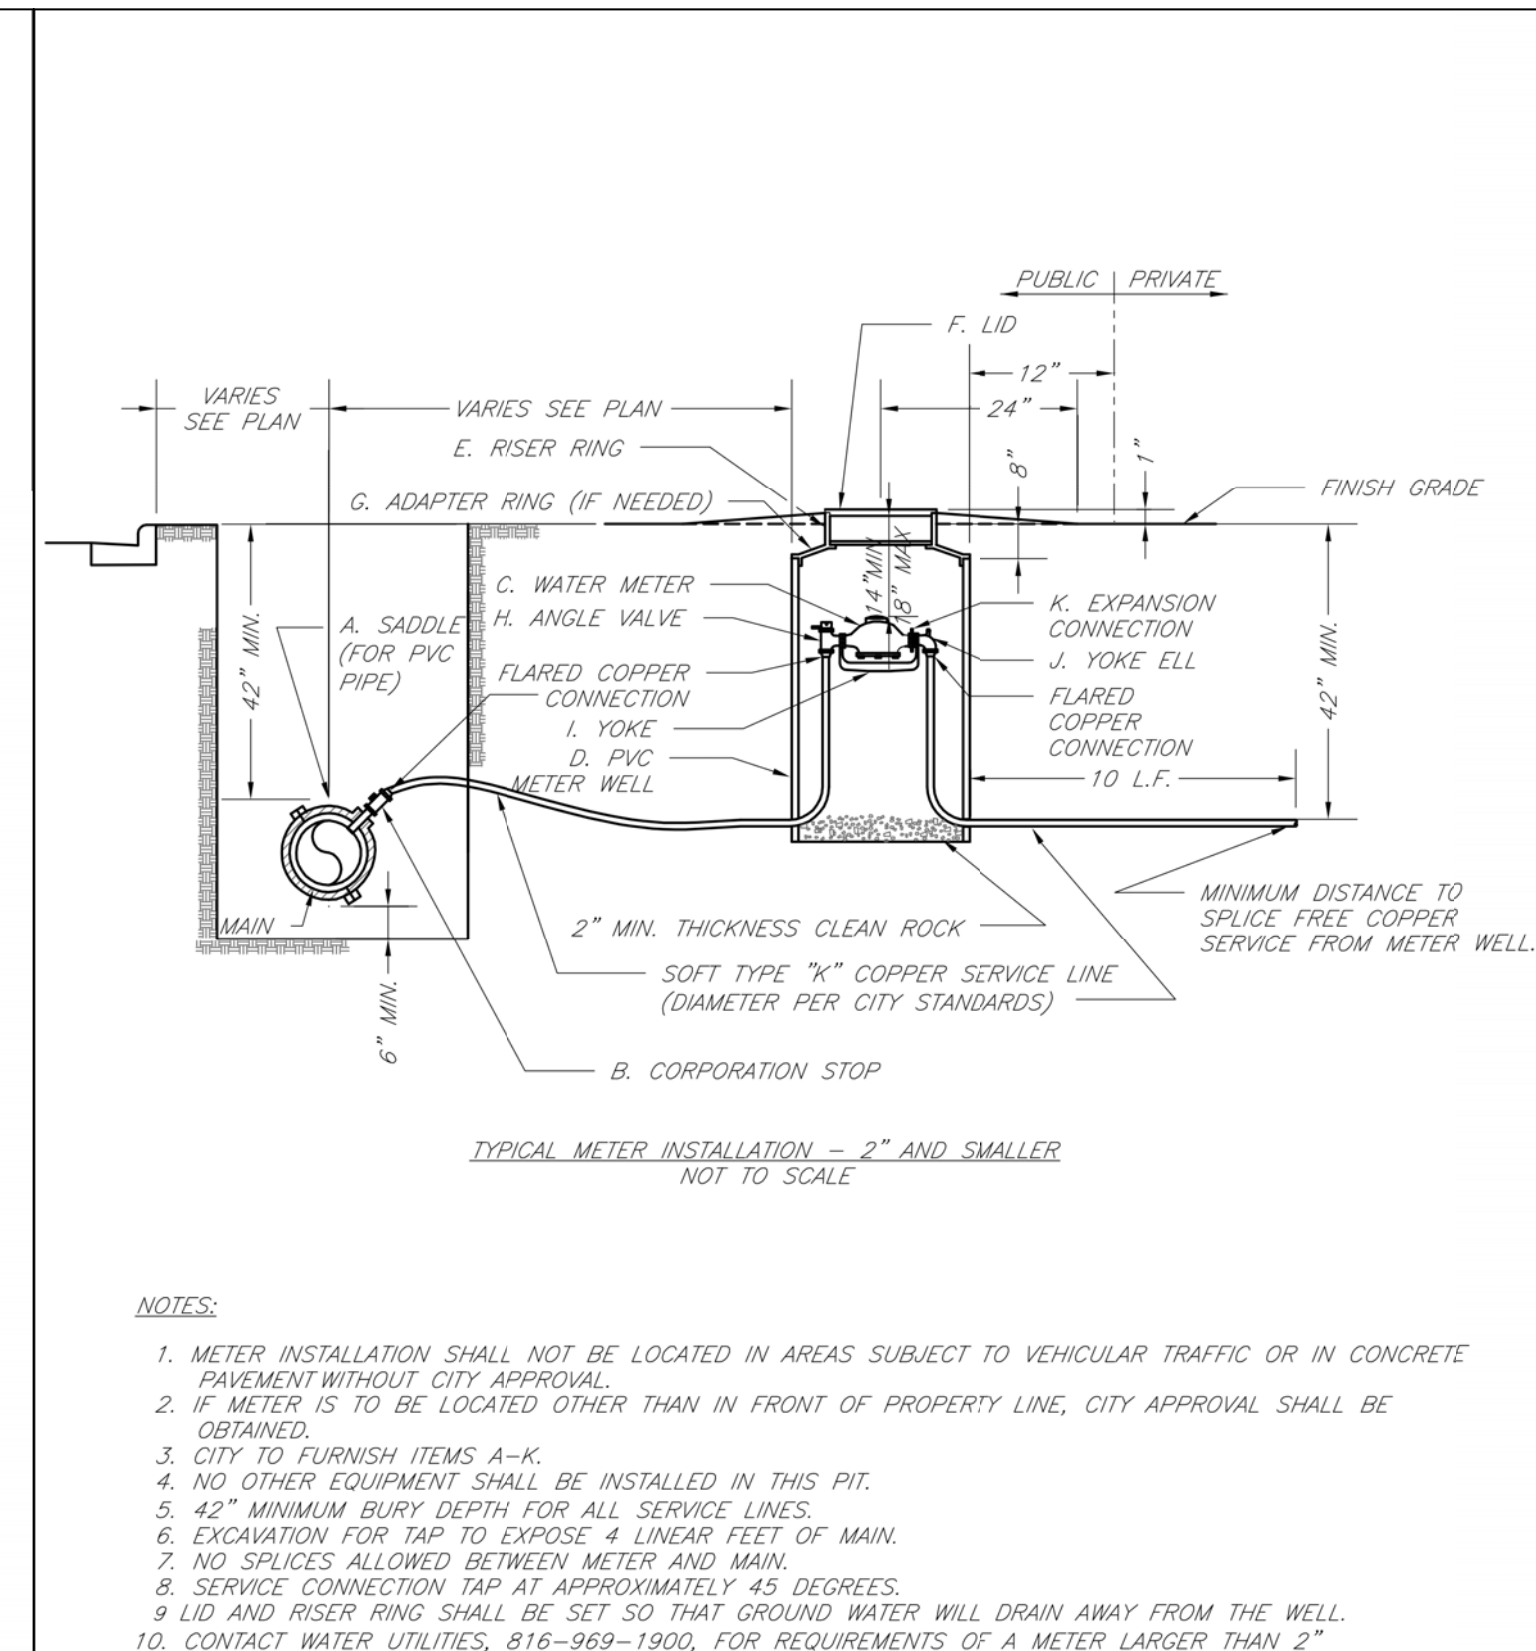

NOTES:


1. METER INSTALLATION SHALL NOT BE LOCATED IN AREAS SUBJECT TO VEHICULAR TRAFFIC OR IN CONCRETE PAVEMENT WITHOUT CITY APPROVAL.
2. IF METER IS TO BE LOCATED OTHER THAN IN FRONT OF PROPERTY LINE, CITY APPROVAL SHALL BE OBTAINED.
3. CITY TO FURNISH ITEMS A-K.
4. NO OTHER EQUIPMENT SHALL BE INSTALLED IN THIS PIT.
5. 42\"/>

LS

LEE'S SUMMIT
MISSOURI
SERVICE CONNECTION/METER WELL

Date: 02/13
Drawn By: JN
Checked By: DL
File: WAT-11
Rev: 1/14

Rev:

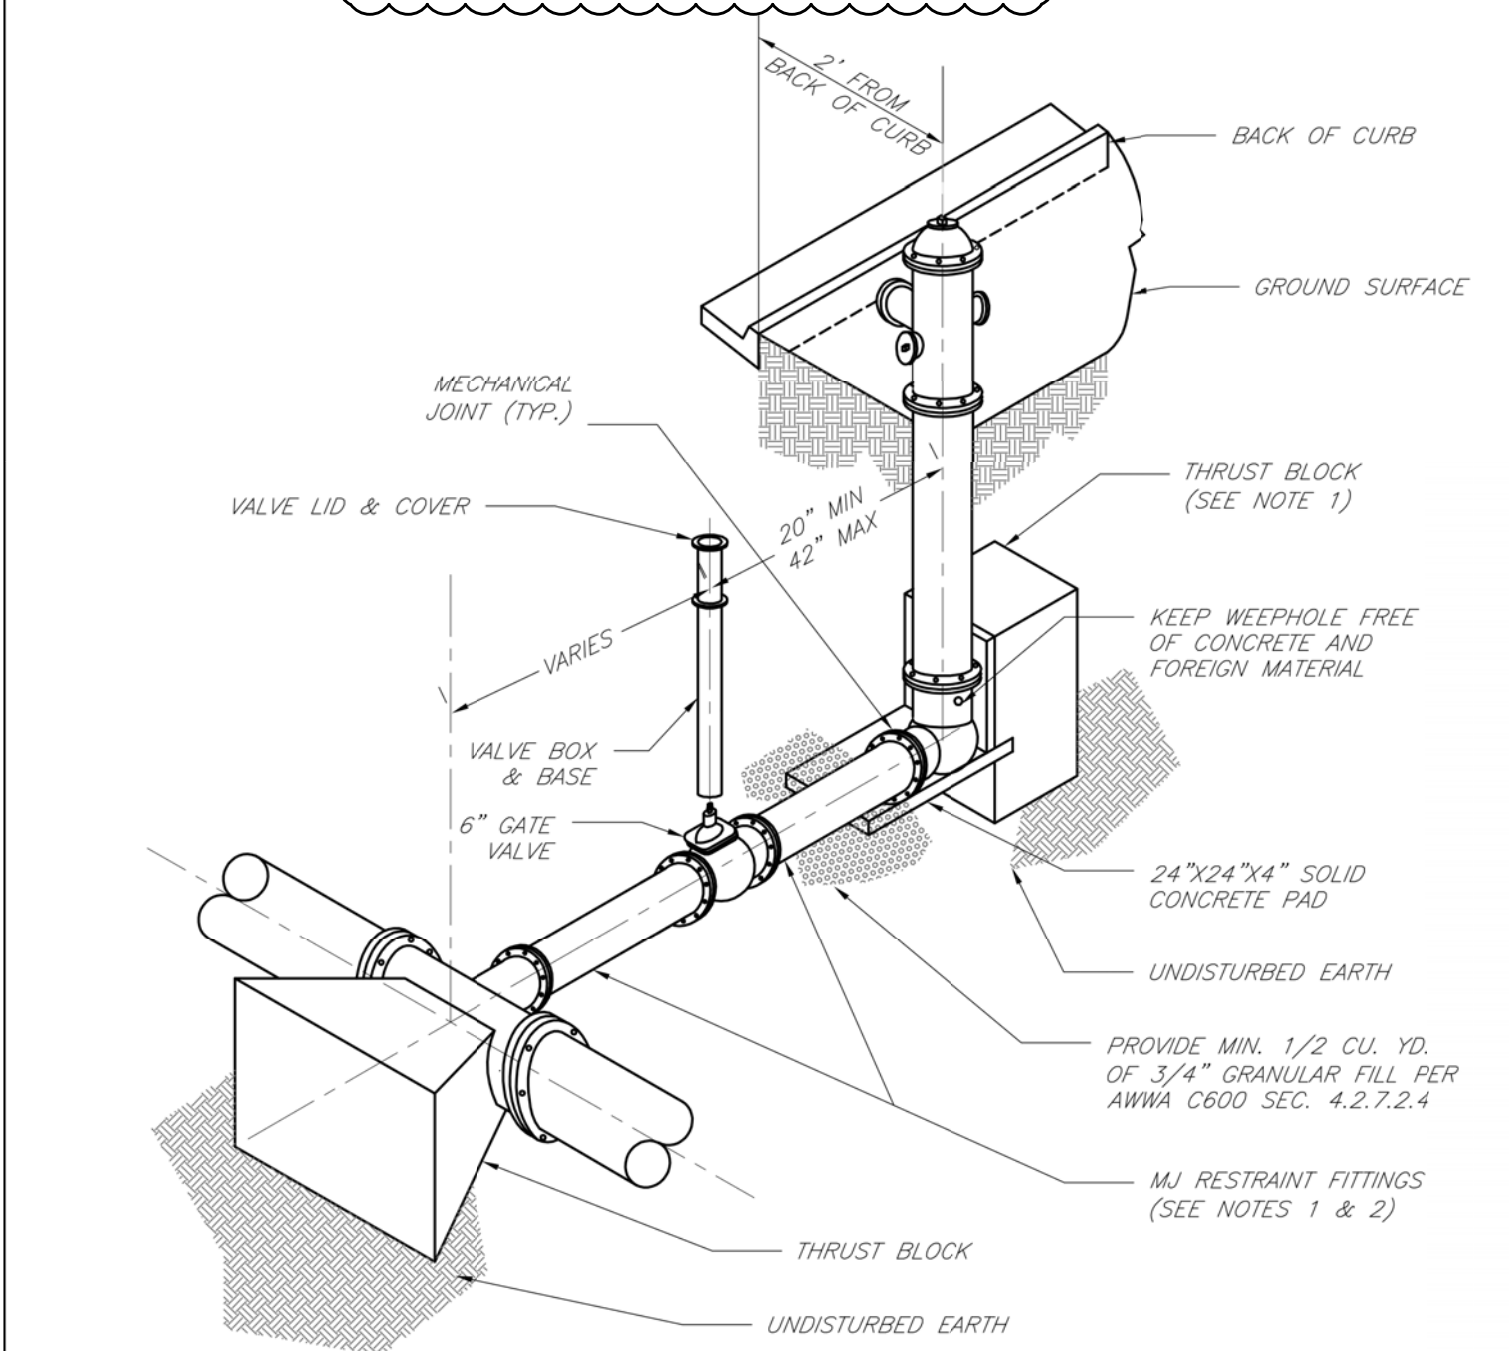

NOTES:


1. WHEN RETAINER GLANDS ARE USED IN LIEU OF MECHANICAL JOINT (MJ) RESTRAINT FITTINGS, HORIZONTAL THRUST BLOCKS ARE REQUIRED.
2. GATE VALVE MAY BE BOLTED DIRECTLY TO MJ RESTRAINT TEE.
3. SEE APPROVED PRODUCTS LIST FOR WATER UTILITIES FOR FIRE HYDRANT, VALVES, VALVE BOX LID, AND COVER.
4. BOTTOM HYDRANT FLANGE SHALL BE 2" TO 6" ABOVE FINISHED GRADE.
5. FOR STREETS WITHOUT CURBS FIRE HYDRANTS SHALL BE PLACED WITHIN 1 FOOT OF THE R/W LINE, BUT NOT MORE THAN 10' FROM EDGE OF PAVEMENT. FIRE HYDRANT SHALL NOT BE PLACED IN BOTTOM OF DITCH.
6. HYDRANT SHALL BE ROTATED AS DIRECTED BY INSPECTOR.

LS

LEE'S SUMMIT
MISSOURI
HYDRANT INSTALLATION - STRAIGHT SET

Date: 02/13
Drawn By: JN
Checked By: DL
File: WAT-7
Rev: 1/14

Rev:

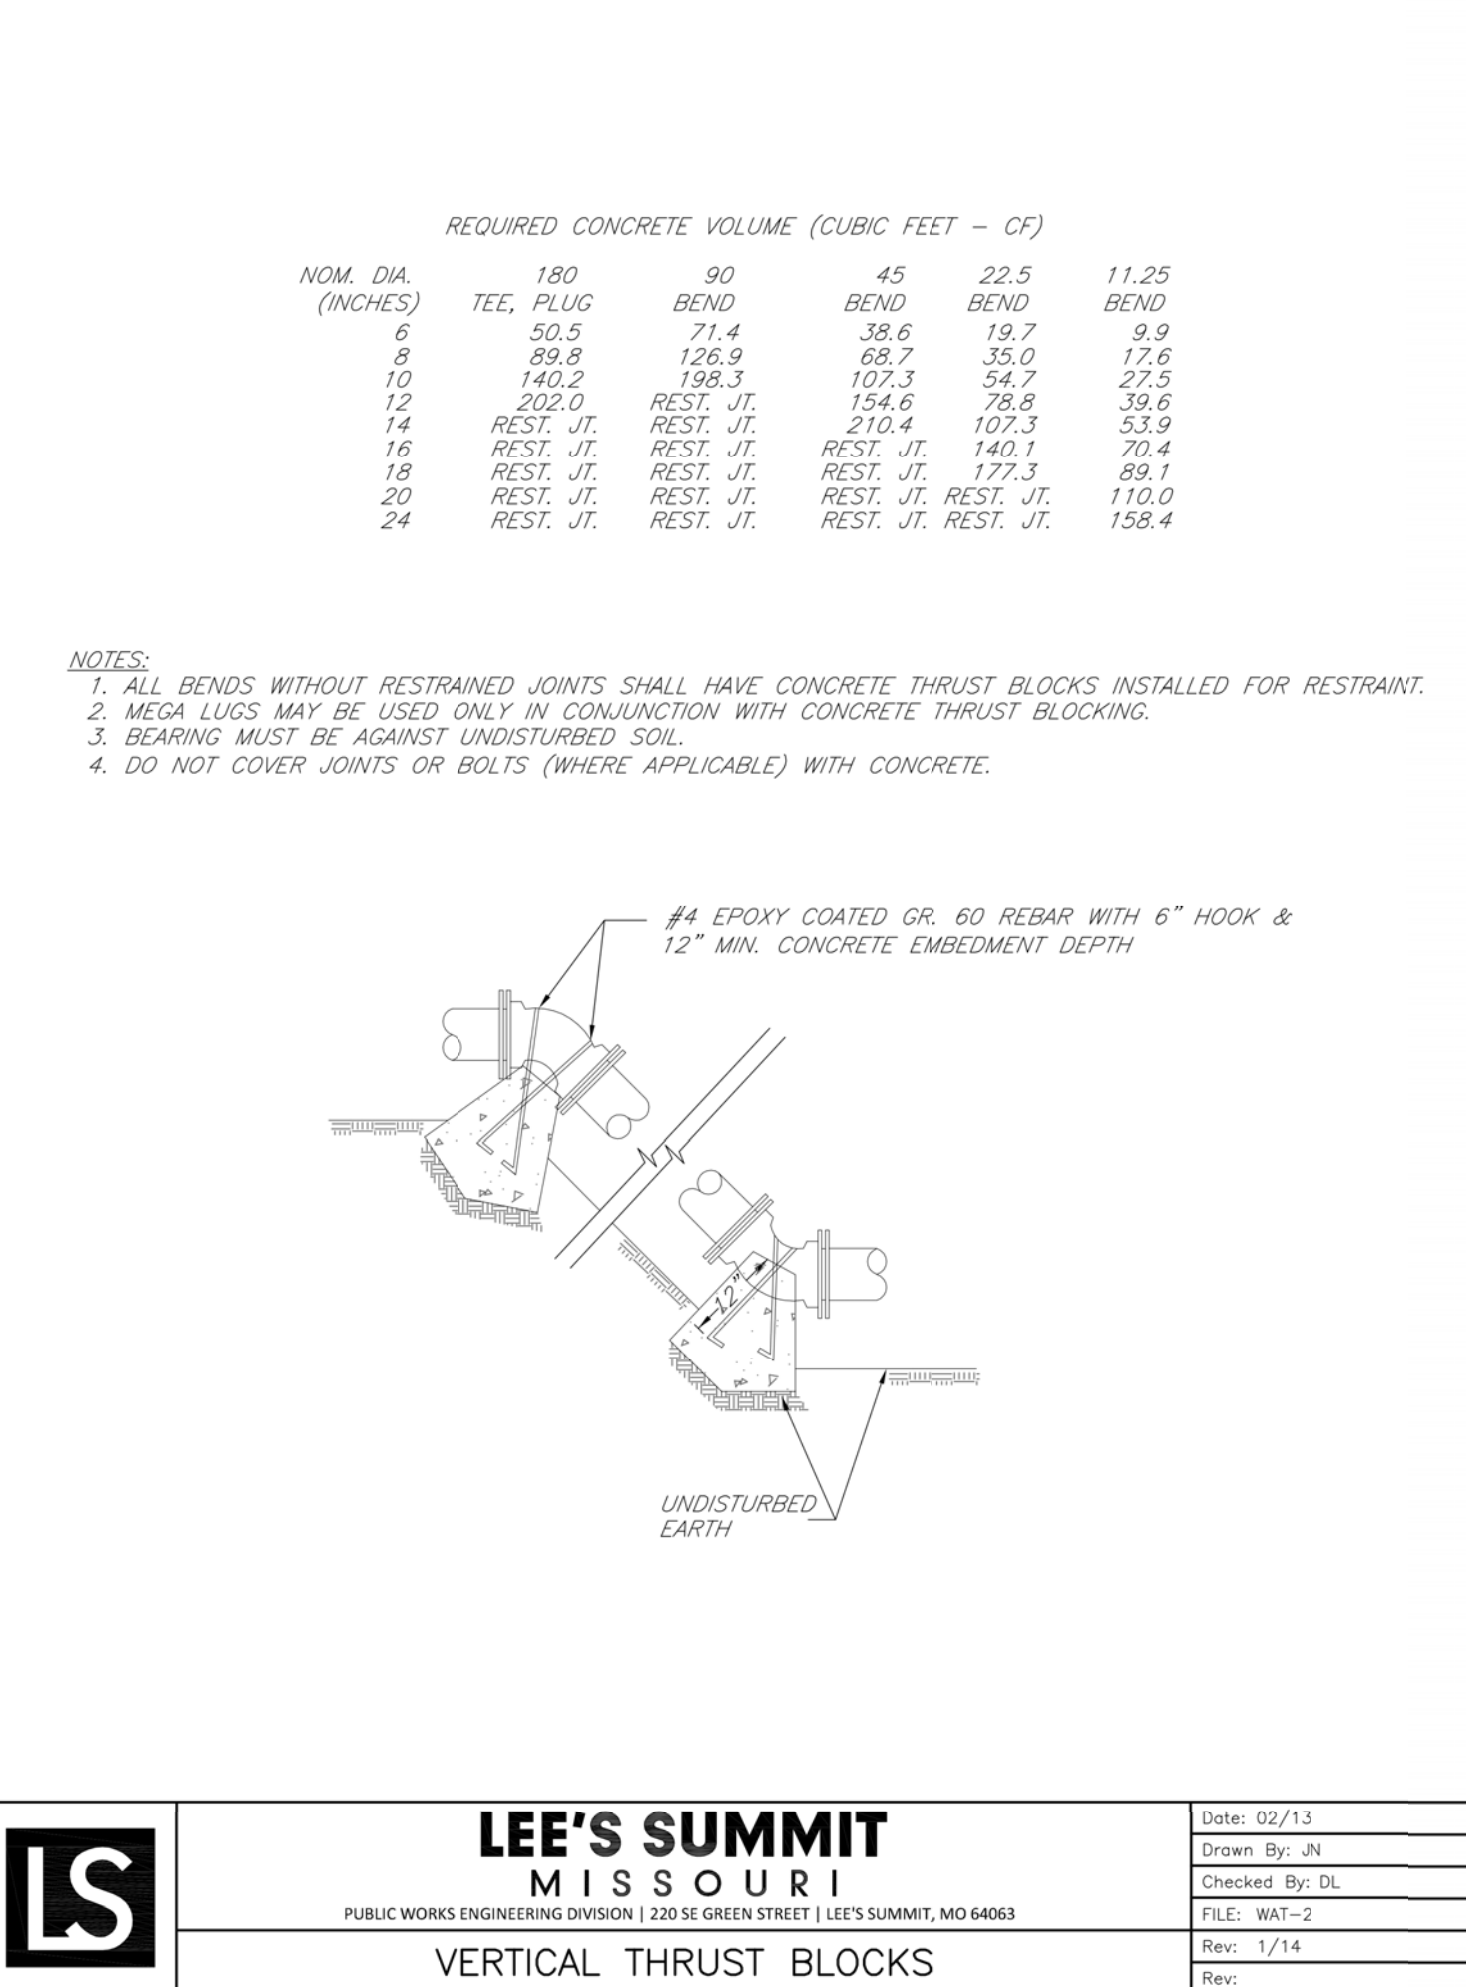


LS

LEE'S SUMMIT
MISSOURI
VERTICAL THRUST BLOCKS

Date: 02/13
Drawn By: JN
Checked By: DL
File: WAT-2
Rev: 1/14

Rev:

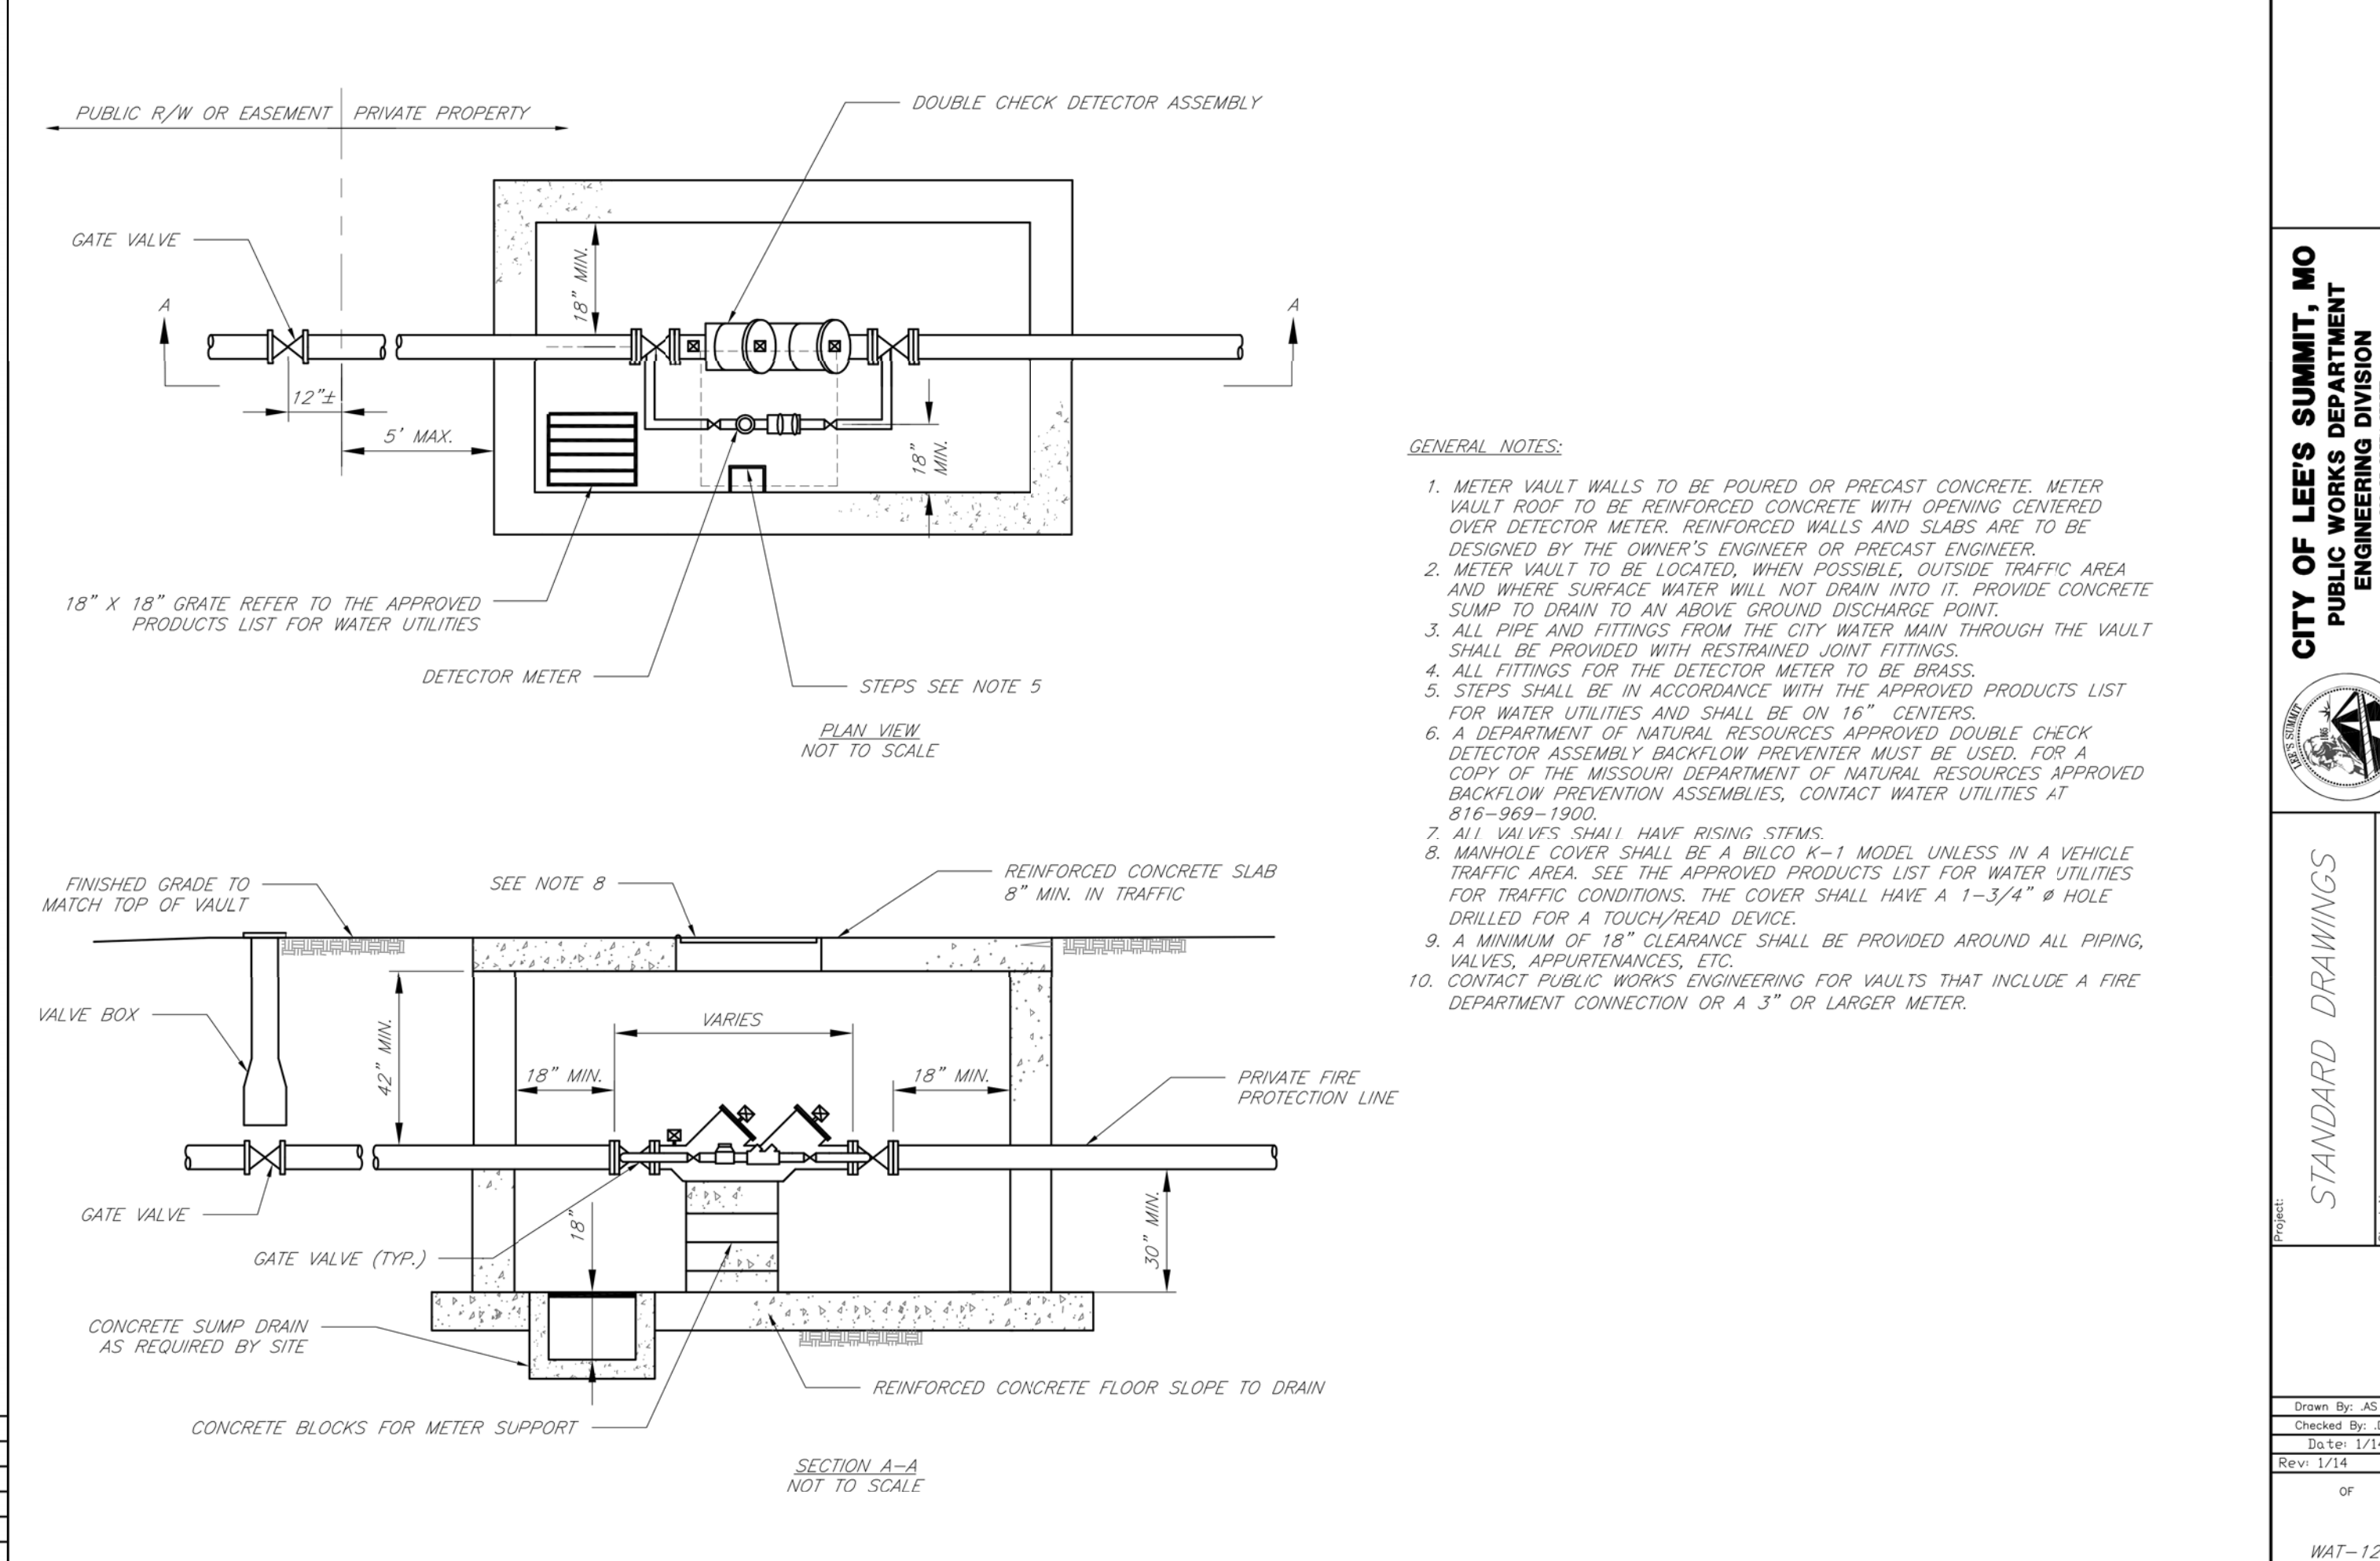

GENERAL NOTES:

1. METER VAULT WALLS TO BE POURED OR PRECAST CONCRETE. METER VAULT ROOF TO BE REINFORCED CONCRETE WITH OPENING CENTERED OVER DETECTOR METER. REINFORCED WALLS AND SLABS ARE TO BE DESIGNED BY THE OWNER'S ENGINEER OR PRECAST ENGINEER.
2. METER VAULT TO BE LOCATED, WHEN POSSIBLE, OUTSIDE TRAFFIC AREA AND WHERE SURFACE WATER WILL NOT DRAIN INTO IT. PROVIDE CONCRETE SUMP TO DRAIN TO AN ABOVE GROUND DISCHARGE POINT.
3. ALL PIPE AND FITTINGS FROM THE CITY WATER MAIN THROUGH THE VAULT SHALL BE PROVIDED WITH RESTRAINED JOINT FITTINGS.
4. ALL FITTINGS FOR THE DETECTOR METER TO BE BRASS.
5. STEPS SHALL BE IN ACCORDANCE WITH THE APPROVED PRODUCTS LIST FOR WATER UTILITIES AND SHALL BE ON 16\"/>

LS

LEE'S SUMMIT
MISSOURI
STANDARD DRAWINGS

Date: 02/13
Drawn By: JN
Checked By: DL
File: WAT-12
Rev: 1/14

Rev:

REVISIONS:

NO.	DATE
ORIGINAL	08/26/2019
1	09/27/2019

THIS SHEET HAS BEEN SIGNED SEALED AND
DATE/ELECTRONICALLY

STATE OF MISSOURI
TIMOTHY D. CROCKETT
PROFESSIONAL ENGINEER
NUMBER
25004000775
MISSOURI LICENSE - 2004000775

PREPARED BY:
CROCKETT
ENGINEERING CONSULTANTS
2610 S. W. MISSOURI
COLUMBIA, MO 65203
www.crockettingeering.com
Crockett Engineering Consultants, LLC
Missouri License of authority
25004000775

OWNER:

NEW TIG-STORAGE MART
PARTNERS PORTFOLIO
2610 STADIUM BLVD. SUITE 207
COLUMBIA, MO 65203

DRAWING INCLUDES:

WATER DETAILS

DESIGNED:

TDC

DRAWN:








JEE

PROJECT NO.:

170504

SHEET:

  CE 10

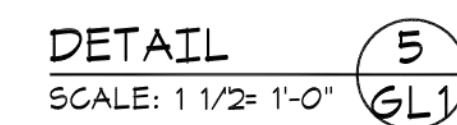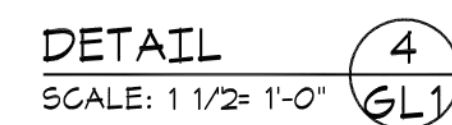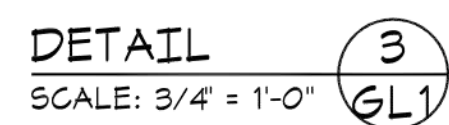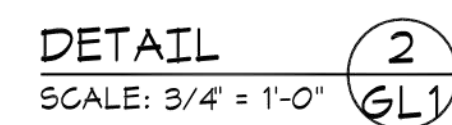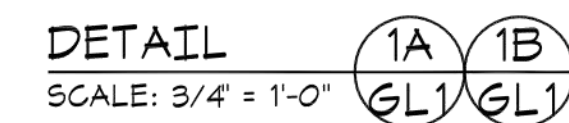

ISSUANCE INFORMATION:	
O. ORIGINAL	DATE
	08/26/2019
THIS SHEET HAS BEEN SIGNED, SEALED AND DATED ELECTRONICALLY	
	
TIMOTHY D. CROCKETT MO LICENSE - 2004000775	
	
Crockett Engineering Consultants, LLC Missouri Certificate of Authority #2000010001	
NEW TIG STORAGE/ART PARTNERS PORTELL 215 N. STAMPA RD. SUITE #207 COLUMBIA, MO 65203	


STORAGE MART 156

3920 S. STATE ROUTE 291
SECTION 3, TOWNSHIP 47 NORTH, RANGE 31 WEST
LEE'S SUMMIT, JACKSON COUNTY, MISSOURI

DRAWING INCLUDES:


SECURITY GATE DETAILS

DESIGNED:	TDC
DRAWN:	JEE
PROJECT NO.:	170504
SHEET:	CE 11

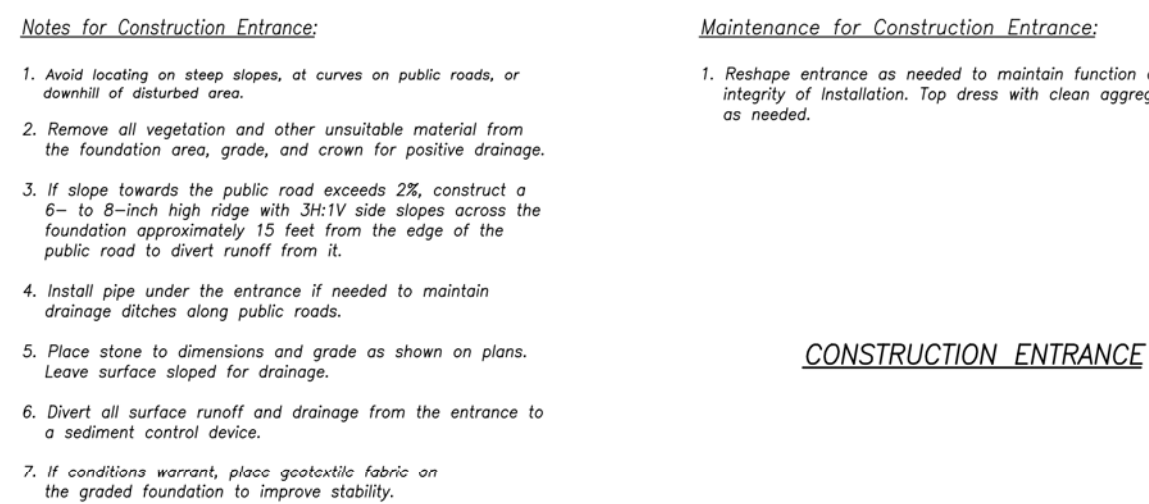



Maintenance for Concrete Washout:

1. Concrete washout materials shall be removed once the materials have been washed to a depth of 725 feet.
2. Concrete washout areas shall be enlarged as necessary to maintain capacity for wasted concrete.
3. Concrete washout water, wasted pieces of concrete and all other debris in the subsurface pit shall be transported from the job site in a water-tight container and disposed of properly.
4. Concrete washout areas shall remain in place until all concrete for the project is placed.
5. When concrete washout areas are removed, excavations shall be filled with suitable compacted backfill and topped, and any disturbed areas shall be restored to the original condition. The use or removal of concrete washout areas shall be stabilized.

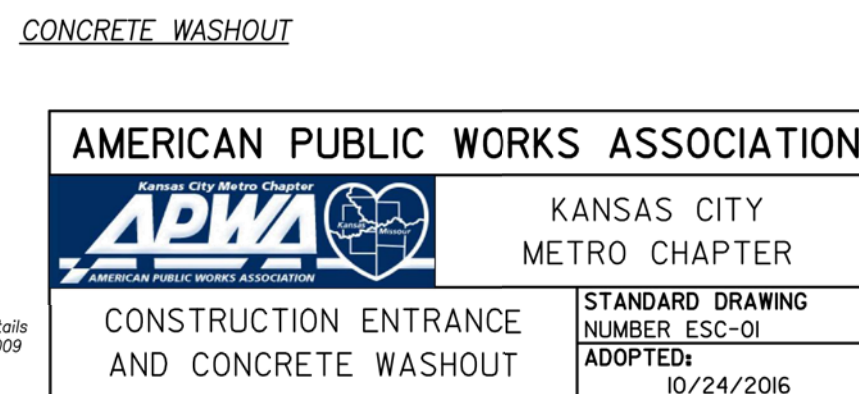


Notes for Installation on Slopes:

  1. Erosion Control Blankets and TRMs shall be laid in the direction of the slope, in order for blanket to be in contact with the soil, lay blanket loosely, avoiding stretching.
2. **ANCHOR SLOTS:** The top of the blanket should be "slotted in" at the top of the slope and anchored in place with anchors 8 inches apart. The slots should be 6 inches wide x 6 inches deep with the blanket anchored in the bottom of the slot, then backfilled, tamped and seeded.
3. **SPLICE SEAM:** When splices are necessary, overlap end a minimum of 8 inches in direction of water flow. Stagger splice seams.
4. **TERMINAL FOLD:** The bottom edge of the blanket shall be turned under a minimum of 4 inches, then anchored in place with anchors 9 inches apart.



SILT FENCE LAYOUT
Not to Scale

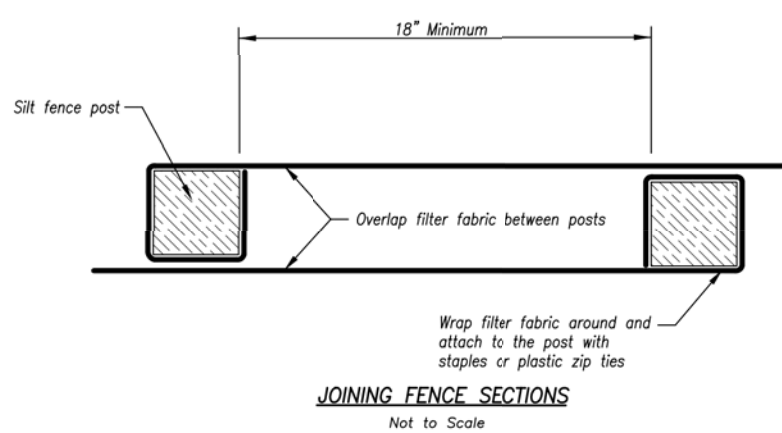

Maintenance:

1. Remove and dispose of sediment deposits when the deposit approaches $\frac{1}{2}$ the height of silt fence.
2. Repair as necessary to maintain function and structure.

Maintenance:



WATTLES AND BIODEGRADABLE LOG

 


Figure 1
(Perimeter Control)

Figure 2
(Steep Slopes)

Notes for Wattles and Biodegradable Log Slope Protection:


1. The Slope barriers shall be placed along contour lines, with a short section turned up grade at each end of the barrier. The maximum length of the slope barrier shall not exceed 250 feet, and the barrier ends need to be staggered.
2. Install wattles and biodegradable logs per manufacturer's instructions.
3. Spacing of stakes per manufacturer's instructions with 4' max. spacing. Length of stakes shall be a minimum of 2 times the diameter of the log with minimum of 24".

Notes for Mulch and Compost Filter Beam

1. The sediment control berm shall be placed uncompact in the window of locations shown on the plans or as directed by the engineer.
2. Parallel to the base of the slope, or around the perimeter of other affected areas, construct a 1 to 3 foot high berm (see Figure 1) to prevent erosion. For maximum water treatment ability or for steep slopes, construct a 1.5 to 3 foot high trapezoidal berm that is 1.5 to 3 feet wide at the top (see Figure 2). In extreme conditions, or where specified by the engineer, a second berm shall be constructed at the top of the slope. Erosion control berm requirements are shown in Figure 3.
3. If berm is to be left as permanent or part of the natural landscape, the compost berm may be seeded during application for permanent vegetation.
4. Do not use compost or wood mulch berms in any runoff channels or concentrated flow areas.
5. Wood mulch shall consist of tree and shrub debris resulting from clearing and grading and shall be ground to a maximum of 1/2" in diameter. Homogeneous top grade or other approved method.
6. Apply wood mulch at a maximum thickness of 2" and a maximum length of 10".





Maintenance for Mulch and Compost Filter Bagm:

1. Berm shall be reshaped and material added as necessary to maintain function and dimensions.
2. Breaches in the berm shall be repaired promptly.

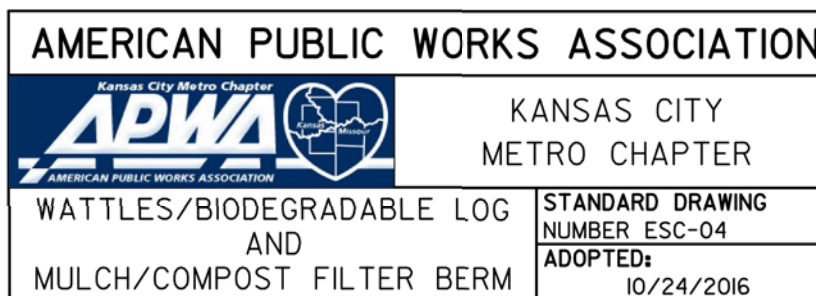

Modified from 2015 Overland Park Standard Details
for Erosion and Sediment Control.

REVISIONS:	
NO.	DATE
ORIGINAL	08/26/2019
THIS SHEET HAS BEEN SIGNED SEALED AND DATED ELECTRONICALLY	
	
TIMOTHY D. CROCKETT MO LICENSE: 2004000775	
PREPARED BY:	
NEW/TKG-STORAGEWART ENGINEERING CONSULTANTS PARTNERS OFFICE 2515 STADIUM BLVD., SUITE 1207 COLUMBIA, MO 65203 631.447.0542 www.crockettengineering.com Crockett Engineering Consultants, LLC Missouri Professional Engineer #2000191361	
OWNER:	NEW/TKG-STORAGEWART ENGINEERING CONSULTANTS PARTNERS OFFICE 2515 STADIUM BLVD., SUITE 1207 COLUMBIA, MO 65203
STORAGE MART 156 3920 S. STATE ROUTE 291 SECTION 3, TOWNSHIP 47 NORTH, RANGE 31 WEST LEE'S SUMMIT, JACKSON COUNTY, MISSOURI	
DRAWING INCLUDES: EROSION CONTROL DETAILS	
DESIGNED:	TDC
DRAWN:	JEE
PROJECT NO.:	170504
SHEET:	CE 12

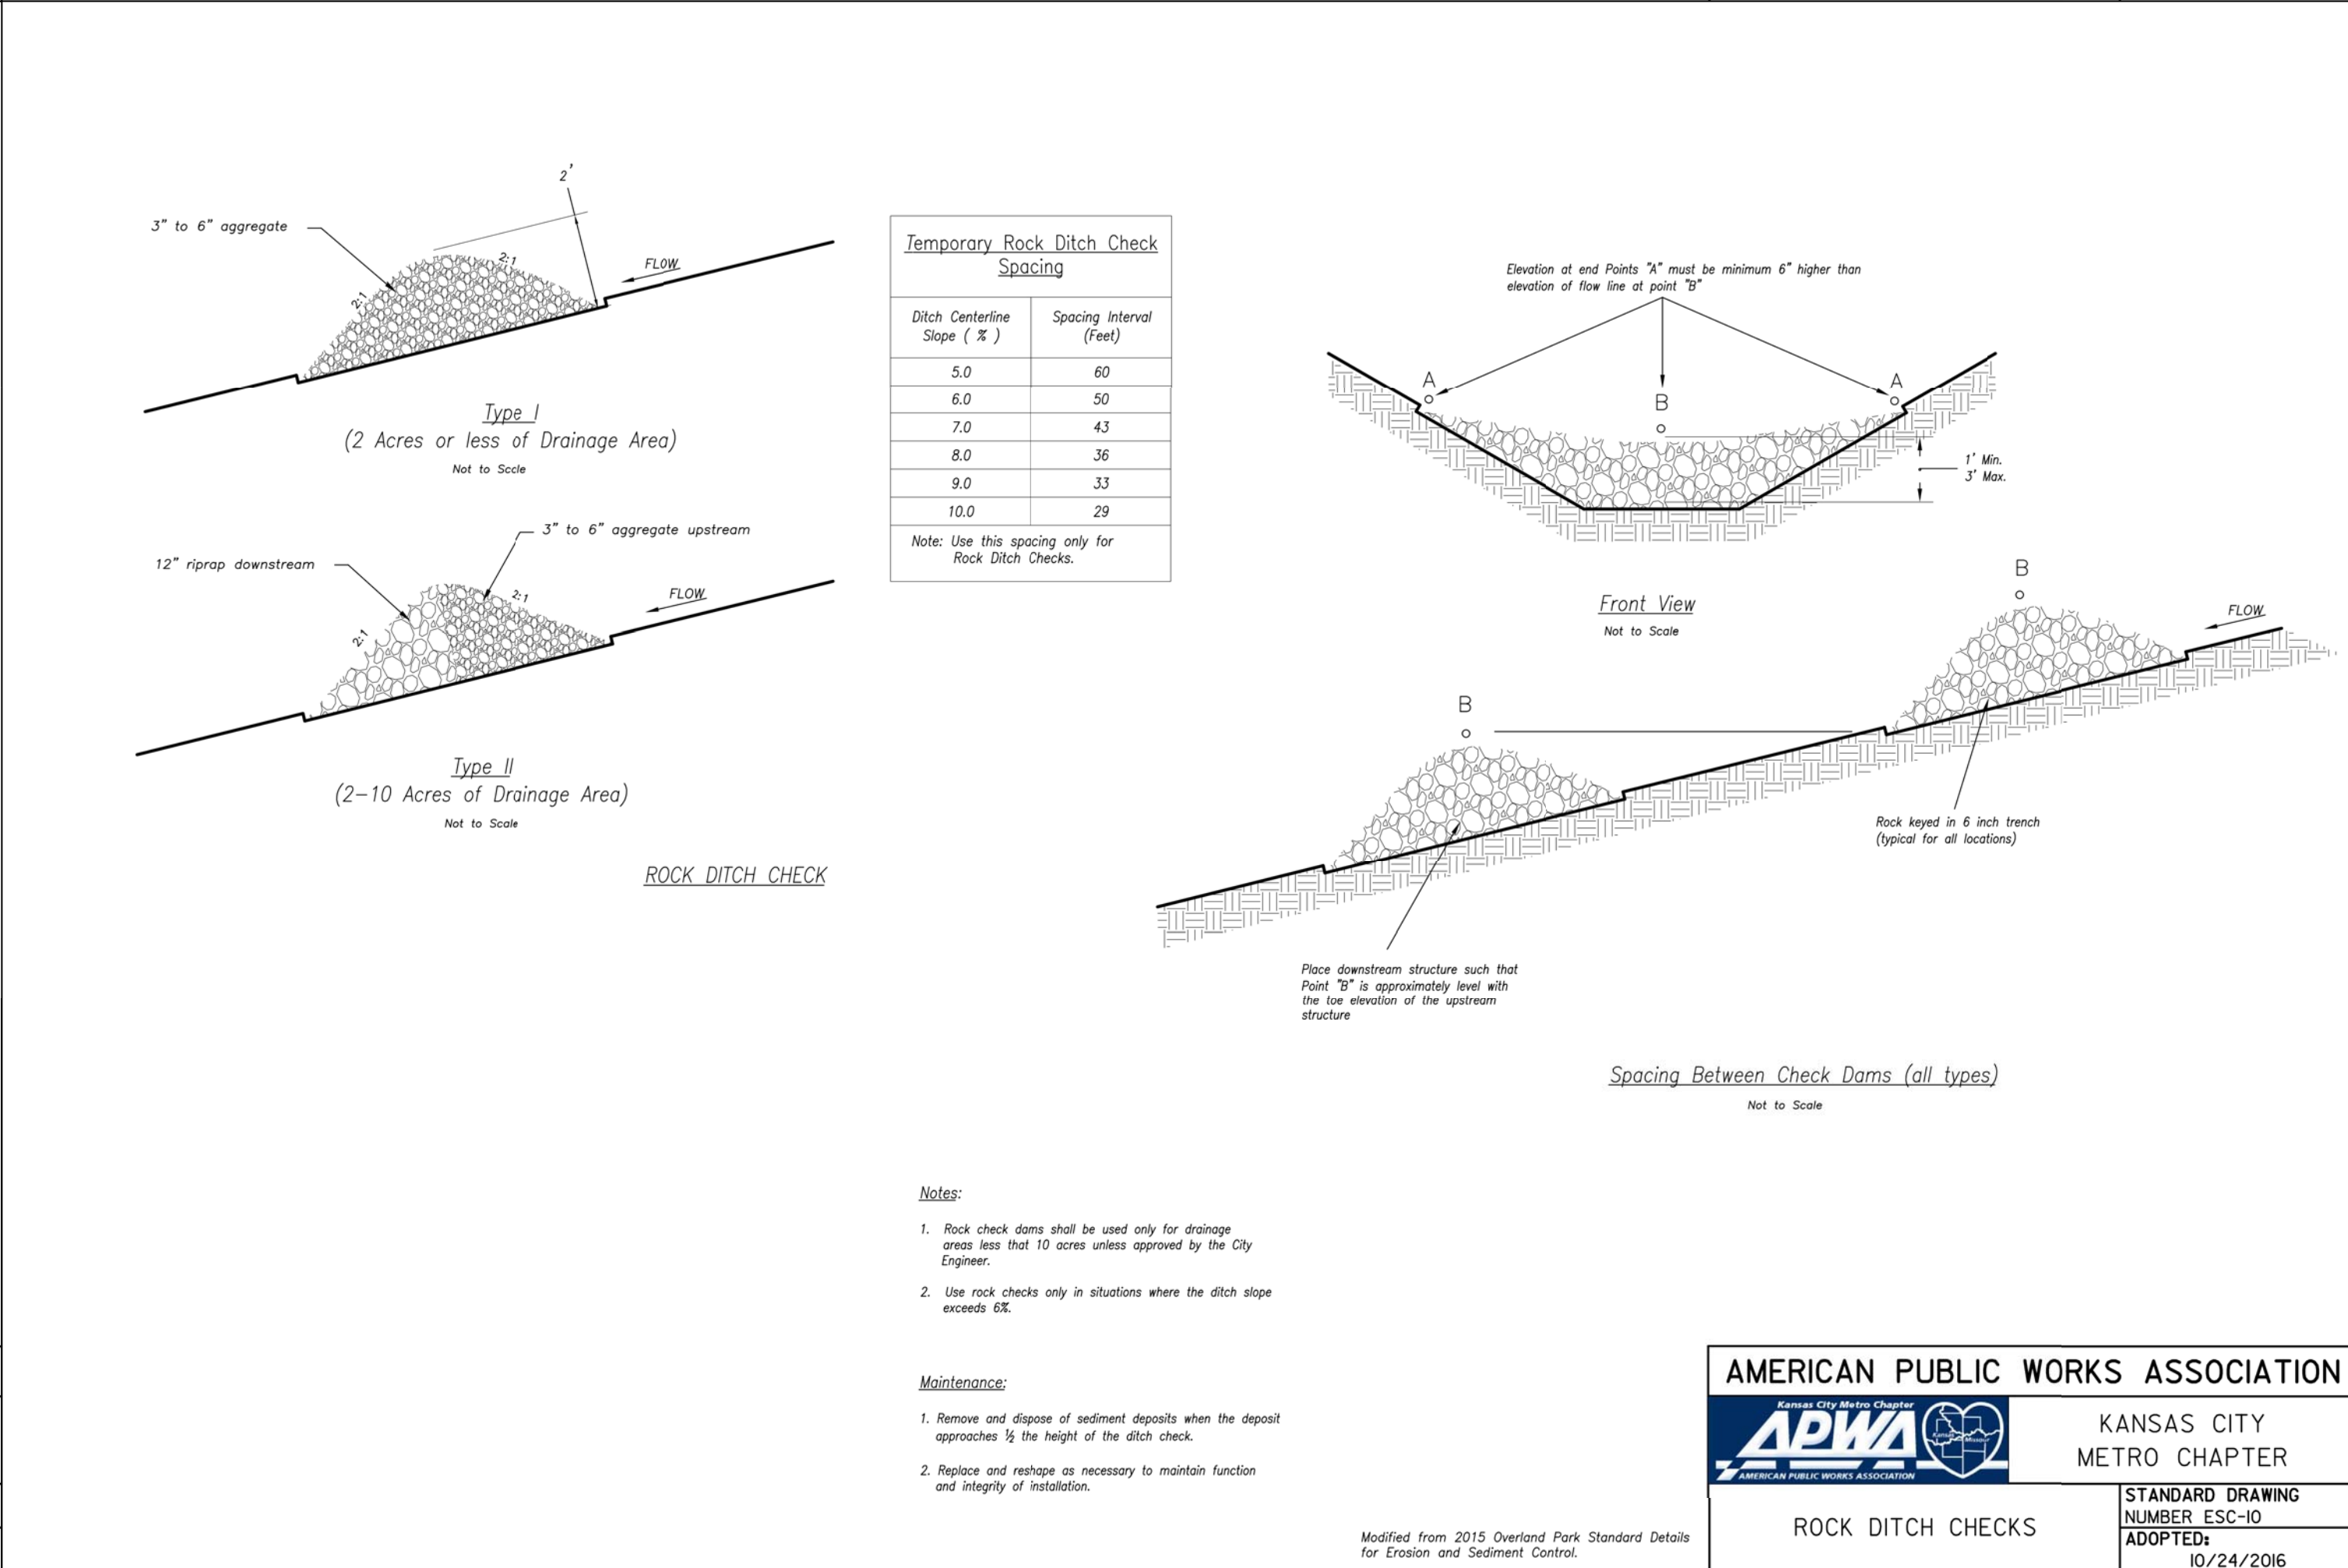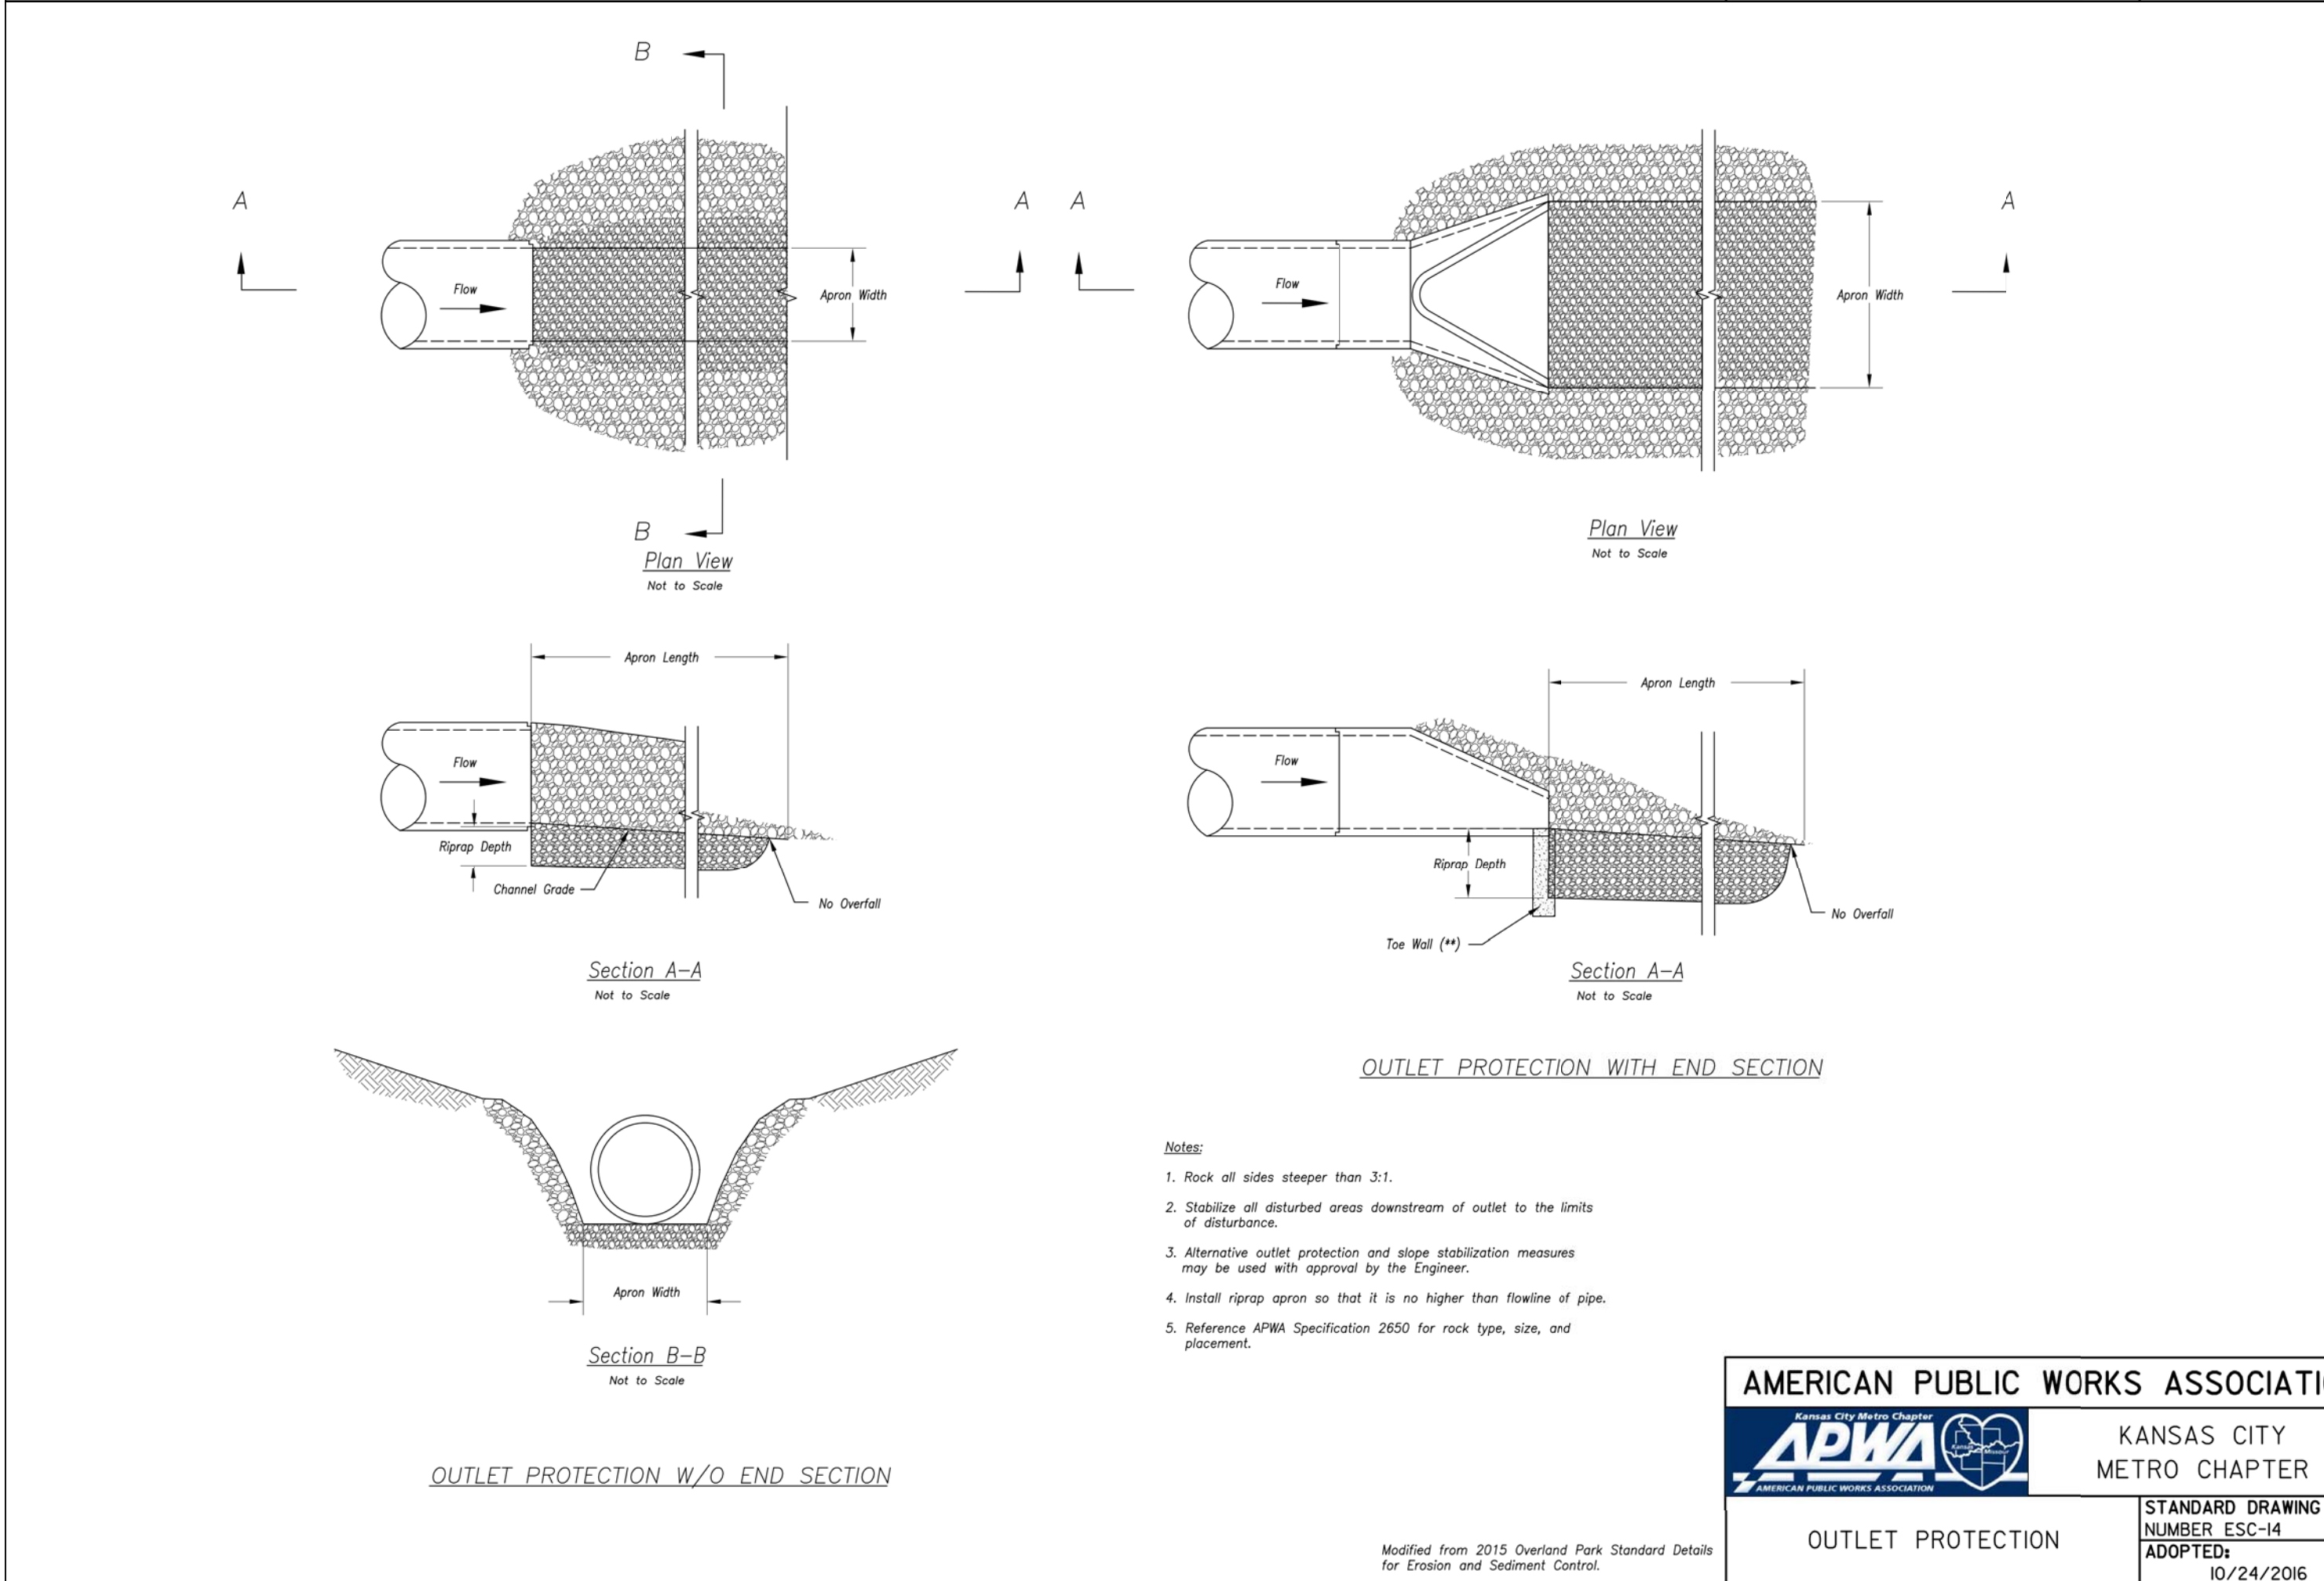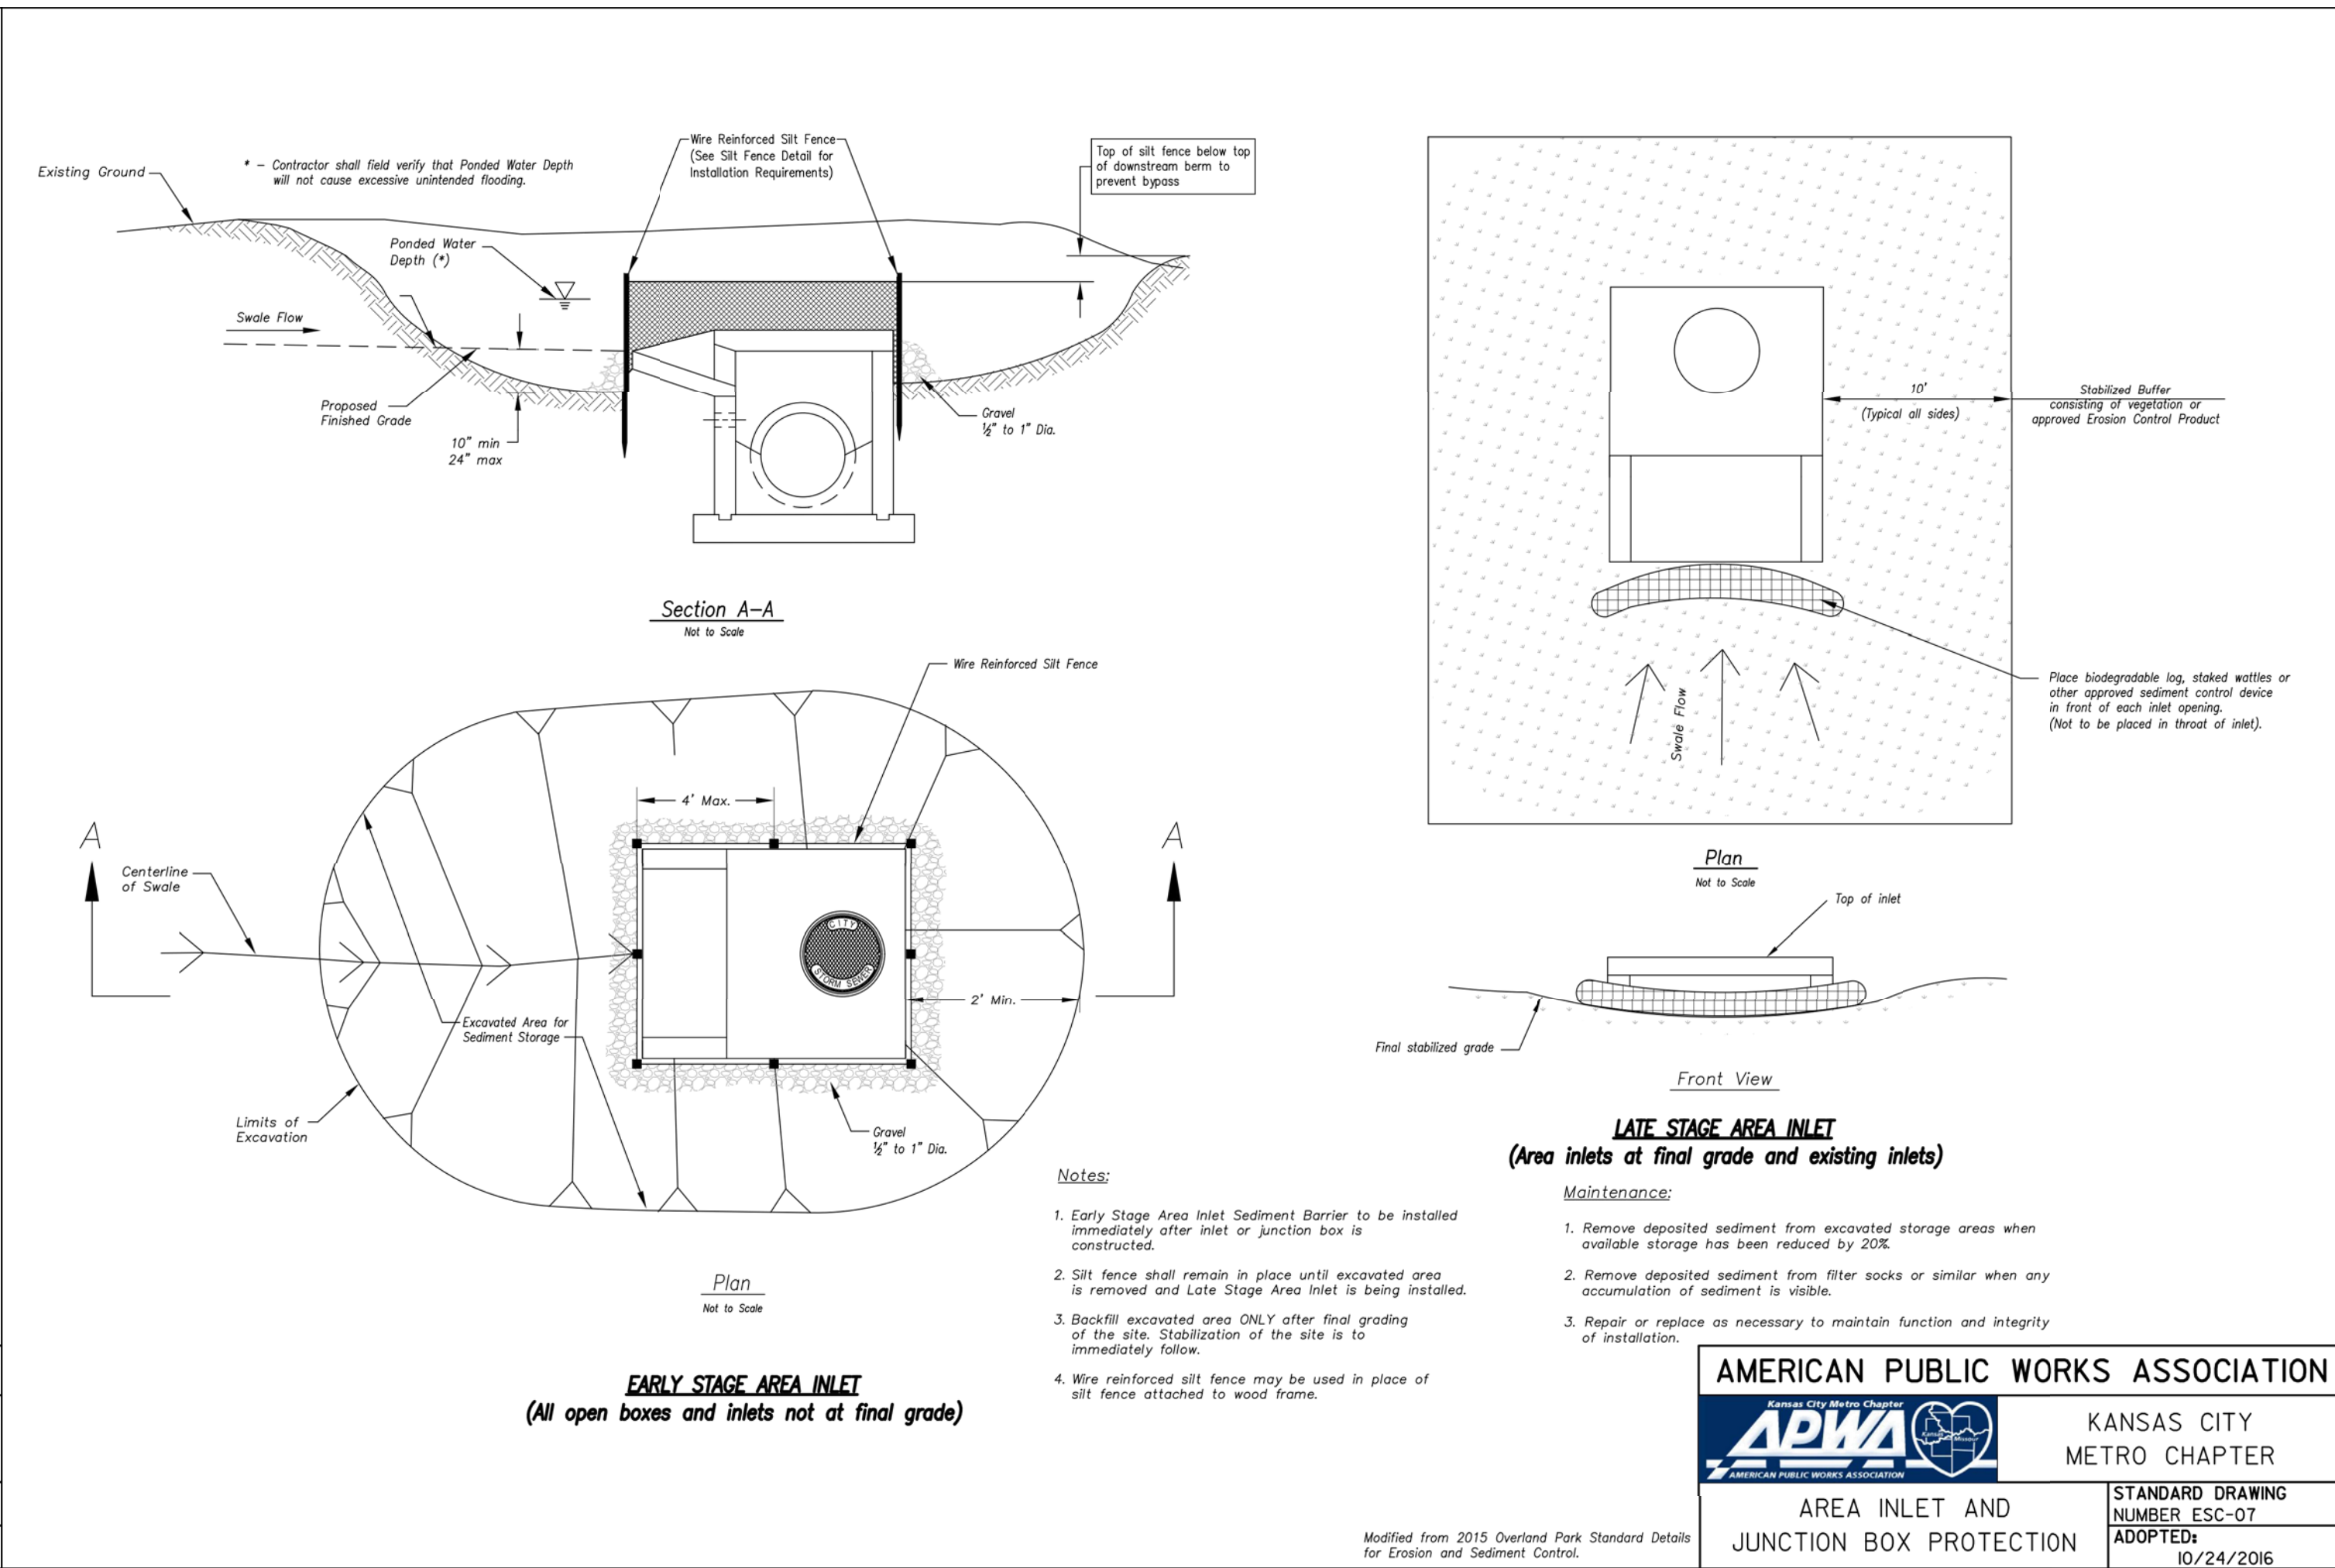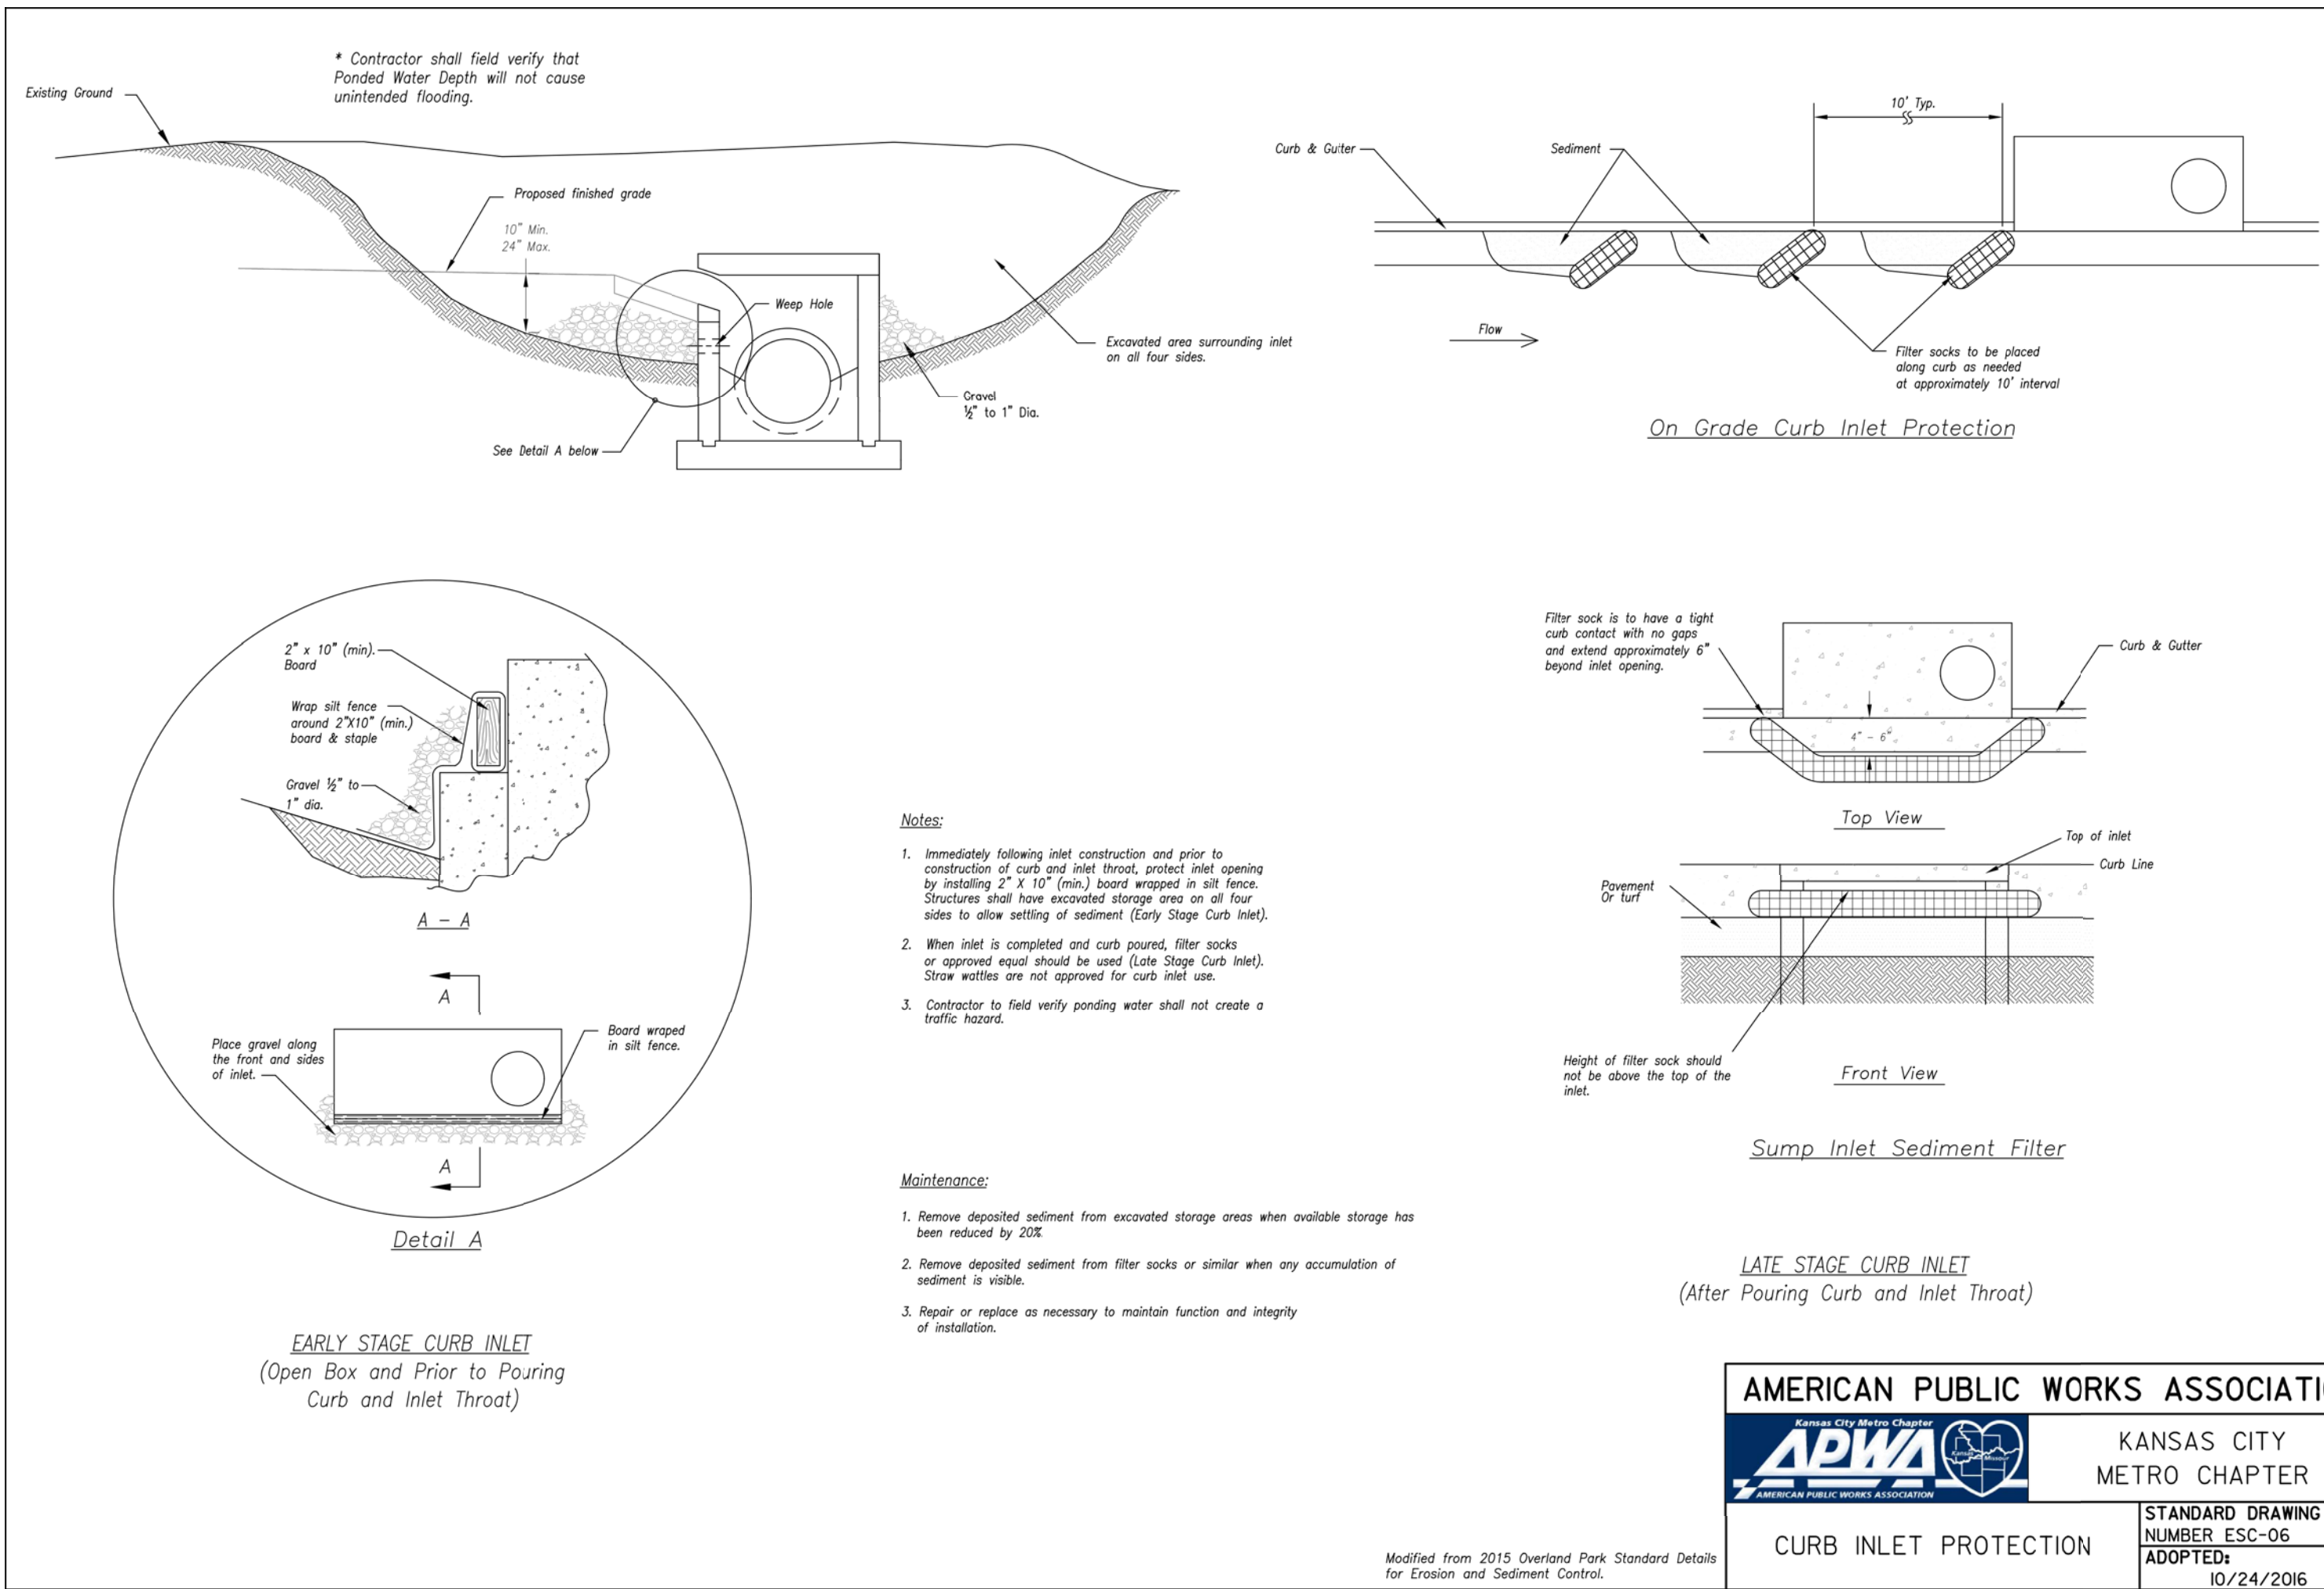

REVISIONS:

NO.	DATE
ORIGINAL	08/26/2019

THIS SHEET HAS BEEN SIGNED, SEALED AND DATED ELECTRONICALLY

STATE OF MISSOURI

PROFESSIONAL ENGINEER

NUMBER 25-0004000775

TIMOTHY D. CROCKETT

MO LICENSE - 2004000775

PREPARED BY:

CROCKETT

ENGINEERING CONSULTANTS

2650 N. W. 10th Street

Columbia, MO 65203

(314) 447-0292

www.crockettingeering.com

Crockett Engineering Consultants, LLC

Missouri License of Authority

0000000001

OWNER:

NEW TIG STOREMART

PARTNERS PORTFOLIO

2650 N. W. 10th Street

SUITE 207

COLUMBIA, MO 65203

STORAGE MART 156

3920 S. STATE ROUTE 291

SECTION 3, TOWNSHIP 47 NORTH, RANGE 31 WEST

LEE'S SUMMIT, JACKSON COUNTY, MISSOURI

DRAWING INCLUDES:

 
EROSION CONTROL DETAILS (CONT.)

DESIGNED: TDC

DRAWN: JEE

PROJECT NO.: 170604


SHEET: CE 13




Site Lighting Design Drawings for

Storage Mart Addition

3920 South State Route 291
Lee's Summit, Jackson County, Missouri

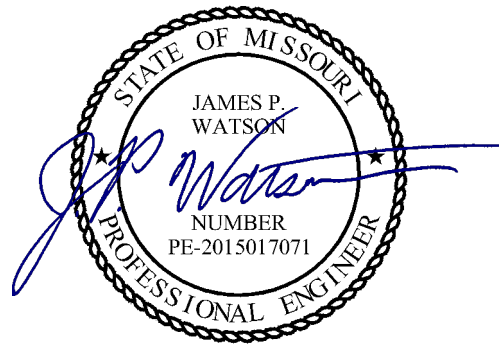

James Watson, P.E. May 17, 2019
PE-2015017071
MO Certificate of Authority # 2018029680

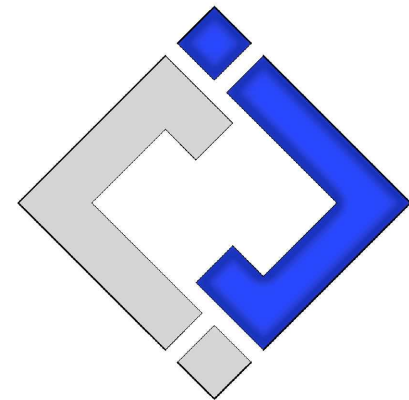

J-SQUARED
ENGINEERING

630 North Morley Street, Suite 102
Moberly, Missouri 65270
573 - 234 - 4492 phone
www.j-squaredeng.com

J2 PROJECT No:	J20038
J2 DESIGN:	JAP

ISSUE TITLE		DATE
PERMIT SET		05 - 17 - 2019

GENERAL MEP SPECIFICATIONS

- IT IS THE RESPONSIBILITY OF THE CONTRACTOR TO REVIEW AND UNDERSTAND ALL DRAWINGS AND SPECIFICATIONS IN THE CONTRACT DOCUMENTS. EACH CONTRACTOR IS RESPONSIBLE FOR ALL WORK ASSOCIATED WITH HIS TRADE REGARDLESS OF WHERE THE WORK IS DEPICTED IN THE DRAWINGS OR SPECIFICATIONS.
- THE LAYOUT OF SYSTEMS SHOWN ON PLANS ARE APPROXIMATE AND WILL NEED TO BE COORDINATED IN FIELD. THE CONTRACTOR SHALL INCLUDE THIS COORDINATION IN HIS SCOPE AND INCLUDE ALL COSTS OF MODIFYING THE LAYOUT AS REQUIRED IN HIS BID.
- THE CONTRACTOR IS RESPONSIBLE FOR PROVIDING ALL NECESSARY PARTS AND LABOR TO PRODUCE A COMPLETE AND FULLY OPERATIONAL SYSTEM UNLESS STATED OTHERWISE ON PLANS.
- ALL MATERIALS TO BE NEW, FIRST CLASS, AND INSTALLED PER MANUFACTURE'S PUBLISHED INSTRUCTIONS.
- ALL WORK SHALL BE PERFORMED IN COMPLIANCE WITH LOCALLY ADOPTED CODES AND ORDINANCES.
- CONTRACTOR IS RESPONSIBLE FOR TO COORDINATE EQUIPMENT LOCATIONS AND SYSTEM ROUTING WITH OTHER TRADES PRIOR TO INSTALLATION.
- CONTRACTOR TO GUARANTEE ALL MATERIALS AND WORKMANSHIP FOR A PERIOD OF ONE YEAR FROM THE DATE THE PROJECT IS TURN OVER TO THE OWNER, UNLESS NOTED OTHERWISE.
- CONTRACTOR IS TO INCLUDE IN HIS SCOPE THE COST OF ALL PERMITS, INSPECTIONS, METERING, AND TAPS ASSOCIATED WITH HIS WORK.
- CONTRACTOR IS RESPONSIBLE FOR ALL EXCAVATION, CUTTING, CORING, PATCHING, AND BACKFILL REQUIRED TO COMPLETE HIS WORK, UNLESS NOTED OTHERWISE.
- THESE PLANS ARE NOT TO BE SCALED. SEE ARCHITECTURAL PLANS FOR DIMENSIONS. WHERE THERE IS A CONFLICT BETWEEN ARCHITECTURAL DIMENSIONS AND MEP DIMENSION, ARCHITECTURAL SHALL GOVERN.
- SEE DISCIPLINE SHEETS FOR ADDITIONAL DISCIPLINE SPECIFIC SPECIFICATIONS.

ELECTRICAL SPECIFICATIONS

- GENERAL
 - THE ENTIRE ELECTRICAL SYSTEM SHALL BE CONTINUOUSLY GROUNDED. EVERY BRANCH CONDUIT SHALL INCLUDE A GREEN GROUND CONDUCTOR SIZED PER NEC.
 - ARC-FAULT CIRCUITS SHALL BE RUN WITH A DEDICATED NEUTRAL AS REQUIRED BY MANUFACTURER.
 - PROVIDE PERMANENT ARC-FLASH LABEL AFFIXED TO EVERY DISCONNECT AND PANEL.
 - PROVIDE TYPE WRITTEN PANEL SCHEDULE FOR EACH PANEL.
- MATERIALS
 - CONDUIT & CONDUCTORS
 - ALL CONDUCTORS SIZES INDICATED ON PLANS ARE COPPER UNLESS NOTED OTHERWISE.
 - ABOVE GRADE CONDUCTORS SHALL BE THHN COPPER. BELOW GRADE CONDUCTORS SHALL BE XHHW-2.
 - MINIMUM CONDUCTOR SIZE SHALL BE #12 UNLESS NOTED OTHERWISE. 120V, 20 AMP CIRCUITS WITH CONDUCTOR LENGTH GREATER THAN 100' SHALL BE MINIMUM #10. ELECTRICAL CONTRACTOR IS RESPONSIBLE FOR MEASURING ACTUAL CONDUCTOR LENGTH AND INCREASING CONDUCTOR SIZE TO COMPENSATE FOR VOLTAGE DROP AS REQUIRED BY NEC.
 - RIGID GALVANIZED OR SCHEDULE 40 PVC CONDUIT SHALL BE USED FOR SERVICE WIRING, BELOW GRADE INSTALLATIONS, OR WHERE EXPOSED TO WEATHER.
 - IN APPLICATIONS OTHER THAN THOSE LISTED IN 2.1.4, EMT OR MC CABLE IS ACCEPTABLE. WHERE CONDUCTORS ARE PROTECTED FROM DAMAGE, ENCLOSED IN BUILDING MATERIALS, AND CONSTRUCTION IS OF A PERMITTED TYPE, NM CABLE MAY BE USED.
 - DEVICES
 - CONTRACTOR TO PROVIDE J-BOXES, COVER PLATES, AND ANY ACCESSORIES REQUIRED TO PROVIDE A COMPLETE SYSTEM. SEE ARCHITECTURAL PLANS FOR DEVICE COLORS.
 - DUPLEX RECEPTACLES SHALL BE TAMPER RESISTANT, 20 AMP, EQUAL TO LEVITON CR20.
 - TOGGLE WALL SWITCHES SHALL BE EQUAL TO LEVITON CSI20-2
 - DIMMER SWITCHES SHALL BE TESTED WITH FIXTURES AND LAMPS FOR COMPATIBILITY.

REFERENCED CODES IN EFFECT

2014 NATIONAL ELECTRIC CODE

2015 INTERNATIONAL ENERGY CONSERVATION CODE

SHEET INDEX

- | | | |
|----|-------|---------------------------|
| 1. | EL001 | SITE LIGHTING COVER SHEET |
| 2. | EL101 | SITE LIGHTING PLAN |

Site Lighting Design Drawings for

Storage Mart Addition

3920 South State Route 291
Lee's Summit, Jackson County, Missouri

SHEET TITLE

SITE LIGHTING
COVER SHEET

SHEET NUMBER

EL001

EXTERIOR LIGHT FIXTURE SCHEDULE										
TAG	MANUFACTURER (OR EQUAL)	MODEL NUMBER (OR EQUAL)	DESCRIPTION	MOUNTING	LUMEN OUTPUT	CCT (°K)	CRI	VOLTS	WATTS	NOTES
WP1	MCGRAW-EDISON	GWC-AF-02-LED-EI-T4FT-P	WALL PACK	EXTERIOR WALL	12874	4000	70	120	113	MOUNTED ON EXTERIOR WALL, TOP OF FIXTURE AT 15' ABOVE FINISHED GRADE. WITH PHOTOCELL.
WP2	MCGRAW-EDISON	GWC-AF-02-LED-EI-SL3-P	WALL PACK	EXTERIOR WALL	12424	4000	70	120	113	MOUNTED ON EXTERIOR WALL, TOP OF FIXTURE AT 15' ABOVE FINISHED GRADE. WITH PHOTOCELL.
NOTES: 1. VERIFY LIGHT FIXTURE FINISHES WITH OWNER / ARCHITECT PRIOR TO INSTALLATION										

SITE PHOTOMETRIC SUMMARY					
AREA	AVERAGE	MAXIMUM	MINIMUM	MAX / MIN	AVG / MIN
NEW PARKING	1.94 fc	5.1 fc	0.3 fc	17.0:1	6.47:1
NOTES: CALCULATIONS BASED ON 95% OF DATA POINT SOURCES, LOWER 2.5% & UPPER 2.5% OF DATA POINTS OMITTED					

LIGHTING LEGEND

- CIRCUIT WIRING
- CIRCUIT TAG
- X1


"X1" INDICATES FIXTURE TYPE (REFER TO SCHEDULE)
- EXTERIOR WALL PACK
- +

#.#

PHOTOMETRIC CALCULATIONS (IN FOOT-CANDLES)


SITE LIGHTING PLAN GENERAL NOTES:

1. SITE PHOTOMETRIC VALUES SHOWN HAVE BEEN CALCULATED PER SPECIFIED LIGHT FIXTURES AT INDICATED MOUNTING HEIGHTS. ANY CHANGES OR ALTERATIONS TO LIGHTING LAYOUT SHOWN WILL REQUIRE RECALCULATING SITE PHOTOMETRICS AND WILL THE RESPONSIBILITY OF THE ELECTRICAL CONTRACTOR / EQUIPMENT SUPPLIER.
2. PHOTOMETRIC CALCULATIONS SHOWN DO NOT INCLUDE EXISTING LIGHT FIXTURE(S), ONLY NEW WALL-PACK FIXTURE(S) SHOWN.

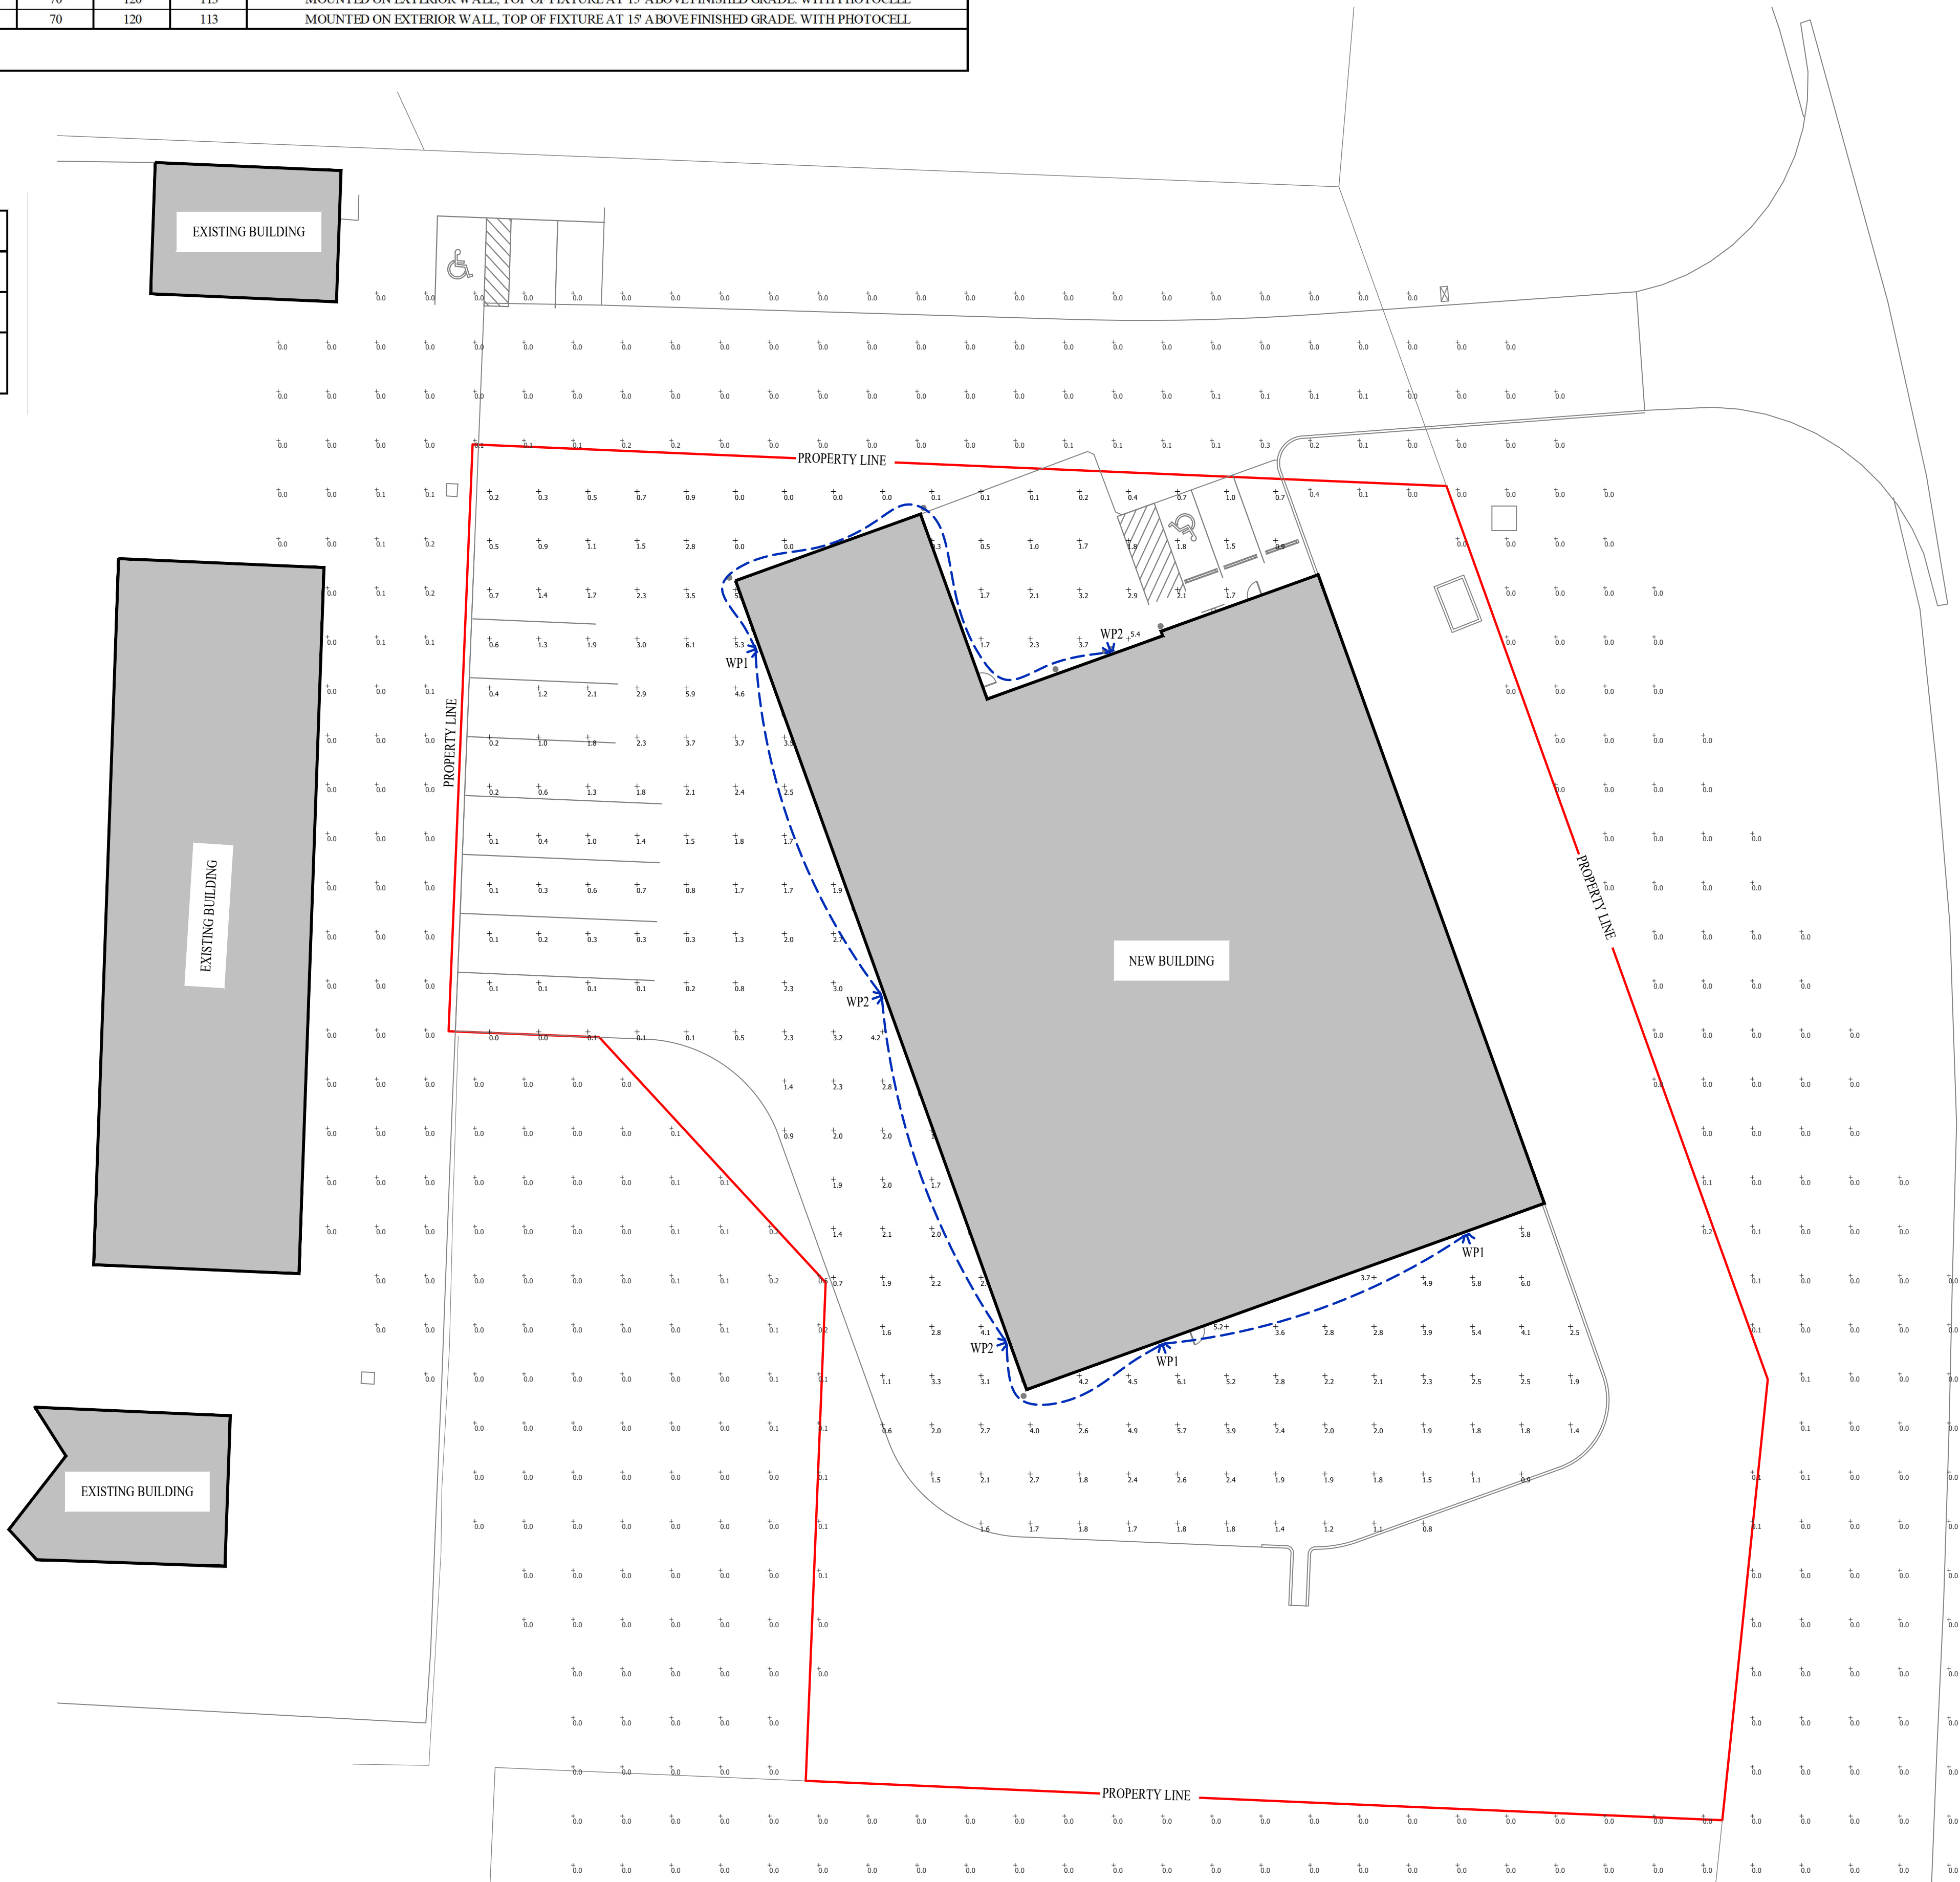


SITE LIGHTING PLAN

SCALE: 1" = 20'-0"

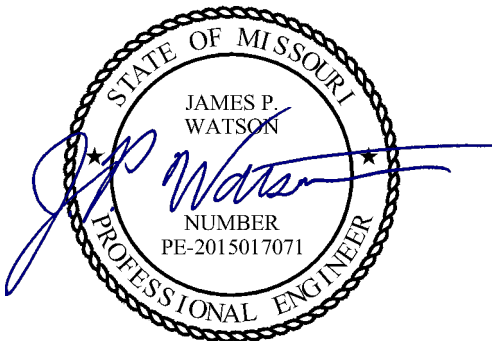

James Watson, P.E. May 17, 2019
PE-2015017071
MO Certificate of Authority # 2018029680

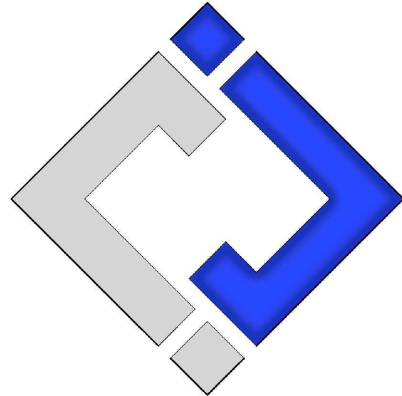

J-SQUARED
ENGINEERING

630 North Morley Street, Suite 102
Moberly, Missouri 65270
573 - 234 - 4492 phone
www.j-squaredeng.com

J2 PROJECT No: J20038

J2 DESIGN: JAP

ISSUE TITLE DATE

PERMIT SET 05 - 17 - 2019

Site Lighting Design Drawings for

Storage Mart Addition


3920 South State Route 291
Lee's Summit, Jackson County, Missouri


SHEET TITLE


SITE LIGHTING
PLAN


SHEET NUMBER

EL101

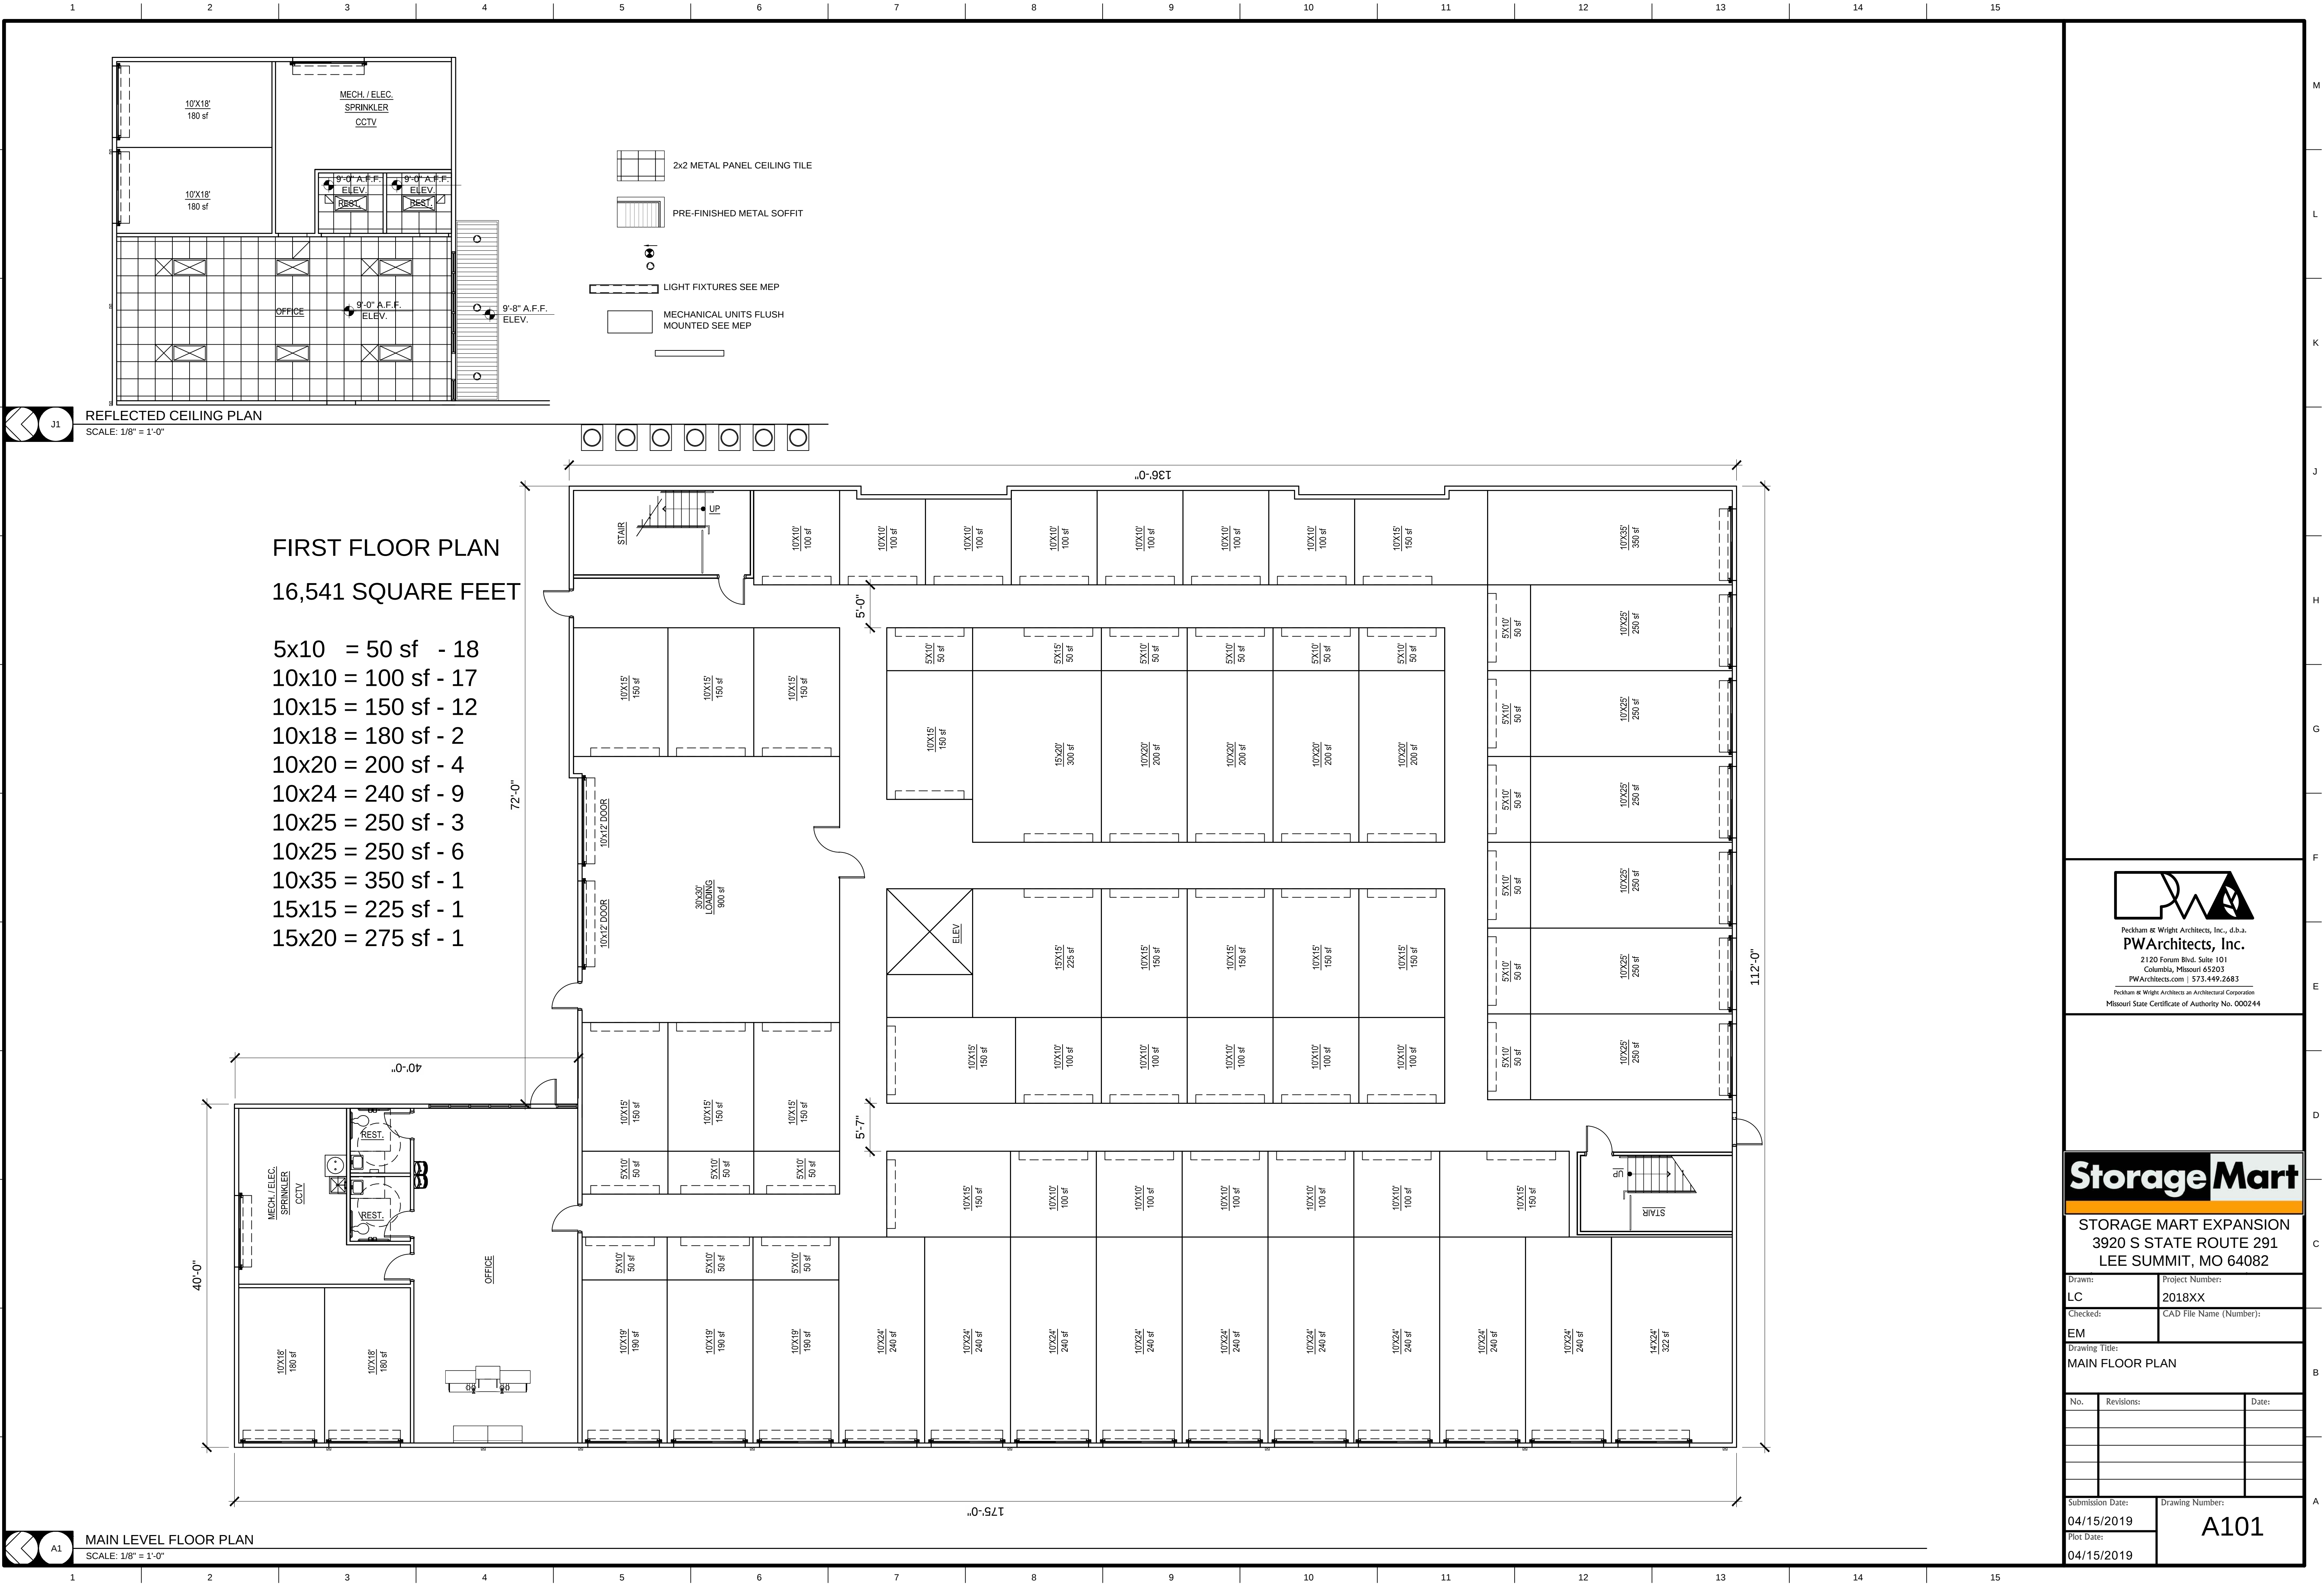

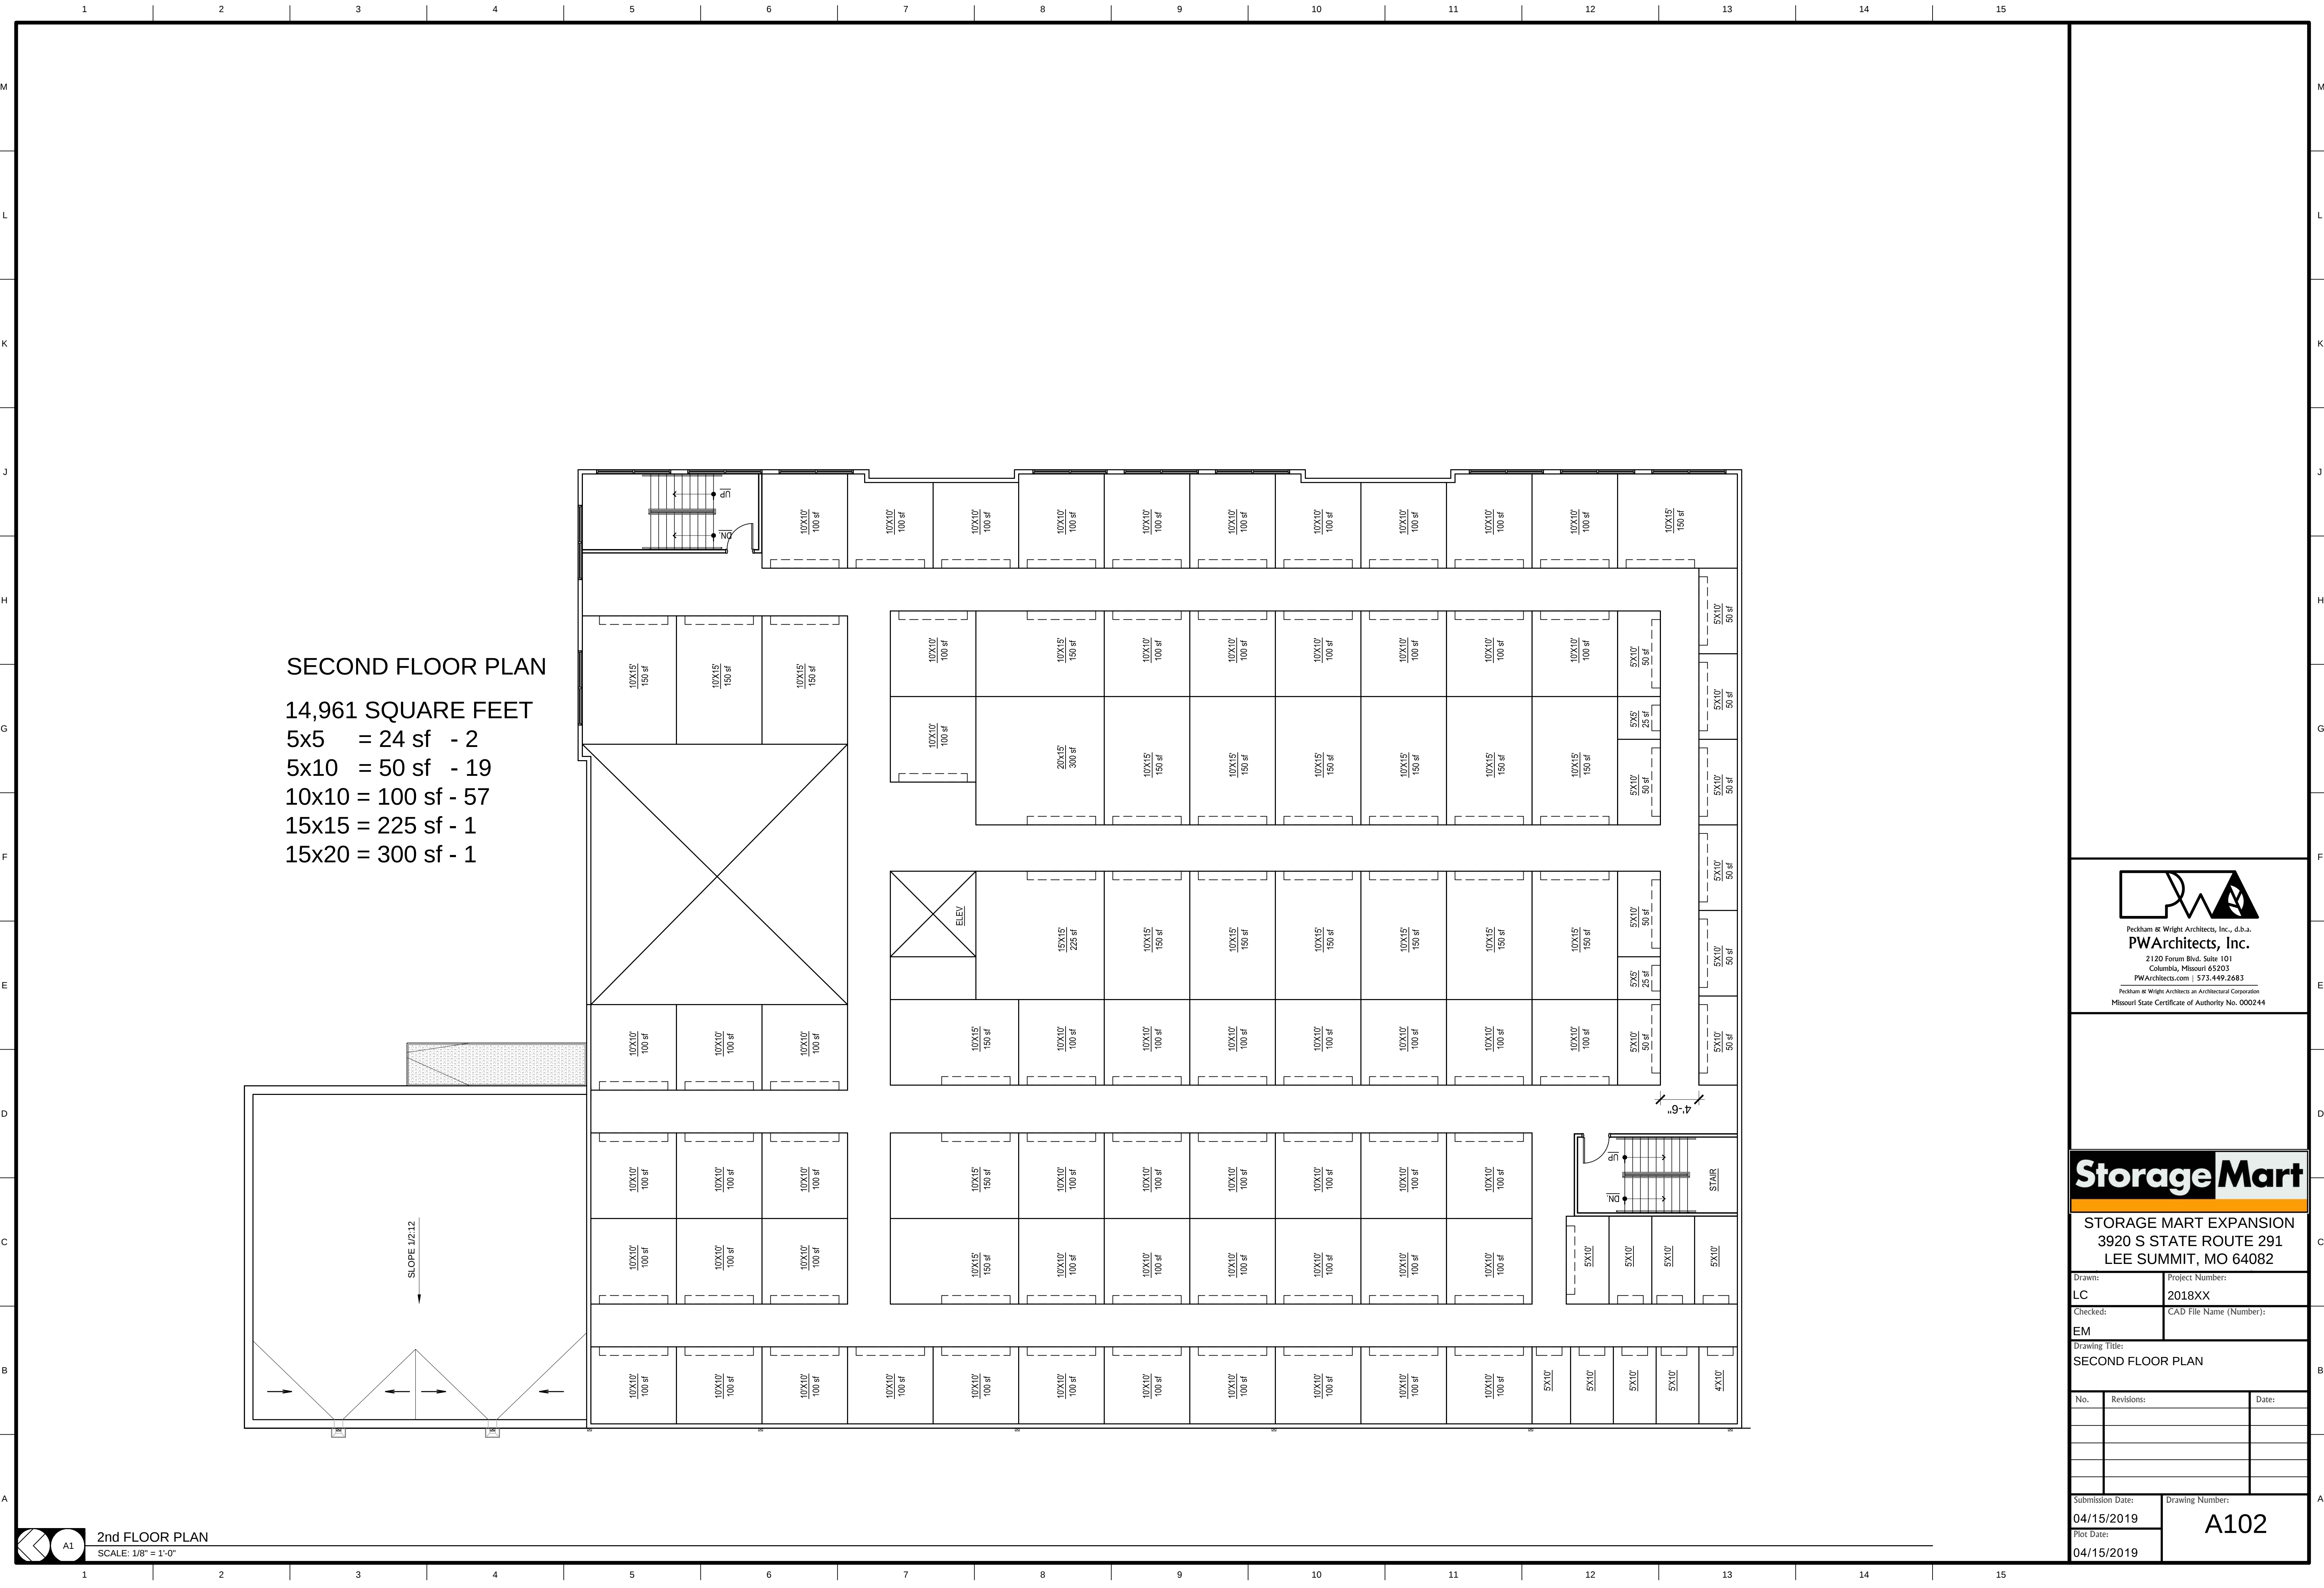

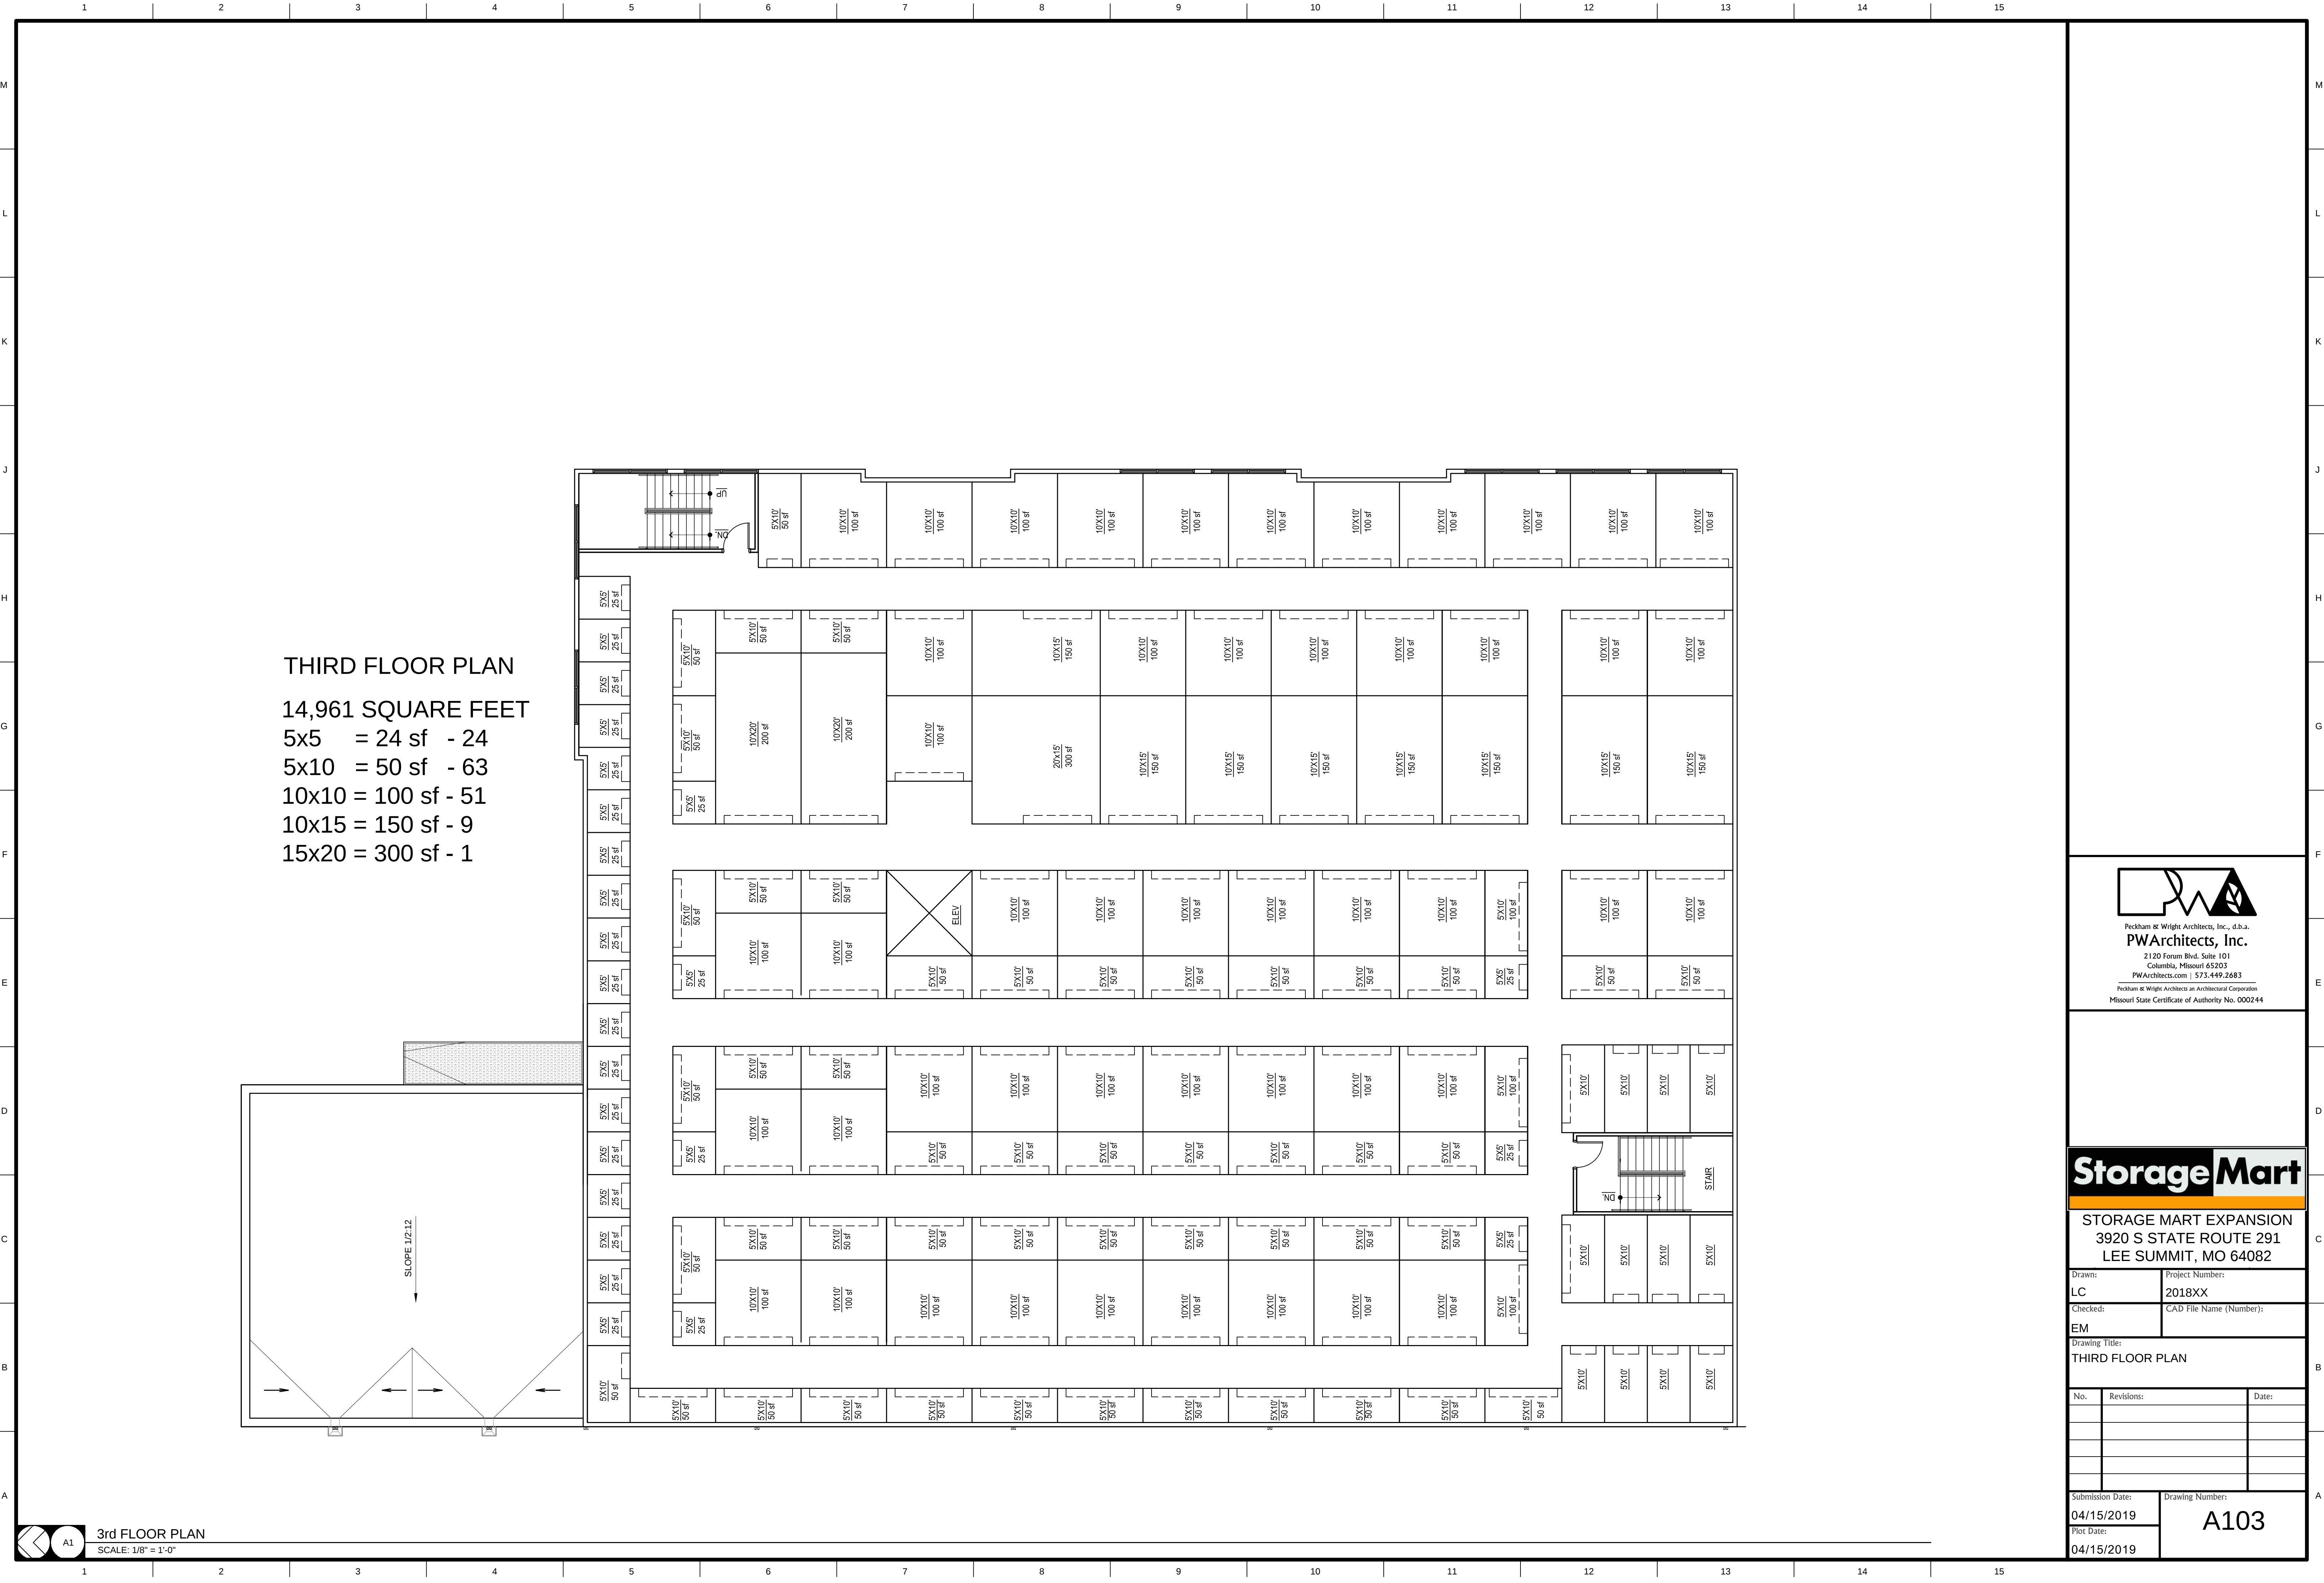

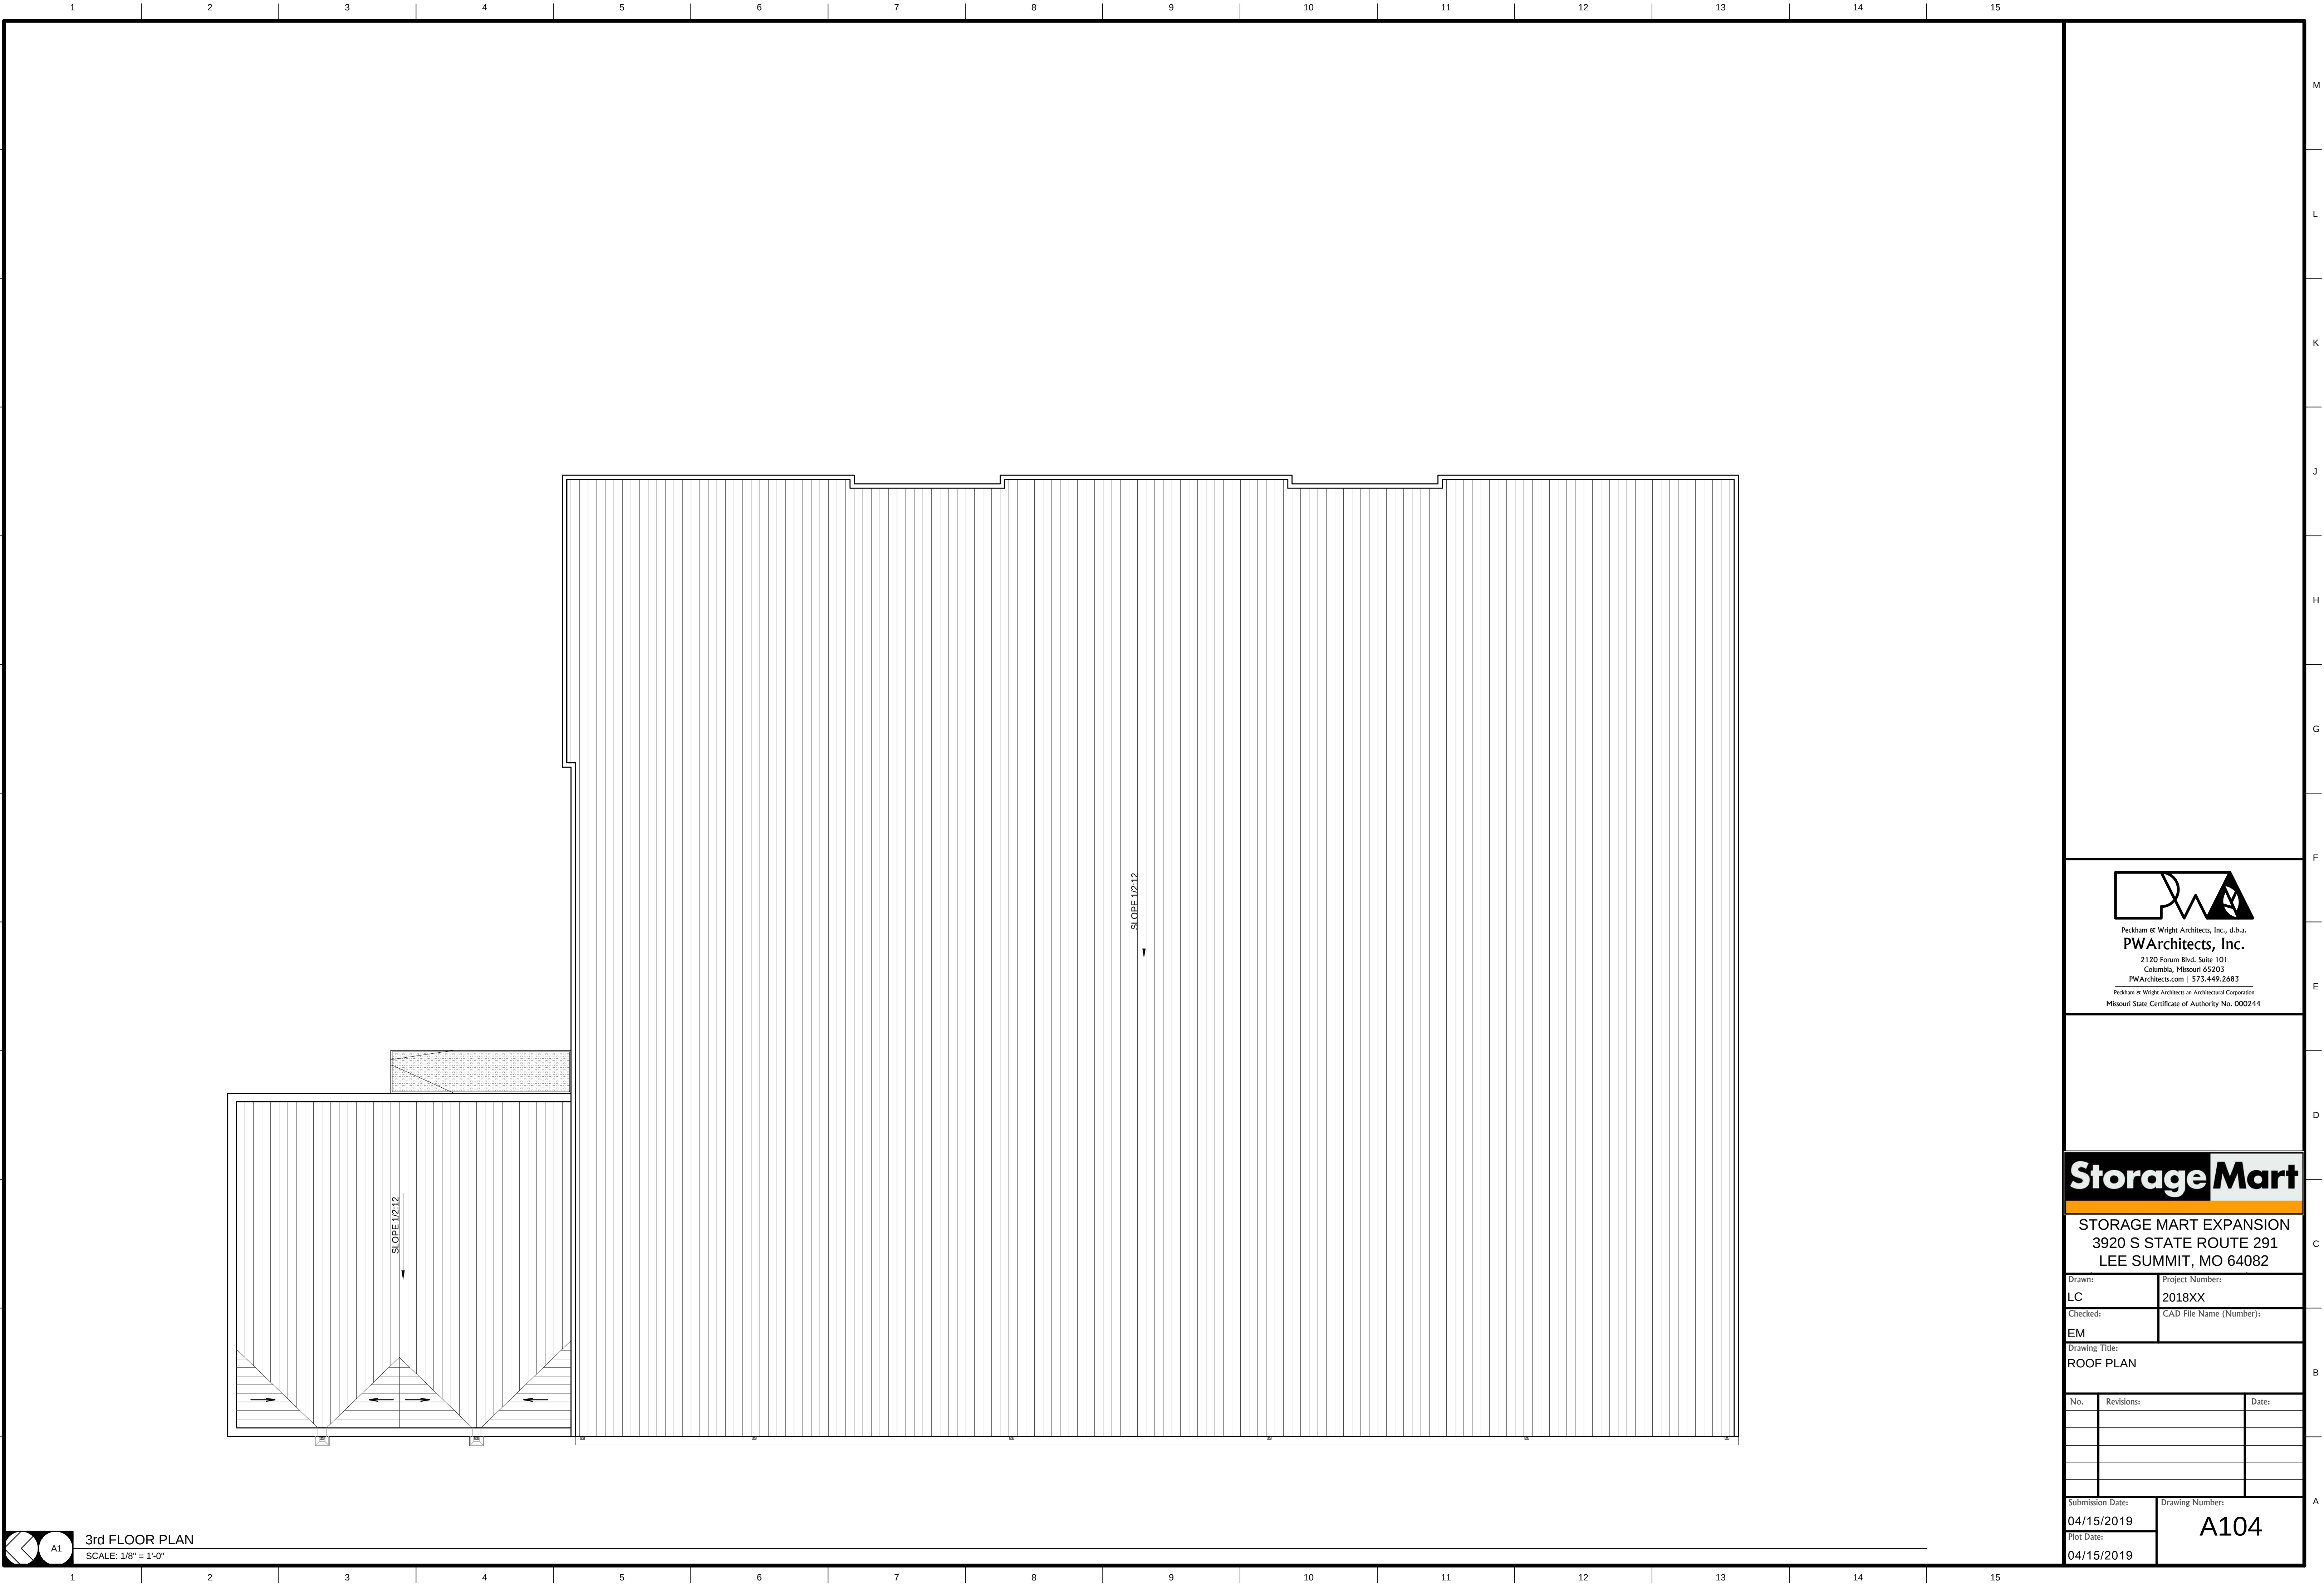



Peckham & Wright Architects, Inc., d.b.a.
PWArchitects, Inc.
2120 Forum Blvd. Suite 101
Columbia, Missouri 65203
PWArchitects.com | 573.449.2683
Peckham & Wright Architects an Architectural Corporation
Missouri State Certificate of Authority No. 000244

Storage Mart


STORAGE MART EXPANSION
3920 S STATE ROUTE 291
LEE SUMMIT, MO 64082

Drawn:	Project Number:
LC	2018XX
Checked:	CAD File Name (Number):
EM	

Drawing Title:
ROOF PLAN



No.	Revisions:	Date:

Submission Date:	Drawing Number:
04/15/2019	A104
Plot Date:	
04/15/2019	

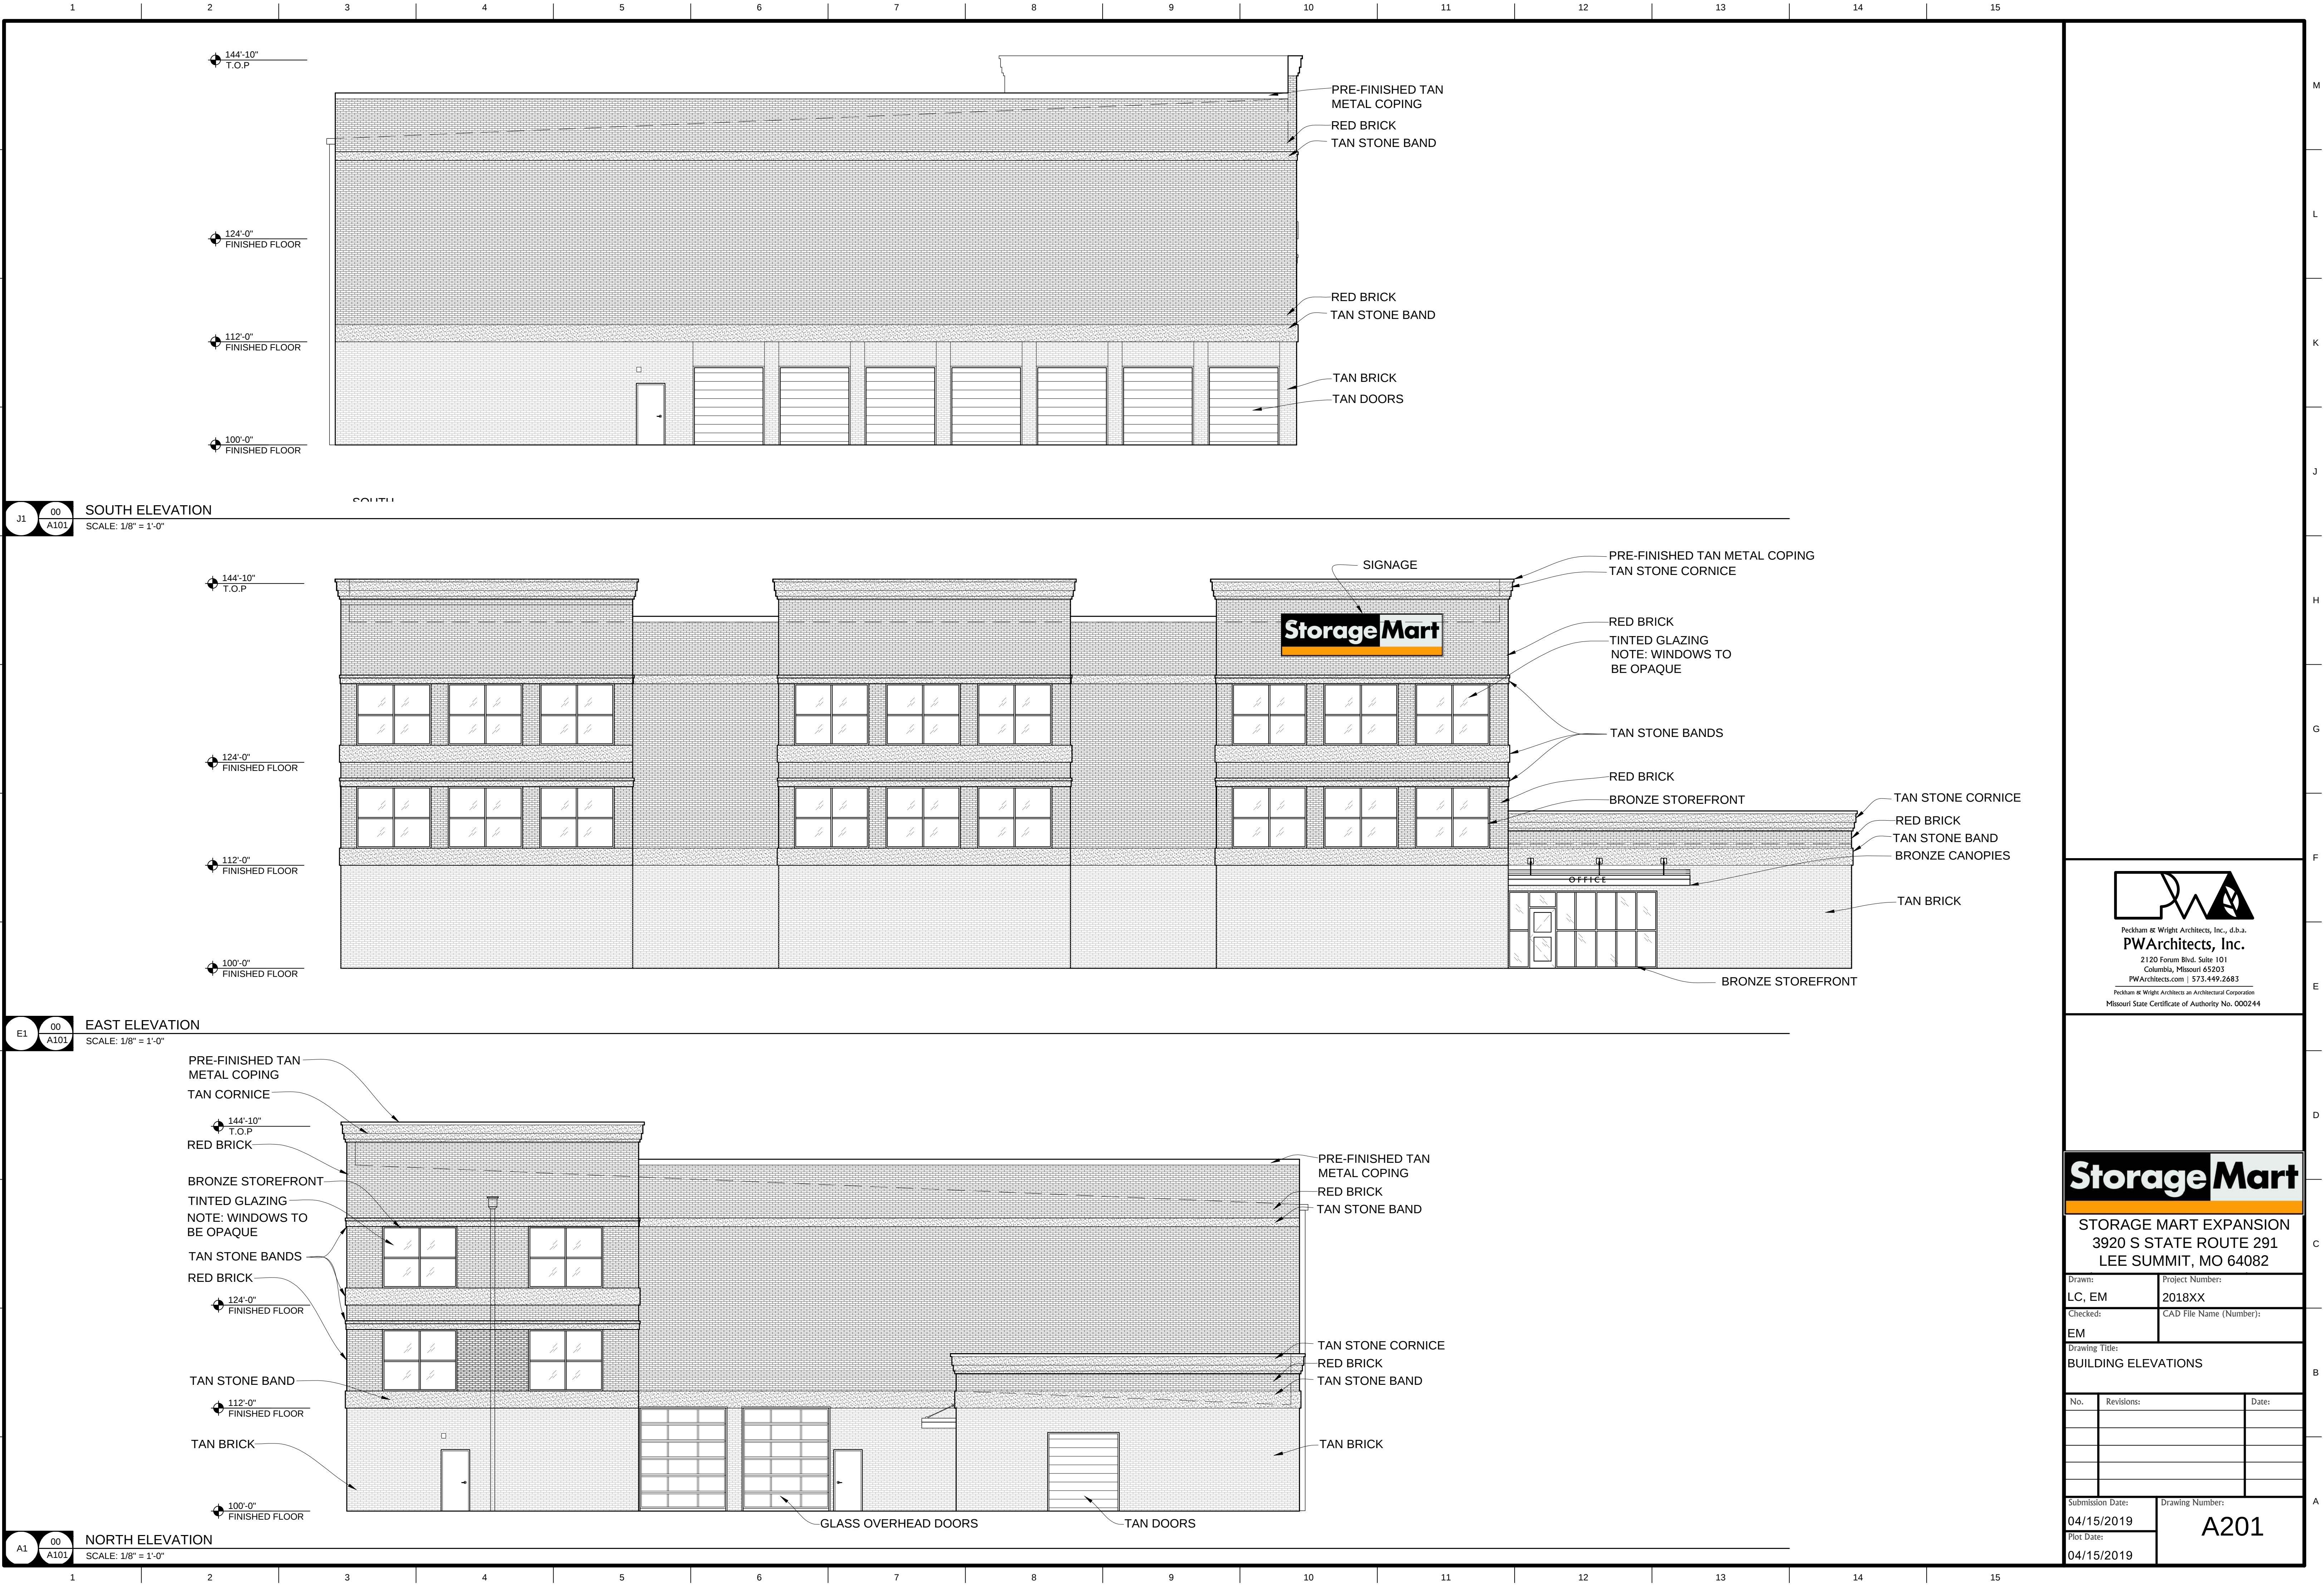

STORAGE MART EXPANSION
3920 S STATE ROUTE 291
LEE SUMMIT, MO 64082

Drawn:	LC, EM	Project Number:	2018XX
Checked:	EM	CAD File Name (Number):	
Drawing Title:	BUILDING ELEVATIONS		
No.	Revisions:	Date:	
Submission Date:	04/15/2019	Drawing Number:	A201
Plot Date:	04/15/2019		

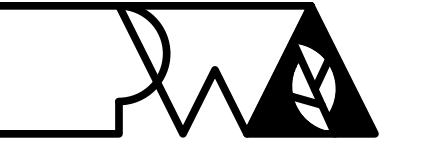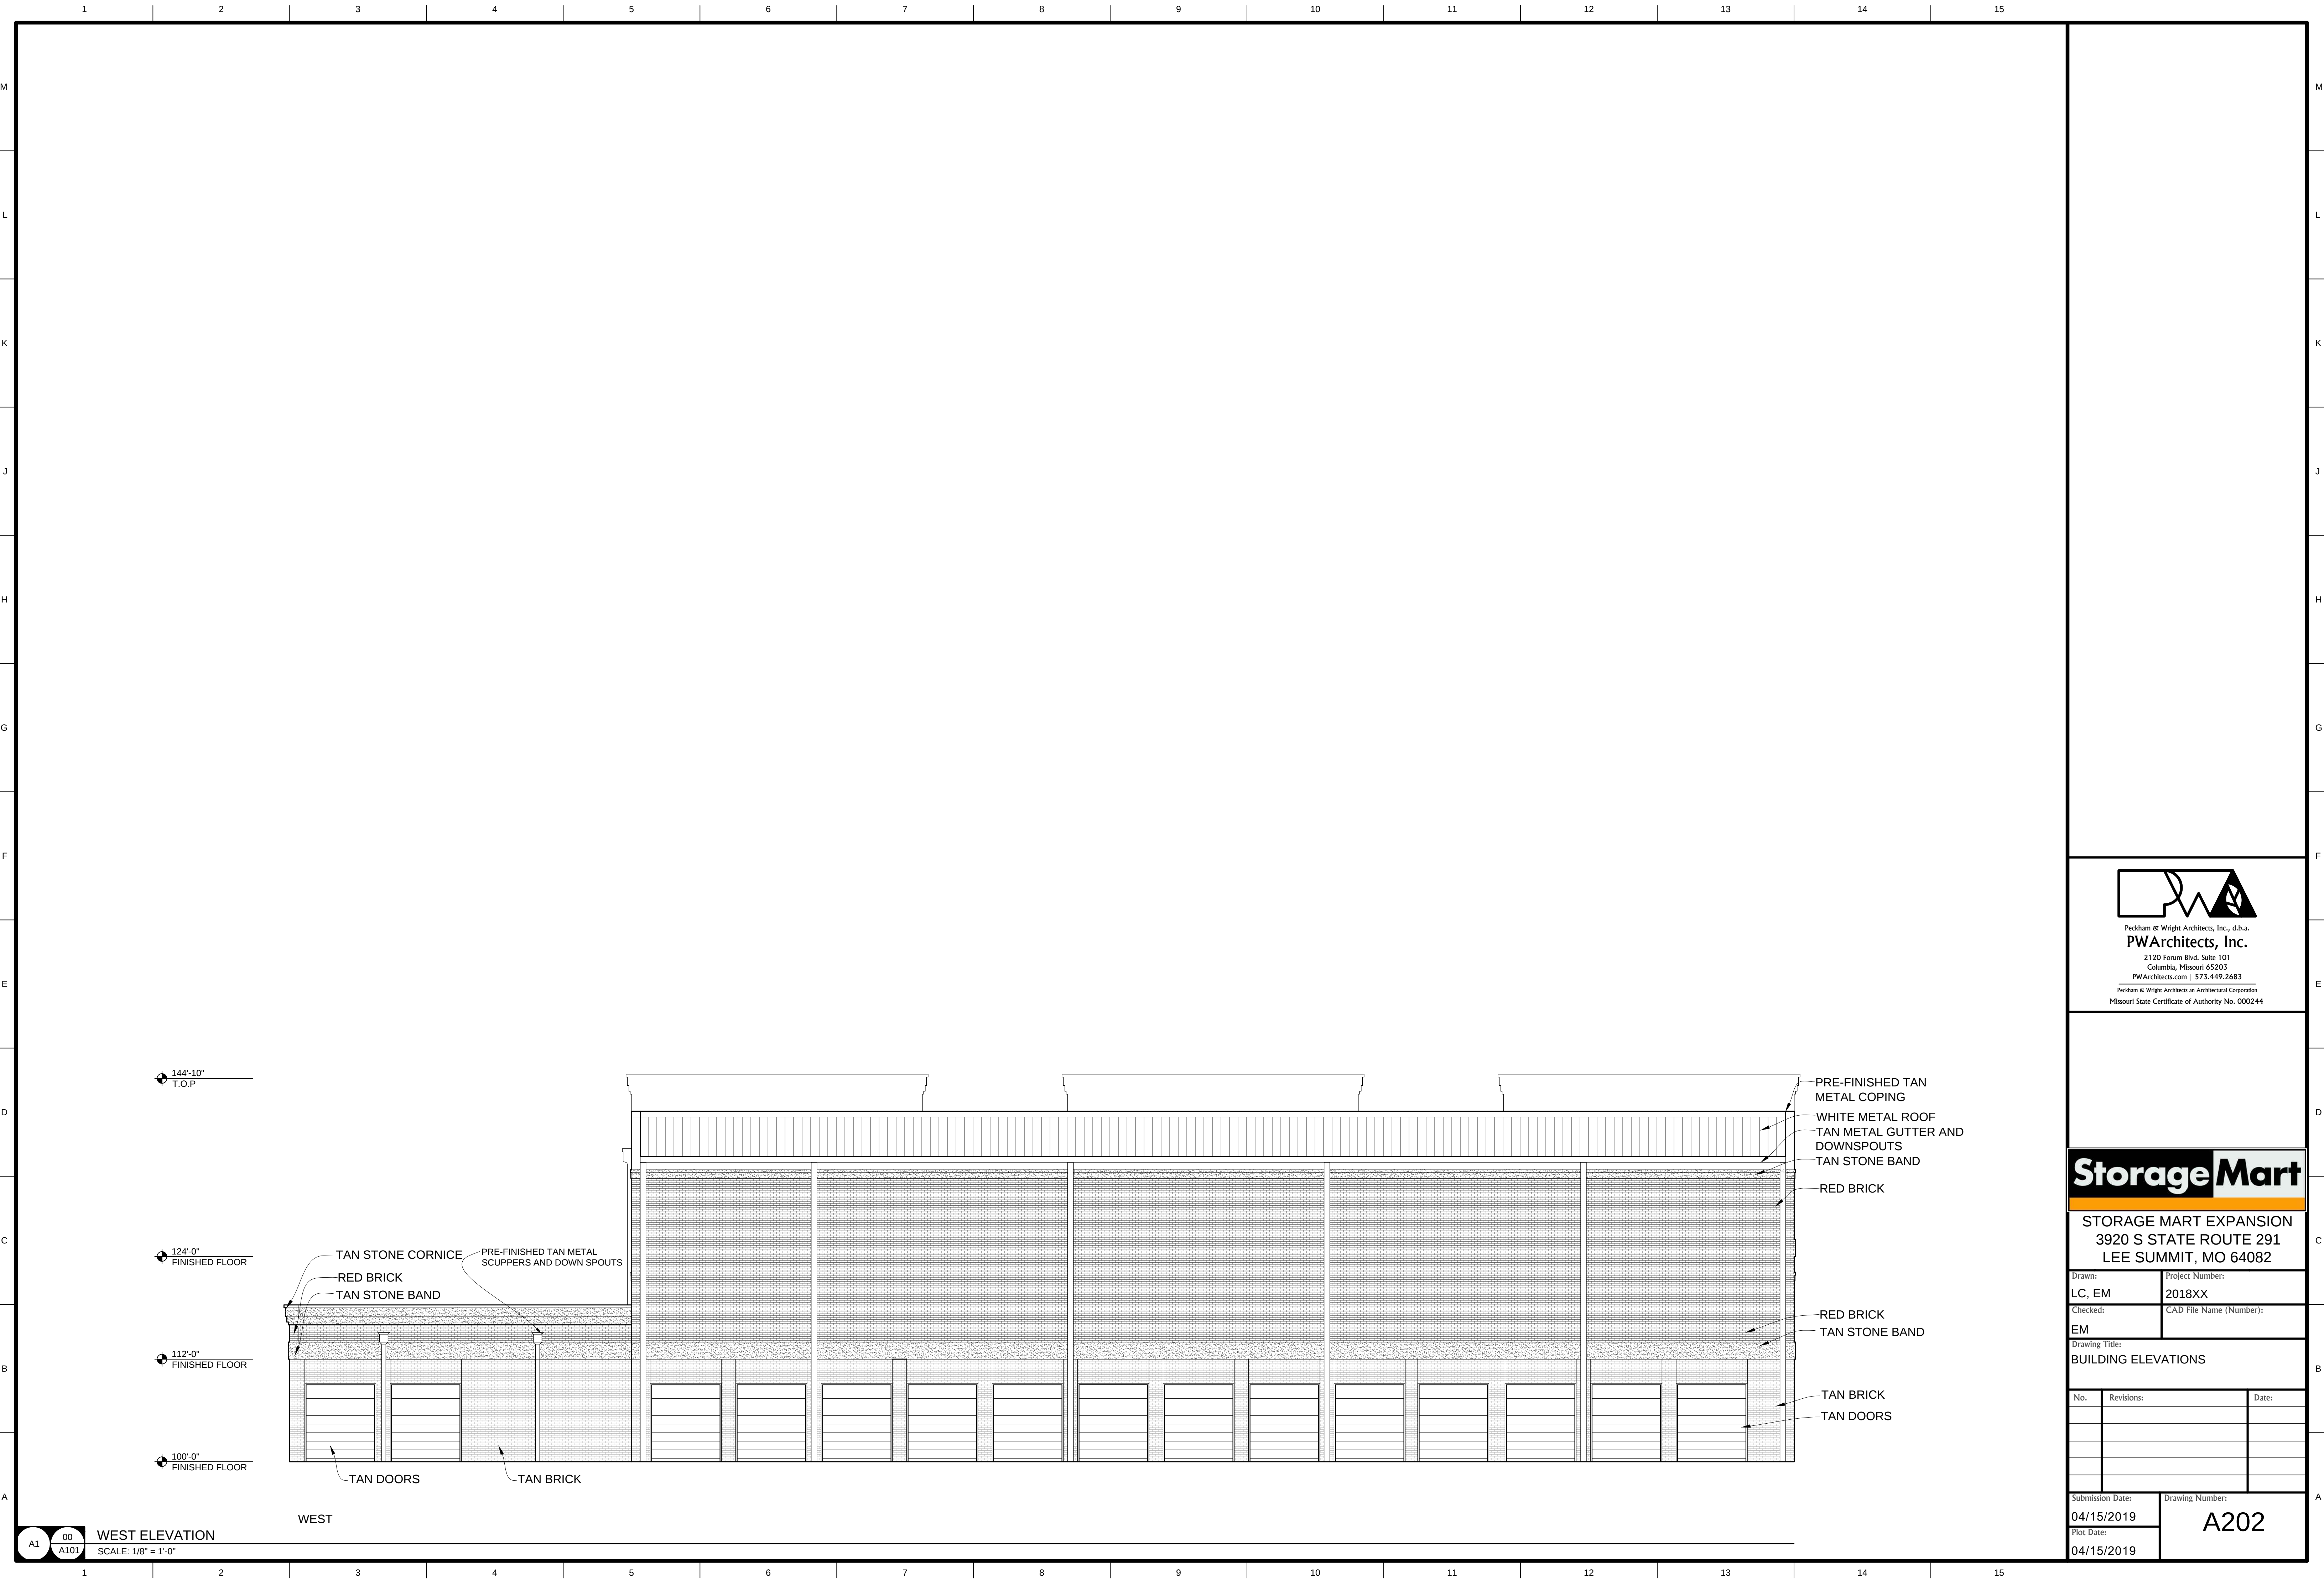

Pearchitects, Inc.
2120 Forum Blvd. Suite 101
Columbia, Missouri 65203
Pearchitects.com | 573.449.2683
Pearchitects is an Architectural Corporation
Missouri State Certificate of Authority No. 000244



STORAGE MART EXPANSION
3920 S STATE ROUTE 291
LEE SUMMIT, MO 64082

Drawn: LC, EM	Project Number: 2018XX
Checked: EM	CAD File Name (Number):

Drawing Title:
BUILDING ELEVATIONS

No.	Revisions:	Date:

Submission Date: 04/15/2019	Drawing Number: A202
Plot Date: 04/15/2019	