


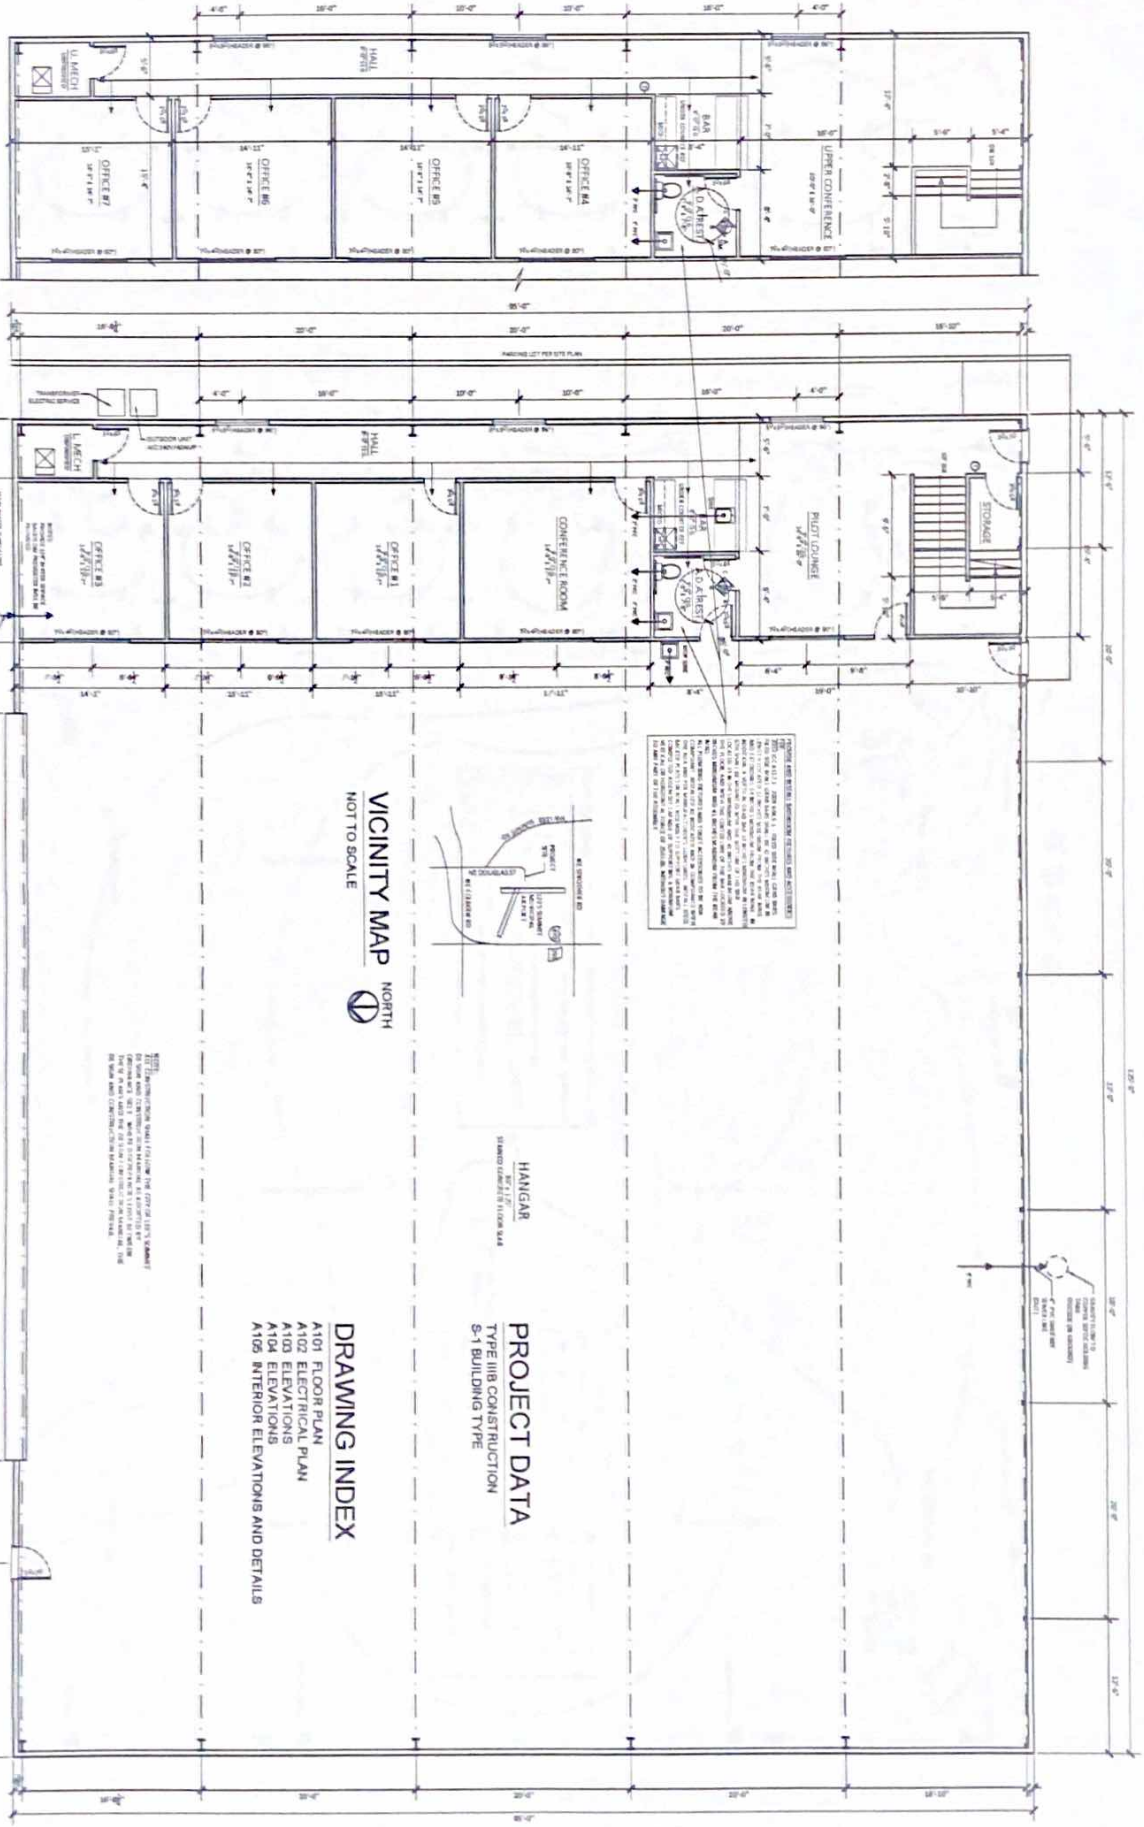

UPPER FLOOR PLAN
SCALE 3/16"=1'-0"

MAIN FLOOR PLAN
SCALE 3/16"=1'-0"

VICINITY MAP
NOT TO SCALE




DRAWING INDEX
A101 FLOOR PLAN
A102 ELECTRICAL PLAN
A103 ELEVATIONS
A104 ELEVATIONS
A105 INTERIOR ELEVATIONS AND DETAILS

PROJECT DATA
TYPE IIB CONSTRUCTION
S-1 BUILDING TYPE

HANGAR

STANDARD CONSTRUCTION

Signature BUILDERS REGISTERED FOR STRUCTURAL REVIEW 2731 NE Douglas St. - Suite 10 Portland, OR 97232-5881 Phone: 503.255.0881 Fax: 503.255.0882 Website: www.signaturebuilders.com		NEW AIRPLANE HANGAR	CADD Construction Documents Volume 1 of 1 Project No. 2019-03 Project Name: New Airplane Hangar Project Location: 2731 NE Douglas St., Suite 10, Portland, OR 97232-5881 Project Date: 2019-03-11 Project Status: In Progress Project Manager: [Name] Project Engineer: [Name] Project Designer: [Name] Project Checker: [Name] Project Approver: [Name]	A 101 1/4" = 1'-0"
--	--	----------------------------	---	------------------------------

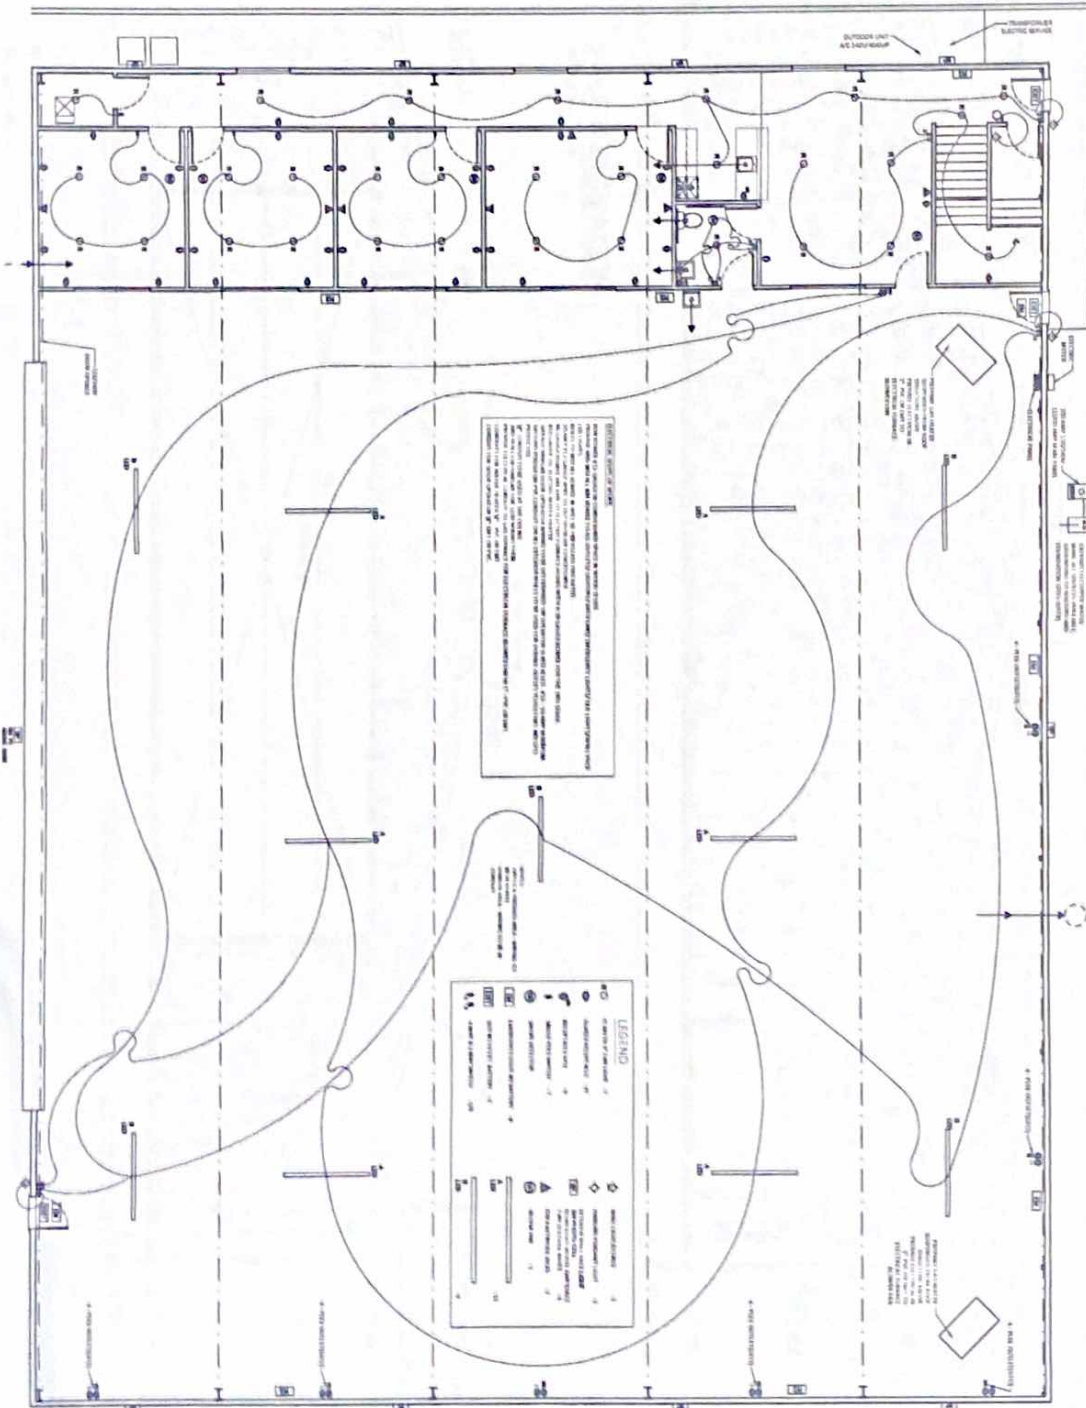

SCALE 3/16"=1'-0"

DOI: 10.1002/anie.200300000

DELETED FROM STRUCTURAL REVIEW

Signature
BUILDERS
A.C.I.E.

Engineer Builders Inc. LLC
2751 Mill Douglas Dr. Suite 10
Lewes, Delaware 19658
Phone: (818) 215-0881

New Airplane Hangar

Call Customer Service Department
Toll Free 1-800-661-1111
or regional@regional.com

[illegible]

A 102


 $1/4^{\circ} \times 1'$

Signature
BUILDERS
KELLER


Signature Builders K.C., LLC
2751 NE Douglas St. - Suite P
Lee's Summit, Missouri 64066
Phone: (816) 215-0891

Websites:
www.sbc-kc.net

New Airplane Hangar

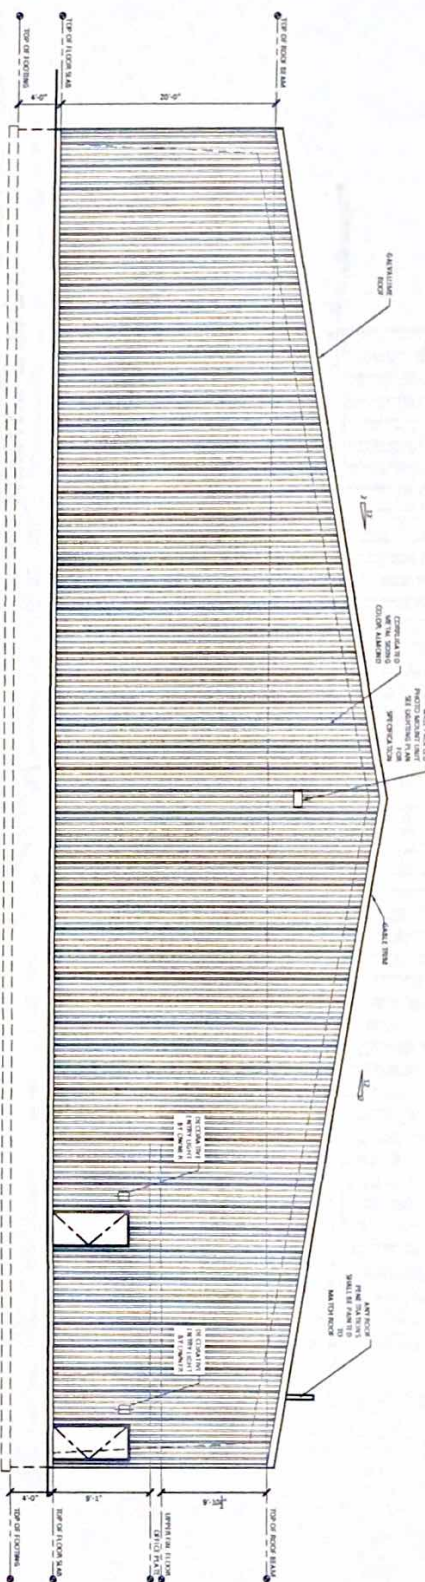[illegible]


SOUTH ELEVATION
SCALE 3/16"=1'-0"

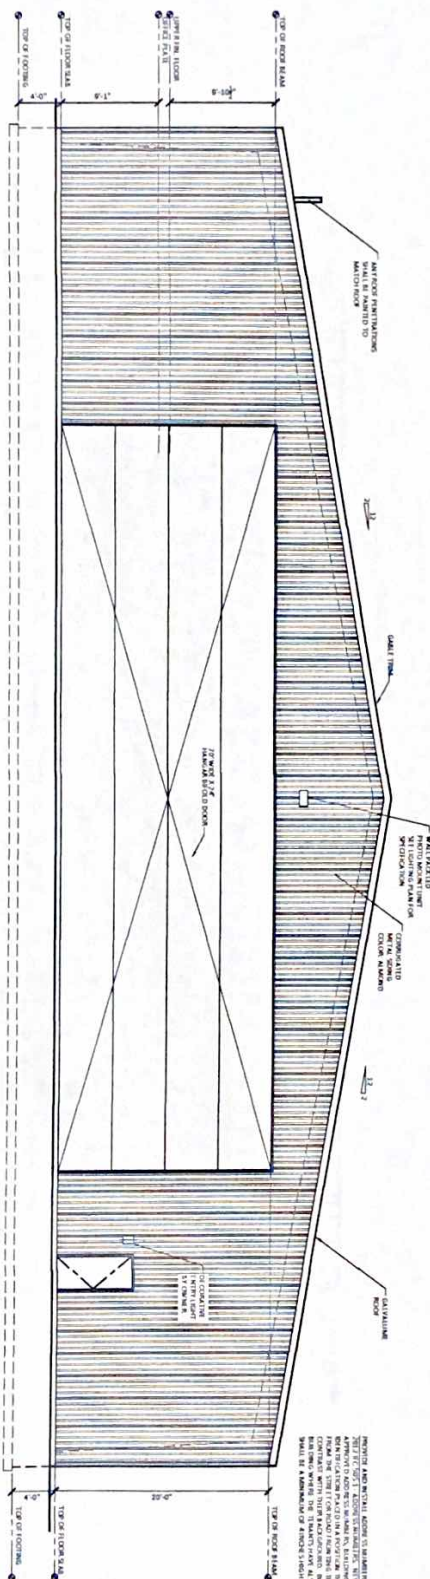

NORTH ELEVATION
SCALE 3/16"=1'-0"


WEST ELEVATION

SCALE 3/16"=1'-0"

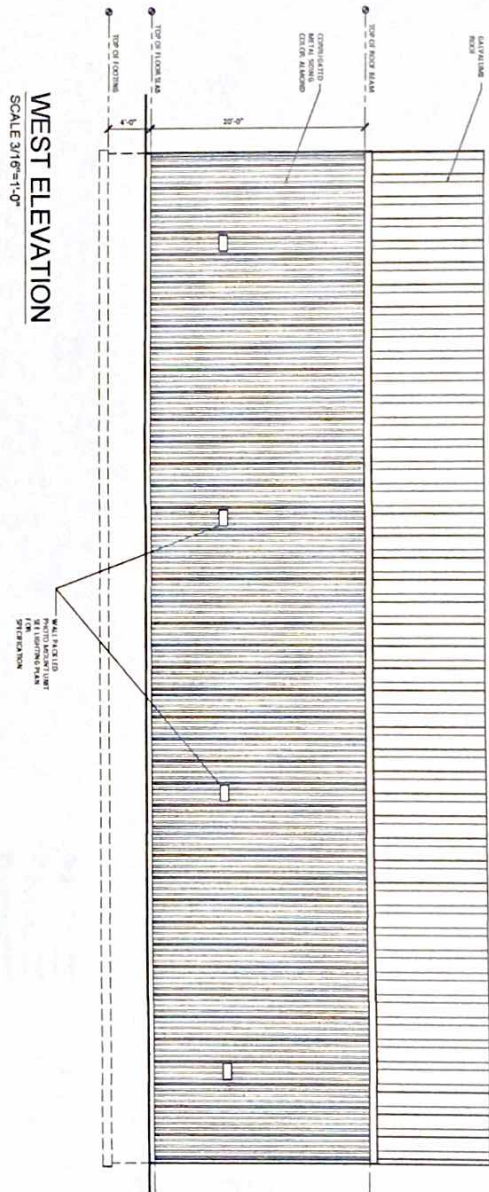

EAST ELEVATION

SCALE 3/16"=1'-0"

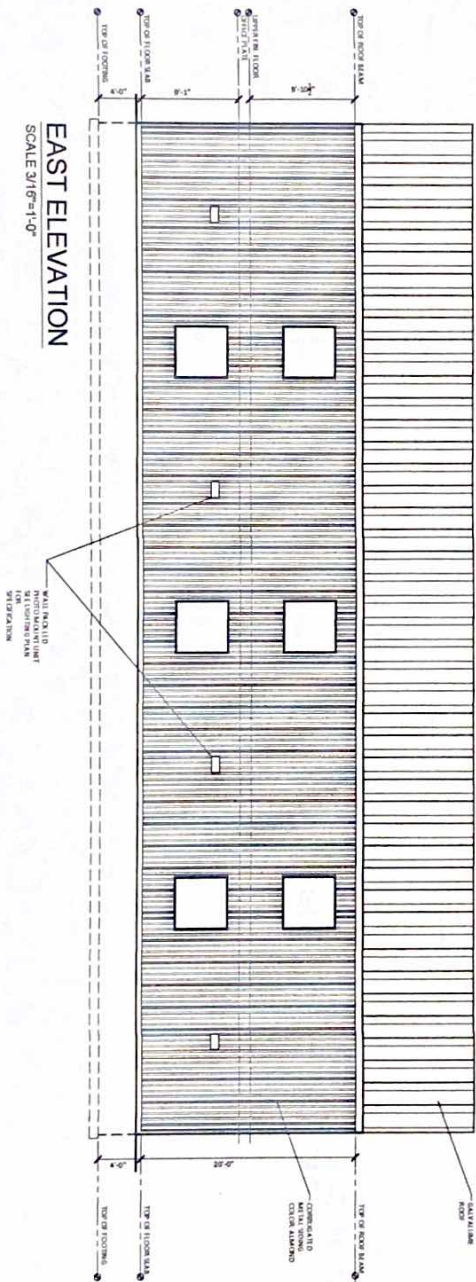

New Airplane Hangar

Signature Builders LLC
2701 1st Avenue SE - Suite 10
Lawrenceville, Georgia 30046
Phone: (770) 215-0881
www.sbuilders.com

Signature
BUILDERS
LLC

SEALED FOR STRUCTURAL
REVIEW

No.	Description	Date

CONSTRUCTION
DOCUMENTS
Project Number: 2019.03
Date: 2019 DEC 10
Drawn By: GCO
Checked By: SBKC

A 104

Scale: 1/4" = 1'-0"

Figure 1 consists of three schematic diagrams labeled A, B, and C, illustrating the experimental apparatus. Diagram A is a top-down view showing a subject's head and shoulders on the left, looking towards a target area on the right. A dashed line indicates the line of sight. A horizontal line represents the starting position of the hand. A vertical line represents the target. A horizontal distance of 10 cm is marked between the starting position and the target. A vertical distance of 10 cm is marked between the starting position and the target. A horizontal distance of 10 cm is marked between the starting position and the target. Diagram B is a side view showing the target at the top, the starting position in the middle, and the distance between them. A horizontal line represents the starting position. A vertical line represents the target. A horizontal distance of 10 cm is marked between the starting position and the target. A vertical distance of 10 cm is marked between the starting position and the target. A horizontal distance of 10 cm is marked between the starting position and the target. Diagram C is a top-down view showing the target at the top, the starting position in the middle, and the distance between them. A horizontal line represents the starting position. A vertical line represents the target. A horizontal distance of 10 cm is marked between the starting position and the target. A vertical distance of 10 cm is marked between the starting position and the target. A horizontal distance of 10 cm is marked between the starting position and the target.

RESTROOM FIXTURES AND ACCESSORIES LEGEND AND SPECIFICATIONS

- ⑫ **Q12** A patient with a history of rheumatoid arthritis is taking a medication. The patient reports joint pain and swelling. The nurse should monitor the patient for which of the following side effects?
- ⑬ **Q13** A patient with a history of rheumatoid arthritis is taking a medication. The patient reports joint pain and swelling. The nurse should monitor the patient for which of the following side effects?
- ⑭ **Q14** A patient with a history of rheumatoid arthritis is taking a medication. The patient reports joint pain and swelling. The nurse should monitor the patient for which of the following side effects?
- ⑮ **Q15** A patient with a history of rheumatoid arthritis is taking a medication. The patient reports joint pain and swelling. The nurse should monitor the patient for which of the following side effects?
- ⑯ **Q16** A patient with a history of rheumatoid arthritis is taking a medication. The patient reports joint pain and swelling. The nurse should monitor the patient for which of the following side effects?
- ⑰ **Q17** A patient with a history of rheumatoid arthritis is taking a medication. The patient reports joint pain and swelling. The nurse should monitor the patient for which of the following side effects?
- ⑱ **Q18** A patient with a history of rheumatoid arthritis is taking a medication. The patient reports joint pain and swelling. The nurse should monitor the patient for which of the following side effects?
- ⑲ **Q19** A patient with a history of rheumatoid arthritis is taking a medication. The patient reports joint pain and swelling. The nurse should monitor the patient for which of the following side effects?
- ⑳ **Q20** A patient with a history of rheumatoid arthritis is taking a medication. The patient reports joint pain and swelling. The nurse should monitor the patient for which of the following side effects?

[illegible]