
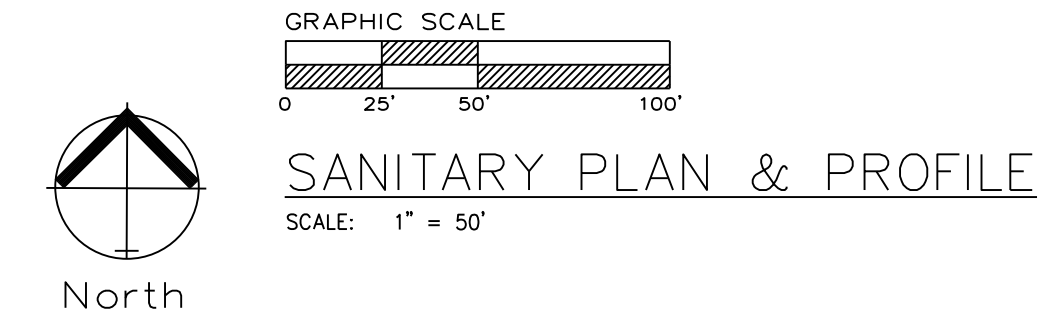


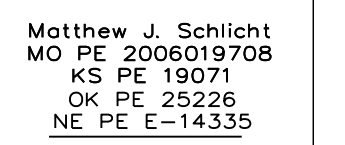


1 ~ ALL CONSTRUCTION SHALL CONFORM TO THE CITY OF LEE'S SUMMIT DESIGN AND CONSTRUCTION MANUAL AS ADOPTED BY ORDINANCE 5813.
2 ~ TRENCH CHECKS SHALL BE INSTALL AT ALL SANITARY WYES LOCATION.

THE TOWNHOMES OF CHAPEL RIDGE-2ND PLAT
LOTS 9-19 & TRACTS A-D
Lee's Summit, Jackson County, Missouri

Sanitary Sewer General Layout
Construction Plans for:
THE TOWNHOMES OF CHAPEL RIDGE-2ND PLAT
LOTS 9-19 & TRACTS A-D
Lee's Summit, Jackson County, Missouri


C.401

GENERAL NOTE:
1 - ALL CONSTRUCTION SHALL CONFORM TO THE CITY OF LEE'S SUMMIT DESIGN AND CONSTRUCTION MANUAL AS ADOPTED BY ORDINANCE 5813.
2 - TRENCH CHECKS SHALL BE INSTALL AT ALL SANITARY WYES LOCATION.

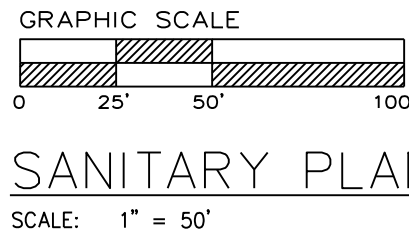


SANITARY PLAN & PROFILE

SCALE: 1" = 50'

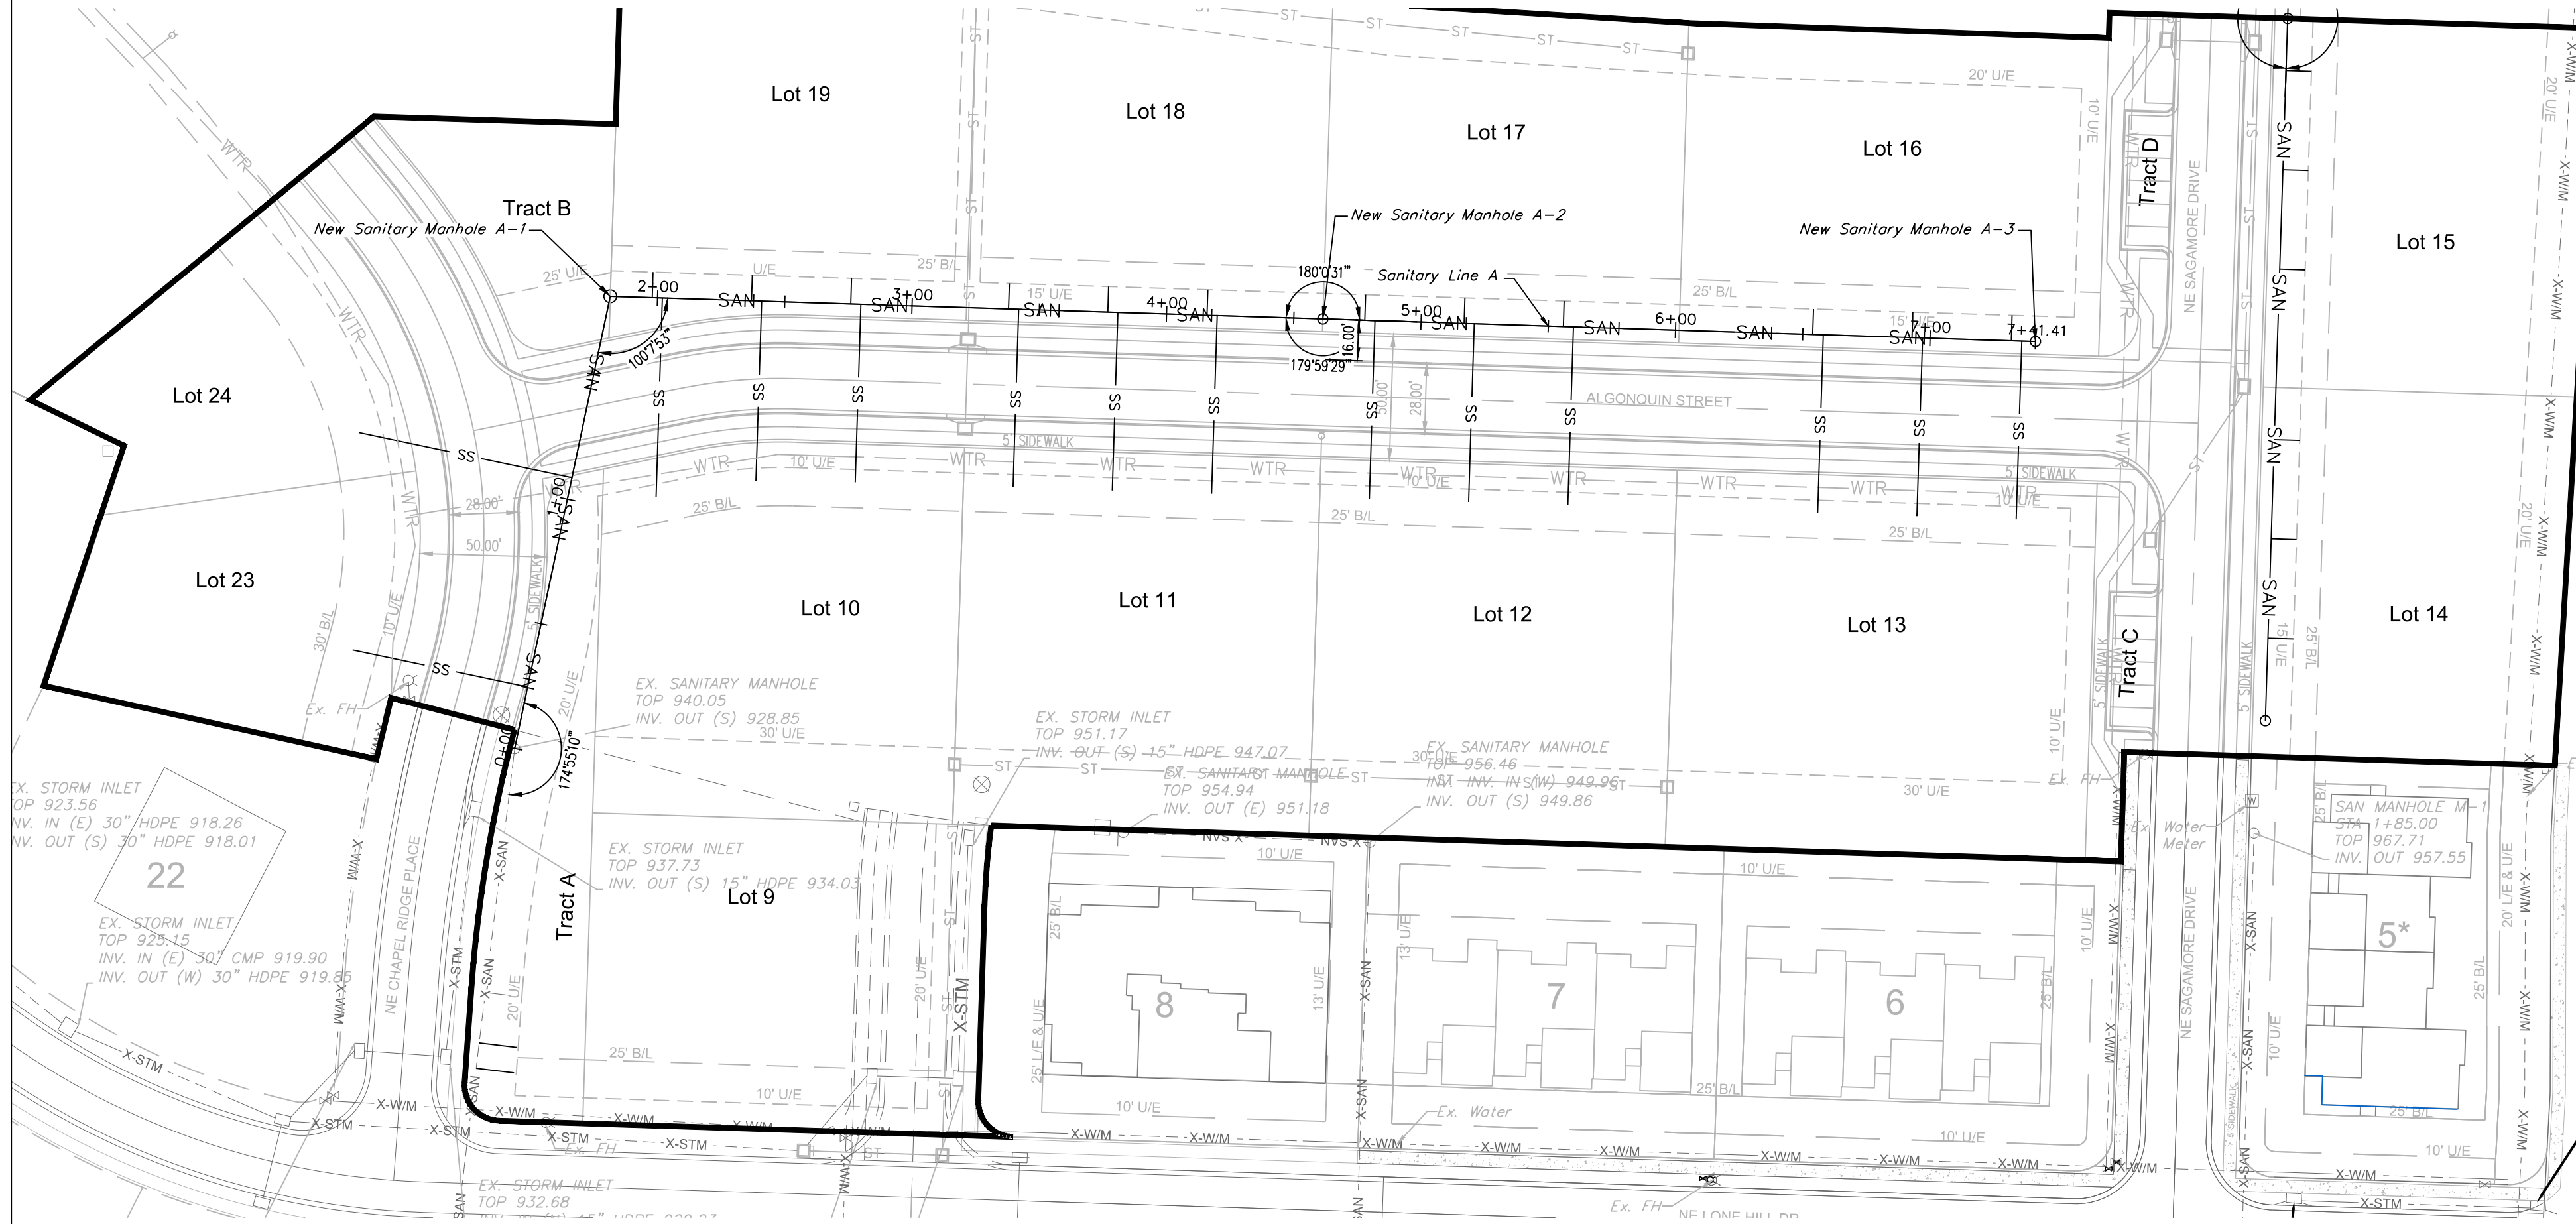


SANITARY LINE A

REVISED PROFILE LINE A

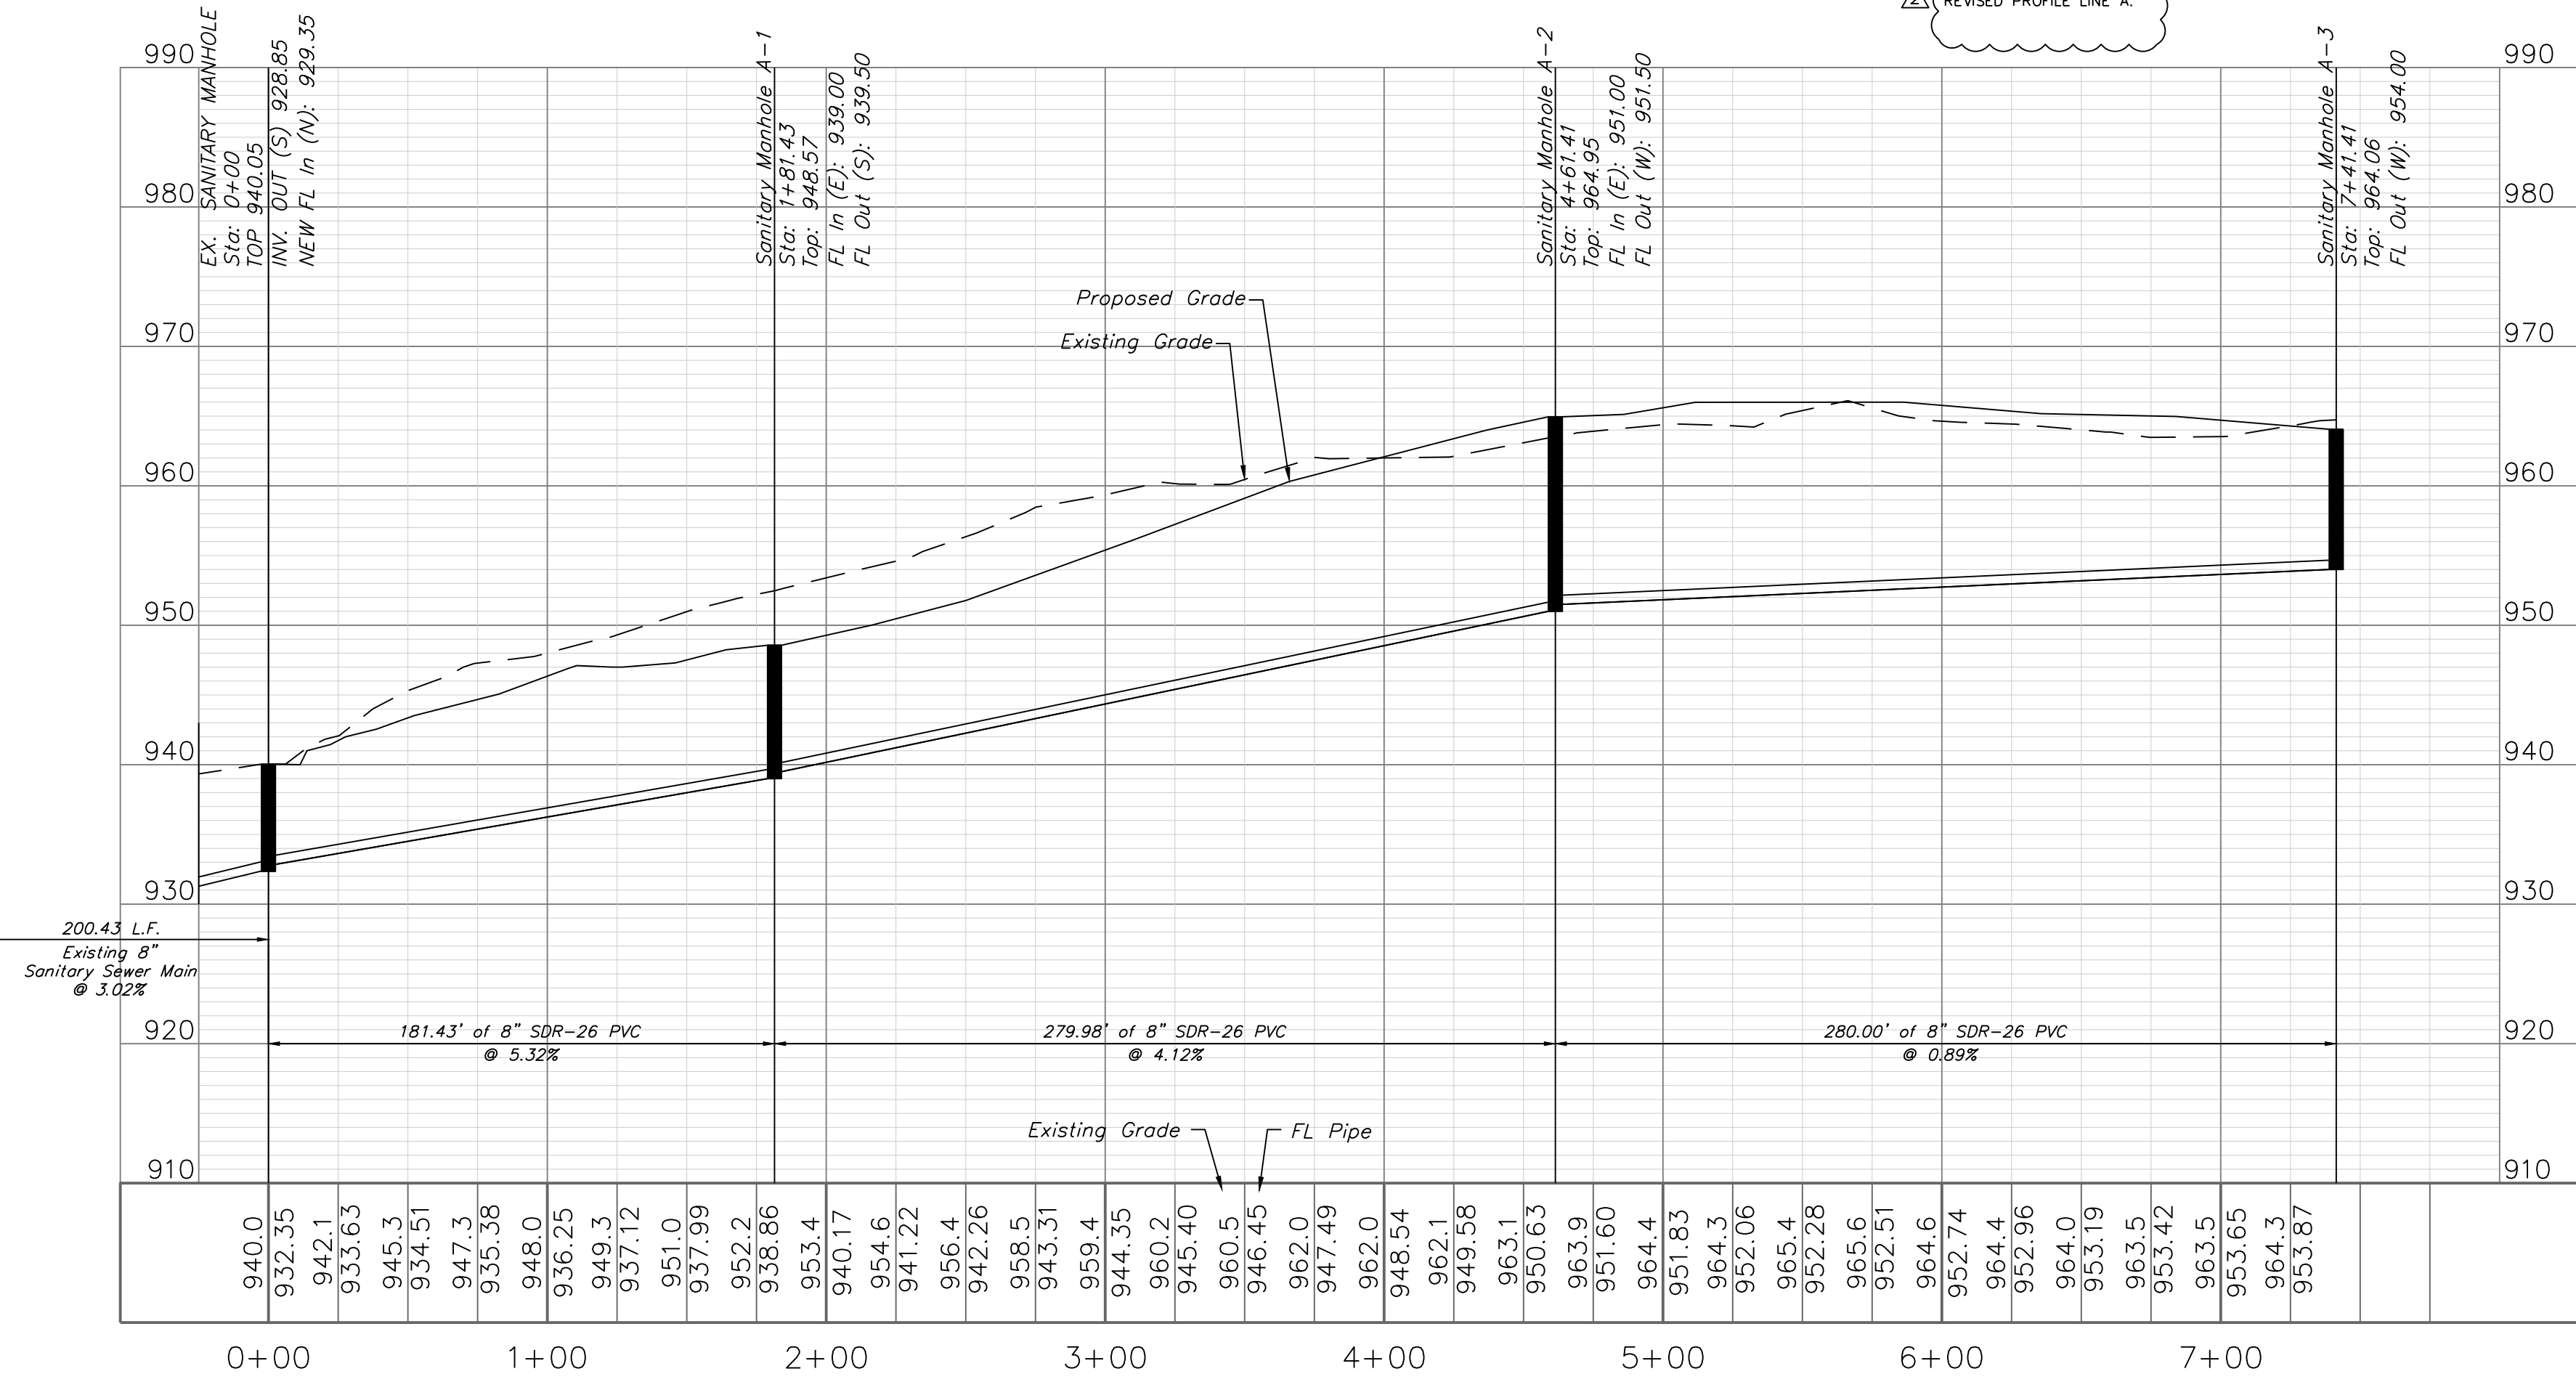


Sewer Stub Table - Line A					
Lot	Station	Main FL	Length	Slope (%)	MSFE
9C	-126.55	925.03	15	2	928.93
9B	-116.55	925.33	15	2	928.93
9A	-96.55	925.93	15	2	928.93
23	0+24.62	933.62	70.26	2	937.62
24	1+08.65	936.55	85.47	2	940.55
19A	1+97.92	940.09	10	2	943.09
10A	2+01.90	940.25	78.16	2	944.25
19B	2+36.92	941.72	10	2	944.72
10B	2+40.90	941.88	70.63	2	945.88
19C	2+75.92	943.35	10	2	946.35
10C	2+79.90	943.51	70	2	947.51
18A	3+37.92	945.94	10	2	948.94
11A	3+41.90	946.11	70	2	950.11
18B	3+76.92	947.57	10	2	950.57
11B	3+80.90	947.74	70	2	951.74
18C	4+15.92	949.20	10	2	952.20
11C	4+19.90	949.37	70	2	953.37
17A	4+77.92	951.63	10	2	954.63
12A	4+81.90	951.66	70	2	955.66
17B	5+16.92	951.98	10	2	954.98
12B	5+20.90	952.02	70	2	956.02
17C	5+55.92	952.34	10	2	955.34
12C	5+59.90	952.37	70	2	956.37
16A	6+53.92	953.23	10	2	956.23
13A	6+58.27	953.27	70	2	957.27
16B	6+92.92	953.58	10	2	956.58
13B	6+97.07	953.62	70	2	957.62
16C	7+31.92	953.94	10	2	956.94
13C	7+36.07	953.97	70	2	957.97

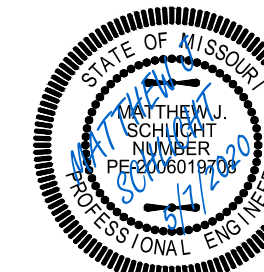


Matthew J. Schlacht
MO PE 2006019708
KS PE 19071
OK PE 25226
NE PE E-14335

REVISIONS
REV. 4/27/2020
REV. 5/7/2020

 GENERAL NOTE:
1 - ALL CONSTRUCTION SHALL CONFORM TO THE CITY OF LEE'S SUMMIT DESIGN AND CONSTRUCTION MANUAL AS ADOPTED BY ORDINANCE 5813.
2 - TRENCH CHECKS SHALL BE INSTALL AT ALL SANITARY WYES LOCATION.
3 - COMPACTED FILL SHALL BE PLACED TO A MINIMUM 18" ABOVE THE TOP OF THE PIPE PRIOR TO INSTALLATION.





SANITARY PLAN & PROFILE
SCALE: 1" = 50'

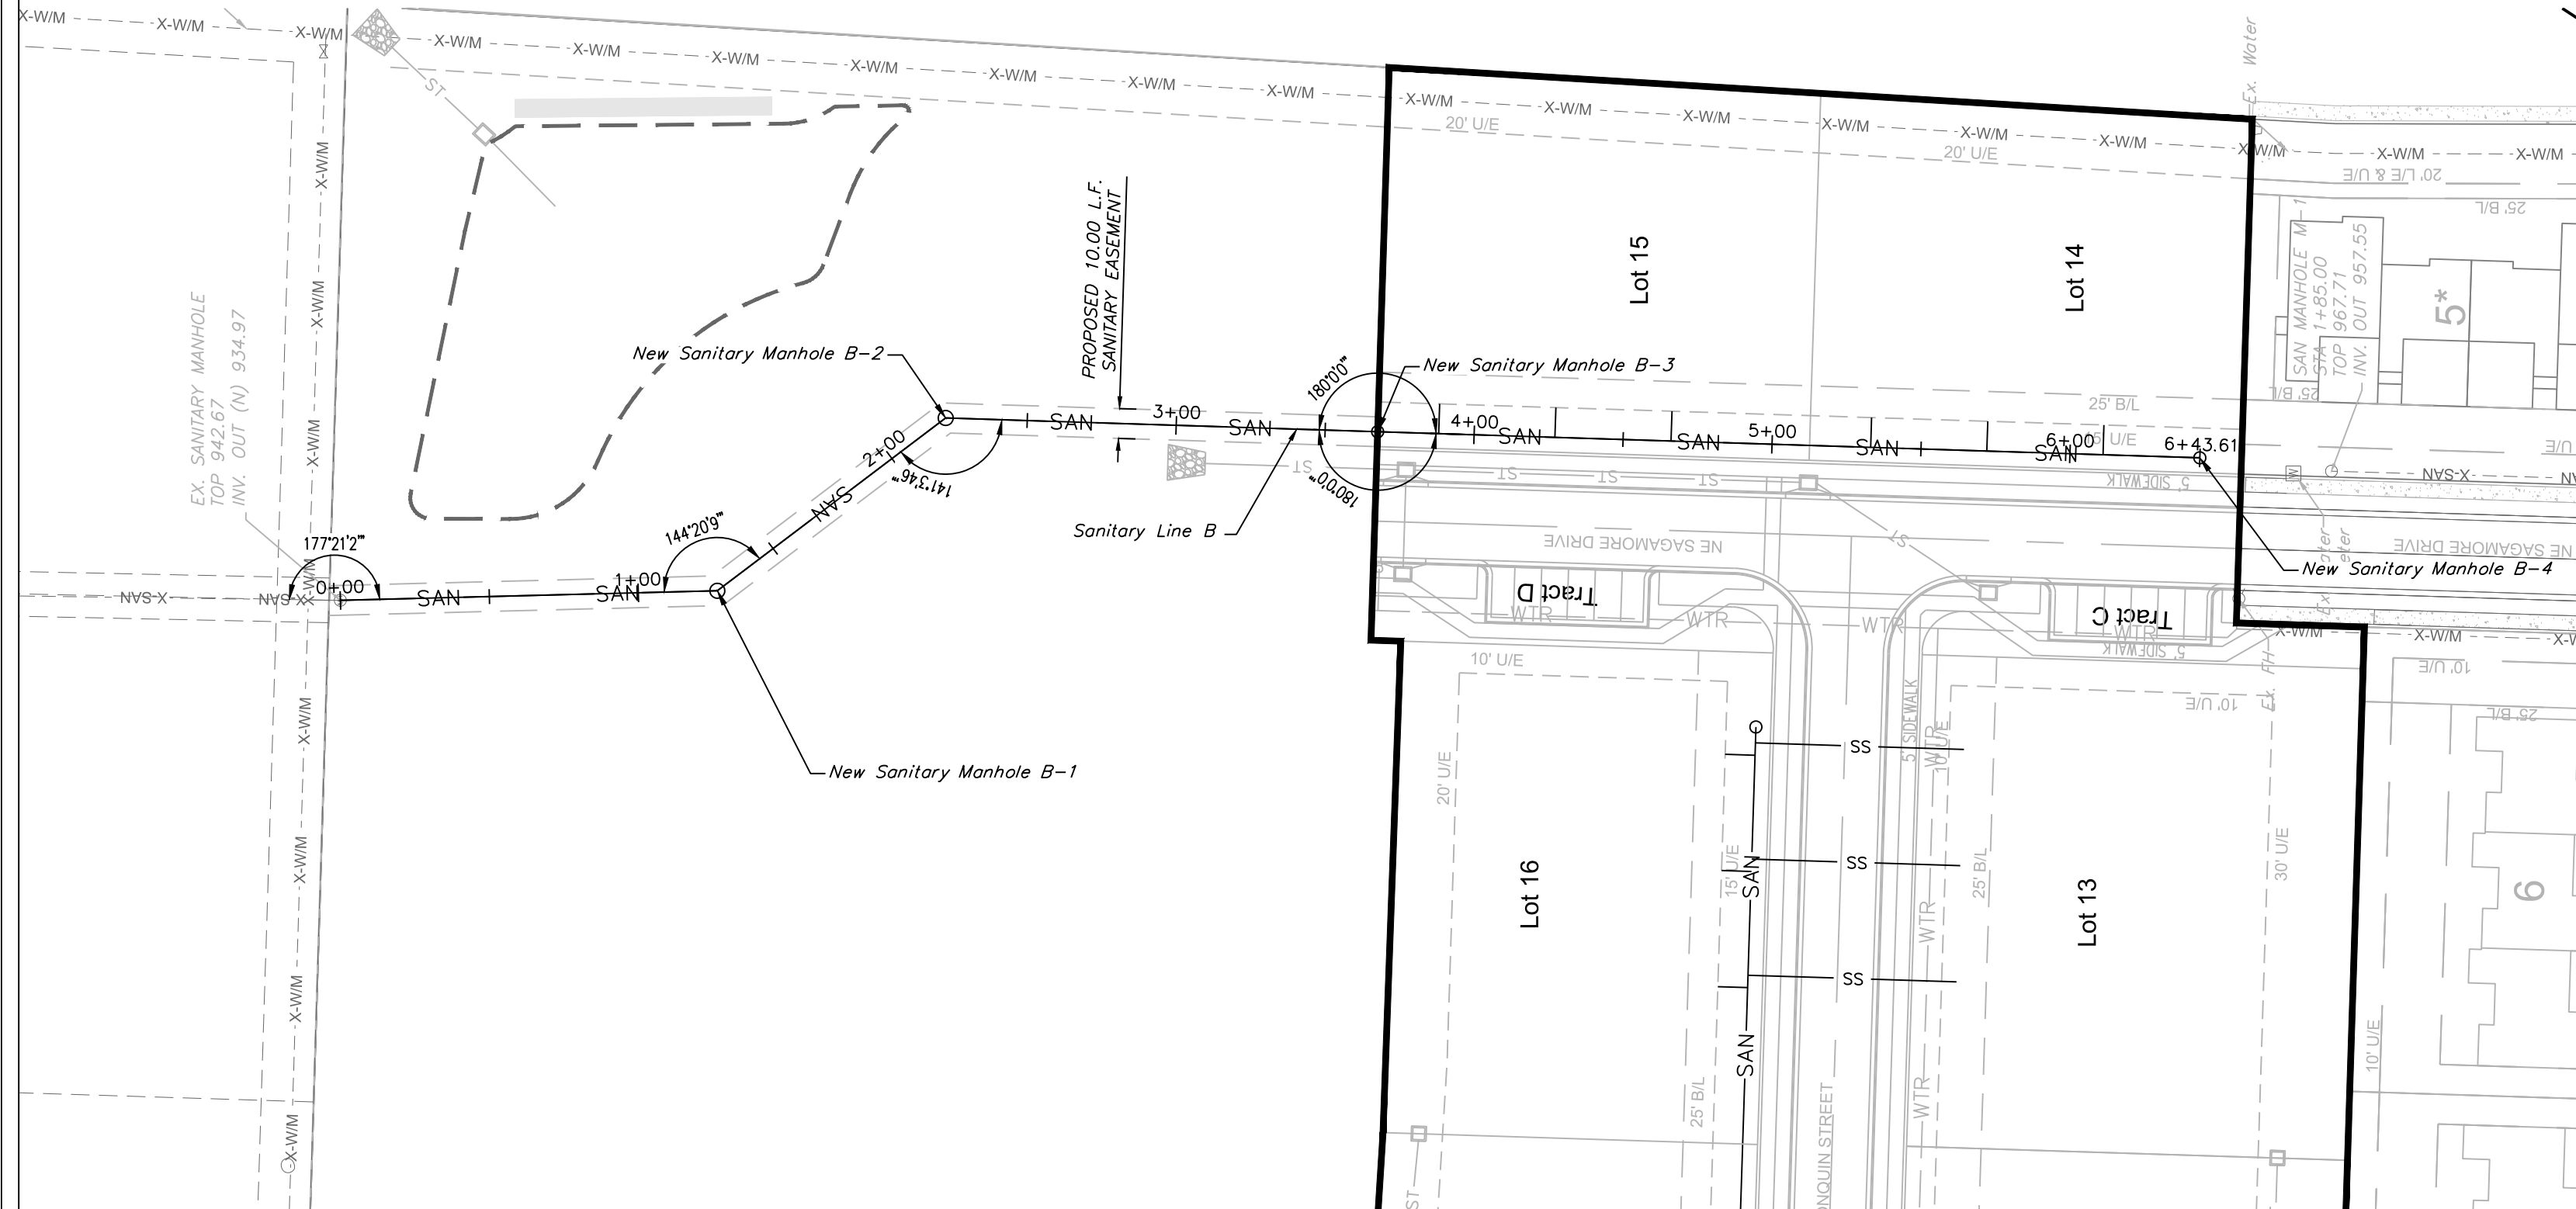

Sewer Stub Table - Line B					
Lot	Station	Main FL	Length	Slope	MSFE
15A	3+88.11	947.88	10	2	950.88
15B	4+27.11	949.20	10	2	952.2
15C	4+66.11	950.53	10	2	953.53
14A	5+33.11	952.81	10	2	955.81
14B	5+72.11	954.14	10	2	957.14
14C	6+11.11	955.48	10	2	958.48

SANITARY LINE B

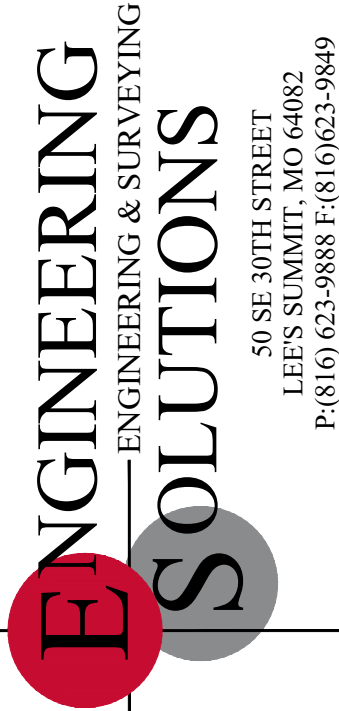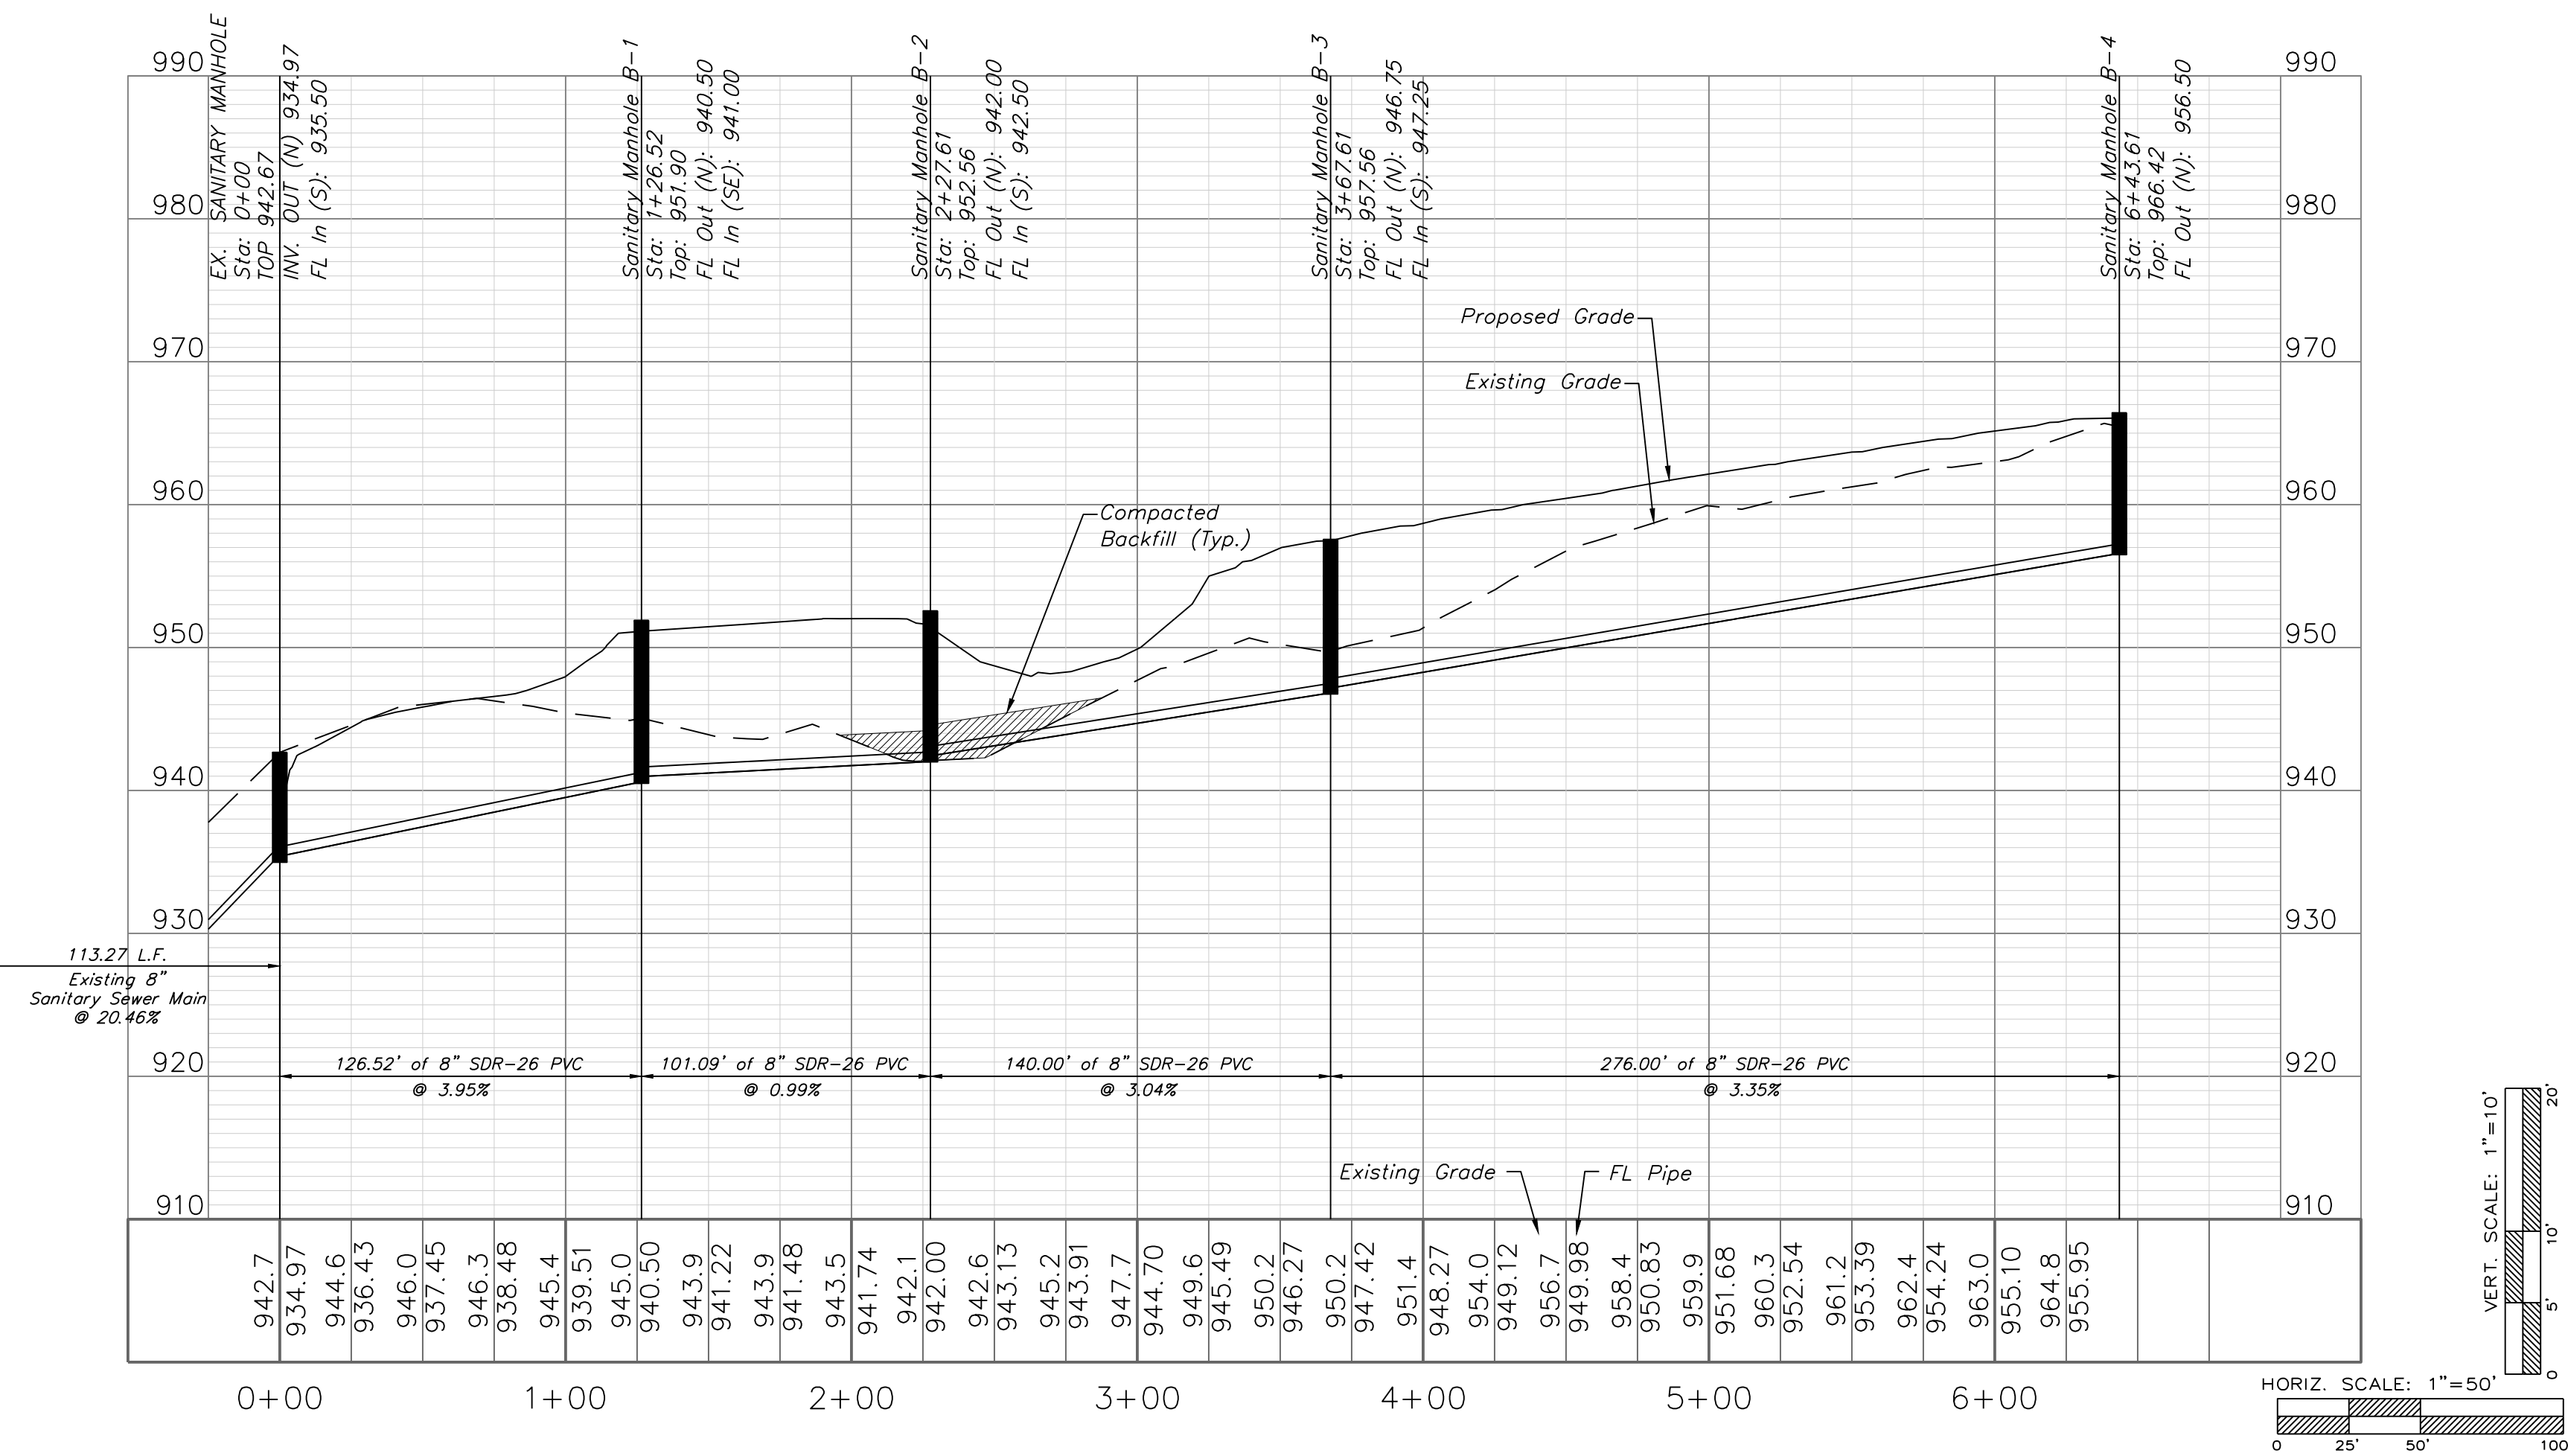


Professional Registration
Missouri
Engineering 2005002186-D
Surveying 2005008319-D
Kansas
Engineering E-1695
Surveying LS-218
Oklahoma
Engineering 6254
Nebraska
Engineering CA2821

THE TOWNHOMES OF CHAPEL RIDGE-2ND PLAT
LOTS 9-19 & TRACTS A-D
Lee's Summit, Jackson County, Missouri

Project:
VILLAS OF CHAPEL
RIDGE, L.S.M.O.
Issue Date:
April 10, 2020

Sanitary Plan and Profile
Construction Plans for:
THE TOWNHOMES OF CHAPEL RIDGE-2ND PLAT
LOTS 9-19 & TRACTS A-D
Lee's Summit, Jackson County, Missouri

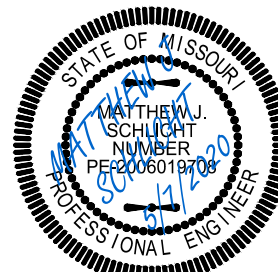

Matthew J. Schlicht
MO PE 2006019708
KS PE 19071
OK PE 25226
NE PE E-14335

REVISIONS
REV. 4/27/2020
REV. 5/7/2020

