


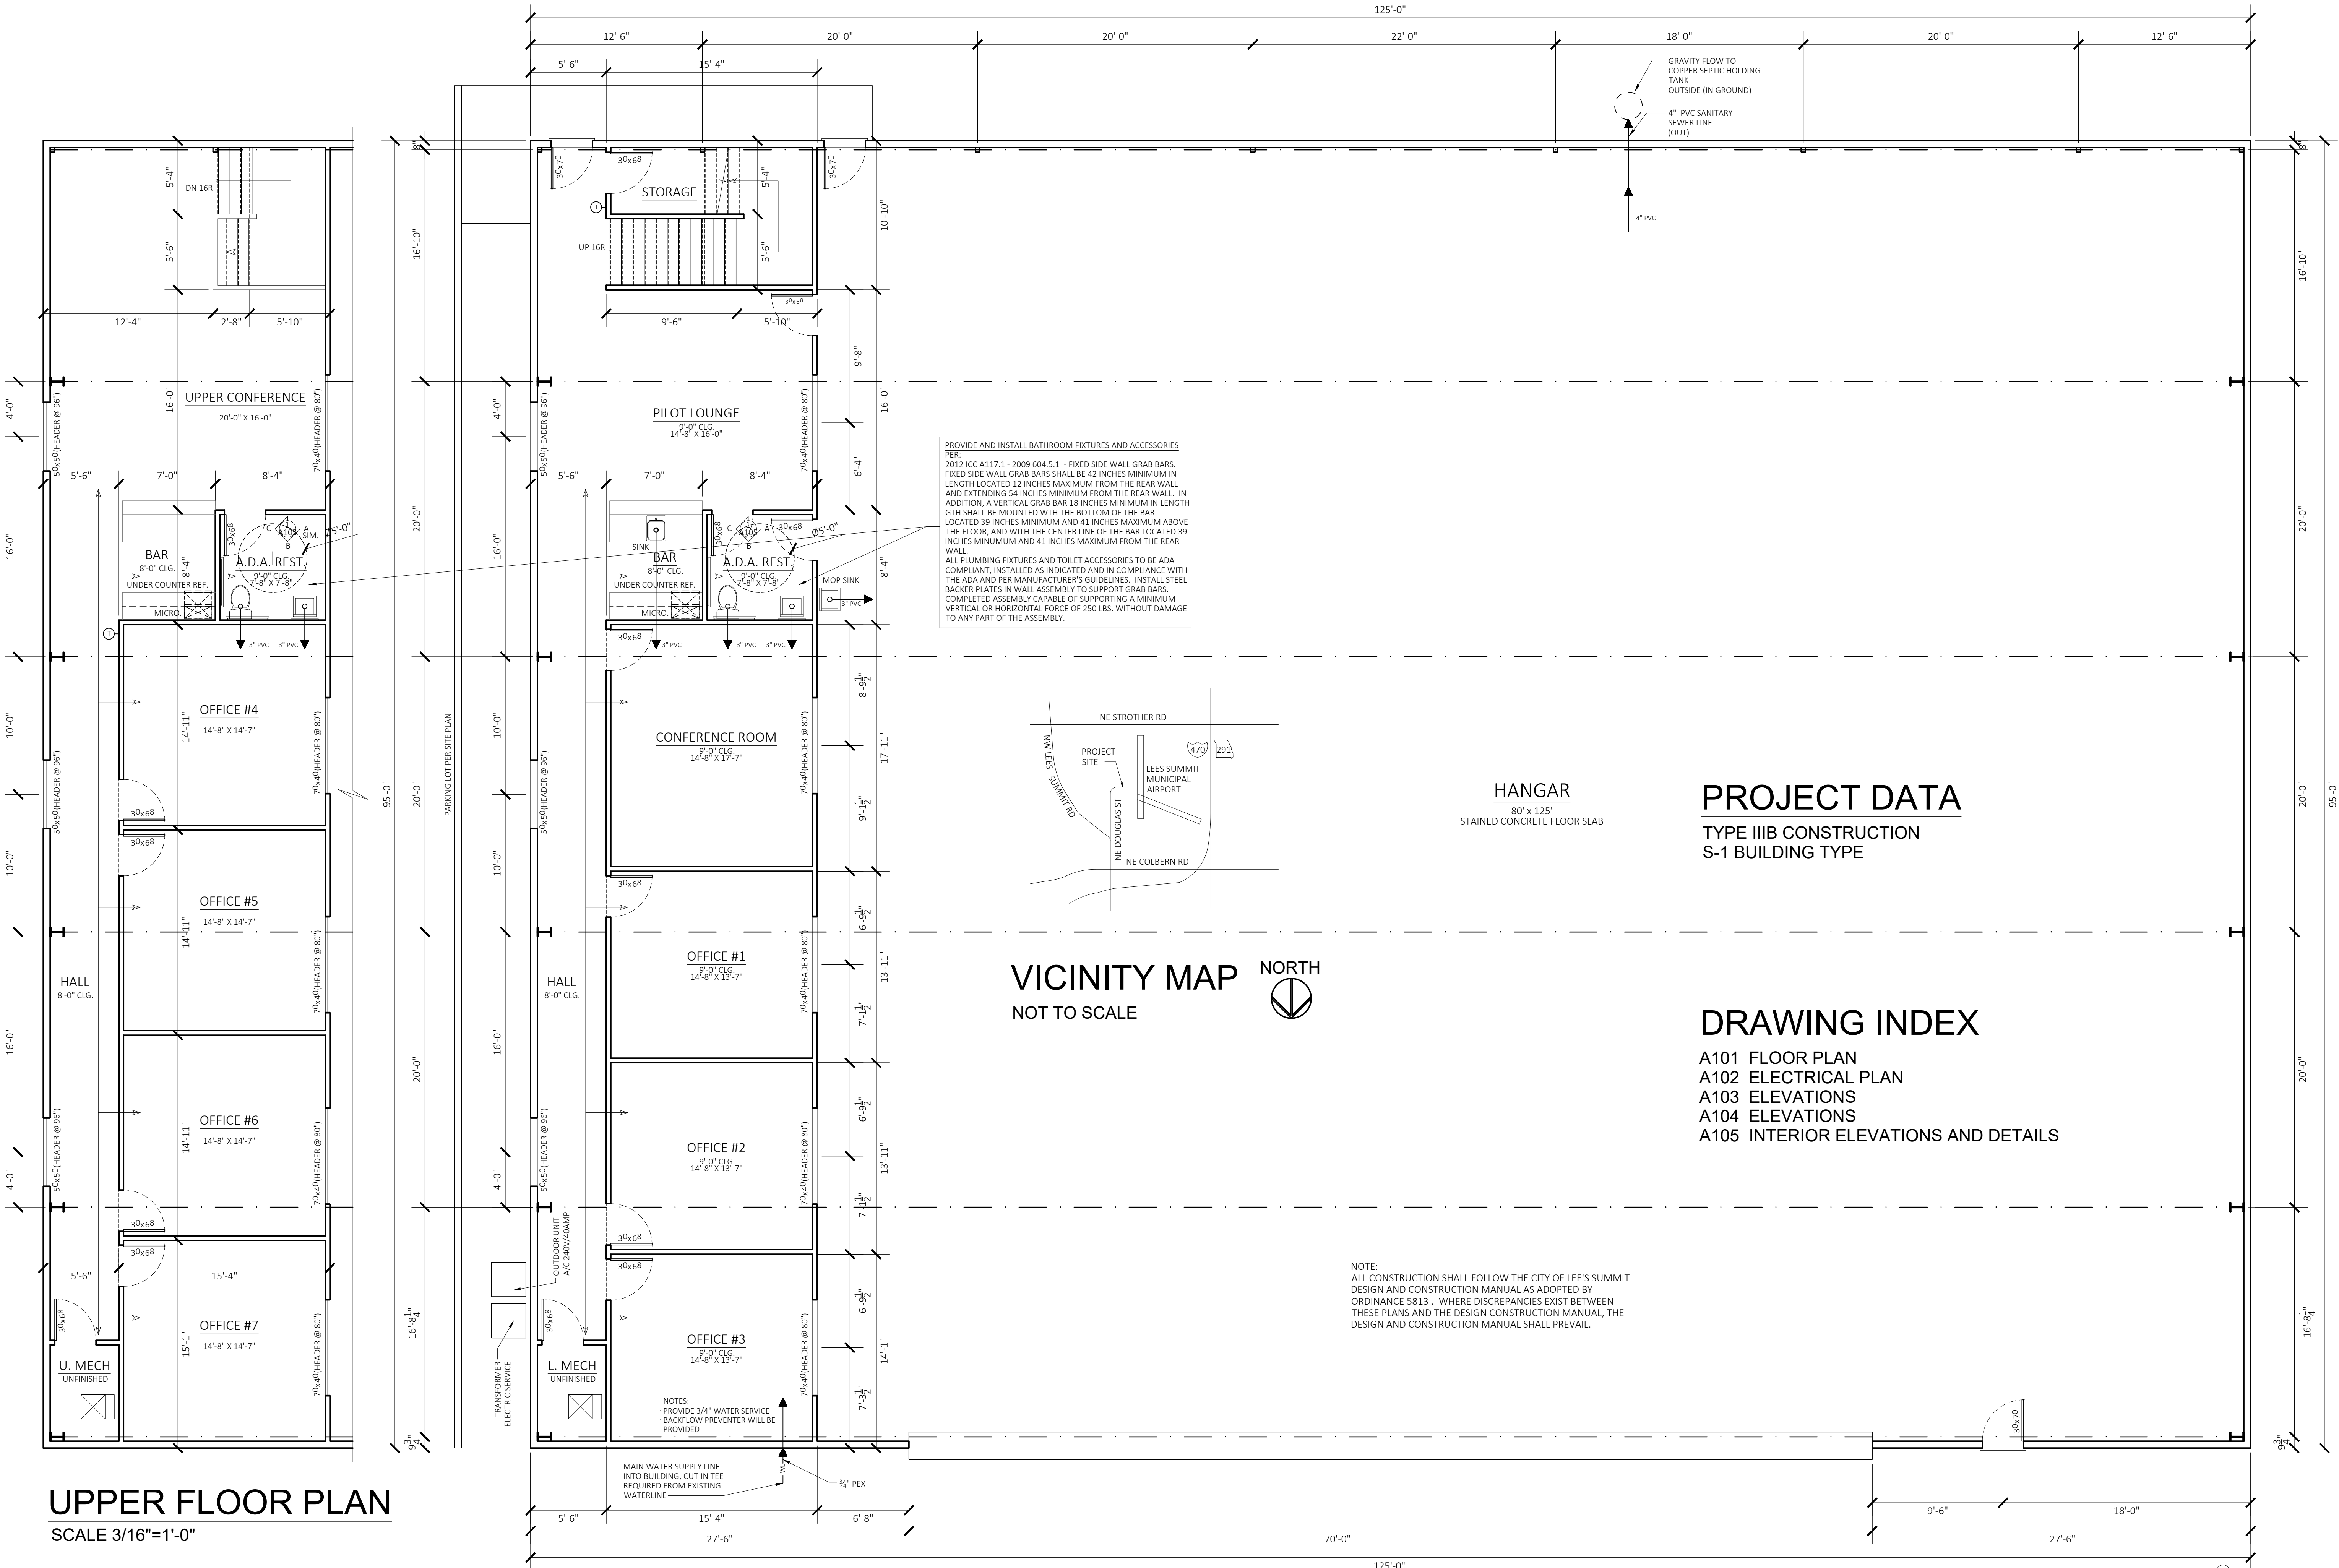

UPPER FLOOR PLAN
SCALE 3/16"=1'-0"

MAIN FLOOR PLAN
SCALE 3/16"=1'-0"

SHEET SIZE: 24" x 36"

SEALED FOR STRUCTURAL
REVIEW



Signature Builders KC, LLC
2751 NE Douglas St. - Suite R
Lee's Summit, Missouri 64064
Phone: (816) 215-0891
Website:
www.sb-kc.net

New Airplane Hangar

PROJECT DATA

TYPE IIIB CONSTRUCTION
S-1 BUILDING TYPE

VICINITY MAP

NOT TO SCALE

DRAWING INDEX



- A101 FLOOR PLAN
- A102 ELECTRICAL PLAN
- A103 ELEVATIONS
- A104 ELEVATIONS
- A105 INTERIOR ELEVATIONS AND DETAILS

CAD Construction Documents
Voice / Text : 913.638.3241
mgspencer@sbcglobal.net

Residential AutoCAD Drafting
and Design Services

No.	Description	Date

CONSTRUCTION DOCUMENTS	
Project Number	2019.03
Date	2019 DEC 11
Drawn By	CCD
Checked By	SBKC
A 101	
Scale	1/4" = 1'-0"

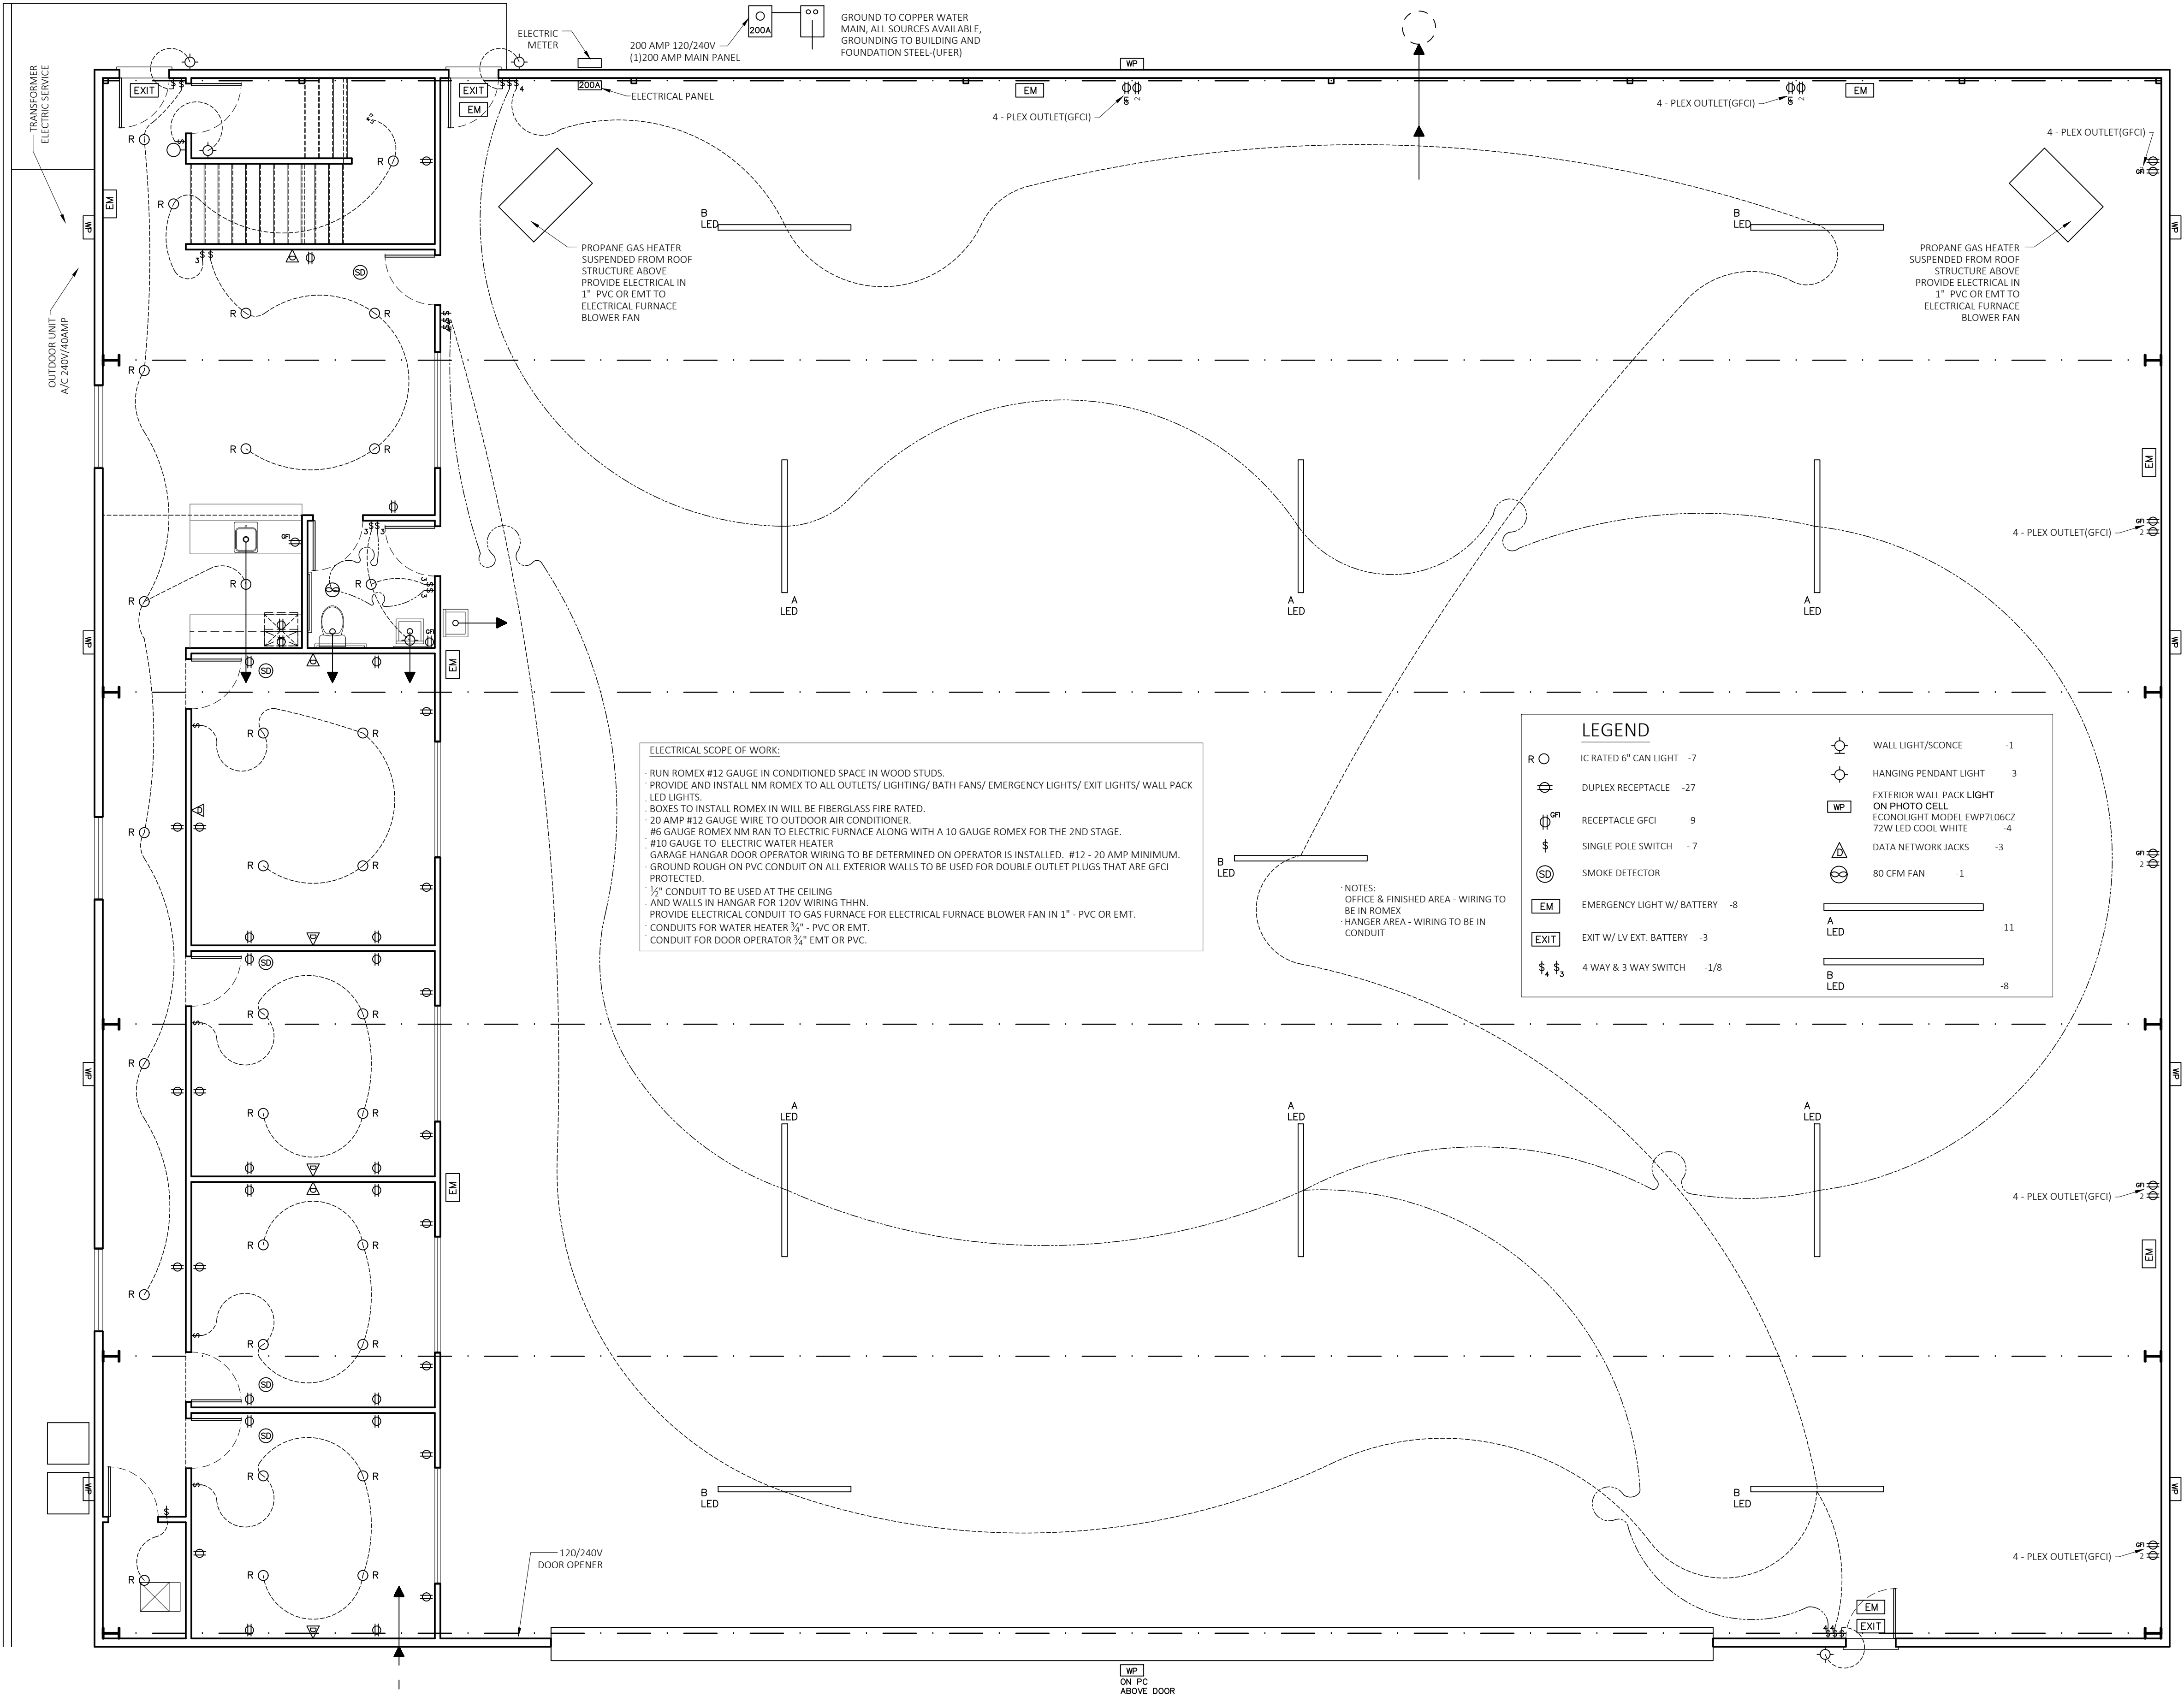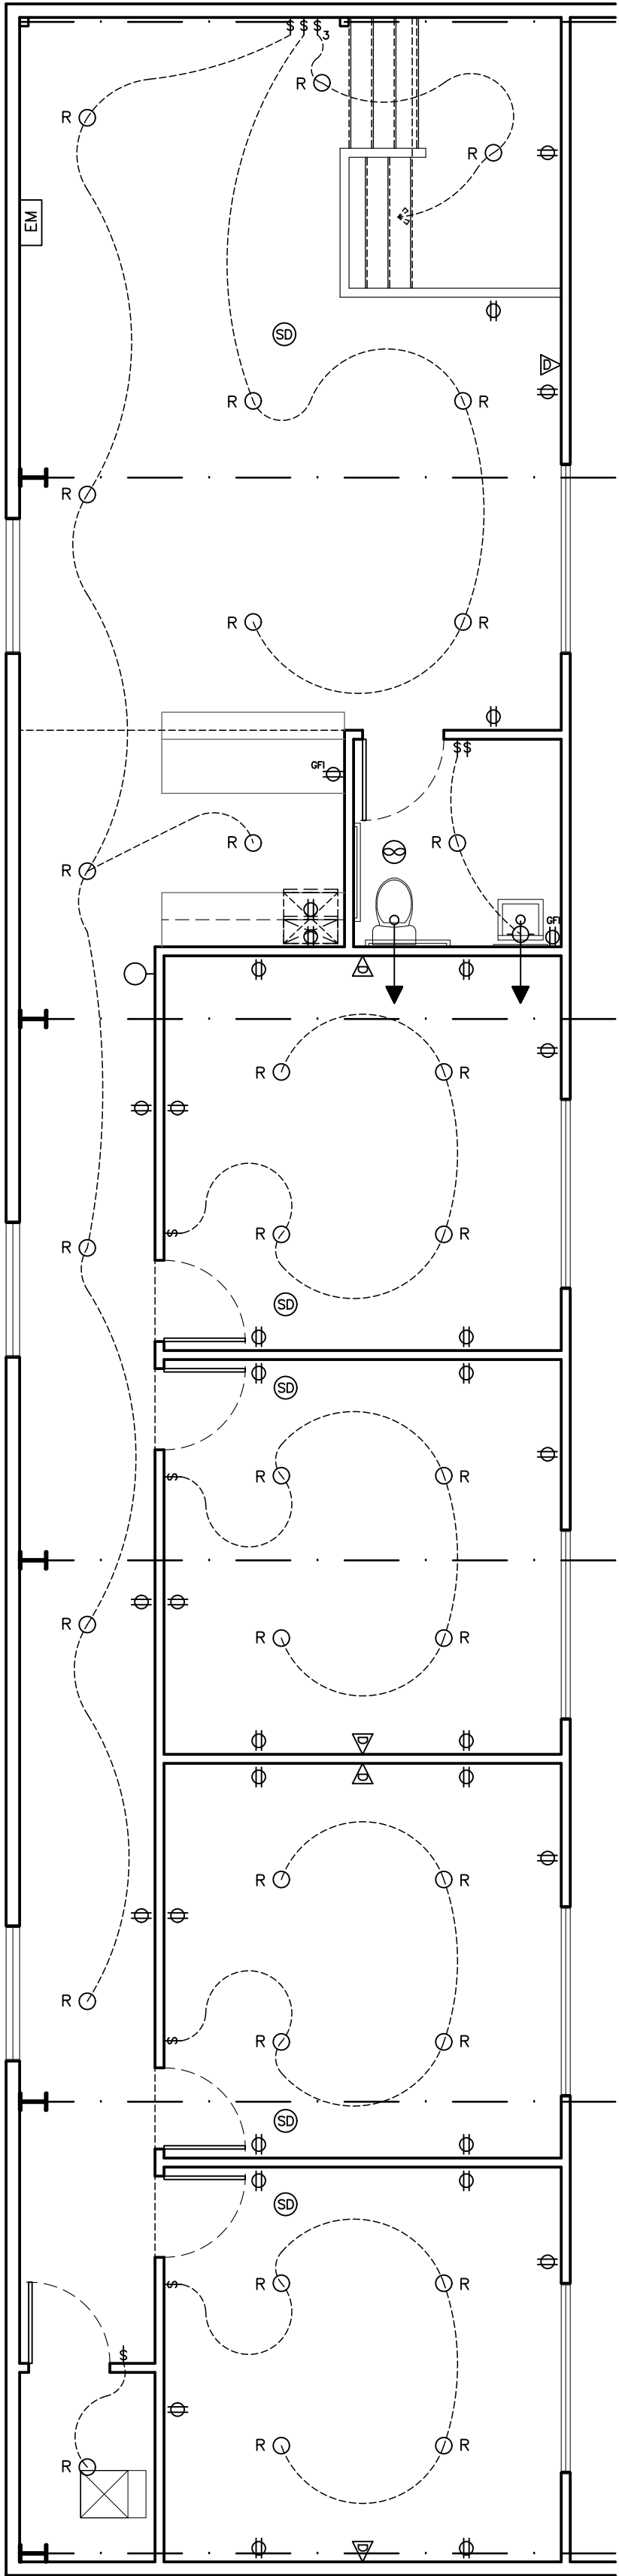

ELECTRICAL PLAN
SCALE 3/16"=1'-0"

SHEET SIZE: 24" x 36"

SEALED FOR STRUCTURAL
REVIEW



Signature Builders KC, LLC
2751 NE Douglas St. - Suite R
Lee's Summit, Missouri 64064
Phone: (816) 215-0891
Website:
www.sb-kc.net


New Airplane Hangar

CAD Construction Documents
Voice / Text : 913.638.3241
mgspencer@sbcglobal.net
Residential AutoCAD Drafting
and Design Services


No.	Description	Date

CONSTRUCTION DOCUMENTS		
Project Number	2019.03	
Date	2019 DEC 11	
Drawn By	CCD	
Checked By	SBKC	

A 102		
Scale	1/4" = 1'-0"	

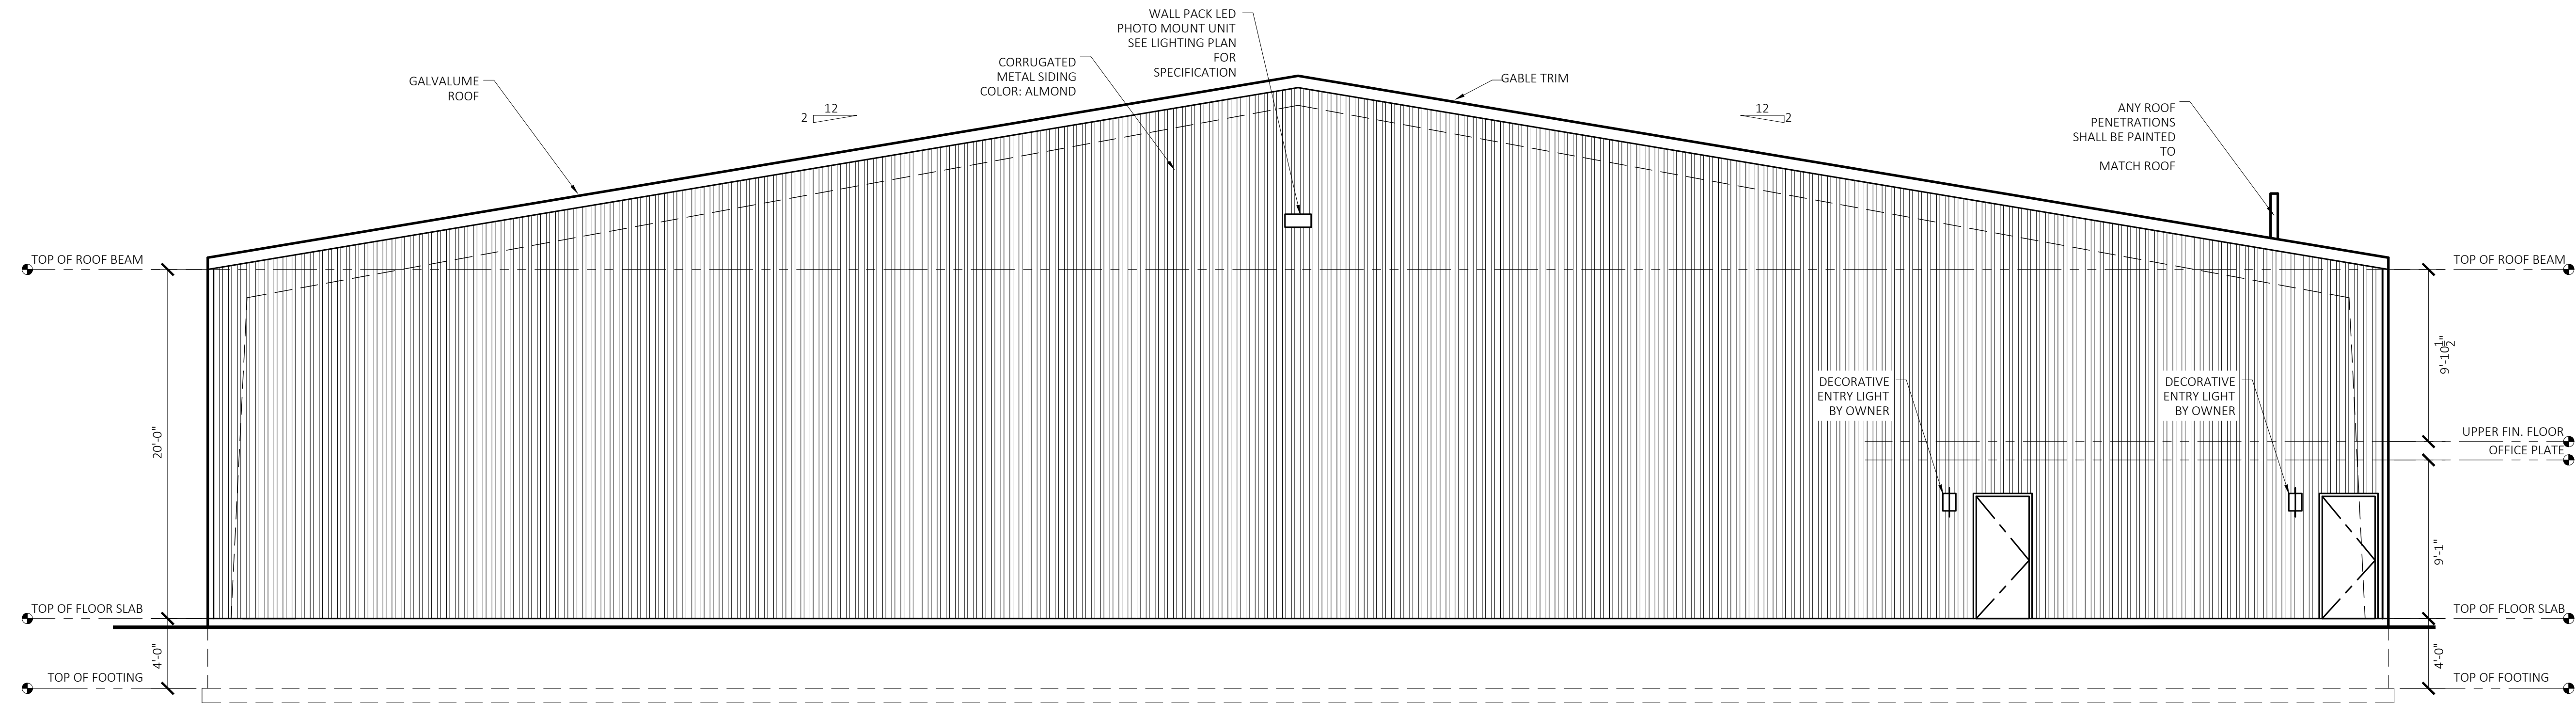

SOUTH ELEVATION
SCALE 3/16"=1'-0"

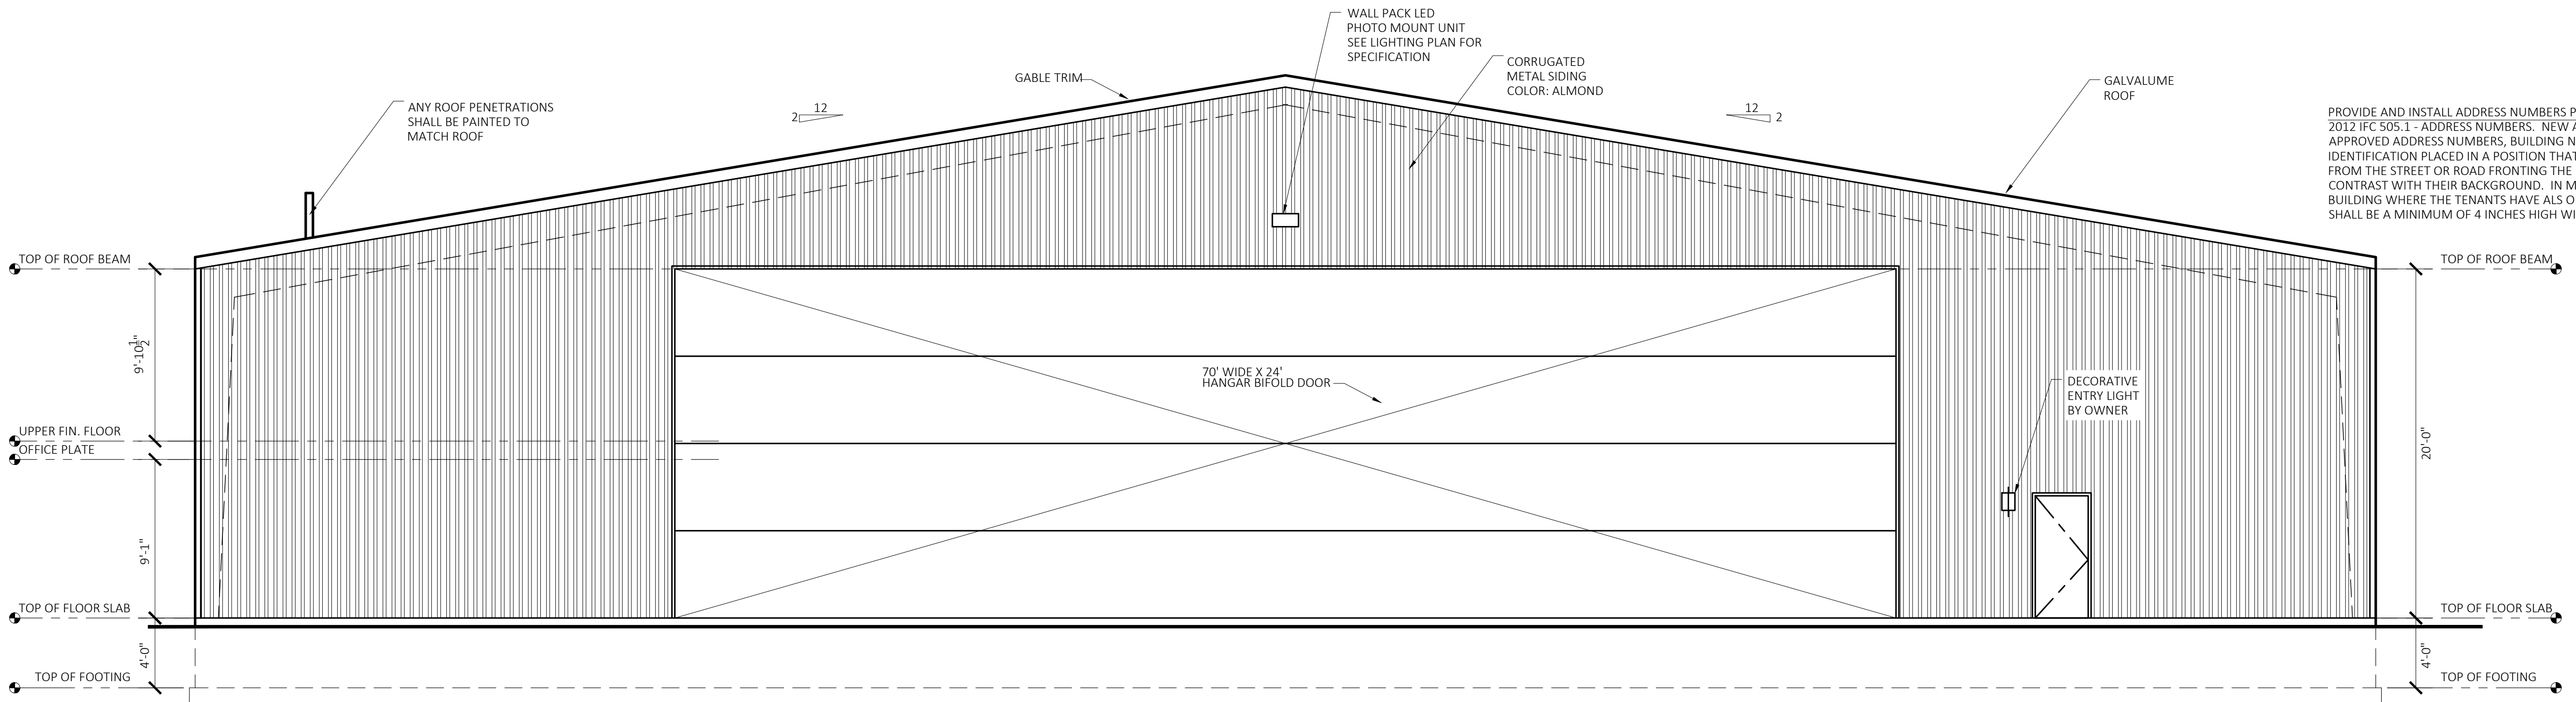

NORTH ELEVATION
SCALE 3/16"=1'-0"

SEALED FOR STRUCTURAL
REVIEW

Signature
BUILDERS
KC, LLC

Signature Builders KC, LLC
2751 NE Douglas St. - Suite R
Lee's Summit, Missouri 64064
Phone: (816) 215-0891

Website:
www.sb-kc.net

New Airplane Hangar

CAD Construction Documents
Voice / Text : 913.638.3241
mgspencer@sbcglobal.net

Residential AutoCAD Drafting
and Design Services

No.	Description	Date

CONSTRUCTION
DOCUMENTS

Project Number 2019.03


Date 2019 DEC 10

Drawn By CCD


Checked By SBKC

A 103

Scale 1/4" = 1'-0"

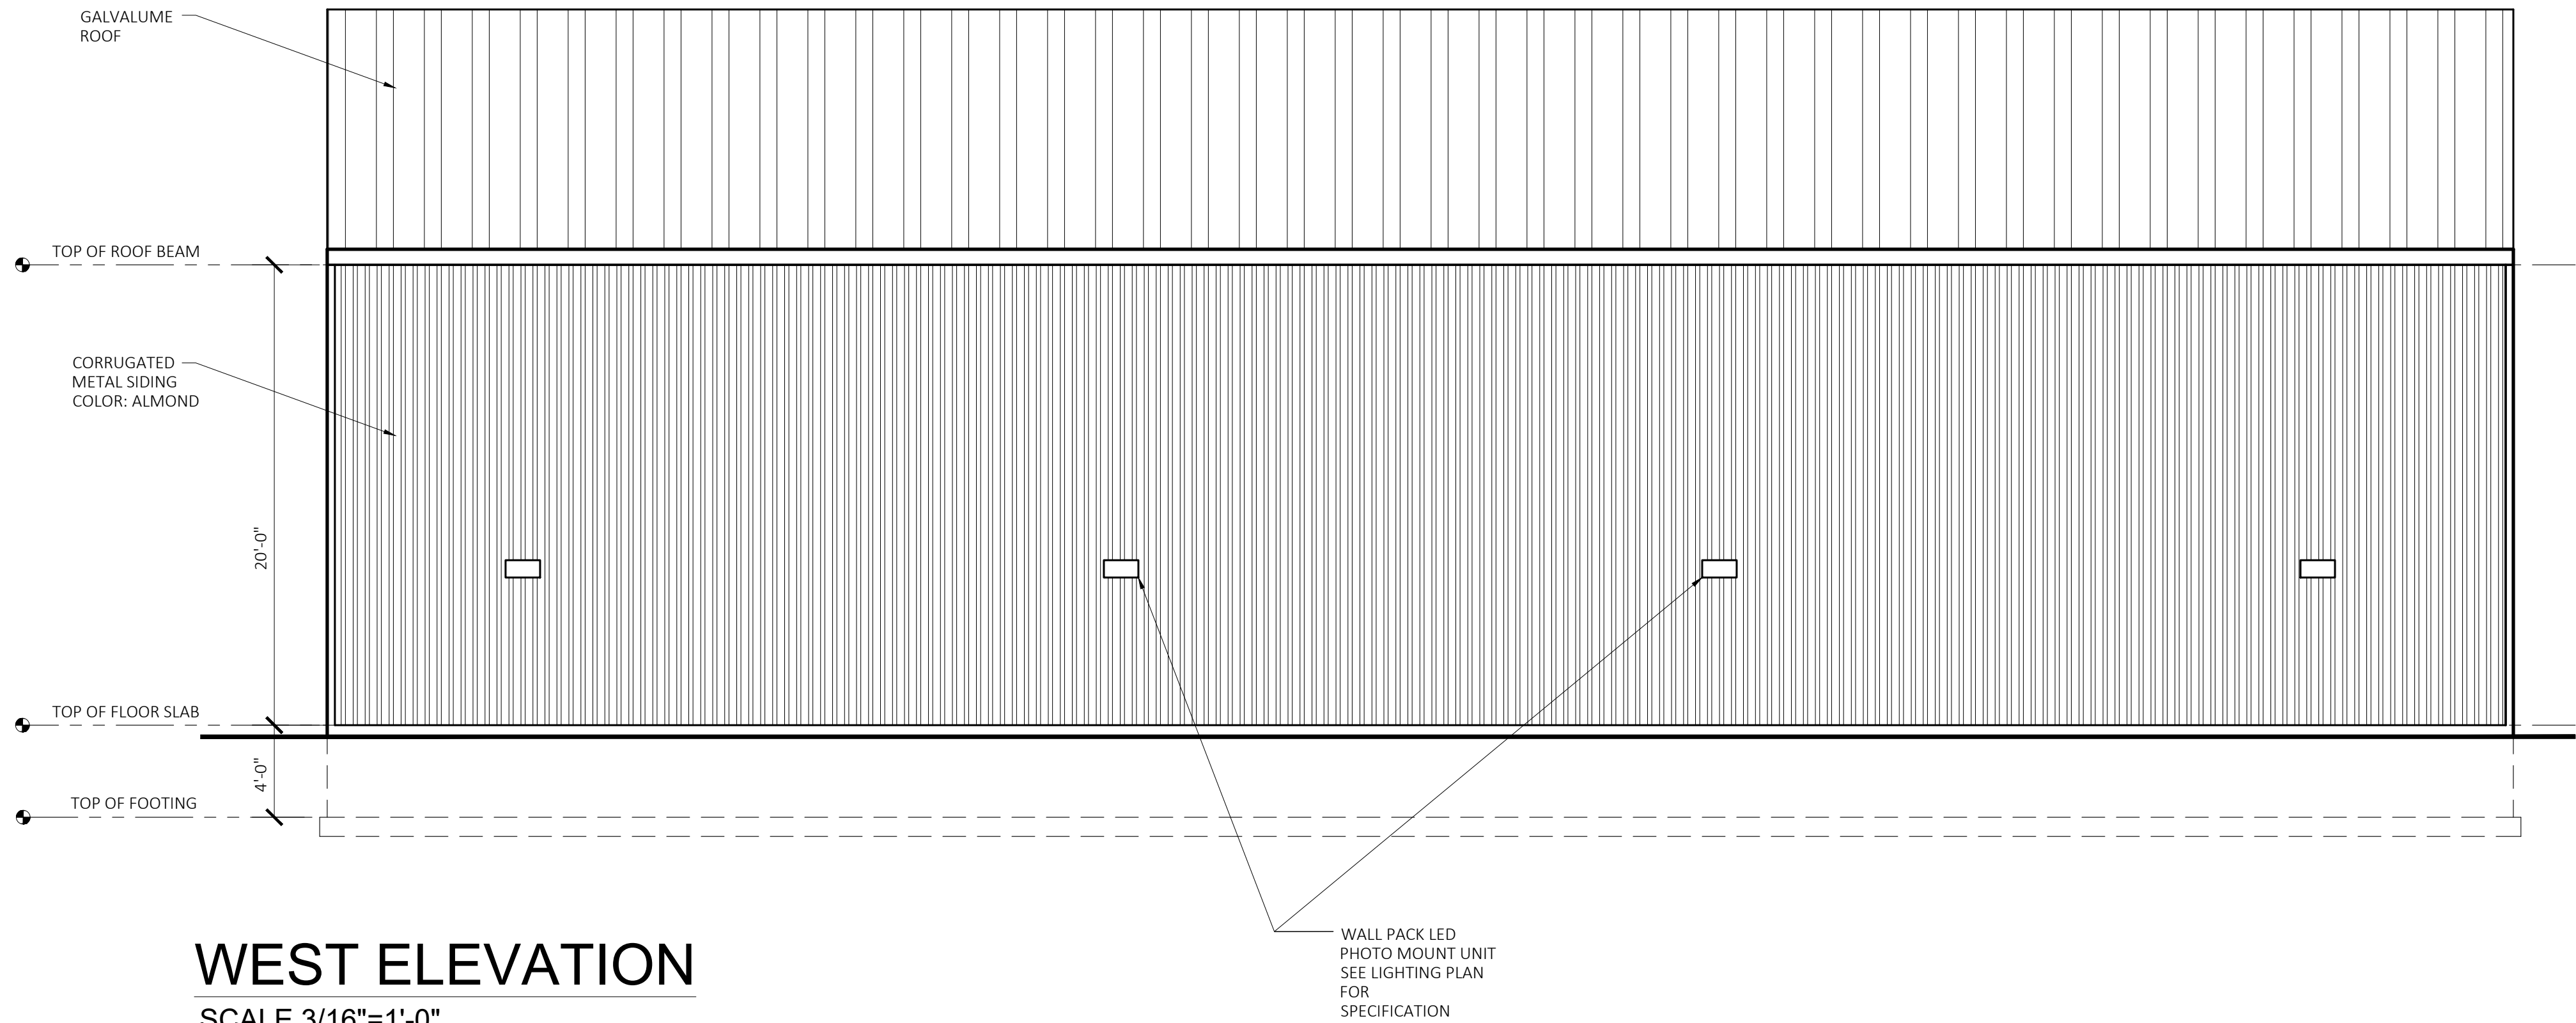

WEST ELEVATION
SCALE 3/16"=1'-0"

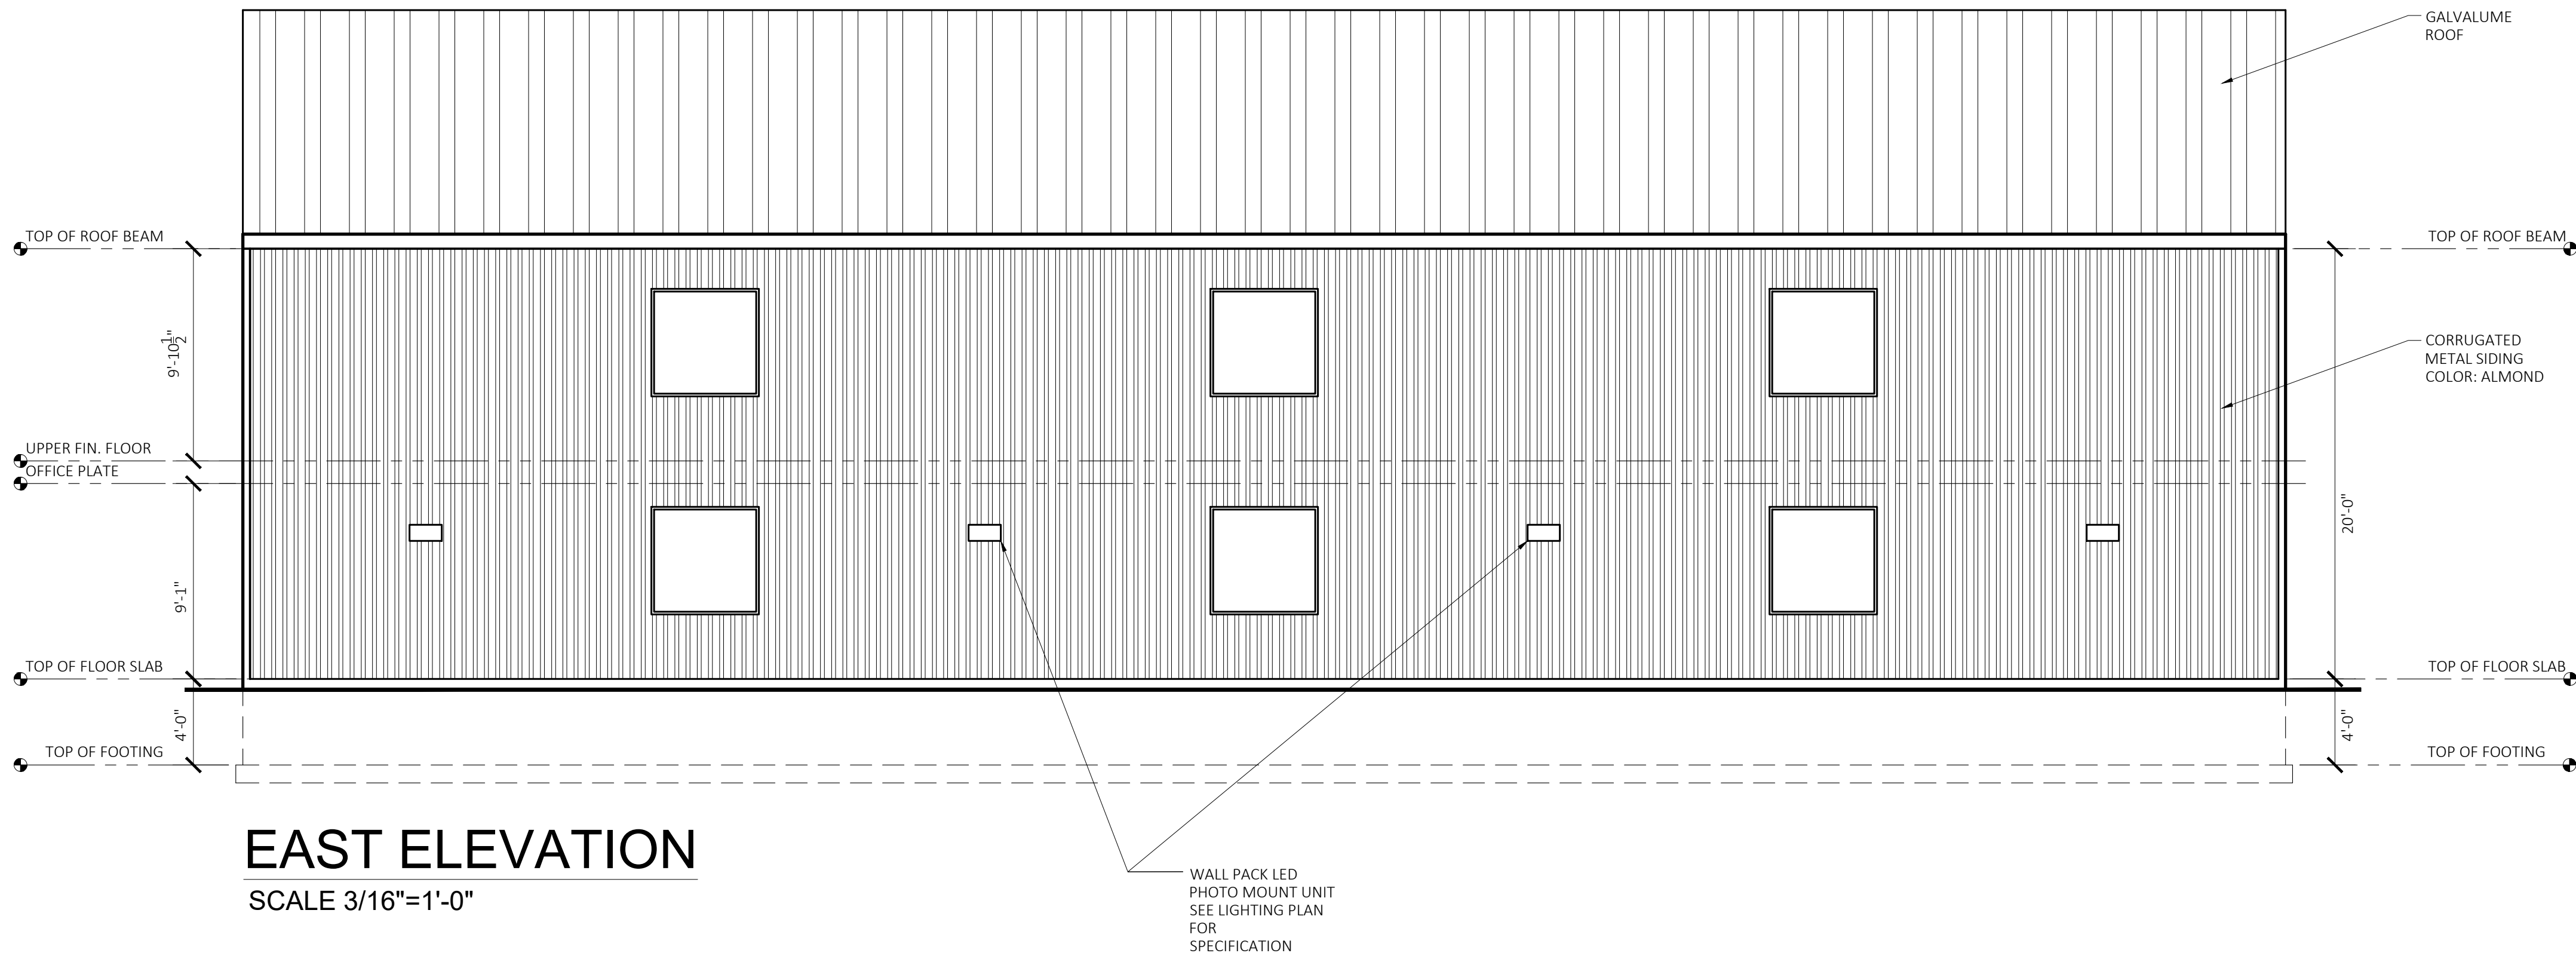

EAST ELEVATION
SCALE 3/16"=1'-0"

SEALED FOR STRUCTURAL
REVIEW



Signature Builders KC, LLC
2751 NE Douglas St. - Suite R
Lee's Summit, Missouri 64064
Phone: (816) 215-0891
Website:
www.sb-kc.net


New Airplane Hangar

CAD Construction Documents
Voice / Text : 913.638.3241
mgspencer@sbcglobal.net
Residential AutoCAD Drafting
and Design Services

No.	Description	Date

CONSTRUCTION DOCUMENTS		
Project Number	2019.03	
Date	2019 DEC 10	
Drawn By	CCD	
Checked By	SBKC	

A 104		
Scale	1/4" = 1'-0"	

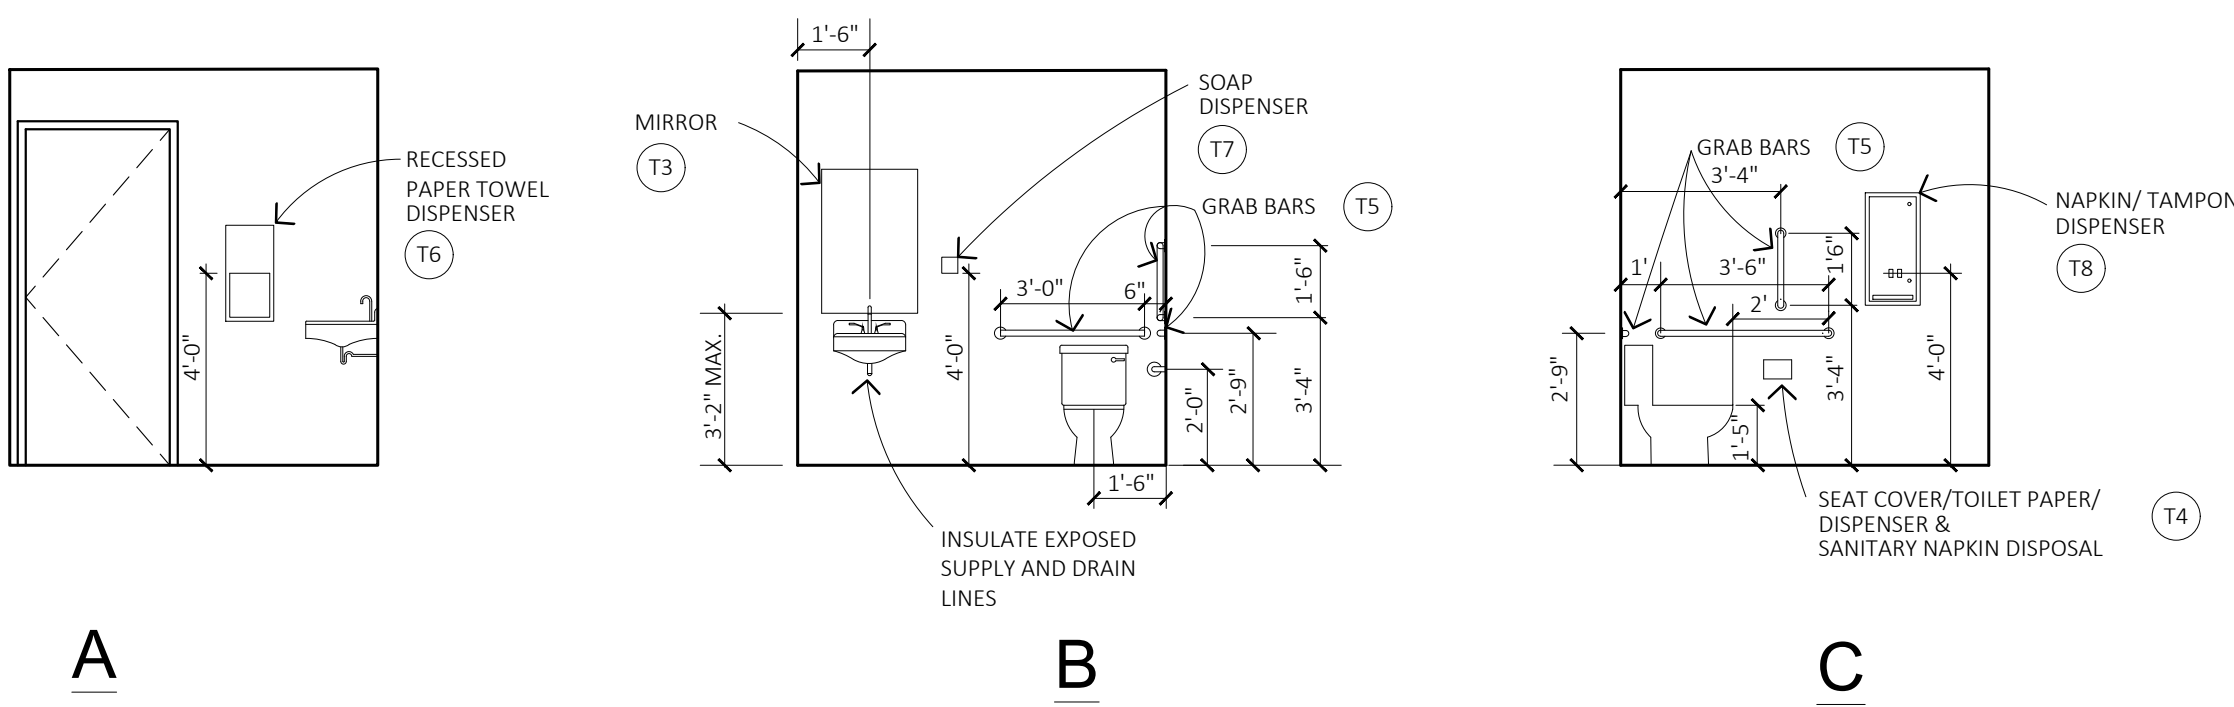

A

B

C

1 HANDICAP RESTROOM - INTERIOR ELEVATIONS

SCALE: 1/4"=1'-0"

- (T1) ADA COMPLIANT PORCELAIN WALL HUNG TOILET AMERICAN STANDARD OR EQUAL
- (T2) ADA COMPLIANT PORCELAIN WALL HUNG LAVATORY AMERICAN STANDARD OR EQUAL
- (T3) ADA COMPLIANT FRAMED MIRROR, SURFACE MOUNTED
- (T4) SEAT COVER DISPENSER/NAPKIN DISPOSAL AND TOILET TISSUE DISPENSER BOBRICK CLASSIC SERIES RECESSED DUAL UNIT MODEL NO. B-3574
- (T5) ADA GRAB BARS 18"L, 36"L & 42" L 34" A.F.F. Q OF BAR BOBRICK MODEL NO. B-6806X18, B-6806X36 AND B-6806X42, OR EQUAL W/ SS FINISH
- (T6) ADA COMPLIANT PAPER TOWEL DISPENSER BOBRICK STAINLESS STEEL TRASH RECEPTACLE UNIT #8369, OR EQUAL
- (T7) ADA COMPLIANT SOAP DISPENSER, WALL HUNG
- (T8) CLASSIC SERIES RECESSED NAPKIN/TAMPON VENDOR 25 CENT OPERATION AND 52" A.F.F. TO HIGHEST OPERABLE PART BOBRICK MODEL NO. B-3706 OR EQUAL W/ SS FINISH

PROVIDE AND INSTALL BATHROOM FIXTURES AND ACCESSORIES PER: 2012 ICC A117.1 - 2009 604.5.1 - FIXED SIDE WALL GRAB BARS, FIXED SIDE WALL GRAB BARS SHALL BE 42 INCHES MINIMUM IN LENGTH LOCATED 12 INCHES MAXIMUM FROM THE REAR WALL AND EXTENDING 54 INCHES MINIMUM FROM THE REAR WALL. IN ADDITION, A VERTICAL GRAB BAR 18 INCHES MINIMUM IN LENGTH GTH SHALL BE MOUNTED WITH THE BOTTOM OF THE BAR LOCATED 39 INCHES MINIMUM AND 41 INCHES MAXIMUM ABOVE THE FLOOR, AND WITH THE CENTER LINE OF THE BAR LOCATED 39 INCHES MINIMUM AND 41 INCHES MAXIMUM FROM THE REAR WALL. ALL PLUMBING FIXTURES AND TOILET ACCESSORIES TO BE ADA COMPLIANT, INSTALLED AS INDICATED AND IN COMPLIANCE WITH THE ADA AND PER MANUFACTURER'S GUIDELINES. INSTALL STEEL BACKER PLATES IN WALL ASSEMBLY TO SUPPORT GRAB BARS. COMPLETED ASSEMBLY CAPABLE OF SUPPORTING A MINIMUM VERTICAL OR HORIZONTAL FORCE OF 250 LBS. WITHOUT DAMAGE TO ANY PART OF THE ASSEMBLY.

2 RESTROOM FIXTURES AND ACCESSORIES LEGEND AND SPECIFICATIONS

SEALED FOR STRUCTURAL REVIEW



Signature Builders KC, LLC
2751 NE Douglas St. - Suite R
Lee's Summit, Missouri 64064
Phone: (816) 215-0891

Website:
www.sb-kc.net

New Airplane Hangar

CAD Construction Documents
Voice / Text : 913.638.3241
mgspencer@sbcglobal.net

Residential AutoCAD Drafting
and Design Services

No.	Description	Date
CONSTRUCTION DOCUMENTS		
Project Number	2019.03	
Date	2019 DEC 10	
Drawn By	CCD	
Checked By	SBKC	

A 105
Scale 1/4" = 1'-0"