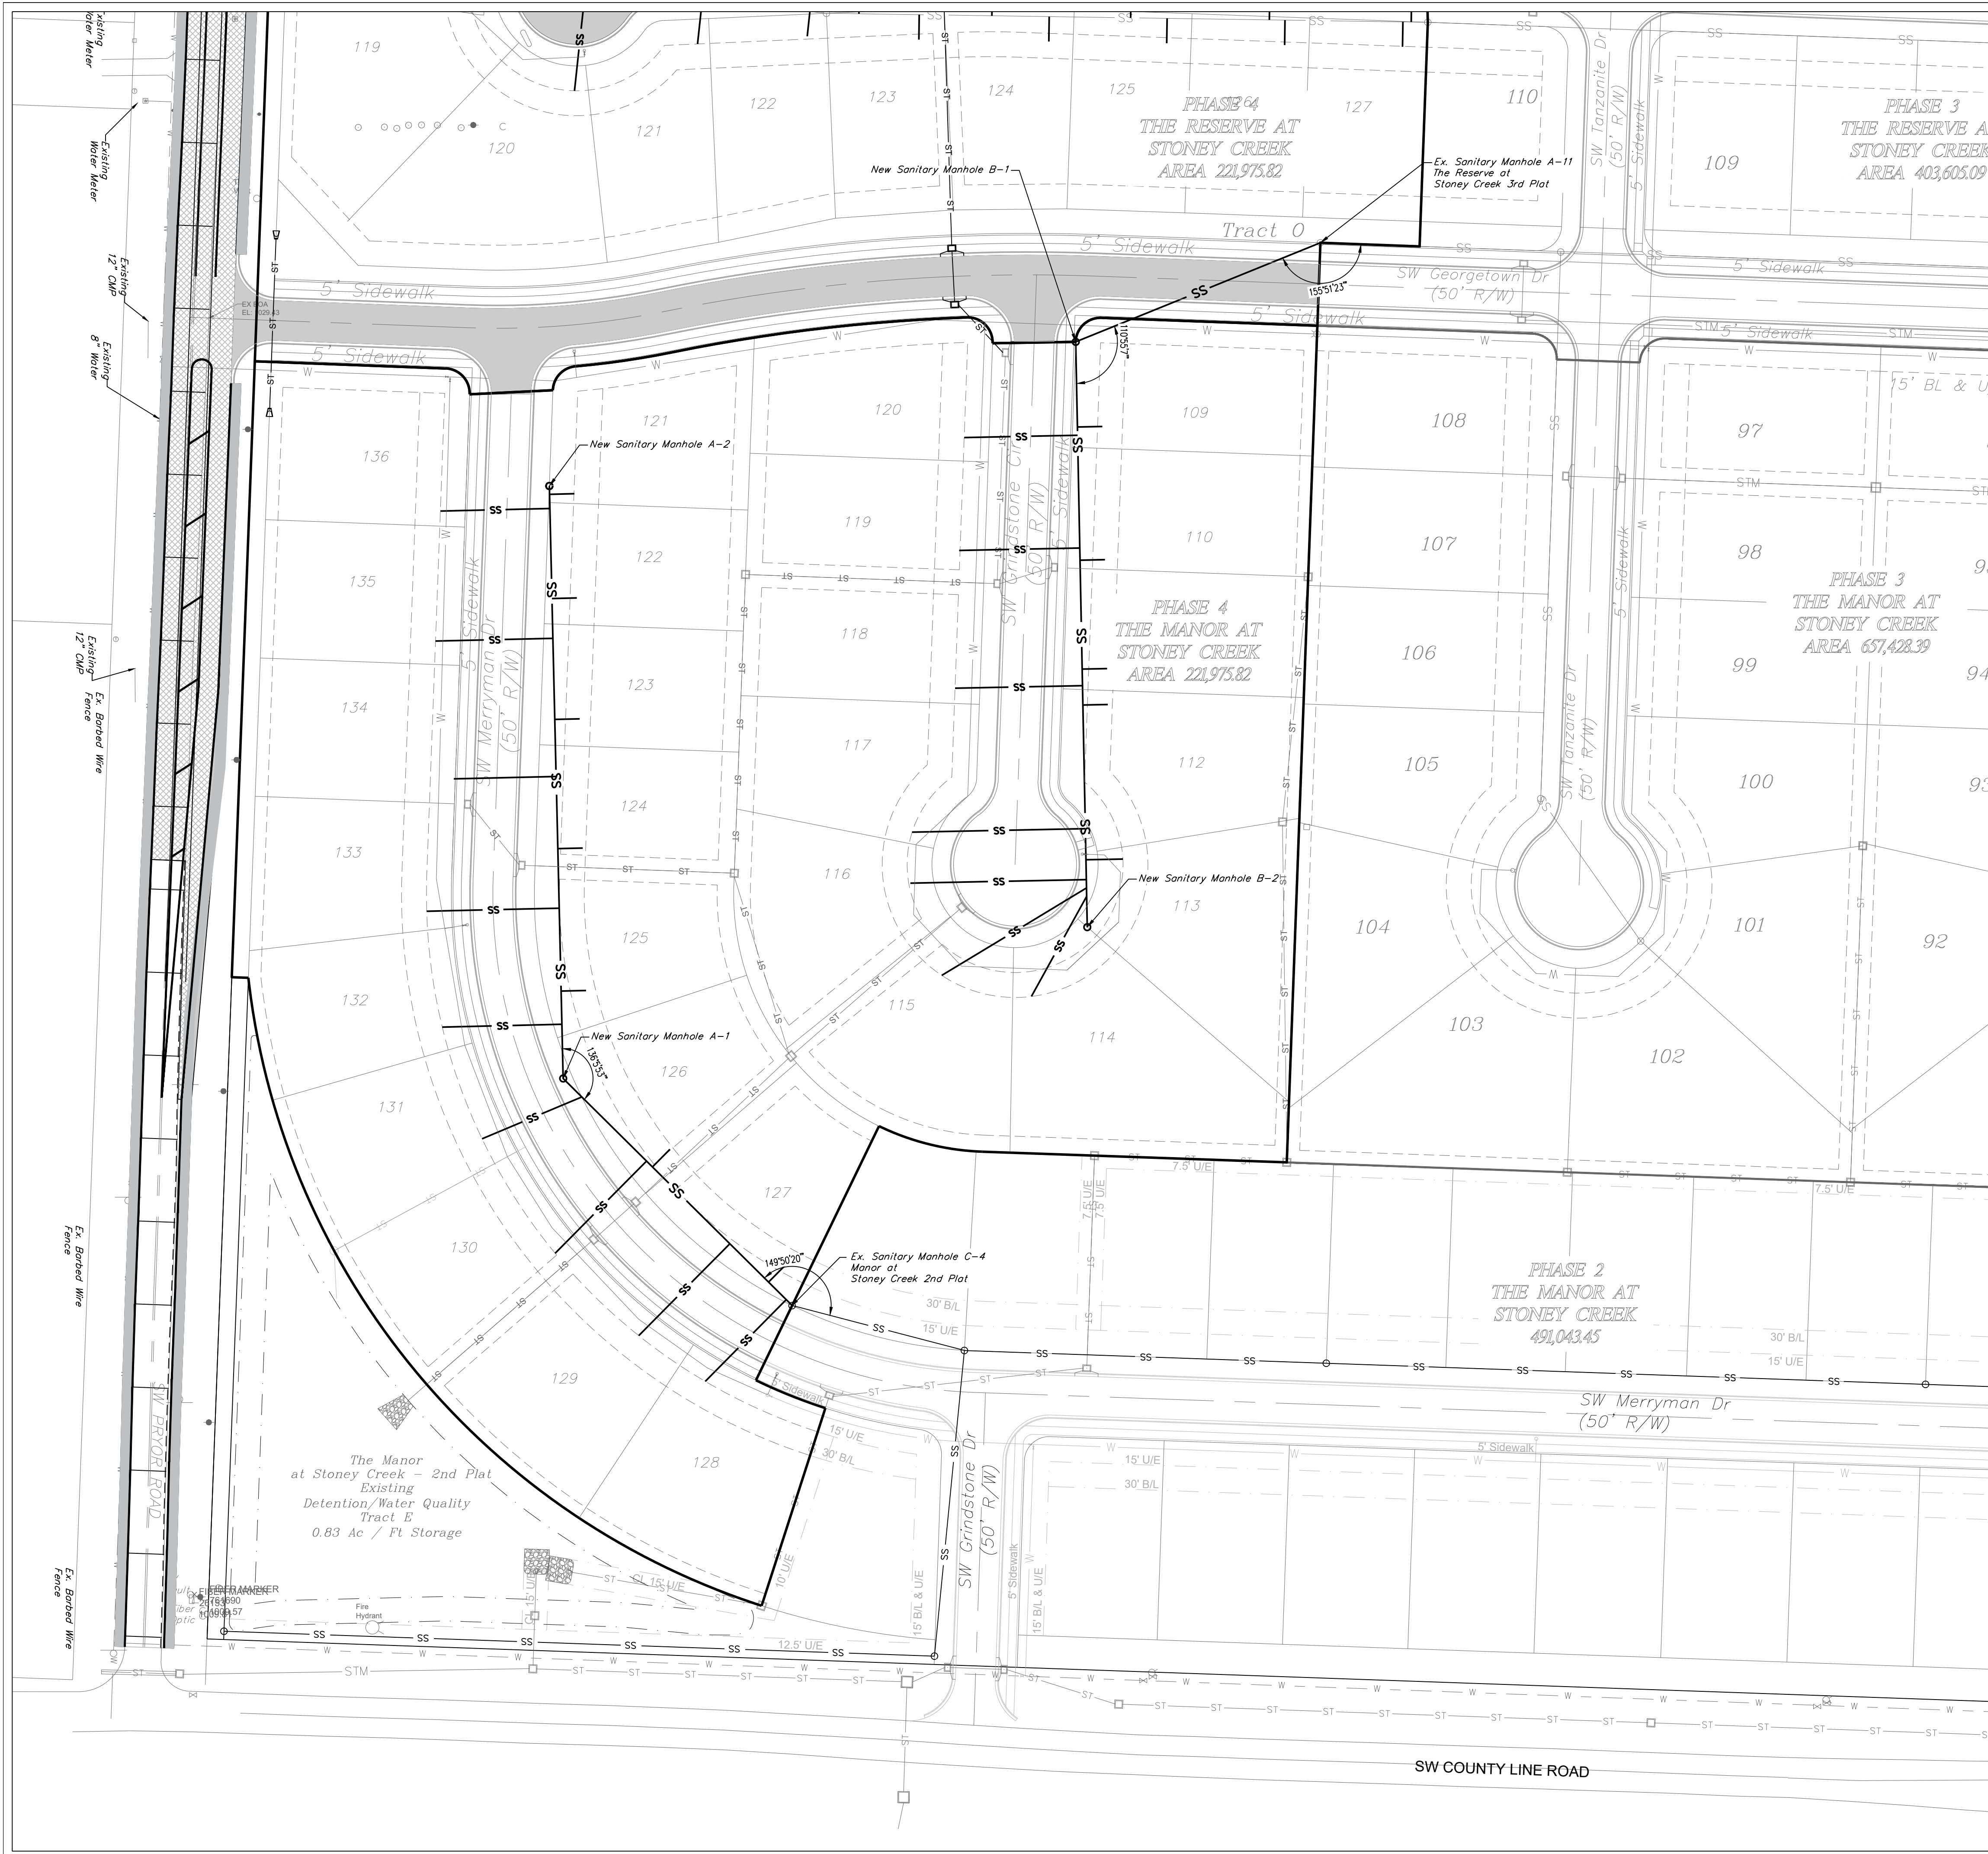


GENERAL NOTE:
1 ~ ALL CONSTRUCTION SHALL CONFORM TO THE CITY OF LEE'S SUMMIT DESIGN AND CONSTRUCTION MANUAL AS ADOPTED BY ORDINANCE 5813.
2 ~ TRENCH CHECKS SHALL BE INSTALL AT ALL SANITARY WYES LOCATION.

ENGINEERING
ENGINEERING & SURVEYING
SOLUTIONS

50 SE 30TH STREET
LEE'S SUMMIT, MO 64082
P: (816) 623-9888 F: (816) 623-9849

Professional Registration
Missouri
Engineering 2005002188-D
Surveying 2005005119-D
Kansas
Engineering E-1695
Surveying LS-218
Oklahoma
Engineering 6254
Nebraska
Engineering CA2821

The Manor at Stoney Creek - 4th Plat
Lee's Summit, Jackson County, Missouri

Project: MANOR AT STONEY CREEK 4TH PLAT
Issue: 01
Date: August 29, 2018

Sanitary Sewer General Layout
Construction Plans for:
The Manor at Stoney Creek - 4th Plat
Lee's Summit, Jackson County, Missouri

Matthew J. Schlicht
MO PE 2006019708
KS PE 19071
OK PE 25226

 

REVISIONS
11/16/2020 As-Built

"AS-BUILT"


900.10
~~900.00~~ Indicates data replaced with "As-Built" information. All other data is as designed and has not been field verified.

C. 401




GENERAL NOTE:
1 - ALL CONSTRUCTION SHALL CONFORM TO THE CITY OF LEE'S SUMMIT DESIGN AND CONSTRUCTION MANUAL AS ADOPTED BY ORDINANCE 5813.
2 - TRENCH CHECKS SHALL BE INSTALL AT ALL SANITARY WYES LOCATION.

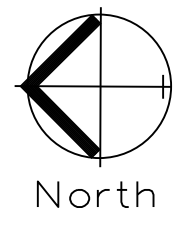

Sanitary Plan & Profile
SCALE: 1" = 50'

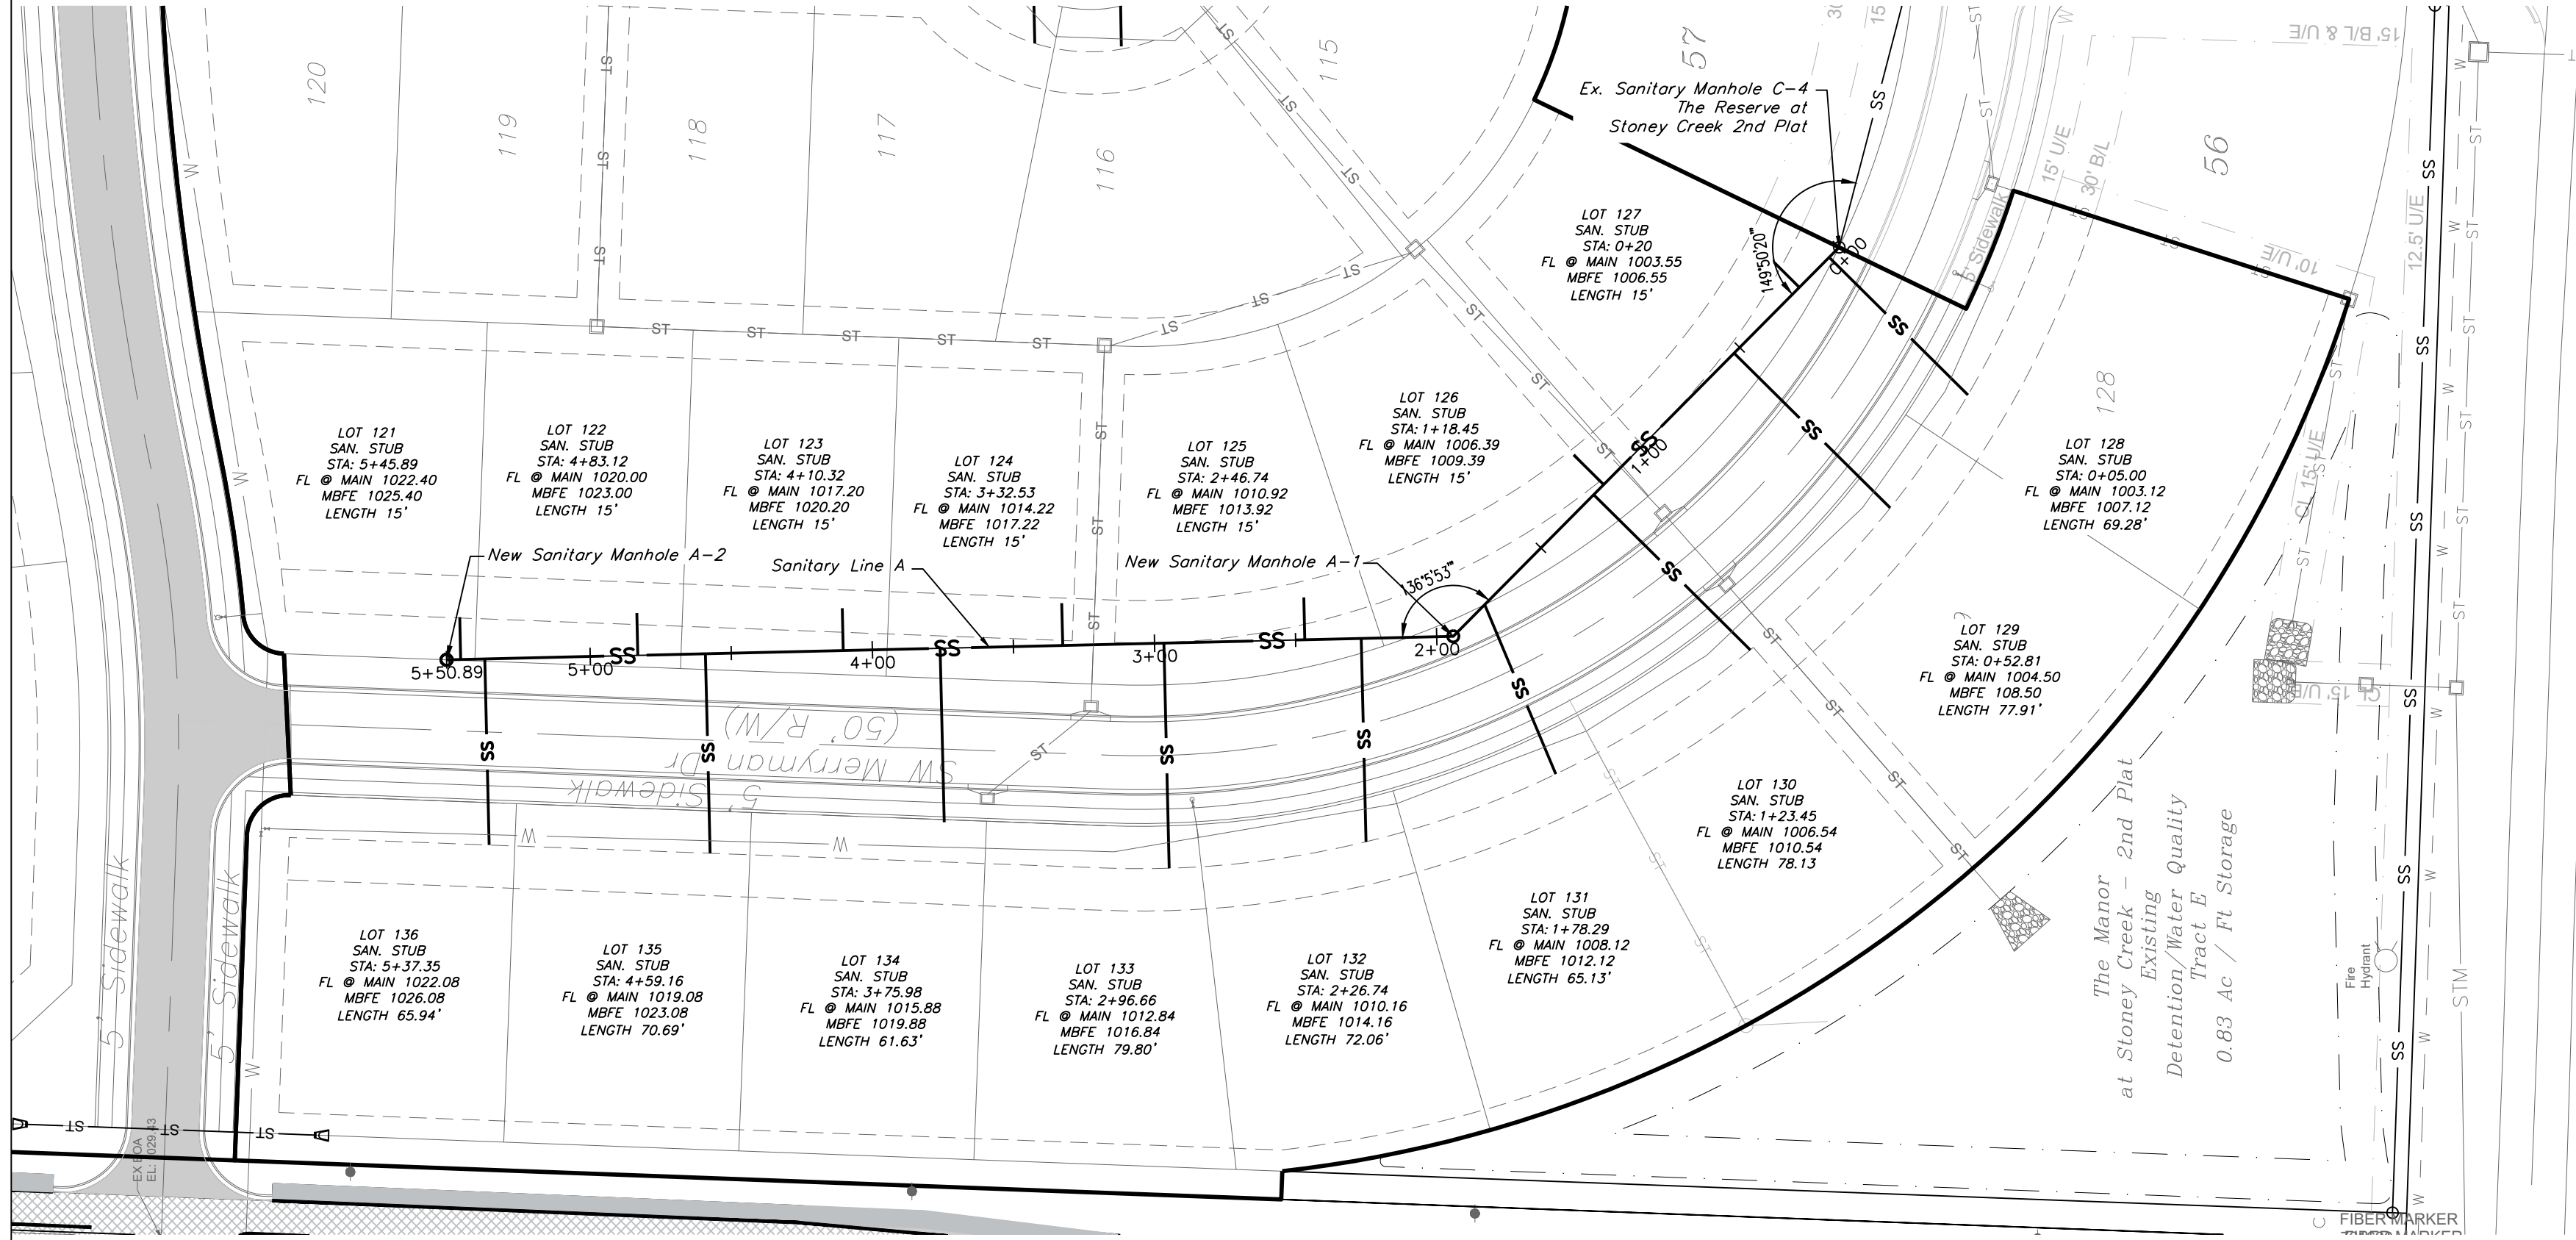



SANITARY LINE A

  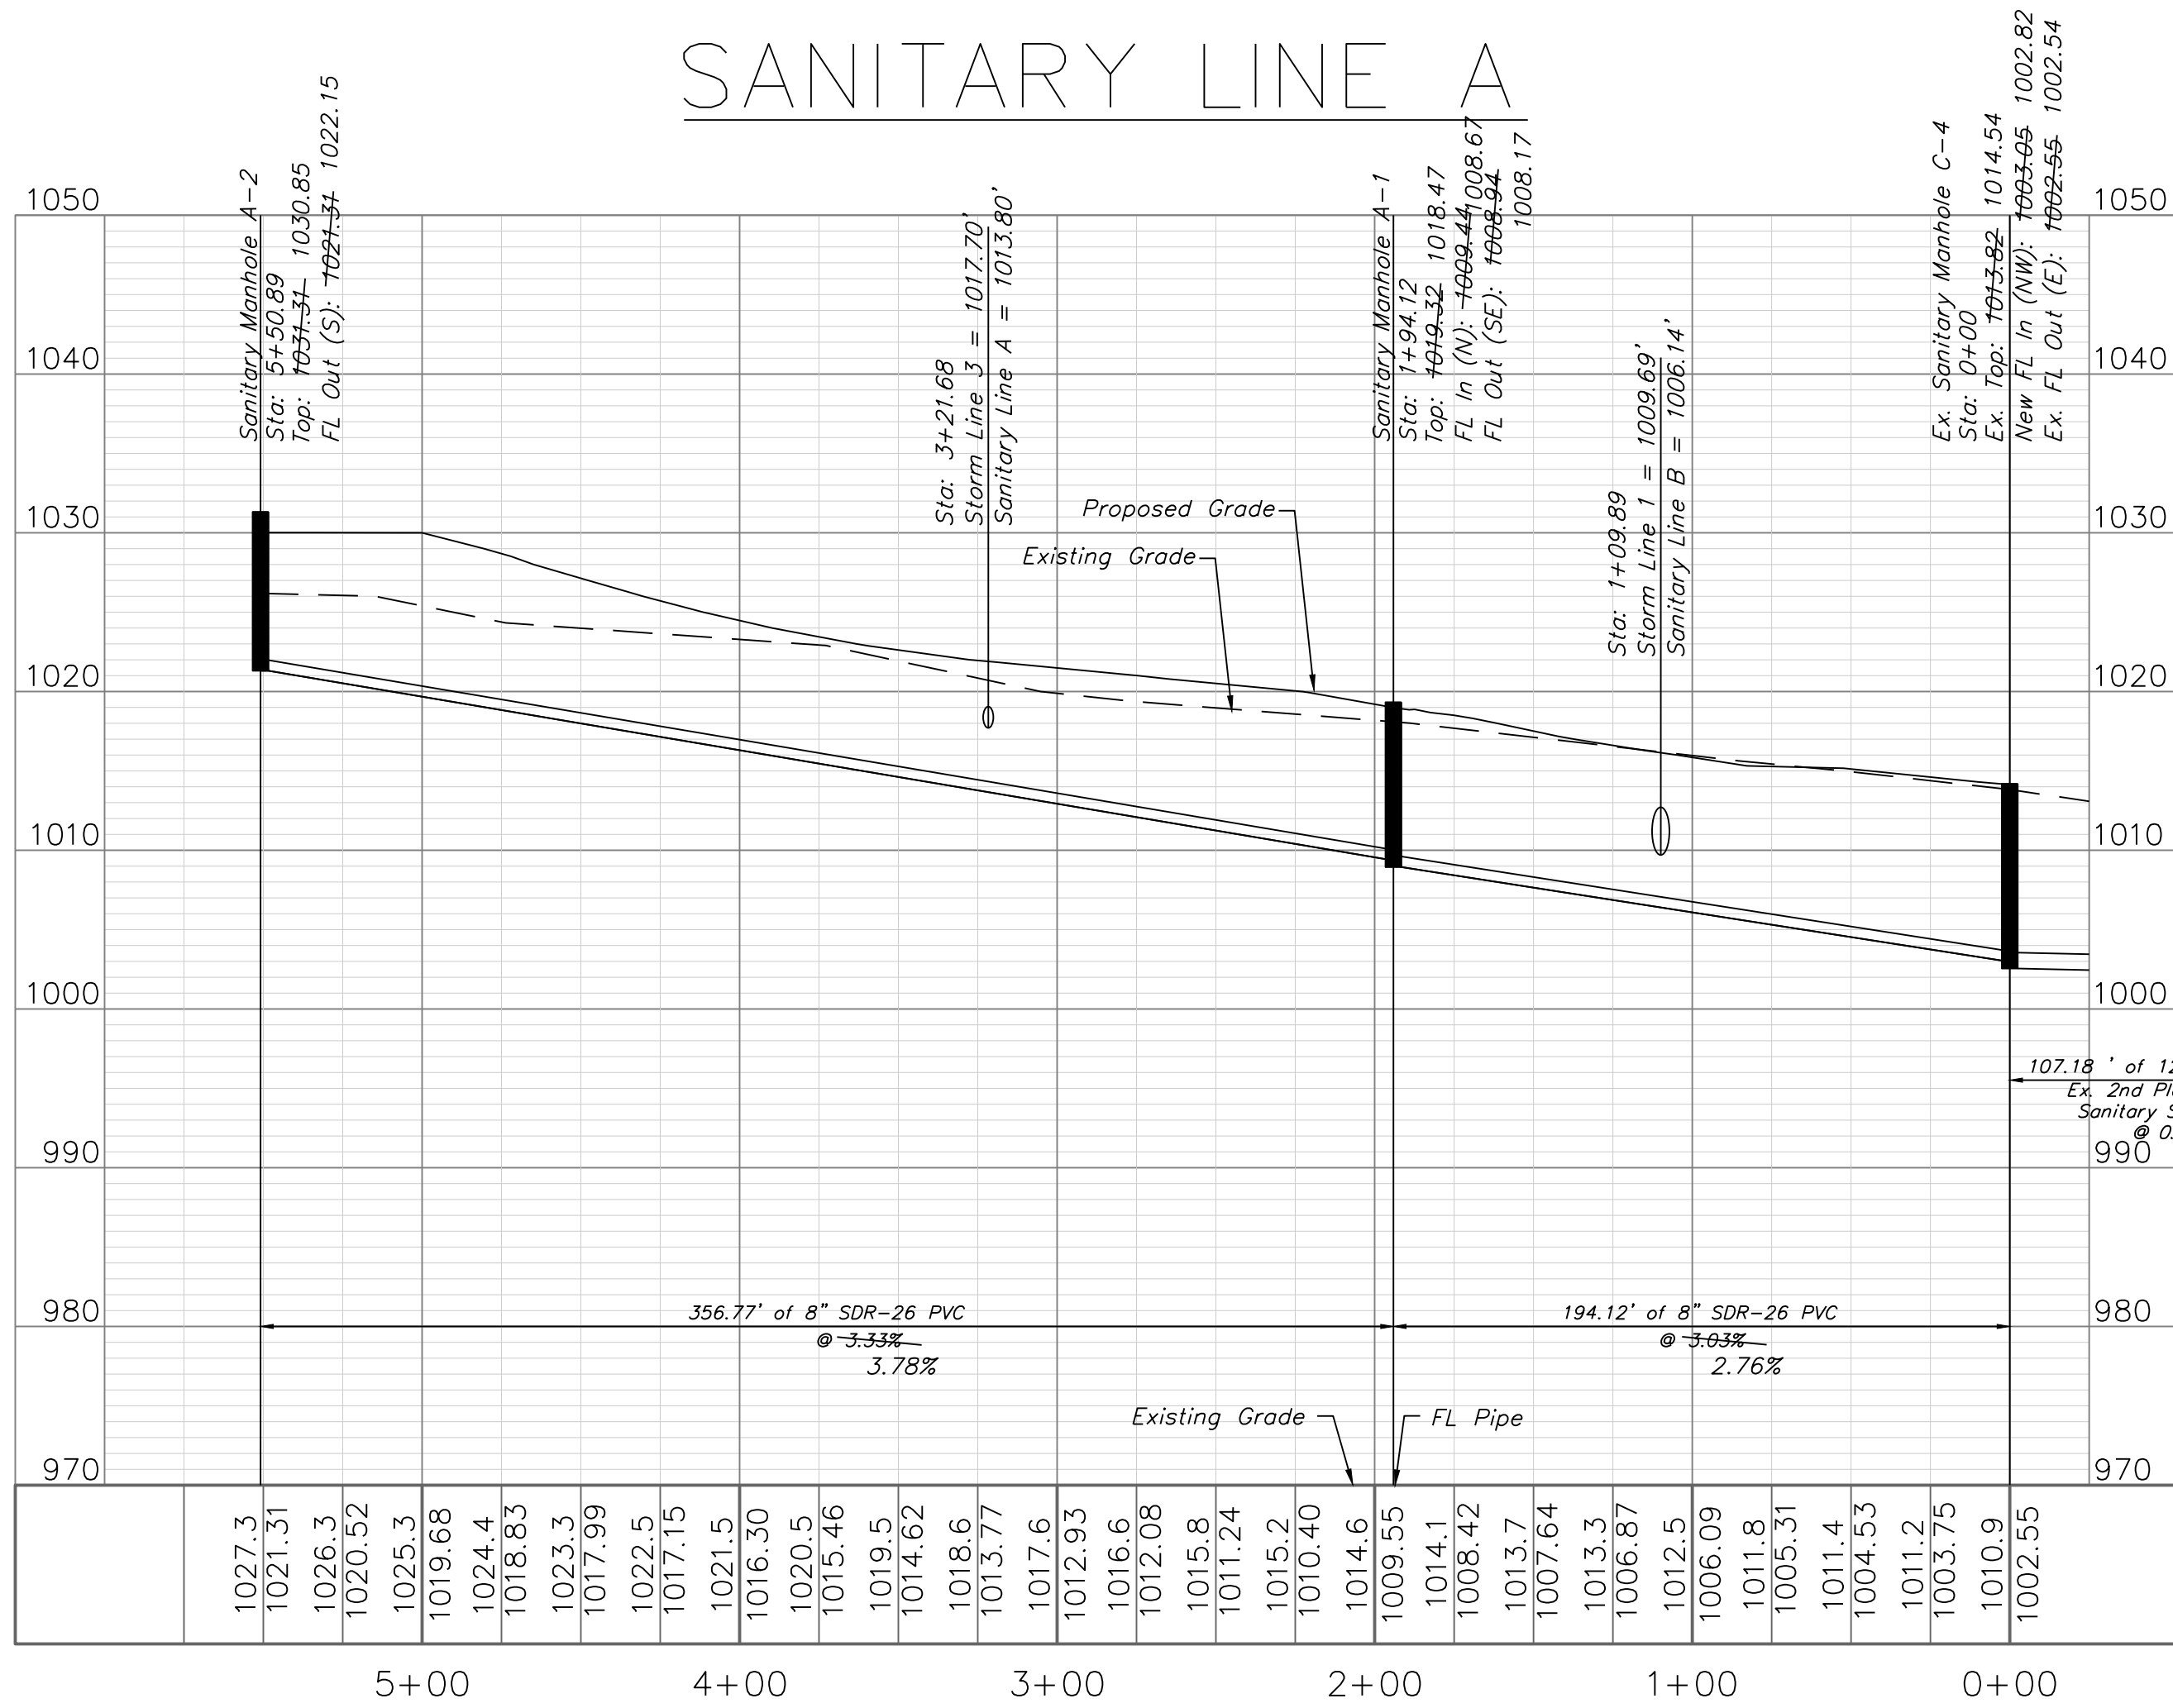

Sanitary Plan & Profile
SCALE: 1" = 50'



 SANITARY LINE B

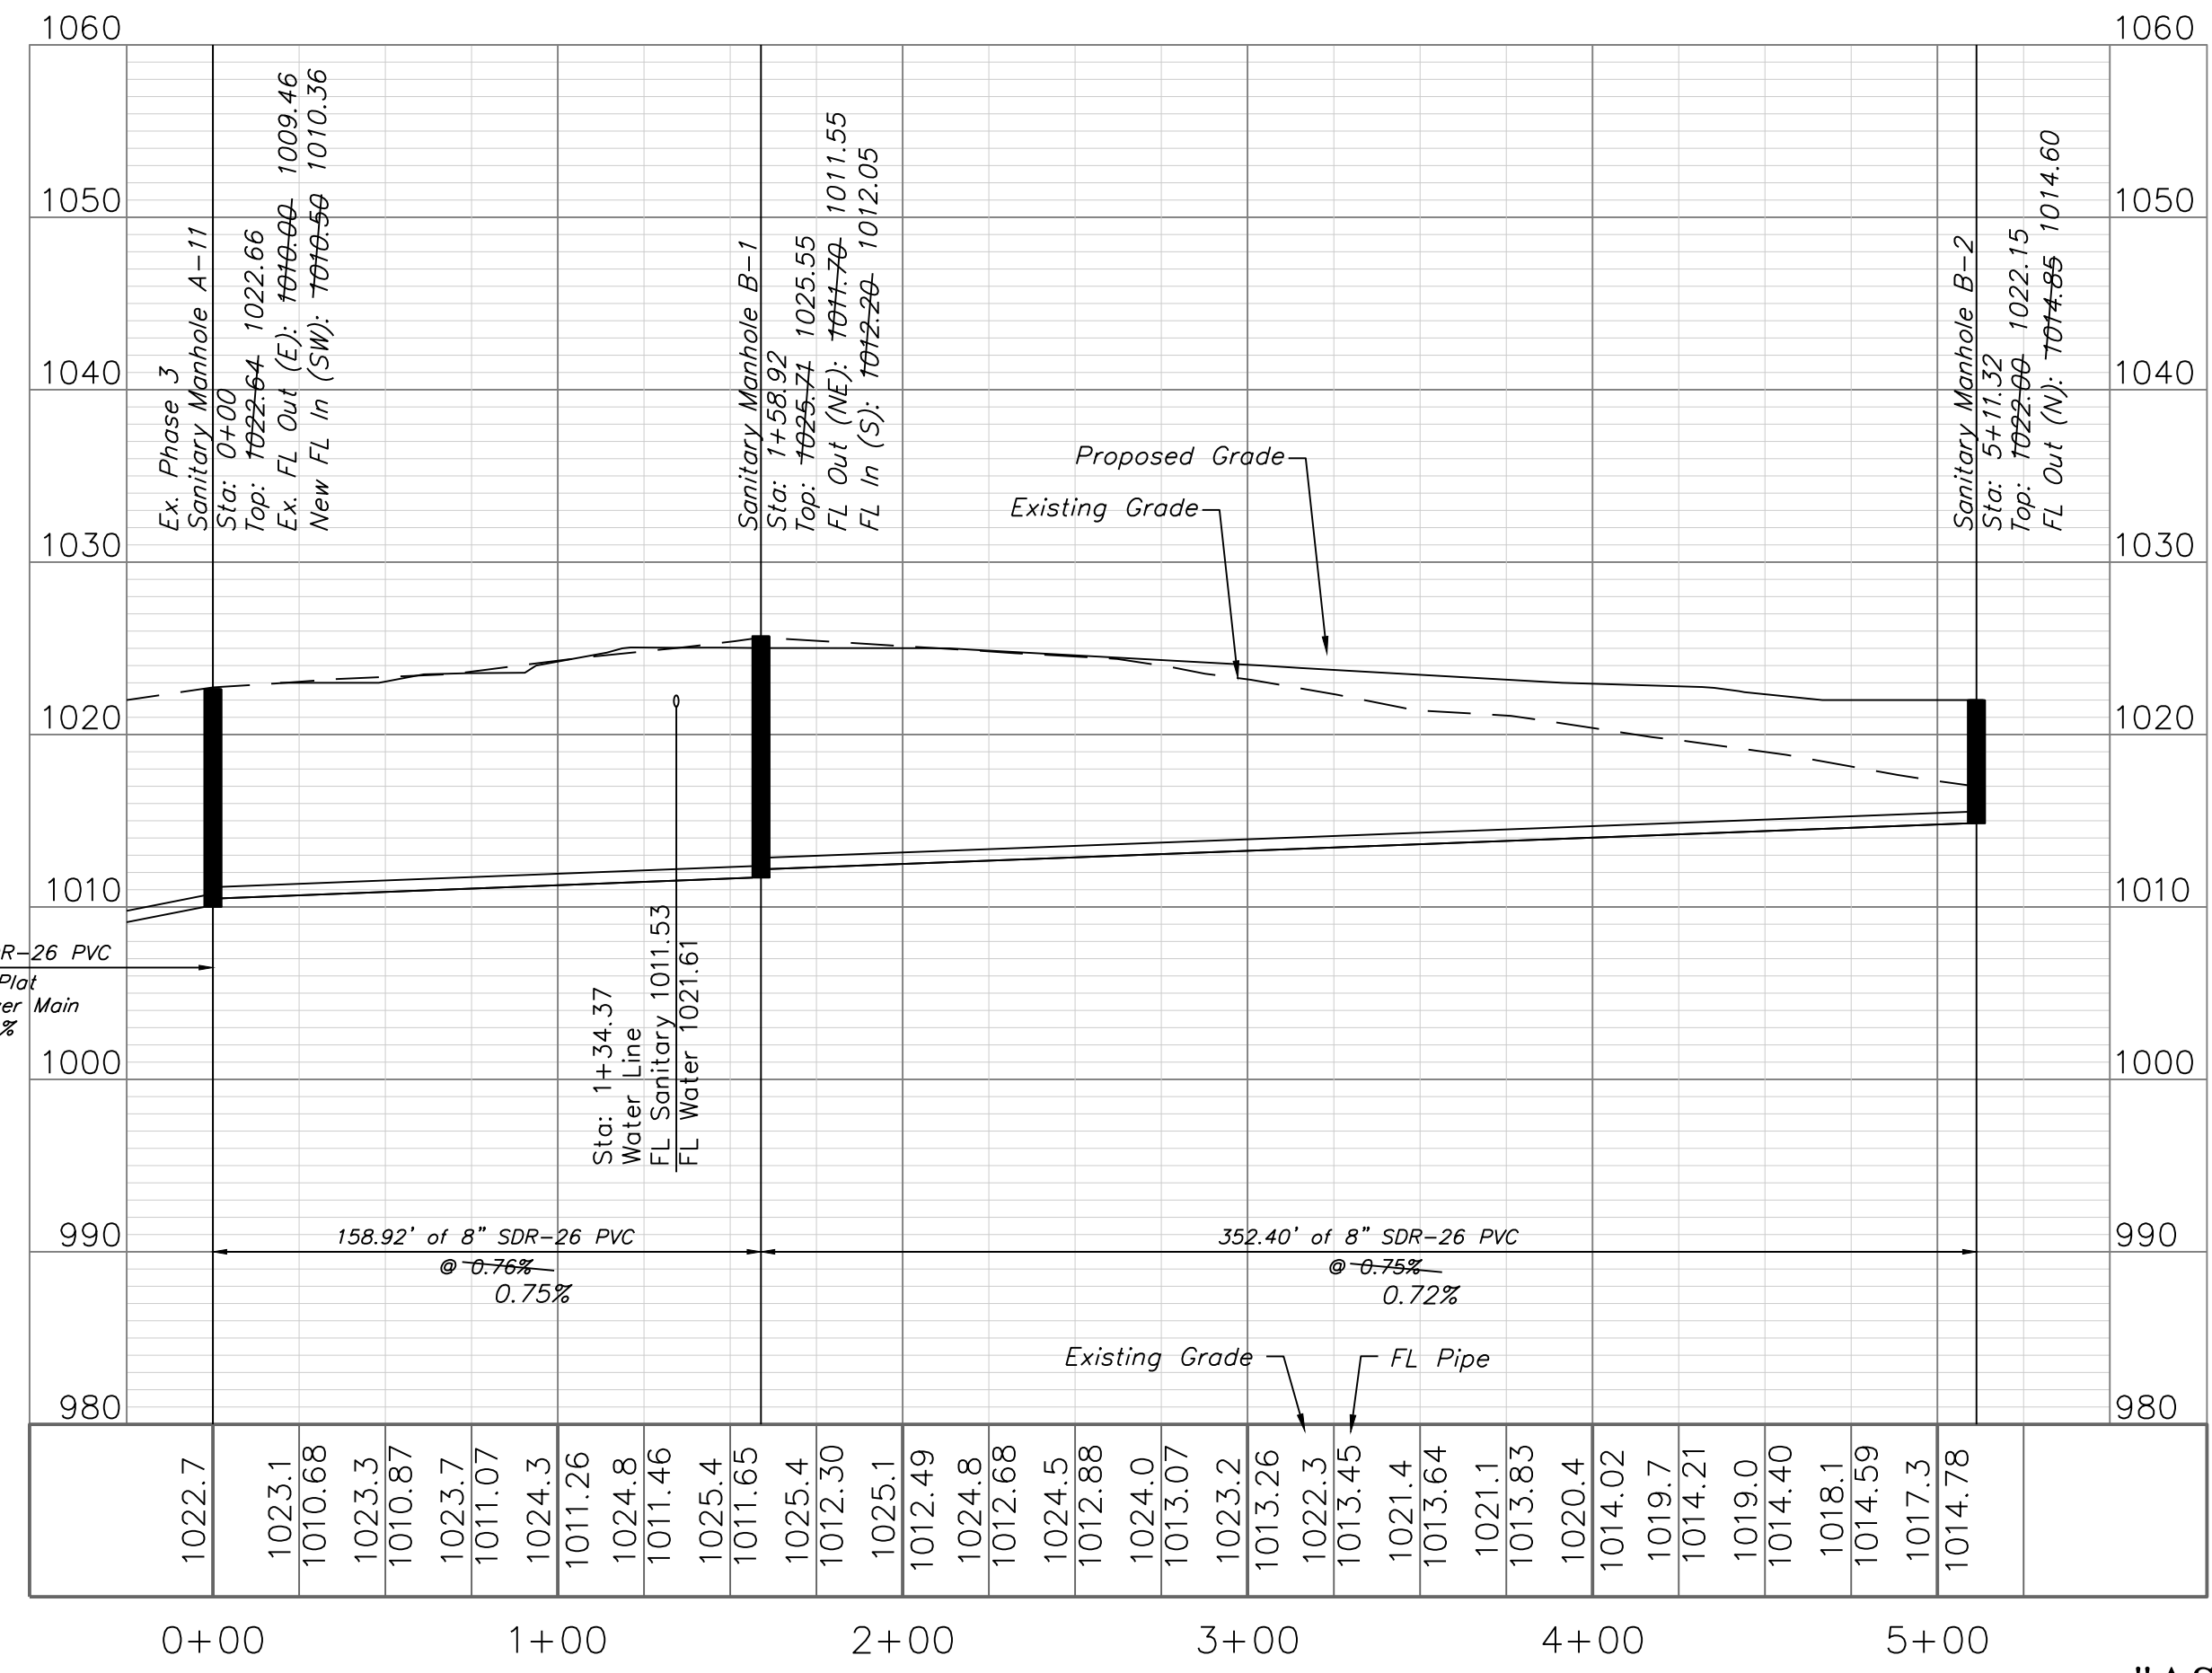

"AS-BUILT"


900.10
900.00 Indicates data replaced with "As-Built" information. All other data is as designed and has not been field verified.

Professional Registration
Missouri
Engineering 2005002198-D
Surveying 2005003199-D
Kansas
Engineering E-1695
Surveying LS-218
Oklahoma
Engineering 6254
Nebraska
Engineering CA2821

The Manor at Stoney Creek - 4th Plat
Lee's Summit, Jackson County, Missouri


Project: MANOR AT STONEY CREEK 4TH PLAT
Issue Date: August 29, 2018

Sanitary Plan and Profile
Construction Plans for:
The Manor at Stoney Creek - 4th Plat
Lee's Summit, Jackson County, Missouri

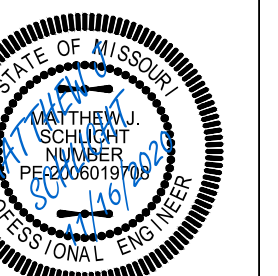


Matthew J. Schlicht
MO PE 2006019708
KS PE 19071
OK PE 25226


REVISIONS
11/16/2020 As-Built

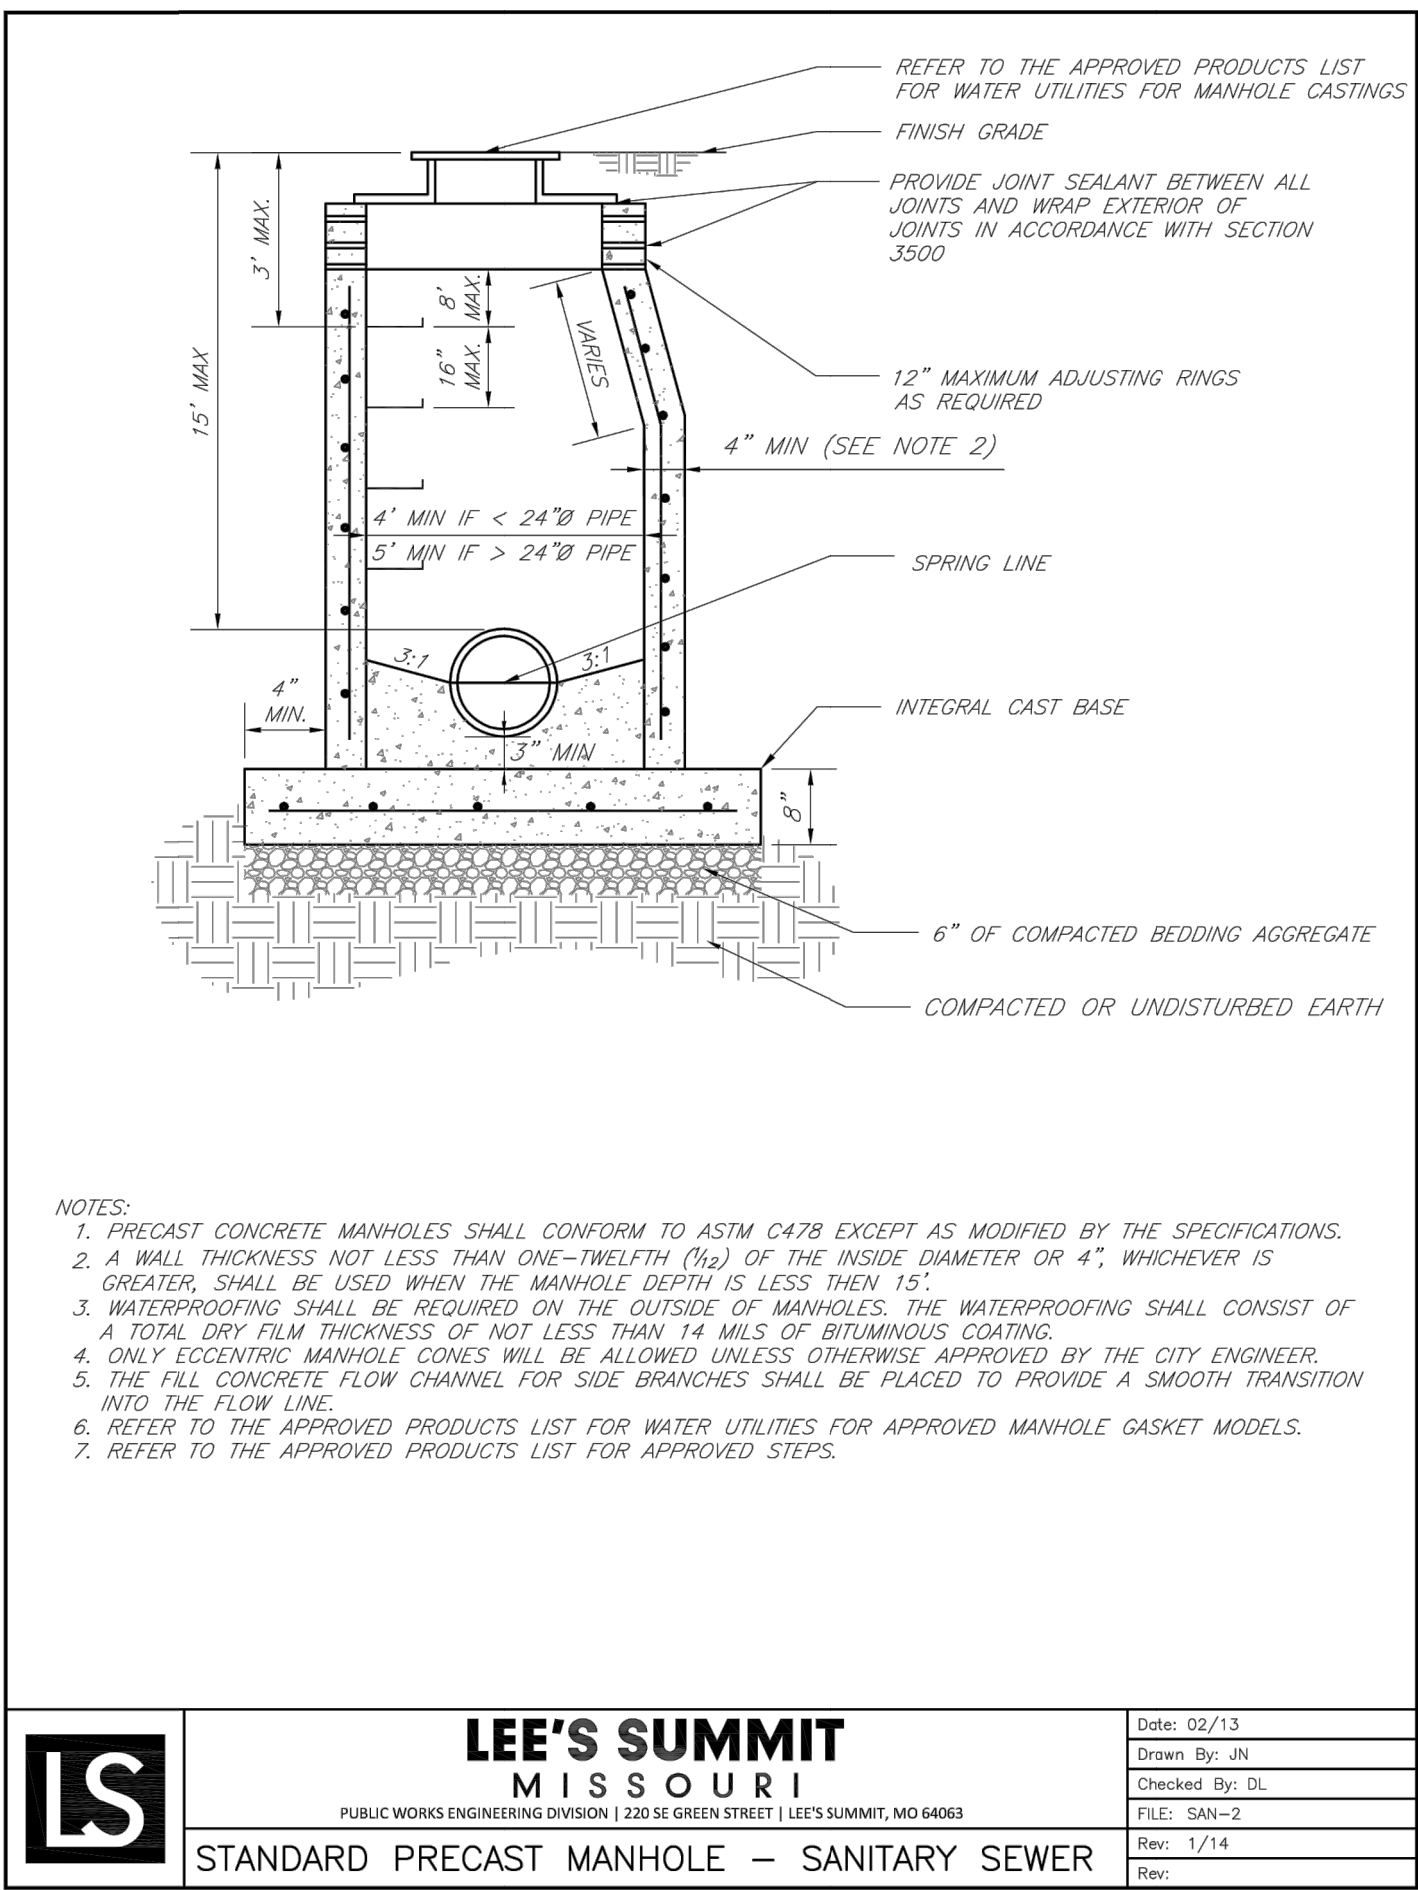


	LEE'S SUMMIT	Date: 02/13
	MISSOURI	Drawn By: JN
	PUBLIC WORKS ENGINEERING DIVISION 220 SE GREEN STREET LEE'S SUMMIT, MO 64083	Checked By: DL
	FILE: SAN-2	Rev: 1/14
	STANDARD PRECAST MANHOLE – SANITARY SEWER	Rev:

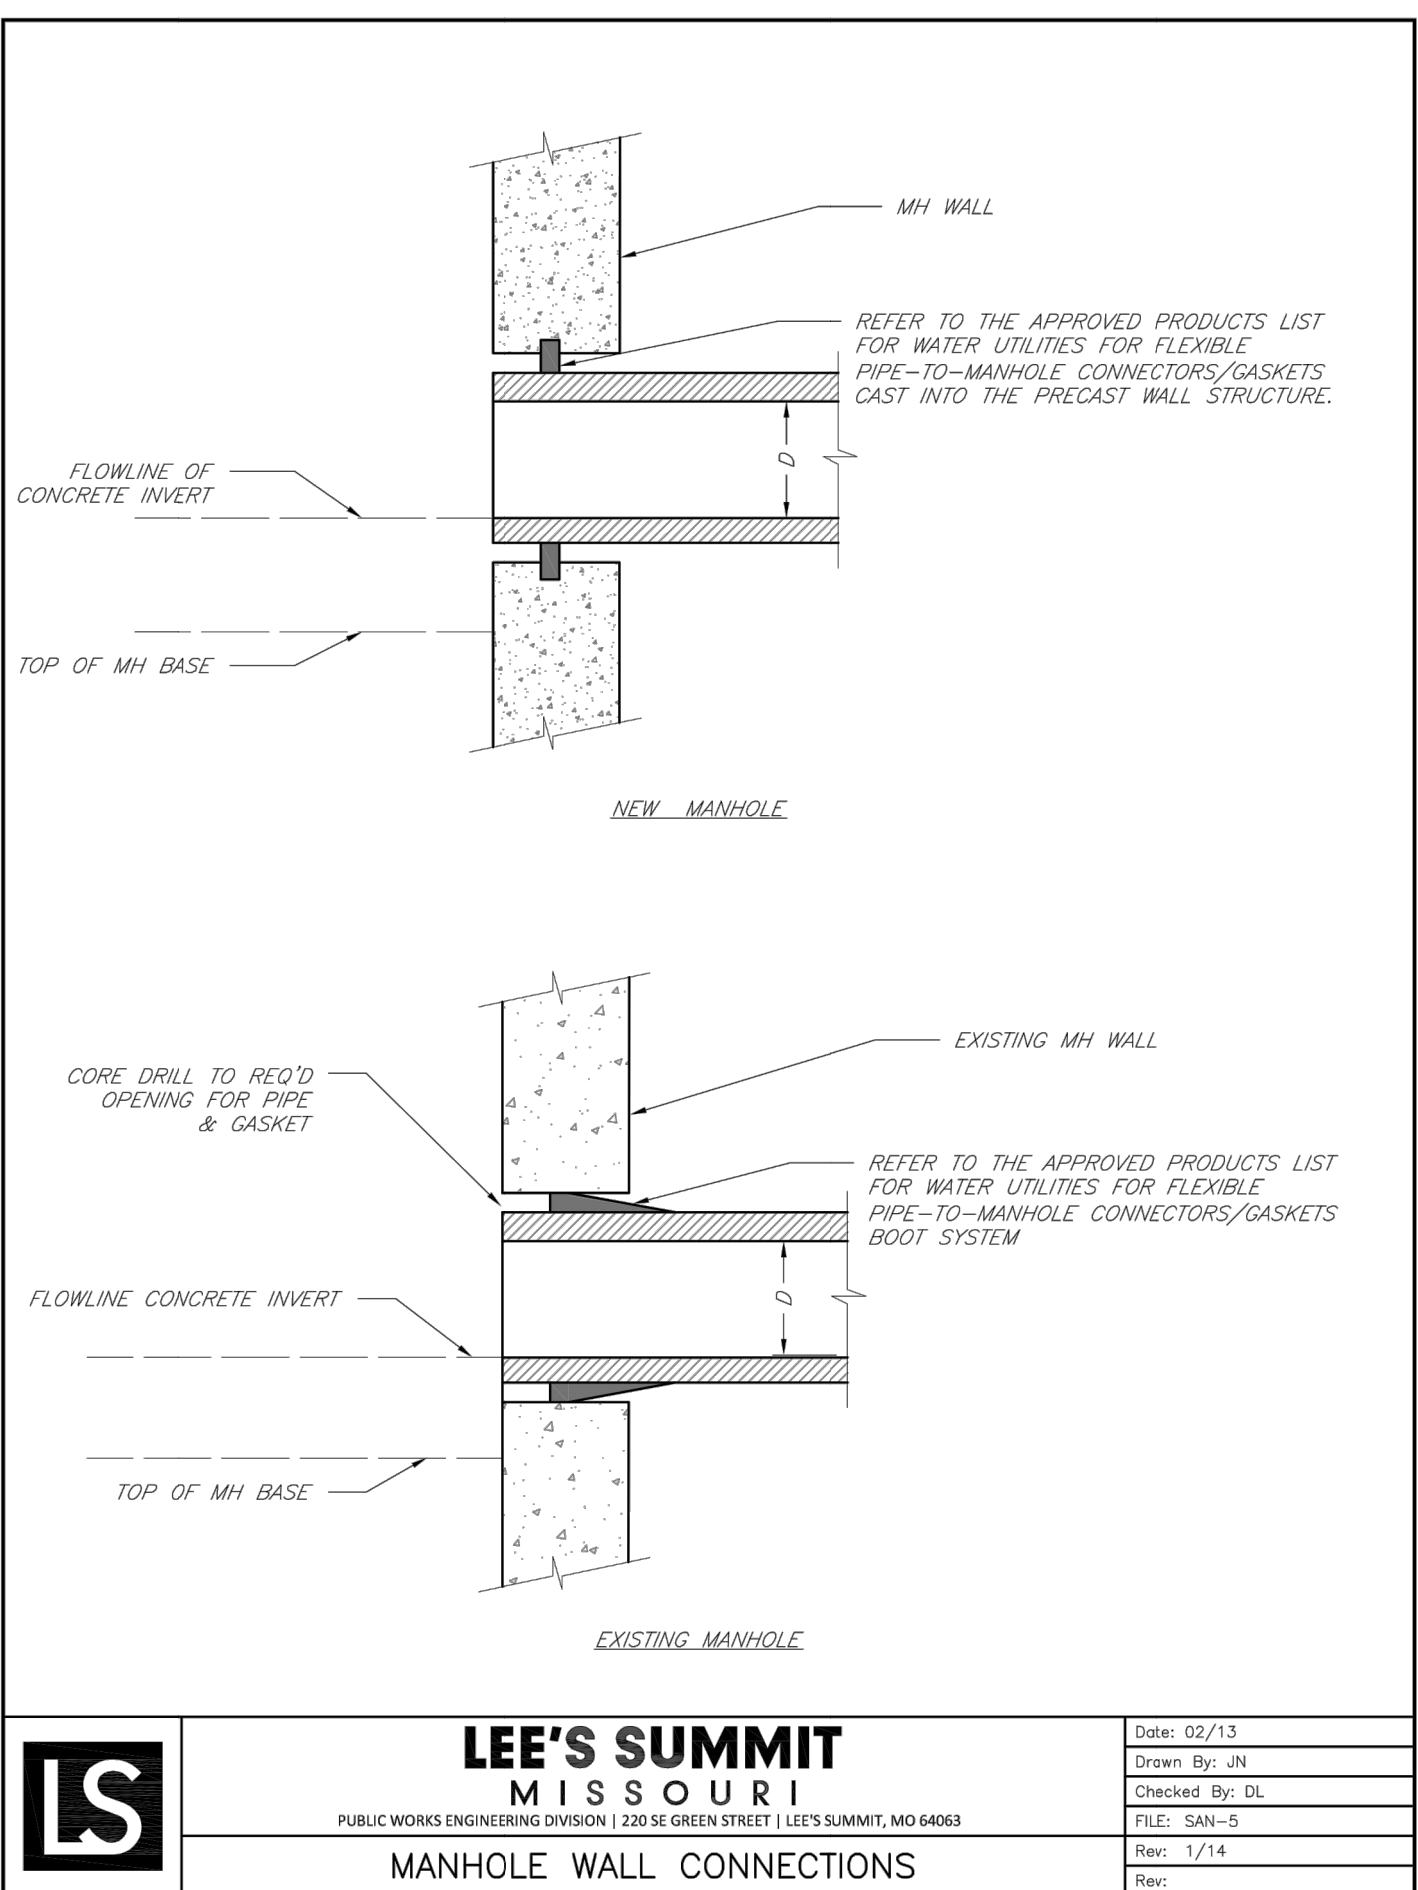

	LEE'S SUMMIT	Date: 02/13
	MISSOURI	Drawn By: JN
	PUBLIC WORKS ENGINEERING DIVISION 220 SE GREEN STREET LEE'S SUMMIT, MO 64083	Checked By: DL
	FILE: SAN-5	Rev: 1/14
	MANHOLE WALL CONNECTIONS	Rev:

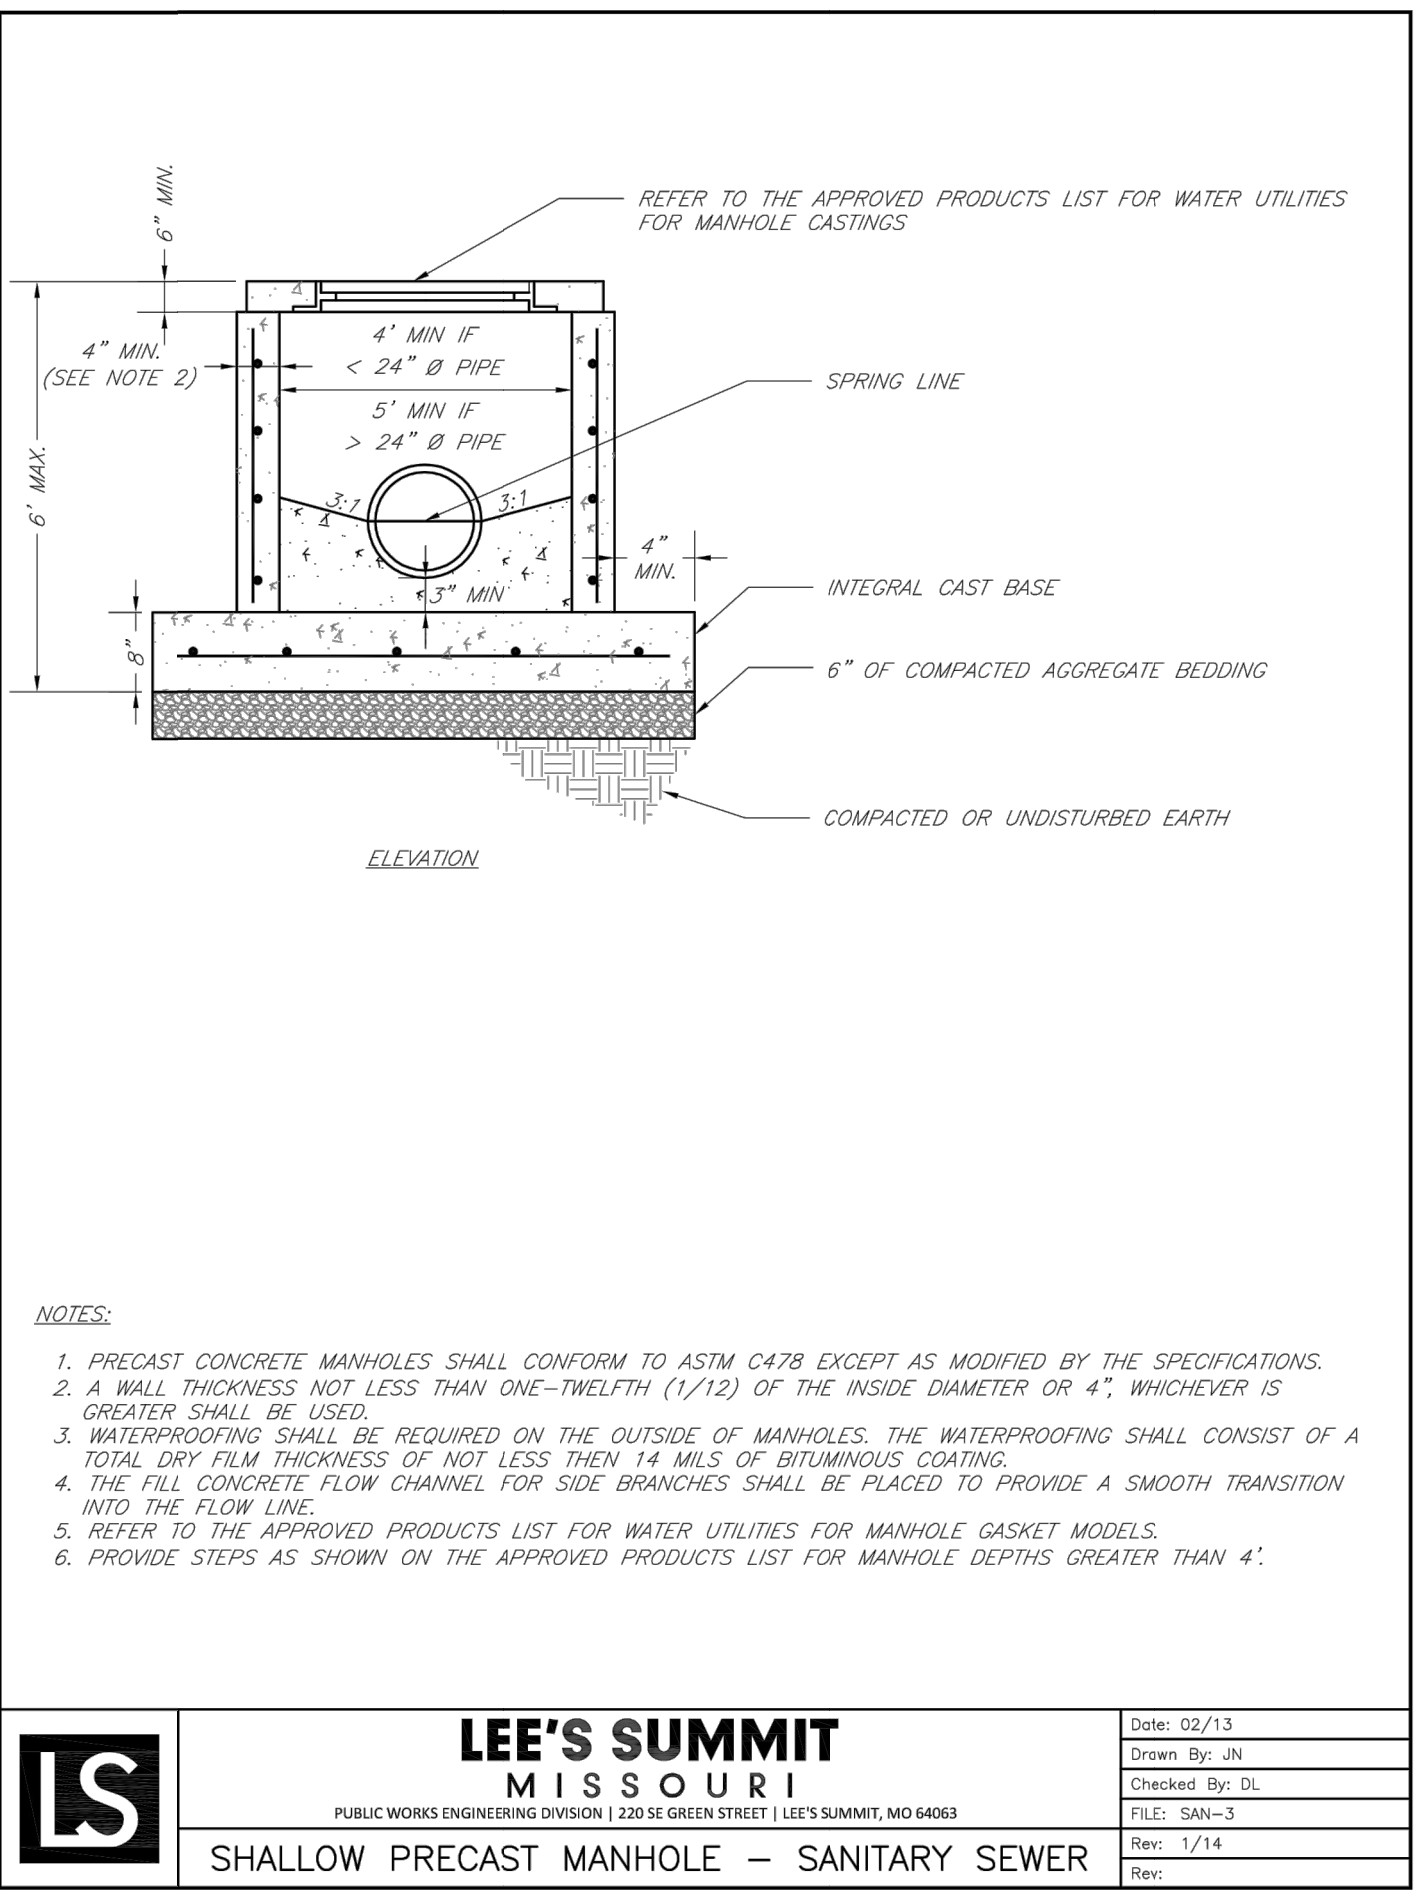

	LEE'S SUMMIT	Date: 02/13
	MISSOURI	Drawn By: JN
	PUBLIC WORKS ENGINEERING DIVISION 220 SE GREEN STREET LEE'S SUMMIT, MO 64083	Checked By: DL
	FILE: SAN-3	Rev: 1/14
	SHALLOW PRECAST MANHOLE – SANITARY SEWER	Rev:

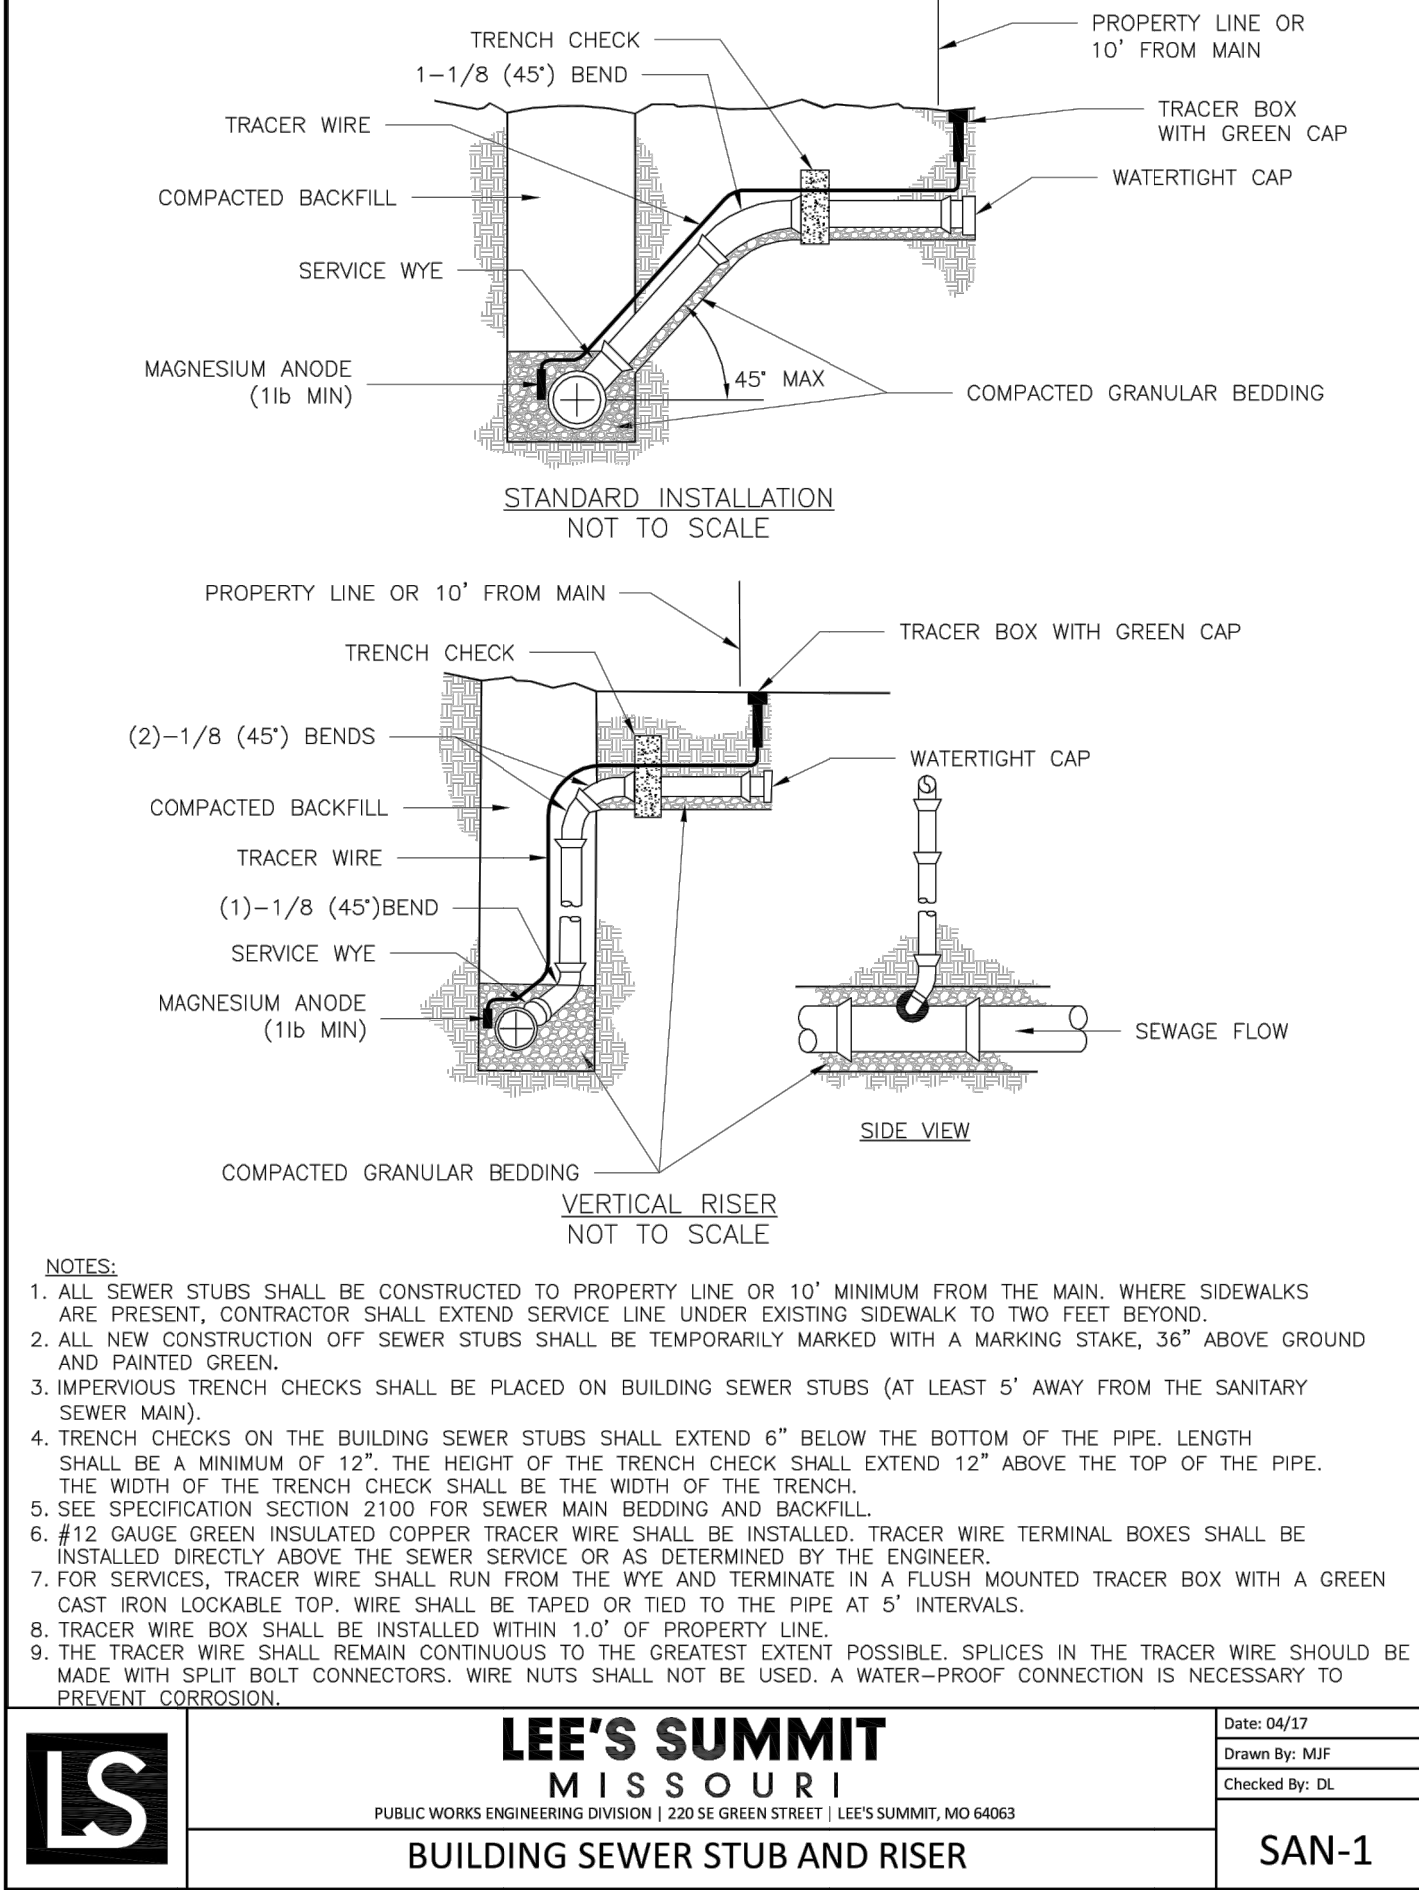

	LEE'S SUMMIT	Date: 04/17
	MISSOURI	Drawn By: MIF
	PUBLIC WORKS ENGINEERING DIVISION 220 SE GREEN STREET LEE'S SUMMIT, MO 64083	Checked By: DL
	FILE: SAN-1	Rev:
	BUILDING SEWER STUB AND RISER	Rev:

GENERAL NOTE:
1 ~ ALL CONSTRUCTION SHALL CONFORM TO THE CITY OF LEE'S SUMMIT DESIGN AND CONSTRUCTION MANUAL AS ADOPTED BY ORDINANCE 5813.
2 ~ TRENCH CHECKS SHALL BE INSTALL AT ALL SANITARY WYES LOCATION.

ENGINEERING
ENGINEERING & SURVEYING
SOLUTIONS

50 SE 30TH STREET
LEES SUMMIT, MO 64082
P: (816) 623-9888 F: (816) 623-9849

Professional Registration

Missouri
Engineering 2005002188-D
Surveying 2005000519-D
Kansas
Engineering E-1695
Surveying LS-218
Oklahoma
Engineering 6254
Nebraska
Engineering CA2821

The Manor at Stoney Creek - 4th Plat
Lee's Summit, Jackson County, Missouri

Project: MANOR AT STONEY CREEK 4TH PLAT
Issue Date: August 29, 2018

Sanitary Details
Construction Plans for:
The Manor at Stoney Creek - 4th Plat
Lee's Summit, Jackson County, Missouri

Matthew J. Schlicht
MO PE 2006019708
KS PE 19071
OK PE 25526
REVISIONS
11/16/2020 As-Built

"AS-BUILT"

900.10
900.00 Indicates data replaced with "As-Built" information. All other data is as designed and has not been field verified.

C. 403