

 

*LEE'S SUMMIT, JACKSON COUNTY, MISSOURI*

## C.400







GENERAL NOTE:  
1 ~ ALL CONSTRUCTION SHALL CONFORM TO THE CITY OF LEE'S SUMMIT DESIGN AND CONSTRUCTION MANUAL AS ADOPTED BY ORDINANCE 5813.  
2 ~ TRENCH CHECKS SHALL BE INSTALL AT ALL SANITARY WYES LOCATION.  
3 ~ COMPACTED FILL SHALL BE PLACED TO A MINIMUM 18" ABOVE THE TOP OF THE PIPE PRIOR TO INSTALLATION.

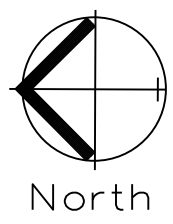

SANITARY PLAN & PROFILE  
SCALE: 1" = 50'

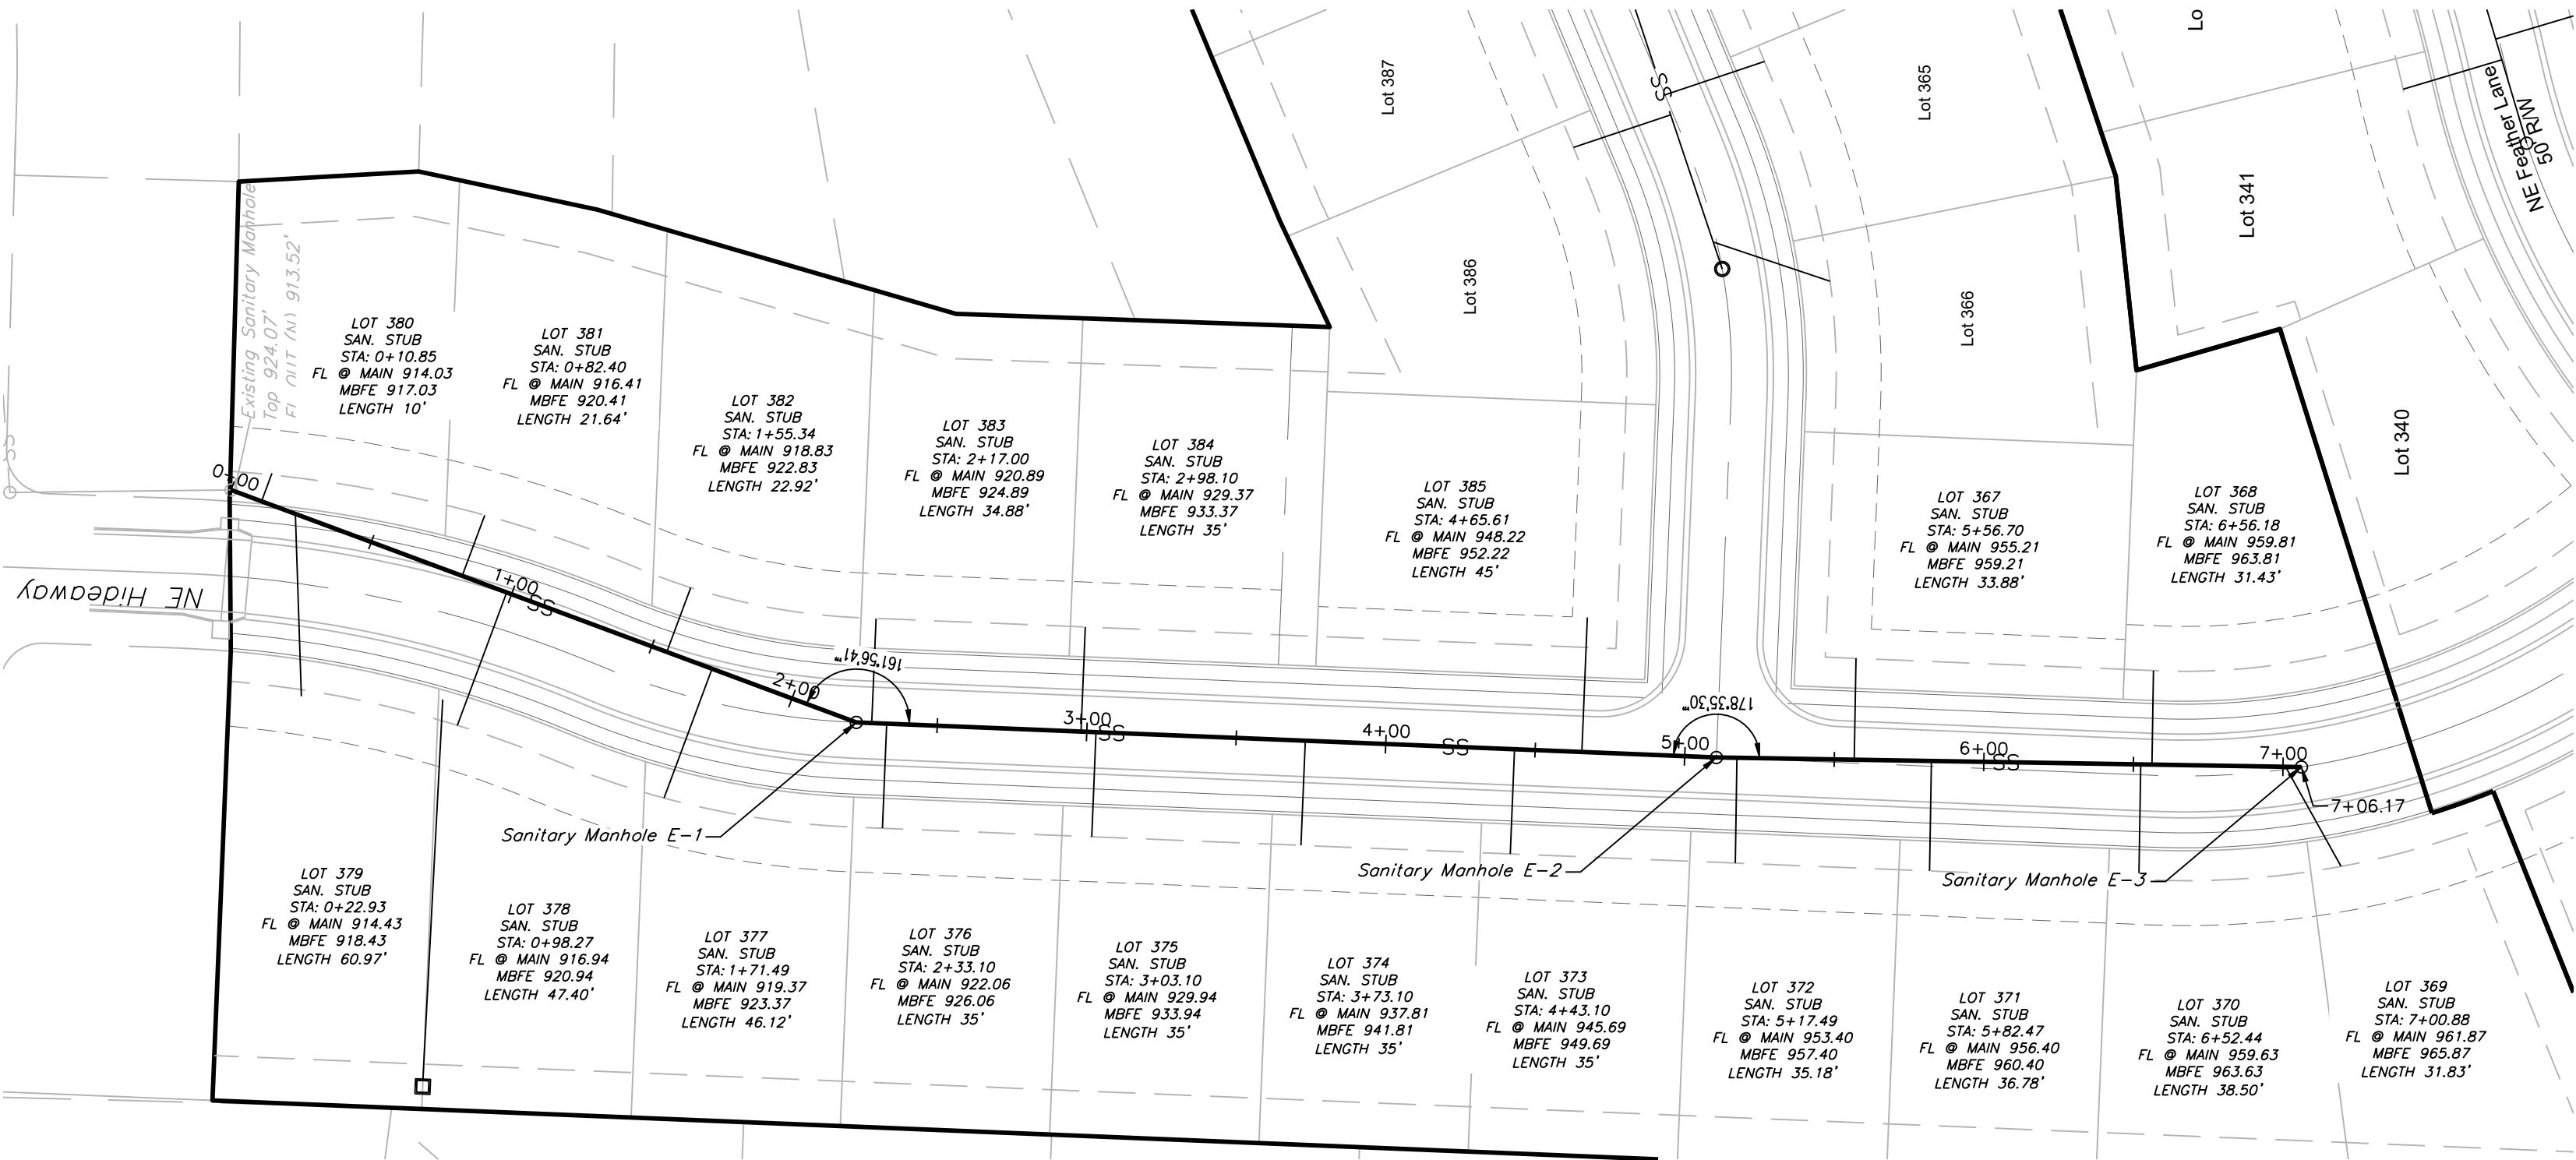

## SANITARY LINE E

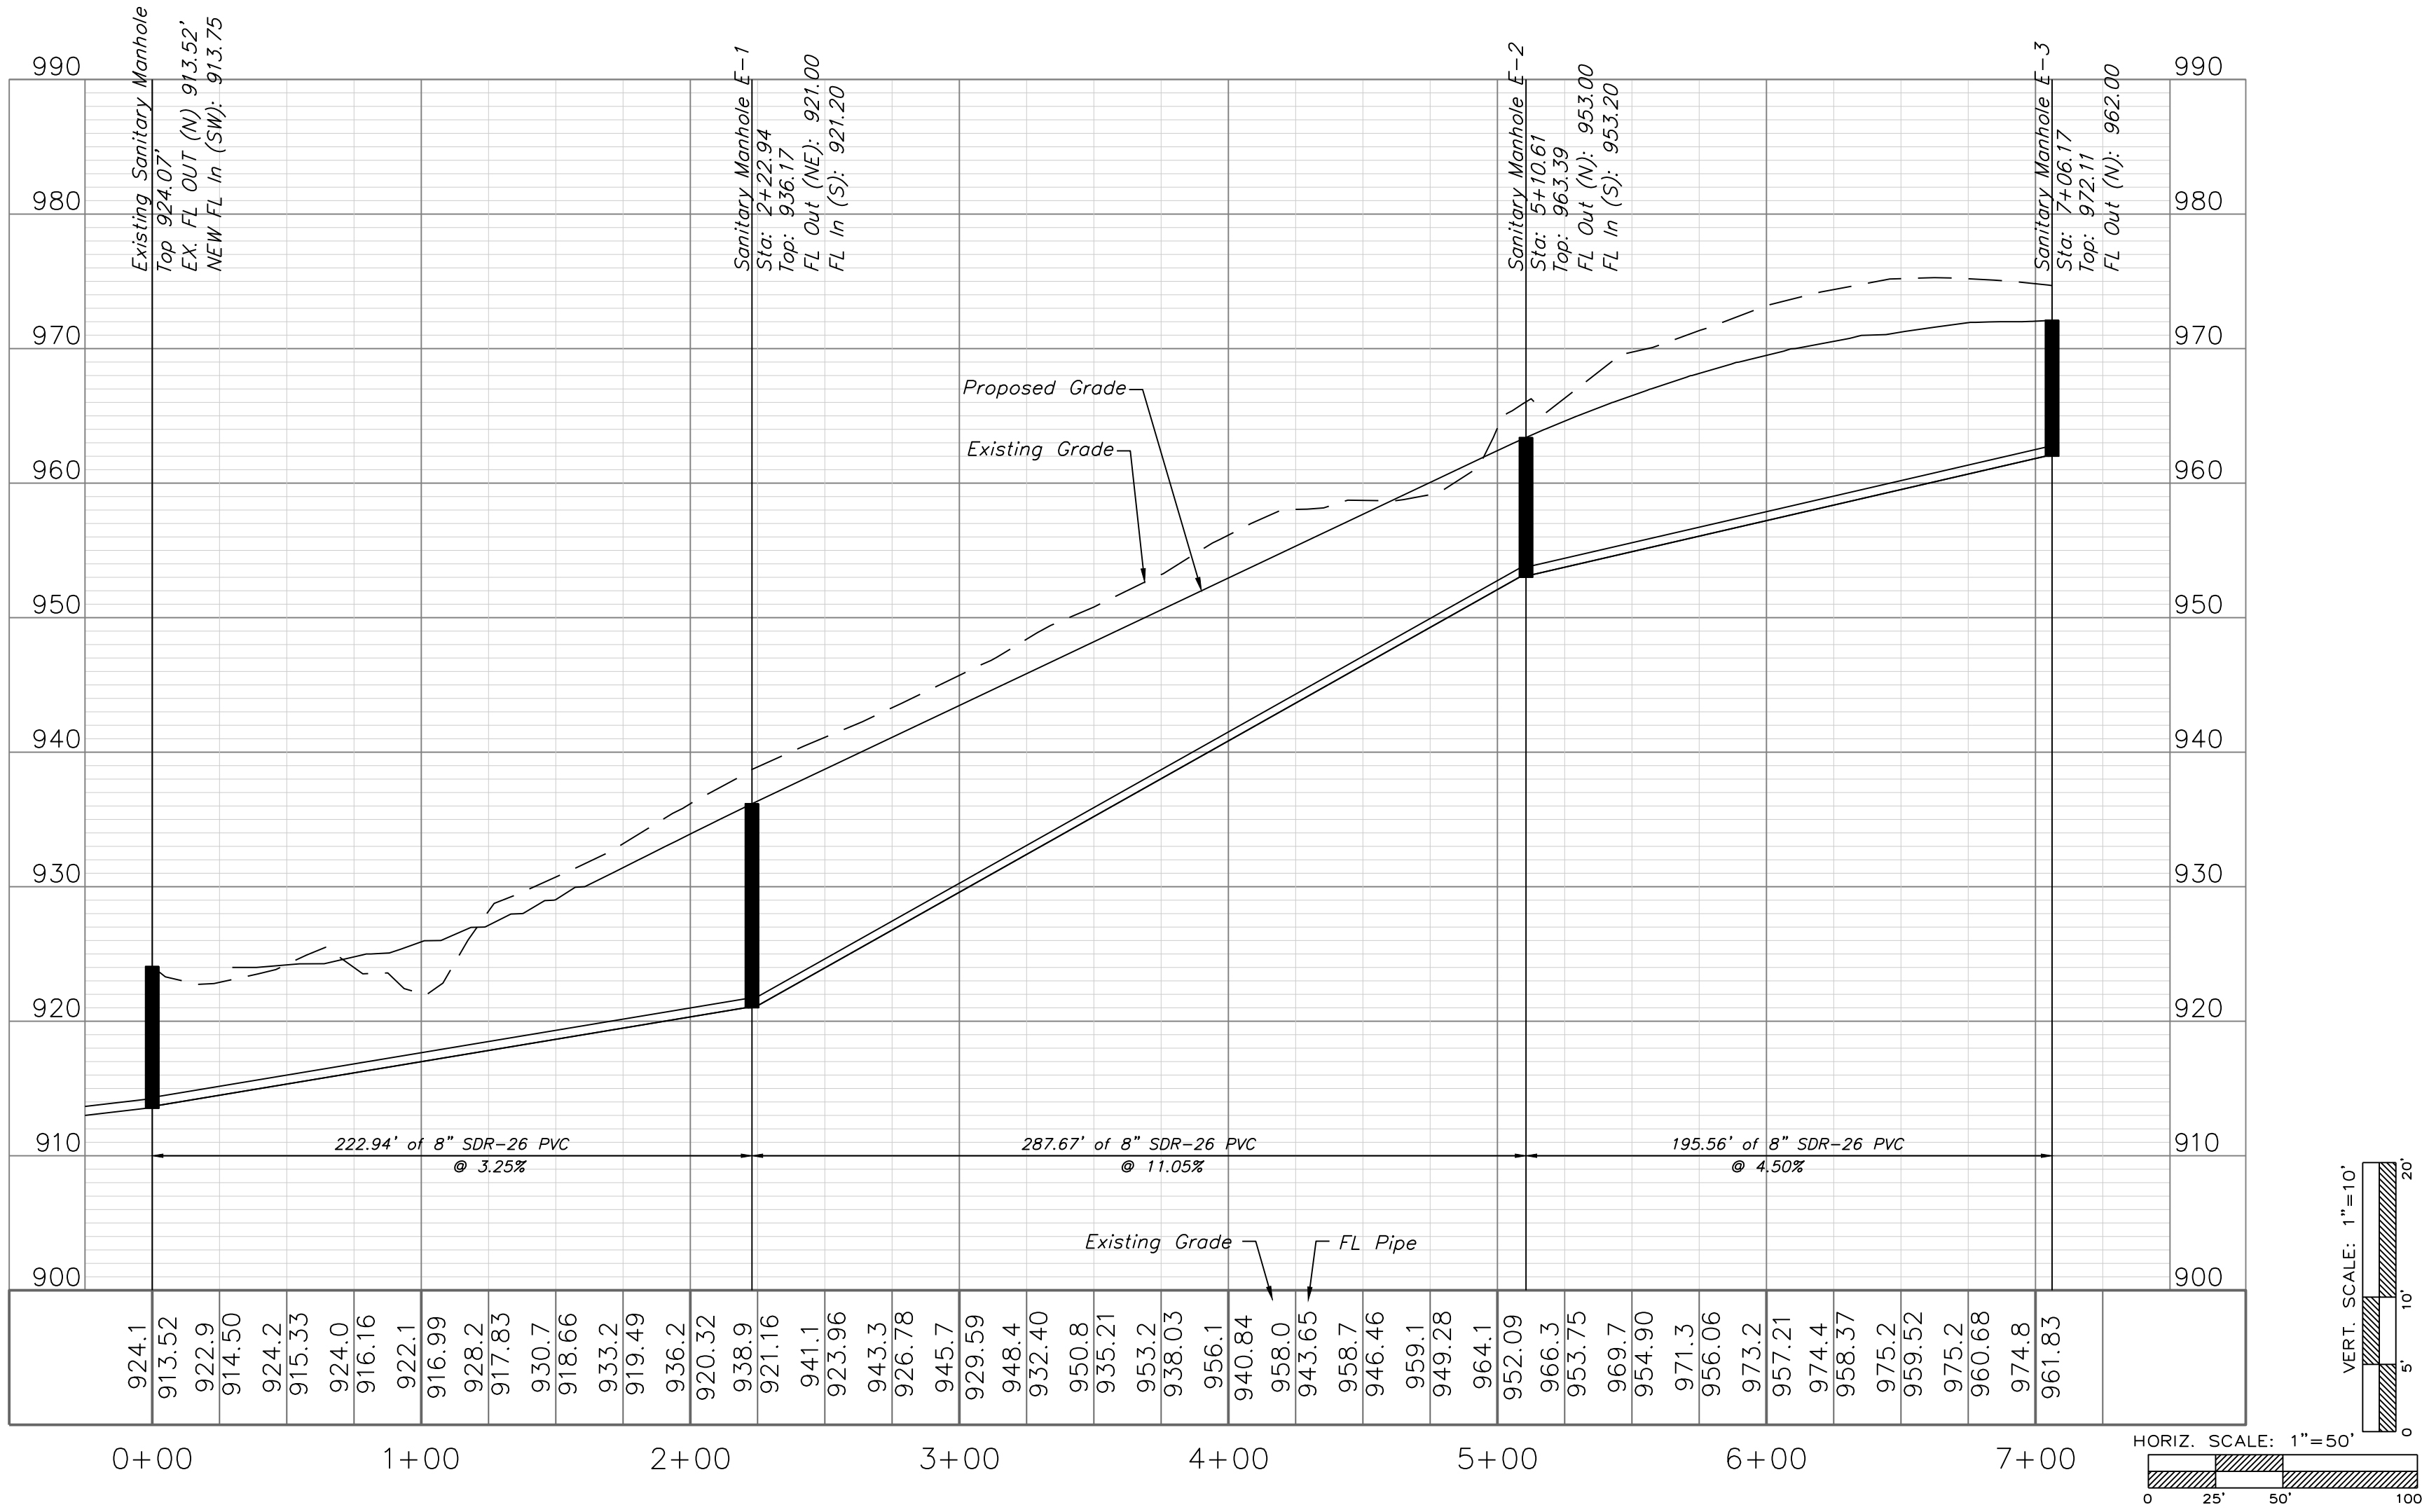

Sanitary Plan and Profile  
MANOR AT PARK RIDGE 8TH PLAT  
Section 9, Township 48 North, Range 31 West  
Lee's Summit, Jackson County, Missouri

Project:  
MANOR AT PARK  
RIDGE  
Issue Date:  
August 25, 2020


Professional Registration  
Missouri  
Engineering 2005002186-D  
Surveying 2005008319-D  
Kansas  
Engineering E-1695  
Surveying LS-218  
Oklahoma  
Engineering 6254  
Nebraska  
Engineering CA2821

ENGINEERING  
ENGINEERING & SURVEYING  
SOLUTIONS  
50 SE 30TH STREET  
LEE'S SUMMIT, MO 64082  
P: (816) 623-9888 F: (816) 623-9849


Matthew J. Schlicht  
MO PE 2006019708  
KS PE 19071  
OK PE 25226  
NE PE E-14335

REVISIONS




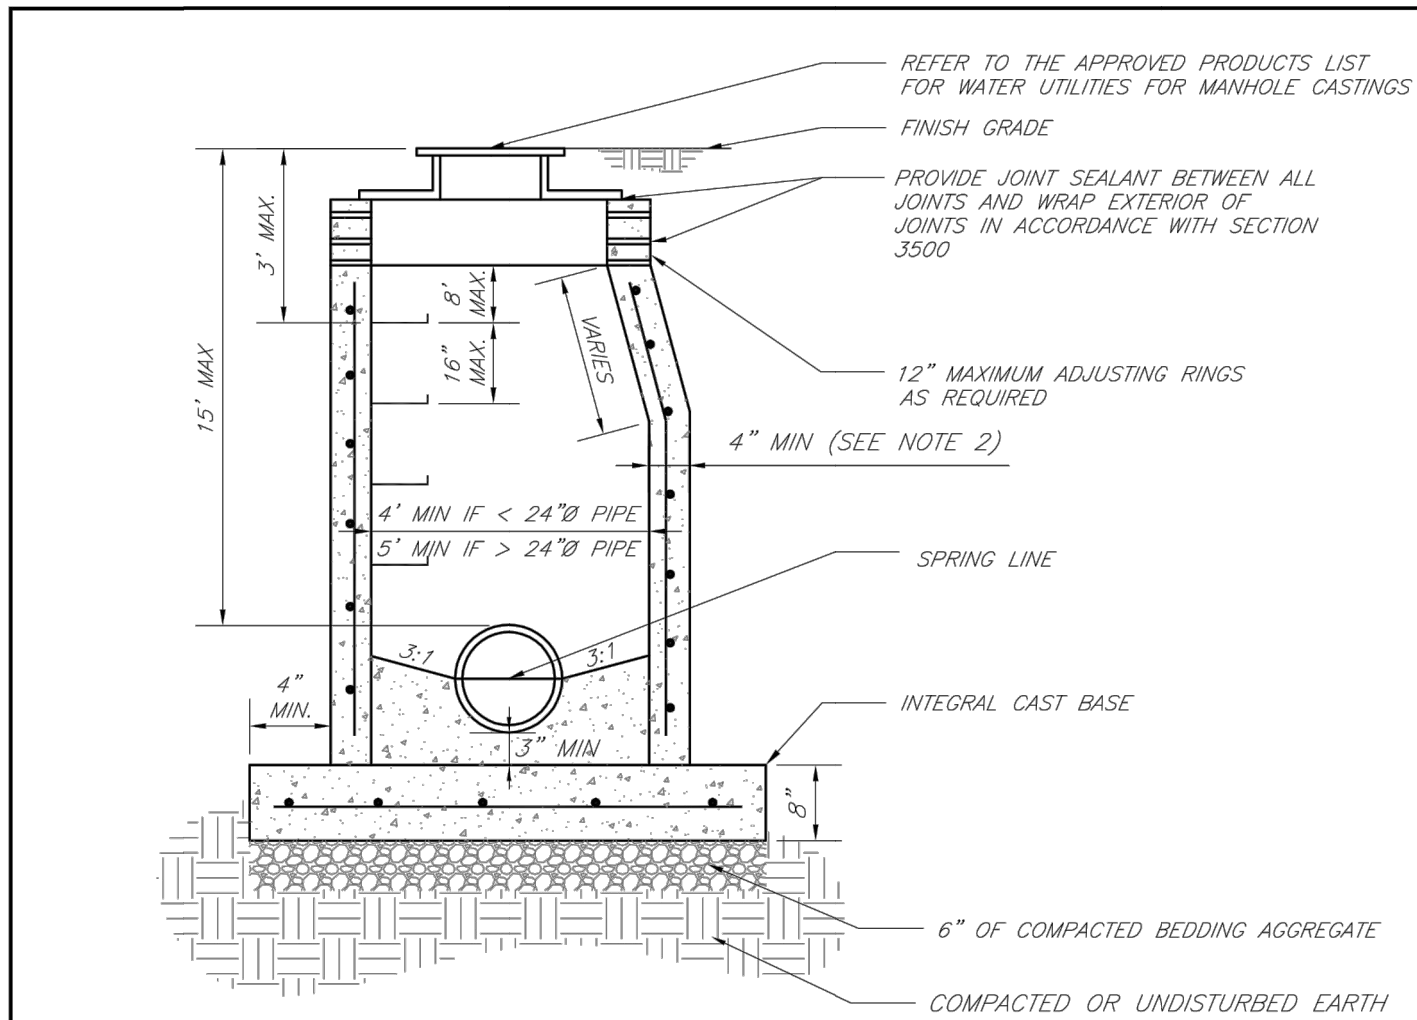


<div>LS</div>	<div>LEE'S SUMMITMISSOURI</div> <div>PUBLIC WORKS ENGINEERING DIVISION   220 SE GREEN STREET   LEE'S SUMMIT, MO 64063</div> <div>STANDARD PRECAST MANHOLE – SANITARY SEWER</div>	Date: 02/13
		Drawn By: JN
		Checked By: DL
		FILE: SAN-2
		Rev: 1/14

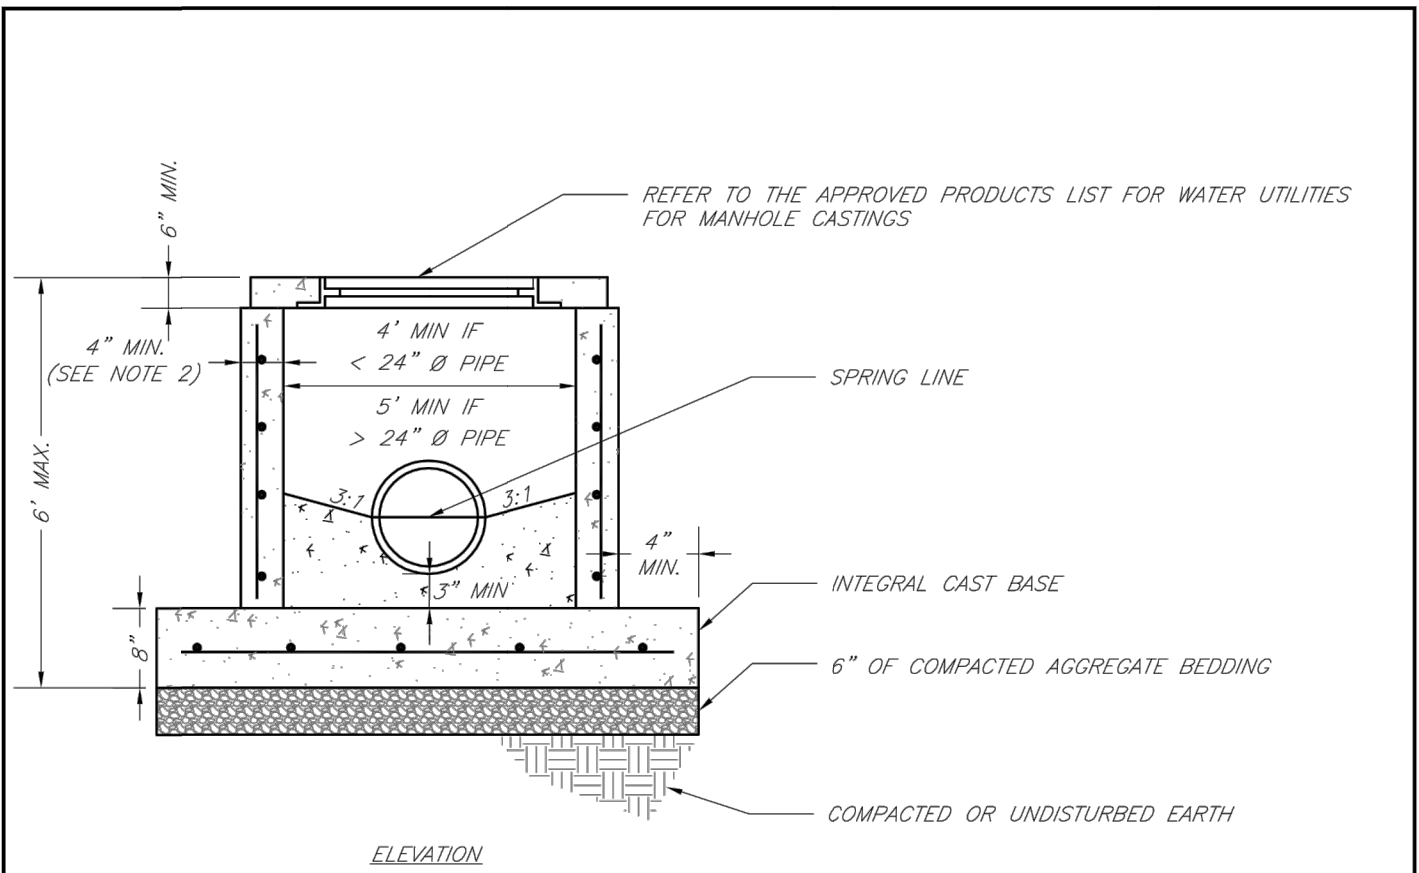

<div>LS</div>	<div>LEE'S SUMMITMISSOURI</div> <div>PUBLIC WORKS ENGINEERING DIVISION   220 SE GREEN STREET   LEE'S SUMMIT, MO 64063</div> <div>SHALLOW PRECAST MANHOLE – SANITARY SEWER</div>	Date: 02/13
		Drawn By: JN
		Checked By: DL
		FILE: SAN-3
		Rev: 1/14

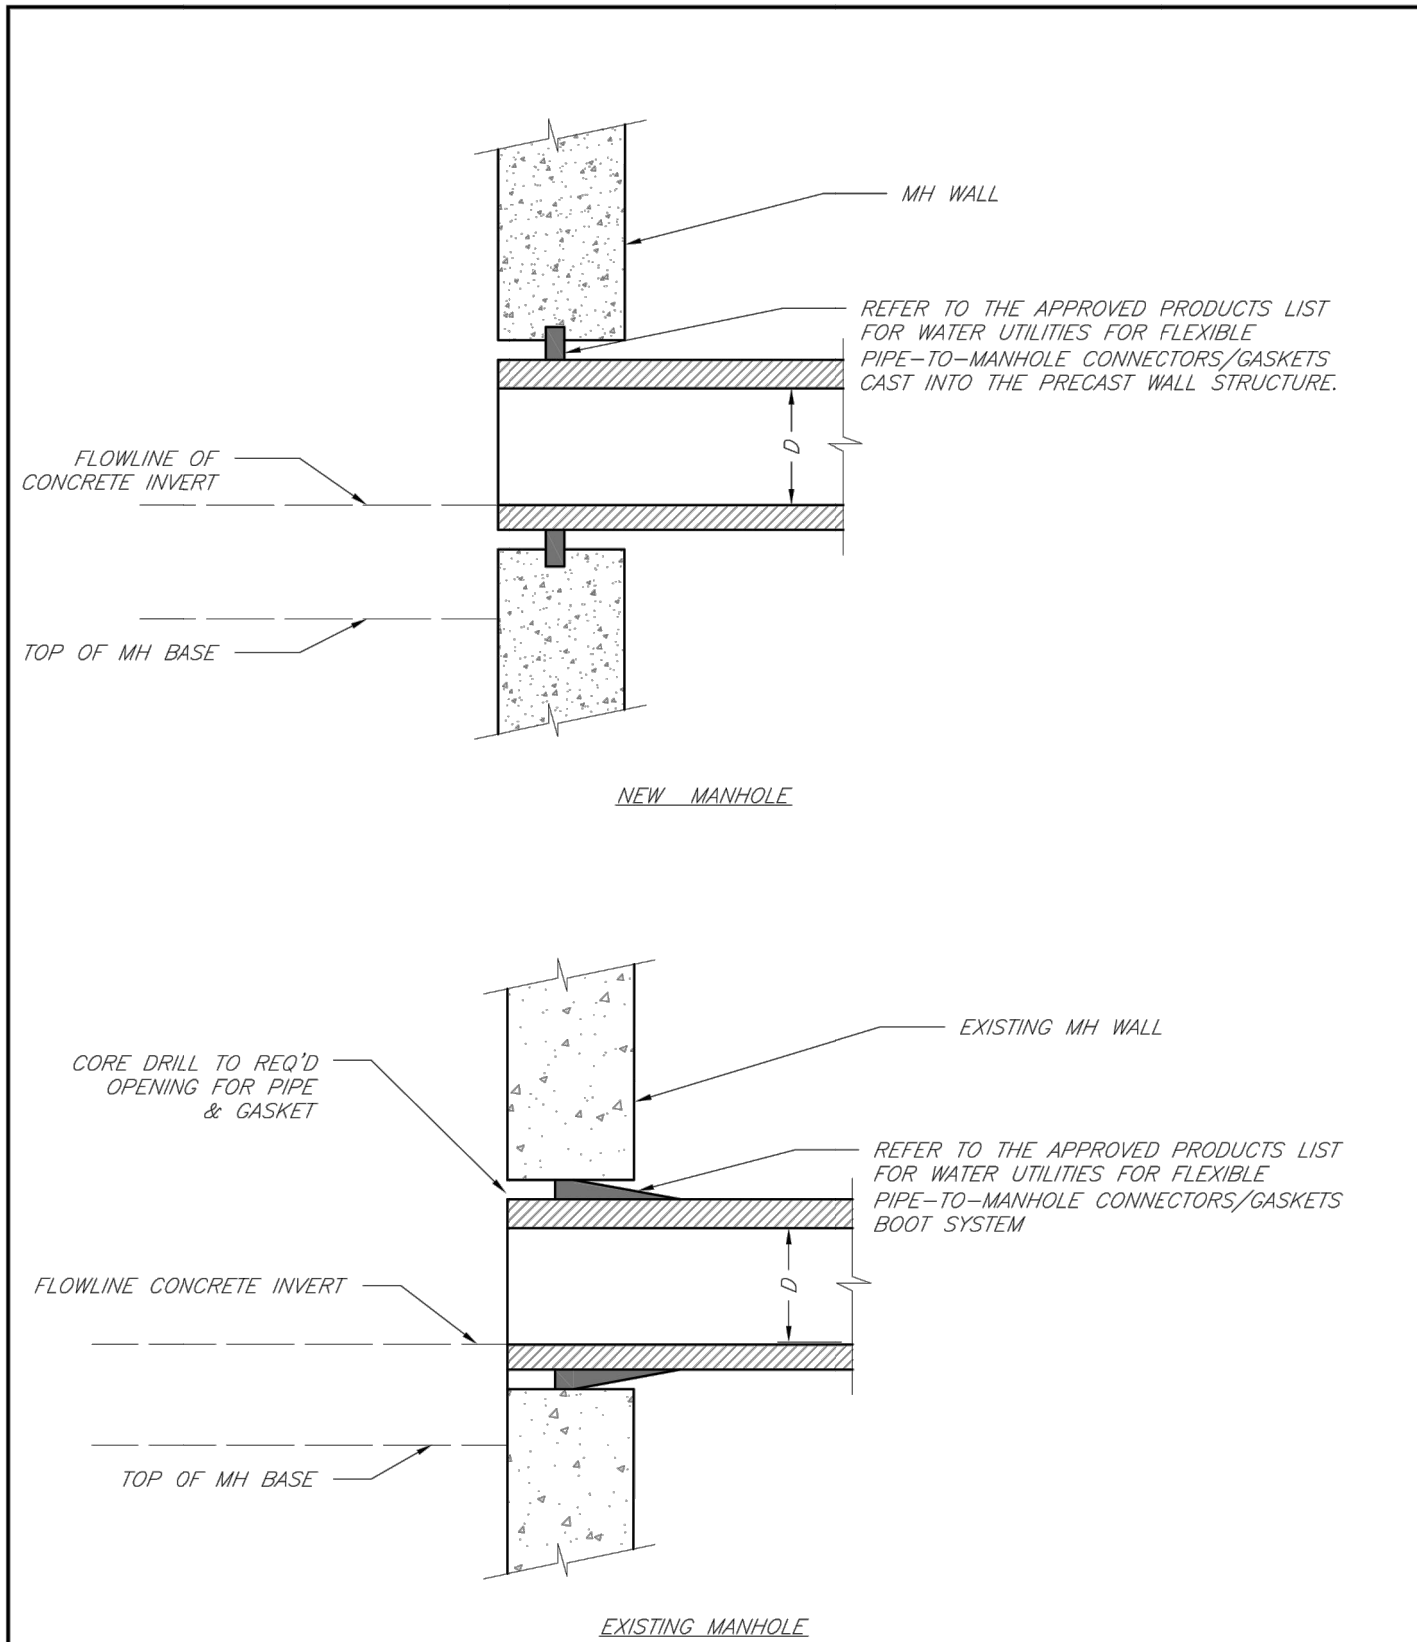

<div>LS</div>	<div>LEE'S SUMMITMISSOURI</div> <div>PUBLIC WORKS ENGINEERING DIVISION   220 SE GREEN STREET   LEE'S SUMMIT, MO 64063</div> <div>MANHOLE WALL CONNECTIONS</div>	Date: 02/13
		Drawn By: JN
		Checked By: DL
		FILE: SAN-5
		Rev: 1/14

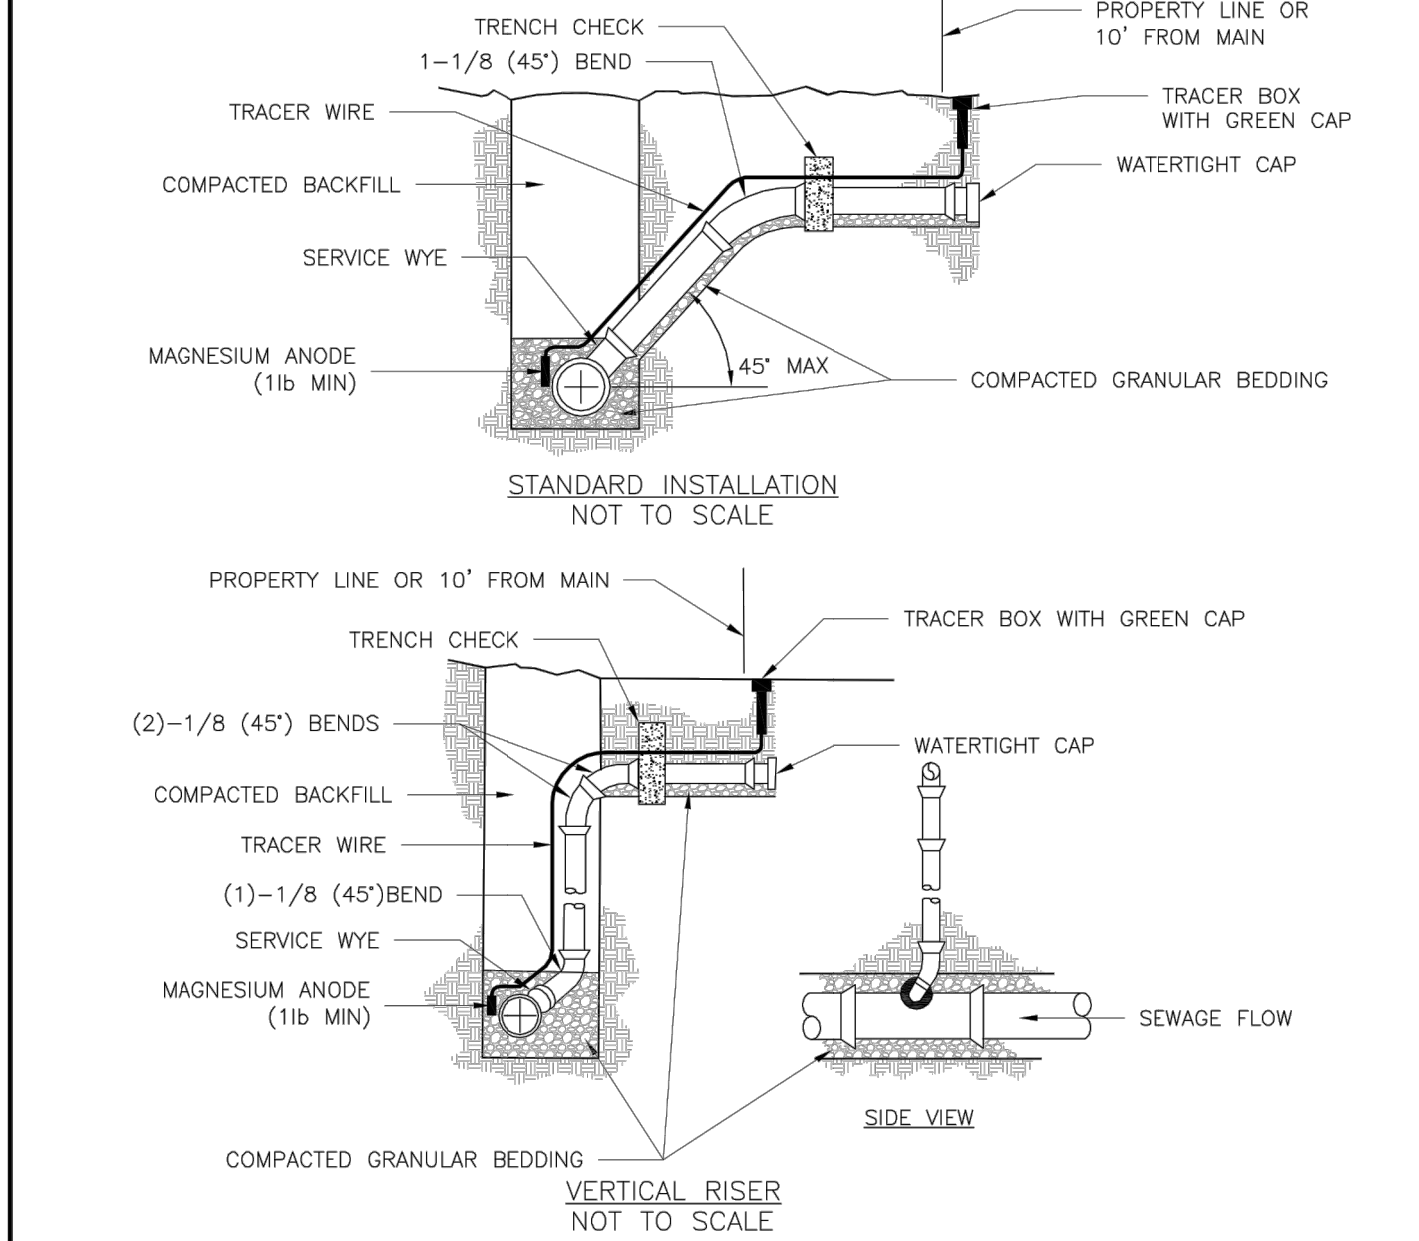

<div>LS</div>	<div>LEE'S SUMMITMISSOURI</div> <div>PUBLIC WORKS ENGINEERING DIVISION   220 SE GREEN STREET   LEE'S SUMMIT, MO 64063</div> <div>BUILDING SEWER STUB AND RISER</div>	Date: 04/17
		Drawn By: MIF
		Checked By: DL
		SAN-1

GENERAL NOTE:  
1 - ALL CONSTRUCTION SHALL CONFORM TO THE CITY OF LEE'S SUMMIT DESIGN AND CONSTRUCTION MANUAL AS ADOPTED BY ORDINANCE 5813.  
2 - TRENCH CHECKS SHALL BE INSTALL AT ALL SANITARY WYES LOCATION.