


LEE'S SUMMIT, JACKSON COUNTY, MISSOURI

C.400

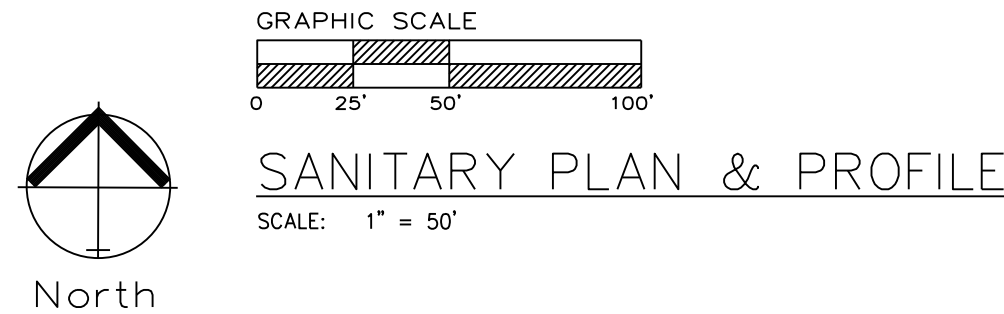

1 ~ ALL CONSTRUCTION SHALL CONFORM TO THE CITY OF LEE'S SUMMIT DESIGN AND CONSTRUCTION MANUAL AS ADOPTED BY ORDINANCE 5813.

2 ~ TRENCH CHECKS SHALL BE INSTALL AT ALL SANITARY WYES LOCATION.

ENGINEERING
—ENGINEERING & SURVEYING—
SOLUTIONS


50 SE 30TH STREET
LEE'S SUMMIT, MO 64082
P: (816) 623-9888 F: (816) 623-9849

Professional Registration
Missouri
Engineering 2005002186-D
Surveying 2005008319-D
Kansas
Engineering E-1695
Surveying LS-218
Oklahoma
Engineering 6254
Nebraska
Engineering CA2621

PARK RIDGE 8TH PLAT
Section 9, Township 48 North, Range 31 West
Lee's Summit, Jackson County, Missouri

Project: MANOR AT PARK RIDGE
Issue Date:

Sanitary Sewer General Layout
PARK RIDGE 8TH PLAT
Section 9, Township 48 North, Range 31 West
Lee's Summit, Jackson County, Missouri


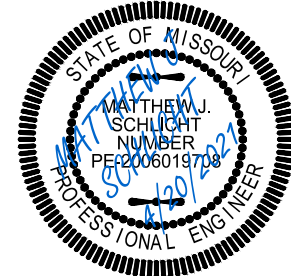


Matthew J. Schlicht
MO PE 2006019708
KS PE 19071
OK PE 25226
NE PE E-14335

REVISIONS

1	REV. 4/20/2021
---	----------------

 
GENERAL NOTE:
1 ~ ALL CONSTRUCTION SHALL CONFORM TO THE CITY OF LEE'S SUMMIT DESIGN AND CONSTRUCTION MANUAL AS ADOPTED BY ORDINANCE 5813.
2 ~ TRENCH CHECKS SHALL BE INSTALL AT ALL SANITARY WYES LOCATION.
3 ~ COMPACTED FILL SHALL BE PLACED TO A MINIMUM 18" ABOVE THE TOP OF THE PIPE PRIOR TO INSTALLATION.

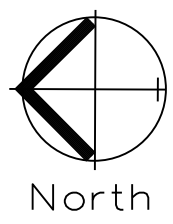

SANITARY PLAN & PROFILE
SCALE: 1" = 50'



SANITARY LINE E

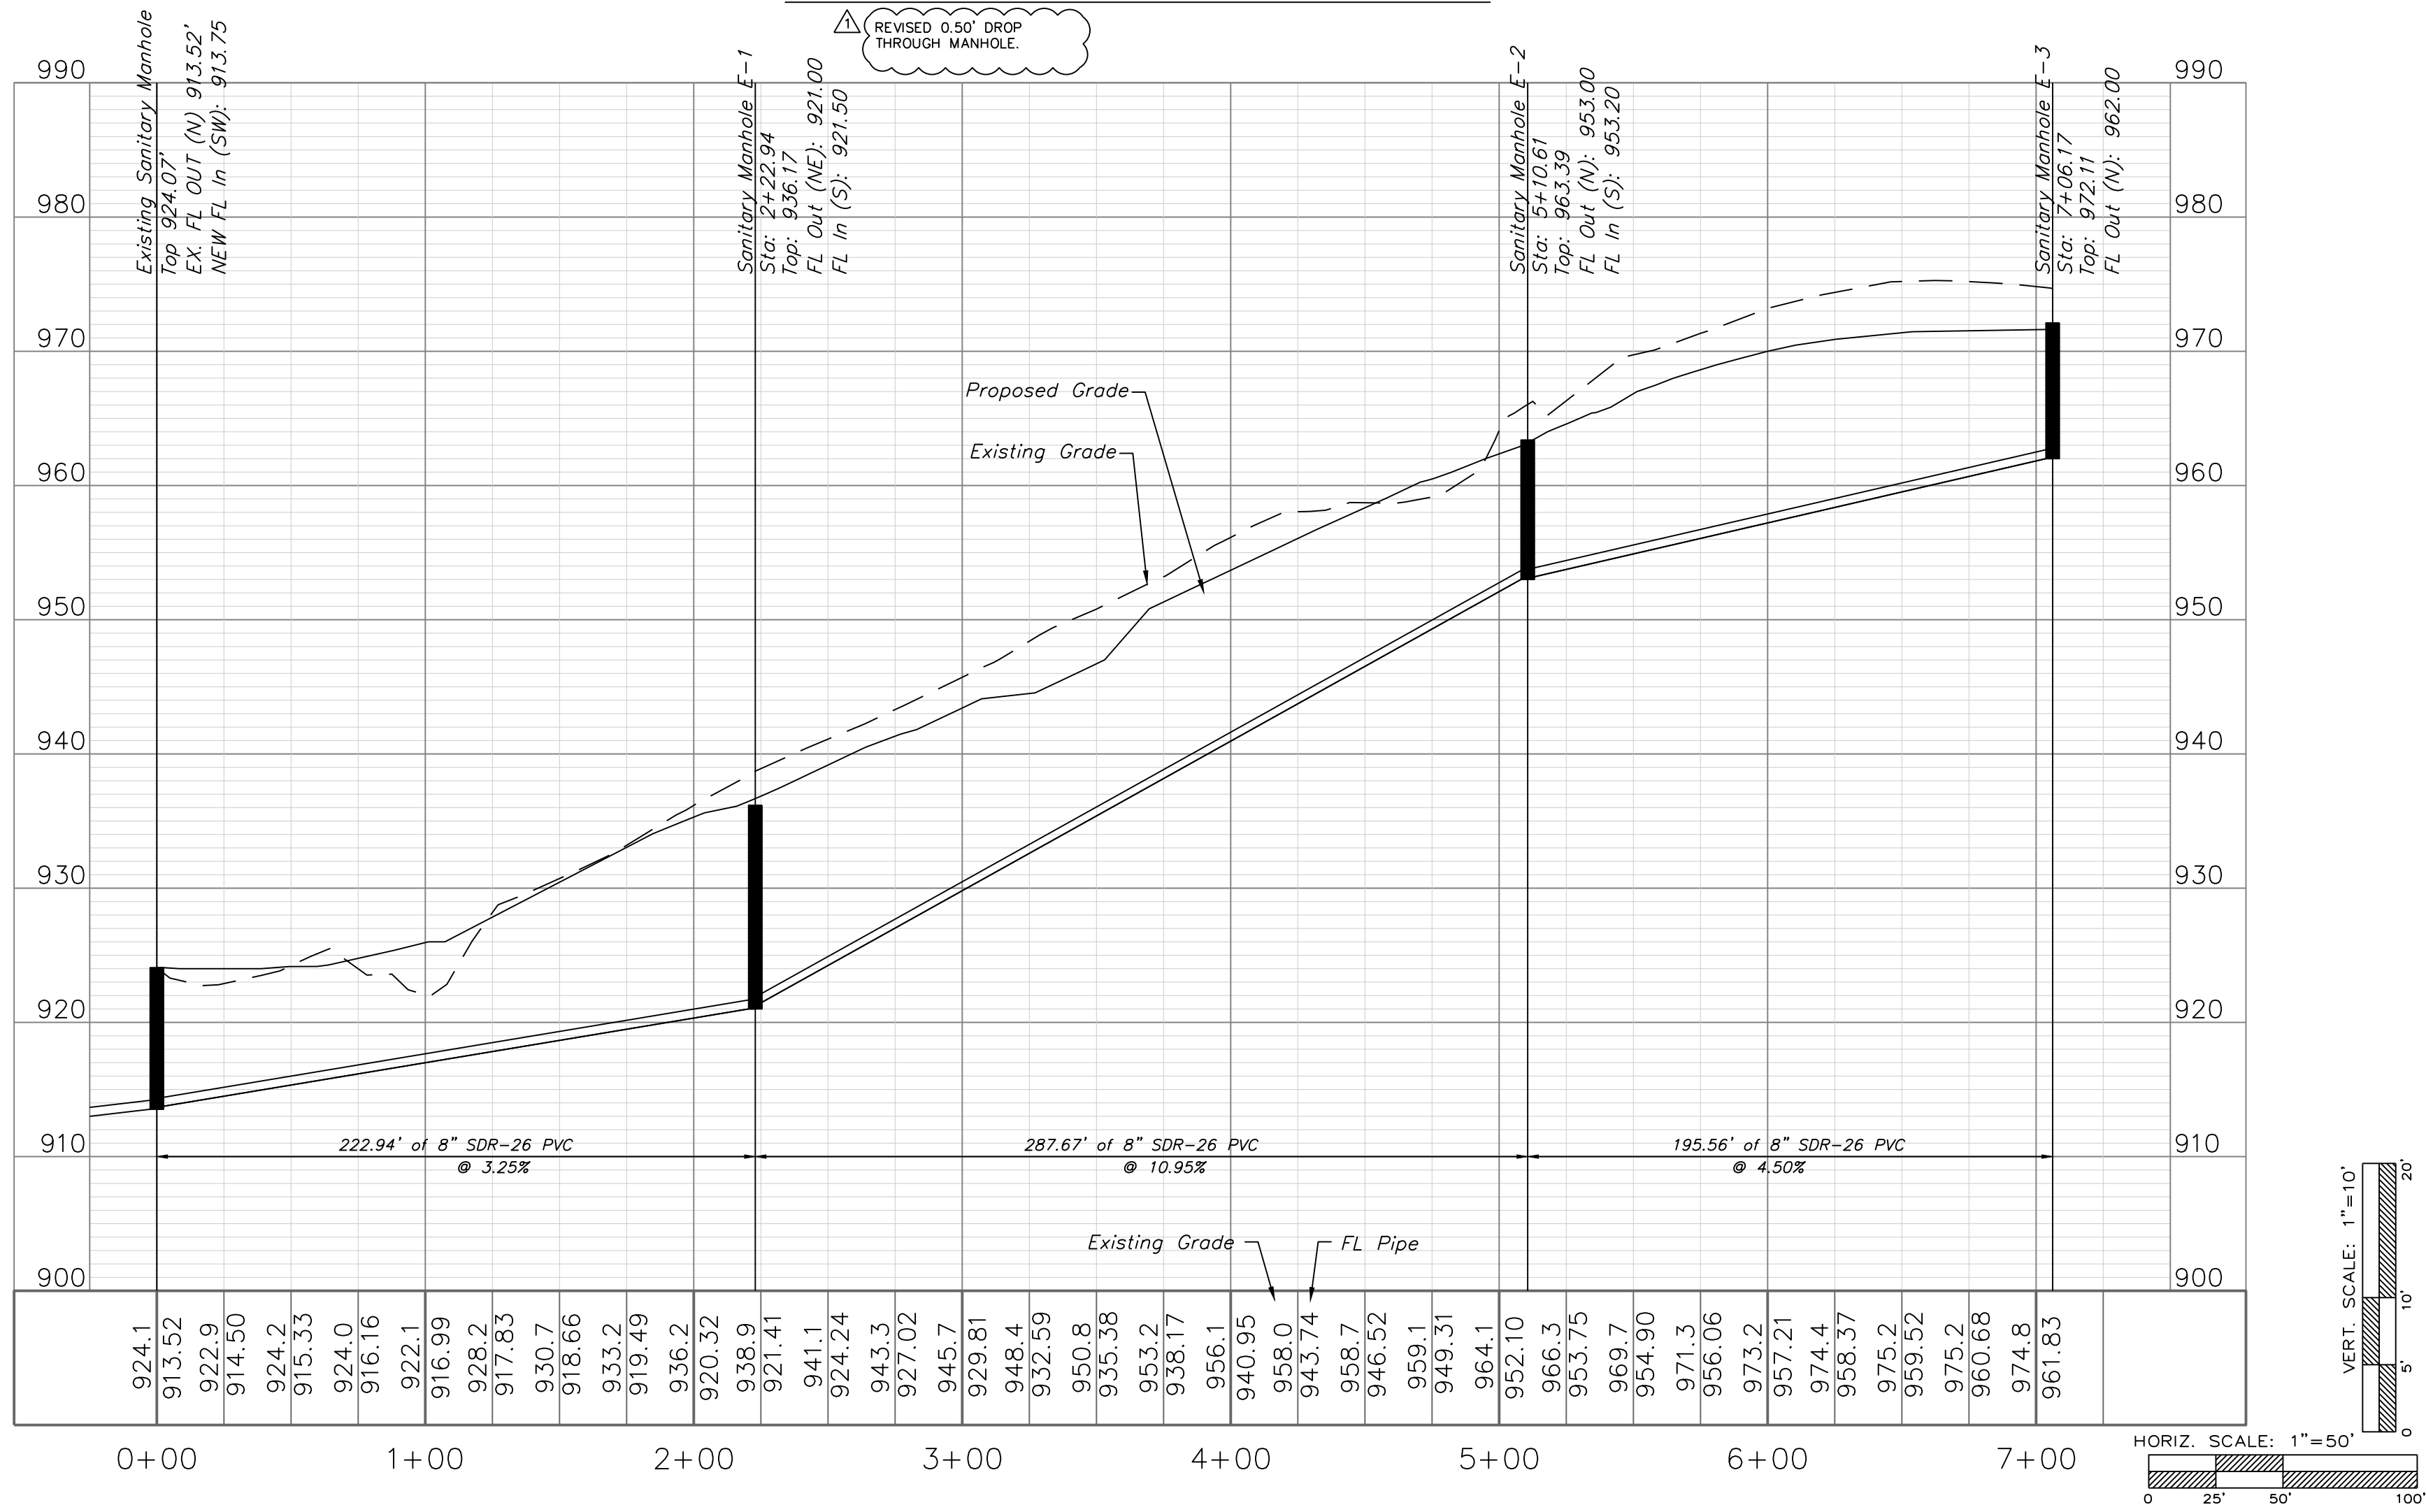


Professional Registration
Missouri
Engineering 2005002186-D
Surveying 2005008319-D
Kansas
Engineering E-1685
Surveying LS-218
Oklahoma
Engineering 6254
Nebraska
Engineering CA2821

PARK RIDGE 8TH PLAT
Section 9, Township 48 North, Range 31 West
Lee's Summit, Jackson County, Missouri






Project:
MANOR AT PARK
RIDGE
Issue Date:
August 25, 2020

Sanitary Plan and Profile
PARK RIDGE 8TH PLAT
Section 9, Township 48 North, Range 31 West
Lee's Summit, Jackson County, Missouri

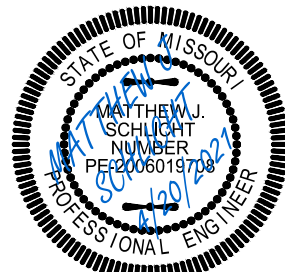

Matthew J. Schlicht
MO PE 2006019708
KS PE 19071
OK PE 25226
NE PE E-14335

REVISIONS
REV. 4/20/2021

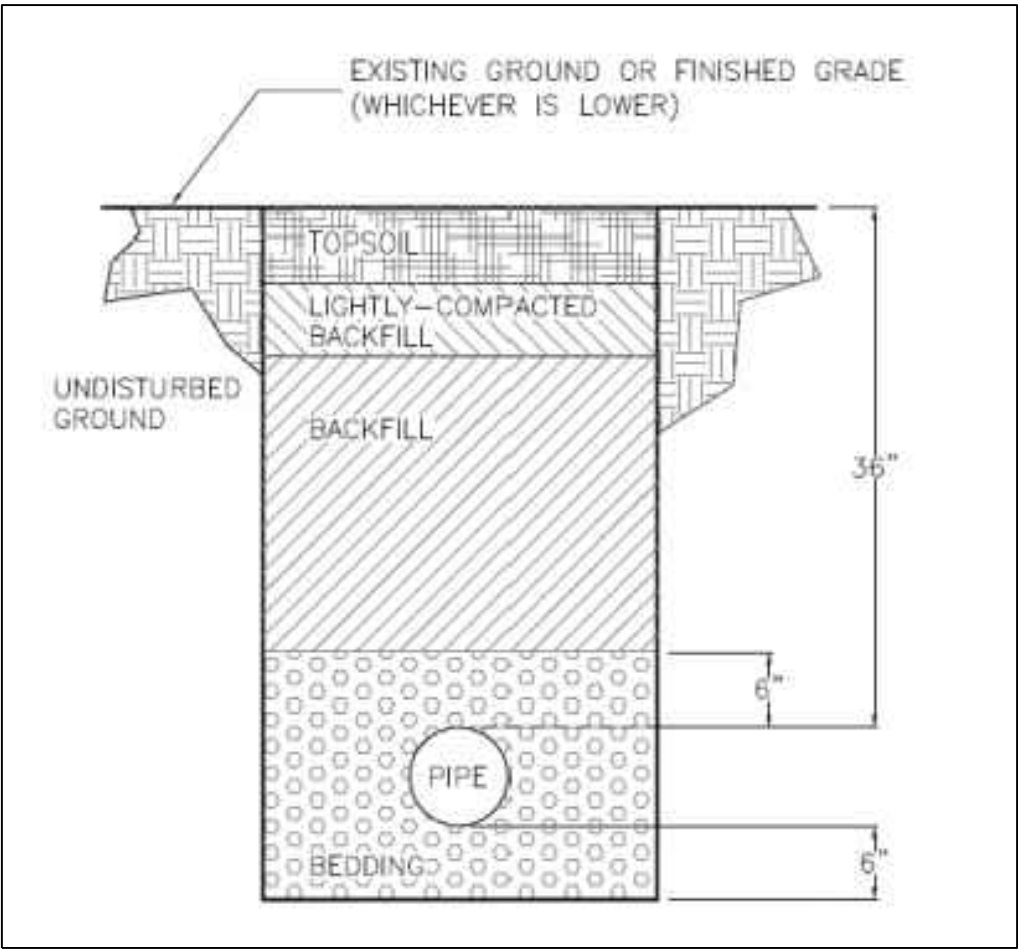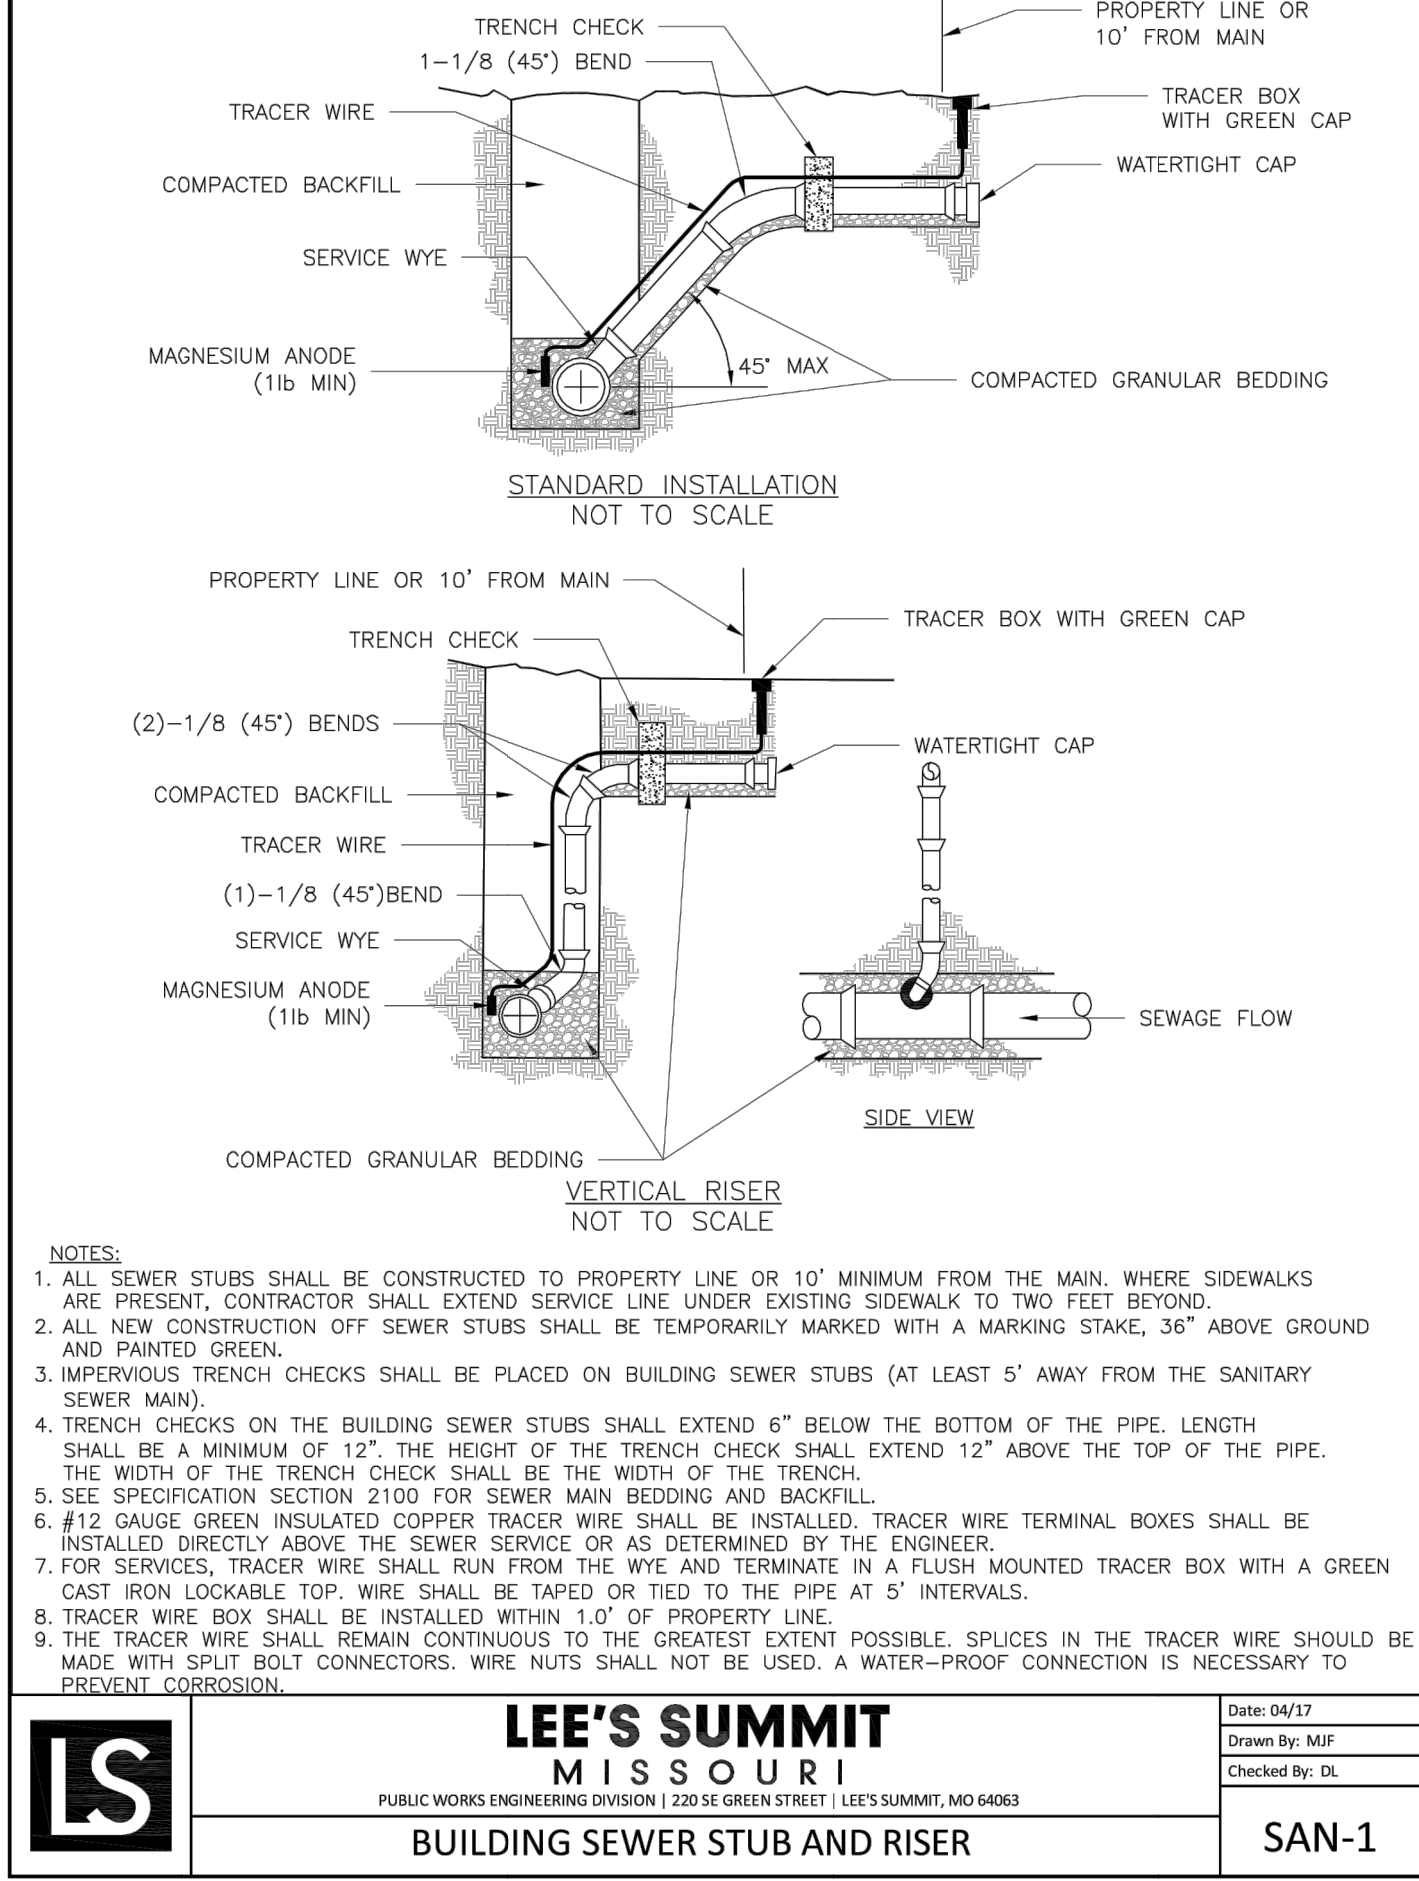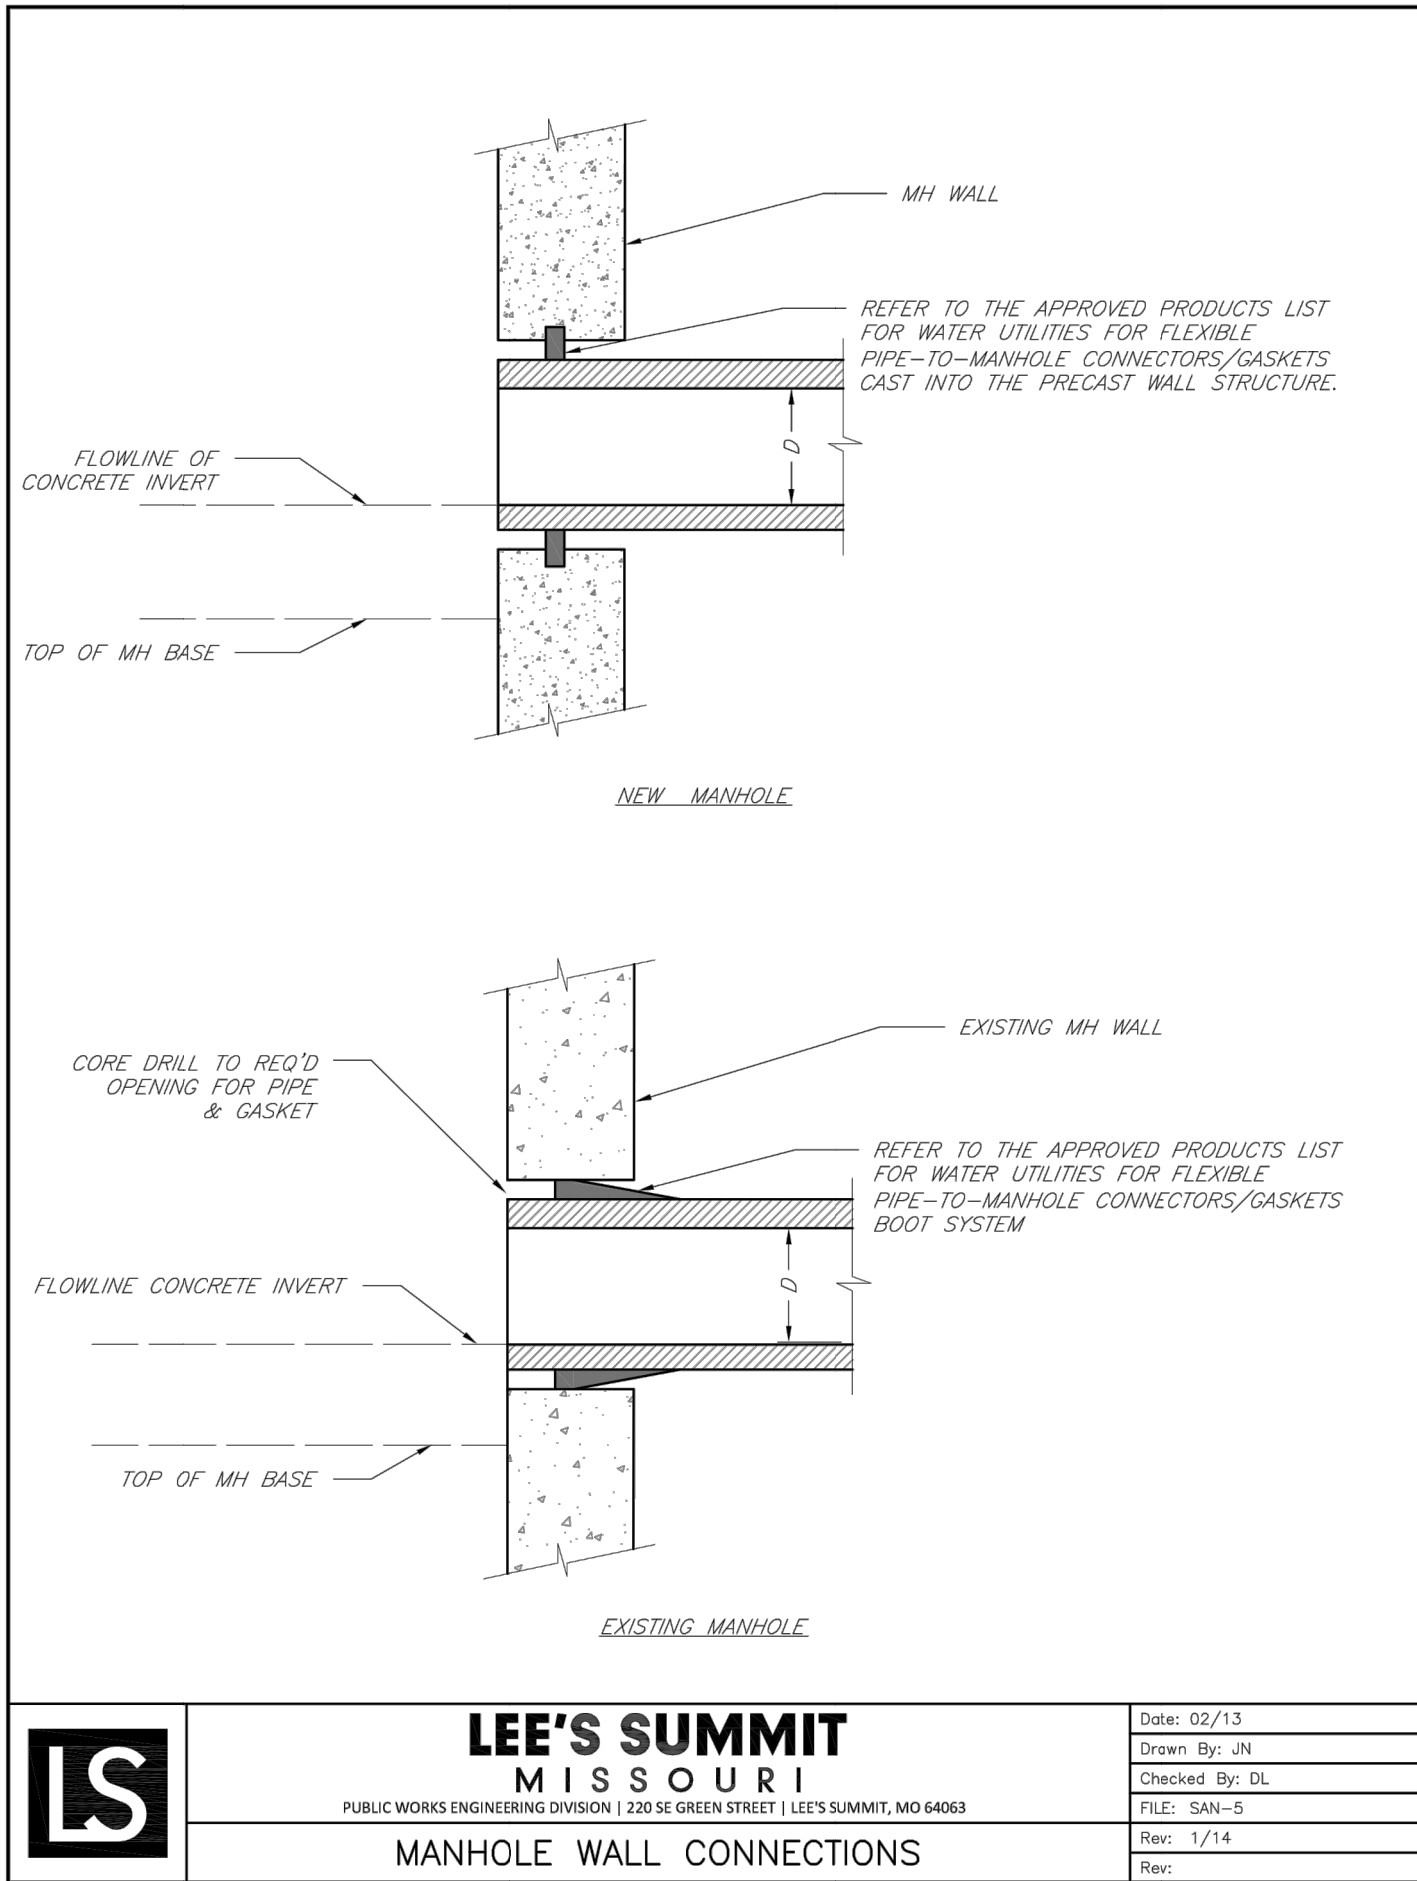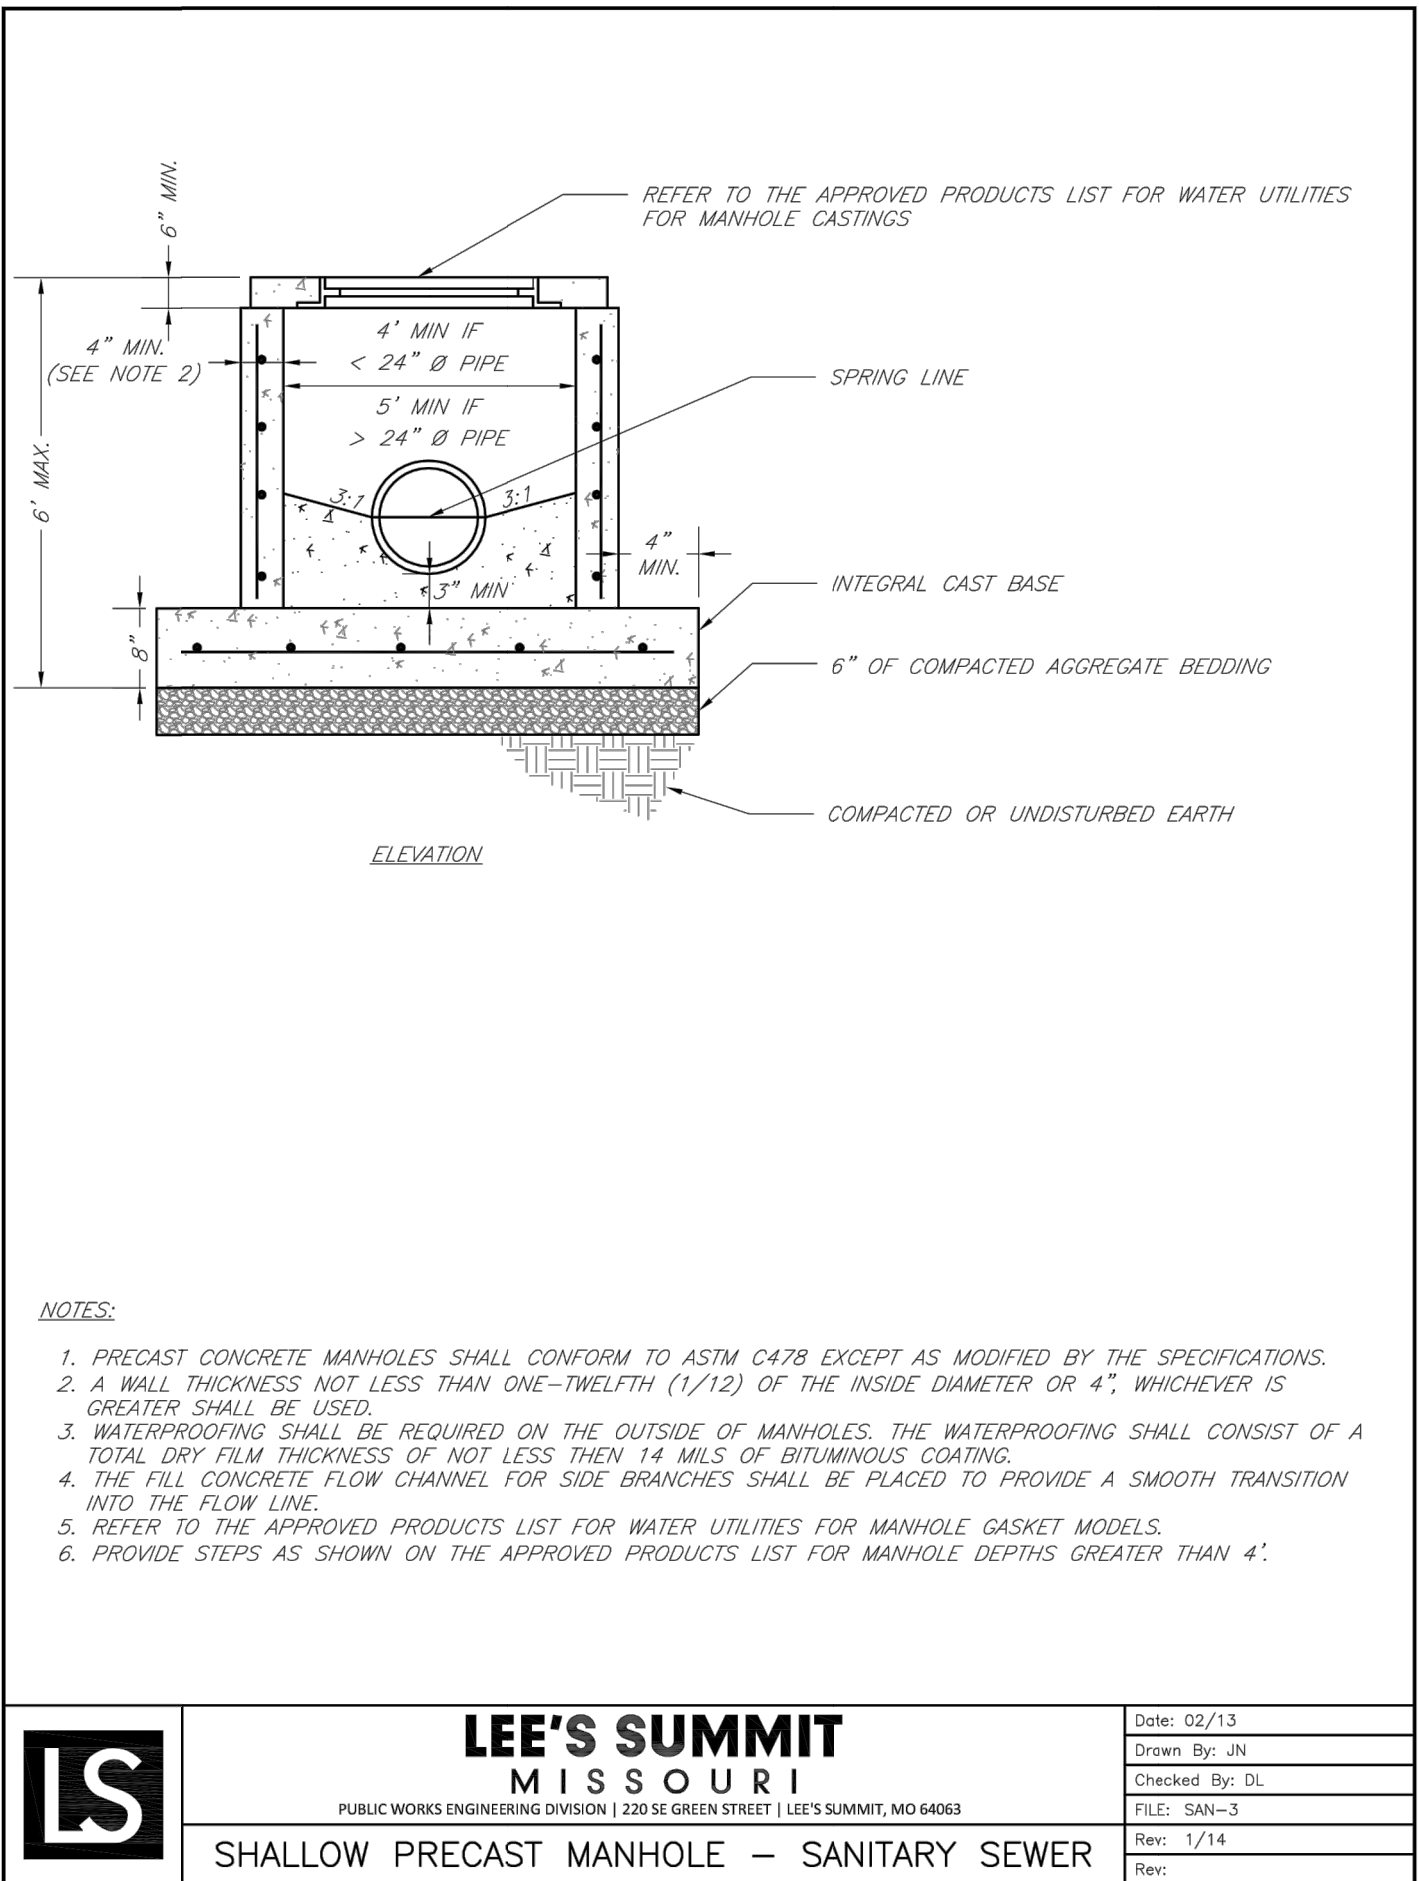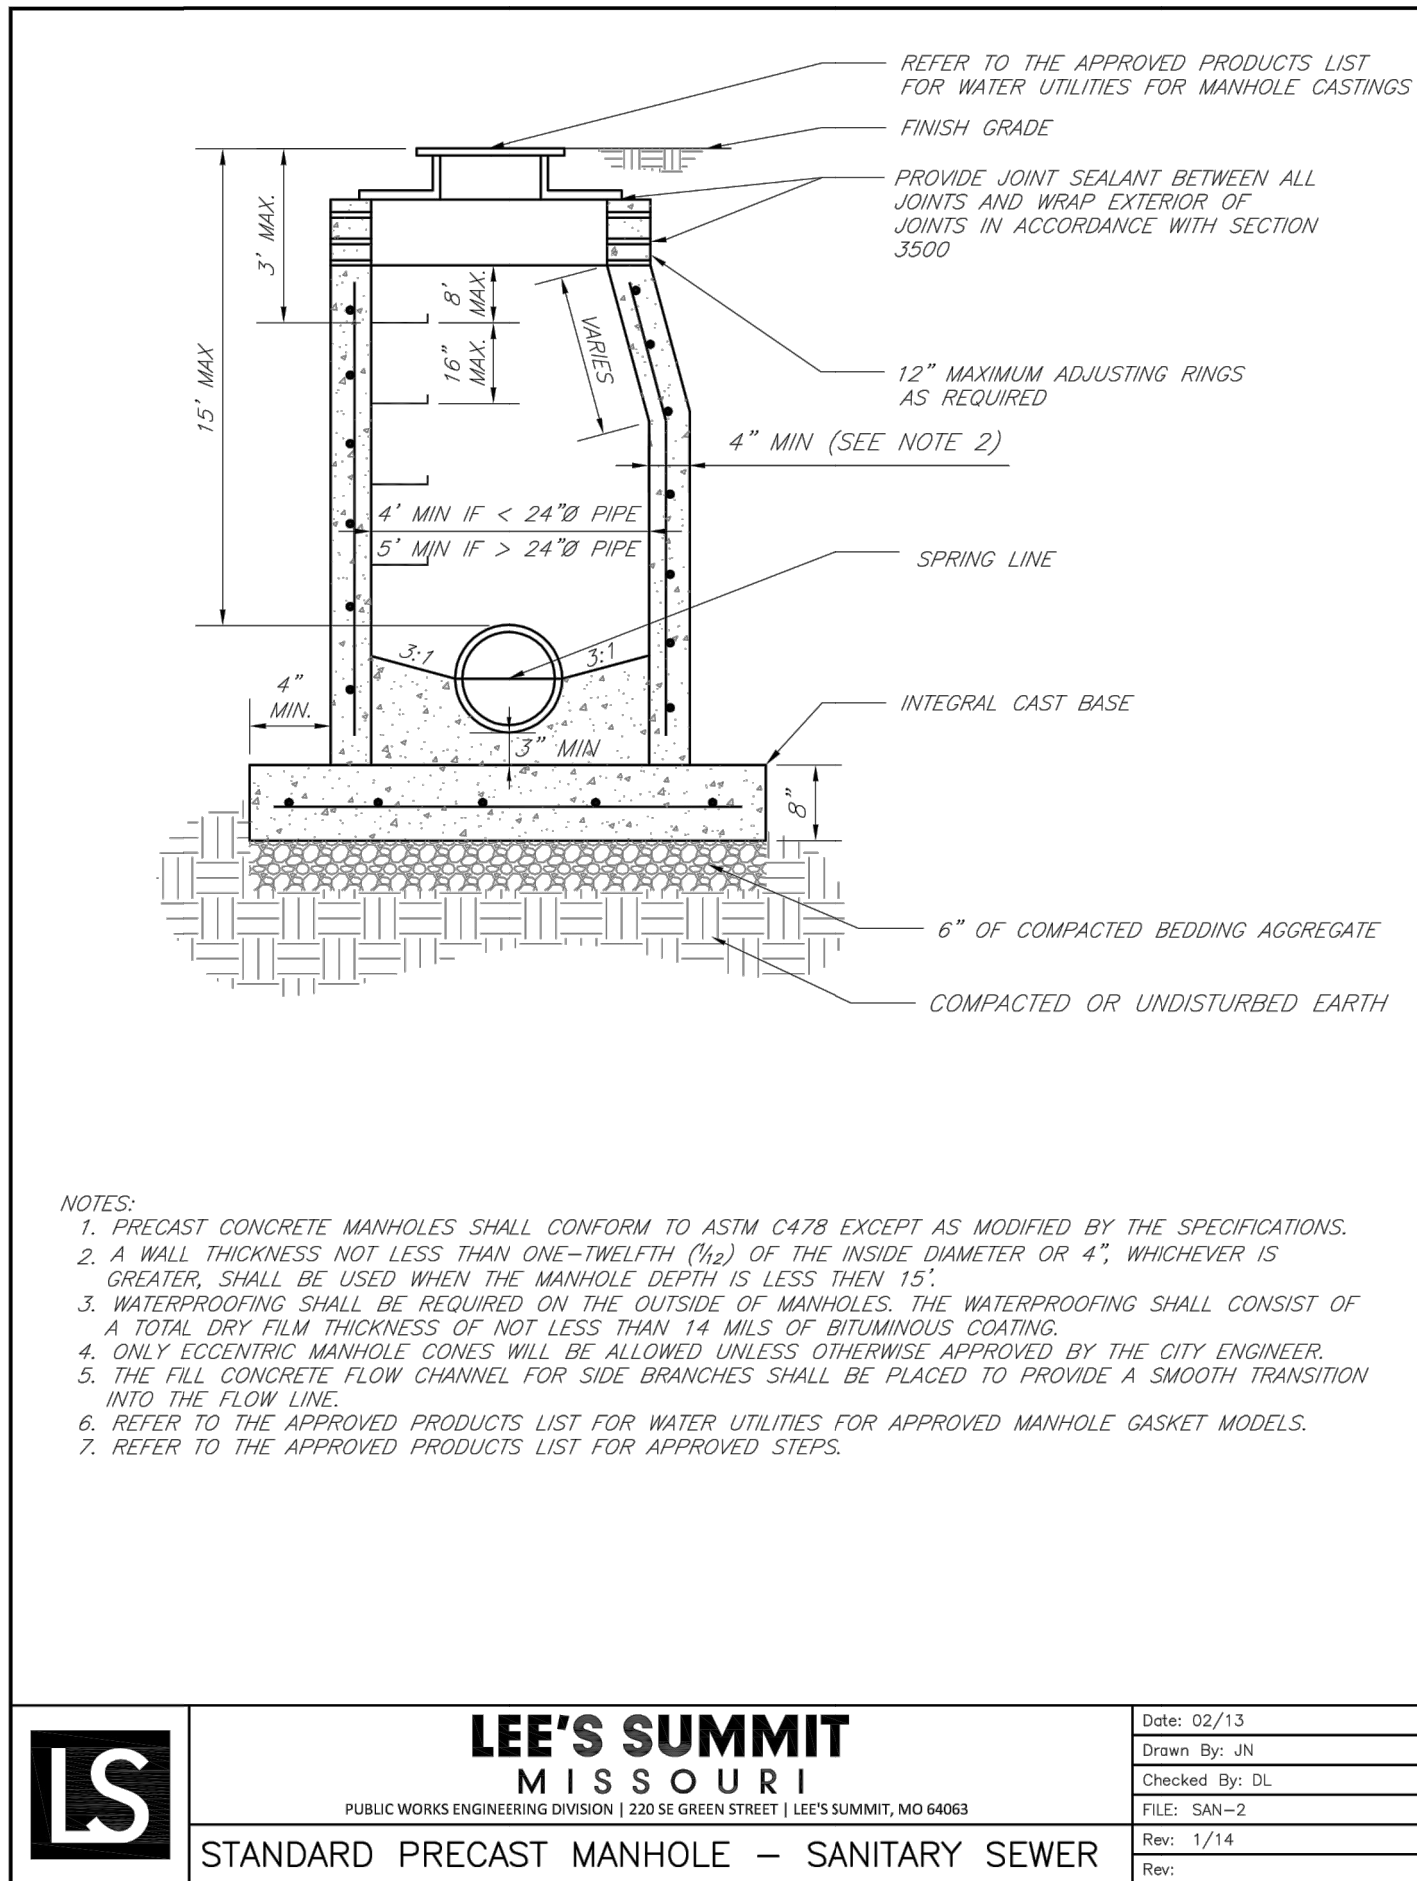

TRENCH AND BACKFILL DETAIL

Added a trench and backfill detail.

GENERAL NOTE:

1 - ALL CONSTRUCTION SHALL CONFORM TO THE CITY OF LEE'S SUMMIT DESIGN AND CONSTRUCTION MANUAL AS ADOPTED BY ORDINANCE 5813.

2 - TRENCH CHECKS SHALL BE INSTALL AT ALL SANITARY WYES LOCATION.