

WOODLAND OAKS

Lots 1 thru 42

SANITARY SEWER CONSTRUCTION PLANS

Section 27, Township 48 North, Range 31 West

LEE'S SUMMIT, JACKSON COUNTY, MISSOURI

CONSTRUCTION AND DESIGN NOTES:

SANITARY SEWERS:

- SANITARY SEWER PIPE SHALL BE POLY VINYL CHLORIDE (PVC), SDR-26, UNLESS NOTED OTHERWISE IN THESE PLANS.
- HOUSE SEWER LATERALS SHALL BE 4 INCH PVC, SDR-26. LATERALS SHALL BE CONSTRUCTED USING A TOP ORIENTED "WYE" AT THE SEWER STATION. SHOWN IN THESE PLANS. LATERALS SHALL BE LAID AT A GRADE OF 2.0% FROM THE SEWER MAIN TO THE STREET RIGHT-OF-WAY LINE OR EASEMENT LINE AS REPRESENTED BY THE LATERAL LENGTH SHOWN IN THESE PLANS. THE ELEVATION SHOWN FOR THE END OF THE LATERAL IN THESE PLANS IS APPROXIMATE. THE ACTUAL ELEVATION SHALL BE DETERMINED BY THE FLOW LINE ELEVATION OF THE SEWER MAIN, THE FITTINGS AND GRADE OF THE SEWER LATERAL.
- THE CONTRACTOR SHALL MAINTAIN A LOG OF THE "AS BUILT" STATION AND LENGTH OF EACH HOUSE LATERAL AND SHALL PROVIDE ENGINEERING SOLUTIONS, L.L.C. WITH A COPY OF SAID LOG UPON COMPLETION OF SEWER CONSTRUCTION.
- ALL MANHOLES INSTALLED IN THE STREET RIGHT-OF-WAY SHALL BE FINISHED 1/2" PER FOOT ABOVE THE NEAREST ADJACENT BACK OF CURB
- A STAKE SHALL BE PLACED AT THE END OF EACH WYE CONNECTION WITH THE END ELEVATION WRITTEN ON THE STAKE
- FILL AREAS SHALL HAVE 18" OF COMPACTED FILL IN PLACE PRIOR TO TRENCHING
- A TRENCH CHECK CONSISTING OF FLOWABLE FILL. MUST BE INSTALLED ON EVERY PRIVATE LATERAL.

GENERAL NOTE:


- ALL CONSTRUCTION SHALL CONFORM TO THE CITY OF LEE'S SUMMIT DESIGN AND CONSTRUCTION MANUAL AS ADOPTED BY ORDINANCE 5813.
- TRENCH CHECKS SHALL BE INSTALL AT ALL SANITARY WYES LOCATION.

OIL - GAS WELLS

ACCORDING TO EDWARD ALTON MAY JR'S ENVIRONMENTAL IMPACT STUDY OF ABANDONED OIL AND GAS WELLS IN LEE'S SUMMIT, MISSOURI IN 1995, THERE ARE NOT OIL AND GAS WELLS WITHIN 185 FEET OF THE PROPERTY AS SURVEYED HEREON.

FLOOD INFORMATION:

The property is located in Zone "X" areas outside the 100 year flood plain per FEMA Map 29095C0430G, dated January 20, 2017

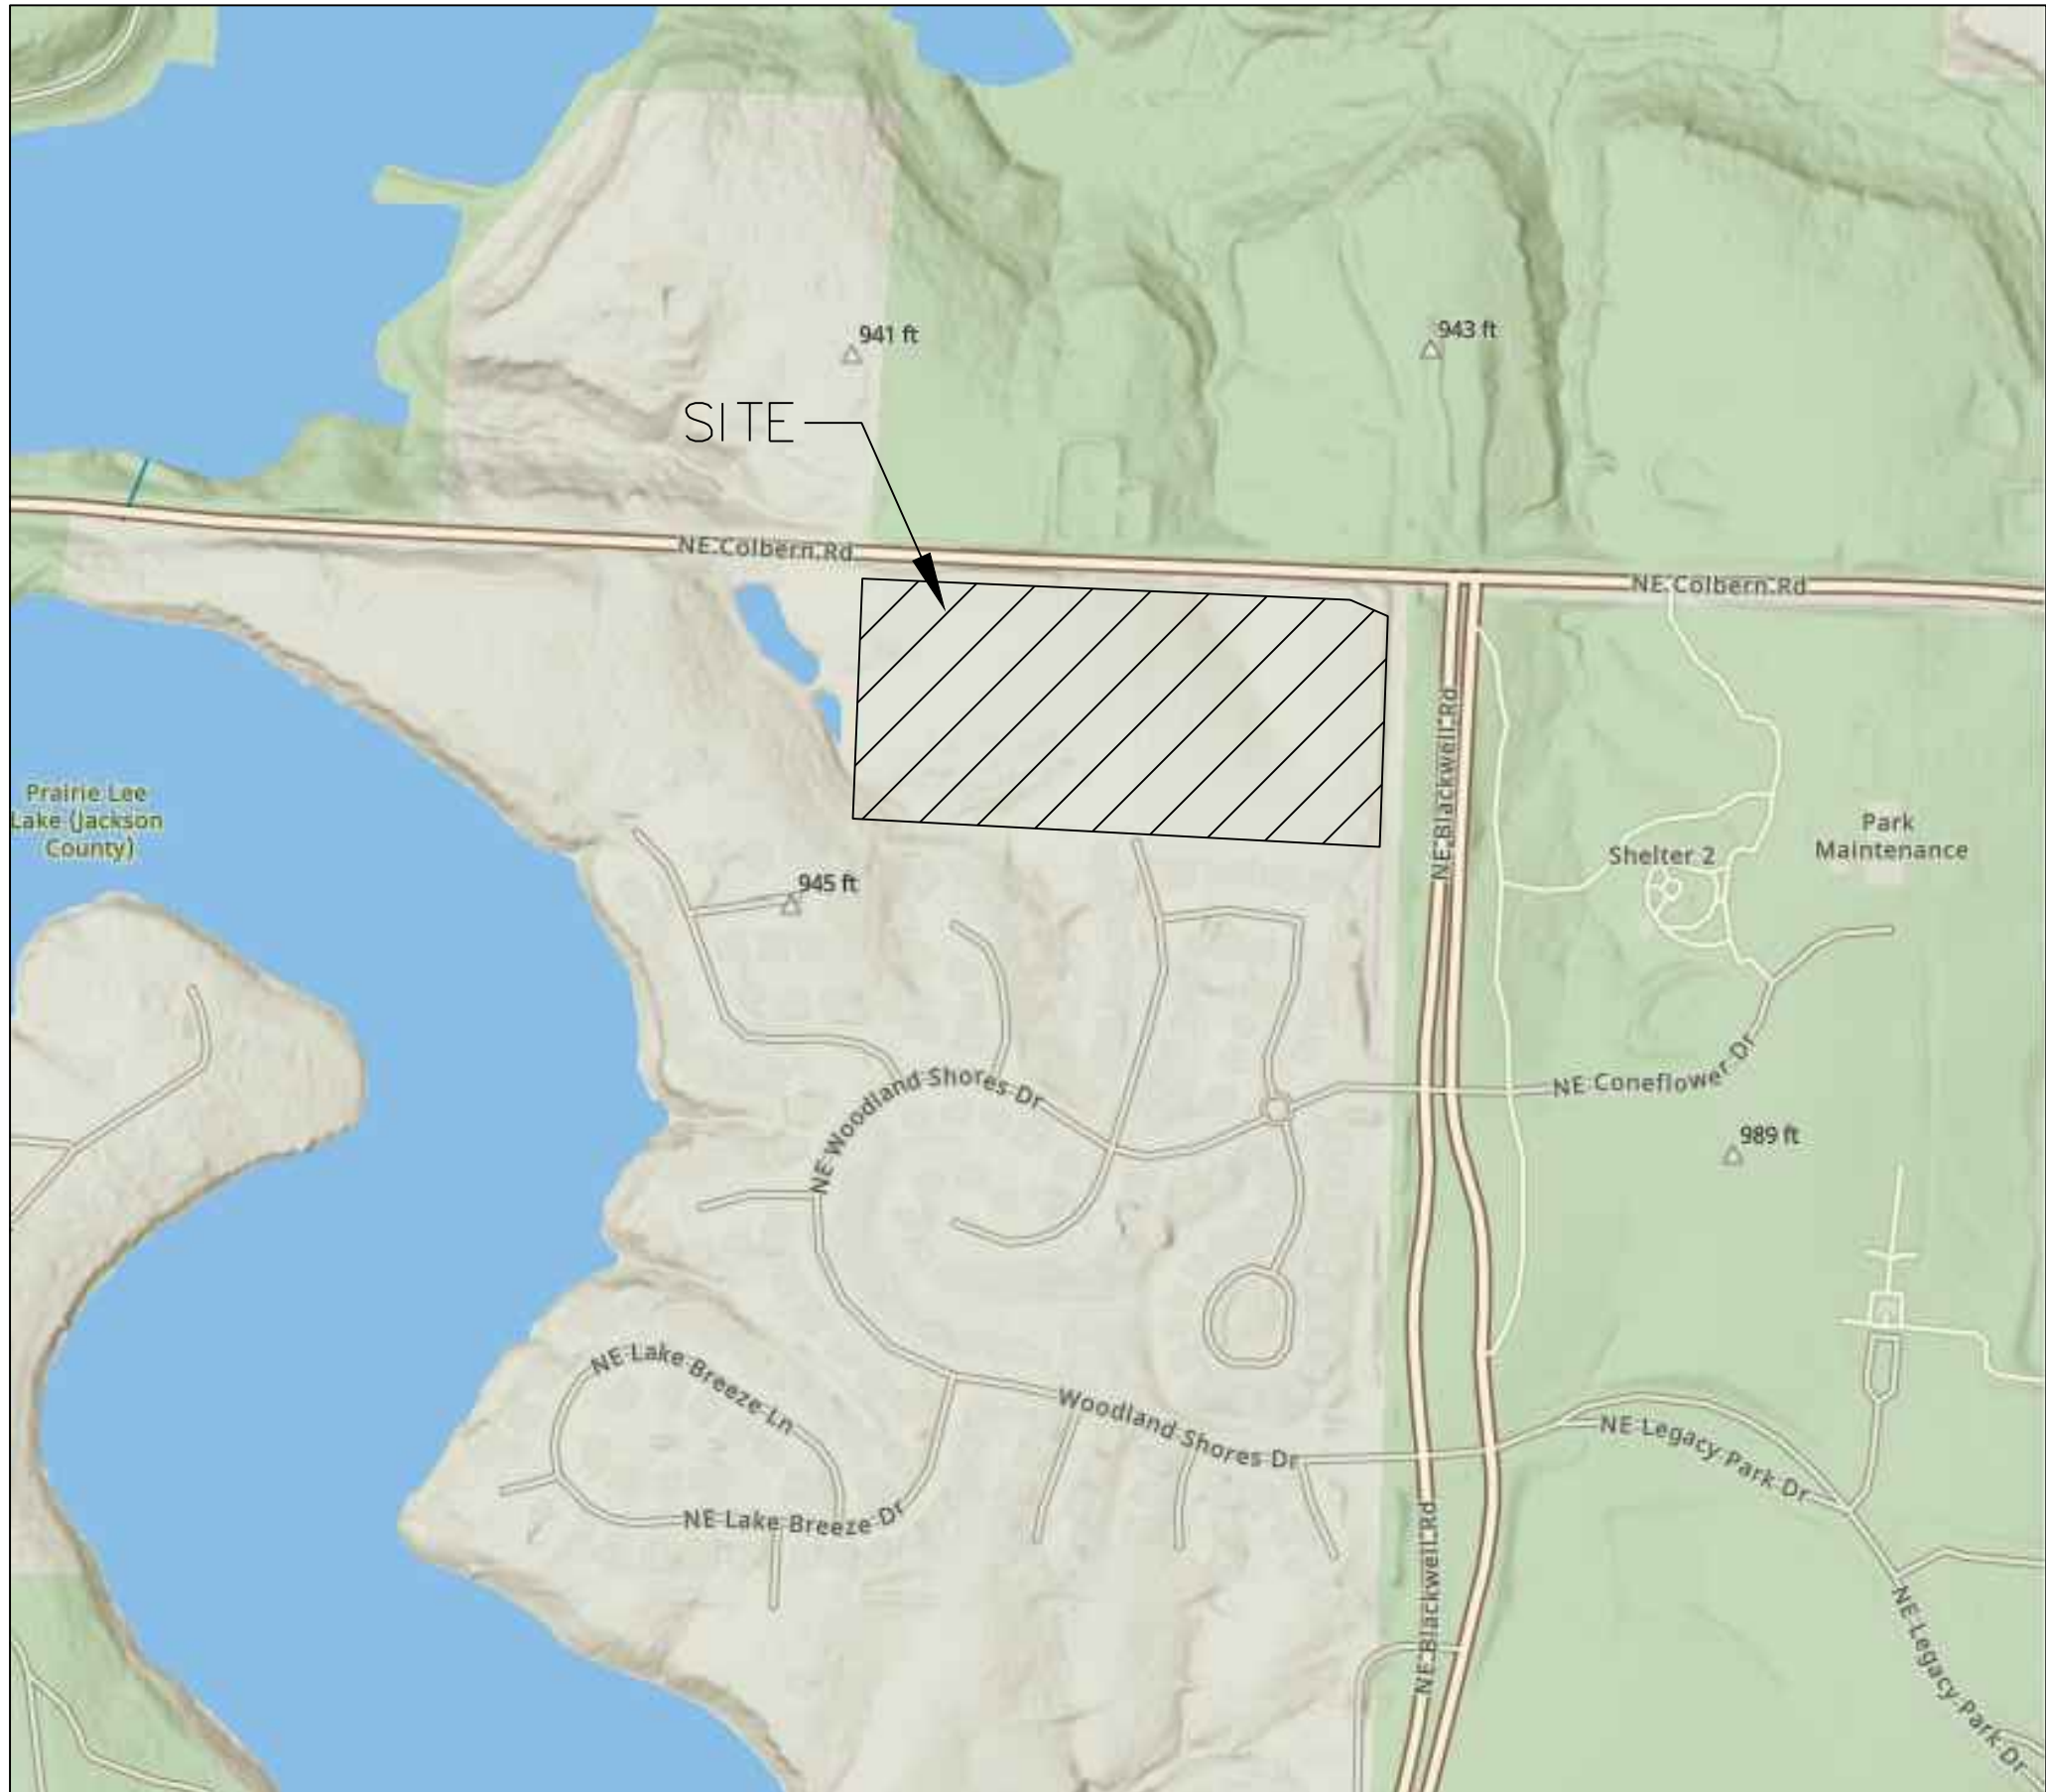

INDEX OF SHEETS:

- C.400 ~ SANITARY SEWER COVER SHEET
- C.401 ~ SANITARY SEWER GENERAL LAYOUT
- C.402 ~ SANITARY SEWER PLAN & PROFILE
- C.403 ~ SANITARY SEWER PLAN & PROFILE
- C.404 ~ SANITARY SEWER PLAN & PROFILE
- C.405 ~ SANITARY SEWER DETAILS

Summary of Quantities:

ITEM AND DESCRIPTION	UNIT	ESTIMATED QUANTITY
SANITARY		
2" PVC HDPE SDR-11 FORCEMAIN	LF	1,602.17
1.25" HDPE SDR-11 SERVICE LINE	LF	530.00
1.25" LATERAL ASSEMBLY	EA	22.00
2" PVC HDPE SDR-11 BENDS	EA	3.00
8" MAIN PVC SDR 26	LF	995.63
4" SERVICE LINE PVC SDR 26	LF	998.22
4" DIA MANHOLE	EA	5.00
SERVICE LINE TEES, WYES, PLUGS, 4" PVC	EA	20.00
CONNECTION TO EXISTING SANITARY SEWER	LS	1.00
TRENCH CHECKS	EA	20.00
TRACER WIRE AND EQUIPMENT	LF	4,126.02

UTILITY COMPANIES:

THE FOLLOWING LIST OF UTILITY COMPANIES IS PROVIDED FOR INFORMATION ONLY. WE DO NOT OFFER ANY GUARANTEE OR WARRANTY THAT THIS LIST IS COMPLETE OR ACCURATE. THE CONTRACTOR SHALL BE RESPONSIBLE FOR CONTACTING ALL UTILITY COMPANIES THAT MAY BE AFFECTED BY THE PROPOSED CONSTRUCTION AND VERIFYING THE ACTUAL LOCATION OF EACH UTILITY LINE. THE CONTRACTOR SHALL NOTIFY ENGINEERING SOLUTIONS AT 816.623.9888 OF ANY CONFLICT WITH PROPOSED IMPROVEMENTS.



EVERGY ~ 298-1196
MISSOURI GAS ENERGY ~ 756-5261
SOUTHWESTERN BELL TELEPHONE ~ 761-5011
COMCAST CABLE ~ 795-1100
WILLIAMS PIPELINE ~ 422-6300
CITY OF LEE'S SUMMIT PUBLIC WORKS ~ 969-1800
CITY OF LEE'S SUMMIT DEVELOPMENT ENGINEERING INSPECTION AT 816.969.1200
CITY OF LEE'S SUMMIT WATER UTILITIES ~ 969-1900
MISSOURI ONE CALL (DIG RITE) ~ 1-800-344-7483

LEGEND:

- B/L - BUILDING SET-BACK
- C/A - COMMON AREA
- D/E - DRAINAGE EASEMENT
- FND. - FOUND
- L/E - LANDSCAPE EASEMENT
- L.N.A. - LIMITS OF NO ACCESS
- R/W - RIGHT OF WAY
- SAN - SANITARY SEWER LINE
- S/W - SIDEWALK
- U/E - UTILITY EASEMENT
- W - WATER LINE
- ST - STORM SEWER LINE

ENGINEER'S CERTIFICATION:

I HEREBY CERTIFY THAT THIS PROJECT HAS BEEN DESIGNED AND THESE PLANS PREPARED IN ACCORDANCE WITH THE CURRENT DESIGN CRITERIA OF THE CITY OF LEE'S SUMMIT, MISSOURI AND THE STATE OF MISSOURI. I FURTHER CERTIFY THAT THESE PLANS WERE DESIGNED IN ACCORDANCE TO AASHTO STANDARDS.

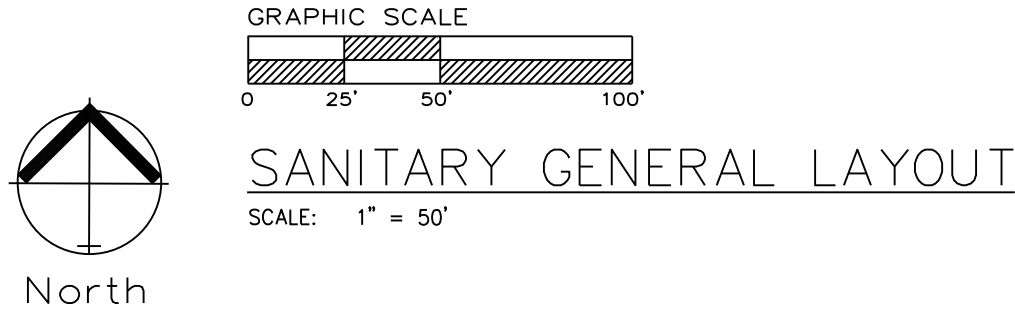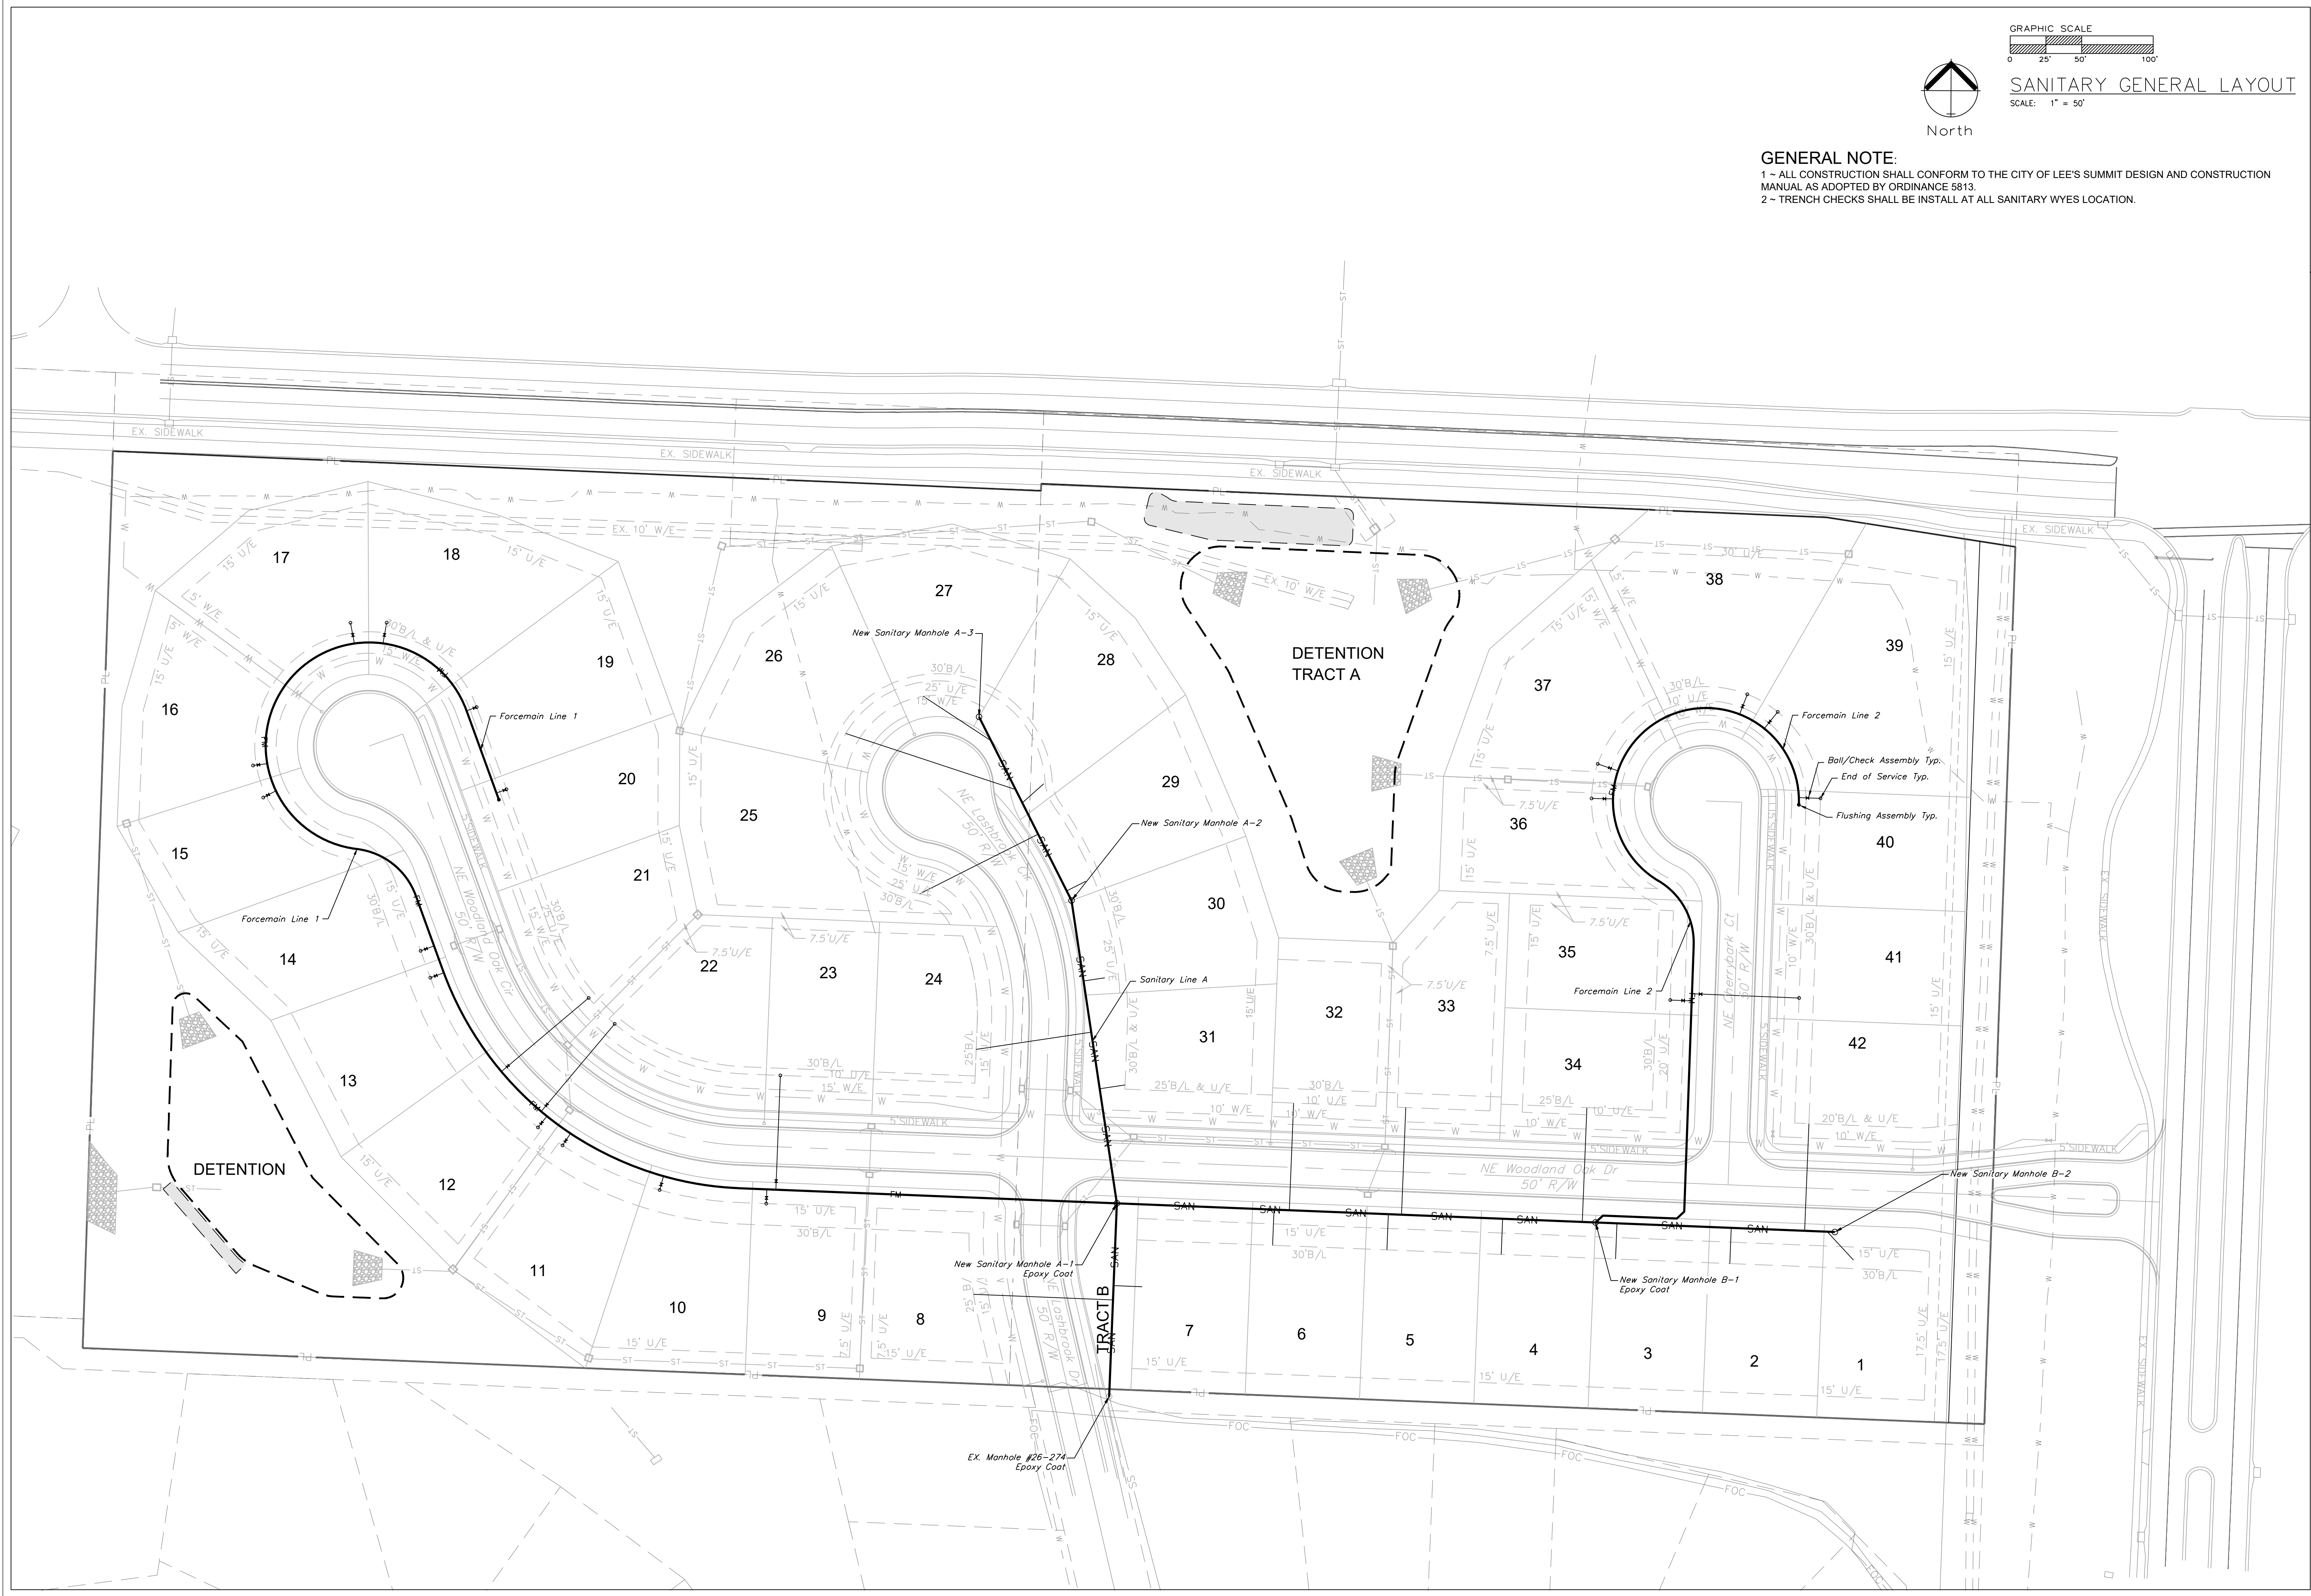

GENERAL NOTE:
1 ~ ALL CONSTRUCTION SHALL CONFORM TO THE CITY OF LEE'S SUMMIT DESIGN AND CONSTRUCTION MANUAL AS ADOPTED BY ORDINANCE 5813.
2 ~ TRENCH CHECKS SHALL BE INSTALL AT ALL SANITARY WYES LOCATION.




Professional Registration
Missouri
Engineering 2005002186-D
Surveying 2005008319-D
Kansas
Engineering E-1685
Surveying LS-218
Oklahoma
Engineering 6254
Nebraska
Engineering CA2821

Part of the Southeast 1/4
Section 27, Township 48 North, Range 31 West
Lee's Summit, Jackson County, Missouri

Project: WOODLAND OAKS
LSMO
Issue Date: February 25, 2021


Sanitary Sewer General Layout
Construction Plans for:
WOODLAND OAKS
Lots 1 thru 42
Lee's Summit, Jackson County, Missouri

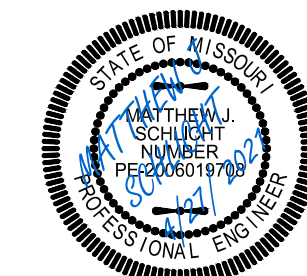


Matthew J. Schlicht
MO PE 2006019708
KS PE 19071
OK PE 25226
NE PE E-14335

REVISIONS
REV. 4/27/2021




 
GENERAL NOTE:
1 - ALL CONSTRUCTION SHALL CONFORM TO THE CITY OF LEE'S SUMMIT DESIGN AND CONSTRUCTION MANUAL AS ADOPTED BY ORDINANCE 5813.
2 - TRENCH CHECKS SHALL BE INSTALL AT ALL SANITARY WYES LOCATION.



SANITARY PLAN & PROFILE
SCALE: 1" = 50'

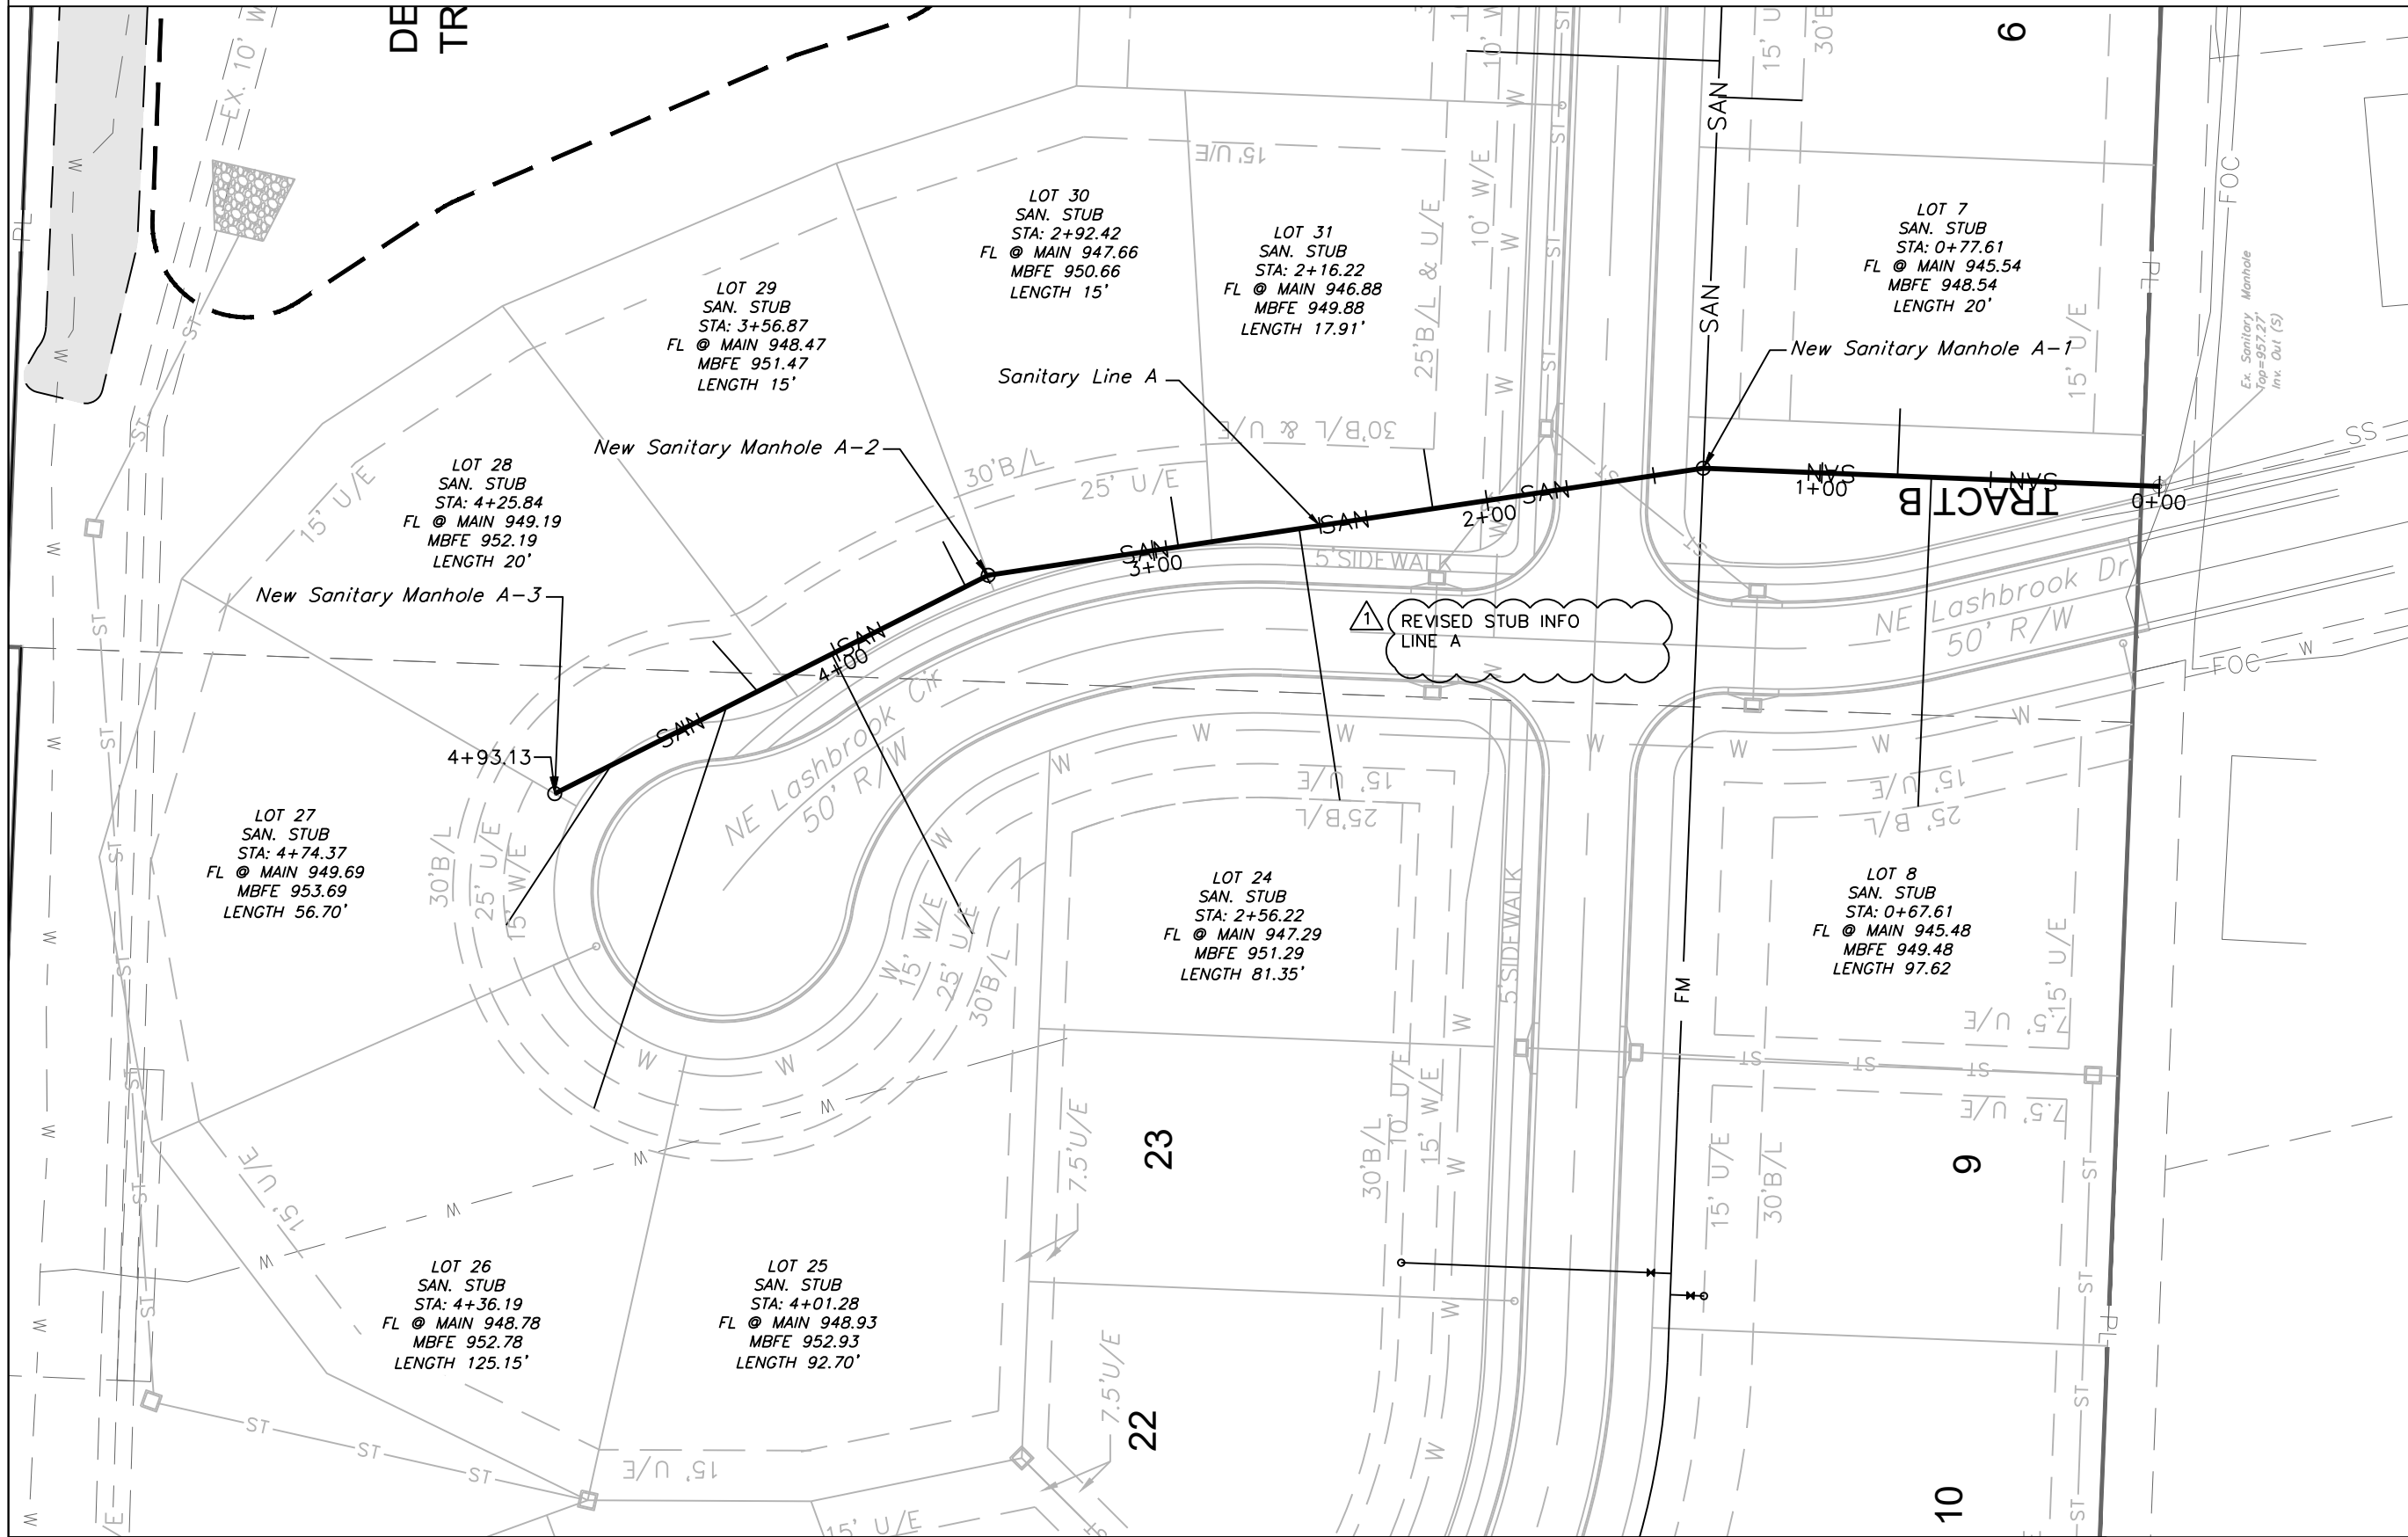





SANITARY LINE A

  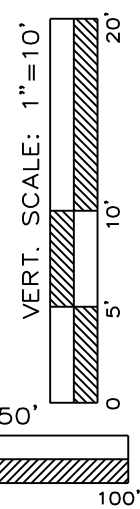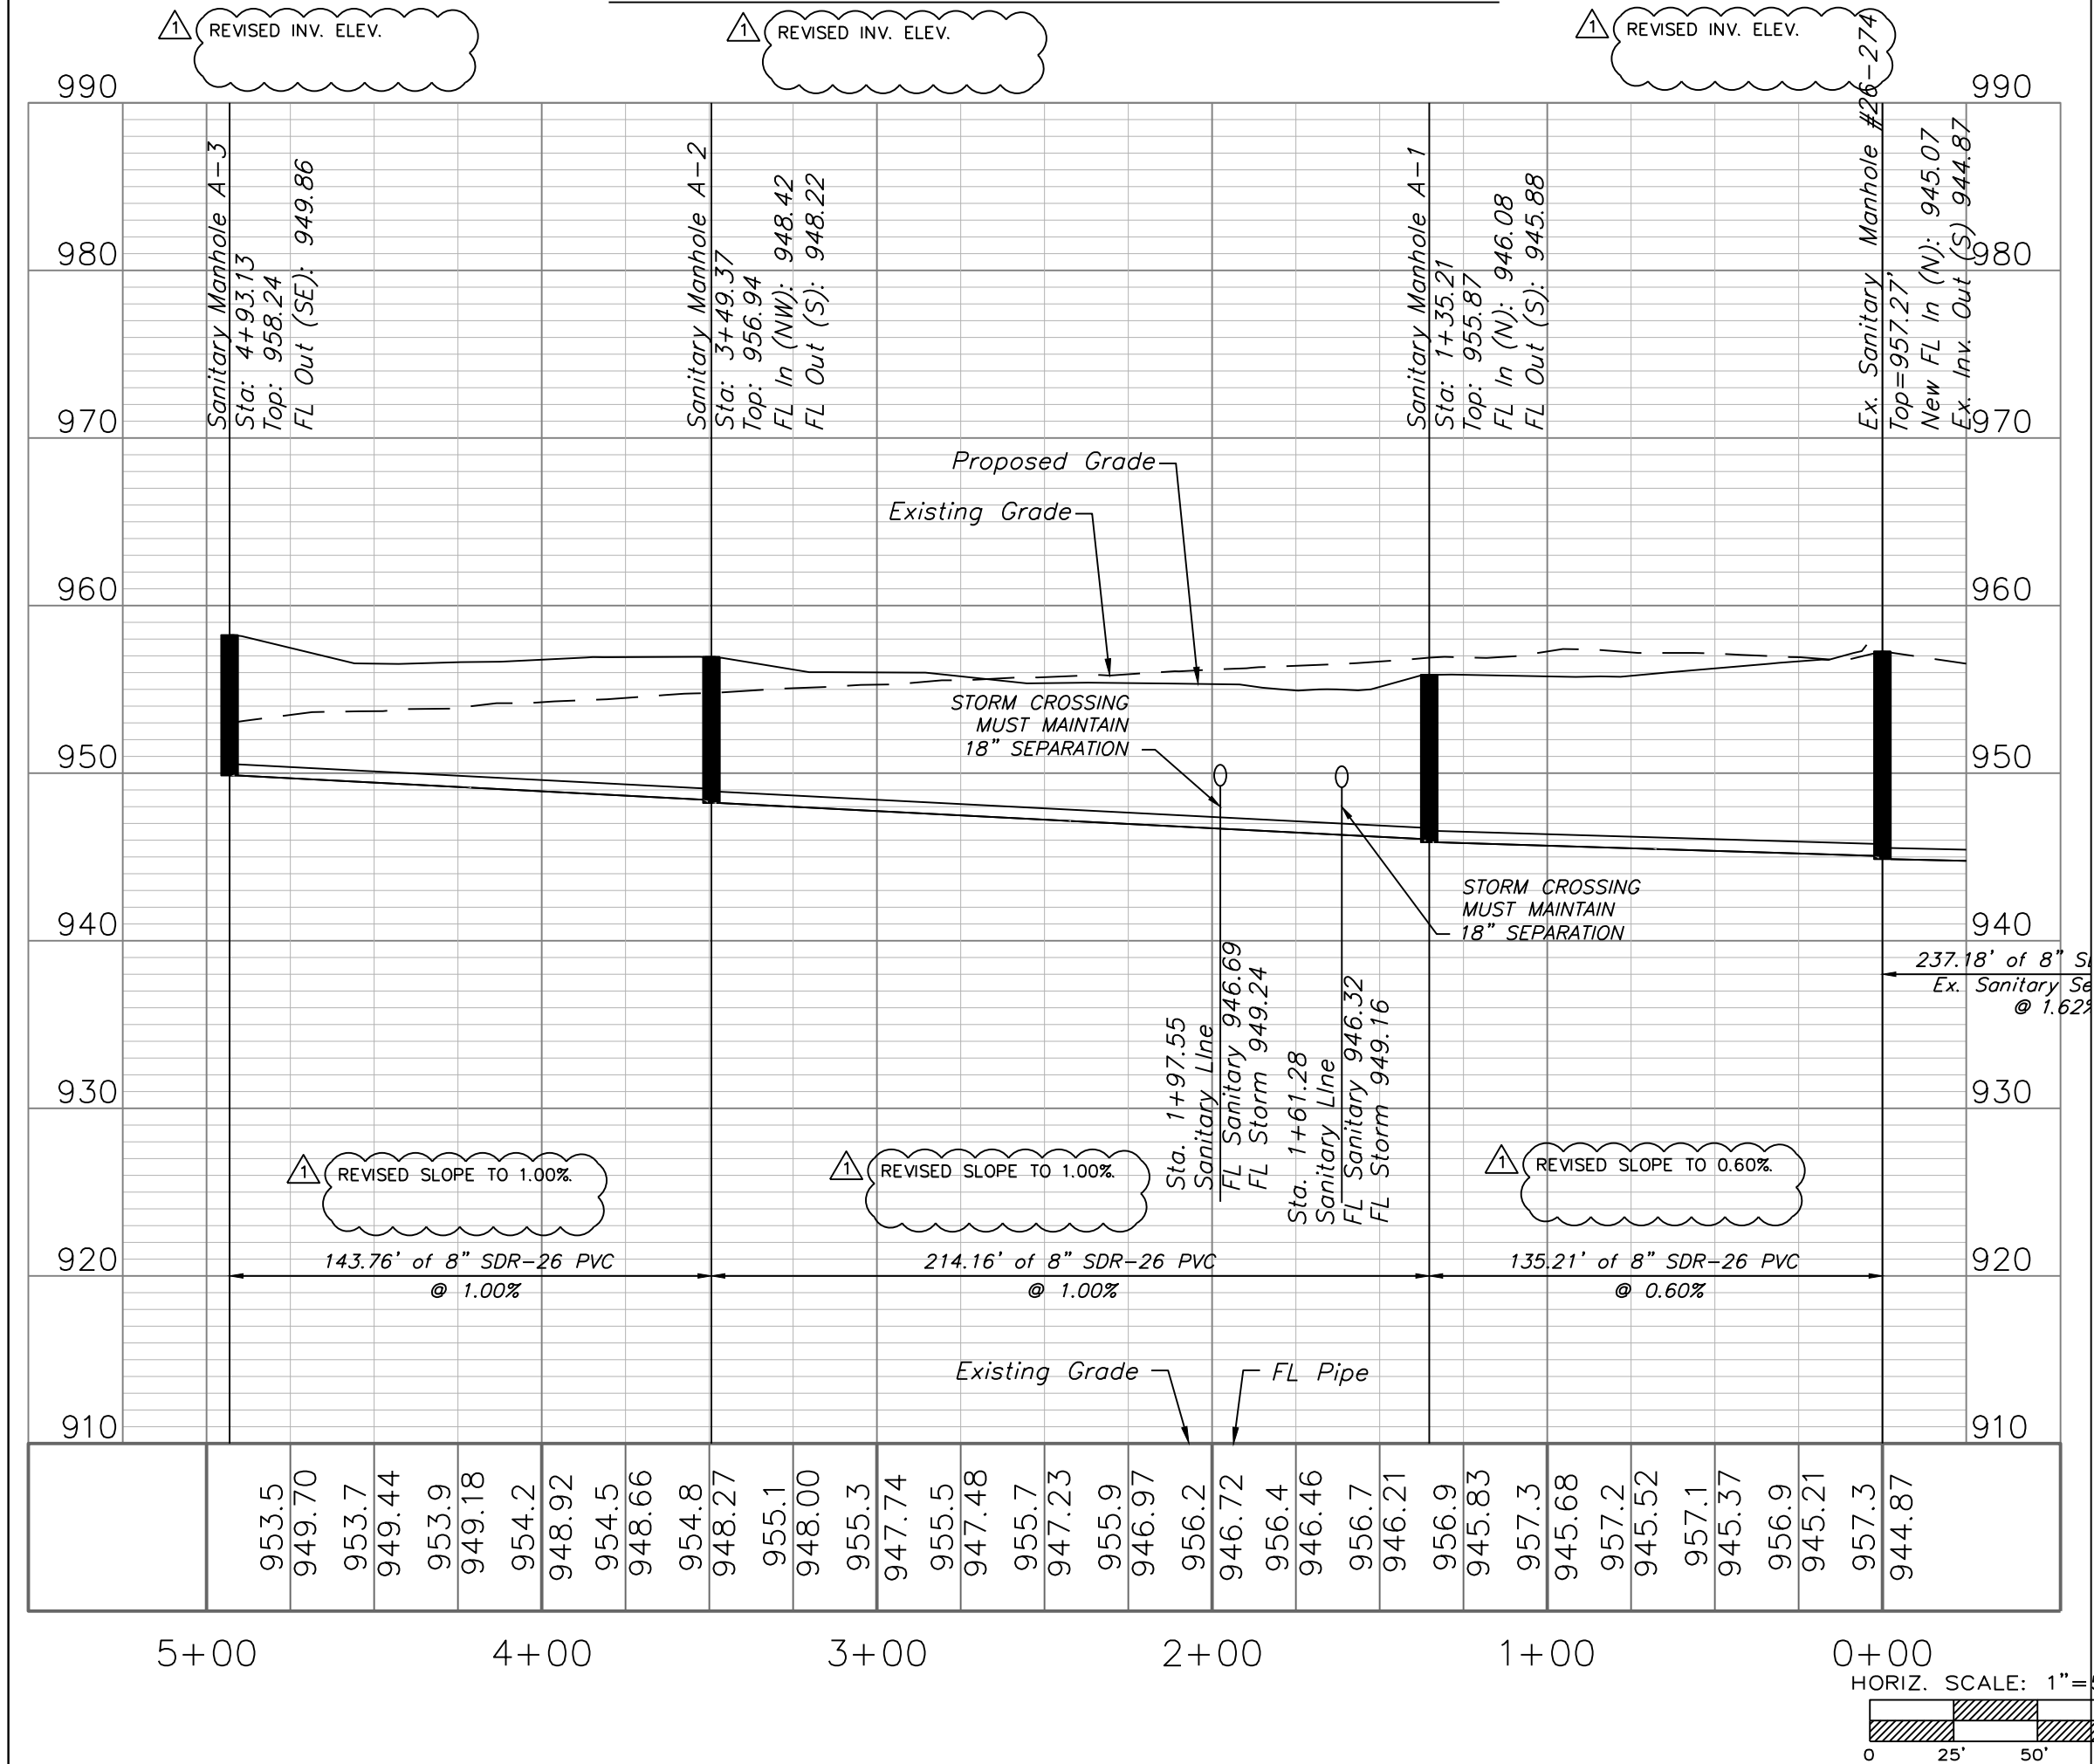

SANITARY PLAN & PROFILE
SCALE: 1" = 50'



 SANITARY LINE B

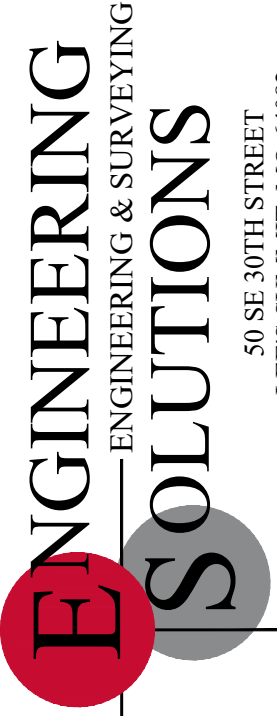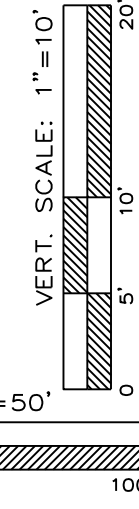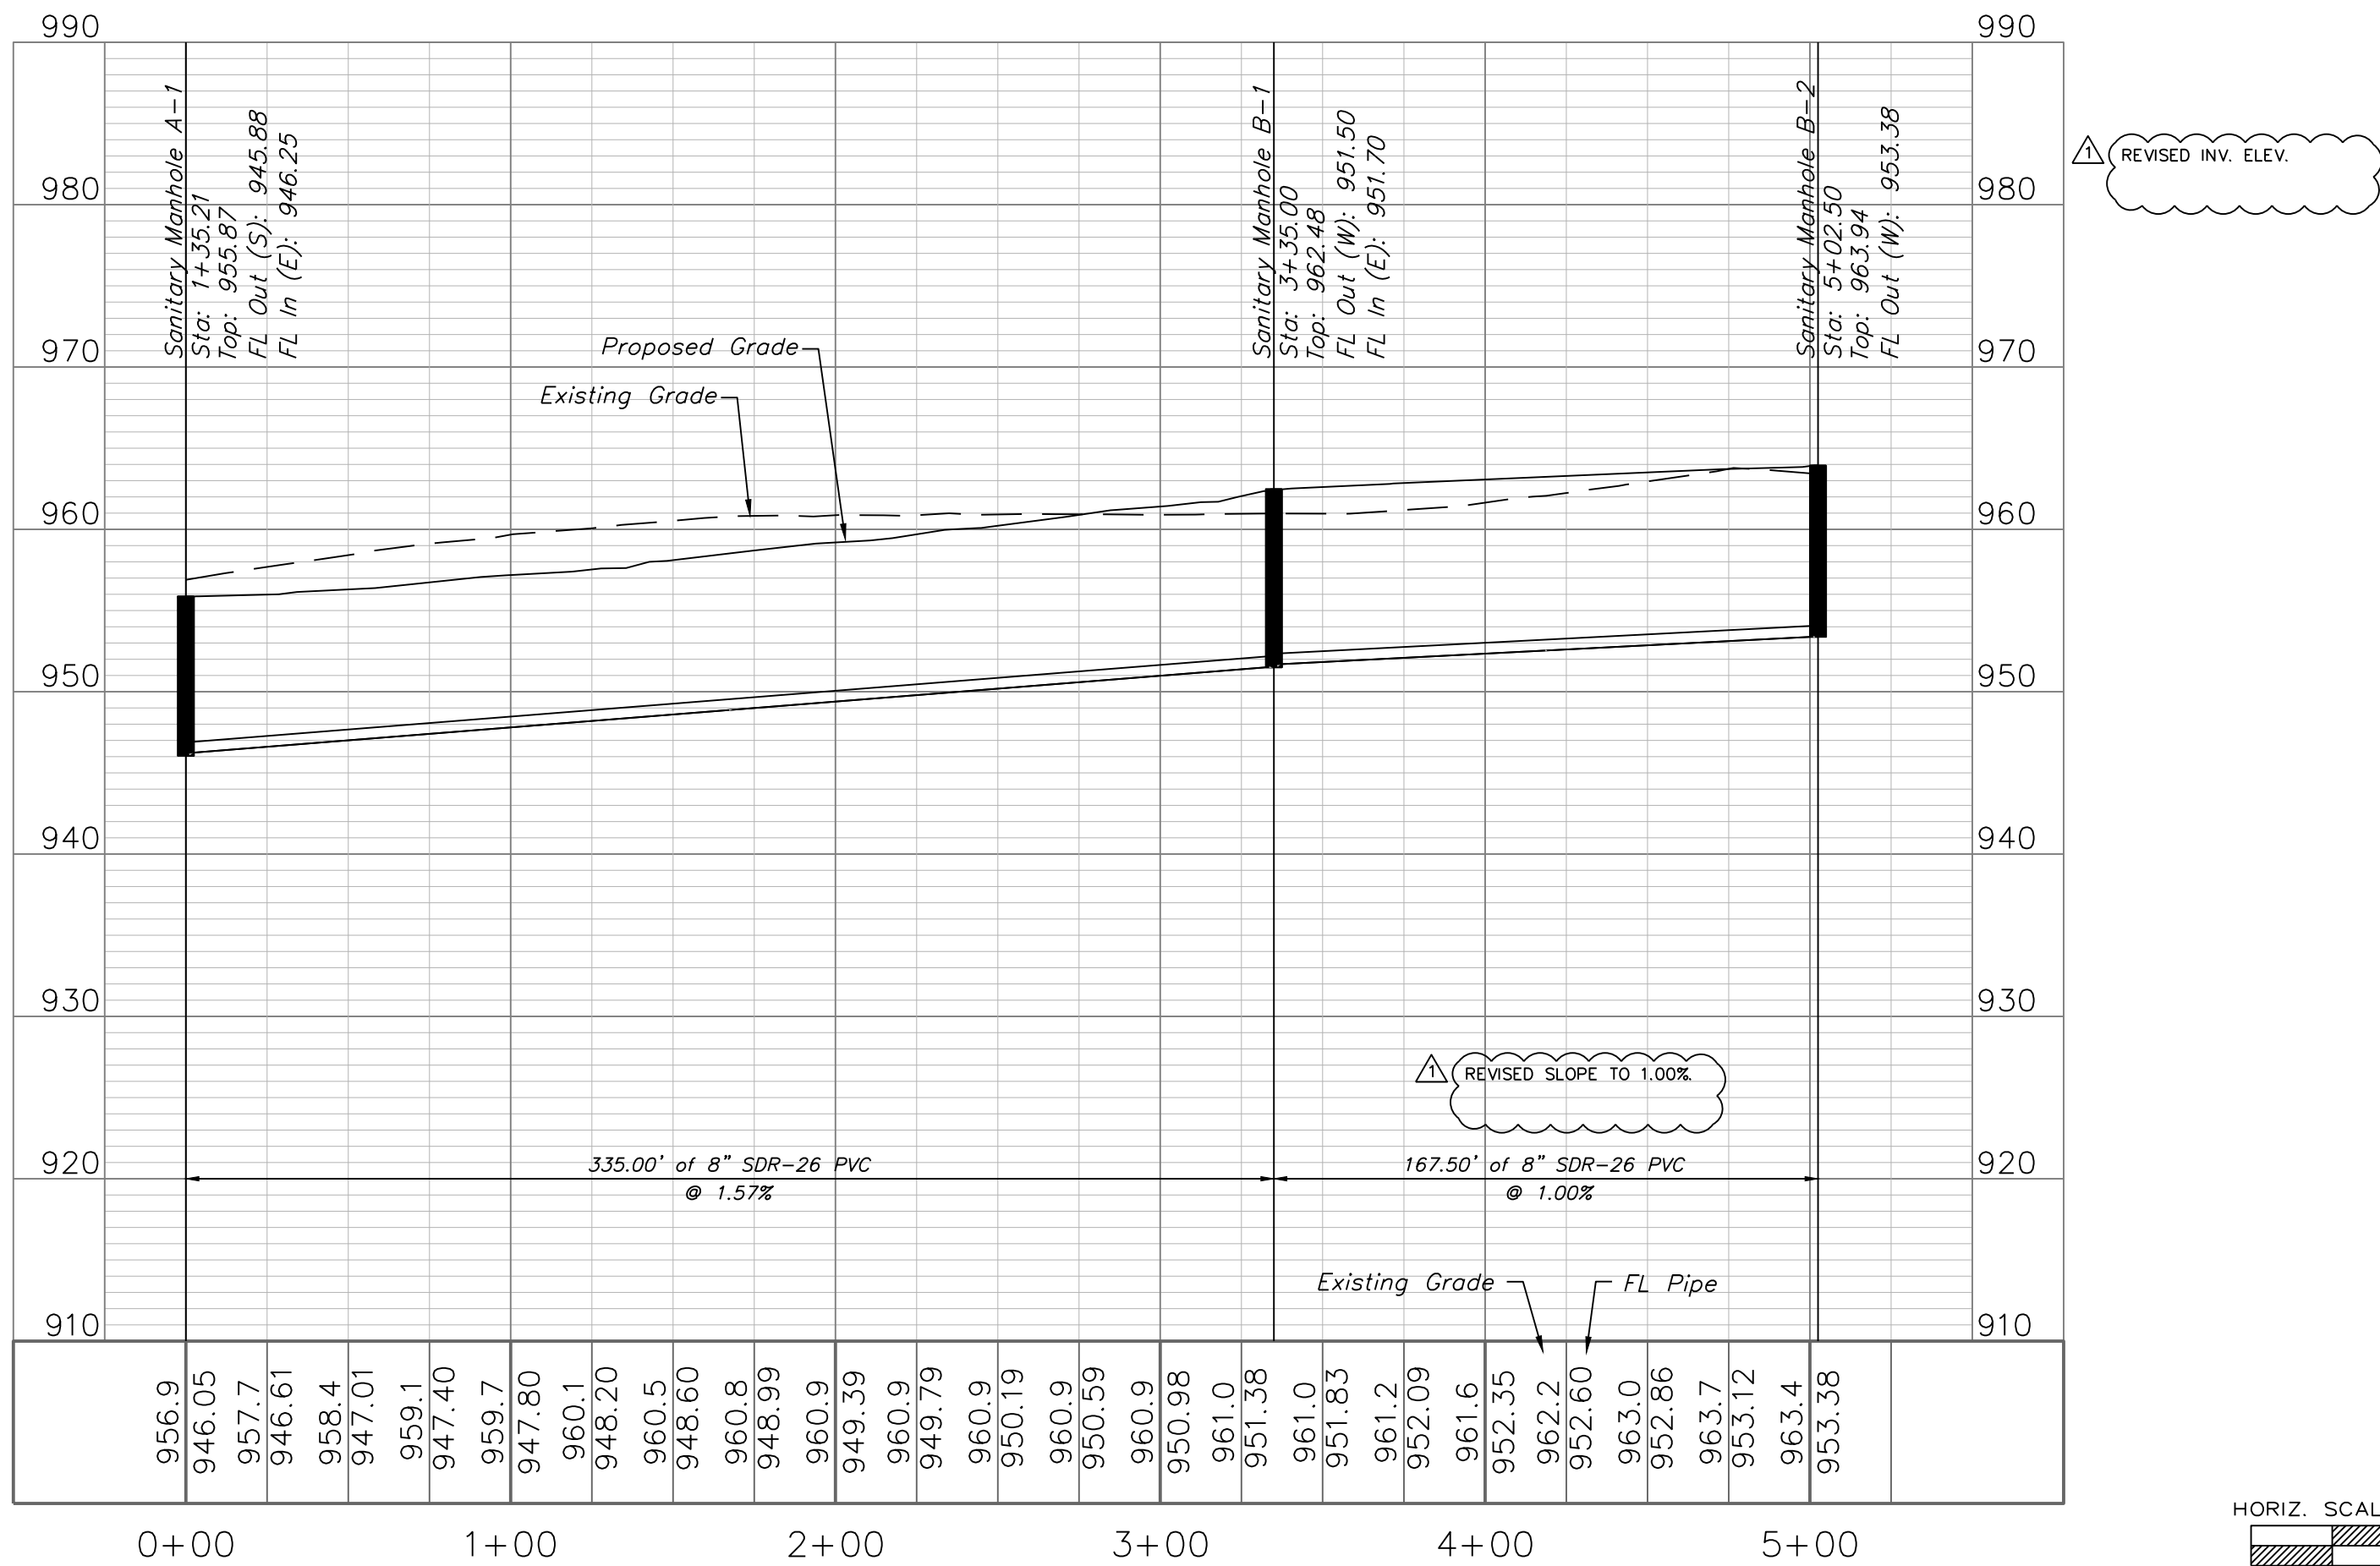


Professional Registration
Missouri
Engineering 2005002186-D
Surveying 2005008319-D
Kansas
Engineering E-1685
Surveying LS-218
Oklahoma
Engineering 6284
Nebraska
Engineering CA2821

Part of the Southeast 1/4
Section 27, Township 48 North, Range 31 West
Lee's Summit, Jackson County, Missouri

Project:
WOODLAND OAKS
LSMO
Issue Date:
February 25, 2021

Sanitary Plan and Profile
Construction Plans for:
WOODLAND OAKS
Lots 1 thru 42
Lee's Summit, Jackson County, Missouri

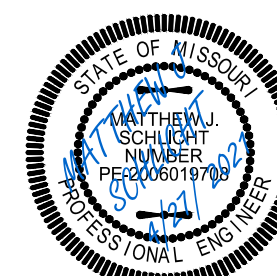


Matthew J. Schlicht
MO PE 0006019708
KS PE 19071
OK PE 25226
NE PE E-14335

REVISIONS
REV. 4/27/2021

GENERAL NOTE:
1 ~ ALL CONSTRUCTION SHALL CONFORM TO THE CITY OF LEE'S SUMMIT DESIGN AND CONSTRUCTION MANUAL AS ADOPTED BY ORDINANCE 5813.
2 ~ TRENCH CHECKS SHALL BE INSTALL AT ALL SANITARY WYES LOCATION.
3 ~ COMPACTED FILL SHALL BE PLACED TO A MINIMUM 18" ABOVE THE TOP OF THE PIPE PRIOR TO INSTALLATION.

 
ADDED NOTE 3




SANITARY PLAN & PROFILE

SCALE: 1" = 50'

NOTE:
LOTS 9 THRU 23 WILL BE FORCEMAIN
AND REQUIRE GRINDER PUMPS.

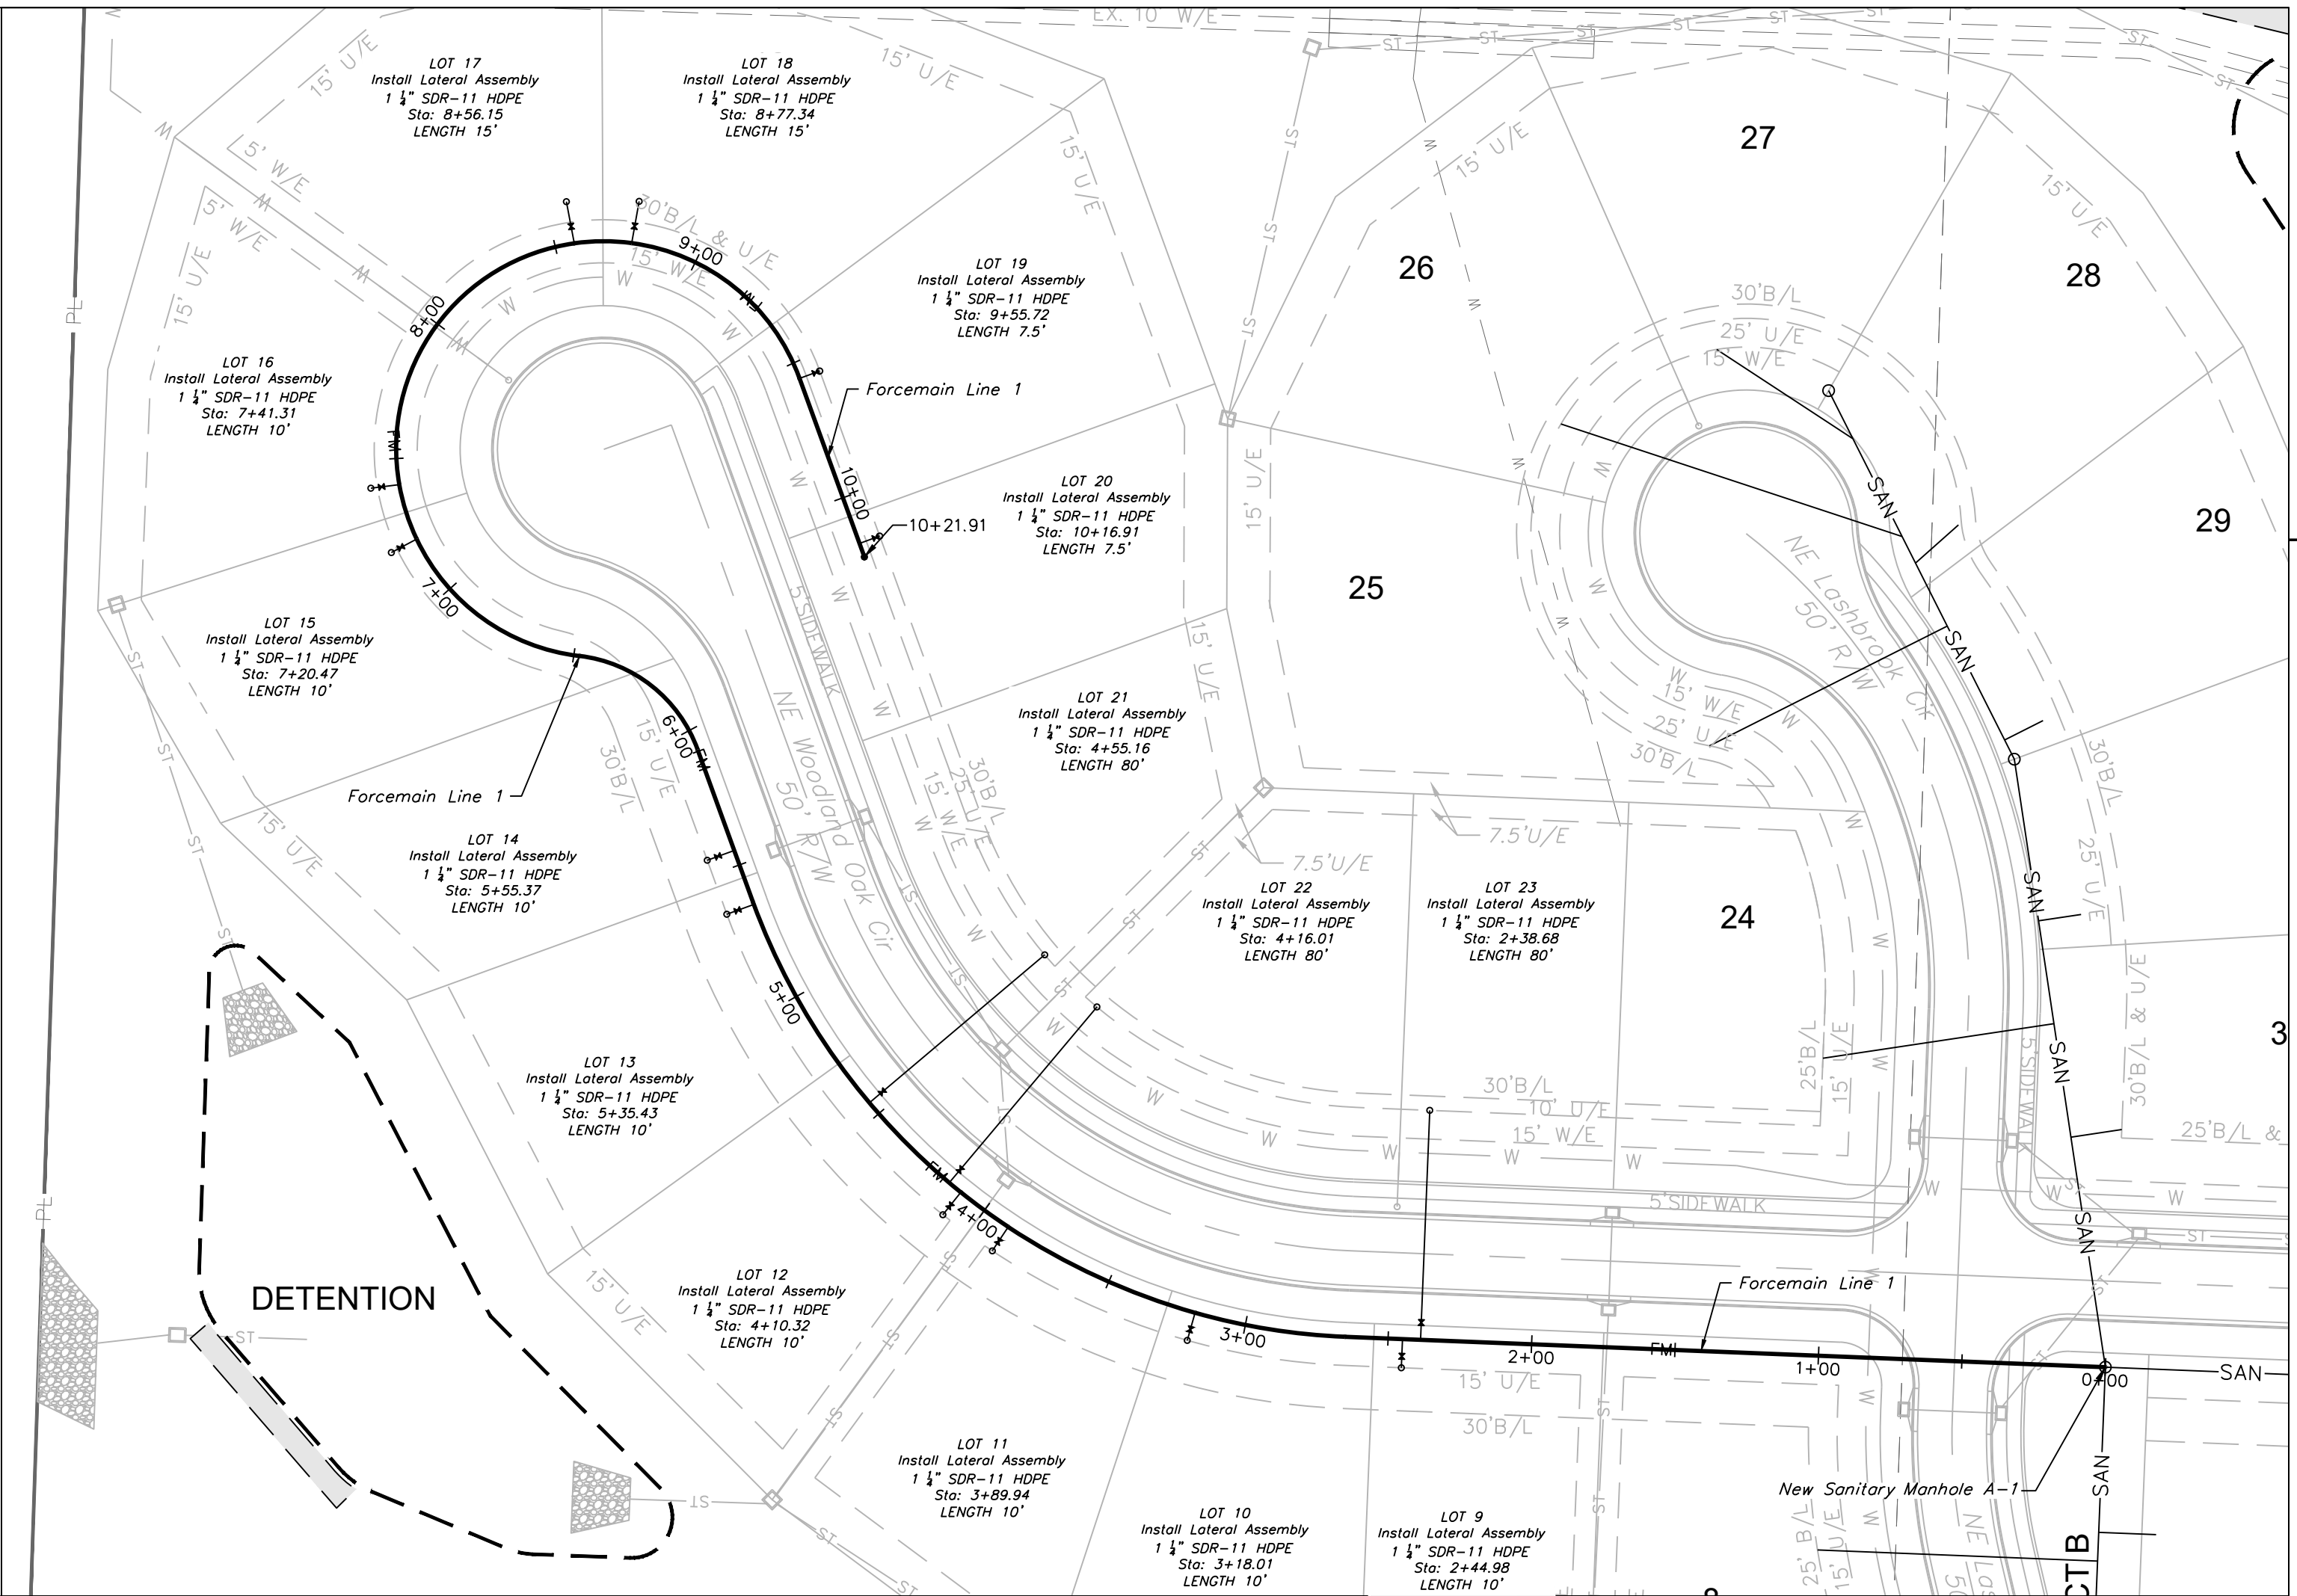

FORCEMAIN LINE 1

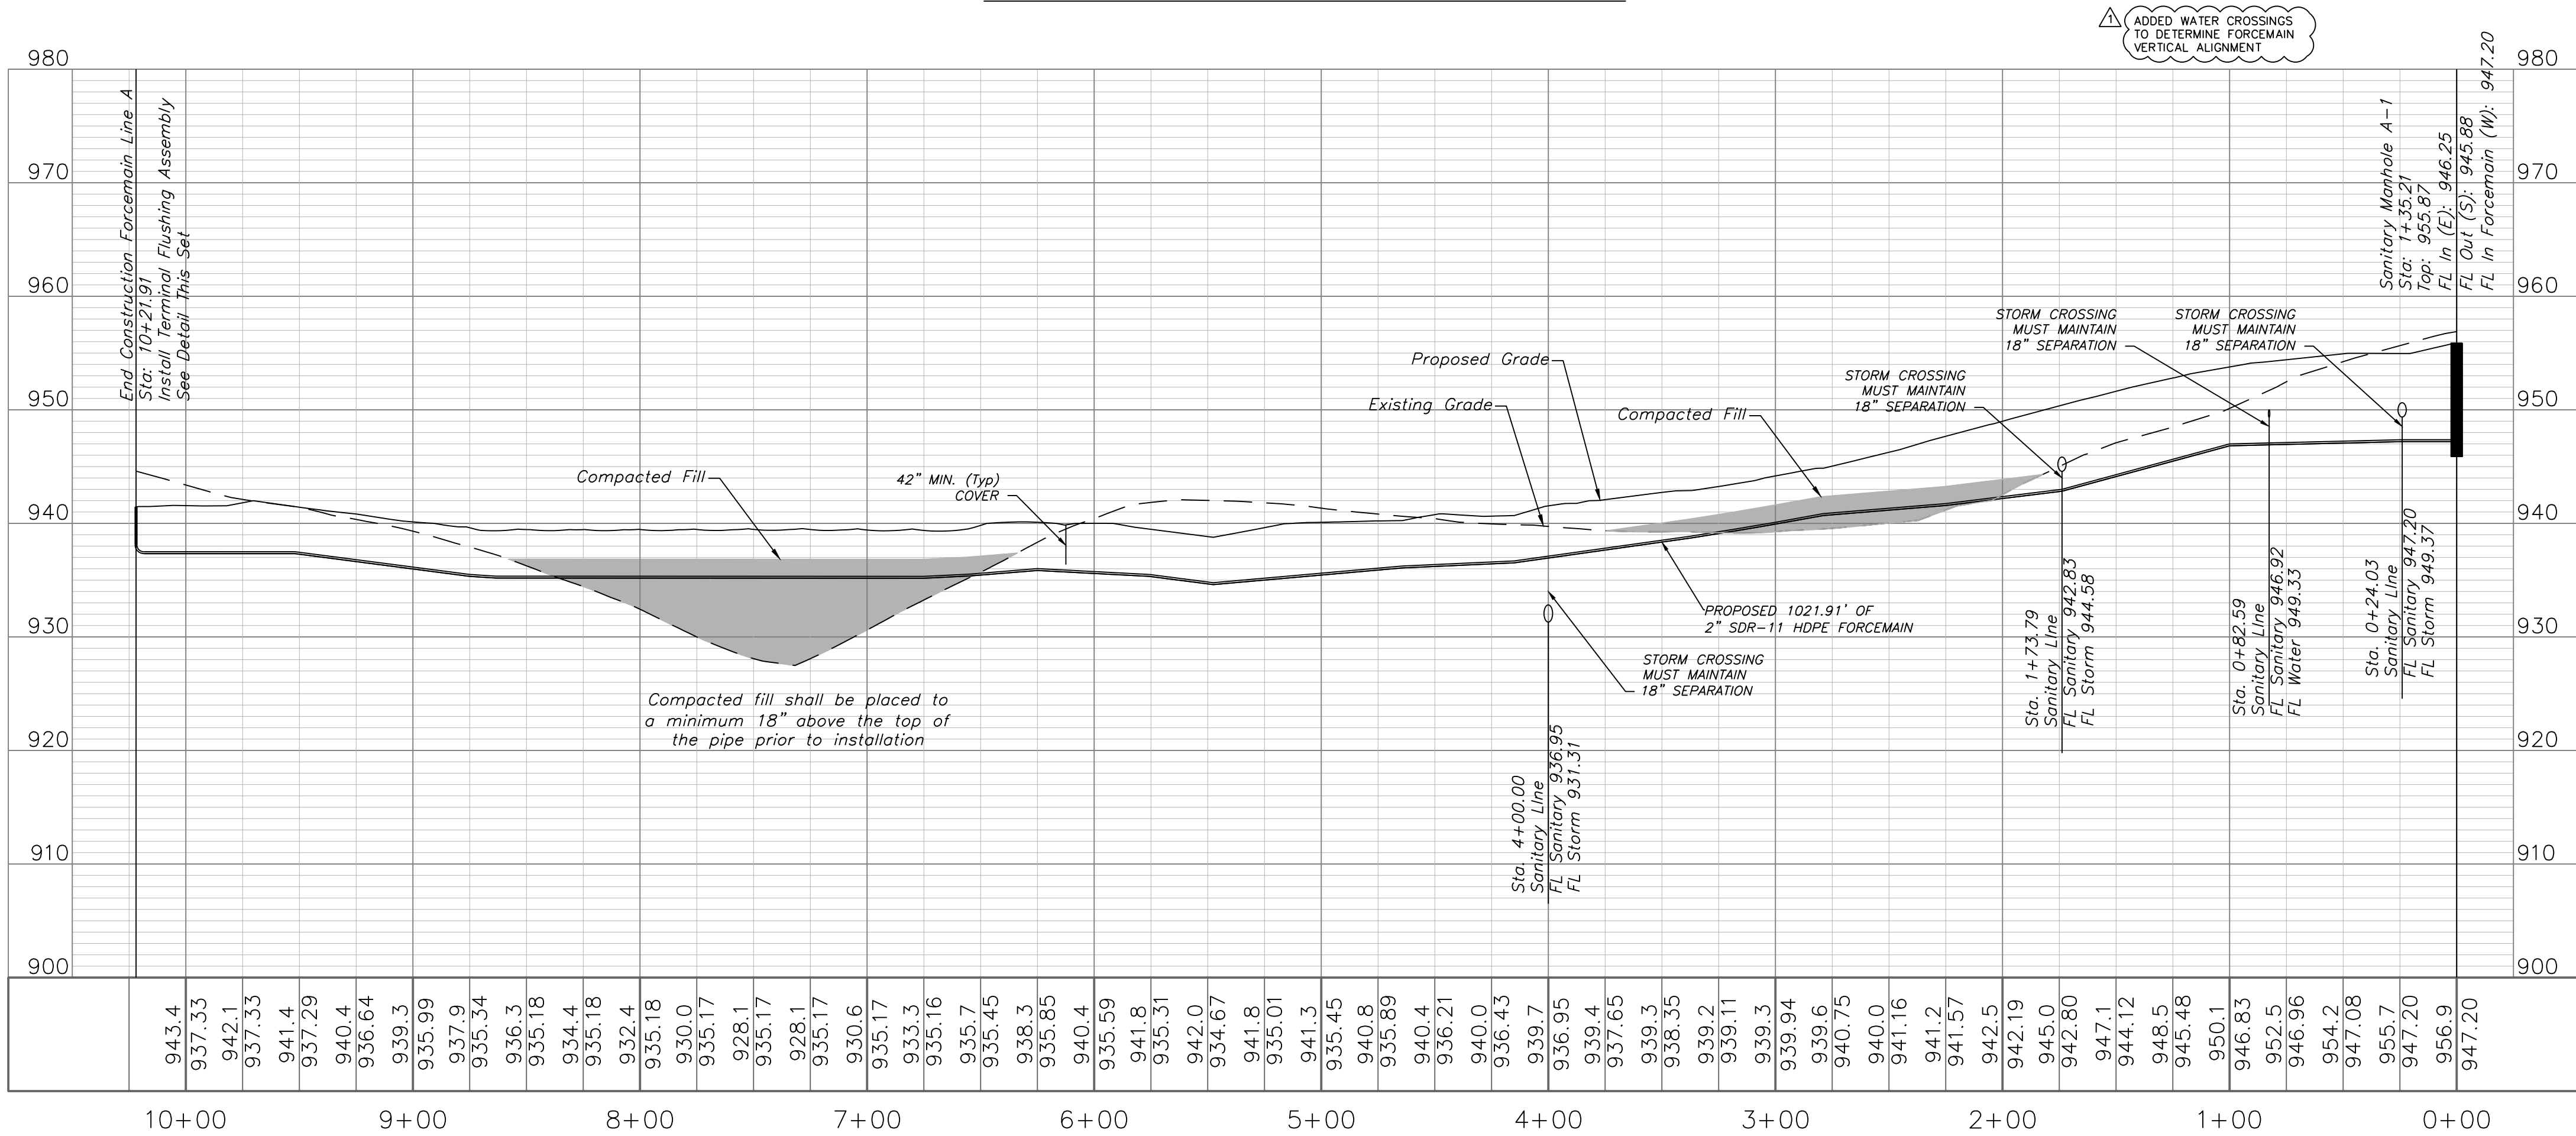


ENGINEERING SOLUTIONS
ENGINEERING & SURVEYING
50 SE 30TH STREET
LEE'S SUMMIT, MO 64082
P: (816) 623-9888 F: (816) 623-9849

Professional Registration
Missouri
Engineering 2005002186-D
Surveying 2005008319-D
Kansas
Engineering E-1695
Surveying LS-218
Oklahoma
Engineering 6254
Nebraska
Engineering CA2821

Part of the Southeast 1/4
Section 27, Township 48 North, Range 31 West
Lee's Summit, Jackson County, Missouri

Project:
WOODLAND OAKS
LSMO
Issue Date:
February 25, 2021

Sanitary Plan and Profile
Construction Plans for:
WOODLAND OAKS
Lots 1 thru 42
Lee's Summit, Jackson County, Missouri

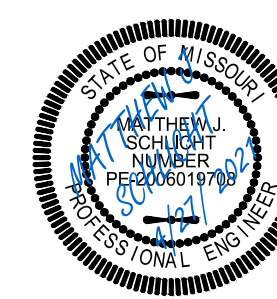



Matthew J. Schlicht
MO PE 2006019708
KS PE 19071
OK PE 25226
NE PE E-14335

REVISIONS
REV. 4/27/2021


GENERAL NOTE:
1 - ALL CONSTRUCTION SHALL CONFORM TO THE CITY OF LEE'S SUMMIT DESIGN AND CONSTRUCTION MANUAL AS ADOPTED BY ORDINANCE 5813.
2 - TRENCH CHECKS SHALL BE INSTALL AT ALL SANITARY WYES LOCATION.
3 - COMPACTED FILL SHALL BE PLACED TO A MINIMUM 18" ABOVE THE TOP OF THE PIPE PRIOR TO INSTALLATION.

ADDED NOTE 3

NOTE:
LOTS 35 THRU 41 WILL BE FORCEMAIN
AND REQUIRE GRINDER PUMPS.

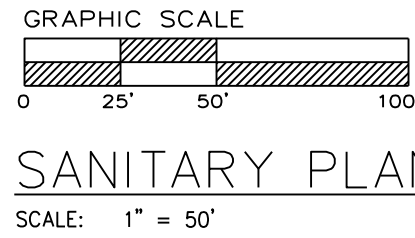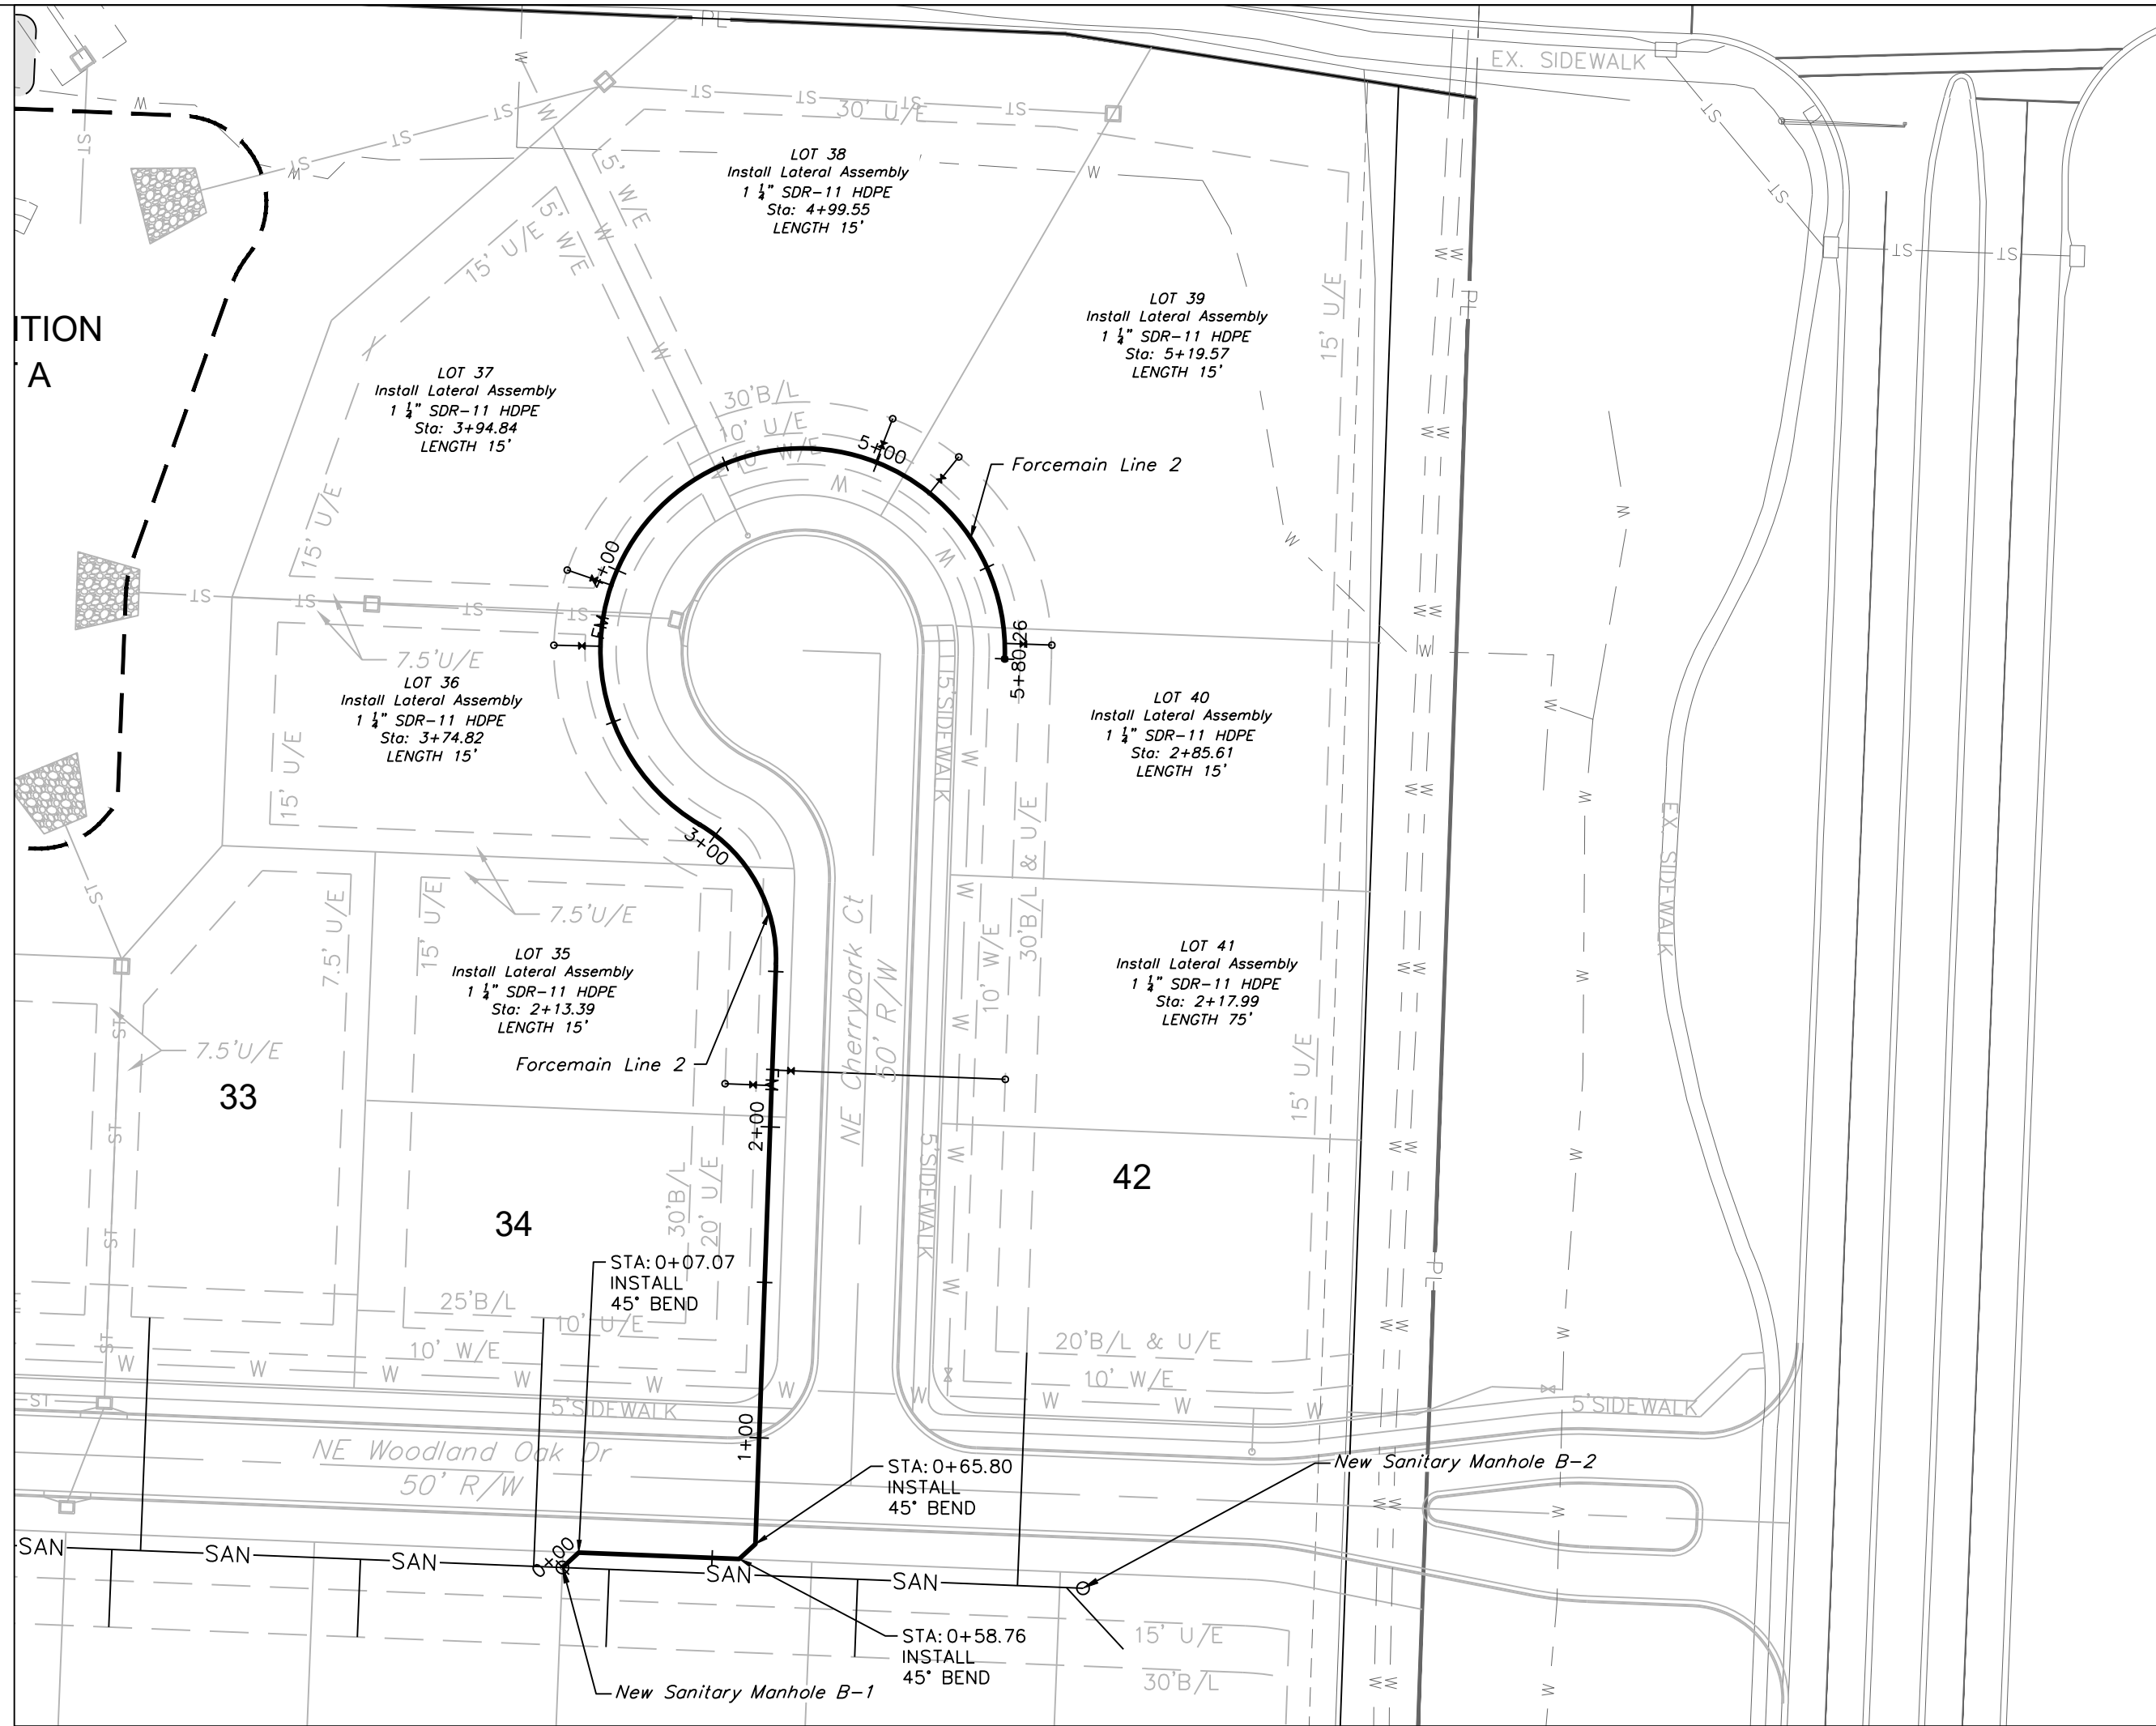

SANITARY PLAN & PROFILE

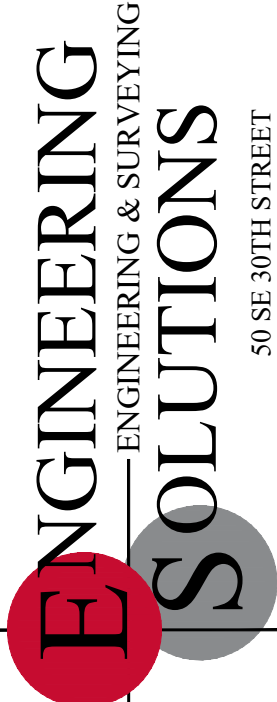


Professional Registration
Missouri
Engineering 2005002186-D
Surveying 2005008319-D
Kansas
Engineering E-1685
Surveying LS-218
Oklahoma
Engineering 6254
Nebraska
Engineering CA2821

Part of the Southeast 1
Section 27, Township 48 North, Range 31 West
Lee's Summit, Jackson County, Missouri

Project:
WOODLAND OAKS
LSMO
Issue Date:
February 25, 2021

Sanitary Plan and Profile
Construction Plans for:
WOODLAND OAKS
Lots 1 thru 42
Lee's Summit, Jackson County, Missouri

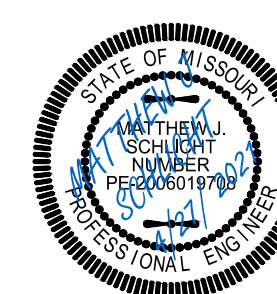

Matthew J. Schlicht
MO PE 0006019708
KS PE 19071
OK PE 25226
NE PE E-14335

REVISIONS
REV. 4/27/2021


 

C. 404







REVISED FORCEMAIN INV.
ELEV.

FORCEMAIN LINE 2


ADDED WATER CROSSINGS
TO CONFORM FORCEMAIN
VERTICAL ALIGNMENT

RAISED FORCEMAIN AND
LOWERED STORM

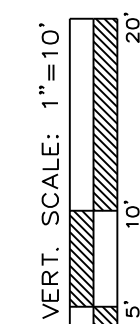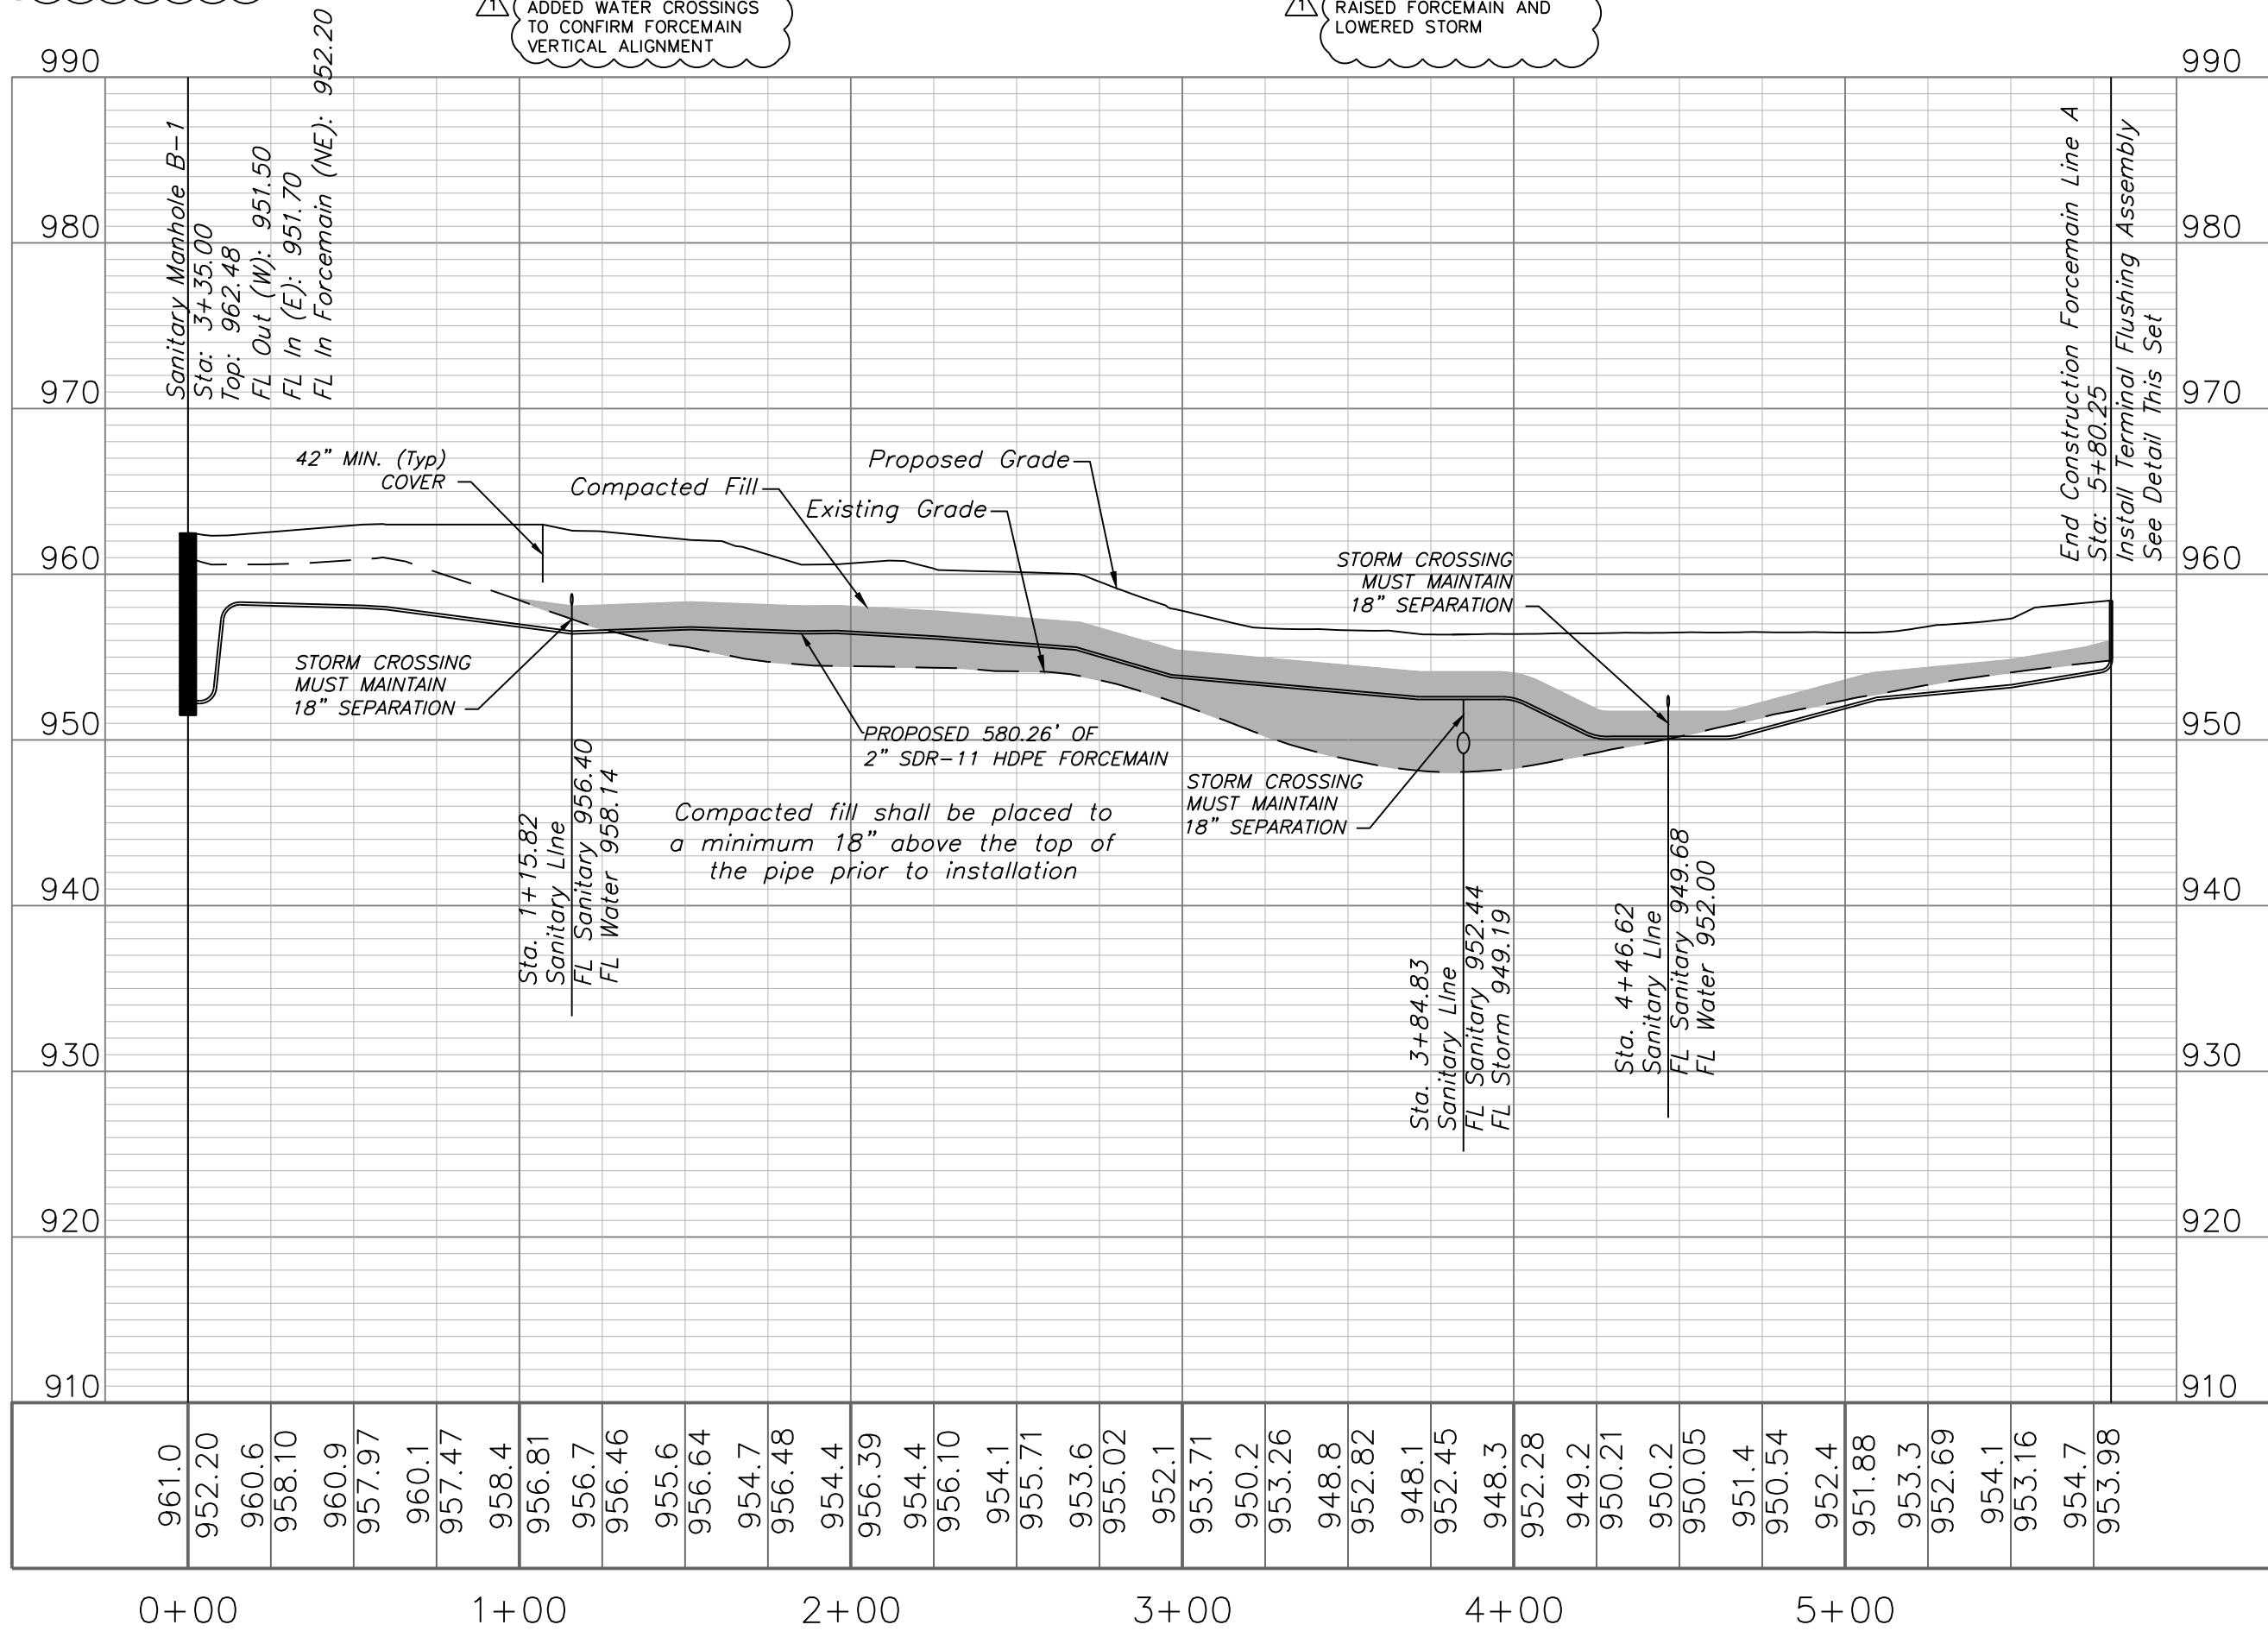


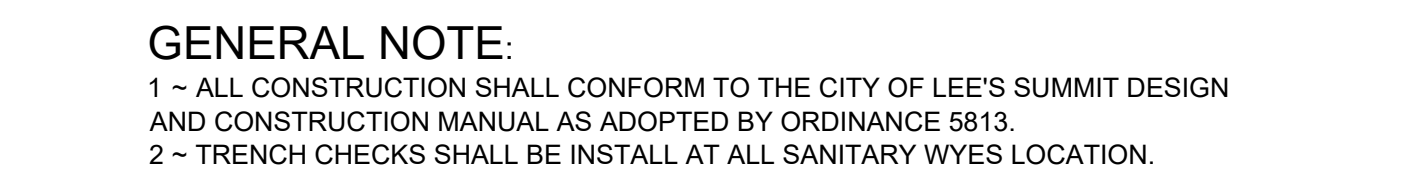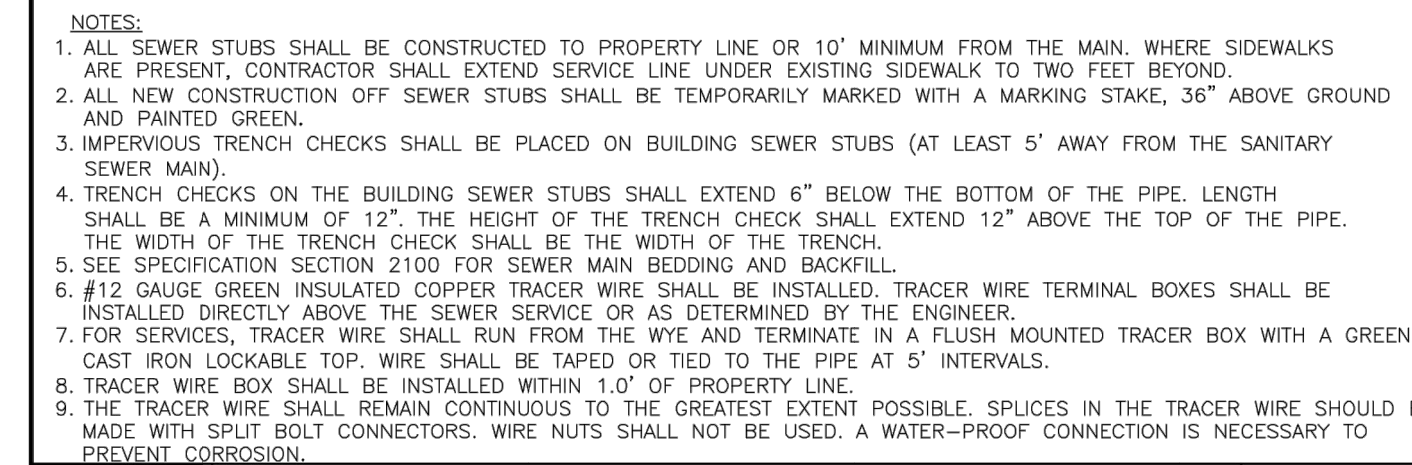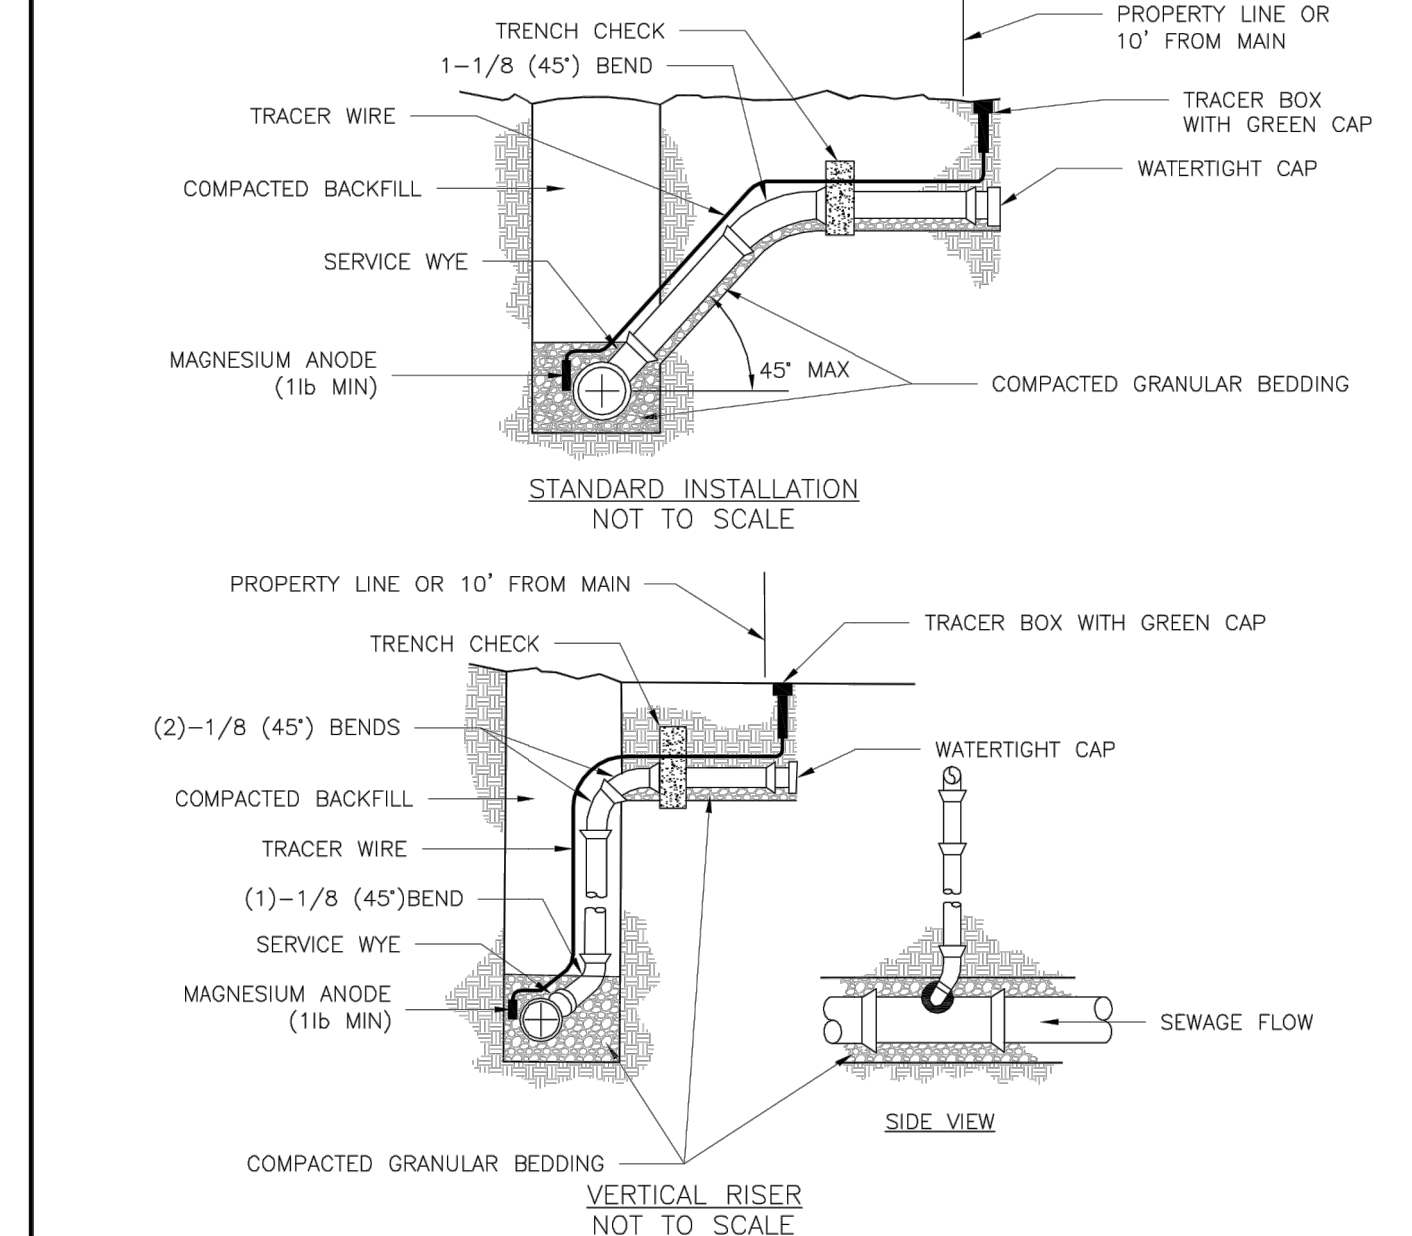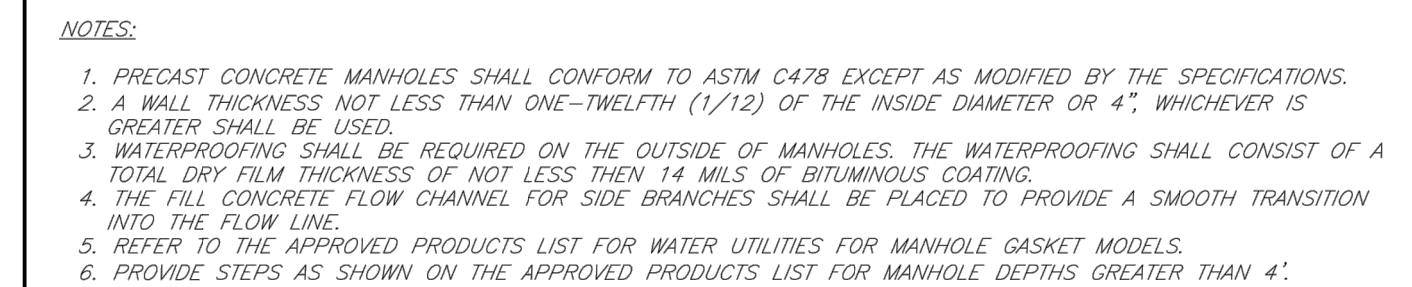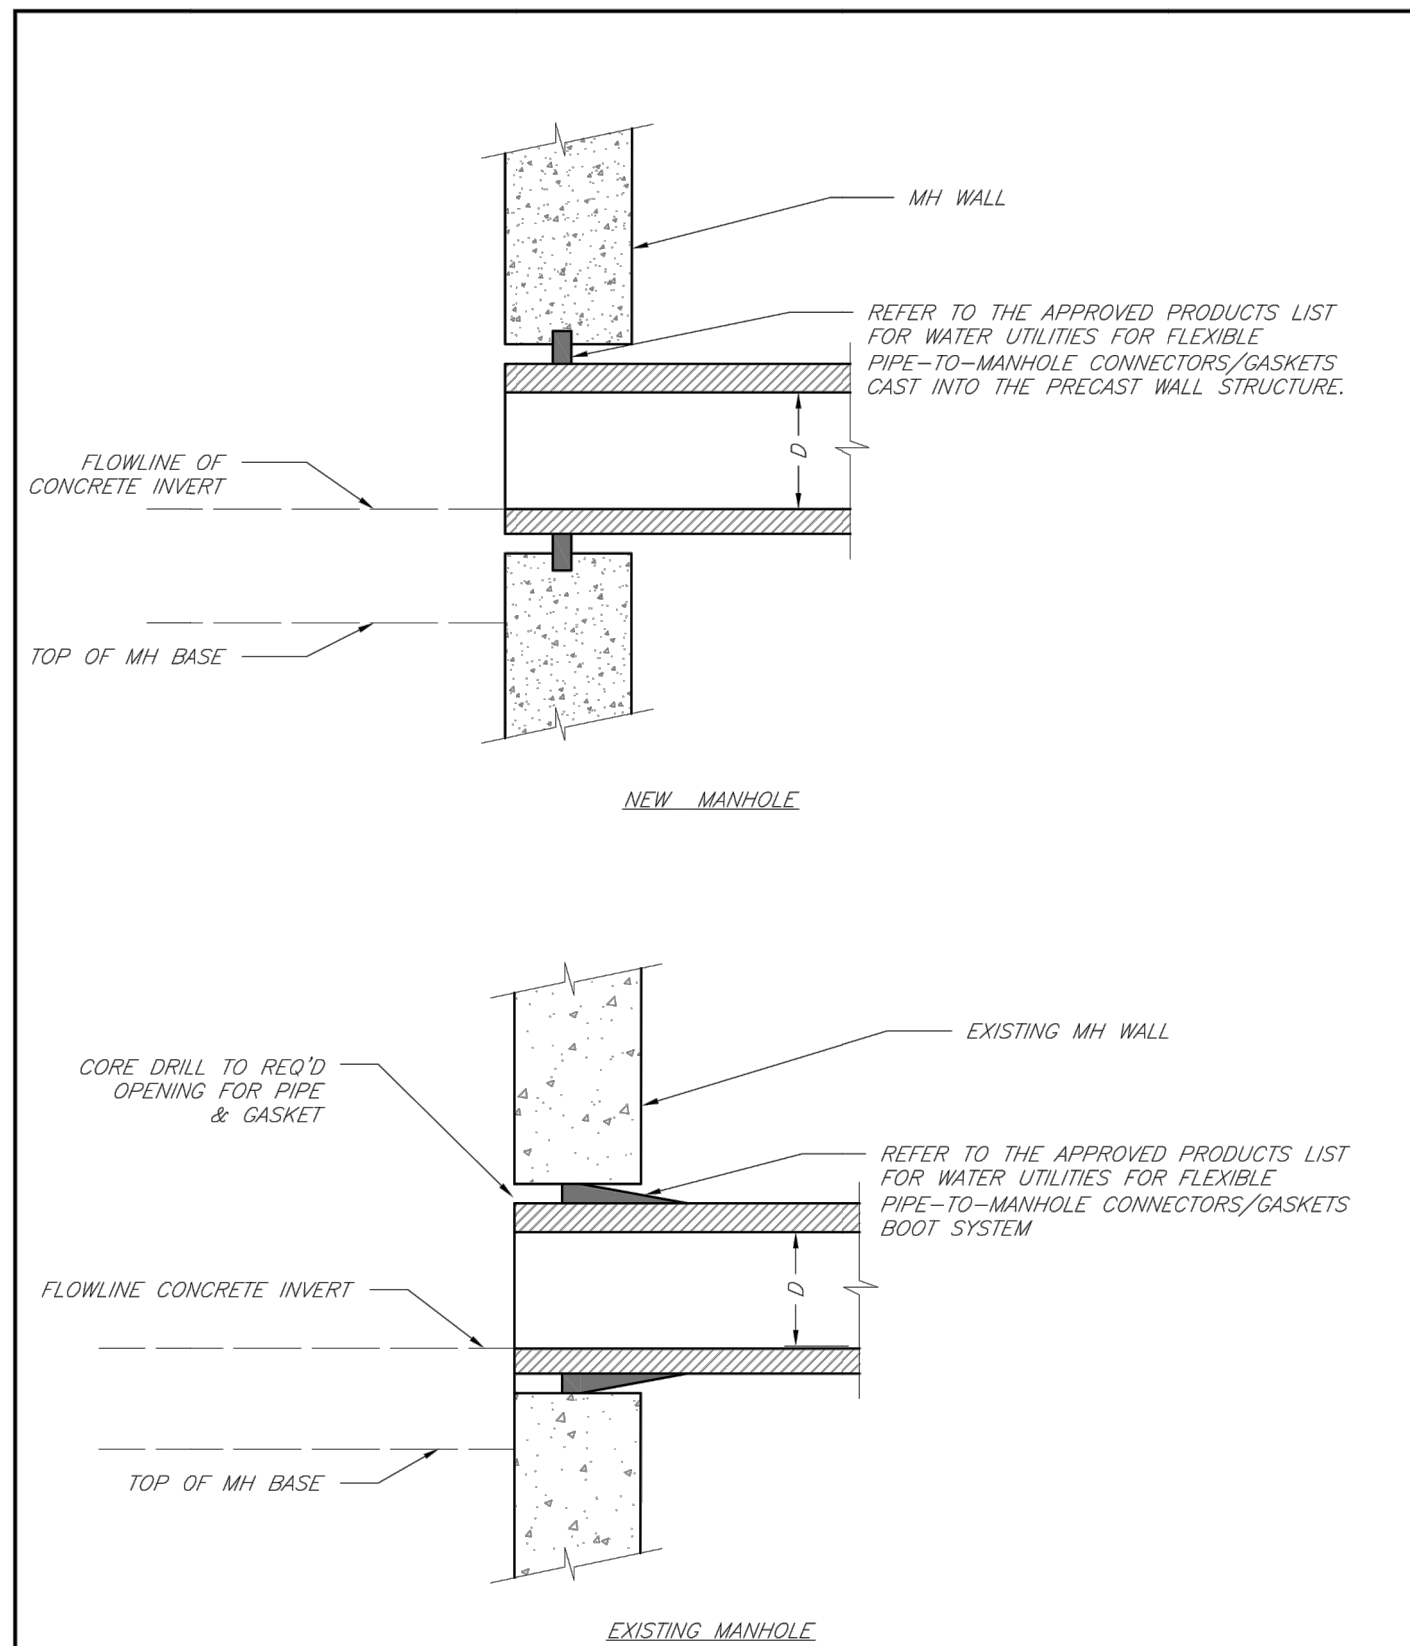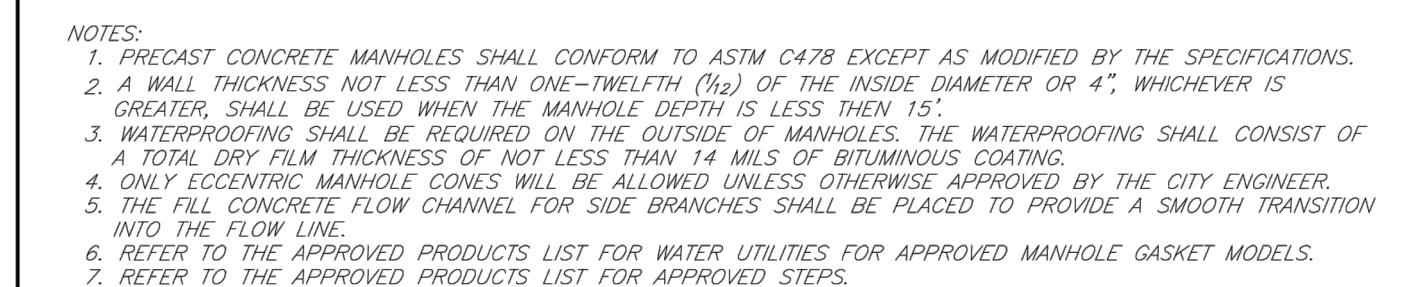

GENERAL NOTE:
1 ~ ALL CONSTRUCTION SHALL CONFORM TO THE CITY OF LEE'S SUMMIT DESIGN AND CONSTRUCTION MANUAL AS ADOPTED BY ORDINANCE 5813.
2 ~ TRENCH CHECKS SHALL BE INSTALL AT ALL SANITARY WYES LOCATION.

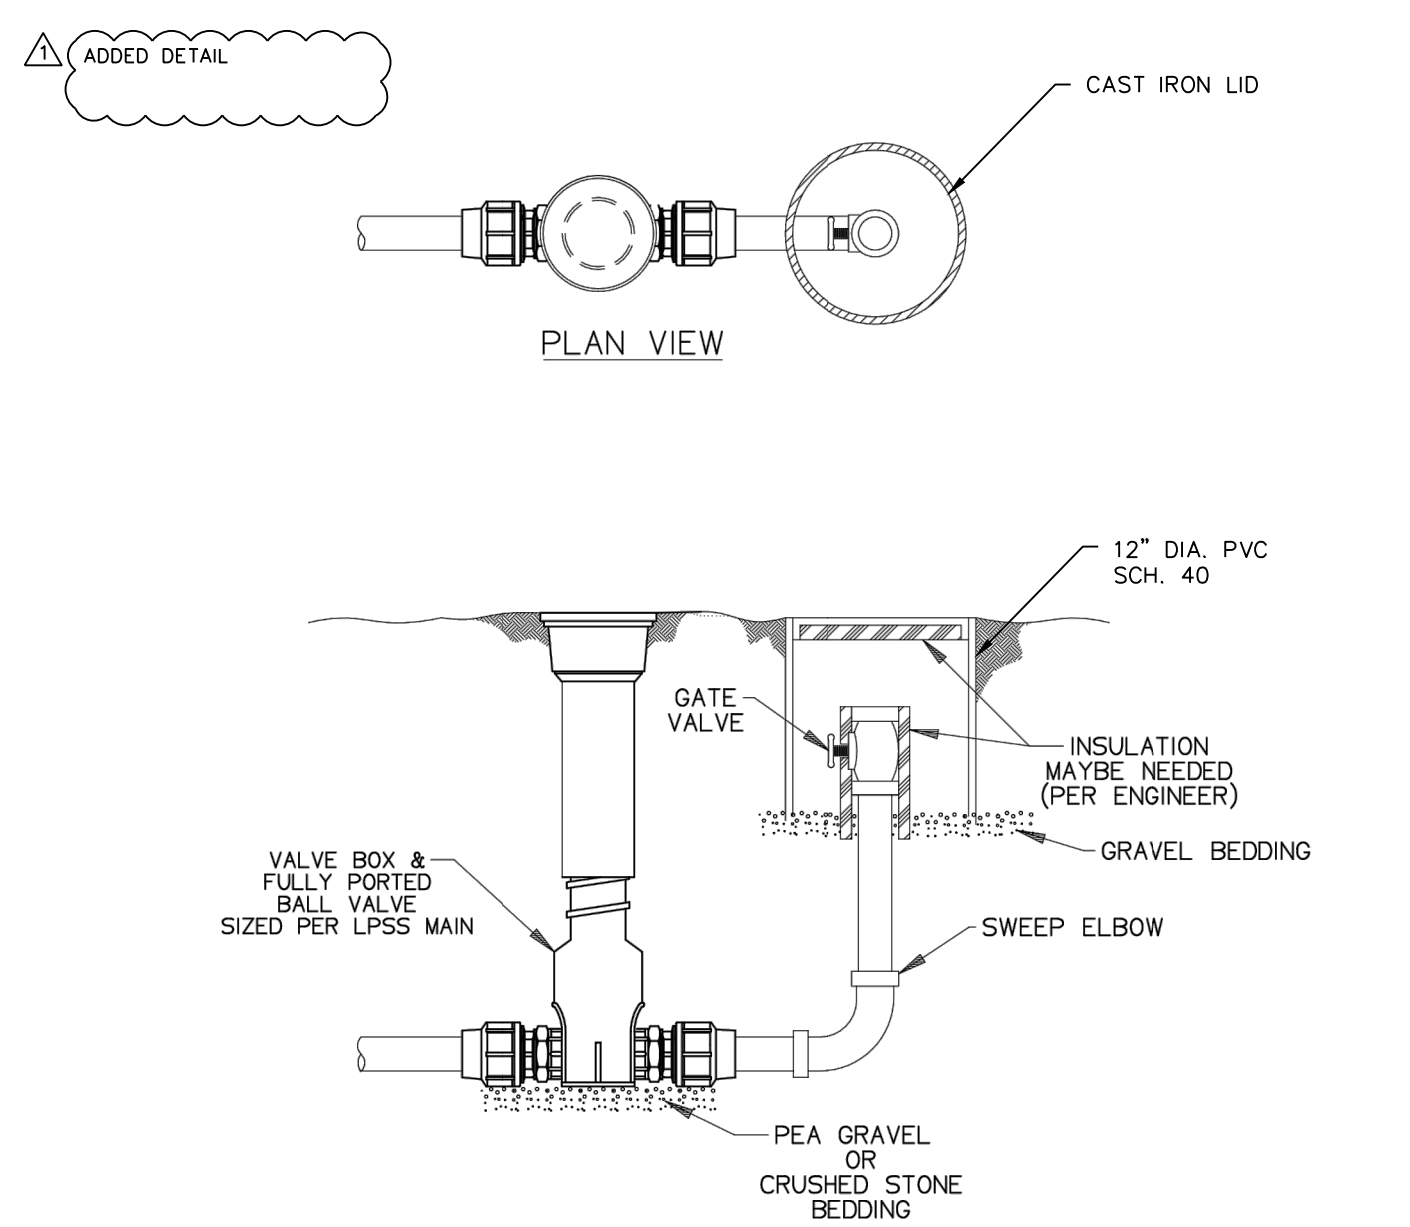

SGS		05-13-10	1	1/32
DR BY	CHK'D	DATE	ISSUE	SCALE
				
TYPICAL TERMINAL FLUSHING CONNECTION				
ESD 10-0094				

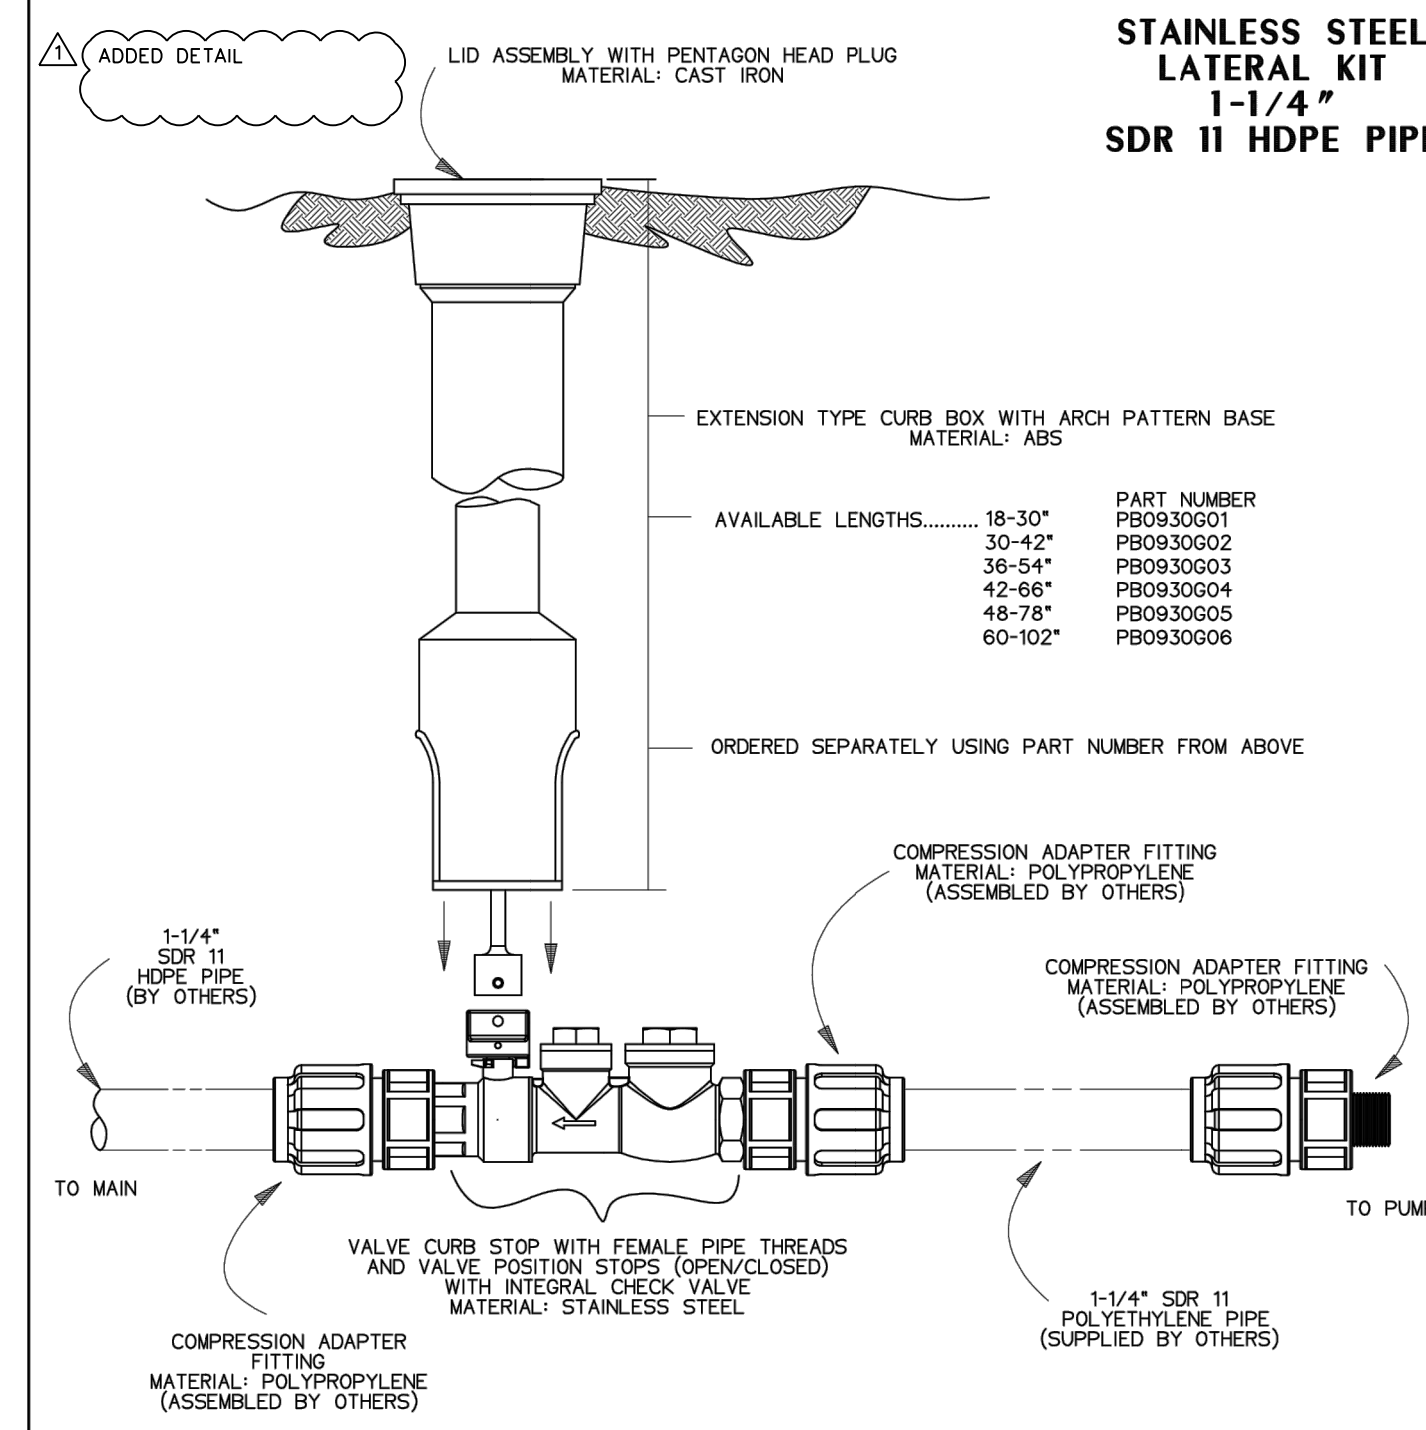

NOTES:

1. SS CURB STOP/CHECK VALVE AND FITTINGS ARE PROVIDED SEPARATELY, TO BE ASSEMBLED BY OTHERS
2. TO ASSEMBLE, APPLY A DOUBLE LAYER OF TEFLON TAPE, AND A LAYER OF PIPE DOPE (SUPPLIED BY OTHERS) TO THE THREADED PORTS OF THE FITTINGS AND INSTALL PER THE MANUFACTURER'S INSTRUCTIONS
*FOR SS FITTING INTO SS THREAD, USE PIPE DOPE OR TEFLON TAPE, NOT BOTH
3. ASSEMBLY IS TO BE PRESSURE TESTED (BY OTHERS)
4. ASSEMBLY IS TO BE USED WITH SDR11 HDPE PIPE
5. TO ORDER SS LATERAL KIT, USE PART NUMBER NCO193001
6. CURB BOX IS TO BE ORDERED SEPARATELY, SEE ABOVE

KIT PARTS ARE NOT ASSEMBLED

SGS	DN	11/02/11	B	3/16
DR BY	CHK'D	DATE	ISSUE	SCALE
				
STAINLESS STEEL LATERAL KIT 1-1/4" SDR 11 HDPE PIPE				
NA0330P02				


Professional Registration
Missouri
Engineering 2005002186-D
Surveying 2005008319-D
Kansas
Engineering E-1695
Surveying LS-218
Oklahoma
Engineering 6254
Nebraska
Engineering CA2821

Part of the Southeast $\frac{1}{4}$
 Section 27, Township 48 North, Range 31 West
 Lee's Summit, Jackson County, Missouri

Project: WOODLAND OAKS
LSMO
Issue Date: February 25, 2021

Sanitary Details

Construction Plans for:
WOODLAND OAKS
Lots 1 thru 42

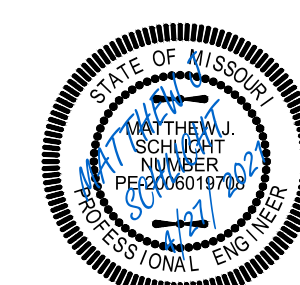

Matthew J. Schlich
MO PE 200601970
KS PE 19071
OK PE 25226
NE PE E-14335

REVISIONS

1 REV. 4/27/202
