


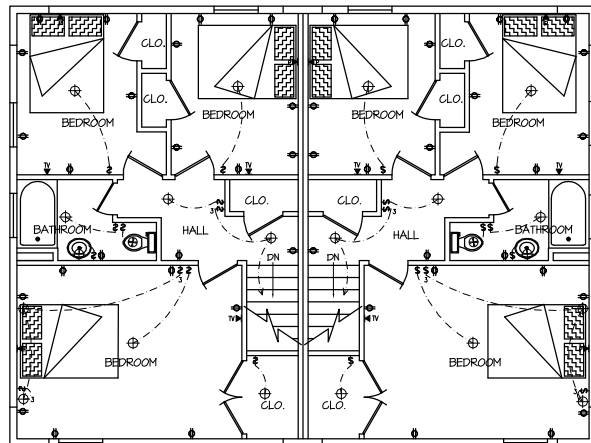


Upper Floor Electrical Plan

Scale: 1/4" = 1'- 0"




FIXTURE LEGEND:

- CAN LIGHT (75 WATT)
- ⊕ LIGHT FIXTURE
- Ⓢ LIGHT SWITCH
- Ⓜ WALL MOUNTED DUPLEX RECEPTICAL
- ⓂGFI WALL MOUNTED DUPLEX RECEPTICAL GROUND FAULT INTERRUPTED
- Ⓜ 220V RECEPTICAL
- Ⓜ EXHAUST FAN
- ⓂP TELEPHONE JACK - CAT 5
- ⓂTV RG-6 CABLE TV

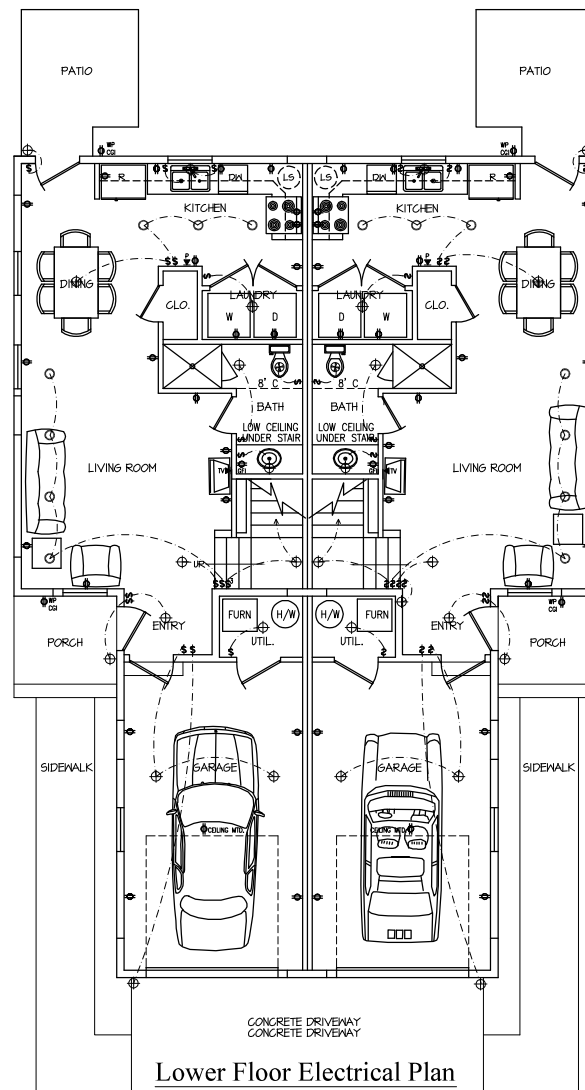

Lower Floor Electrical Plan

 Scale: 1/4" = 1'- 0"



DRAWN BY: MM
CHECKED BY: JG
DATE ISSUED: 7/11/17
DWG. NAME: 401HL-AS


REVISIONS:

- △
- △
- △
- △

New Duplex Construction

THE GAMBLE CO., INC.
Mo. License Identification Number A-3986

1009 North Cottage, Suite 200
Independence, Missouri 64050
Phone: (816) 252-7100
Fax: (816) 254-3468

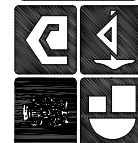

Job No:

SHEET No.

A-9