


Luminaire Schedule			
Symbol	Label	Qty	Label
	L1	2	ASW2_250S_SR4W_HS
	L2	1	ASW2_250M_SR3_HS

MH = MOUNTING HEIGHT. SEE PLAN.

Calculation Summary						
Label	Units	Avg	Max	Min	Max/Min	
Parking_Lot_1	Fc	3.04	9.8	0.4	24.50	
Property_Line	Fc	0.10	0.1	0.0	N.A.	

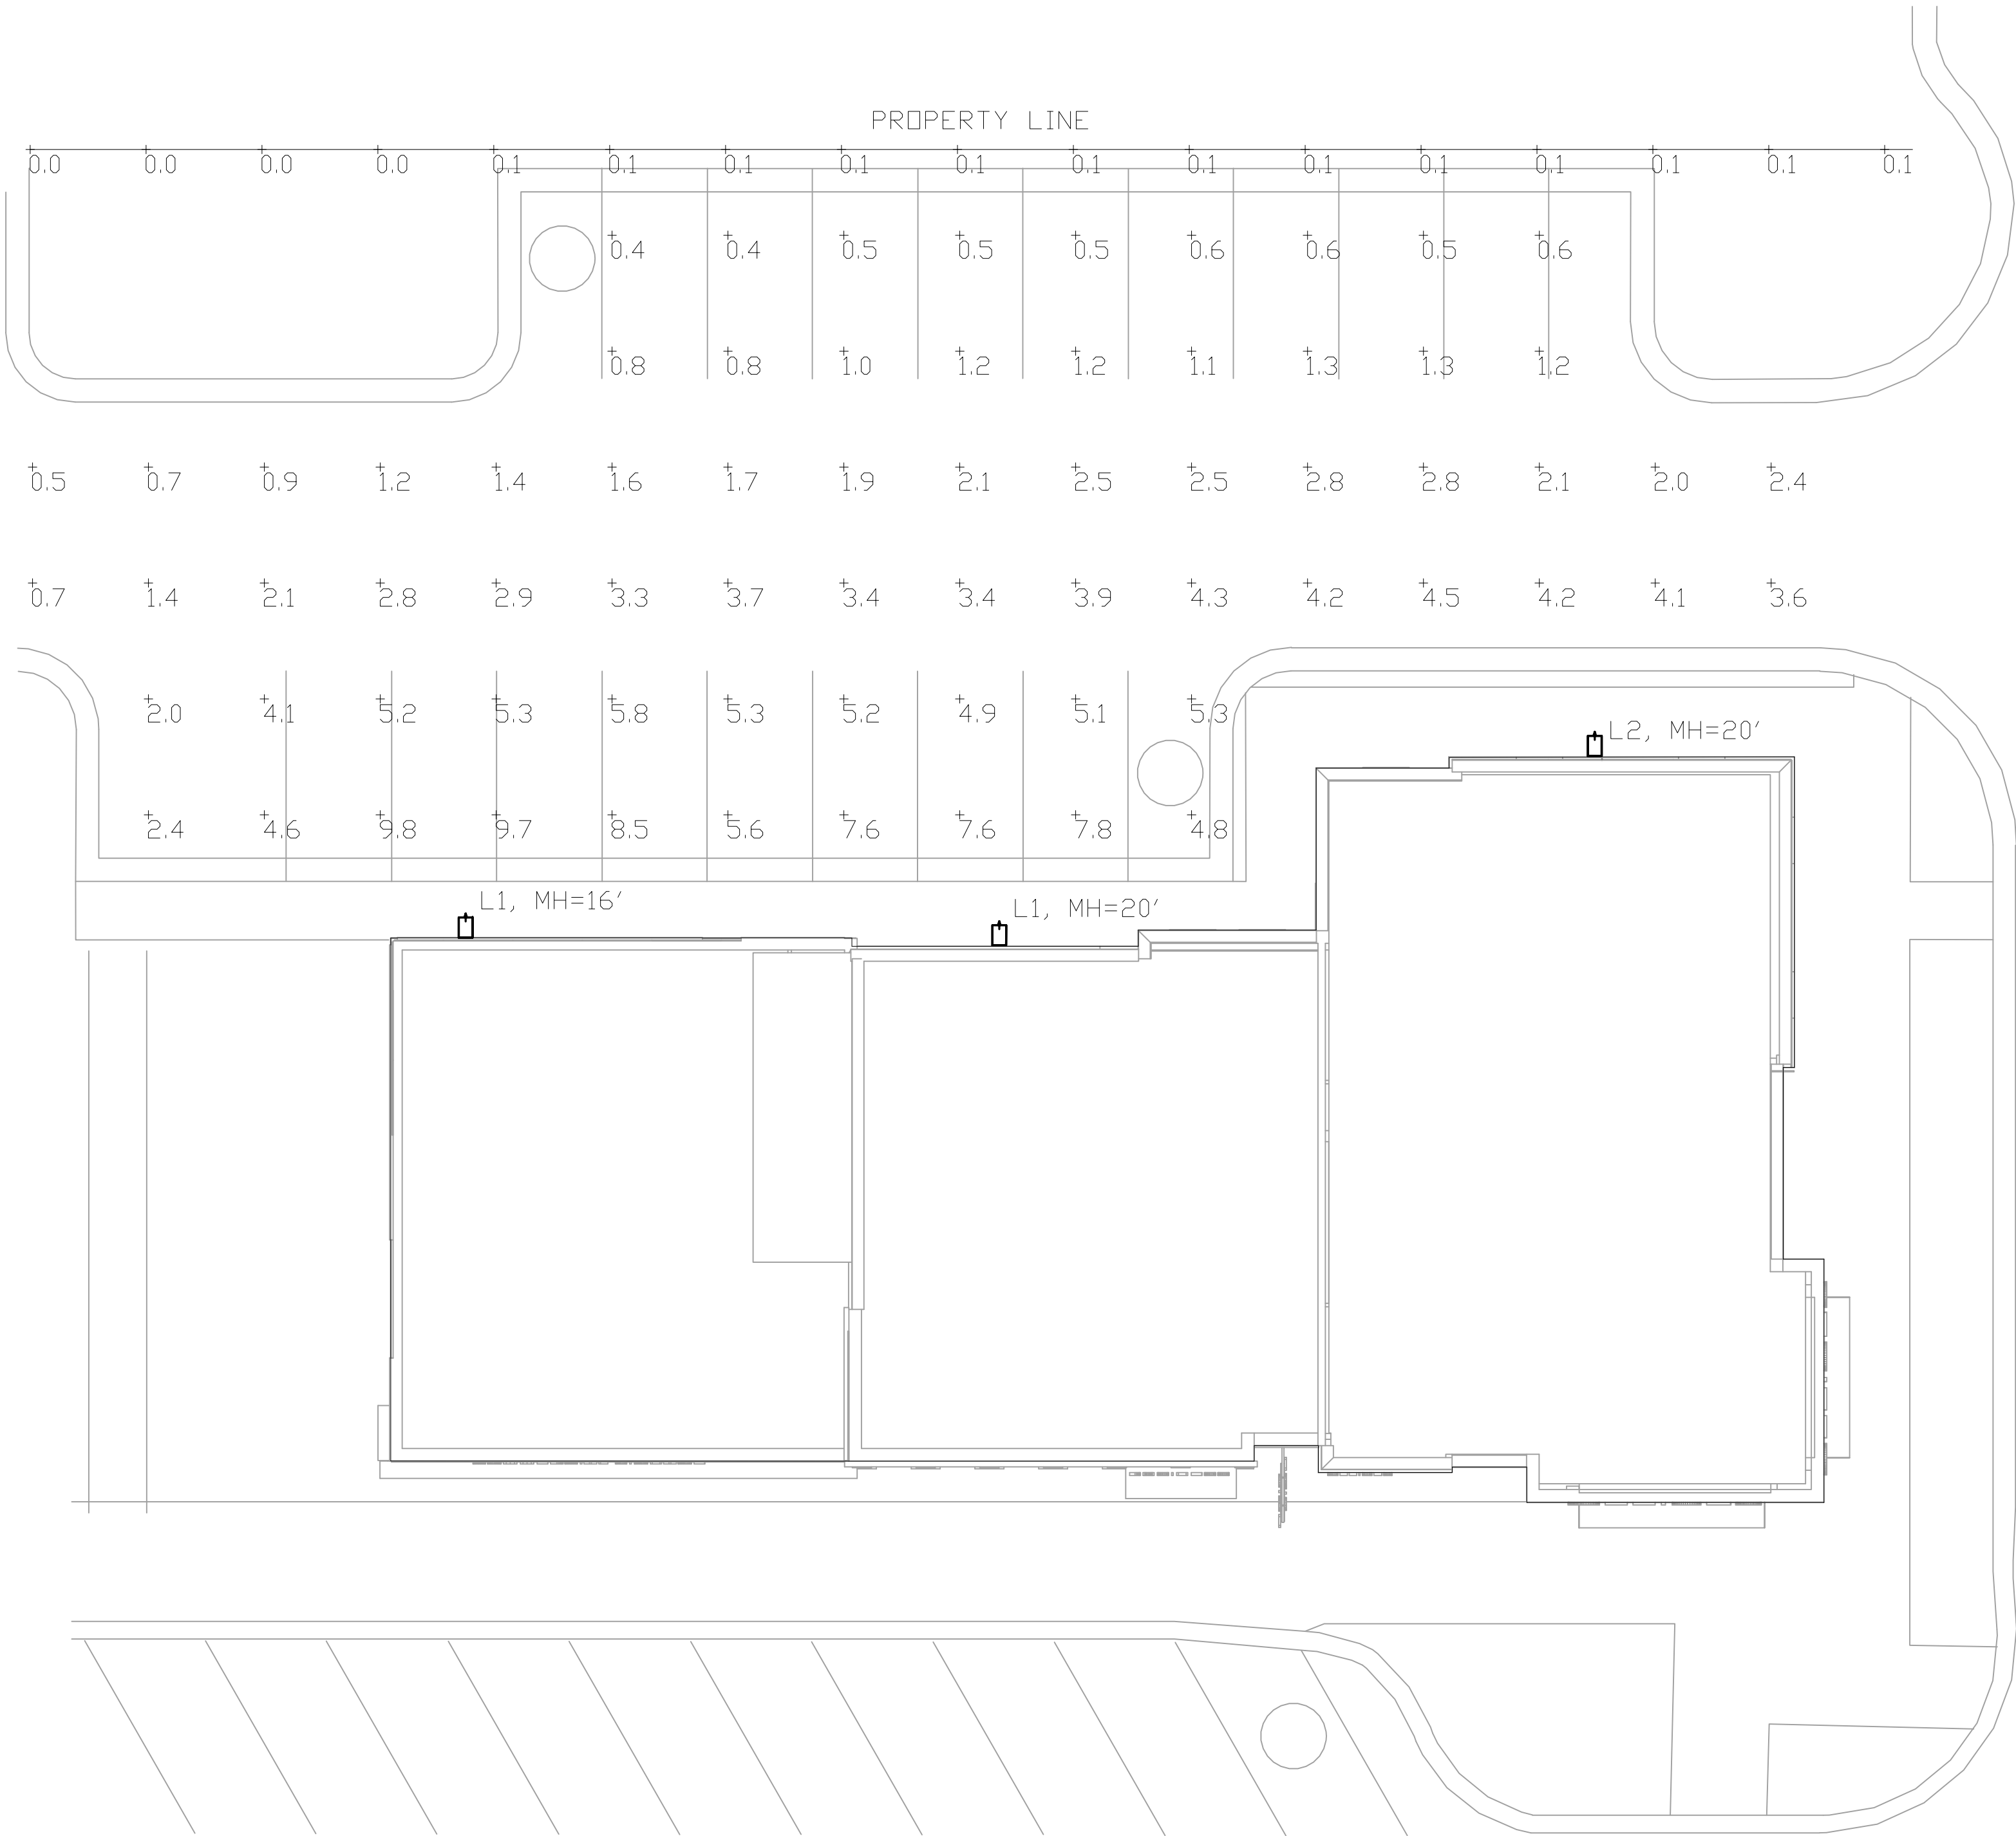

SITE LIGHTING PLAN

SCALE : 3/32" = 1'-0"

1





ASW1 LED
LED Wall Luminaire

Specifications

Width: 15" (381mm)
Depth: 13.314" (338mm)
Height: 9.114" (231mm)
Weight (max): 54 lbs (24.5kg)

Introduction

The *Aeris* family combines sleek, fluid forms and crisp edges into a striking architectural aesthetic that can be echoed throughout entire sites.

The ASW1 LED integrates the latest LED technology with the designer aesthetic of the *Aeris* family for stylish, high-performance illumination that lasts. The ASW1 LED is ideal for replacing 100-300W metal halide in area lighting applications with typical energy savings of 65% and expected service life of over 100,000 hours.

Ordering Information		EXAMPLE: ASW1 LED 42C 700 40K 584 MVOLT DOBTXD	
ASW1 LED	42C 700 40K 584 MVOLT DOBTXD	ASW1 LED	42C 700 40K 584 MVOLT DOBTXD

Control System	Option System	Details
Shipped installed PE Photocell w/1 button opt. BL30 In-hand-mounted dimming 0-10V BL30 In-hand-mounted dimming 0-10V PMS002 For right, dim 1 lux PMS002 For right, dim 1 lux PMS002 For right, dim 1 lux	Shipped installed SP Single bar (12, 27, 32, 37, 9342,	