


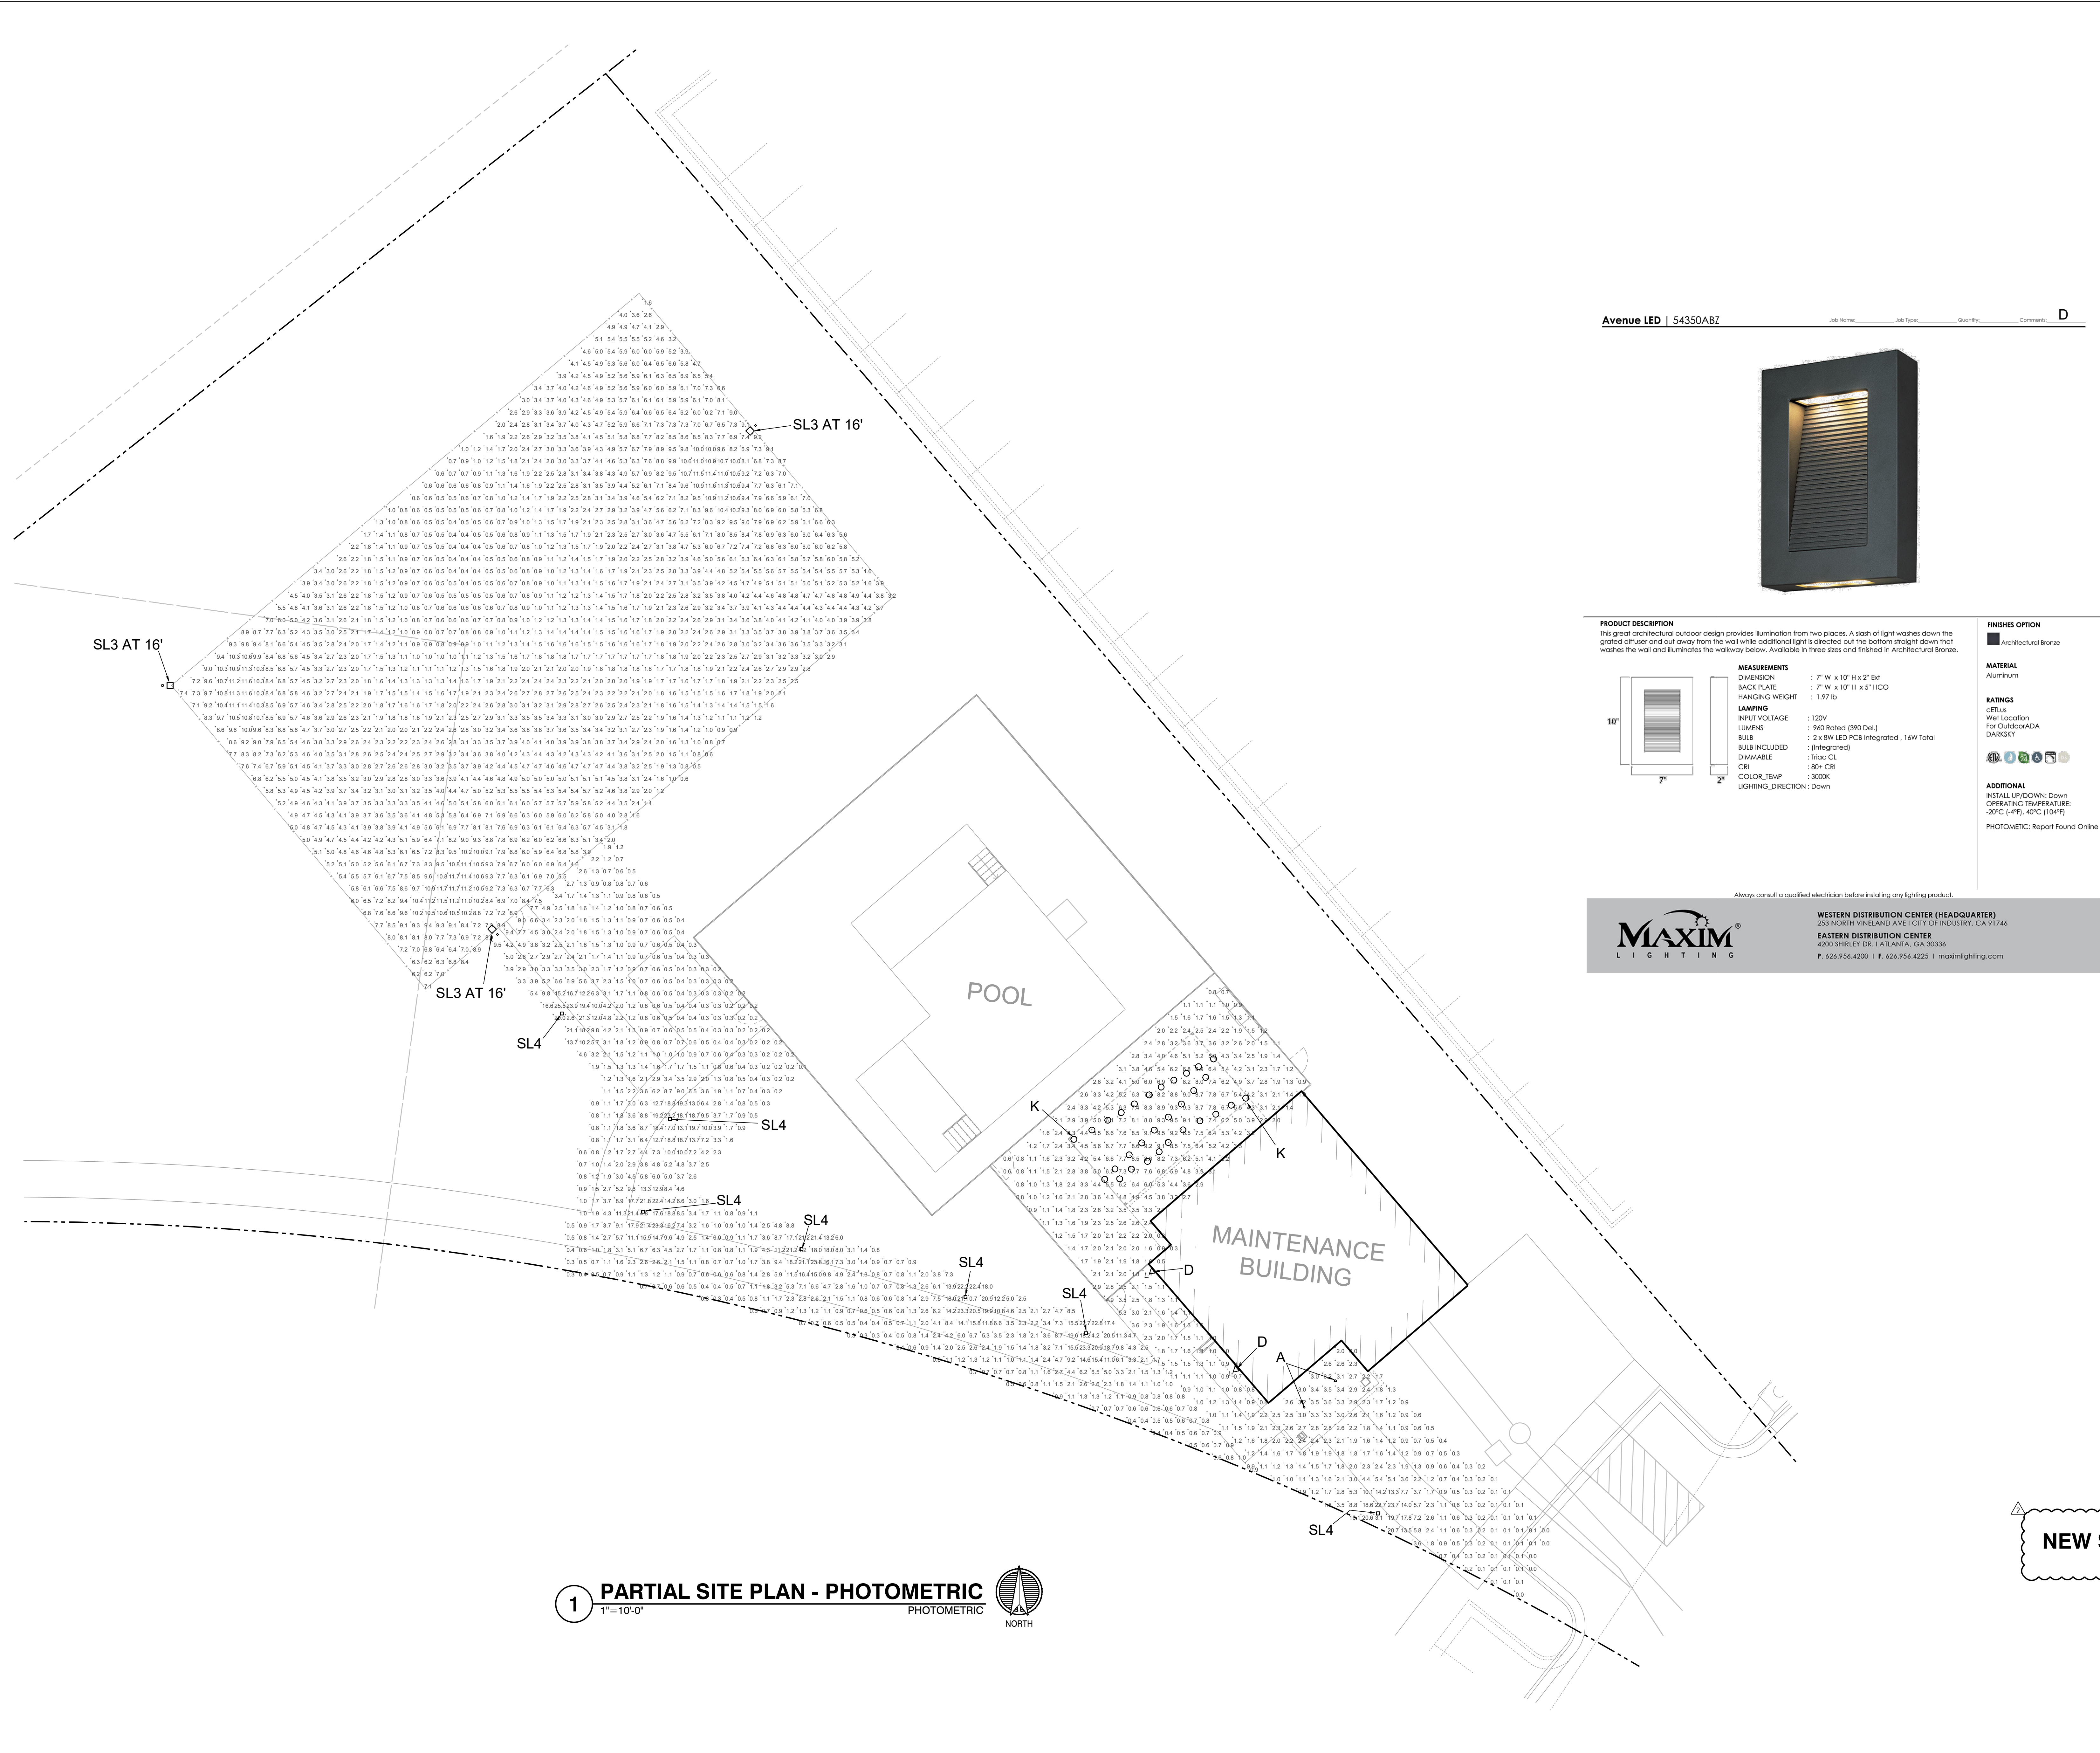

Avenue LED | 54350ABZ

Job Name: Job Type: Quantity: Comments: **D**



PRODUCT DESCRIPTION
This great architectural outdoor design provides illumination from two places. A slash of light washes down the grated diffuser and out away from the wall while additional light is directed out the bottom straight down that washes the wall and illuminates the walkway below. Available in three sizes and finished in Architectural Bronze.

MEASUREMENTS
DIMENSION : 7" W x 10" H x 2" Bd
BACK PLATE : 7" W x 10" H x 5" HCO
HANGING WEIGHT : 1.97 lb

LAMPING
INPUT VOLTAGE : 120V
LUMENS : 960 Rated (390 Del.)
BULB : 2 x 8W LED PCB Integrated , 16W Total
BULB INCLUDED : (Integrated)
DIMMABLE : 100% CL
CRI : 80+ CRI
COLOR TEMP : 3000K
LIGHTING DIRECTION : Down

FINISHES OPTION
Architectural Bronze

MATERIAL
Aluminum

RATINGS
cETLUS
Wall Location
For Outdoor/ADA
DARKSKY

ADDITIONAL
INSTALL UP/DOWN: Down
OPERATING TEMPERATURE:
-20°C (-4°F) - 40°C (104°F)
PHOTOMETRIC: Report Found Online

Always consult a qualified electrician before installing any lighting product.


MAXIM LIGHTING

WESTERN DISTRIBUTION CENTER (HEADQUARTER)
235 NORTH VINLAND AVE. CITY OF INDUSTRY, CA 91746

EASTERN DISTRIBUTION CENTER
4200 SHIRLEY DR. ATLANTA, GA 30336
P. 626.956.4200 | F. 626.956.4225 | maximlighting.com

NEW SHEET

PARTIAL SITE PLAN - PHOTOMETRIC
1"=10'-0"

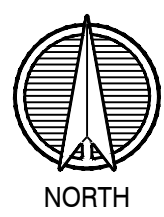

LS&A
Latter Somers & Associates, P.A.
CONSULTING ENGINEERS
3639 SW Summerfield Drive, Suite A
Topeka, Kansas 66614-3974
Telephone: (785) 233-3332
Fax: (785) 233-0647
Email: lepp@lsand.com
LSA PROJECT NO. 2104008

STATE OF MISSOURI
REINHOLD R. BLANKENHORN
PROFESSIONAL ENGINEER
9-28-21

ARCHITECT
STRUCTURAL ENGINEER
CIVIL ENGINEER
GENERAL CONTRACTOR
MECHANICAL ENGINEER
PLUMBING ENGINEER
ELECTRICAL ENGINEER

TRI ARCHITECTS
STRUCTURAL
CIVIL
GENERAL CONTRACTOR
ENGINEER
PLUMBING
ELECTRICAL

Together Development

The Signature at West Pryor
2100 NW LOWENSTEIN DR.
LEE'S SUMMIT, MISSOURI 64081

TRI ARCHITECTS
1790 S. Brentwood Blvd.
St. Louis, Missouri 63144
© Copyright 2021
T: 314-365-9750
www.triarchitects.com

DATE: 7.15.2021

REVISIONS
FDP COMMENTS 09-28-21

DWG BY CAD/RRB
TRi PROJECT NO. 20-001
SHEET NO. E001a
SITE PLAN - PHOTOMETRIC