



LEE'S SUMMIT MEDICAL CENTER

FINAL DEVELOPMENT PLAN

LEE'S SUMMIT MEDICAL CENTER ICU EXPANSION 2100 SE BLUE PARKWAY LEE'S SUMMIT, MISSOURI 64063

PROJECT TEAM

ARCHITECT ACI BOLAND, INC.

1710 WYANDOTTE STREET
KANSAS CITY, MO 64108
PHONE 816.763.9600
FAX 816.763.9757

MEP ENGINEER HENDERSON ENGINEERS, INC.

8345 LENEXA DRIVE, SUITE 300
LENEXA, KS 66214
PHONE 913.742.5000
FAX 913.742.5001

STRUCTURAL ENGINEER BOB D. CAMPBELL & COMPANY

4338 BELLEVIEW AVE
KANSAS CITY, MO 64111
PHONE 816.531.4144
JEFF WRIGHT
FAX 816.531.8572


OWNER / DEVELOPER HCA MIDWEST HEALTH

MIDWEST DIVISION - LSH, LLC
d/b/a LEE'S SUMMIT MEDICAL CENTER
2100 SE BLUE PARKWAY
LEE'S SUMMIT, MO 64063
PHONE 816.282.5018

ABBREVIATIONS

AC.	ACOUSTIC/ACOUSTICAL	FLOR.	FLUORESCENT	PTD.	PAINTED
ADD.	ADDENDUM	FTG.	FOOTING	PG.	PAGE
ADDN.	ADDITION	FND.	FOUNDATION	PLAM.	PLASTIC LAMINATE
ABC.	AGGREGATE BASE COURSE	FR.	FRAME	PR.	PAIR
AFF.	ABOVE FINISH FLOOR	F.H.C.	FIRE HOSE CAB.	PNL.	PANEL
AGG.	AGGREGATE	FV.	FIELD VERIFY	PTN.	PARTITION
ANC.	AIR CONDITIONING	GA.	GALVEANIZED STEEL	P.	PENNY
AL.	ALUMINUM	GL.	GLASS / GLAZING	PL.	PLATE
ALT.	ALTERNATE	GD.	GRADE	PLBG.	PLUMBING
A.B.	ANCHOR BOLT	GRD.	GRID	PLYWD.	PLYWOOD
&	AND	G.	GRILLE	GRAM.	GRAM
ARCH.	ARCHITECT	GRL.	GRILL	P.S.I.	POUNDS PER SQ. IN.
ASP.	ASPHALT	GRD.	GROUND	P.S.F.	POUNDS PER SQ. FT.
@	AT	GND.	GROUND	P.C.	PRECAST
ACT.	ACOUSTIC CEILING TILE/PANEL	GYP.	GYPSUM	P.L.	PROPERTY LINE
ANGLE	ANGLE	GWB/G.B.	GYPSUM BOARD		
BLKG.	BLOCKING	H.R.	HAND RAIL	R.	RISER, RISERS
BSMT.	BASEMENT	HDN.	HARDENER	RAD.	RADIUS
BM.	BEAM	HDW.	HARDWARE	R.D.	ROOF DRAIN
B.M.	BENCHMARK	HDWD.	HARDWOOD	RB.	RESILIENT BASE
BOARD	BOARD	HTR.	HEATER	RE.	REFER TO
B.O.	BOTTOM OF	HT.	HEIGHT	REG.	REGISTER
BLDG.	BUILDING	H.P.	HIGH POINT	REQD.	REQUIRED
CABT.	CABINET	H.M.	HOLLOW METAL	REV.	REVISION
C.I.P.	CAST IN PLACE	HORIZ.	HORIZONTAL	RFG.	ROOFING
C.B.	CATCH BASIN	H.B.	HOSE BIB	RGL.	ROUGH
CEILING	CEILING	H.W.	HOT WATER	RM.	ROOM
CEM.	CEMENT/CEMENTITIOUS	IN.	INCH / INCHES	RND.	ROUND
CG.	CENTIGRAM	INSUL.	INSULATION	R.O.	ROUGH OPENING
CM.	CENTIMETER	INT.	INTERIOR	SCHED.	SCHEDULE
CL.	CENTER LINE	INV.	INVERT	S.C.	SEALED CONCRETE
CER.	CERAMIC			SCR.	SCREW
C.T.	CERAMIC TILE			SECT.	SECTION
CHAN.	CHANNEL	JAN.	JANITOR	SEL.	SELECT
C.	CHANNEL	JT.	JOINT	SHG.	SHEATHING
CLR.	CLEAR	JST.	JOIST	SHT.	SHEET
C.O.	CLEAN OUT	K.P.	KICK PLATE	SDG.	SIDING
CLOS.	CLOSE	LAM.	LAMINATED	SIM.	SIMILAR
COL.	COLUMN	LB.	POUND	SLDG.	SLIDING
CONC.	CONCRETE	LDG.	LANDING	SM.	SMOOTH
CONN.	CONNECTION	LTH.	LATH	SPEC.	SPECIFICATION
CONST.	CONSTRUCTION	LTV.	LAVATORY	SQ.	SQUARE
C.J.	CONTROL JOINT	LOC.	LOCATION	ST.	STAINED
CONT.	CONTINUOUS	L.O.	LENGTH	STD.	STANDARD
CONTR.	CONTRACTOR	LOC.	LOCATION	S.S. /	S.S. /
CORR.	CORRUGATED	LT.	LIGHT	ST.STL.	STAINLESS STEEL
CTR.	COUNTER	L.W.C.	LIGHT WEIGHT CONCRETE	STRUC.	STRUCTURE
CTSJK.	COUNTERSUNK	LVR.	LOUVER	SUSP.	SUSPENDED
C.M.U.	CONCRETE MASONRY UNIT	LOC.	LOCATION	SWB.	SWITCHBOARD
D.P.	DAMP PROOFING	M.O.	MASONRY OPENING	SYS.	SYSTEM
DB.	DECIBEL	MATL.	MATERIAL	T.	TREAD
DIAG.	DIAGONAL	MTR.	MANUFACTURER	T.C.	TOP OF CURB
DIAM.	DIAMETER	MB.	MARKER BOARD	T.G.	TEMPERED GLASS
DM.	DIMENSION	MAX.	MAXIMUM	T.O.	TOP OF
DISP.	DISPENSER	MECH.	MECHANICAL	T.S.D.	TOP OF STEEL DECK
DWL.	DOWEL	MTL.	METAL	T.W.	TEACHERS WARDROBE
DN.	DOWN	M.L.	METAL LATH	TYP.	TYPICAL
D.S.	DOWNSPOUT	M.	METER	U.O.N.	UNLESS OTHERWISE NOTED
DWG.	DRAWING	MIN.	MINIMUM	V.	VENT
EA.	EACH	MLDG.	MOLDING	VERT.	VERTICAL
ELEC.	ELECTRIC	MULL.	MULLION	V.G.	VERTICAL GRAIN
E.W.C.	ELECTRIC WATER COOLER	N.G.	NATURAL GRADE	VEST.	VESTIBULE
EL.	ELEVATION	NOM.	NOMINAL	V.C.T.	VINYL COMPOSITION TILE
ELEV.	ELEVATOR	N.I.C.	NOT IN CONTRACT	VCP.	VITREOUS CLAY PIPE
EQ.	EQUAL	N.T.S.	NOT TO SCALE	W.W.M.	WELDED WIRE MESH
EQUIP.	EQUIPMENT	NO. / #	NUMBER	W.C.	WATER CLOSET
EXH.	EXHAUST	Obs.	OBSOLETE	W.H.	WATER HEATER
EXPAN.	EXPANSION	O.C.	ON CENTER	W.F.	WIDE FLANGE
E.J.	EXPANSION JOINT	OPNG.	OPENING	W.	WITH
EXST.	EXISTING	O.A.	OVERALL	W/O	WITHOUT
EXT.	EXTERIOR	O.D.	OUTSIDE DIAMETER	WD.	WOOD
FT.	FEET / FOOT	O.F.S.	OVERFLOW SCUPPER	WDW.	WINDOW
FIN.	FINISH	O.F.D.	OVERFLOW DRAIN	W.W.	WINDOW WALL
FL.	FLASHING	O.H.D.	OVERHEAD DOOR		
FUR.	FLOOR				
F.D.	FLOOR DRAIN				

LOCATION PLAN

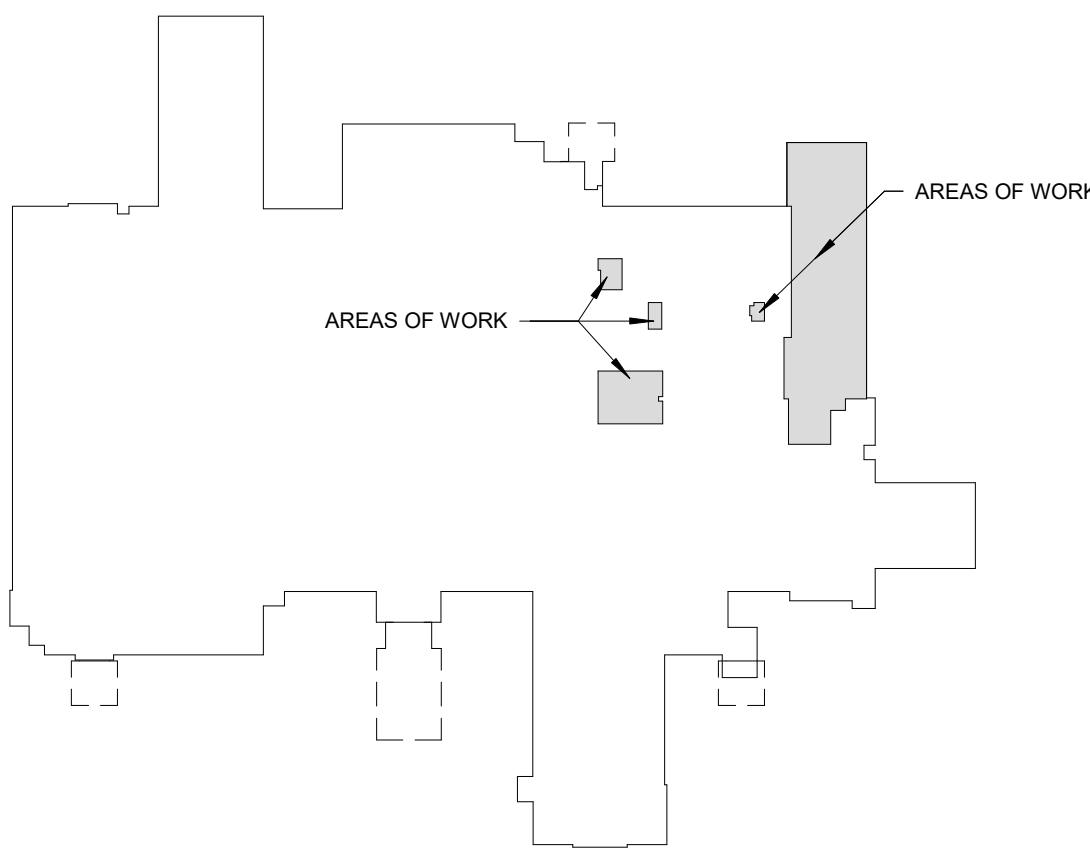

FIRST FLOOR KEY PLAN
1" = 100'-0"

GENERAL NOTES

- ALL WORK SHALL BE PERFORMED IN ACCORDANCE WITH A.D.A. REQUIREMENTS AND ALL APPLICABLE LOCAL, STATE, AND FEDERAL BUILDING CODES AND REGULATIONS.
- THE CONTRACTOR IS RESPONSIBLE FOR OBTAINING ALL NECESSARY BUILDING PERMITS.
- THE GENERAL CONTRACTOR AND SUBCONTRACTORS SHALL FIELD VERIFY EXISTING CONDITIONS AND NOTIFY THE ARCHITECT OF ANY INCONSISTENCIES OR DISCREPANCIES WITH THE PROJECT DOCUMENTS. ACCESS TO THE SITE AND/OR SPACE UNDER CONSTRUCTION DURING BIDDING AND CONSTRUCTION SHALL BE COORDINATED WITH THE OWNER.
- DO NOT SCALE DRAWINGS.
- THE WORD "ALIGN AND 'EQUAL' AS USED IN THESE DOCUMENTS SHALL SUPERCEDE ANY DIMENSIONAL INFORMATION GIVEN.
- TYPICAL DIMENSIONS ARE TO FACE OF CONCRETE, GYPSUM BOARD, CURTAINWALL, ETC. OR TO COLUMN CENTERLINE. DIMENSIONS AT WINDOWS ARE TYPICALLY TO FACE OF FRAME. REFER TO PLAN DETAILS FOR ADDITIONAL INFORMATION.
- THE GENERAL CONTRACTOR SHALL BE RESPONSIBLE FOR EXAMINING AND CONFIRMING ALL SUBSTRATE CONDITIONS WHERE NEW MATERIALS ARE APPLIED. THE SUBSTRATE SHALL BE SMOOTH AND FREE OF DEFECTS AND SHALL CONFORM TO THE REQUIREMENTS OF THE FINISHED MATERIAL MANUFACTURERS RECOMMENDATIONS.
- THE GENERAL CONTRACTOR SHALL BE RESPONSIBLE FOR CLEAN-UP.
- THE GENERAL CONTRACTOR SHALL INSPECT AND CHECK THE ADEQUACY OF INSTALLATION OF THRU-WALL FLASHING PRIOR TO COVERING WITH FINISH MATERIALS. THIS SHALL INCLUDE, BUT IS NOT LIMITED TO INSPECTION AGAINST HOLES OR PENETRATIONS, APPROPRIATE LAPPING AND SEALING, AND OVERALL WORKMANSHIP IN CONFORMANCE WITH THE SPECIFICATIONS.

SHEET INDEX - FDP

GENERAL	FDP COVER
A0.0	CODE FOOTPRINT PLAN
A0.2	
CIVIL	
C1.0	DEMOLITION PLAN
C1.0	GRAIN QUALITY PLAN
C3.0	DRAINAGE MAP AND CALCULATIONS
C4.0	STORM PLANT & PROFILES
C5.0	CONSTRUCTION DETAILS
C6.0	STORM SEWER DETAILS
C7.0	EROSION CONTROL DETAILS
C8.0	EROSION CONTROL DETAILS
ARCHITECTURE	
A2.1	FIRST FLOOR DIMENSION PLAN
A2.2	FIRST FLOOR ANNOTATION PLAN
A2.5	ROOF PLAN AND DETAILS
A5.1	EXTERIOR ELEVATIONS


UTILITY CONTACTS

Sanitary Sewers	Mr. Jeff Thorn, PE City of Lee's Summit Water Utilities 1200 SE Hamblen Road Lee's Summit, MO 64063 (816) 969-1922 email: jeff.thorn@cityofLS.net	Gas	Mr. Donnie Richards Missouri Gas Energy 7500 E 35th Terrace Kansas City, MO 64129 (816) 472-9454 Fax (816) 472-3488 email: donnie.richards@sug.com
Water	Mr. John Flathers Little Blue Valley Sewer District 21208 E Old Atherton Road Independence, MO 64058 (816) 769-7660 email: flathers@lbvwsd.org	Cable Television	Mr. Greg Thomas Time Warner Cable 8221 W 119th Street Overland Park, KS 66213 (913) 643-1950 email: greg.thomas@twcable.com
Electric Service	Mr. Jeff Thorn, PE City of Lee's Summit Water Utilities 1200 SE Hamblen Road Lee's Summit, MO 64063 (816) 969-1922 email: jeff.thorn@cityofLS.net	Telephone	Ms. Glenda Charles AT&T 1425 Oak Street Kansas City, MO 64106 (816) 365-1669 Fax (816) 275-1109 email: gc6954@aatt.com
	Mr. Nathan Michael Kansas City Power & Light P.O. Box 418679 Kansas City, MO 64141 (816) 220-5210 Fax (816) 245-3623 email: Nathan.Michael@kcpl.com		

Missouri One Call System 1-800-344-7483 (DIG-RITE)



Samuel K. Beckman - Architect
License - Missouri WA-2011012130

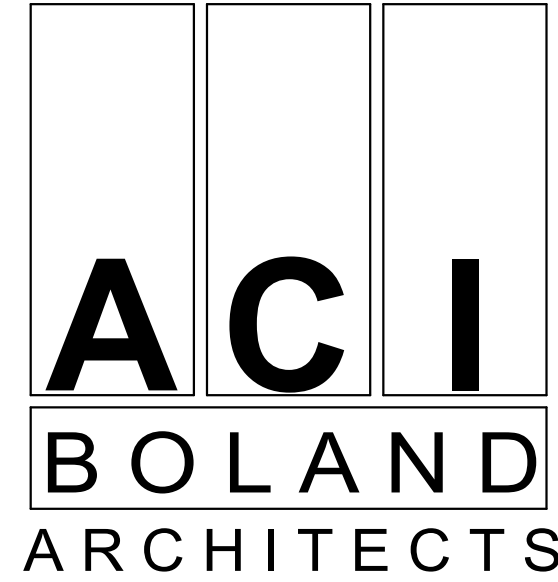

ACI/Boland, Inc.
Kansas City | St. Louis
1710 Wyandotte
Kansas City, MO 64108
T: 816.763.9600

Licensee's Certificate of Authority Number:
Missouri: #000958

MEP CONSULTANT

HENDERSON ENGINEERS, INC.
1801 MAIN STREET, SUITE #300
KANSAS CITY, MO 64108
T: 816.663.8700
Licensee's Certificate of Authority Number:
0000000000

STRUCTURAL CONSULTANT

BOB D. CAMPBELL & CO.
4338 BELLEVIEW AVE
KANSAS CITY, MO 64111
T: 816.531.4144
Licensee's Certificate of Authority Number:
0000000000

LEE'S SUMMIT MEDICAL CENTER -
ICU EXPANSION
2100 SE BLUE PARKWAY
LEE'S SUMMIT, MISSOURI 64063

Date	01/14/2022
Job Number	3-21112
Drawn By	Author
Checked By	Checker

Revision		
Number	Date	Description
2	2/11/22	CITY COMMENTS
4	3/2/22	CITY COMMENTS
6	3/22/22	FDP COMMENTS



CODE SUMMARY

Project Construction Purpose: ICU EXPANSION

Owner Information
LEE'S SUMMIT MEDICAL CENTER
2100 SE BLUE PRAIRY AVE
LEE'S SUMMIT, MISSOURI 64683
Phone: 816-282-5500

Designer Information
ATC BOLD AND ASSOCIATES
1710 Wyandotte St.
Kansas City, MO 64108
Phone: (816) 763-9600

Code Information
2018 International Building Code
2018 International Plumbing Code
2018 International Mechanical Code
2017 National Electrical Code (NFPA 70)
2018 International Fire Code
2012 Life Safety Code (NFPA 101)
2010 ADA Standards for Accessible Design / Americans with Disabilities Act of 1990
2009 ICCANSI A117.1

Note: If code requirements allow, the most stringent shall apply. Building was originally designed to 2003 International Building Code.

Local Authority
Responding Fire Service: Lee's Summit Fire Department
Local Building Inspection: Lee's Summit, MO, County Administration Department

Area of Addition
5,925 +/- SF

Area of Reduction
2,418 +/- SF

Occupancy Group: I-2 - Section 308.3

Occupant Load:
Sleeping Area: 120 SF / occupant
Treatment Area: 100 SF / occupant
Business Area: 100 SF / occupant
Total Number of Occupants = 58

Type of Construction: Type IB - (NFPA 222)

Required Fire Resistance Ratings (in hours):
per NFPA 101, I.B.2.4.1.2

Exterior Bearing Walls	2 HR
Interior Bearing Walls	2 HR
Primary Structural Frame	2 HR
Floor Construction	2 HR
Roof Construction	1 HR
Interior non-bearing walls	1 HR

Active Fire Safety Features:

- **Fire Alarm System:** The fire alarm system is specified as an addressable type system. The device type and locations are per the applicable codes as well as AIA requirements.
- **Smoke Control System:** All ductwork penetrating smoke rated walls will have a smoke or combination fire/smoke damper installed on construction documents. These dampers will close upon detection of smoke by the smoke detectors or duct smoke detectors in the air handling units.
- **Fire Sprinkler System:** Specified to be per NFPA 13.
The sprinkler heads are specified to be quick response type.
- **Emergency Lighting and Power:** Emergency lighting, life safety and critical loads will receive power from a backup generator located outside the main electrical room.
- **Illuminated Exit Signs**

Passive Fire Safety Features:

- **Smoke Compartments** no greater than 22,500 SF.



1

0000000000

STRUCTURAL CONSULTANT

BOB D. CAMPBELL & CO.

4338 BELLEVIEW AVE

KANSAS CITY, MO 64111

1: 816.531.4144

Licensee's Certificate of Authority Number:
0000000000

0000000000


SYMBOLS	
	SMOKE COMPARTMENT DESIGNATION
	SUITE DESIGNATION
	FIRE EXIT OCCUPANT LOAD EXIT WIDTH PROVIDED EXIT WIDTH REQUIRED
	NEW FIRE EXTINGUISHER CABINET
	EXISTING FIRE EXTINGUISHER CABINET
	EXIT SIGN
	FIRE DOOR RATING
	TRAVEL DISTANCE
	FIRE/SMOKE DAMPER
	SMOKE DETECTOR
	HEAT DETECTOR
	STROBE
	STROBE/SPEAKER
	HORN/STROBE
	HORN
	FIRE PULL STATION
	FIRE SPRINKLER ZONE VALVE

Λ0 2

AU.2

© 2021 ACI/ROLAND, Inc.


CODE FOOTPRINT PLAN

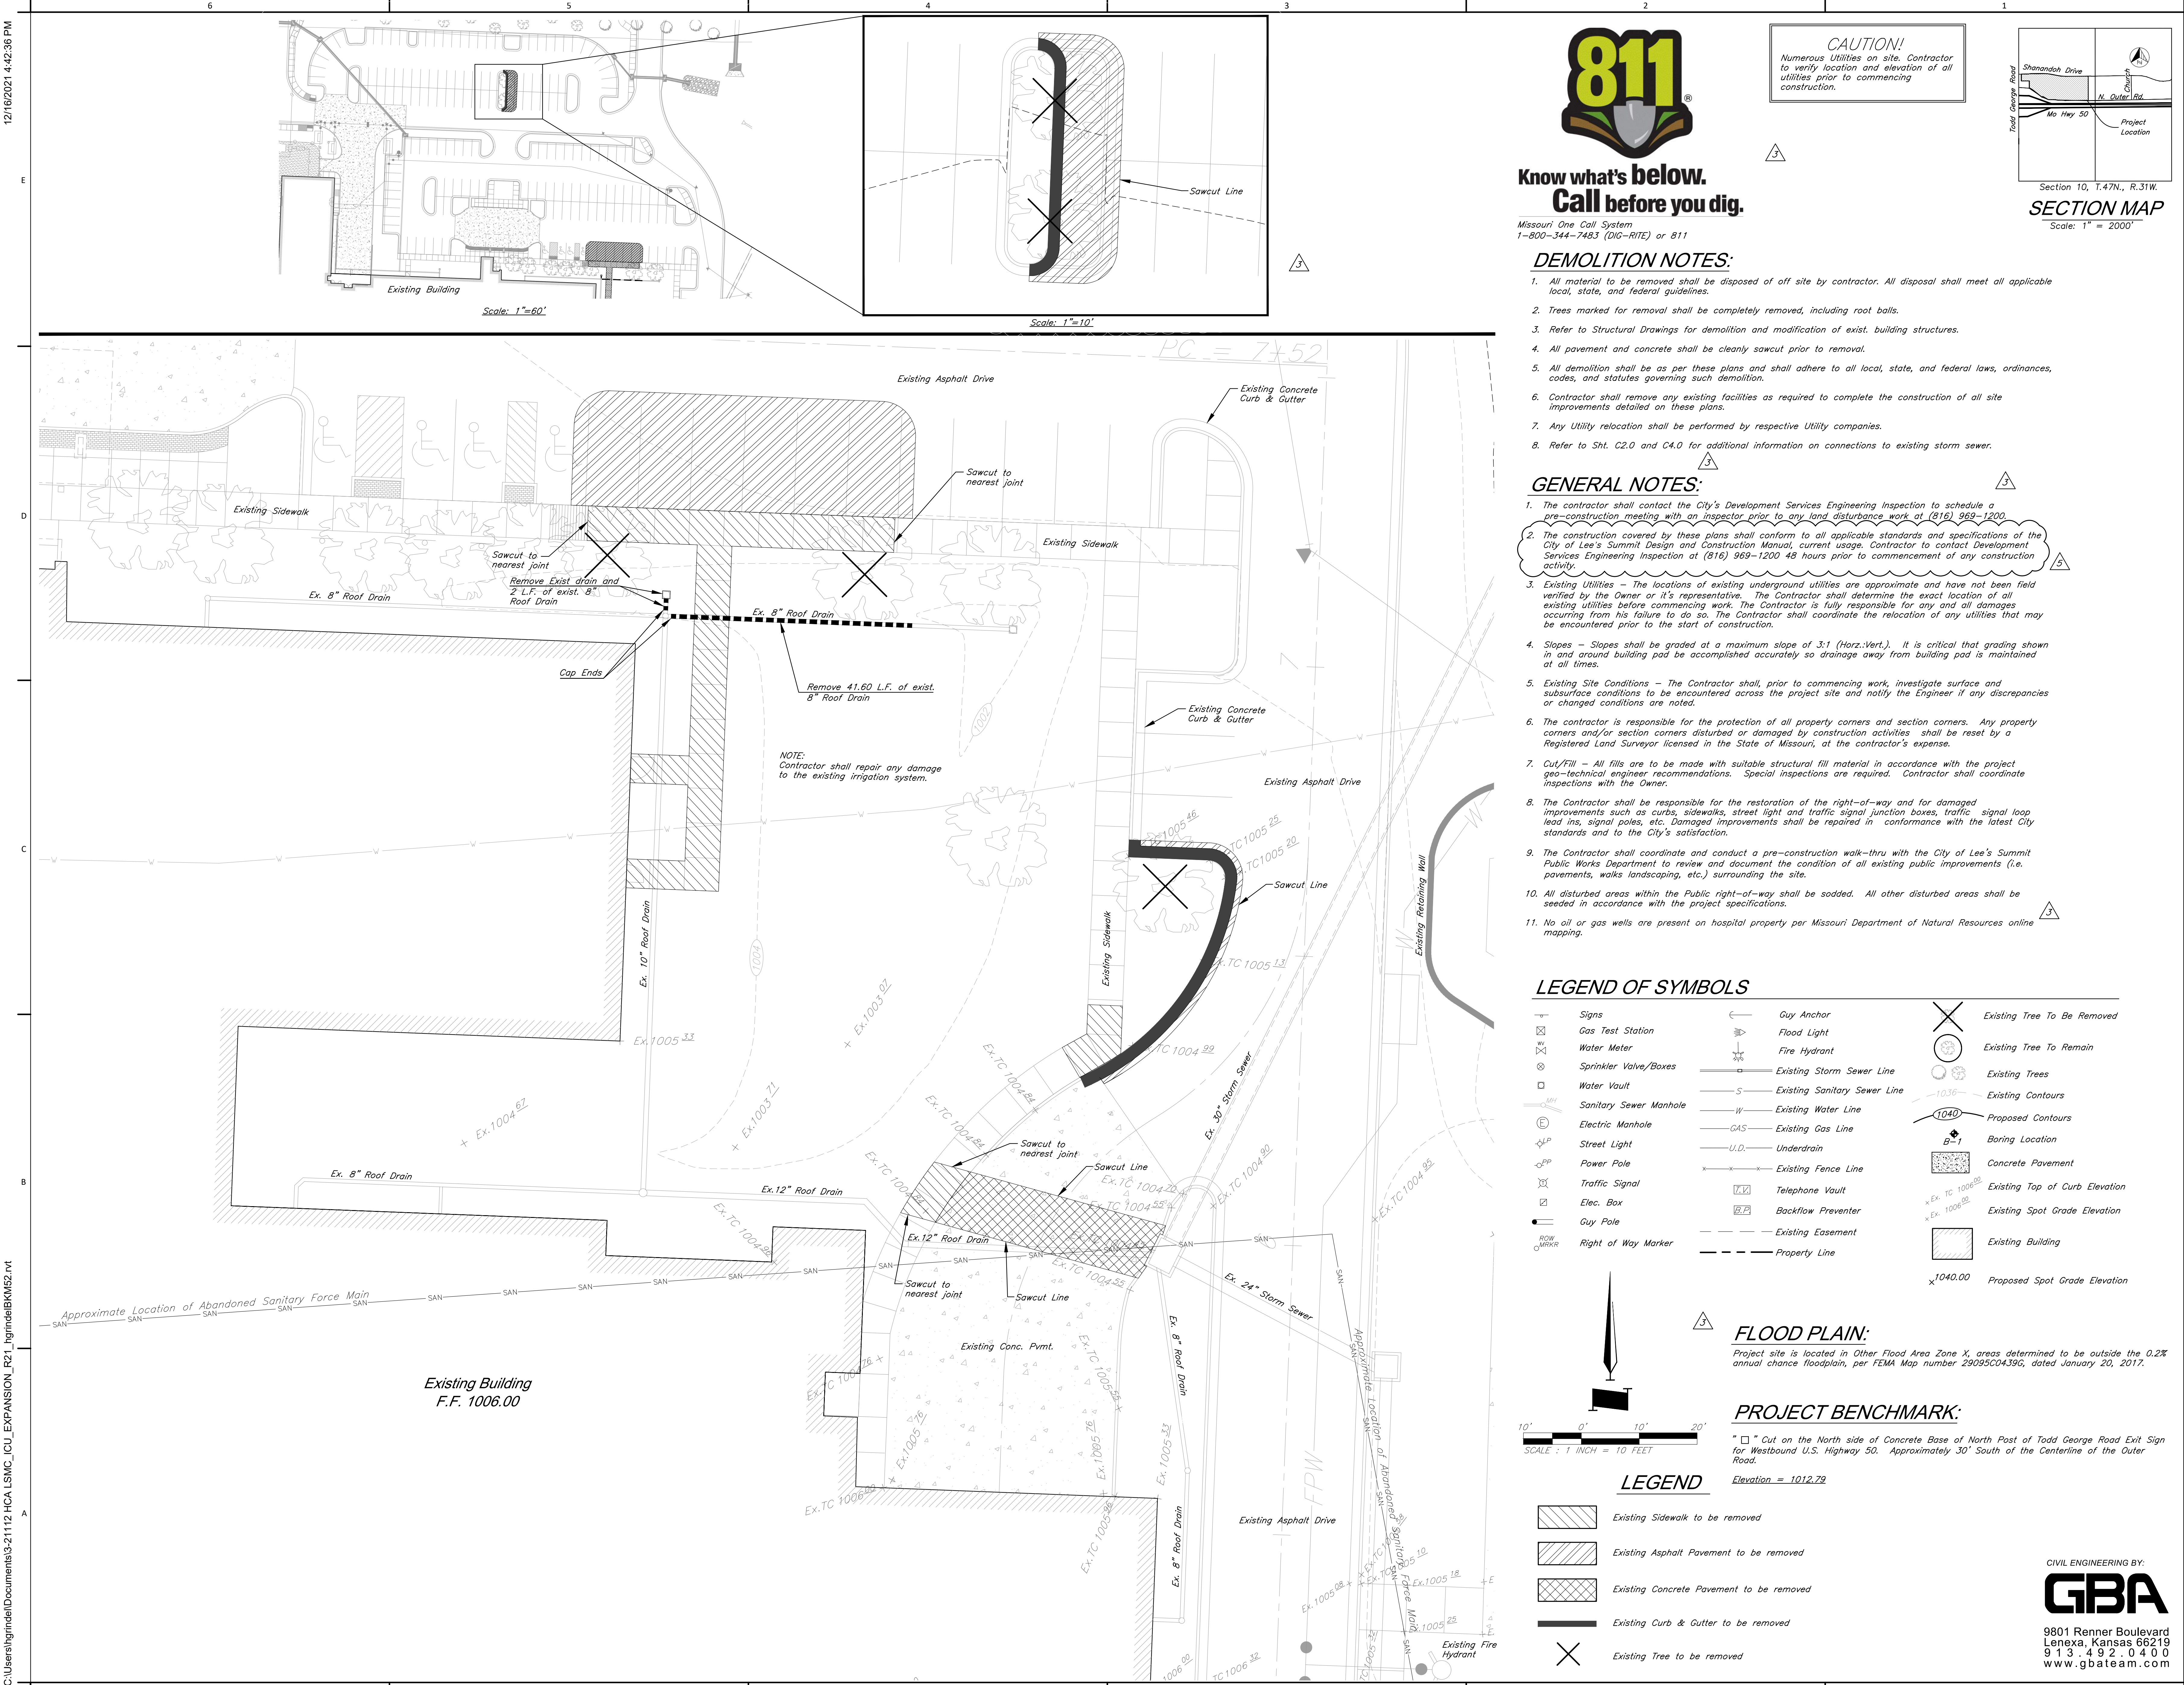

Know what's below.
Call before you dig.

Missouri One Call System
1-800-344-7483 (DIG-RITE) or 811

CAUTION!
Numerous Utilities on site. Contractor to verify location and elevation of all utilities prior to commencing construction.

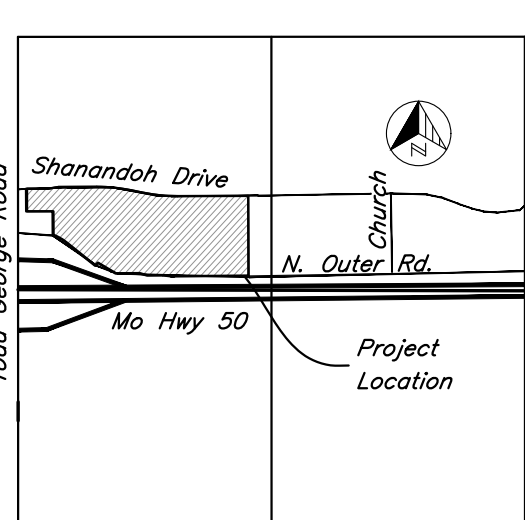

SECTION MAP
Scale: 1" = 2000'

DEMOLITION NOTES:


1. All material to be removed shall be disposed of off site by contractor. All disposal shall meet all applicable local, state, and federal guidelines.
2. Trees marked for removal shall be completely removed, including root balls.
3. Refer to Structural Drawings for demolition and modification of exist. building structures.
4. All pavement and concrete shall be cleanly sawcut prior to removal.
5. All demolition shall be as per these plans and shall adhere to all local, state, and federal laws, ordinances, codes, and statutes governing such demolition.
6. Contractor shall remove any existing facilities as required to complete the construction of all site improvements detailed on these plans.
7. Any Utility relocation shall be performed by respective Utility companies.
8. Refer to Sht. C2.0 and C4.0 for additional information on connections to existing storm sewer.

GENERAL NOTES:

1. The contractor shall contact the City's Development Services Engineering Inspection to schedule a pre-construction meeting with an inspector prior to any land disturbance work of (816) 969-1200.
2. The construction covered by these plans shall conform to all applicable standards and specifications of the City of Lee's Summit Design and Construction Manual, current usage. Contractor to contact Development Services Engineering Inspection at (816) 969-1200 48 hours prior to commencement of any construction activity.
3. Existing Utilities - The locations of existing underground utilities are approximate and have not been field verified by the Owner or its representative. The Contractor shall determine the exact location of all existing utilities before commencing work. The Contractor is fully responsible for any and all damages occurring from his failure to do so. The Contractor shall coordinate the relocation of any utilities that may be encountered prior to the start of construction.
4. Slopes - Slopes shall be graded at a maximum slope of 3:1 (Horz:Vert.). It is critical that grading shown in and around building pad be accomplished accurately so drainage away from building pad is maintained at all times.
5. Existing Site Conditions - The Contractor shall, prior to commencing work, investigate surface and subsurface conditions to be encountered across the project site and notify the Engineer if any discrepancies or changed conditions are noted.
6. The contractor is responsible for the protection of all property corners and section corners. Any property corners and/or section corners disturbed or damaged by construction activities shall be reset by a Registered Land Surveyor licensed in the State of Missouri, at the contractor's expense.
7. Cut/Fill - All fills are to be made with suitable structural fill material in accordance with the project geo-technical engineer recommendations. Special inspections are required. Contractor shall coordinate inspections with the Owner.
8. The Contractor shall be responsible for the restoration of the right-of-way and for damaged improvements such as curbs, sidewalks, street light and traffic signal junction boxes, traffic signal loop lead ins, signal poles, etc. Damaged improvements shall be repaired in conformance with the latest City standards and to the City's satisfaction.
9. The Contractor shall coordinate and conduct a pre-construction walk-thru with the City of Lee's Summit Public Works Department to review and document the condition of all existing public improvements (i.e. pavements, walks landscaping, etc.) surrounding the site.
10. All disturbed areas within the Public right-of-way shall be sodded. All other disturbed areas shall be seeded in accordance with the project specifications.
11. No oil or gas wells are present on hospital property per Missouri Department of Natural Resources online mapping.

LEGEND OF SYMBOLS

	Signs		Guy Anchor		Existing Tree To Be Removed
	Gas Test Station		Flood Light		Existing Tree To Remain
	Water Meter		Fire Hydrant		Existing Trees
	Sprinkler Valve/Boxes		Existing Storm Sewer Line		Existing Contours
	Water Vault		Existing Sanitary Sewer Line		Proposed Contours
	Sanitary Sewer Manhole		Existing Water Line		Boring Location
	Electric Manhole		Existing Gas Line		Concrete Pavement
	Street Light		Underdrain		Existing Top of Curb Elevation
	Power Pole		Existing Fence Line		Existing Spot Grade Elevation
	Traffic Signal		Telephone Vault		Existing Building
	Elec. Box		Backflow Preventer		Proposed Spot Grade Elevation
	Guy Pole		Existing Easement		
	Right of Way Marker		Property Line		

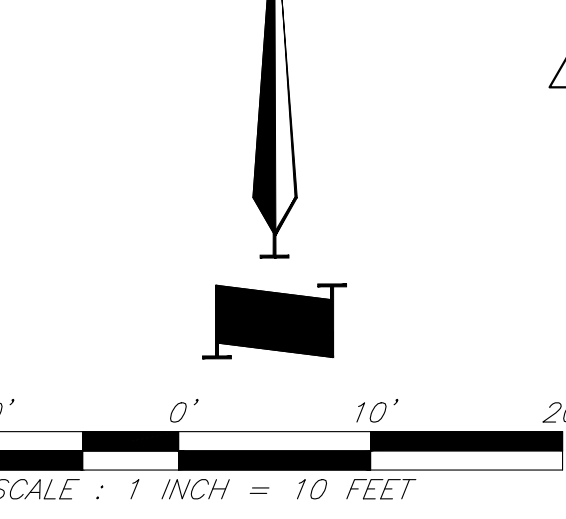

LEGEND

- Existing Sidewalk to be removed
- Existing Asphalt Pavement to be removed
- Existing Concrete Pavement to be removed
- Existing Curb & Gutter to be removed
- Existing Tree to be removed

FLOOD PLAIN:

Project site is located in Other Flood Area Zone X, areas determined to be outside the 0.2% annual chance floodplain, per FEMA Map number 29095C04396, dated January 20, 2017.

PROJECT BENCHMARK:

" " " Cut on the North side of Concrete Base of North Post of Todd George Road Exit Sign for Westbound U.S. Highway 50. Approximately 30' South of the Centerline of the Outer Road.
Elevation = 1012.79

CIVIL ENGINEERING BY:



9801 Renner Boulevard
Lenexa, Kansas 66219
913.492.0400
www.gbateam.com



Clint Loumaster - Civil Engineer
License - Missouri #PE-2011009651



ACI/Boland, Inc.
Kansas City | St. Louis
1710 Wyandotte
Kansas City, MO 64108
T: 816.763.9600
Licensee's Certificate of Authority Number:
Missouri: #000958

MEP CONSULTANT

HENDERSON ENGINEERS, INC.
1801 MAIN STREET, SUITE #300
KANSAS CITY, MO 64108
T: 816.663.8700
Licensee's Certificate of Authority Number:
0000000000

STRUCTURAL CONSULTANT


BOB D. CAMPBELL & CO.
4338 BELLEVUE AVE
KANSAS CITY, MO 64111
T: 816.531.4144
Licensee's Certificate of Authority Number:
0000000000


LEE'S SUMMIT MEDICAL CENTER -
ICU EXPANSION
2100 SE BLUE PARKWAY
LEE'S SUMMIT, MISSOURI 64063

Date 1/10/2022
Job Number 3-21112
Drawn By HG
Checked By Checker

Number	Date	Description
3	2/11/2022	
5	3/2/2022	

Revision
C1.0
Demolition Plan

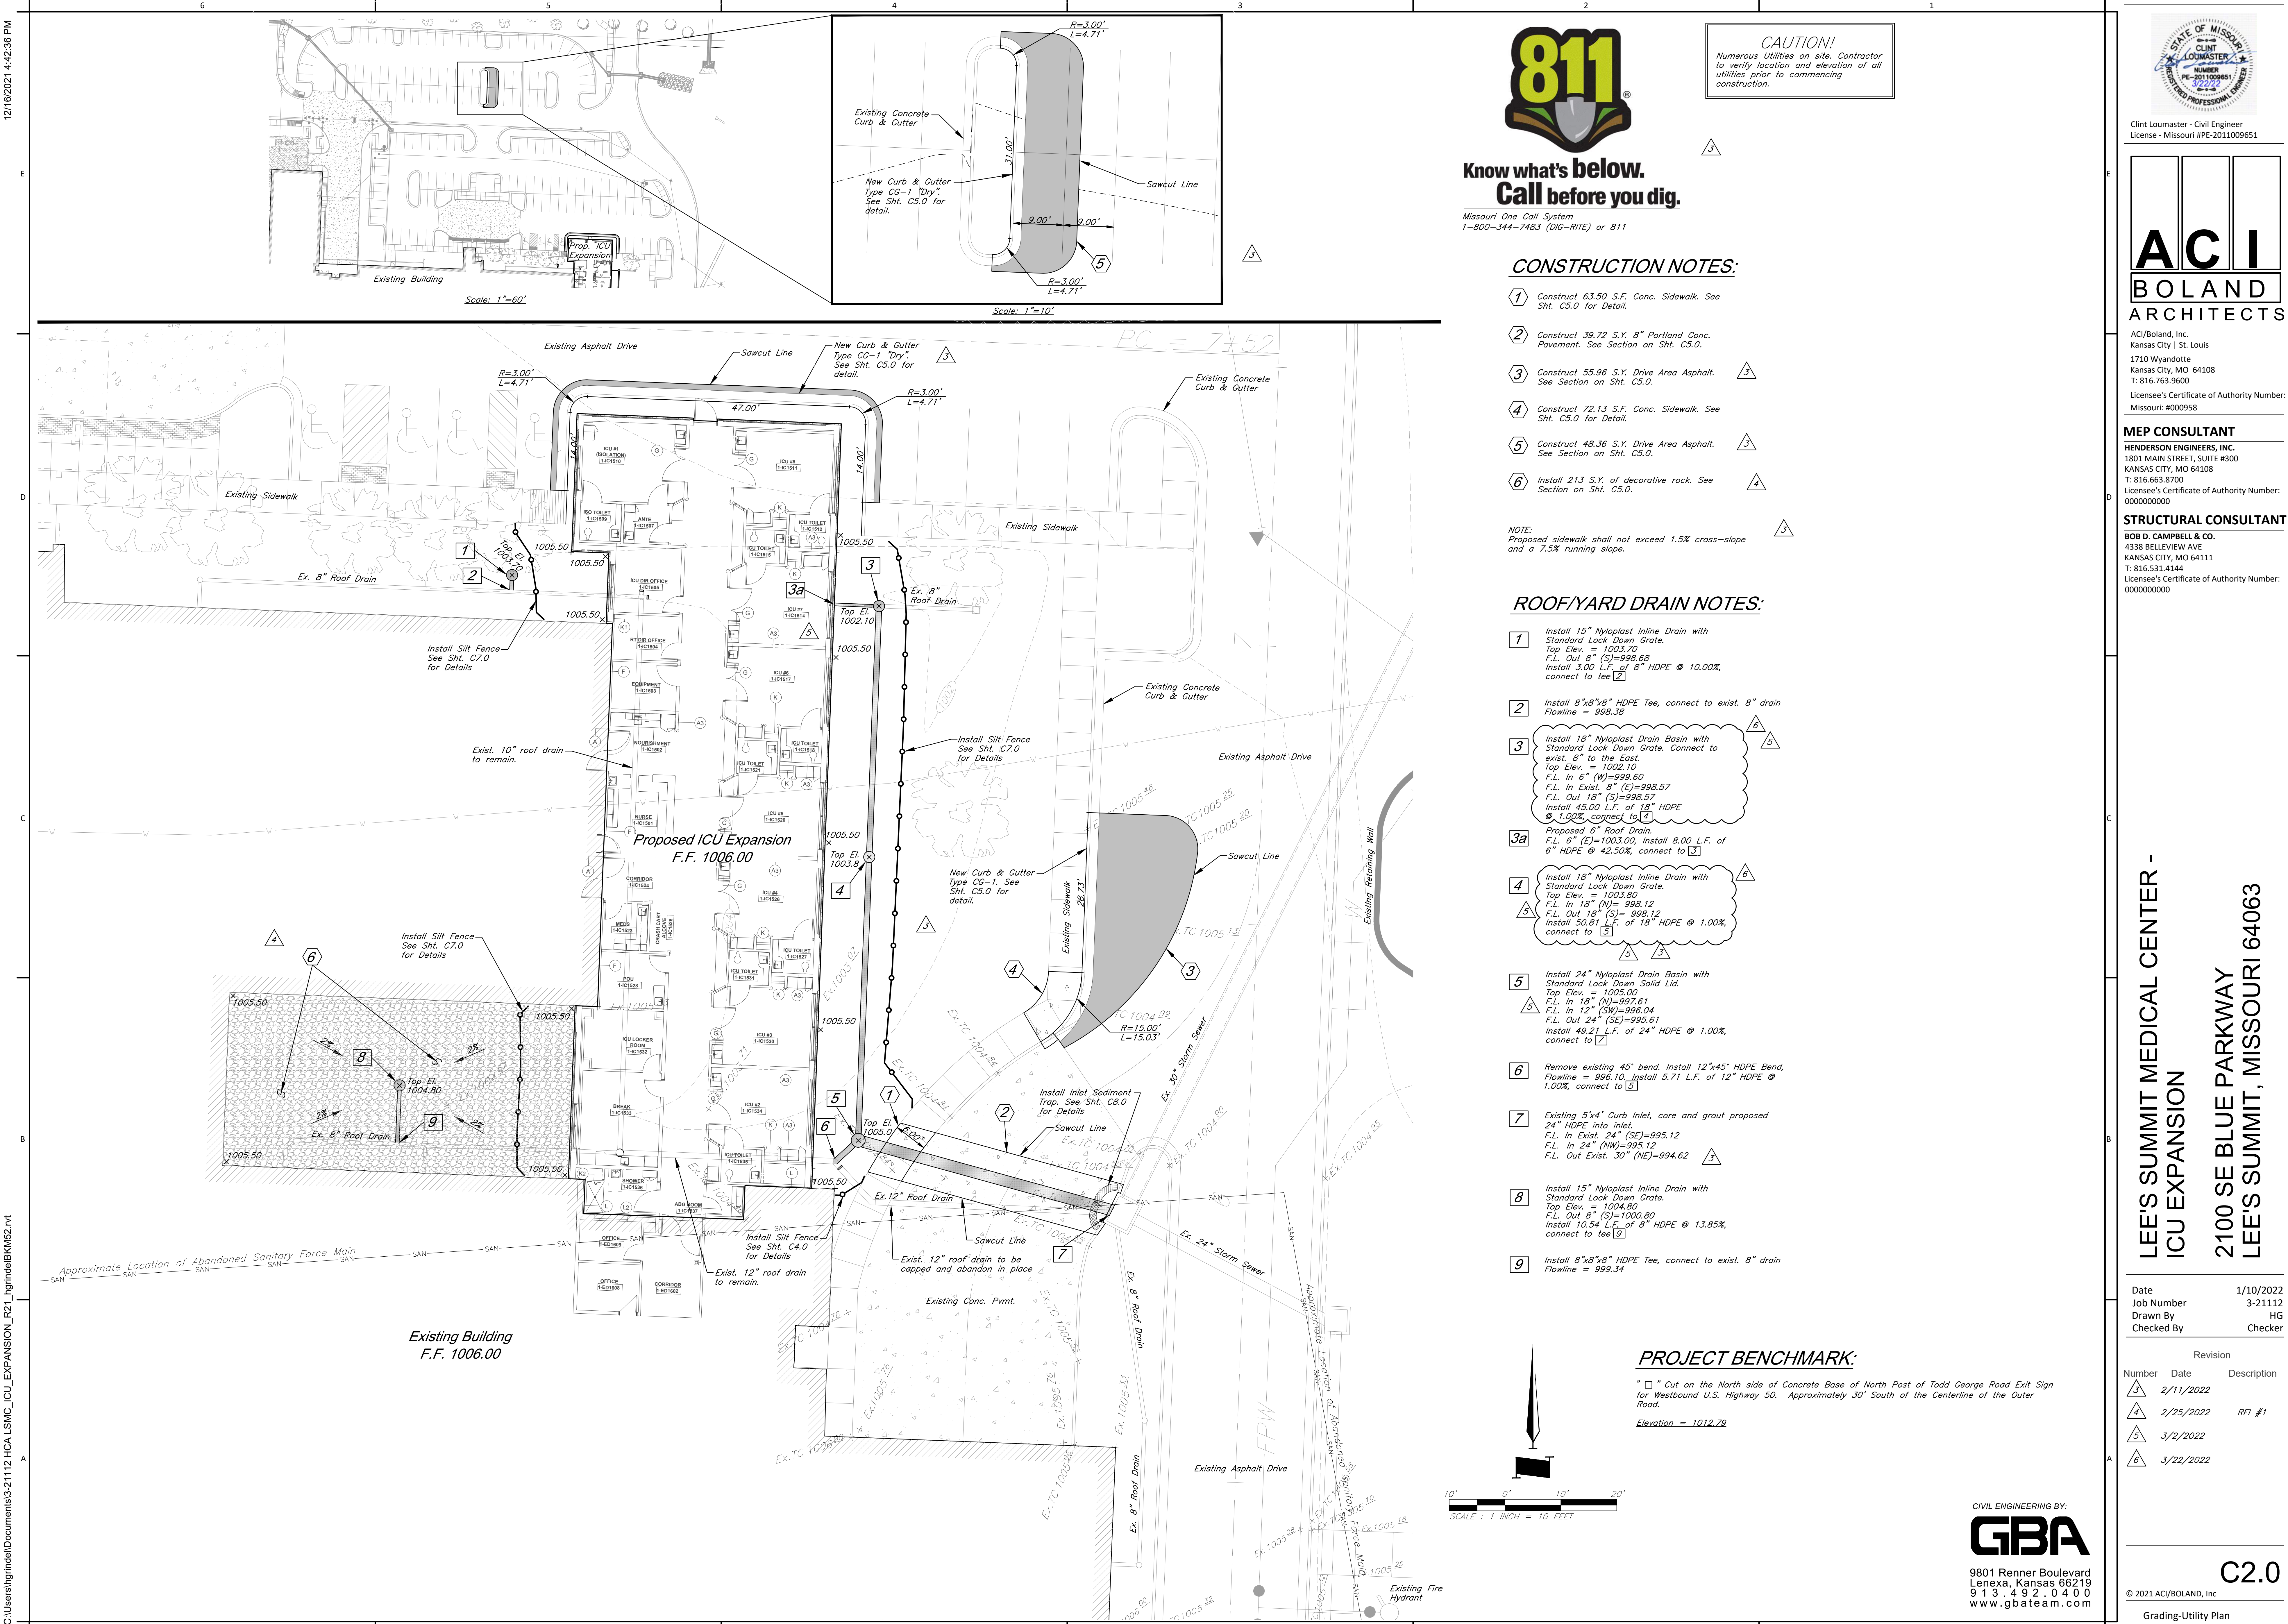

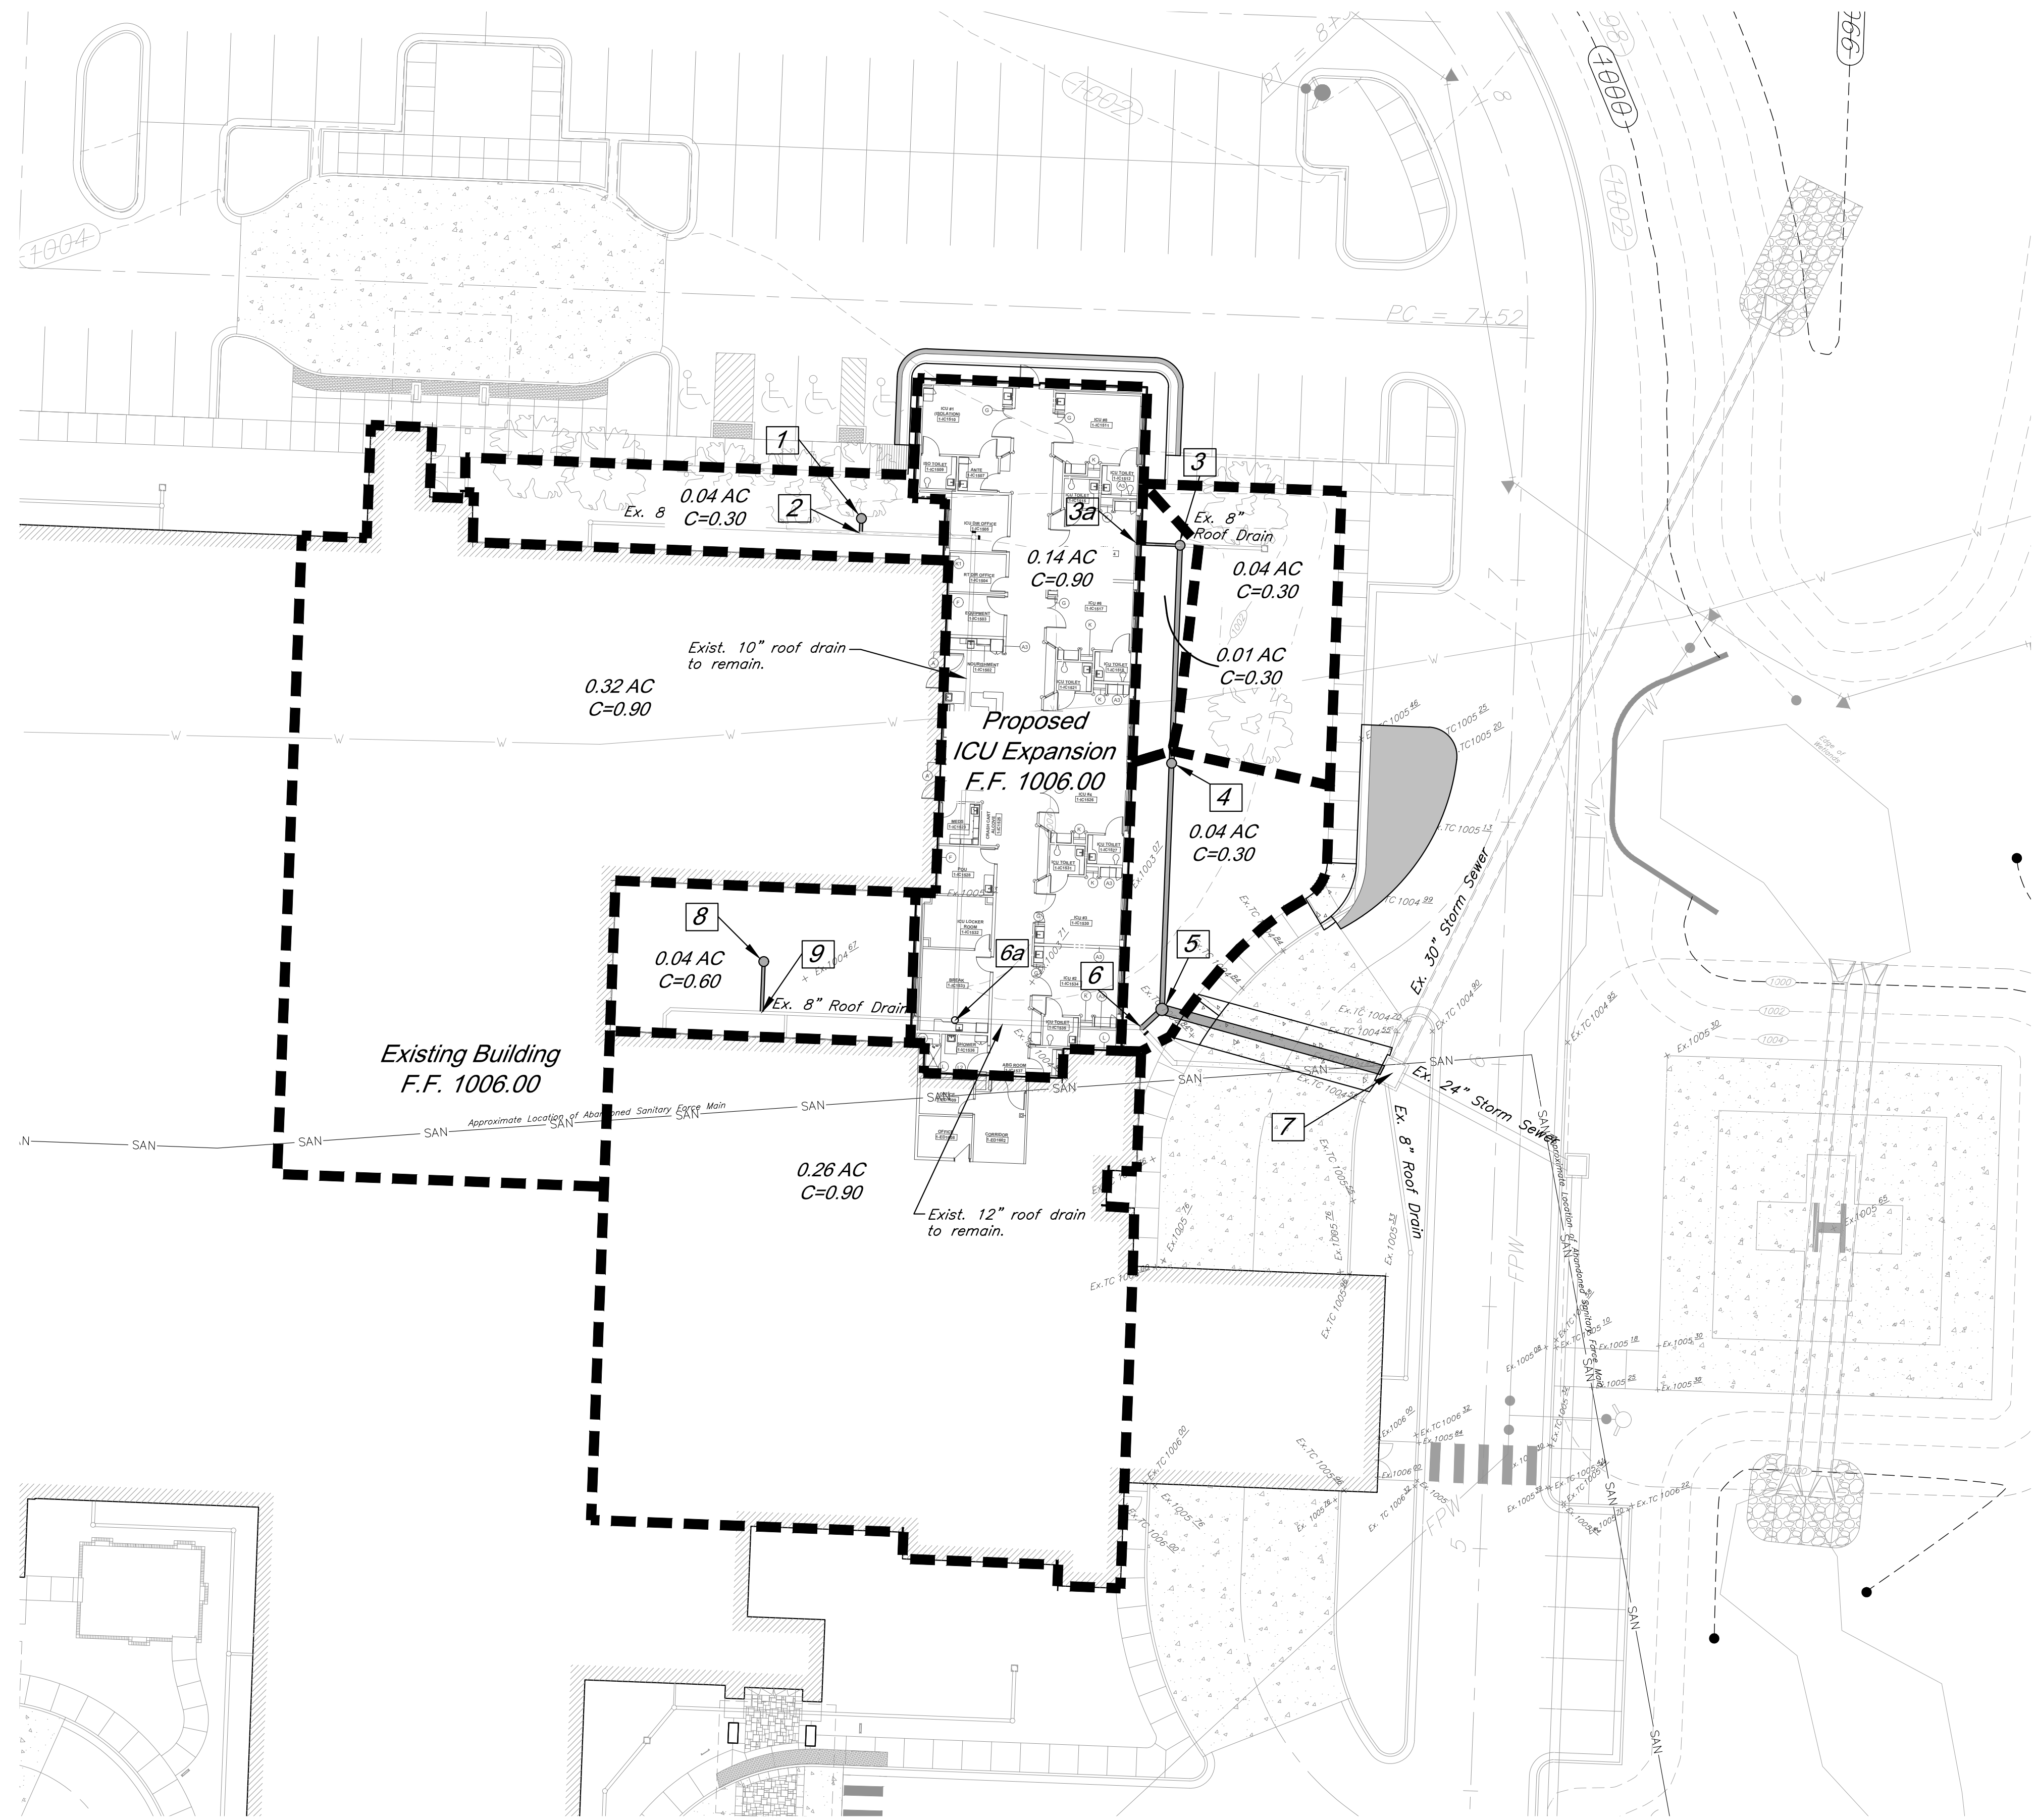


CAUTION!
Numerous Utilities on site. Contractor to verify location and elevation of all utilities prior to commencing construction.

LEGEND
----- Proposed Drainage Boundary

10 Year Storm																			
Structures		Runoff Calculations										Pipe Design							
From	To	Direct Area (acre)	Line In (acre)	Total Area (acre)	C	K	Tc (min)	Flow Time (min)	Intensity (in/hr)	Design Q (cfs)	Description	Pipe length (lin ft)	Pipe Slope Slope, %	Pipe dia (in)	Manning's n Value	Q full (cfs)	Pipe Area, sf	V full fps	Design V fps
3->7	3	0.01	0.18	0.19	0.30	1.00	5.00	0.26	7.35	0.0	Nyloplast Grate Inlet	45.00	1.00	18	0.013	10.53	1.77	5.96	2.86
	4	0.04	0.19	0.23	0.30	1.00	5.00	0.28	7.35	0.1	RCP	50.81	1.00	18	0.013	10.53	1.77	5.96	3.05
	5	0.00	0.66	0.66	0.30	1.00	5.00	0.28	7.35	0.0	Nyloplast w/ Solid Lid	49.21	1.00	24	0.013	22.68	3.14	7.22	2.94
	7			0.89	0.60	1.00	5.54	0.28	7.19	0.5	RCP								
1->2	1	0.04		0.04	0.30	1.00	5.00	0.01	7.35	0.1	Nyloplast Grate Inlet	3.00	10.00	8	0.013	3.83	0.35	10.98	4.70
	2			0.04	0.30	1.00	5.00		7.35	0.1	RCP								
8->9	8	0.04		0.04	0.60	1.00	5.00	0.03	7.35	0.2	Nyloplast Grate Inlet	10.54	13.85	8	0.013	4.51	0.35	12.92	6.46
	9			0.04	0.60	1.00	5.00		7.35	0.2	RCP								

100 Year Storm																			
Structures		Runoff Calculations										Pipe Design							
From	To	Direct Area (acre)	Line In (acre)	Total Area (acre)	C	K	Tc (min)	Flow Time (min)	Intensity (in/hr)	Design Q (cfs)	Description	Pipe length (lin ft)	Pipe Slope Slope, %	Pipe dia (in)	Manning's n Value	Q full (cfs)	Pipe Area, sf	V full fps	Design V fps
3->7	3	0.01	0.18	0.19	0.30	1.25	5.00	0.18	10.32	0.0	Nyloplast Grate Inlet	45.00	1.00	18	0.013	10.53	1.77	5.96	4.06
	4	0.04	0.19	0.23	0.30	1.25	5.00	0.19	10.32	0.2	RCP	50.81	1.00	18	0.013	10.53	1.77	5.96	4.37
	5	0.00	0.66	0.66	0.30	1.25	5.00	0.19	10.32	0.0	Nyloplast w/ Solid Lid	49.21	1.00	24	0.013	22.68	3.14	7.22	4.21
	7			0.89	0.60	1.25	5.38	0.19	10.17	0.9	RCP								
1->2	1	0.04		0.04	0.30	1.25	5.00	0.01	10.32	0.2	Nyloplast Grate Inlet	3.00	10.00	8	0.013	3.83	0.35	10.98	6.95
	2			0.04	0.30	1.25	5.00		10.32	0.2	RCP								
8->9	8	0.04		0.04	0.60	1.25	5.00	0.02	10.32	0.3	Nyloplast Grate Inlet	10.54	13.85	8	0.013	4.51	0.35	12.92	8.79
	9			0.04	0.60	1.25	5.00		10.32	0.3	RCP								

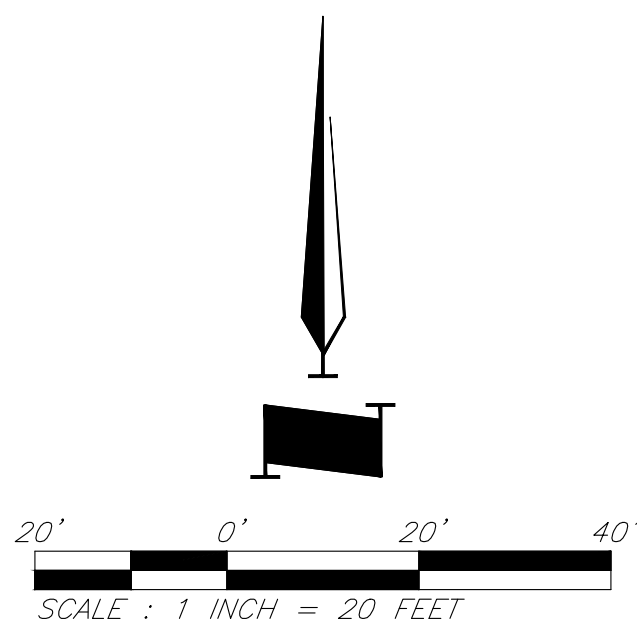

CIVIL ENGINEERING BY:
GBA
9801 Renner Boulevard
Lenexa, Kansas 66219
913.492.0400
www.gbateam.com



Clint Loumaster - Civil Engineer
License - Missouri #PE-2011009651

ACI
BOLAND
ARCHITECTS

ACI/Boland, Inc.
Kansas City | St. Louis
1710 Wyandotte
Kansas City, MO 64108
T: 816.763.9600
Licensee's Certificate of Authority Number:
Missouri: #000958

MEP CONSULTANT
HENDERSON ENGINEERS, INC.
1801 MAIN STREET, SUITE #300
KANSAS CITY, MO 64108
T: 816.663.8700
Licensee's Certificate of Authority Number:
0000000000

STRUCTURAL CONSULTANT
BOB D. CAMPBELL & CO.
4338 BELLEVUE AVE
KANSAS CITY, MO 64111
T: 816.531.4144
Licensee's Certificate of Authority Number:
0000000000


**LEE'S SUMMIT MEDICAL CENTER -
ICU EXPANSION**
**2100 SE BLUE PARKWAY
LEE'S SUMMIT, MISSOURI 64063**

Date 1/10/2022
Job Number 3-21112
Drawn By HG
Checked By Checker

Revision
Number Date Description
3 2/11/2022
4 2/25/2022 RFI #1
5 3/2/2022
6 3/22/2022

5

C3.0
Drainage Map and Calculations
© 2021 ACI/BOLAND, Inc.

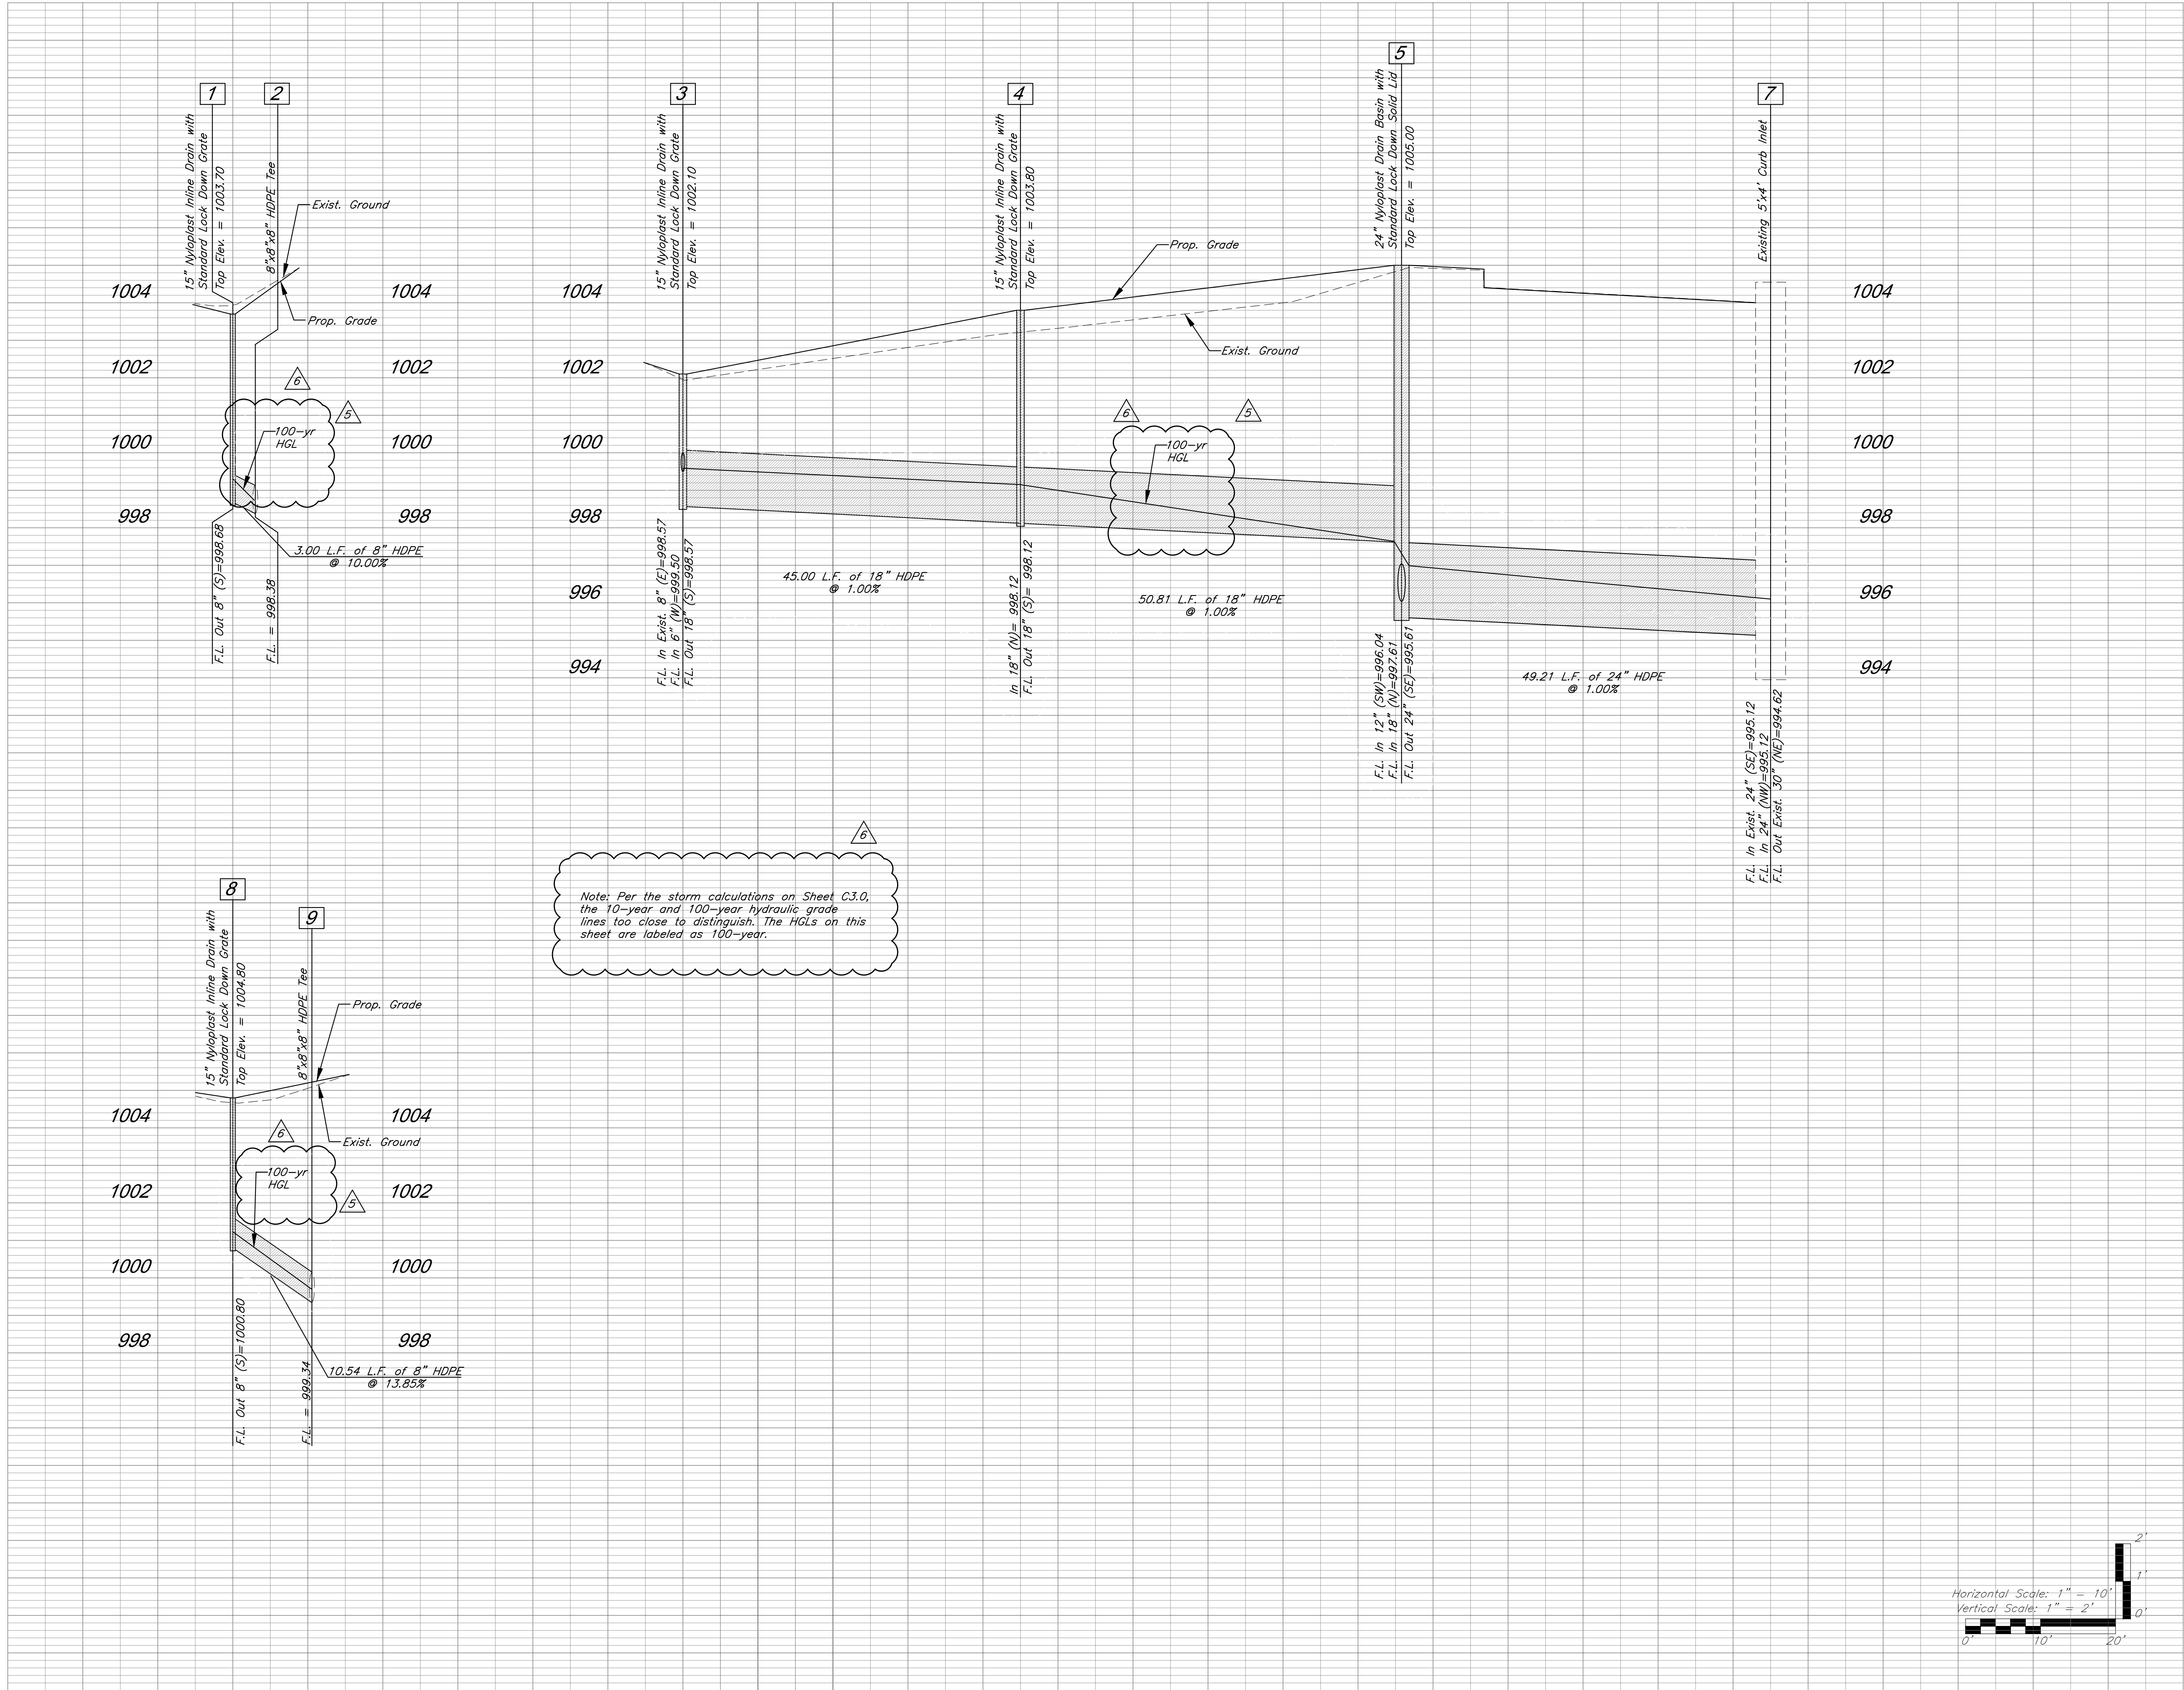


3

CIVIL ENGINEERING BY:
GBA
9801 Renner Boulevard
Lenexa, Kansas 66219
913.492.0400
www.gbateam.com



Clint Loumaster - Civil Engineer
License - Missouri #PE-2011009651

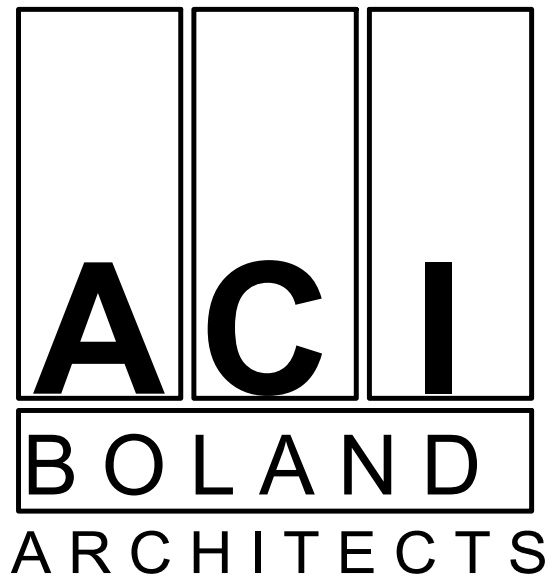

ACI/Boland, Inc.
Kansas City | St. Louis
1710 Wyandotte
Kansas City, MO 64108
T: 816.763.9600
Licensee's Certificate of Authority Number:
Missouri: #000958

MEP CONSULTANT
HENDERSON ENGINEERS, INC.
1801 MAIN STREET, SUITE #300
KANSAS CITY, MO 64108
T: 816.663.8700
Licensee's Certificate of Authority Number:
0000000000

STRUCTURAL CONSULTANT
BOB D. CAMPBELL & CO.
4338 BELLEVUE AVE
KANSAS CITY, MO 64111
T: 816.531.4144
Licensee's Certificate of Authority Number:
0000000000

LEE'S SUMMIT MEDICAL CENTER -
ICU EXPANSION
2100 SE BLUE PARKWAY
LEE'S SUMMIT, MISSOURI 64063

Date 1/10/2022
Job Number 3-21112
Drawn By HG
Checked By Checker

Revision		
Number	Date	Description
3	2/11/2022	
5	3/2/2022	
6	3/22/2022	

C4.0


© 2021 ACI/BOLAND, Inc.

Storm Plan & Profiles


3

5


NON TRAFFIC INSTALLATION

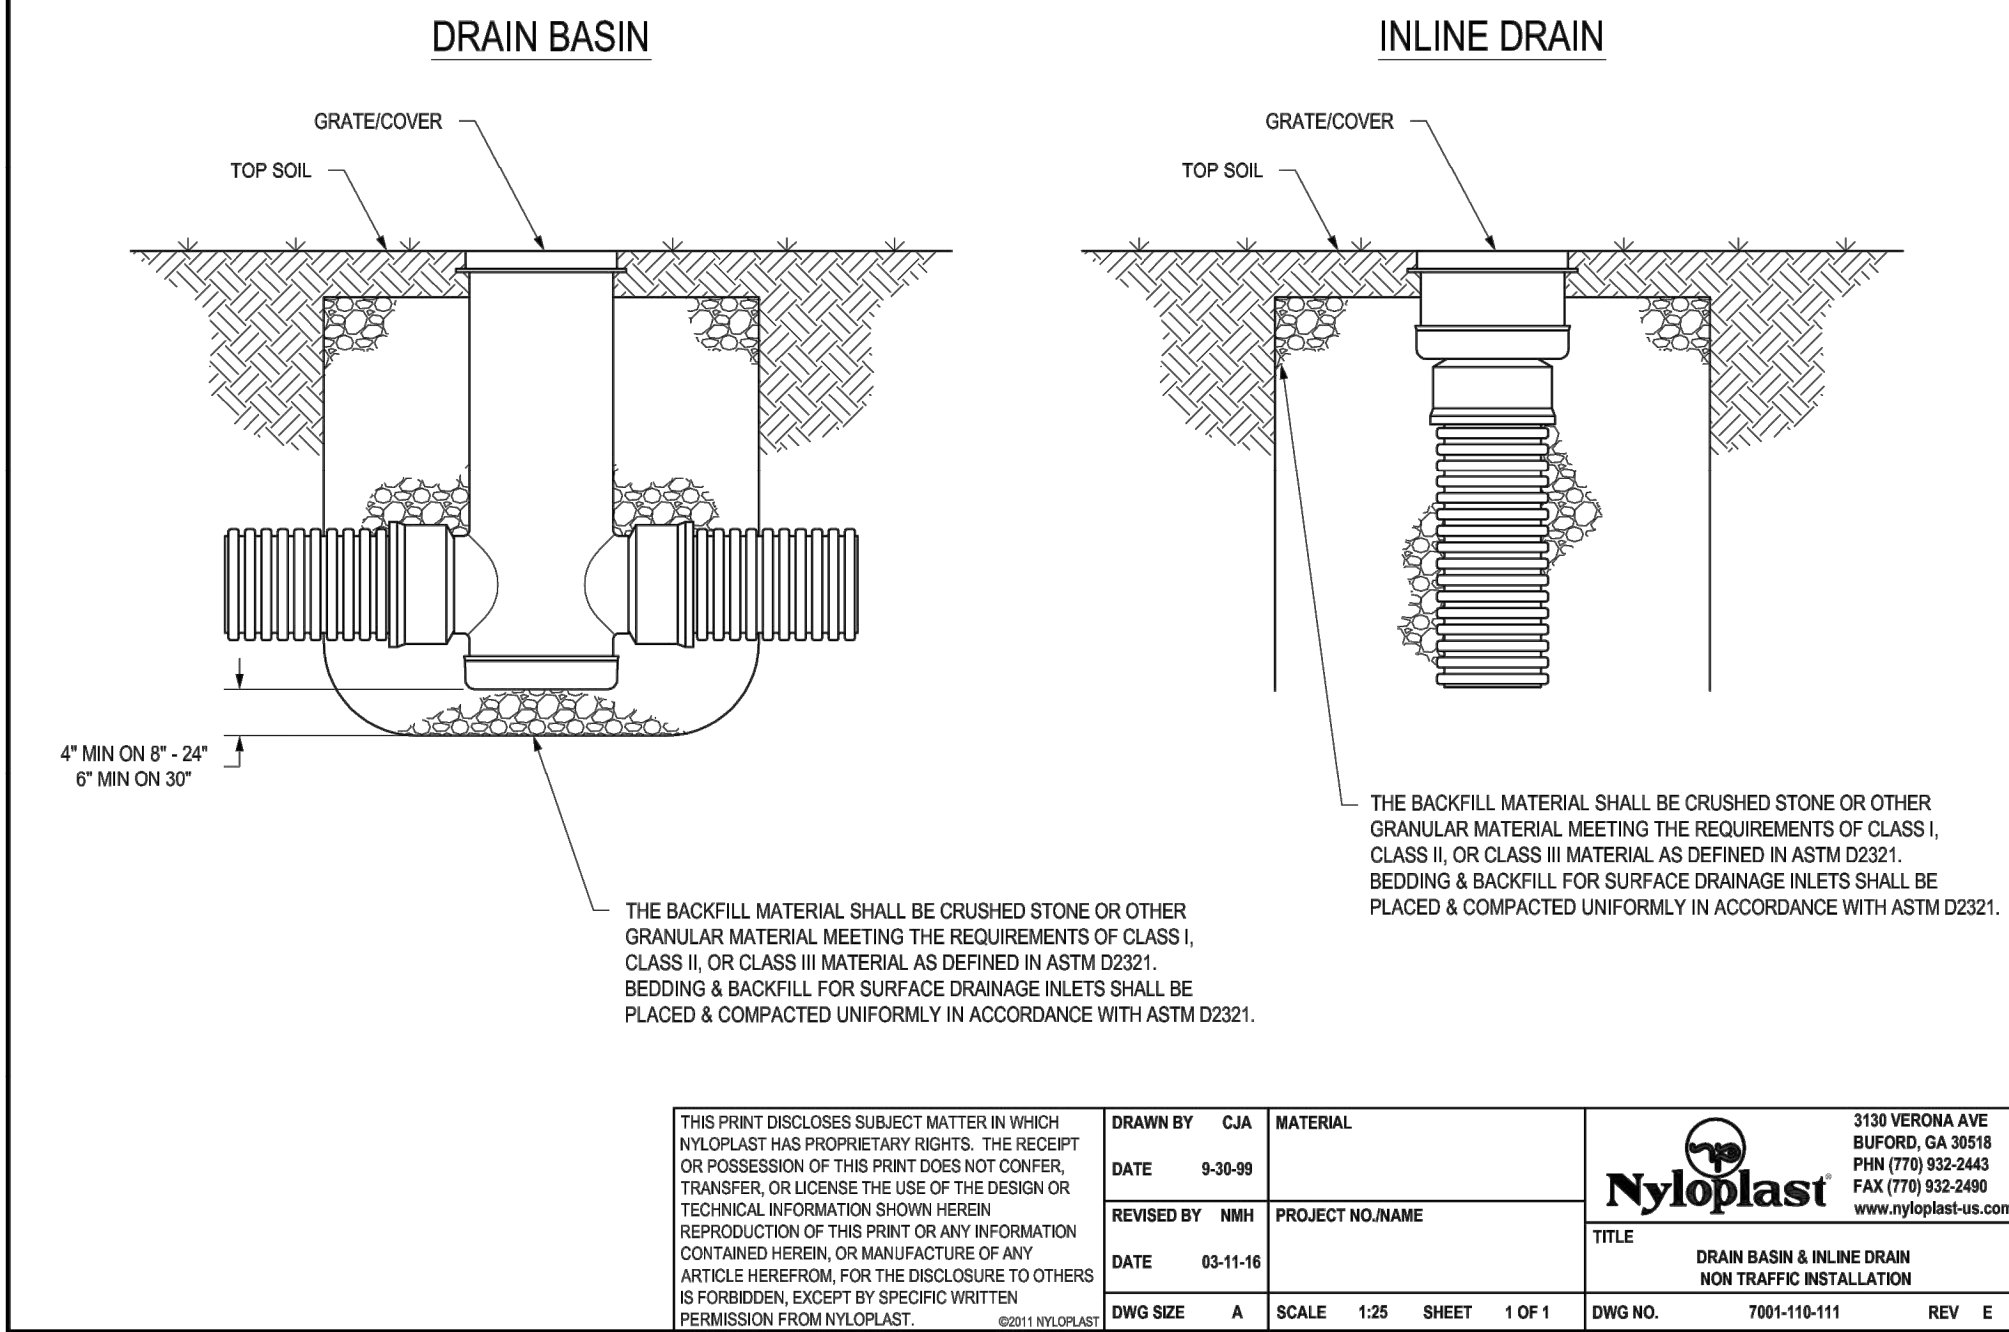

NYLOPLAST 18" INLINE DRAIN: 2718AG __ X

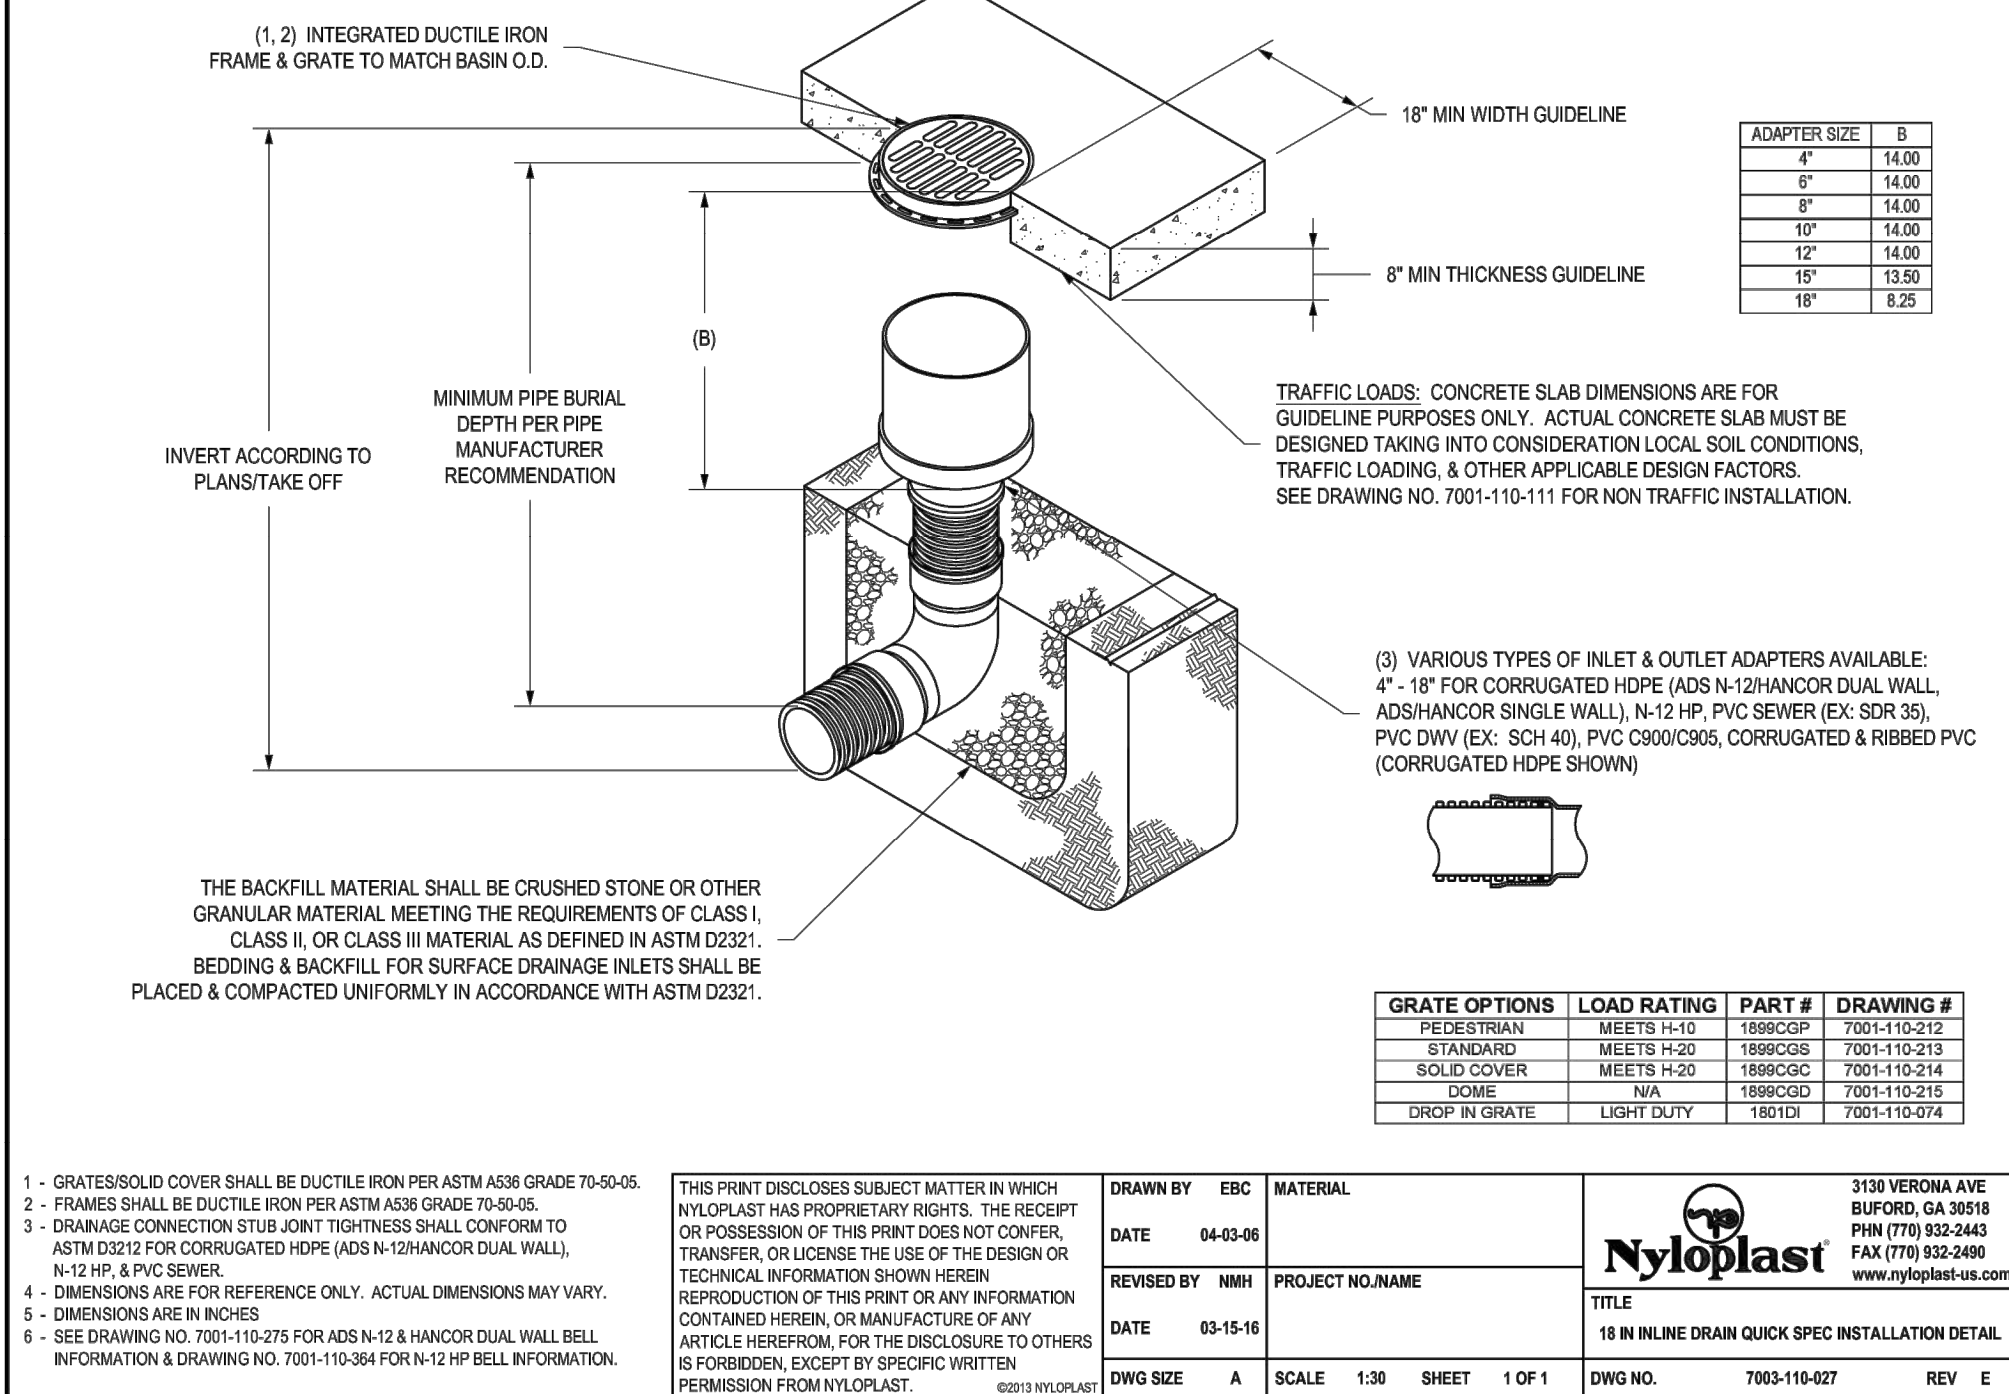

NYLOPLAST 18" DRAIN BASIN: 2818AG __ X

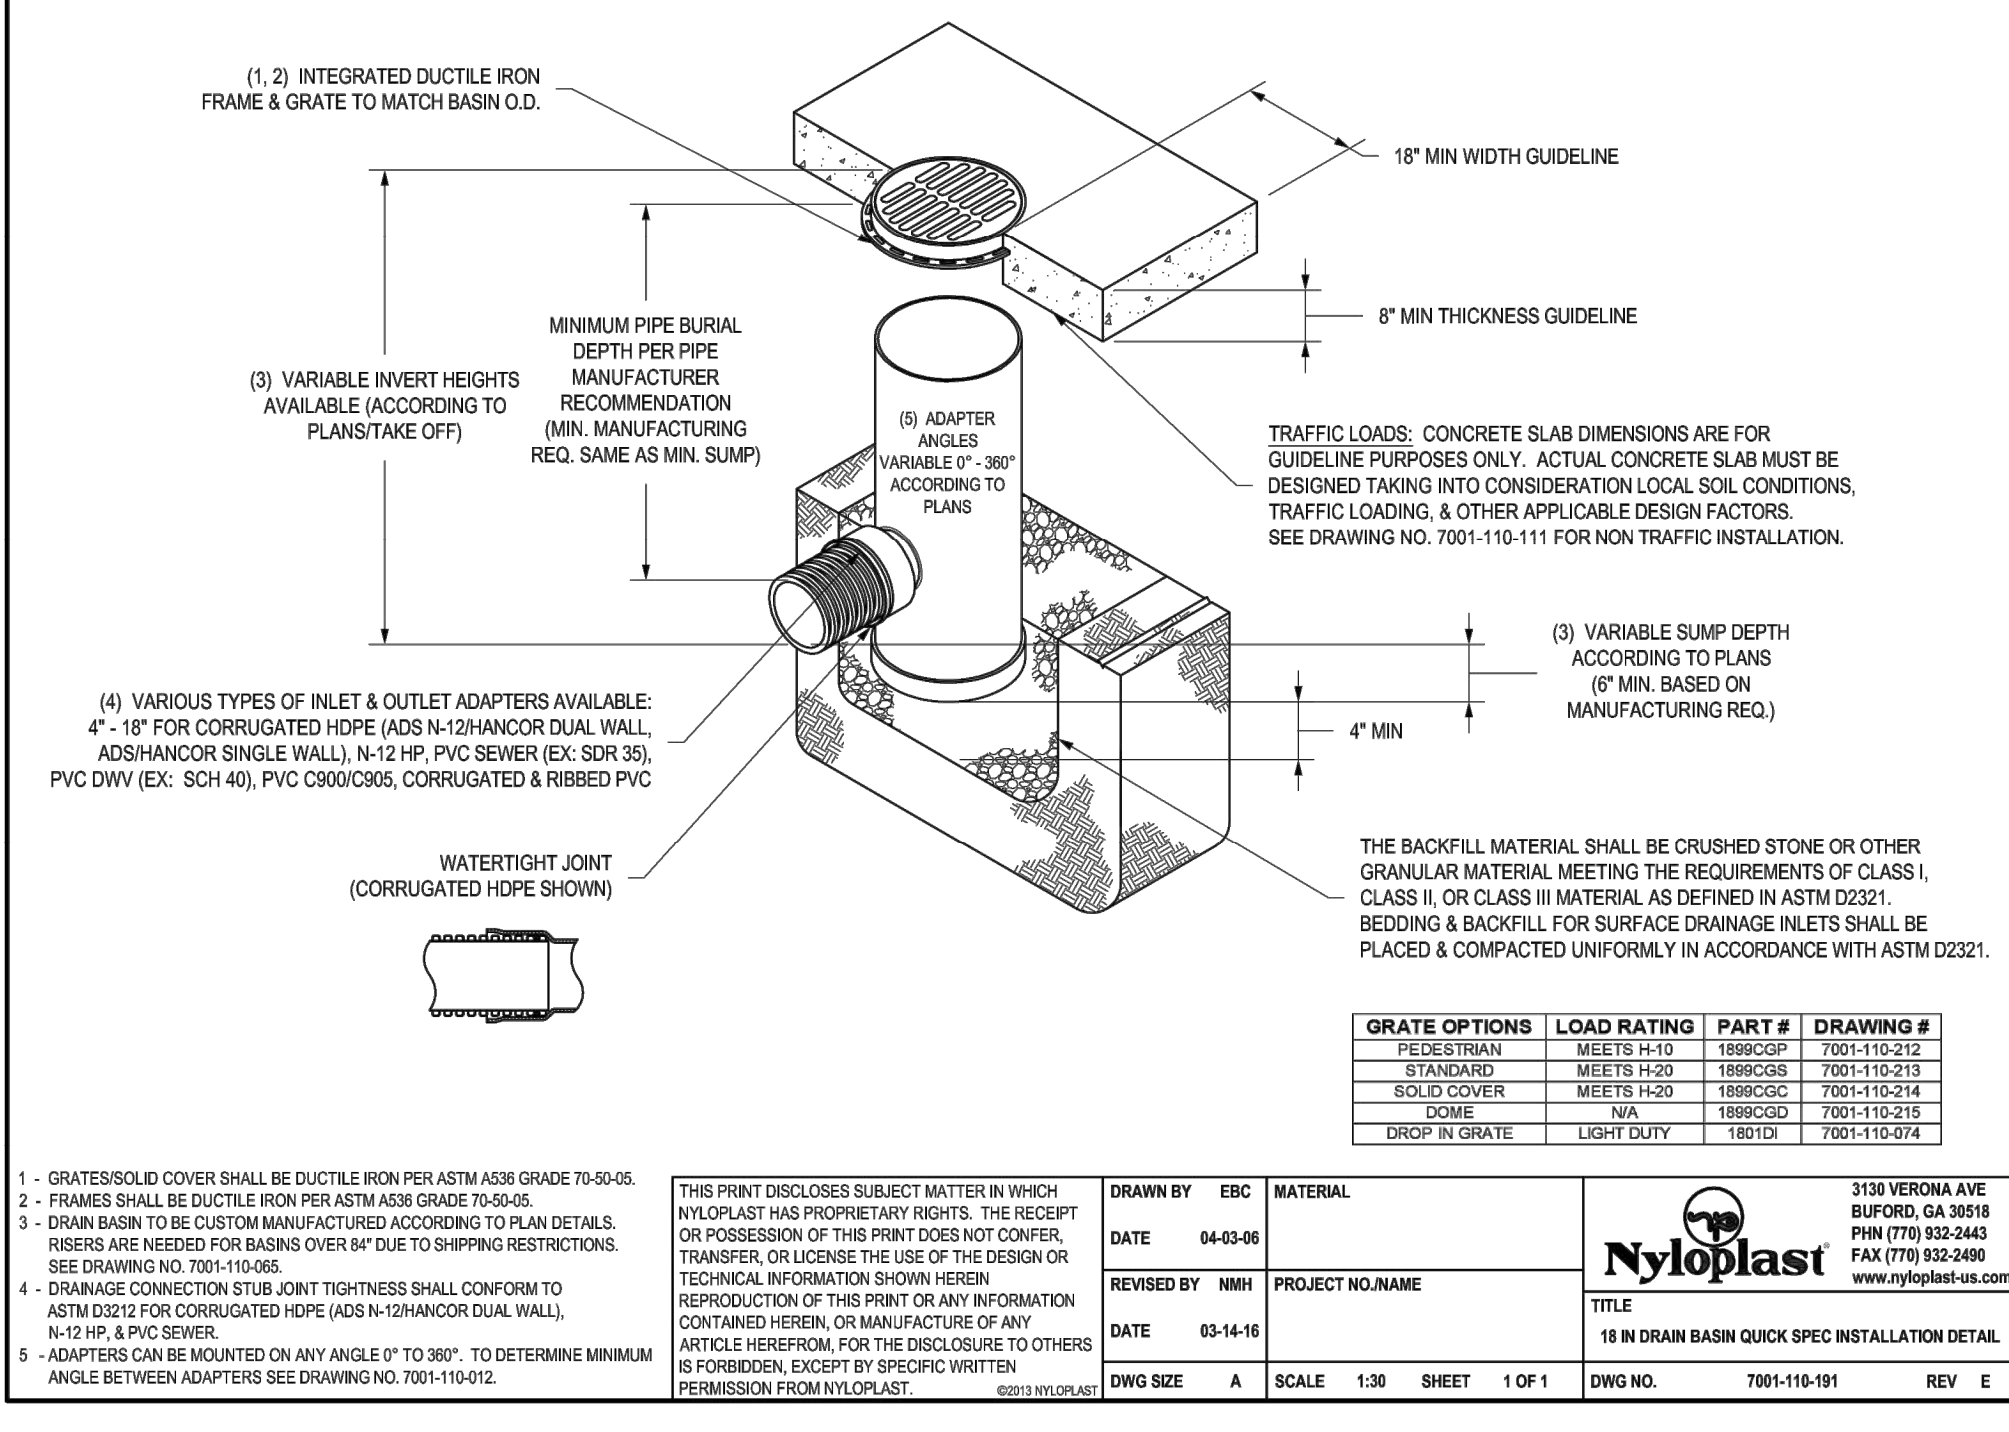

CIVIL ENGINEERING BY:



9801 Renner Boulevard
Lenexa, Kansas 66219
913.492.0400
www.gbateam.com



Clint Loumaster - Civil Engineer
License - Missouri #PE-2011009651



ACI/Boland, Inc.
Kansas City | St. Louis
1710 Wyandotte
Kansas City, MO 64108
T: 816.763.9600
Licensee's Certificate of Authority Number:
Missouri: #000958

MEP CONSULTANT

HENDERSON ENGINEERS, INC.
1801 MAIN STREET, SUITE #300
KANSAS CITY, MO 64108
T: 816.663.8700
Licensee's Certificate of Authority Number:
0000000000

STRUCTURAL CONSULTANT

BOB D. CAMPBELL & CO.
4338 BELLEVUE AVE
KANSAS CITY, MO 64111
T: 816.531.4144
Licensee's Certificate of Authority Number:
0000000000

LEE'S SUMMIT MEDICAL CENTER -
ICU EXPANSION
2100 SE BLUE PARKWAY
LEE'S SUMMIT, MISSOURI 64063

Date 1/10/2022
Job Number 3-21112
Drawn By HG
Checked By Checker

Revision
Number Date Description
3 2/11/2022
5 3/2/2022

C6.0

© 2021 ACI/BOLAND, Inc


Storm Sewer Details

12/16/2021 4:42:36 PM

C:\Users\hgrindel\Documents\3-21112 HCA LPMC_ICU_EXPANSION_R21_1grindelBKM62.rvt



Clint Loumaster - Civil Engineer
License - Missouri #PE-2011009651

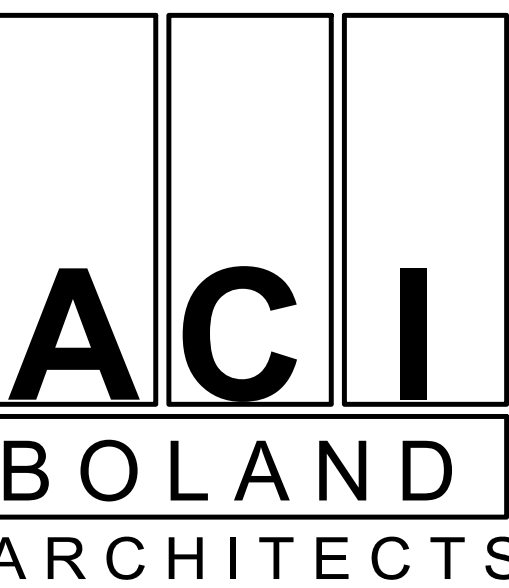

ACI/Boland, Inc.
Kansas City | St. Louis
1710 Wyandotte
Kansas City, MO 64108
T: 816.763.9600
Licensee's Certificate of Authority Number:
Missouri: #000958

MEP CONSULTANT
HENDERSON ENGINEERS, INC.
1801 MAIN STREET, SUITE #300
KANSAS CITY, MO 64108
T: 816.663.8700
Licensee's Certificate of Authority Number:
0000000000

STRUCTURAL CONSULTANT
BOB D. CAMPBELL & CO.
4338 BELLEVUE AVE
KANSAS CITY, MO 64111
T: 816.531.4144
Licensee's Certificate of Authority Number:
0000000000

LEE'S SUMMIT MEDICAL CENTER -
ICU EXPANSION
2100 SE BLUE PARKWAY
LEE'S SUMMIT, MISSOURI 64063

Date 1/10/2022
Job Number 3-21112
Drawn By HG
Checked By Checker

Revision
Number Date Description
3 2/11/2022

C7.0


© 2021 ACI/BOLAND, Inc

Erosion Control Details

CIVIL ENGINEERING BY:



9801 Renner Boulevard
Lenexa, Kansas 66219
913.492.0400
www.gbateam.com

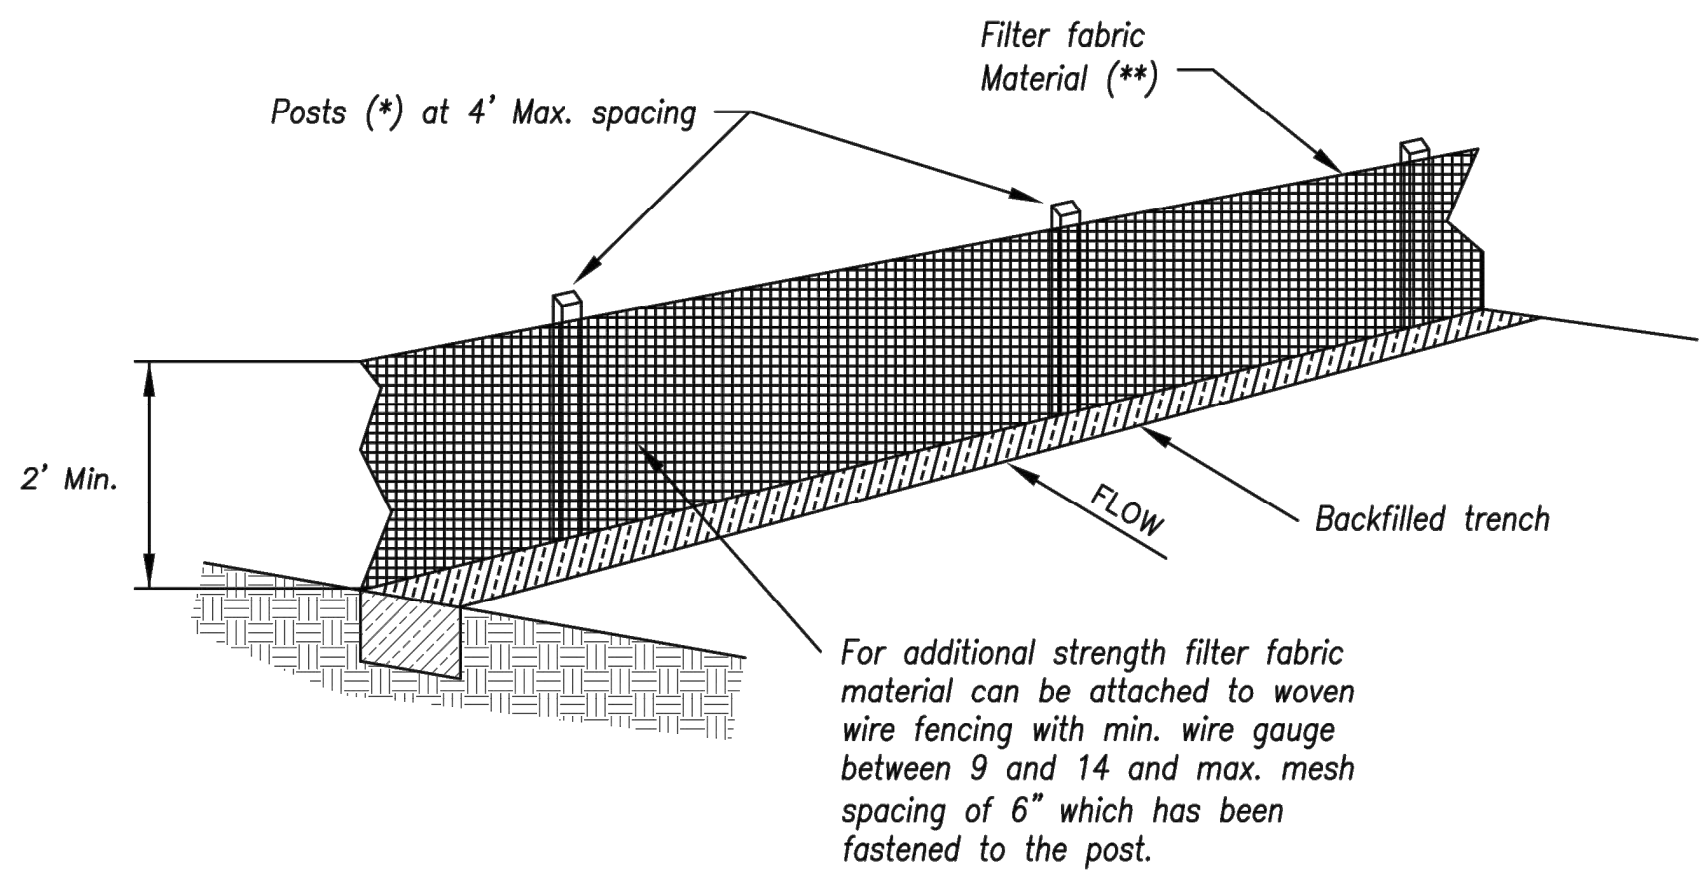


(*) POSTS

- MIN. LENGTH 4'
- HARDWOOD 1 3/8" x 1 3/8"
- NO.2 SOUTHERN PINE 2 5/8" x 2 5/8"
- STEEL 1.33 LB/FT

() -** Geotextile Fabric shall meet the requirements of AASHTO M288

SILT FENCE DETAILS

Not to Scale

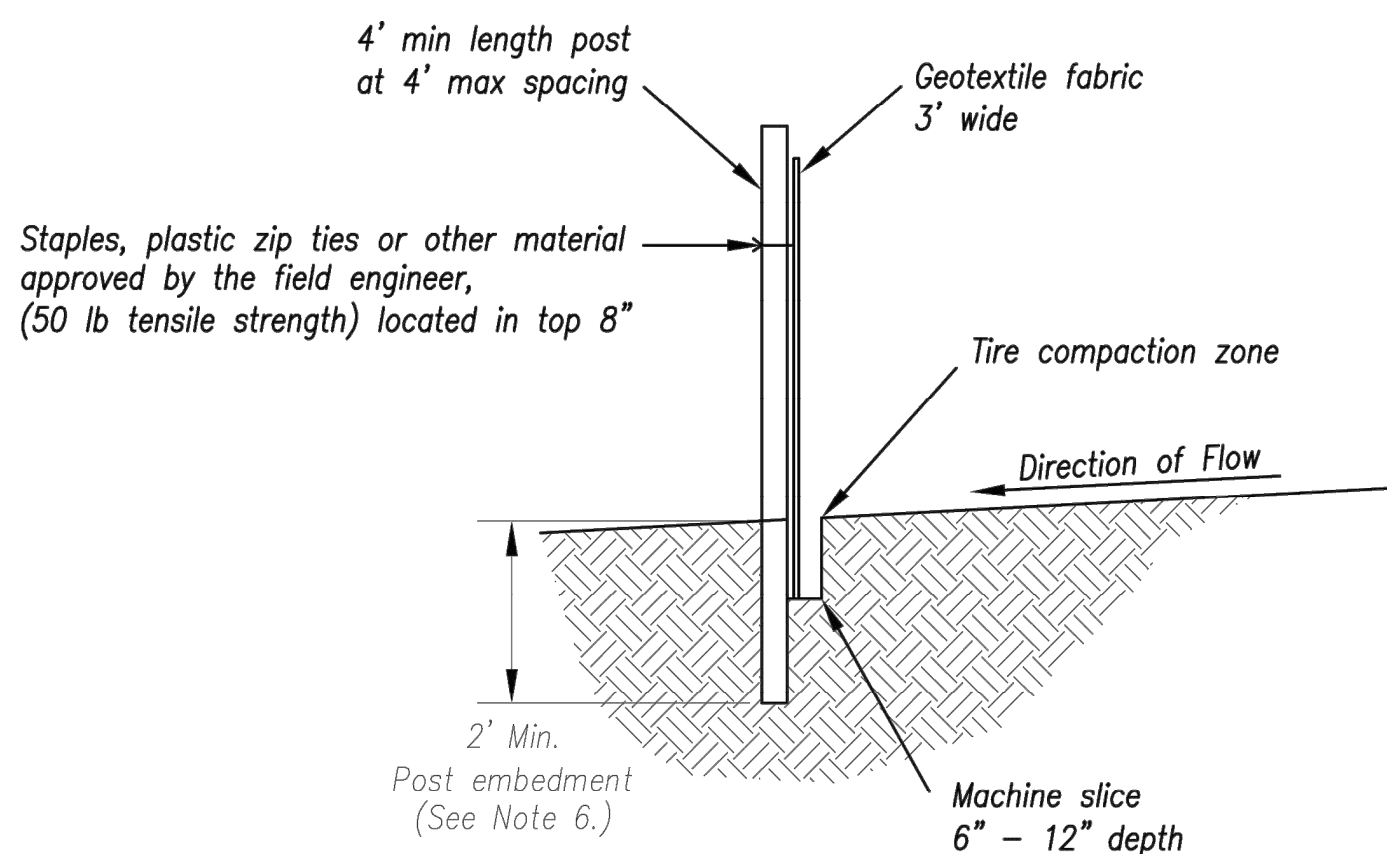

Notes:

1. In order to contain water, the ends of the silt fence must be turned uphill (Figure A).
2. Long perimeter runs of silt fence must be limited to 100'. Runs should be broken up into several smaller segments to minimize water concentrations (Figure A).
3. Long slopes should be broken up with intermediate rows of silt fence to slow runoff velocities.
4. Attach fabric to upstream side of post.
5. Install posts a minimum of 2' into the ground.
6. Trenching will only be allowed for small or difficult installation, where slicing machine cannot be reasonably used.

Maintenance:

1. Remove and dispose of sediment deposits when the deposit approaches 1/2 the height of silt fence.
2. Repair as necessary to maintain function and structure.



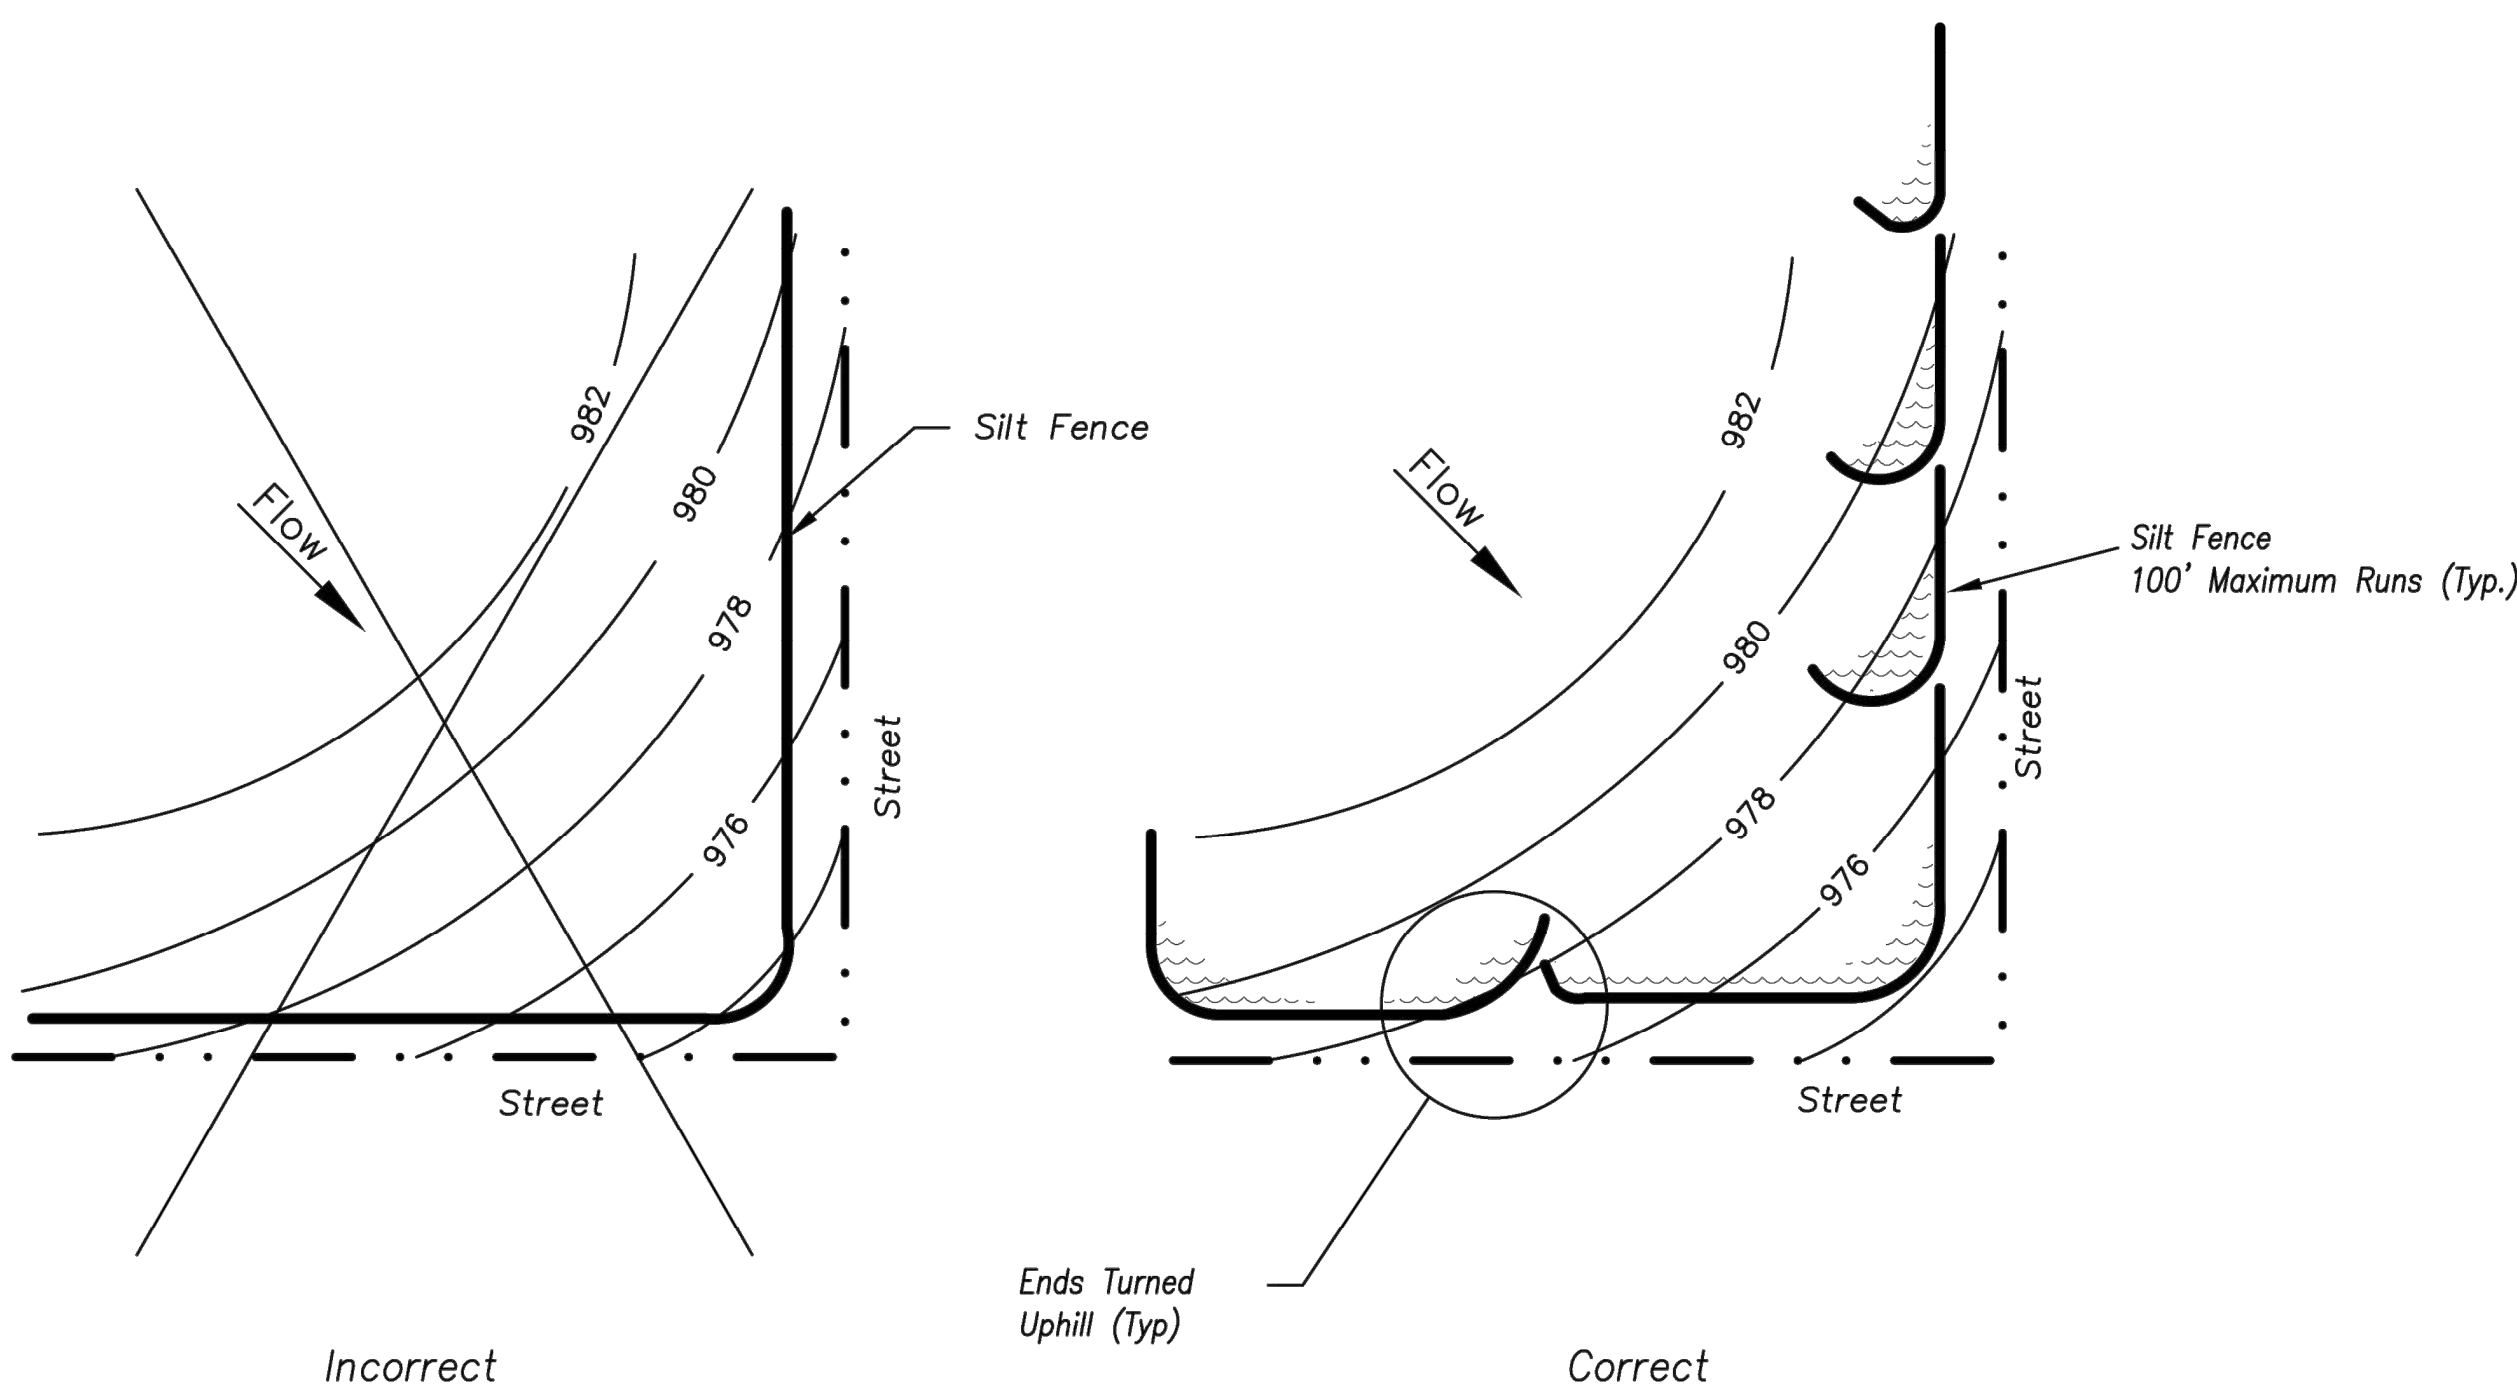


Figure A

SILT FENCE LAYOUT

Not to Scale

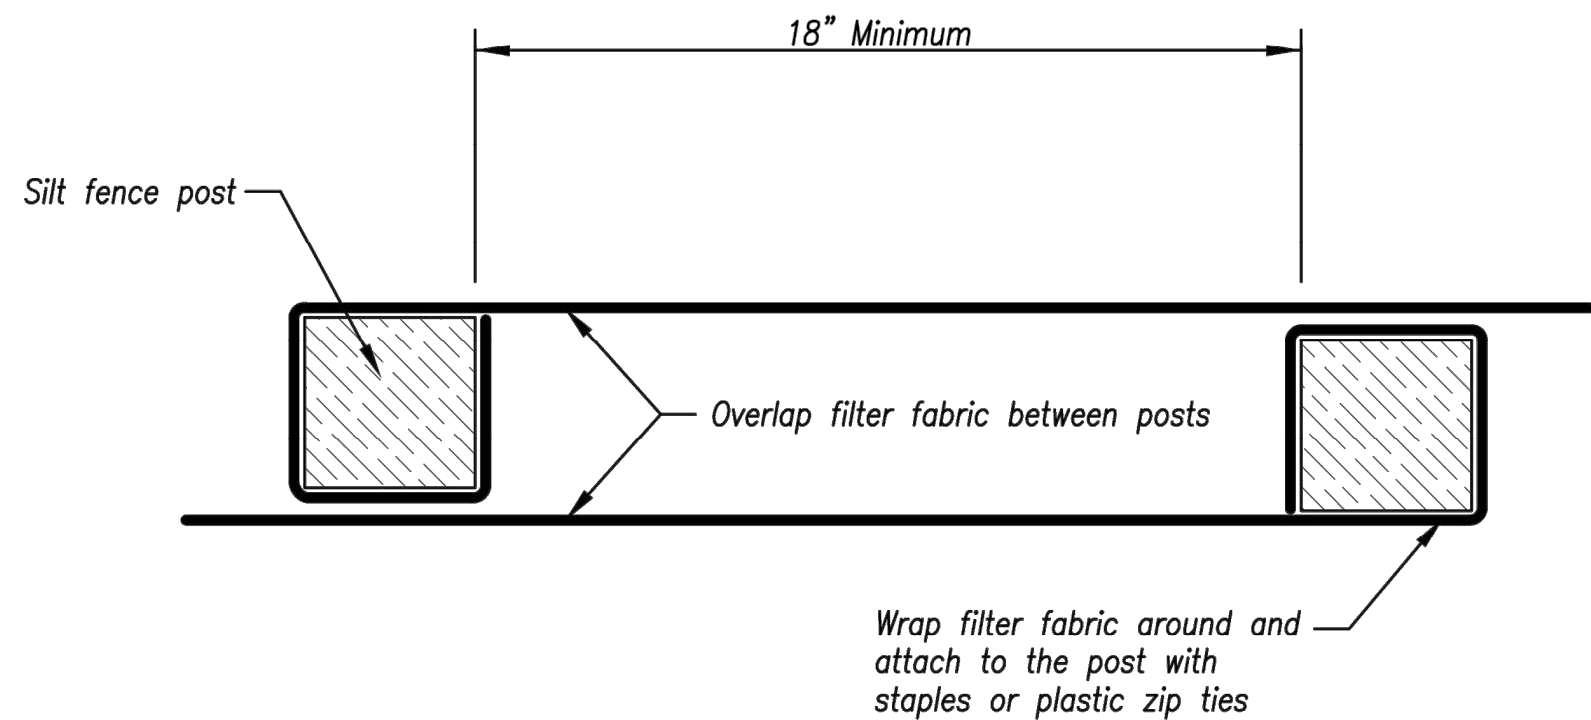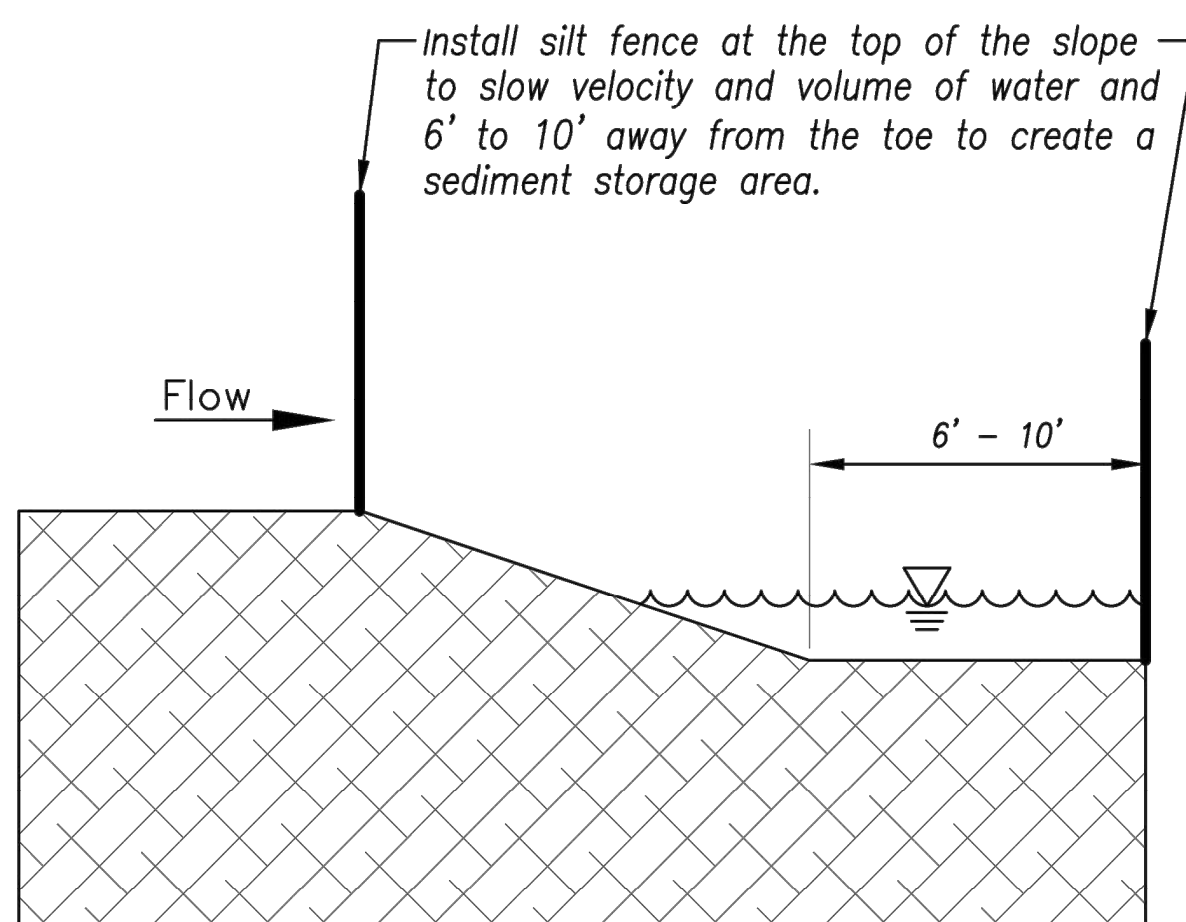

JOINING FENCE SECTIONS

Not to Scale

AMERICAN PUBLIC WORKS ASSOCIATION



KANSAS CITY
METRO CHAPTER



SILT FENCE

STANDARD DRAWING
NUMBER ESC-03
ADOPTED:
10/24/2016


Modified from 2015 Overland Park Standard Details
for Erosion and Sediment Control.

12/16/2021 4:42:36 PM



C:\Users\hgrindel\Documents\3-21112 HCA LS\MC_ICU_EXPANSION_R21_hgrindel\BKM52.rvt

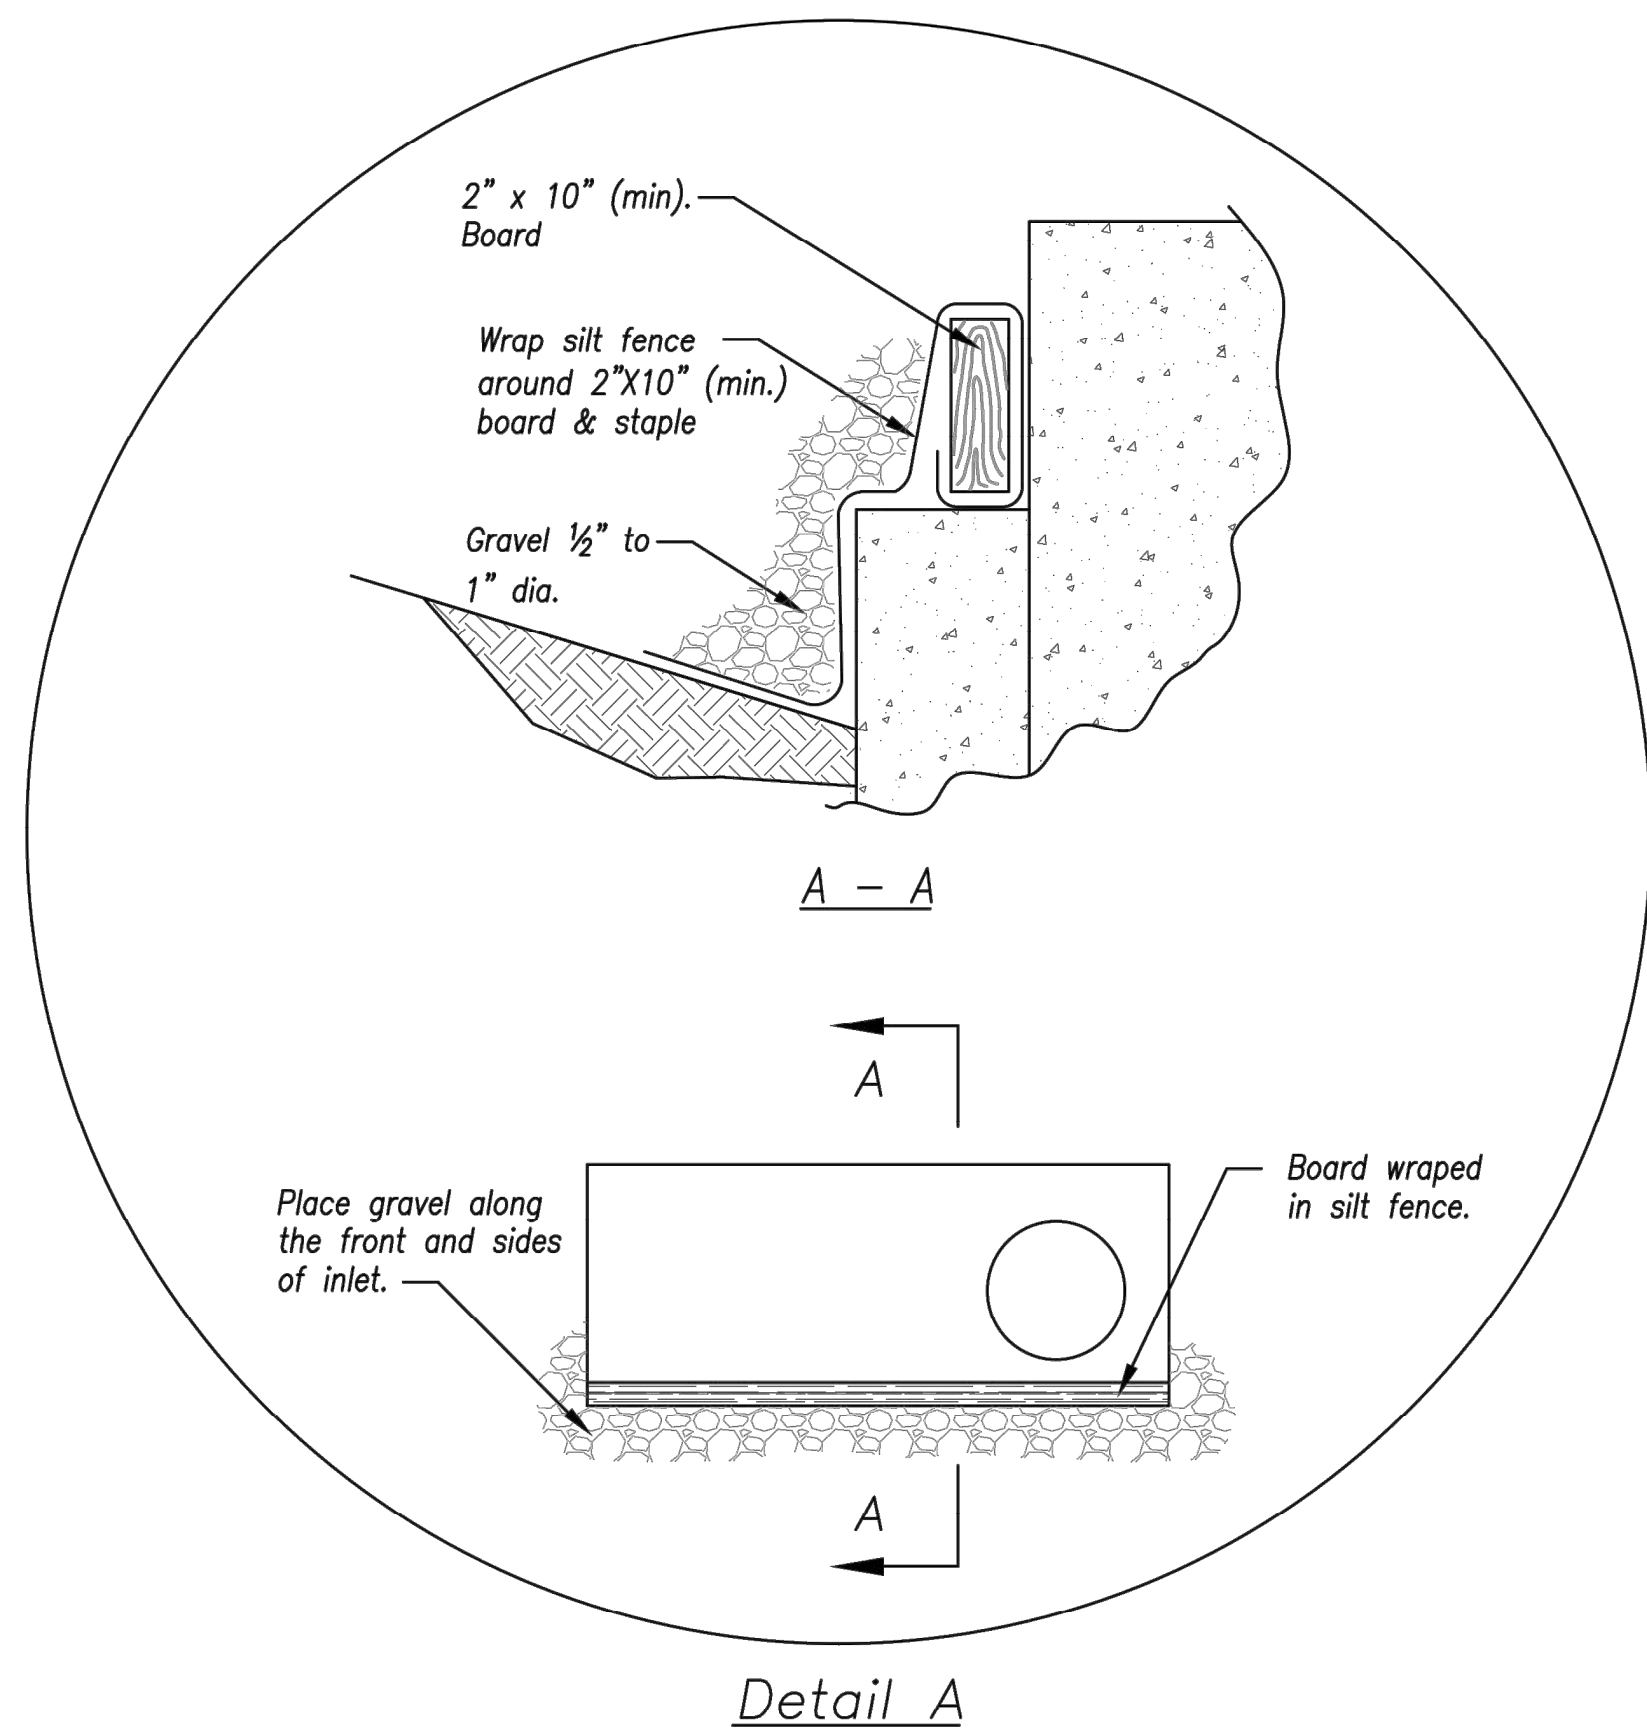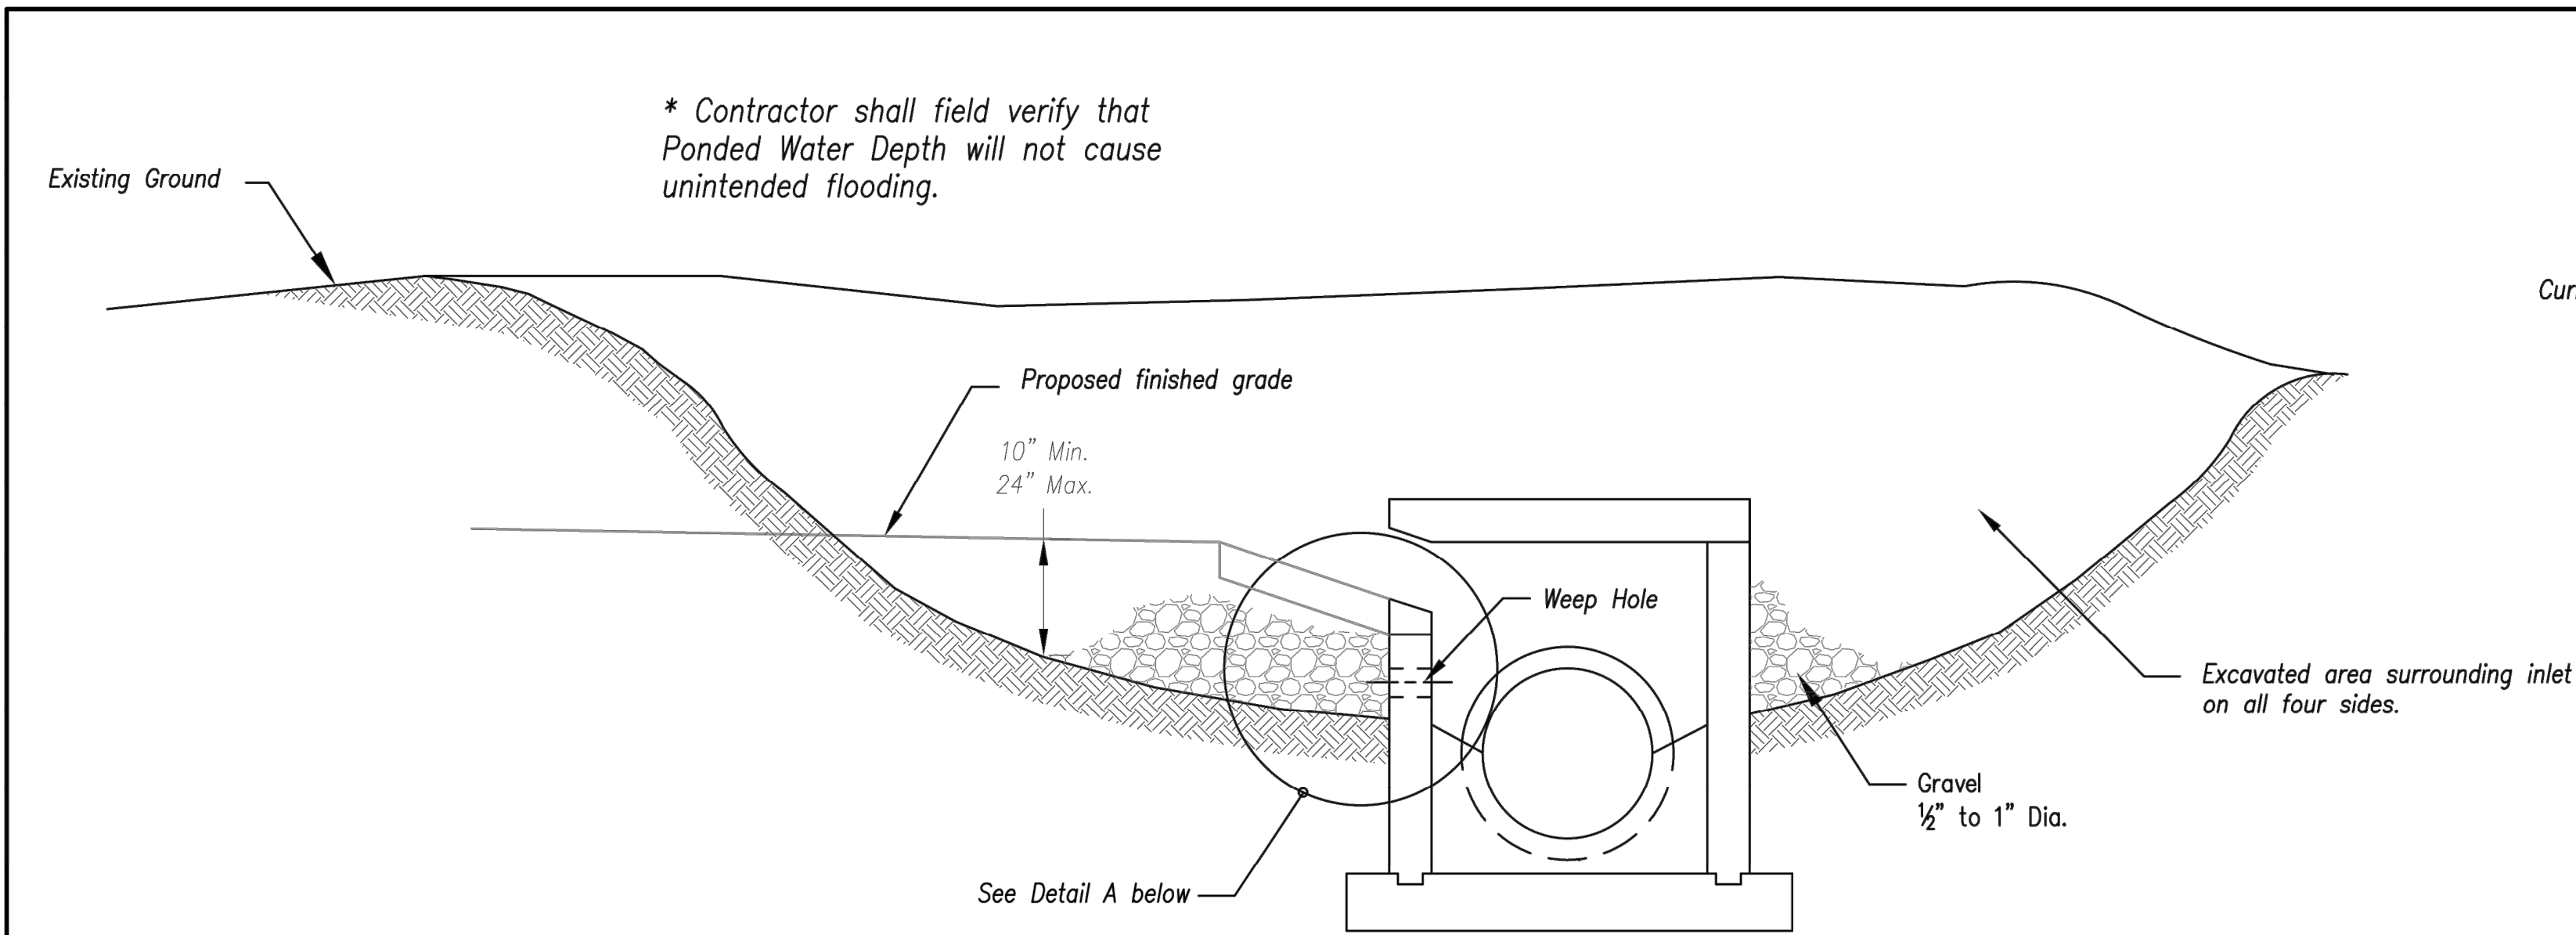

EARLY STAGE CURB INLET
(Open Box and Prior to Pouring Curb and Inlet Throat)

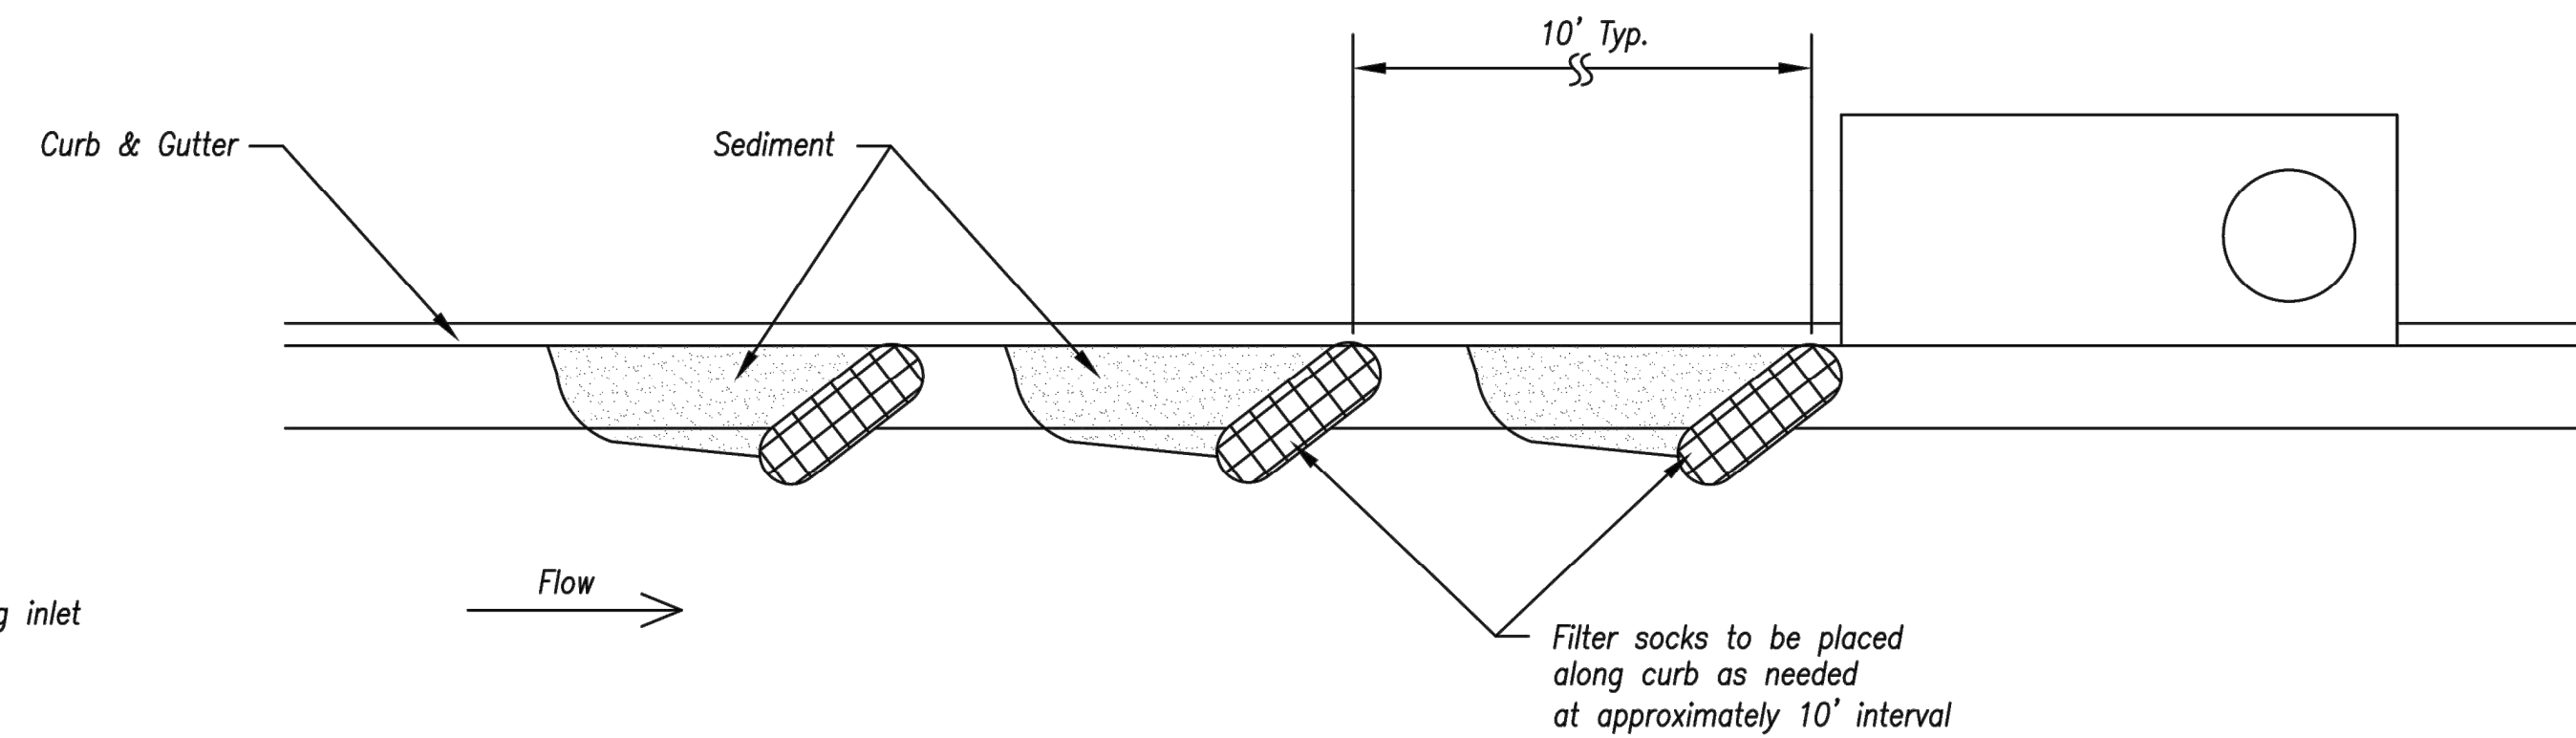

On Grade Curb Inlet Protection

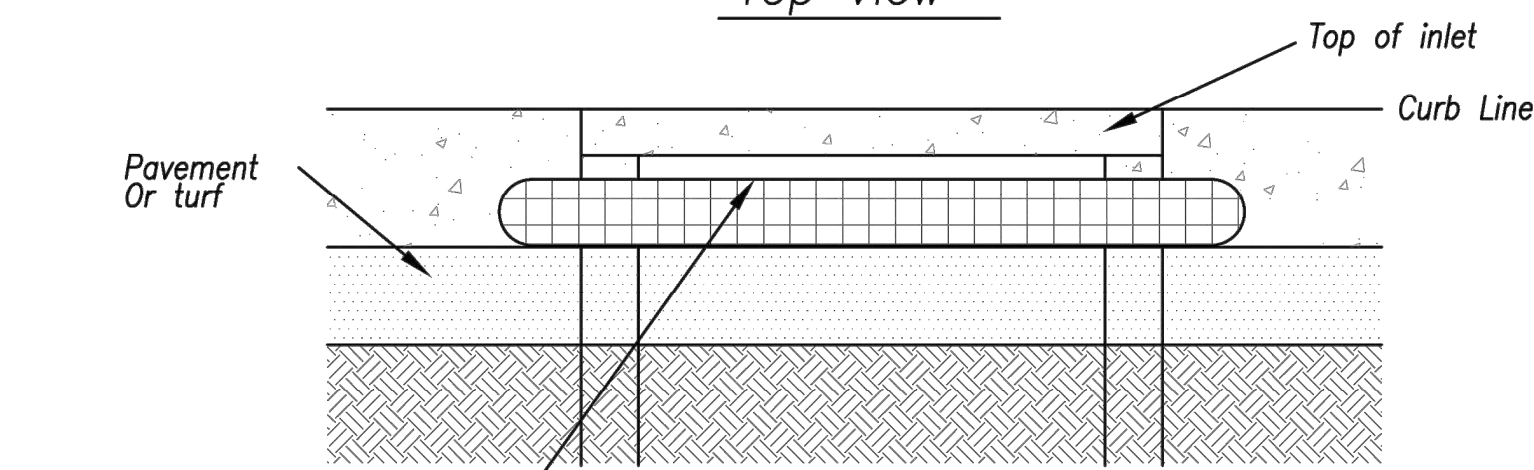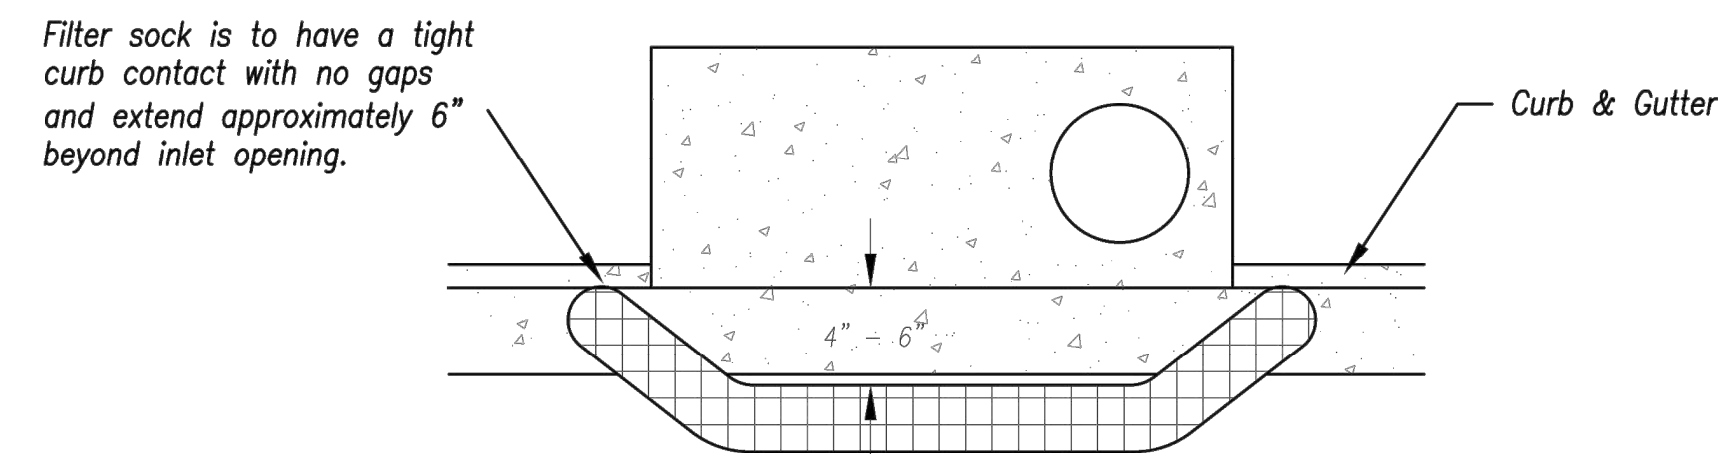

Height of filter sock should not be above the top of the inlet.

Sump Inlet Sediment Filter

LATE STAGE CURB INLET
(After Pouring Curb and Inlet Throat)

AMERICAN PUBLIC WORKS ASSOCIATION	
	KANSAS CITY METRO CHAPTER
CURB INLET PROTECTION	STANDARD DRAWING NUMBER ESC-06
	ADOPTED: 10/24/2016

Modified from 2015 Overland Park Standard Details for Erosion and Sediment Control.

Notes:

1. Immediately following inlet construction and prior to construction of curb and inlet throat, protect inlet opening by installing 2" X 10" (min.) board wrapped in silt fence. Structures shall have excavated storage area on all four sides to allow settling of sediment (Early Stage Curb Inlet).
2. When inlet is completed and curb poured, filter socks or approved equal should be used (Late Stage Curb Inlet). Straw wattles are not approved for curb inlet use.
3. Contractor to field verify ponding water shall not create a traffic hazard.

Maintenance:

1. Remove deposited sediment from excavated storage areas when available storage has been reduced by 20%.
2. Remove deposited sediment from filter socks or similar when any accumulation of sediment is visible.
3. Repair or replace as necessary to maintain function and integrity of installation.



Clint Loumaster - Civil Engineer
License - Missouri #PE-2011009651



ACI/Boland, Inc.
Kansas City | St. Louis
1710 Wyandotte
Kansas City, MO 64108
T: 816.763.9600
Licensee's Certificate of Authority Number: Missouri: #000958

MEP CONSULTANT

HENDERSON ENGINEERS, INC.
1801 MAIN STREET, SUITE #300
KANSAS CITY, MO 64108
T: 816.663.8700
Licensee's Certificate of Authority Number: 0000000000

STRUCTURAL CONSULTANT

BOB D. CAMPBELL & CO.
4338 BELLEVUE AVE
KANSAS CITY, MO 64111
T: 816.531.4144
Licensee's Certificate of Authority Number: 0000000000

LEE'S SUMMIT MEDICAL CENTER -
ICU EXPANSION
2100 SE BLUE PARKWAY
LEE'S SUMMIT, MISSOURI 64063

Date 1/10/2022
Job Number 3-21112
Drawn By HG
Checked By Checker

Revision
Number Date Description
3 2/11/2022

CIVIL ENGINEERING BY:


GBA

9801 Renner Boulevard
Lenexa, Kansas 66219
913.492.0400
www.gbateam.com


C8.0

© 2021 ACI/BOLAND, Inc


Erosion Control Details

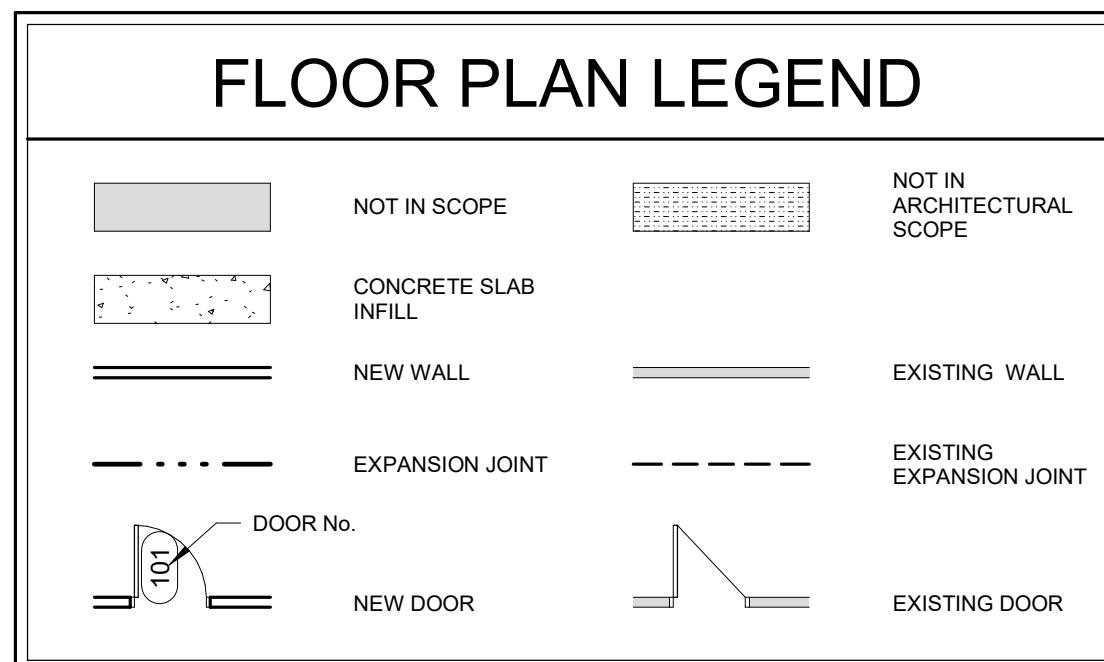


© 2021 ACI/BOLAND, Inc

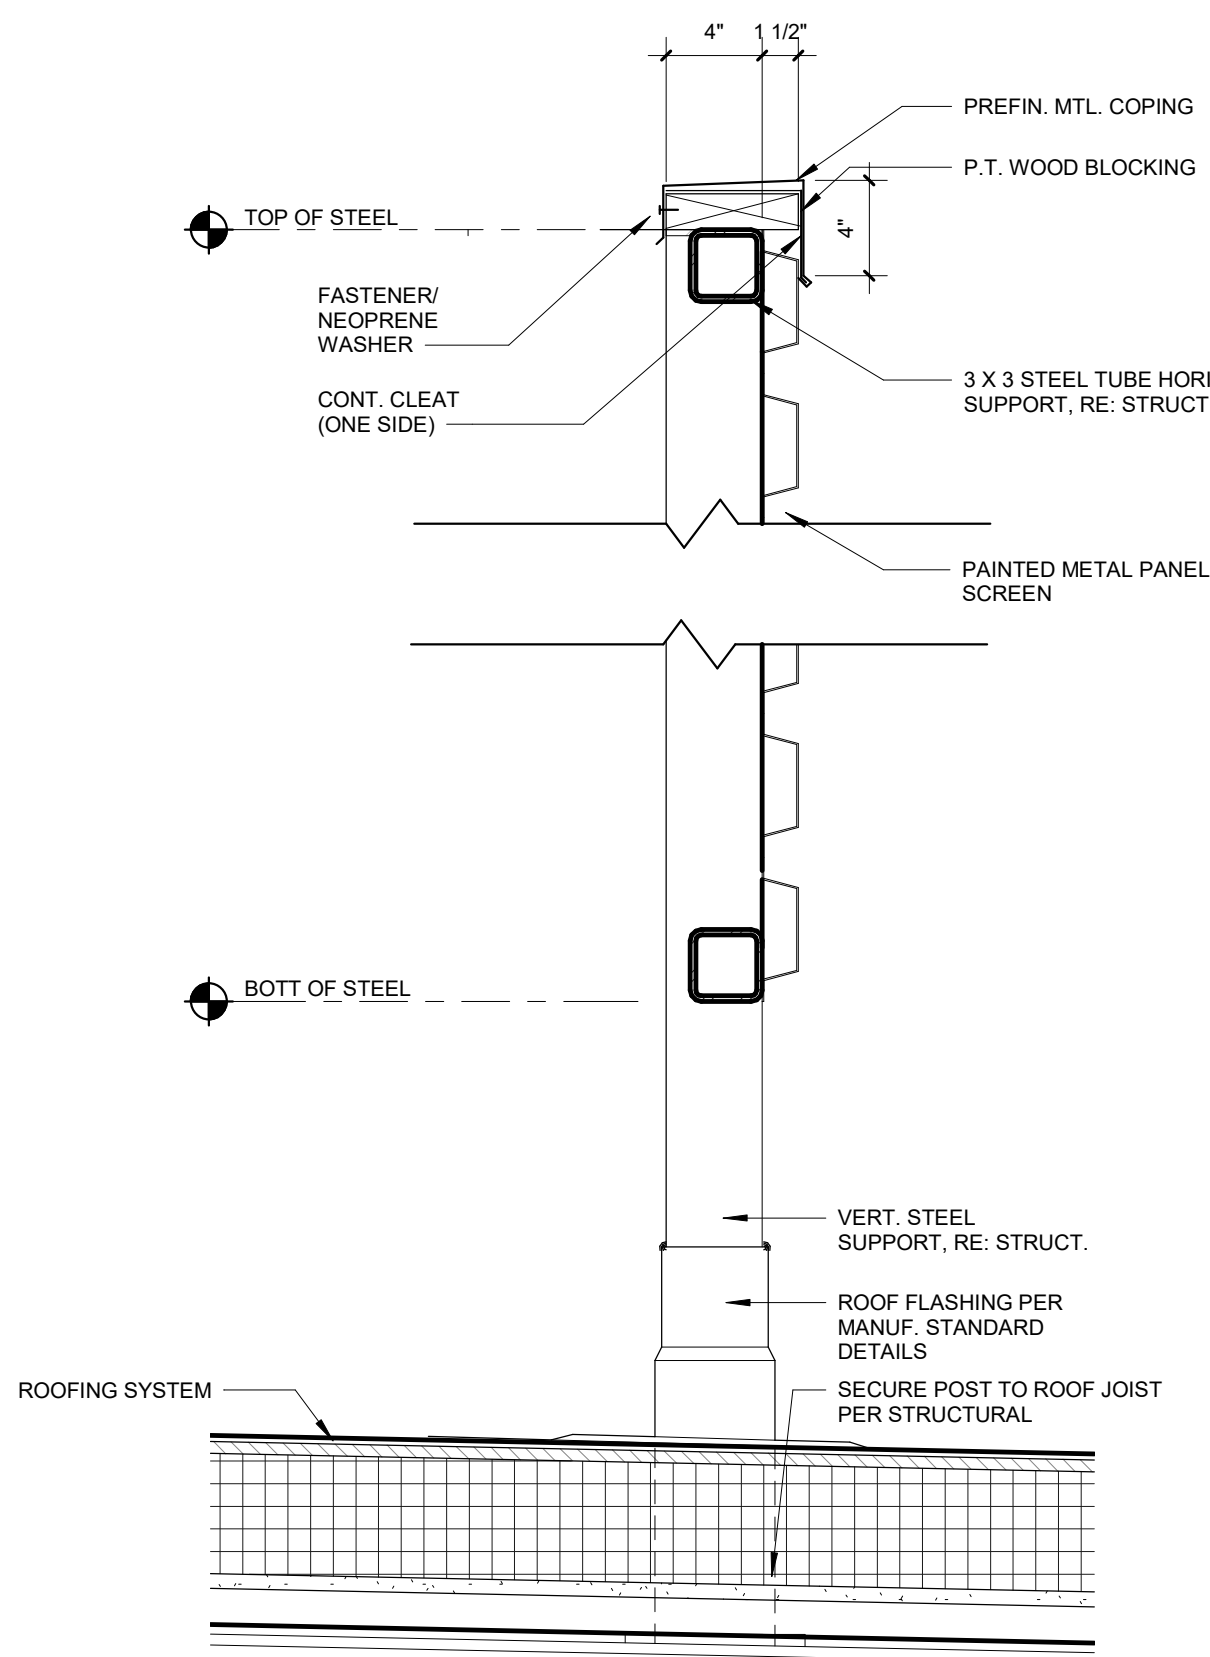

D6 ROOF SCREEN DETAIL
1 1/2" = 1'-0"

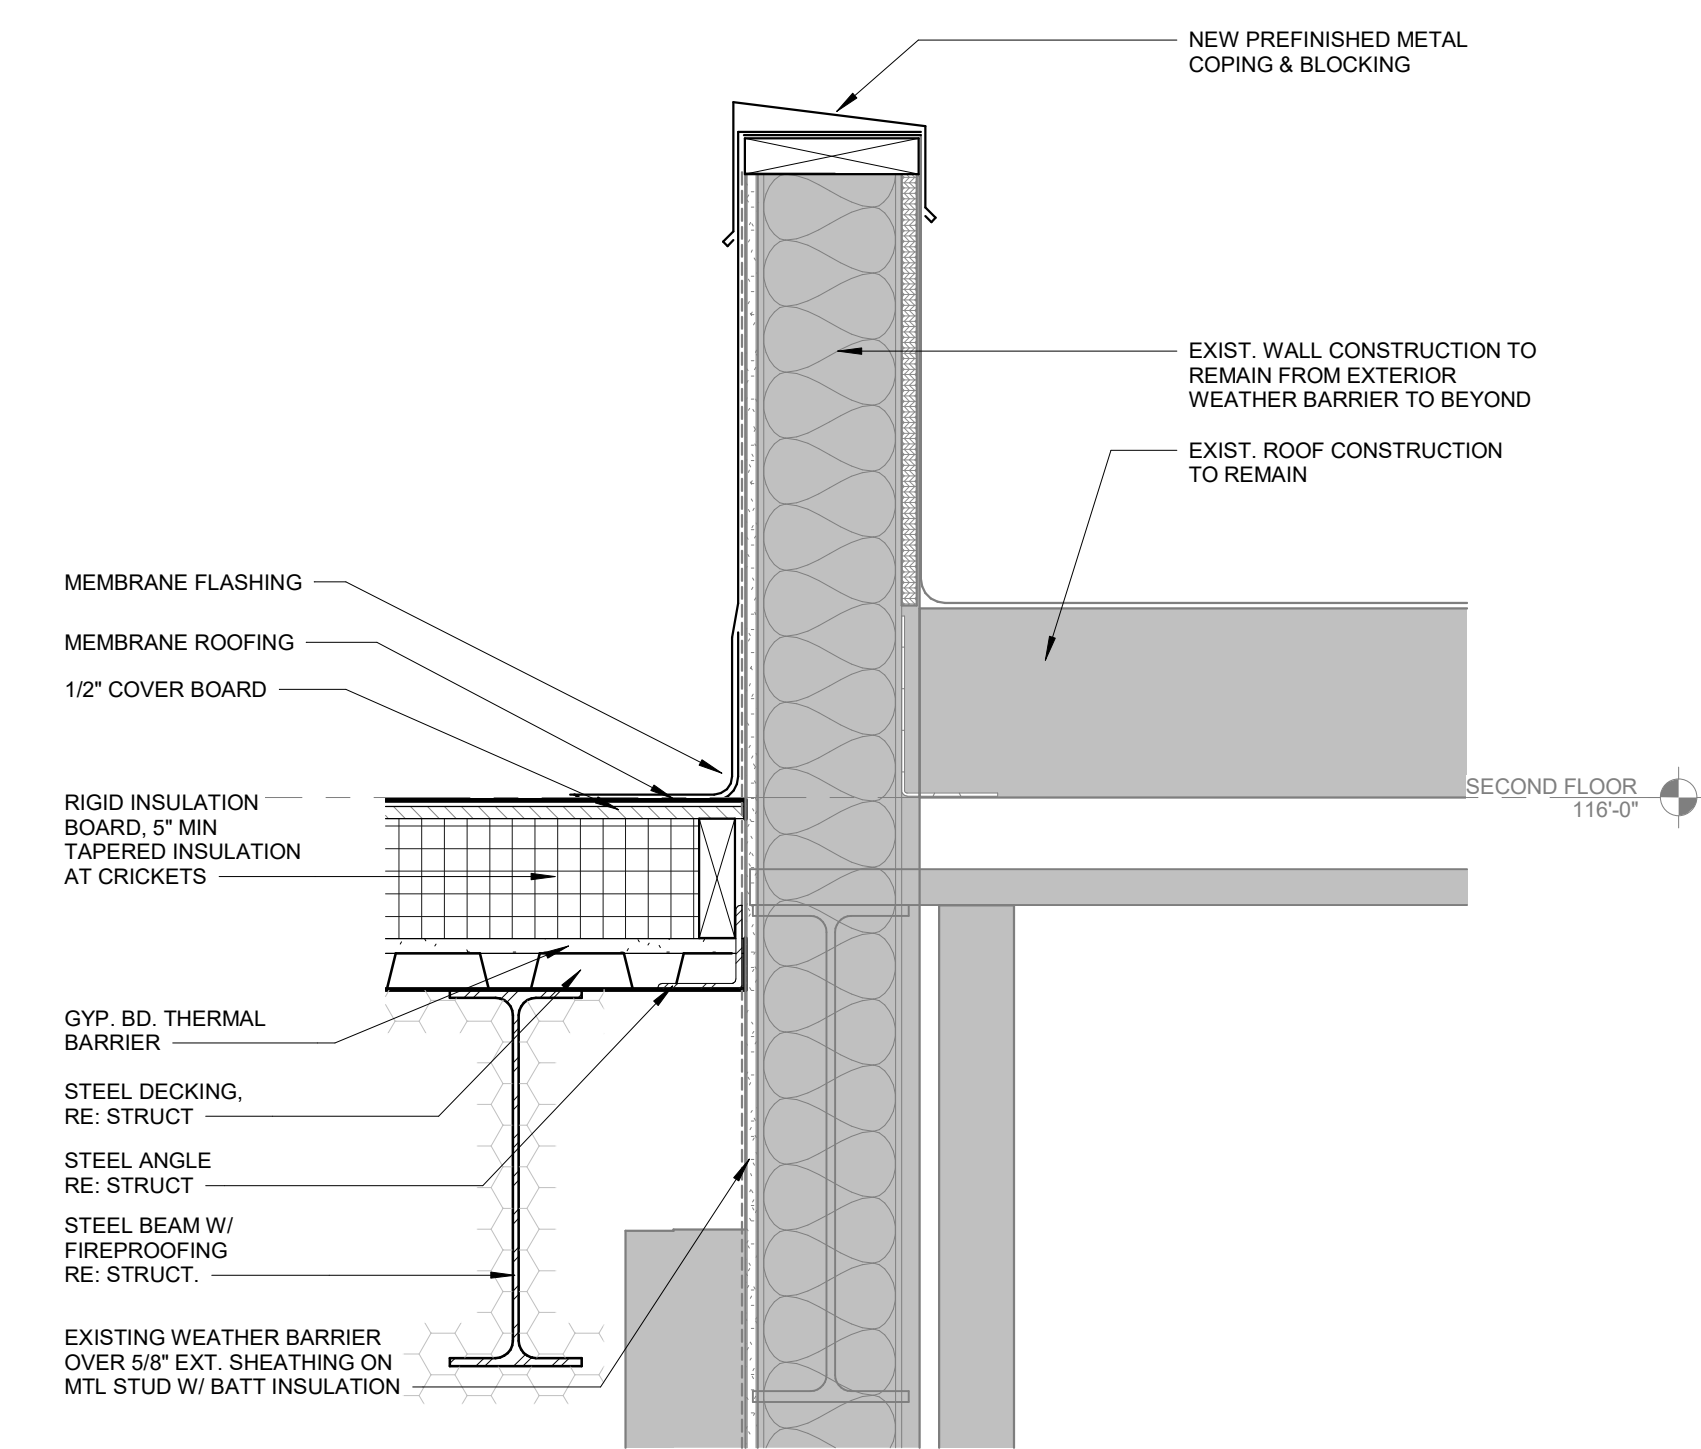


B6 DETAIL - SOUTH ROOF
1 1/2" = 1'-0"

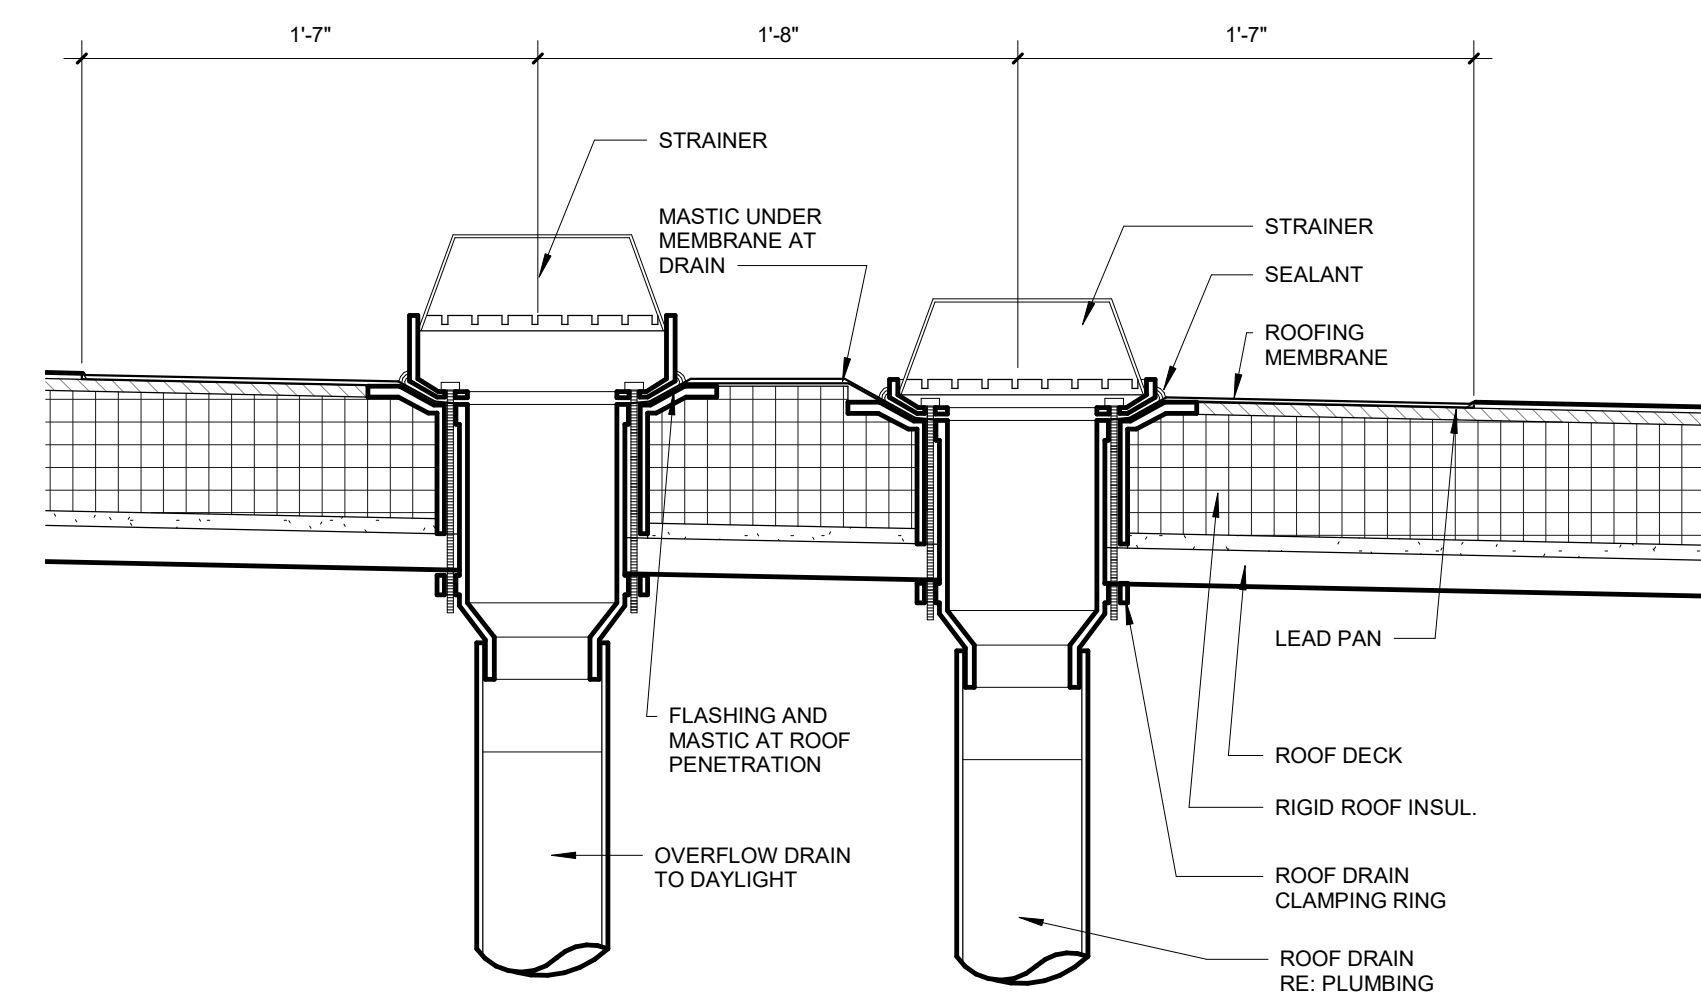

A6 ROOF DRAIN W/ OVERFLOW DETAIL
1 1/2" = 1'-0"

KEYNOTES - ROOF PLAN

Number	Comments
1	PREFINISHED SHEET METAL COPING
2	TAPERED INSULATION AT CRICKETS WITH 1/4"FT. SLOPE
3	F.R. EXPANSION JOINT
4	SINGLE-PLY ROOF MEMBRANE ON RIGID INSULATION
5	MECHANICAL EQUIPMENT, RE. MECH.
6	ROOF SCREEN

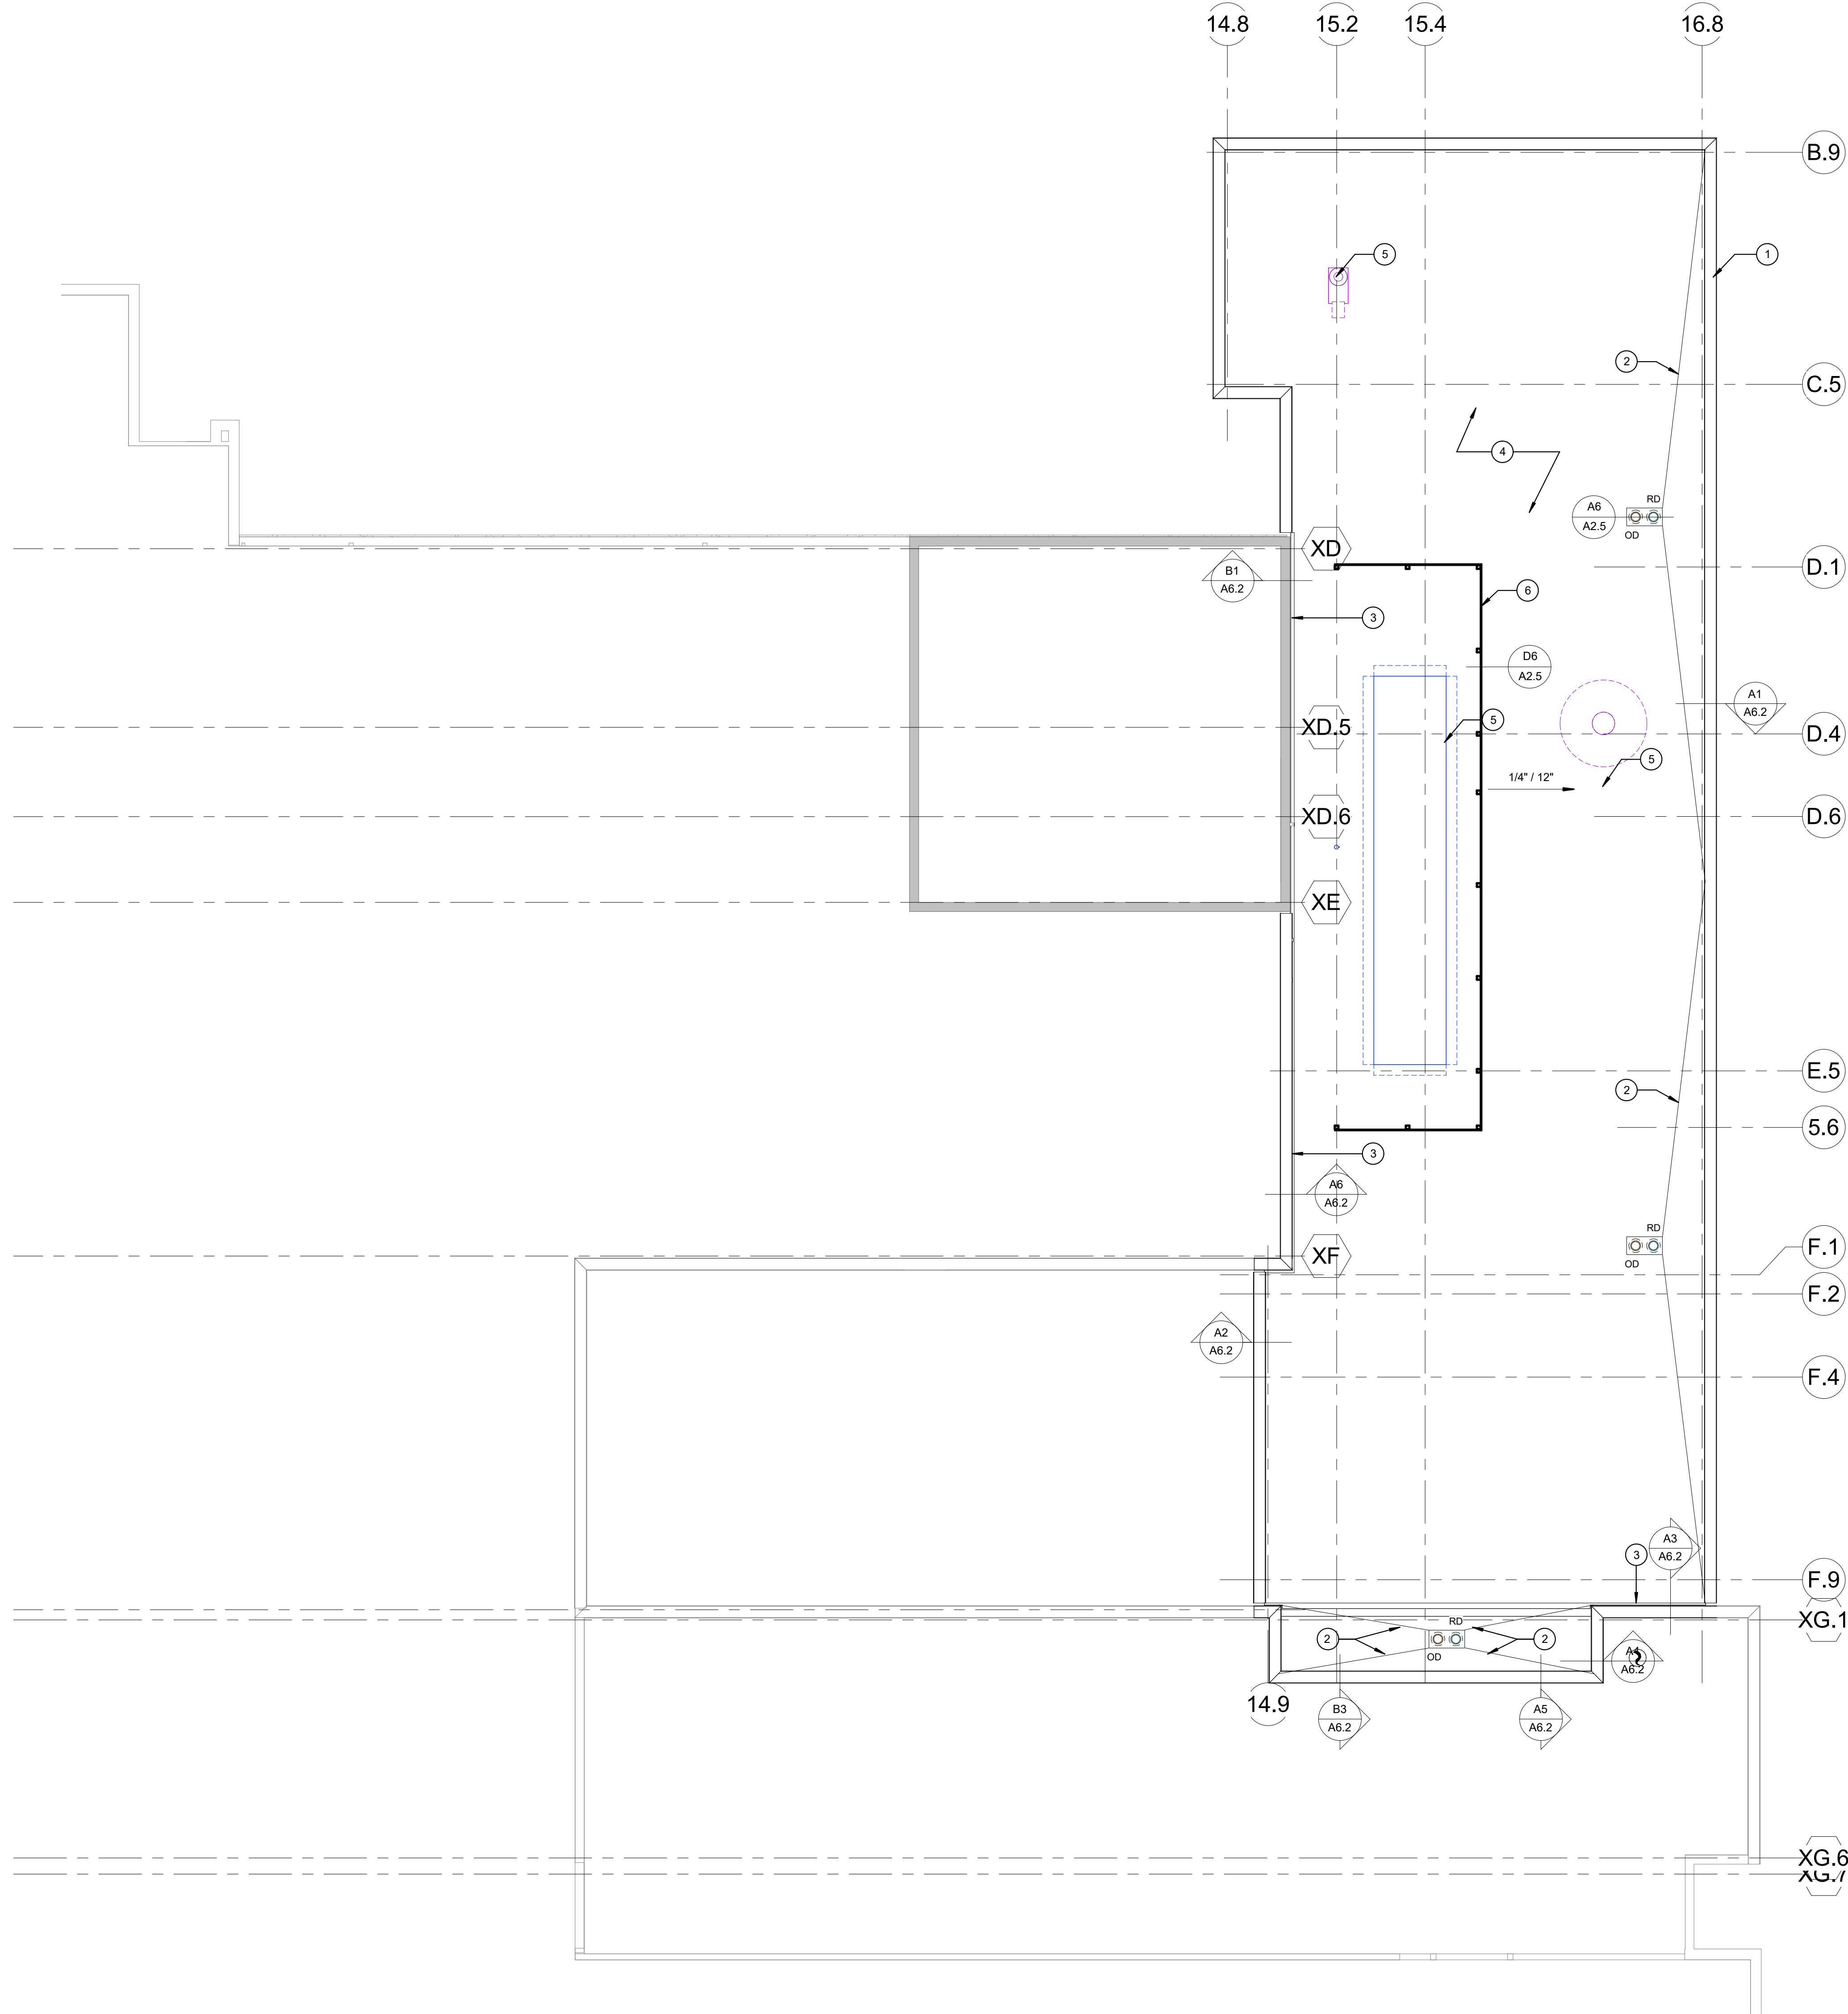

A1 ROOF PLAN
1/8" = 1'-0"



Samuel K. Beckman - Architect
License - Missouri WA-2011012130

ACI BOLAND ARCHITECTS

ACI/Boland, Inc.
Kansas City | St. Louis
1710 Wyandotte
Kansas City, MO 64108
T: 816.763.9600
Licensee's Certificate of Authority Number:
Missouri: #000958

MEP CONSULTANT

HENDERSON ENGINEERS, INC.
1801 MAIN STREET, SUITE #300
KANSAS CITY, MO 64108
T: 816.663.8700
Licensee's Certificate of Authority Number:
0000000000

STRUCTURAL CONSULTANT

BOB D. CAMPBELL & CO.
4338 BELLEVUE AVE
KANSAS CITY, MO 64111
T: 816.531.4144
Licensee's Certificate of Authority Number:
0000000000

LEE'S SUMMIT MEDICAL CENTER -
ICU EXPANSION
2100 SE BLUE PARKWAY
LEE'S SUMMIT, MISSOURI 64063

Date 01/14/2022
Job Number 3-21112
Drawn By Author
Checked By Checker

Revision
Number Date Description

A2.5

© 2021 ACI/BOLAND, Inc.
ROOF PLAN AND DETAILS

LEE'S SUMMIT MEDICAL CENTER -
ICU EXPANSION
22100 SE BLUE PARKWAY
LEE'S SUMMIT, MISSOURI 64063

Revision		
Number	Date	Description
2	2/11/22	CITY COMMENT

A5.1

© 2021 ACI/BOLAND, Inc

EXTERIOR ELEVATION

