



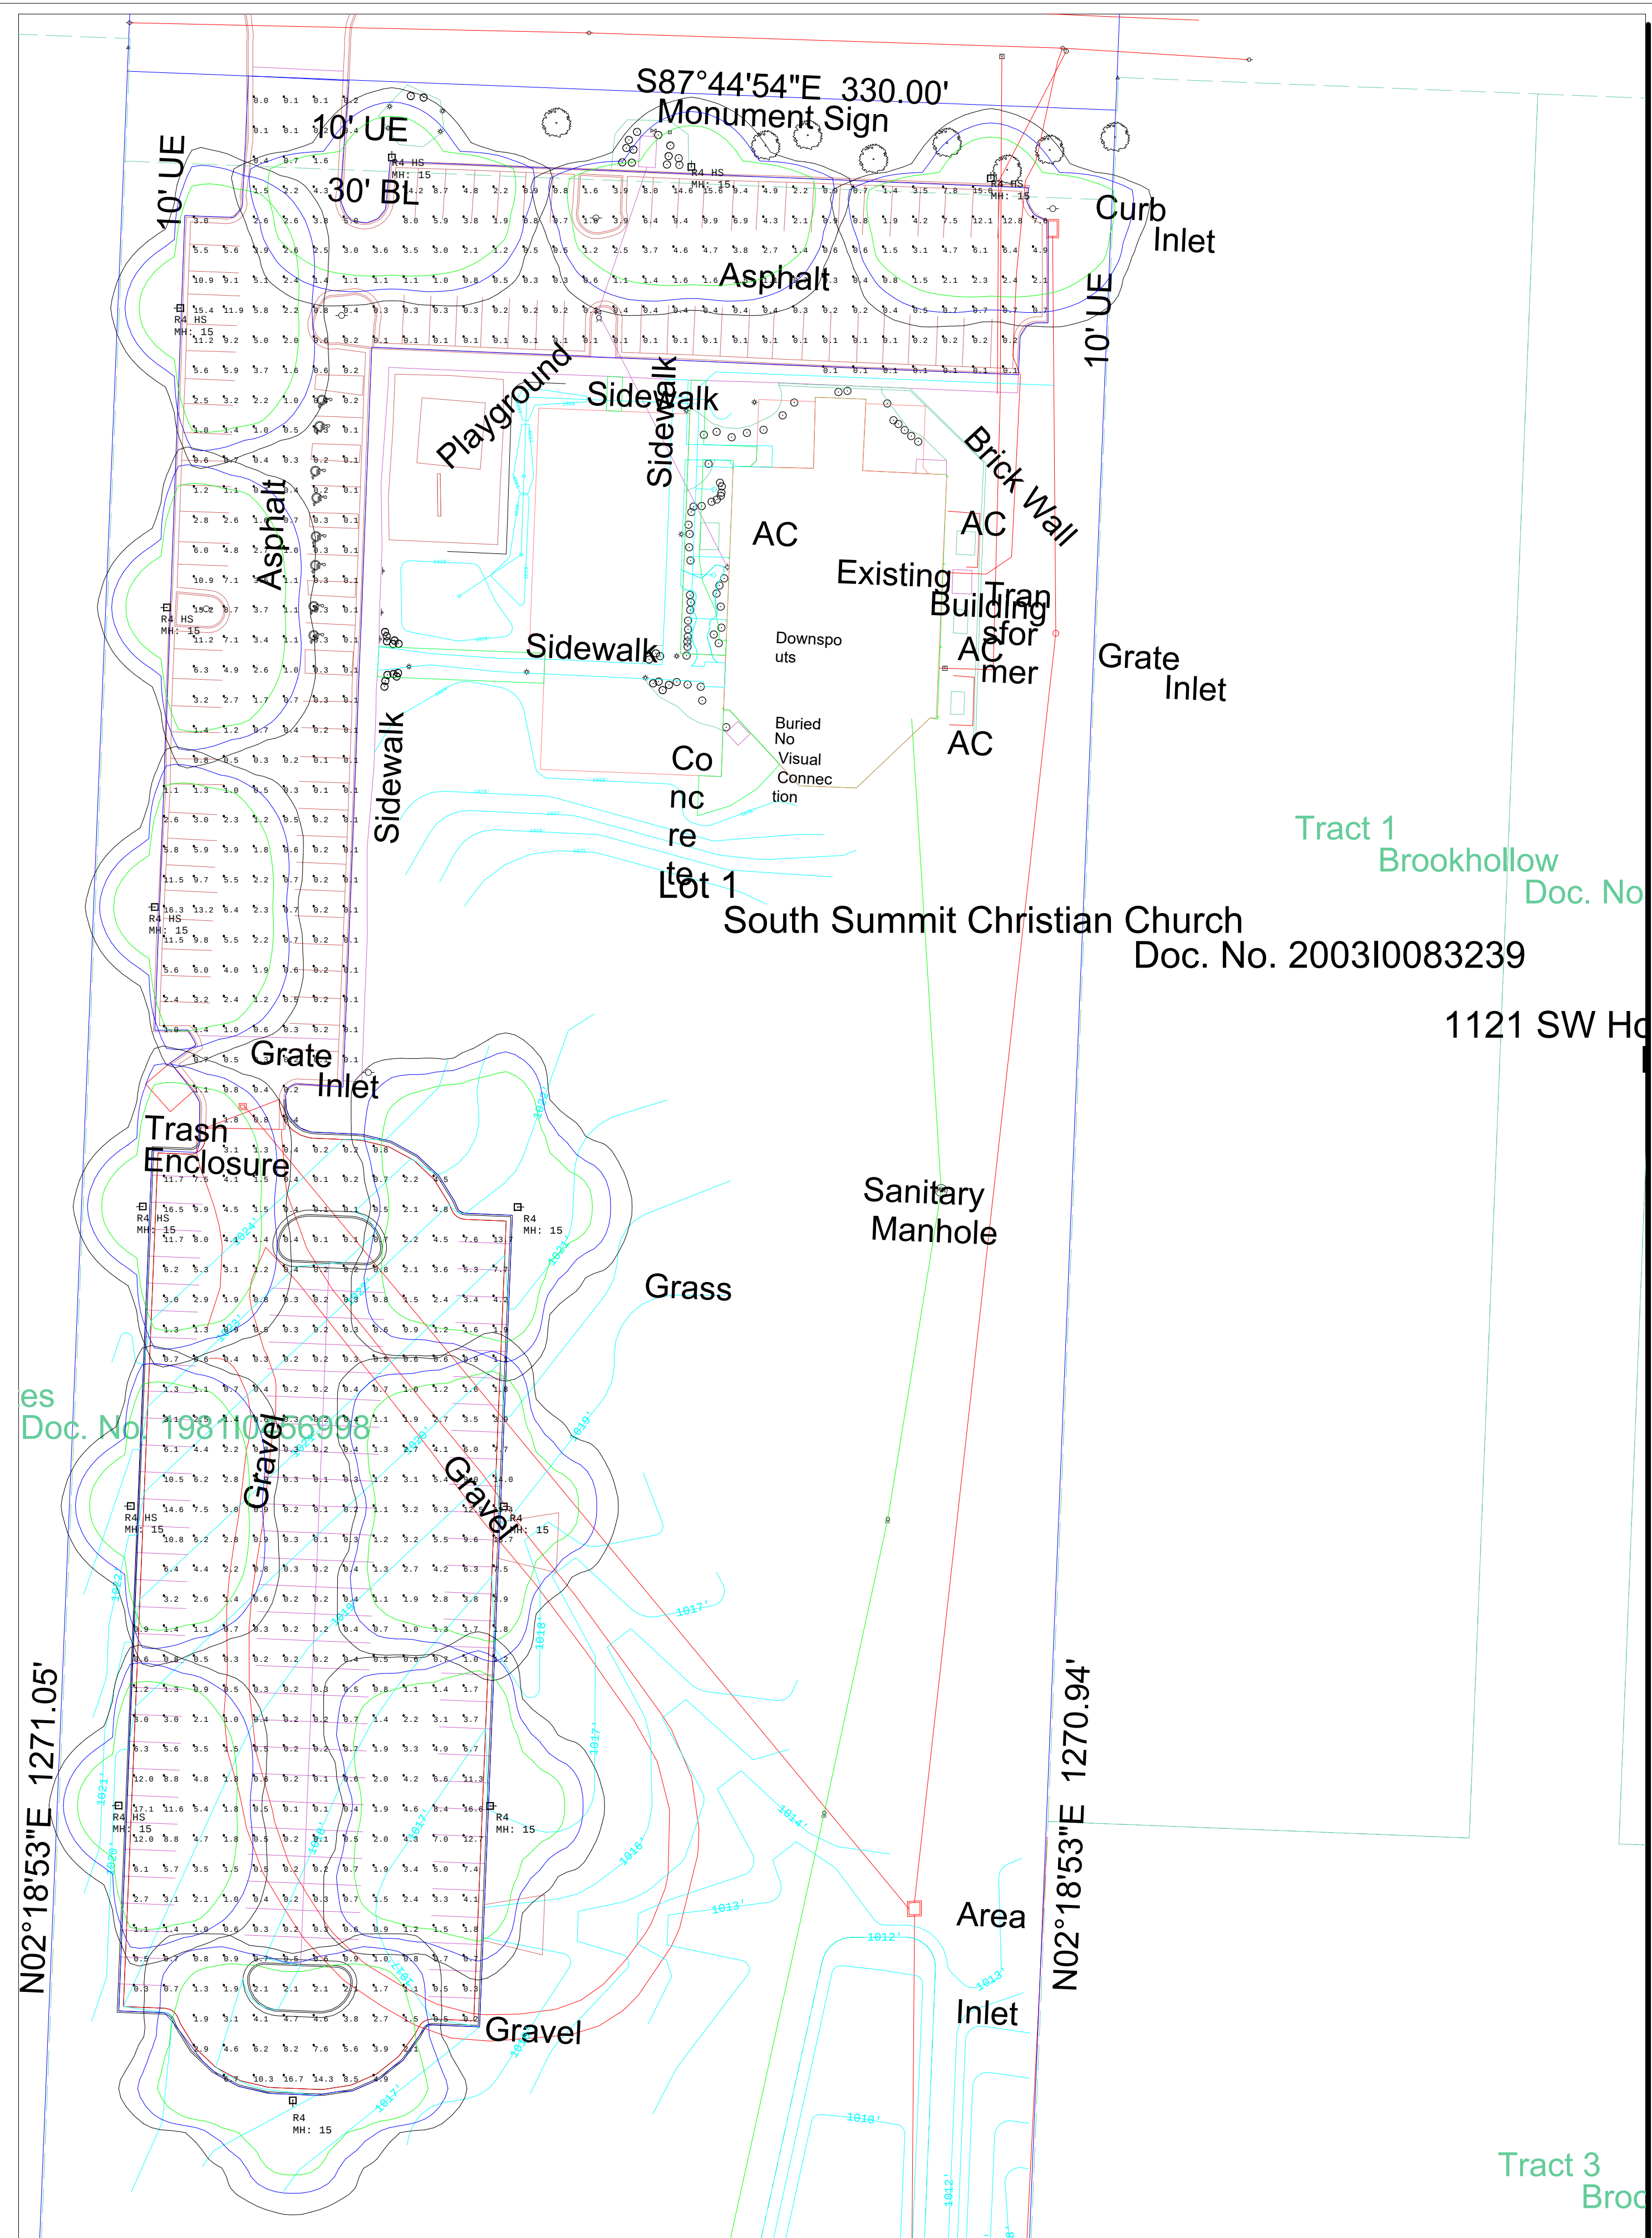

Luminaire Schedule					
Symbol	Qty	Label	Description	LLF	Luminaire Lumens
	9	R4 HS	RSX2 LED P4 40K R4 HS	0.950	17635
	4	R4	RSX2 LED P4 40K R4	0.950	25328

Calculation Summary						
Label	Units	Avg	Max	Min	Avg/Min	Max/Min
Parking Area Planar	Fc	2.58	19.4	0.0	N.A.	N.A.

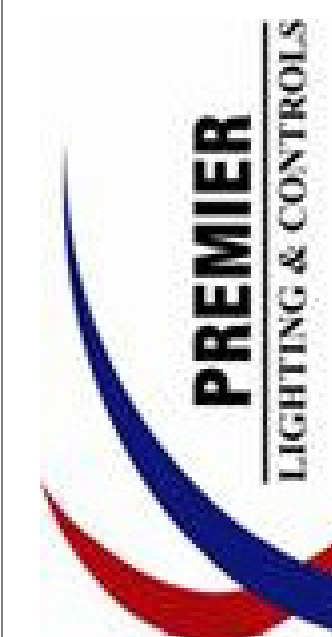

	#	Date	Comments

Drawn By:
Checked By:
Date: 2/23/2022

LIVING FAITH CHURCH