



CONFIDENTIAL – PROPRIETARY: This document is the property of ELDECON, INC., and is subject to return upon request. The document includes confidential and proprietary information of ELDECON, INC., and is loaned in confidence with the understanding that it is not to be copied or reproduced without expressed written permission, and that neither the document nor the information contained thereon will be used adversely to ELDECON INC. All patent rights are reserved.

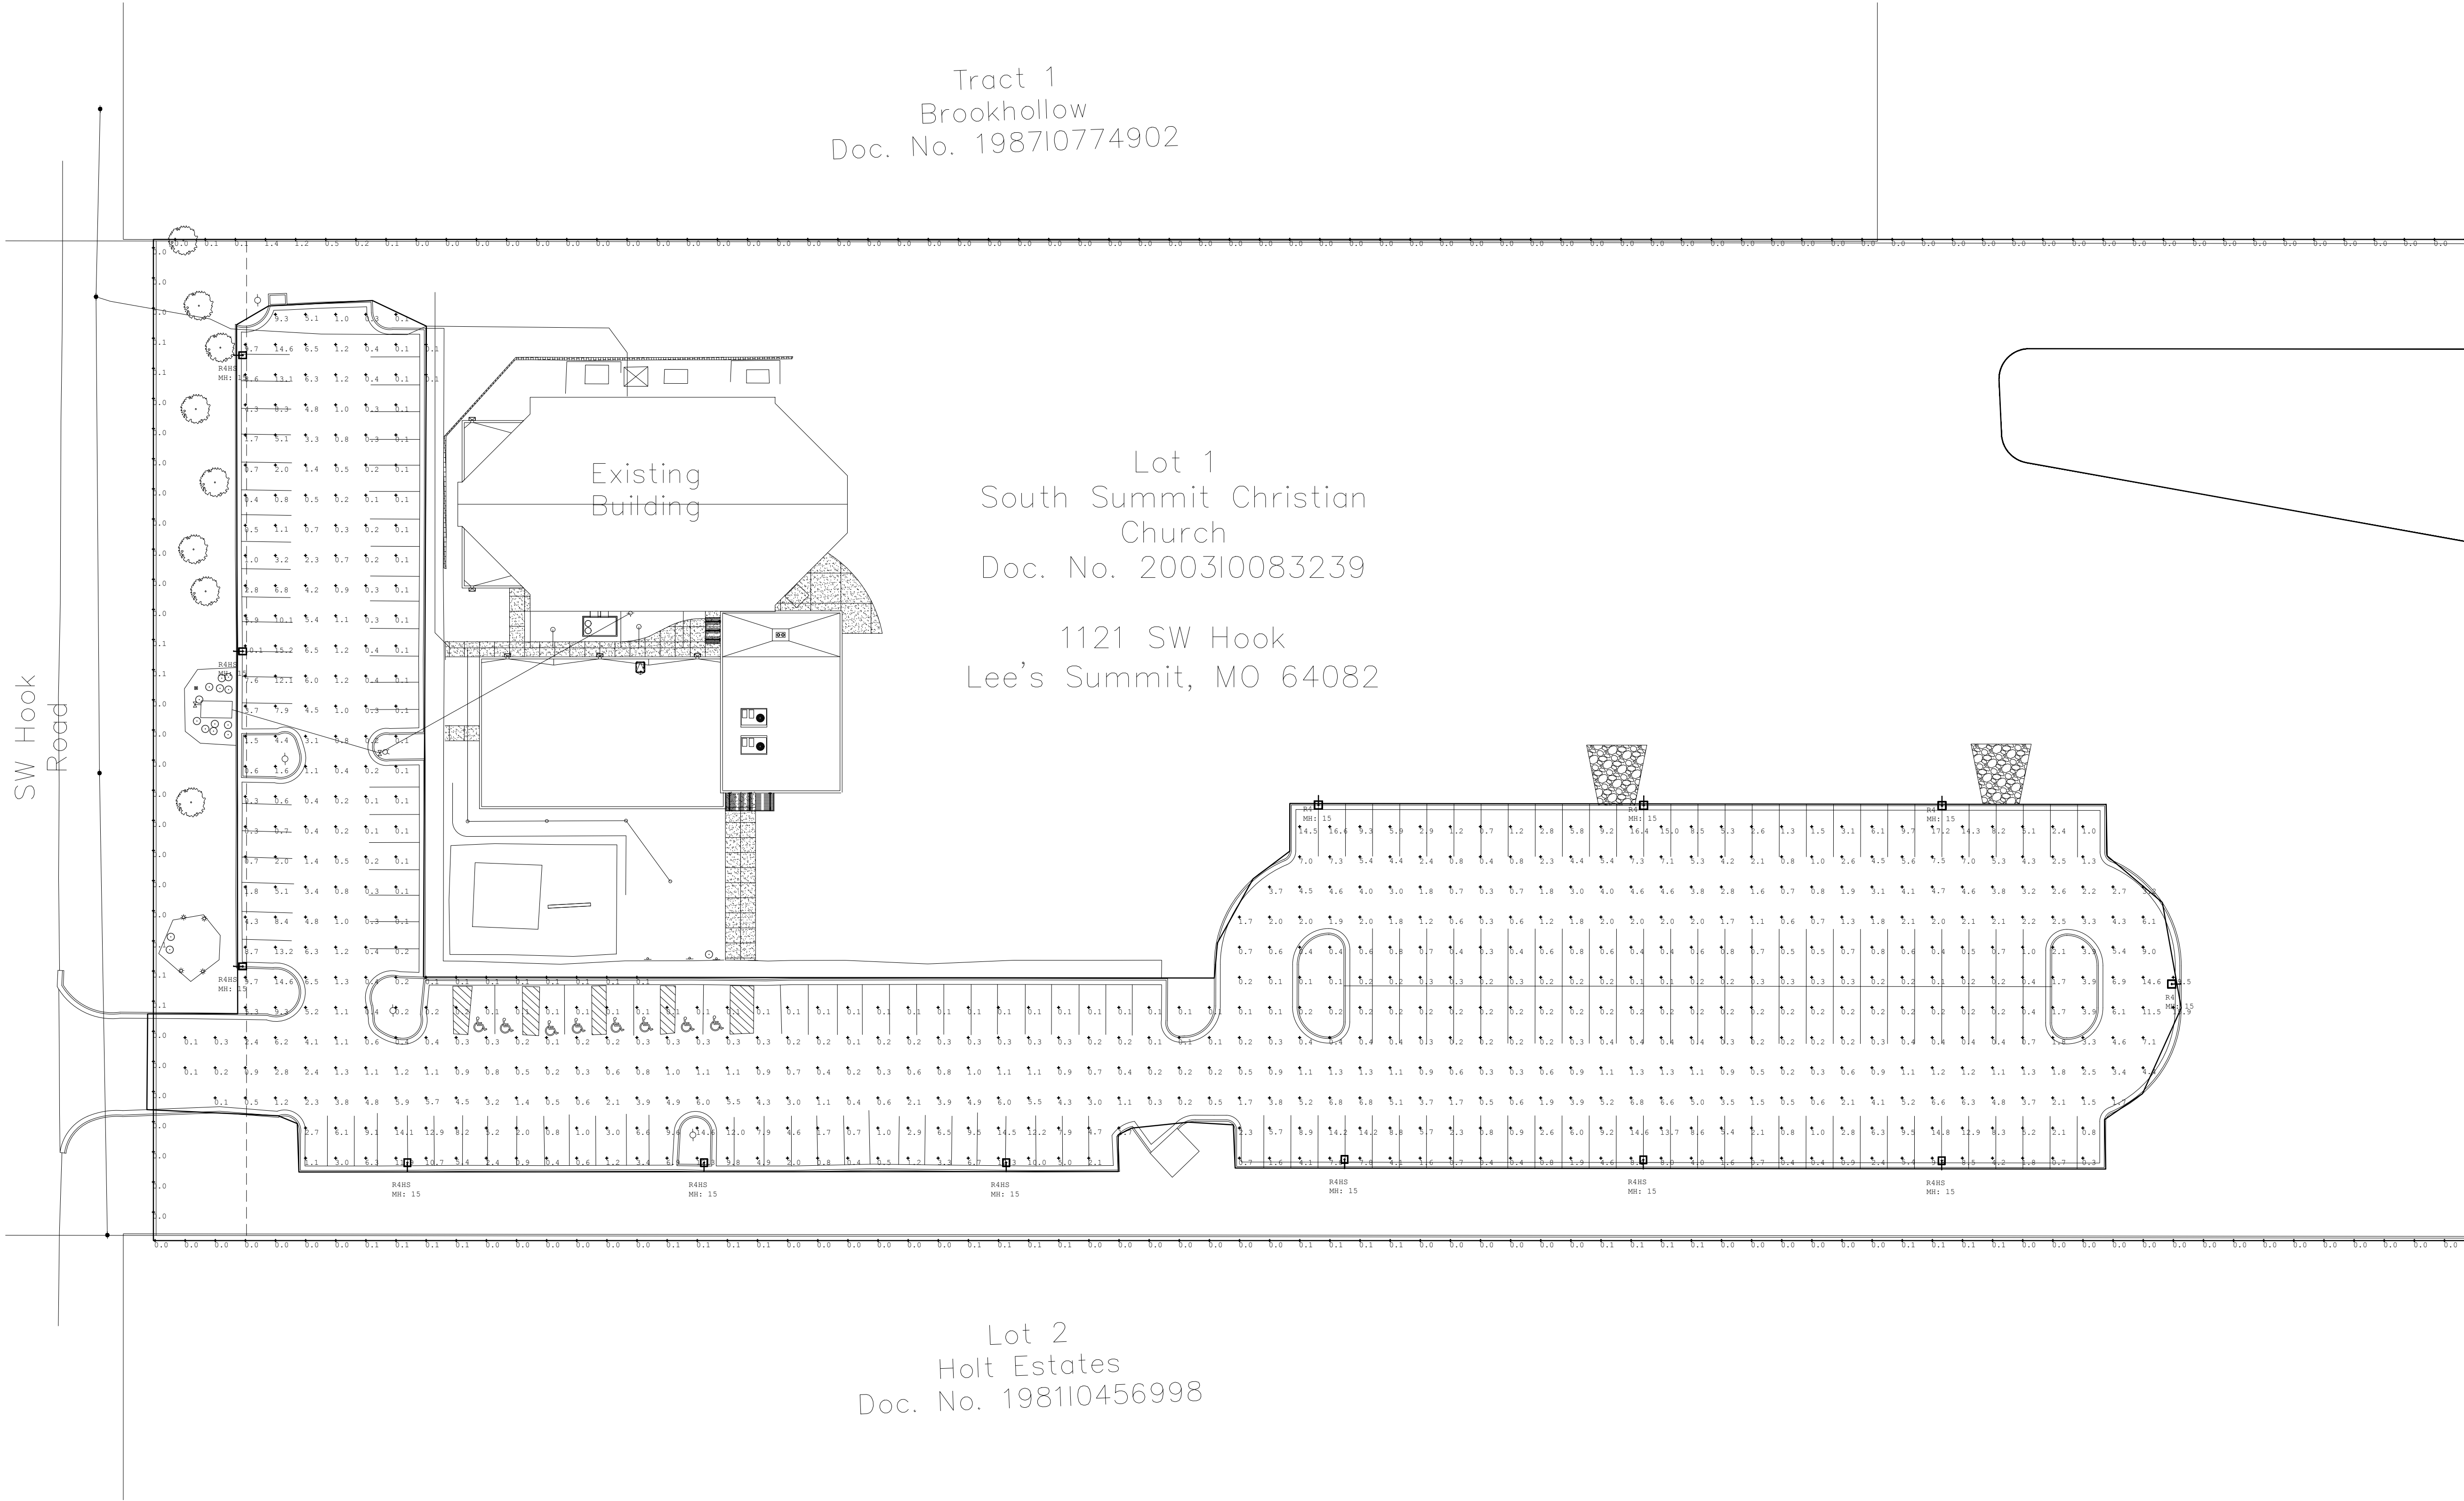

Luminaire Schedule						
Symbol	Qty	Label	Arrangement	Total Lamp Lumens	LLF	Description
	4	RSX2 LED P4 40K R4	SINGLE	N.A.	0.950	RSX2 LED P4 40K R4
	9	RSX2 LED P4 40K R4 HS	SINGLE	N.A.	0.950	RSX2 LED P4 40K R4 HS

Calculation Summary							
Label	CalcType	Units	Avg	Max	Min	Avg/Min	Max/Min
PARKING LOT	Illuminance	Fc	2.68	19.5	0.1	26.80	195.00
PROPERTY LINE	Illuminance	Fc	0.03	1.4	0.0	N.A.	N.A.

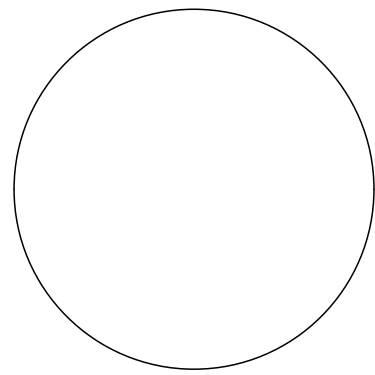

ELDECON
ELECTRICAL DESIGN & CONSTRUCTION
22001 NW Kelly Drive Kansas City, Missouri 64152
Certificate of Authority Number: #2006013730

ADDITION TO AND RENOVATIONS FOR:
LIVING FAITH CHURCH
1121 SW HOOK ROAD
LEE'S SUMMIT, MISSOURI 64082

PROJECT #:
ISSUE DATE: 09/29/2022
DRAWN BY: JDH
CHECKED BY: LRF
REVISIONS:

SHEET No.
ES1.1
PHOTOMETRIC PLAN