




WESLEY PRYOR - LOI 12

LEE SUMMIT, MO

LIGHT FIXTURE SCHEDULE							
PLAN MARK	MANUFACTURER	MODEL NUMBER	MOUNTING	FINISH	LAMP CODE	LAMP QUANTITY	NOTES
AA	LITHONIA LTG	RSX2 LED P3 40K R3 MVOLT SPA	25' POLE	BRONZE	147W	1	1,2,3
AA1	LITHONIA LTG	RSX2 LED P3 40K R3 MVOLT AASP	10' POLE	BRONZE	147W	1	1,2,3,4
BB	LITHONIA LTG	RSX2 LED P3 40K R3 MVOLT SPA-2 HEADS	25' POLE	BRONZE	147W PER HEAD	2	1,2,3
CC	LITHONIA LTG	RSX2 LED P3 40K R4 MVOLT SPA	25' POLE	BRONZE	147W	1	1,2,3
CC1	LITHONIA LTG	RSX2 LED P3 40K R4 MVOLT AASP	10' POLE	BRONZE	147W	1	1,2,3,4
DD	LITHONIA LTG	RSX2 LED P3 40K R4 MVOLT SPA-2 HEADS	25' POLE	BRONZE	147W PER HEAD	2	1,2,3
A	COOPER	XTOR3B	SURFACE	BRONZE	26W LED	—	1,2
B	JUNO LIGHTING	MD1LWG2-3K-FL-BL	RECESSED	BLACK	5W LED	—	1,2
C	AFX	BMWS171800L30MVBZ	SURFACE WALL	BRONZE	1,800 LUMENS/19W	—	1,2

NOTES LEGEND

- 1 - PROVIDE WET LOCATION RATED FIXTURE
- 2 - PROVIDE COLD LOCATION RATED BALLAST
- 3 - PROVIDE SQUARE STRAIGHT STEEL POLE RATED FOR 100 MPH WIND GUSTS, PRIMED AND PAINTED TO MATCH FIXTURE
- 4 - PROVIDE WITH ADJUSTABLE MOUNTING ARM. MOUNT AT 15 DEGREES FROM HORIZONTAL

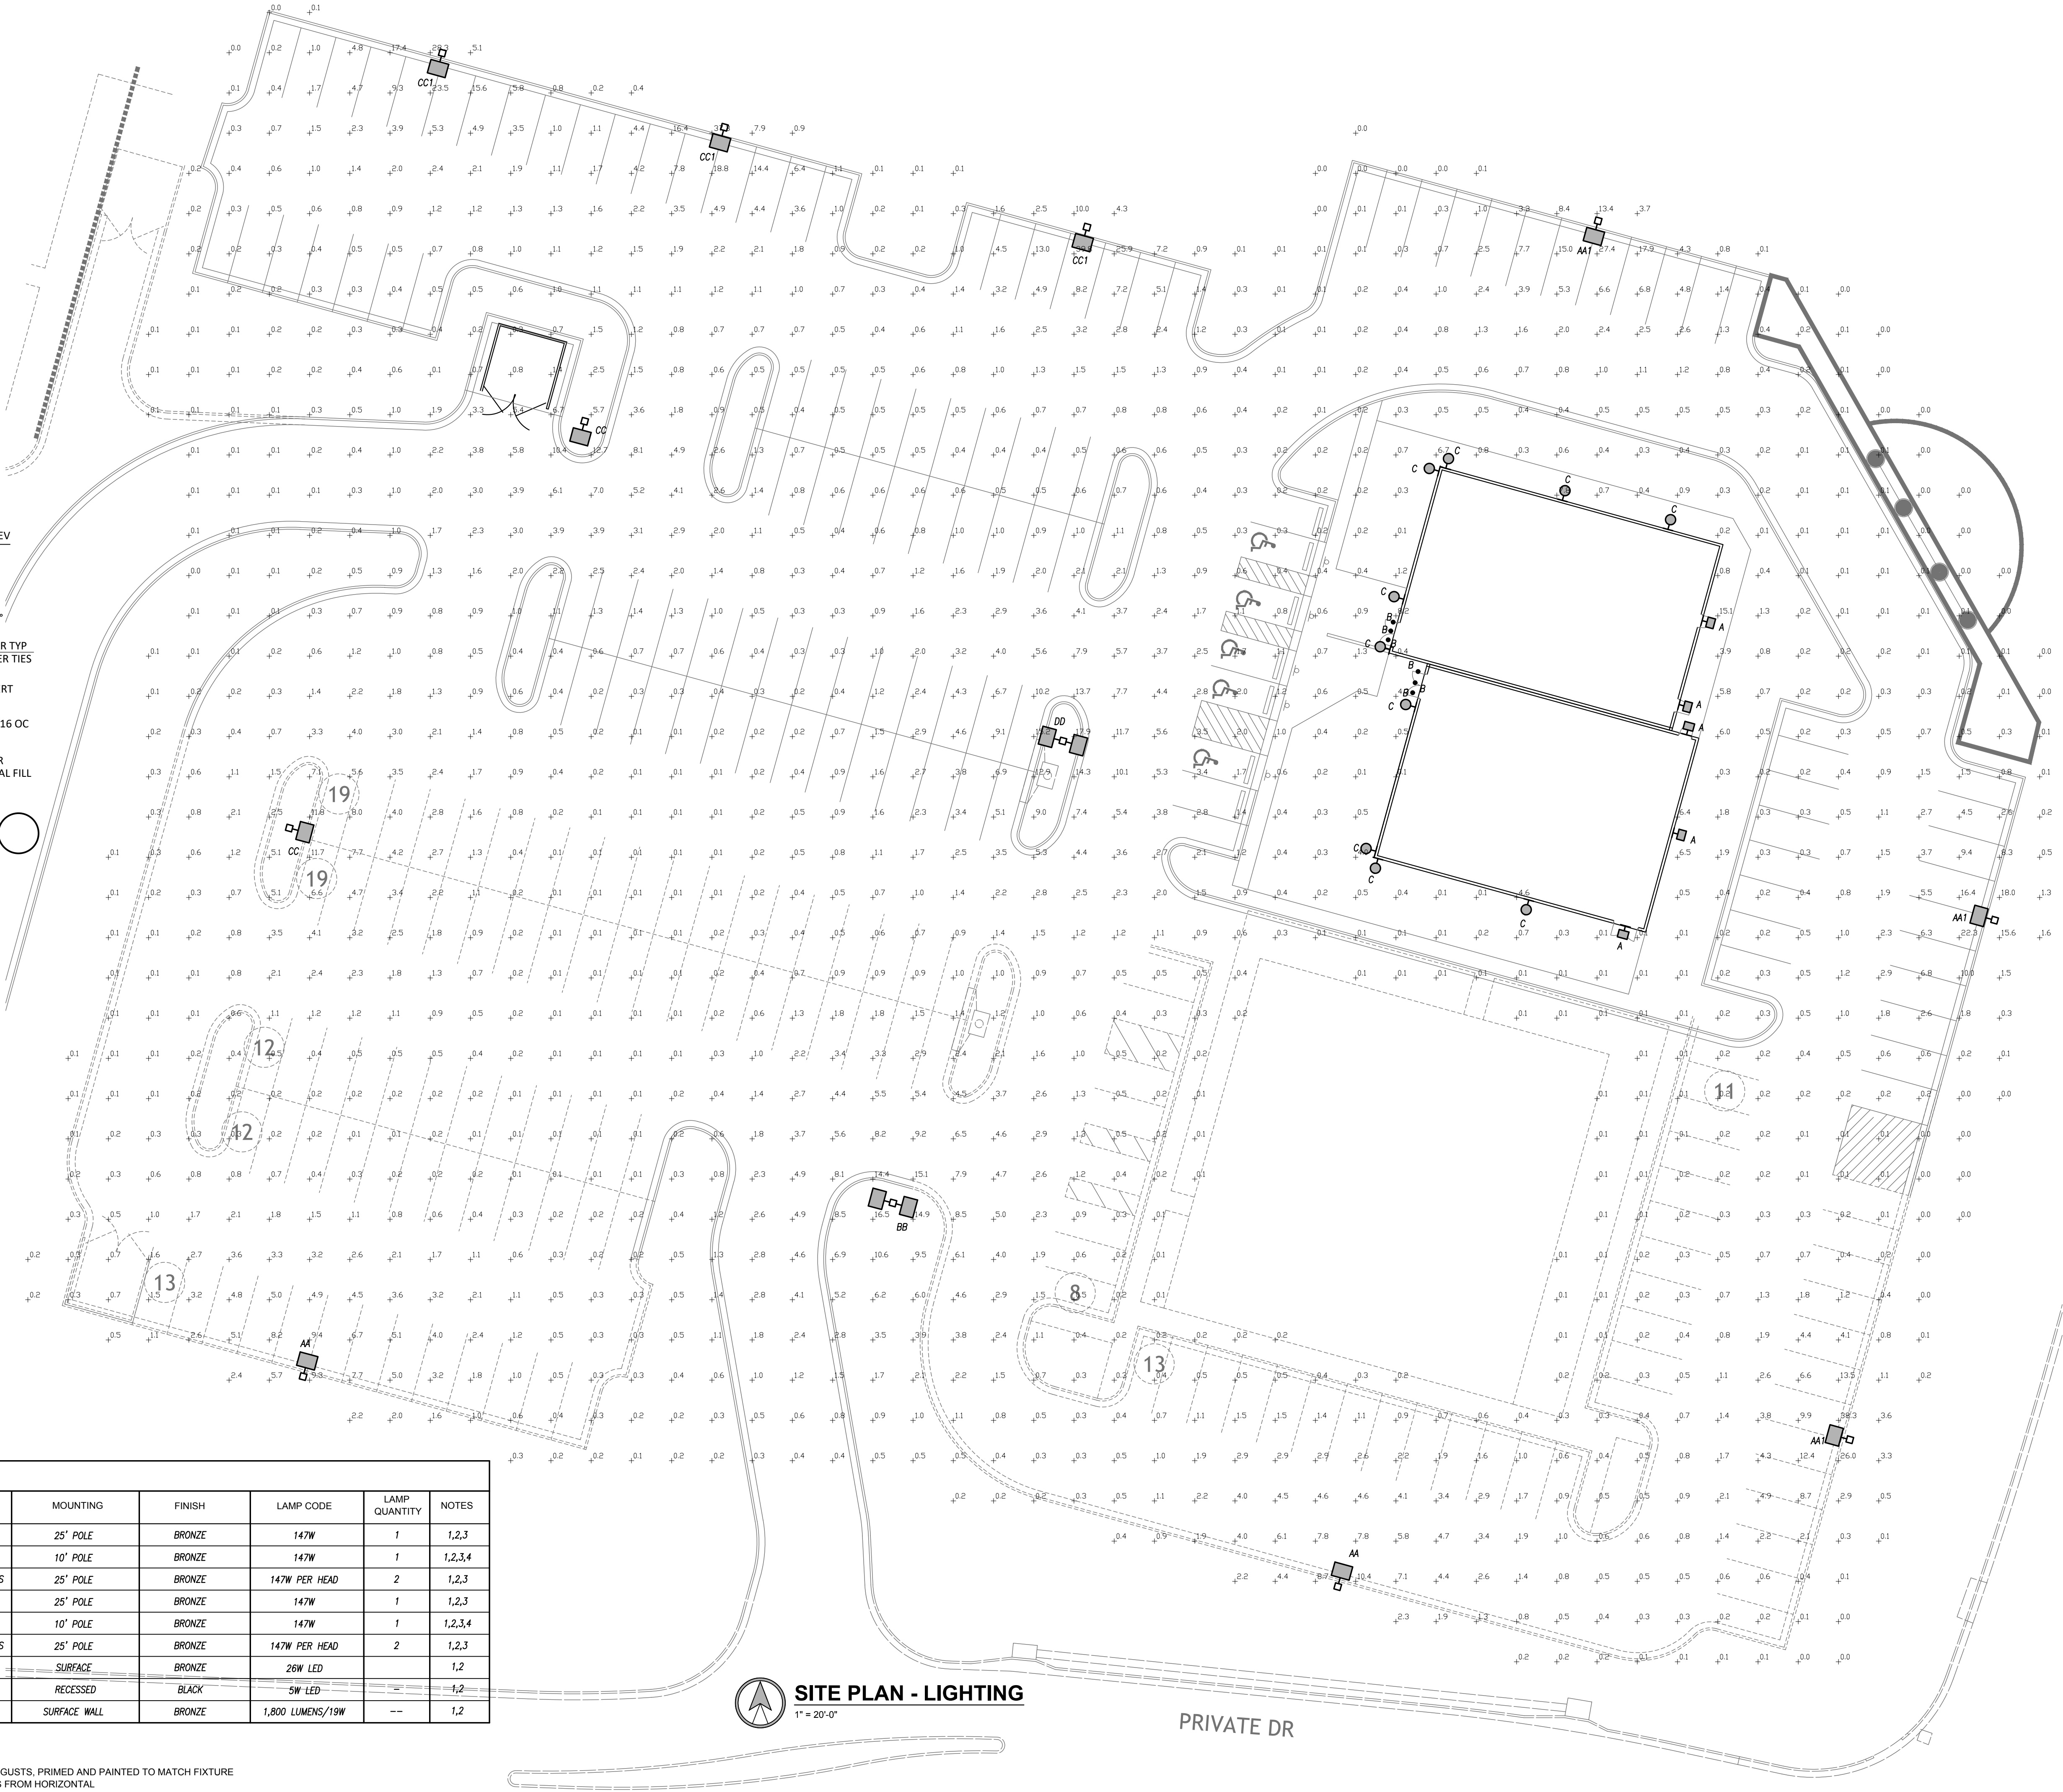

ISSUED FOR:	
DESCRIPTION	DATE
1	
2	
3	
4	
5	
6	
7	
8	
© PEARSON KENT MCKINLEY RAAF ENGINEERS, LLC	
DRAWN BY:	CLZ
CHECKED BY:	BSL
SHEET TITLE:	
SITE LIGHTING	
DATE:	PKMR PROJECT:
10/14/22	22.369
SHEET NUMBER:	

ME1