

THE TOWNHOMES OF CHAPEL RIDGE-2ND PLAT

LOTS 9-19 & TRACTS A-D SANITARY SEWER CONSTRUCTION PLANS Section 8, Township 48 North, Range 31 West LEE'S SUMMIT, JACKSON COUNTY, MISSOURI

CONSTRUCTION AND DESIGN NOTES:

SANITARY SEWERS:

- SANITARY SEWER PIPE SHALL BE POLY VINYL CHLORIDE (PVC), SDR-26, UNLESS NOTED OTHERWISE IN THESE PLANS.
- HOUSE SEWER LATERALS SHALL BE 4 INCH PVC, SDR-26. LATERALS SHALL BE CONSTRUCTED USING A TOP ORIENTED "WYE" AT THE SEWER STATION SHOWN IN THESE PLANS. LATERALS SHALL BE LAID AT A GRADE OF 2.0% FROM THE SEWER MAIN TO THE STREET RIGHT-OF-WAY LINE OR EASEMENT LINE AS REPRESENTED BY THE LATERAL LENGTH SHOWN IN THESE PLANS. THE ELEVATION SHOWN FOR THE END OF THE LATERAL IN THESE PLANS IS APPROXIMATE. THE ACTUAL ELEVATION SHALL BE DETERMINED BY THE FLOW LINE ELEVATION OF THE SEWER MAIN, THE FITTINGS AND GRADE OF THE SEWER LATERAL.
- THE CONTRACTOR SHALL MAINTAIN A LOG OF THE "AS BUILT" STATION AND LENGTH OF EACH HOUSE LATERAL AND SHALL PROVIDE ENGINEERING SOLUTIONS, L.L.C. WITH A COPY OF SAID LOG UPON COMPLETION OF SEWER CONSTRUCTION.
- ALL MANHOLES INSTALLED IN THE STREET RIGHT-OF-WAY SHALL BE FINISHED 1/2" PER FOOT ABOVE THE NEAREST ADJACENT BACK OF CURB
- A STAKE SHALL BE PLACED AT THE END OF EACH WYE CONNECTION WITH THE END ELEVATION WRITTEN ON THE STAKE
- FILL AREAS SHALL HAVE 18" OF COMPACTED FILL IN PLACE PRIOR TO TRENCHING
- A TRENCH CHECK CONSISTING OF FLOWABLE FILL MUST BE INSTALLED ON EVERY PRIVATE LATERAL.

GENERAL NOTE:


- ALL CONSTRUCTION SHALL CONFORM TO THE CITY OF LEE'S SUMMIT DESIGN AND CONSTRUCTION MANUAL AS ADOPTED BY ORDINANCE 5813.
- TRENCH CHECKS SHALL BE INSTALL AT ALL SANITARY WYES LOCATION.

OIL - GAS WELLS

ACCORDING TO EDWARD ALTON MAY JR'S ENVIRONMENTAL IMPACT STUDY OF ABANDONED OIL AND GAS WELLS IN LEE'S SUMMIT, MISSOURI IN 1995, THERE ARE NOT OIL AND GAS WELLS WITHIN 185 FEET OF THE PROPERTY AS SURVEYED HEREON.

FLOOD INFORMATION:

The property is located in Zone "X" areas outside the 100 year flood plain per FEMA Map 29095C0430G, dated January 20, 2017

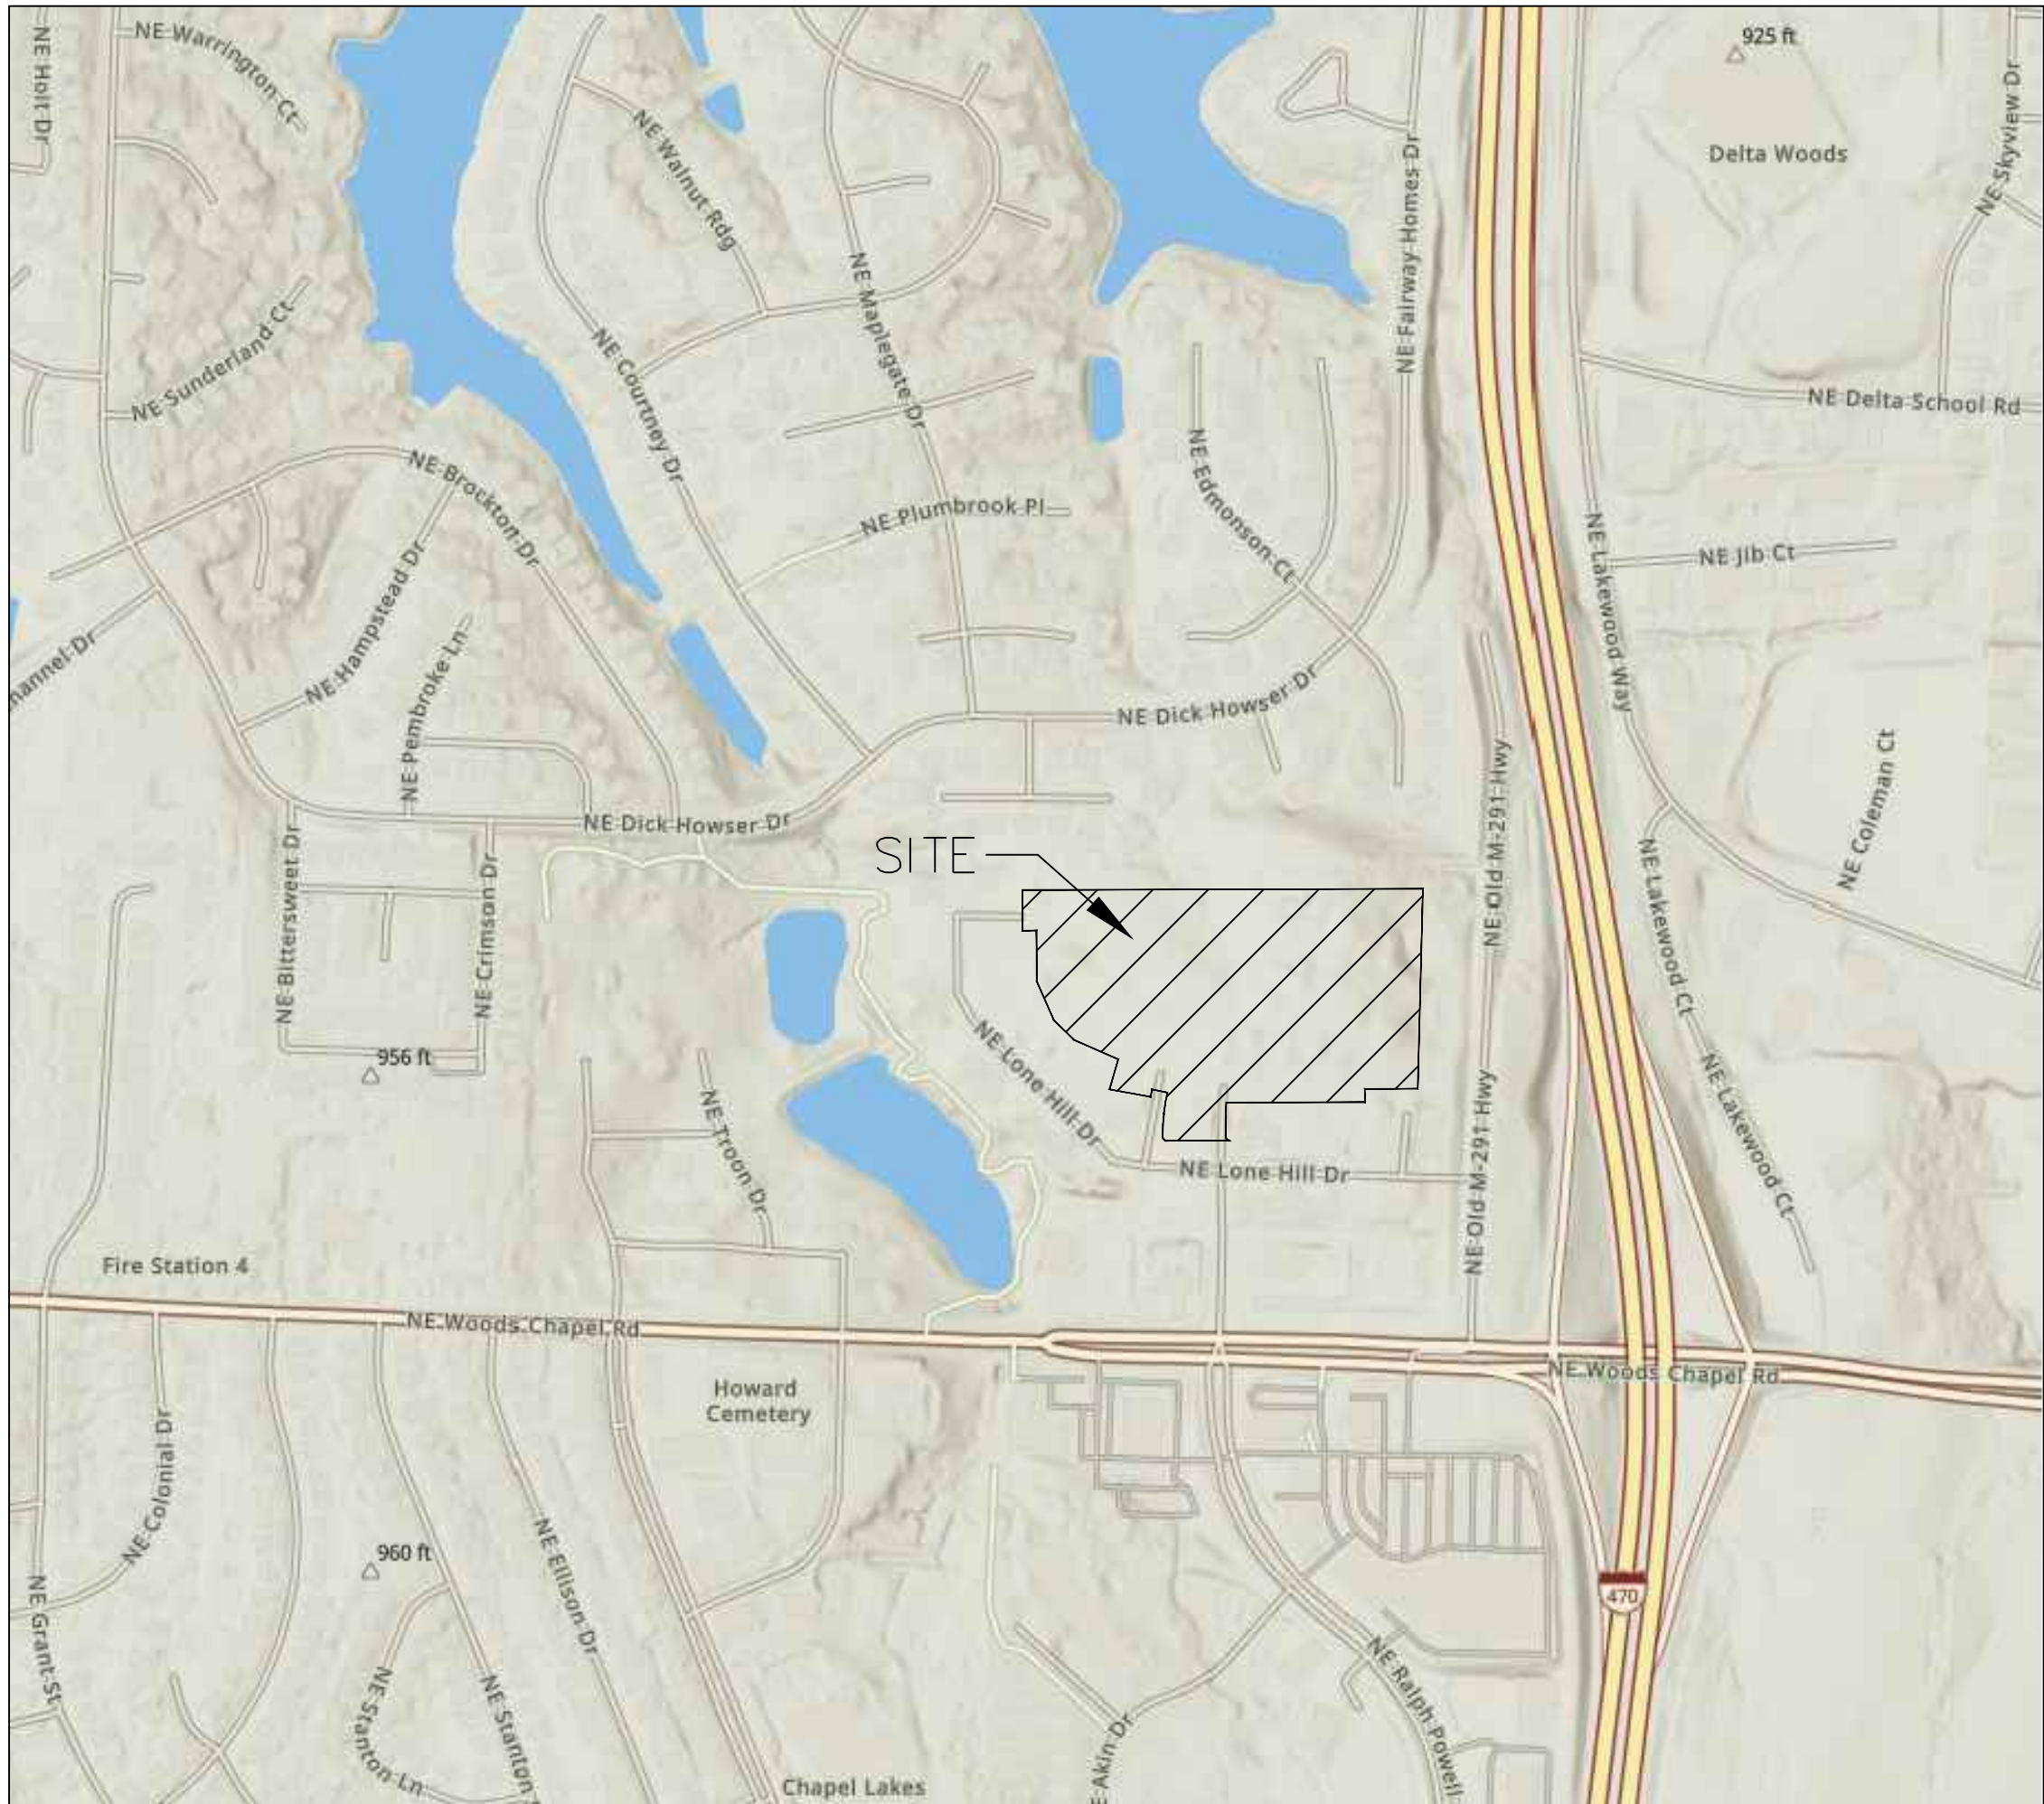

INDEX OF SHEETS:

- C.400 ~ SANITARY SEWER COVER SHEET
- C.401 ~ SANITARY SEWER GENERAL LAYOUT
- C.402 ~ SANITARY SEWER PLAN & PROFILE
- C.403 ~ SANITARY SEWER PLAN & PROFILE
- C.404 ~ SANITARY SEWER DETAILS

Summary of Quantities:

ITEM AND DESCRIPTION	UNIT	ESTIMATED QUANTITY
SANITARY		
4" PVC SDR 26 Service Line	LF	1,229.52
8" PVC SDR 26	LF	1,385.02
4' DIA Manhole	EA	7.00
TEES, BENDS, WYES	LS	35.00
CONNECTION TO EXISTING SANITARY SEWER	LS	2.00
TRACER WIRE AND EQUIPMENT	L.F.	1,385.02

UTILITY COMPANIES:

THE FOLLOWING LIST OF UTILITY COMPANIES IS PROVIDED FOR INFORMATION ONLY. WE DO NOT OFFER ANY GUARANTEE OR WARRANTY THAT THIS LIST IS COMPLETE OR ACCURATE. THE CONTRACTOR SHALL BE RESPONSIBLE FOR CONTACTING ALL UTILITY COMPANIES THAT MAY BE AFFECTED BY THE PROPOSED CONSTRUCTION AND VERIFYING THE ACTUAL LOCATION OF EACH UTILITY LINE. THE CONTRACTOR SHALL NOTIFY ENGINEERING SOLUTIONS AT 816.623.9888 OF ANY CONFLICT WITH PROPOSED IMPROVEMENTS.

EVERGY ~ 298-1196
MISSOURI GAS ENERGY ~ 756-5261
SOUTHWESTERN BELL TELEPHONE ~ 761-5011
COMCAST CABLE ~ 795-1100
WILLIAMS PIPELINE ~ 422-6300
CITY OF LEE'S SUMMIT PUBLIC WORKS ~ 969-1800
CITY OF LEE'S SUMMIT DEVELOPMENT ENGINEERING INSPECTION AT 816.969.1200
CITY OF LEE'S SUMMIT WATER UTILITIES ~ 969-1900
MISSOURI ONE CALL (DIG RITE) ~ 1-800-344-7483

LEGEND:

- B/L - BUILDING SET-BACK
- C/A - COMMON AREA
- D/E - DRAINAGE EASEMENT
- FND. - FOUND
- L/E - LANDSCAPE EASEMENT
- L.N.A. - LIMITS OF NO ACCESS
- R/W - RIGHT OF WAY
- SAN - SANITARY SEWER LINE
- S/W - SIDEWALK
- U/E - UTILITY EASEMENT
- W - WATER LINE
- ST - STORM SEWER LINE

ENGINEER'S CERTIFICATION:

I HEREBY CERTIFY THAT THIS PROJECT HAS BEEN DESIGNED AND THESE PLANS PREPARED IN ACCORDANCE WITH THE CURRENT DESIGN CRITERIA OF THE CITY OF LEE'S SUMMIT, MISSOURI AND THE STATE OF MISSOURI. I FURTHER CERTIFY THAT THESE PLANS WERE DESIGNED IN ACCORDANCE TO AASHTO STANDARDS.

CITY OF LEE'S SUMMIT, MISSOURI

APPROVED: DATE: _____

BY: _____
CITY ENGINEER

RECORD DRAWING

The information provided on this drawing conforms to construction records; it is not intended for construction, implementation or recording purposes; and it is solely based on information obtained by my firm.

"100-00 100.10", "4-00% 1.15% slope", or "8-inch HDPE-PVC pipe" are all typical examples of revisions that indicate that design data has been replaced with "as-built" information. All other data is as designed and has not been field verified.

Date: 11/17/2022

Certified by: Matthew J. Schlicht

Title: Engineer

Firm: Engineering Solutions

Record Drawing




Professional Registration
Missouri
Engineering 2005002186-D
Surveying 2005008319-D
Kansas
Engineering E-1685
Surveying LS-218
Oklahoma
Engineering 6254
Nebraska
Engineering CA2821

THE TOWNHOMES OF CHAPEL RIDGE-2ND PLAT
LOTS 9-19 & TRACTS A-D
Lee's Summit, Jackson County, Missouri

Project: VILLAS OF CHAPEL RIDGE LS2MO
Issue Date: April 10, 2020


Cover Sheet
Construction Plans for:
THE TOWNHOMES OF CHAPEL RIDGE-2ND PLAT
LOTS 9-19 & TRACTS A-D
Lee's Summit, Jackson County, Missouri

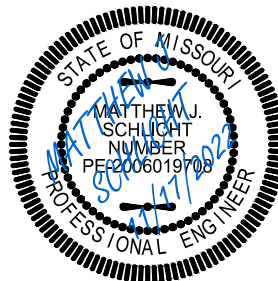

Matthew J. Schlicht
MO PE 2006019708
KS PE 19071
OK PE 25226
NE PE E-14335

REVISIONS

11/17/2022 As-Built

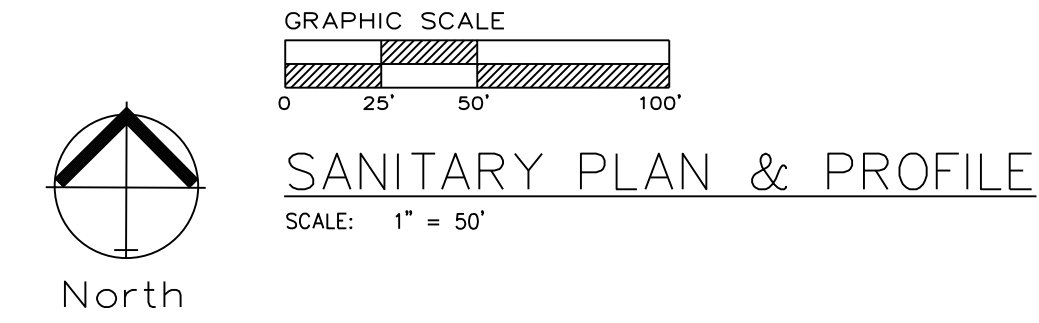

1 ~ ALL CONSTRUCTION SHALL CONFORM TO THE CITY OF LEE'S SUMMIT DESIGN AND CONSTRUCTION MANUAL AS ADOPTED BY ORDINANCE 5813.
2 ~ TRENCH CHECKS SHALL BE INSTALL AT ALL SANITARY WYES LOCATION.

ENGINEERING SOLUTIONS
—ENGINEERING & SURVEYING—
50 SE 30TH STREET
LEE'S SUMMIT, MO 64082
P: (616) 623-9888 F: (616) 623-9849


Professional Registration
Missouri
Engineering 20050002186-D
Surveying 2005000319-D
Kansas
Engineering E-1695
Surveying LS-218
Oklahoma
Engineering 6254
Nebraska
Engineering CA2621

THE TOWNHOMES OF CHAPEL RIDGE-2ND PLAT
LOTS 9-19 & TRACTS A-D
Lee's Summit, Jackson County, Missouri

Project: VILLAS OF CHAPEL
RIDGE, LSMO

Issue Date: April 10, 2020

Sanitary Sewer General Layout
Construction Plans for:
THE TOWNHOMES OF CHAPEL RIDGE-2ND PLAT
LOTS 9-19 & TRACTS A-D
Lee's Summit, Jackson County, Missouri

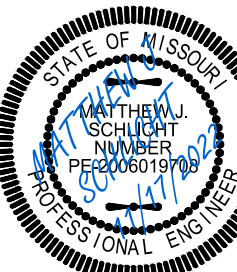

Matthew J. Schlie
MO PE 20060197
KS PE 19071
OK PE 25226
NE PE E-1433

REVISIONS

11/17/2022 As-B

C.401

Record Drawing


RECORD DRAWING

The information provided on this drawing conforms to construction records; it is not intended for construction, implementation or recording purposes; and it is solely based on information obtained by my firm.

"400-00 100.10", "4-00% 1.15% slope", or "8-inch HDPE-PVC pipe" are all typical examples of revisions that indicate that design data has been replaced with "as-built" information. All other data is as designed and has not been field verified.


Date: 11/17/2022
 Certified by: Matthew J. Schlicht
 Title: Engineer
 Firm: Engineering Solutions

GENERAL NOTE:
1 ~ ALL CONSTRUCTION SHALL CONFORM TO THE CITY OF LEE'S SUMMIT DESIGN AND CONSTRUCTION MANUAL AS ADOPTED BY ORDINANCE 5813.
2 ~ TRENCH CHECKS SHALL BE INSTALL AT ALL SANITARY WYES LOCATION.

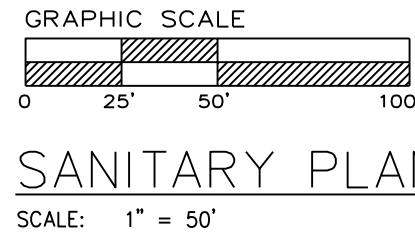


SANITARY PLAN & PROFILE


SCALE: 1" = 50'

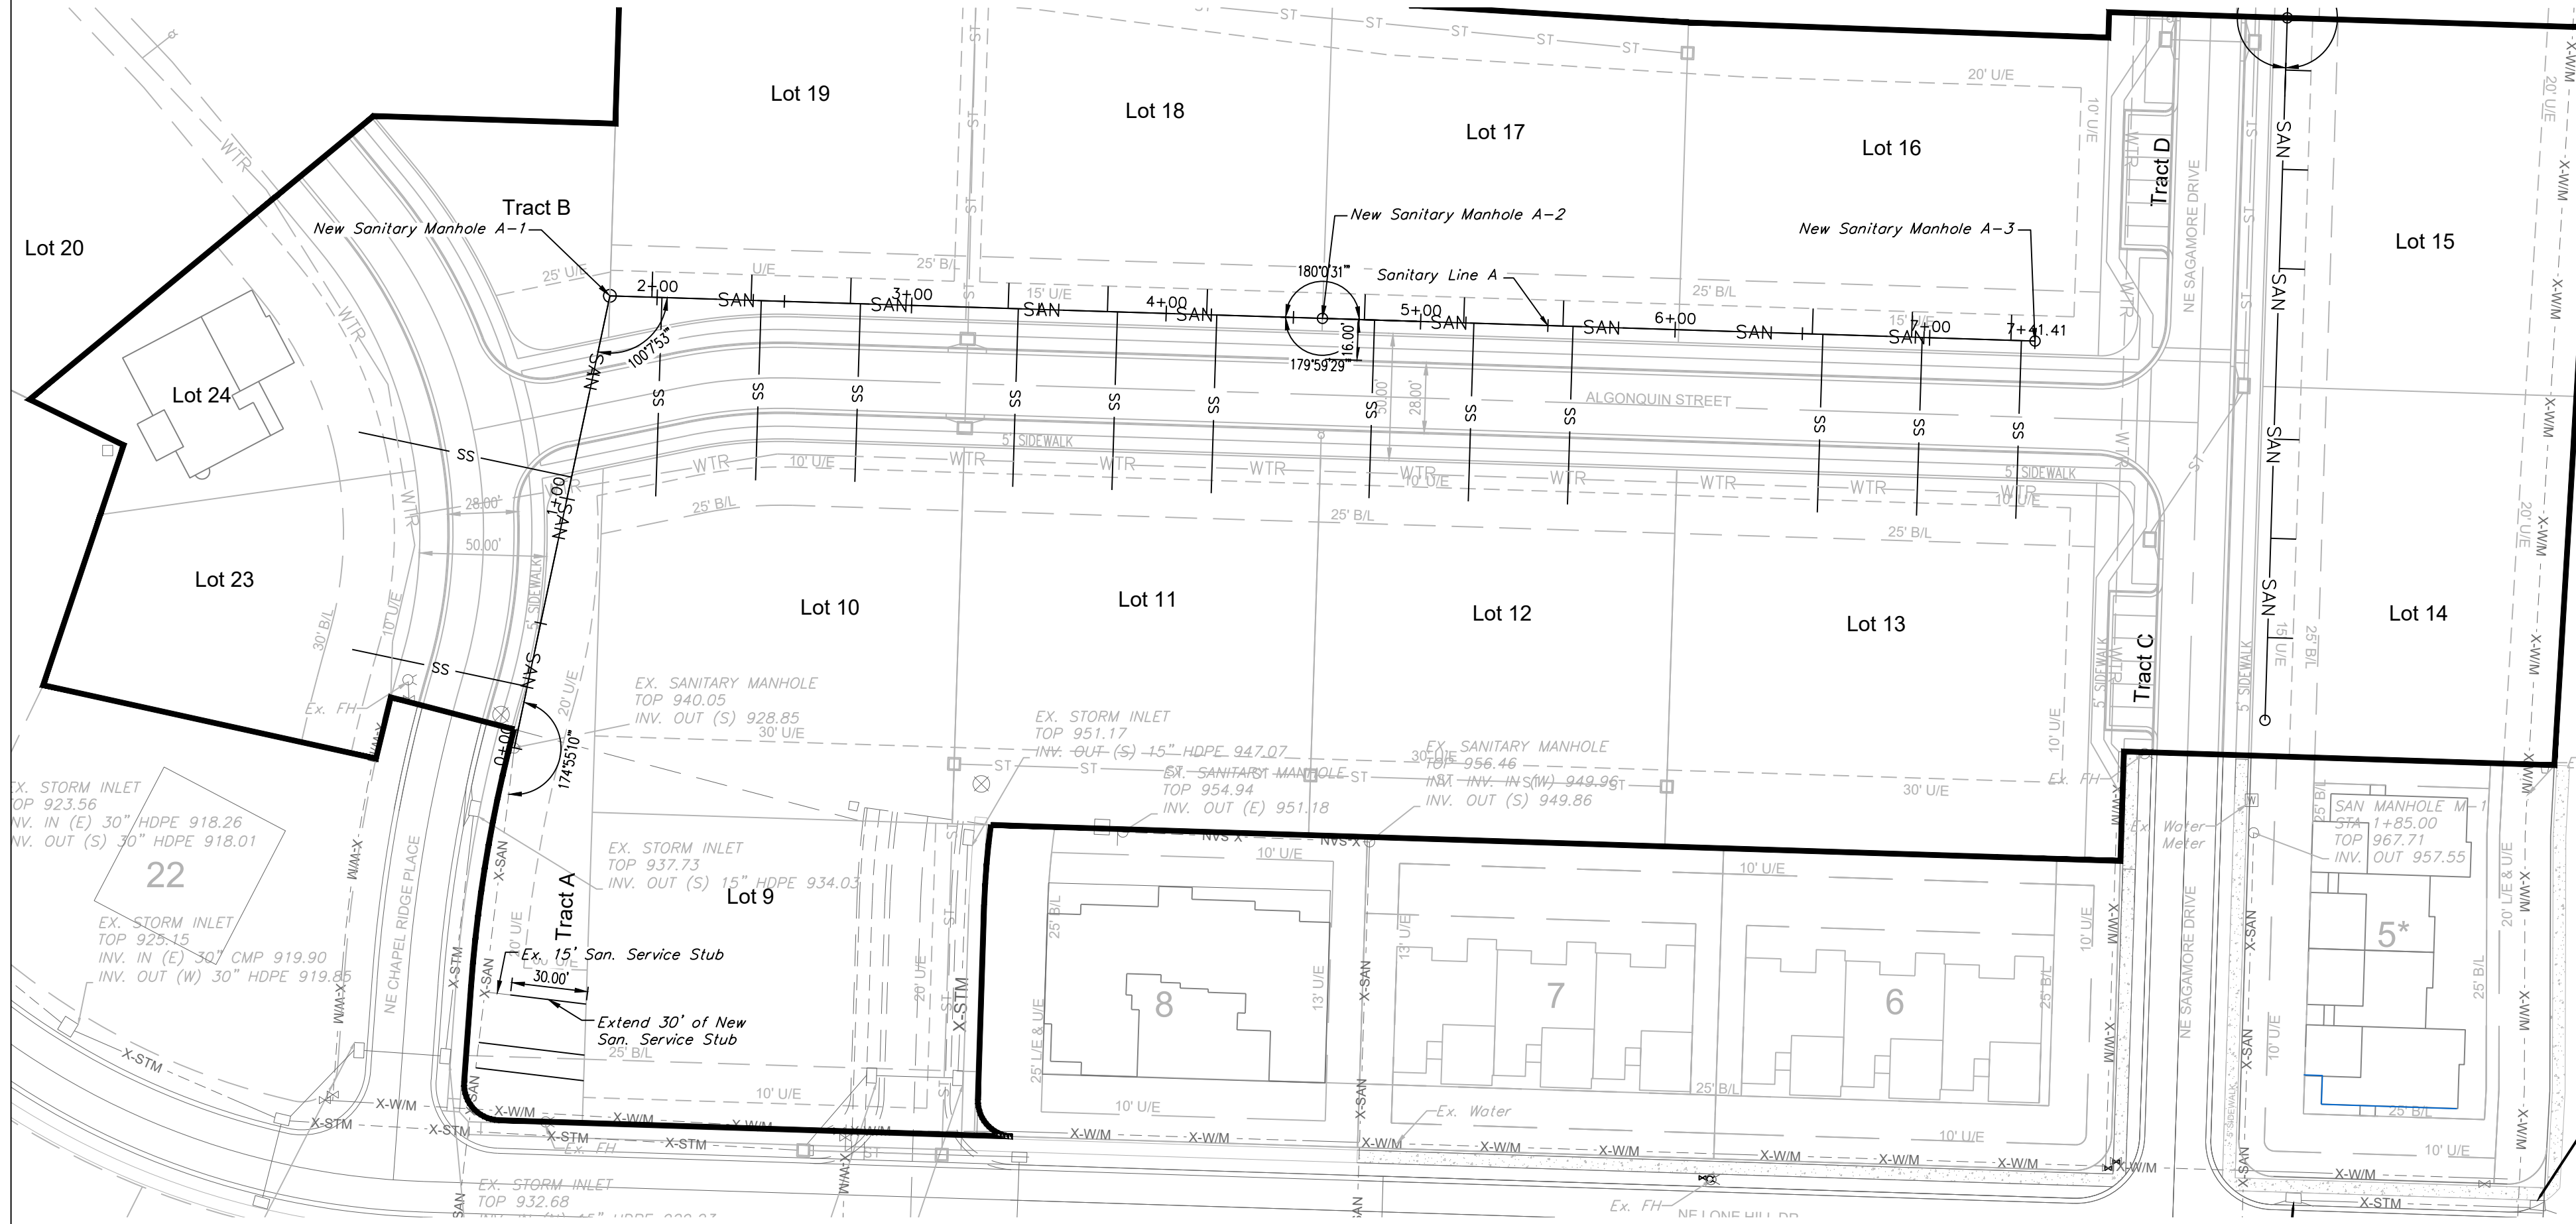

SANITARY LINE A

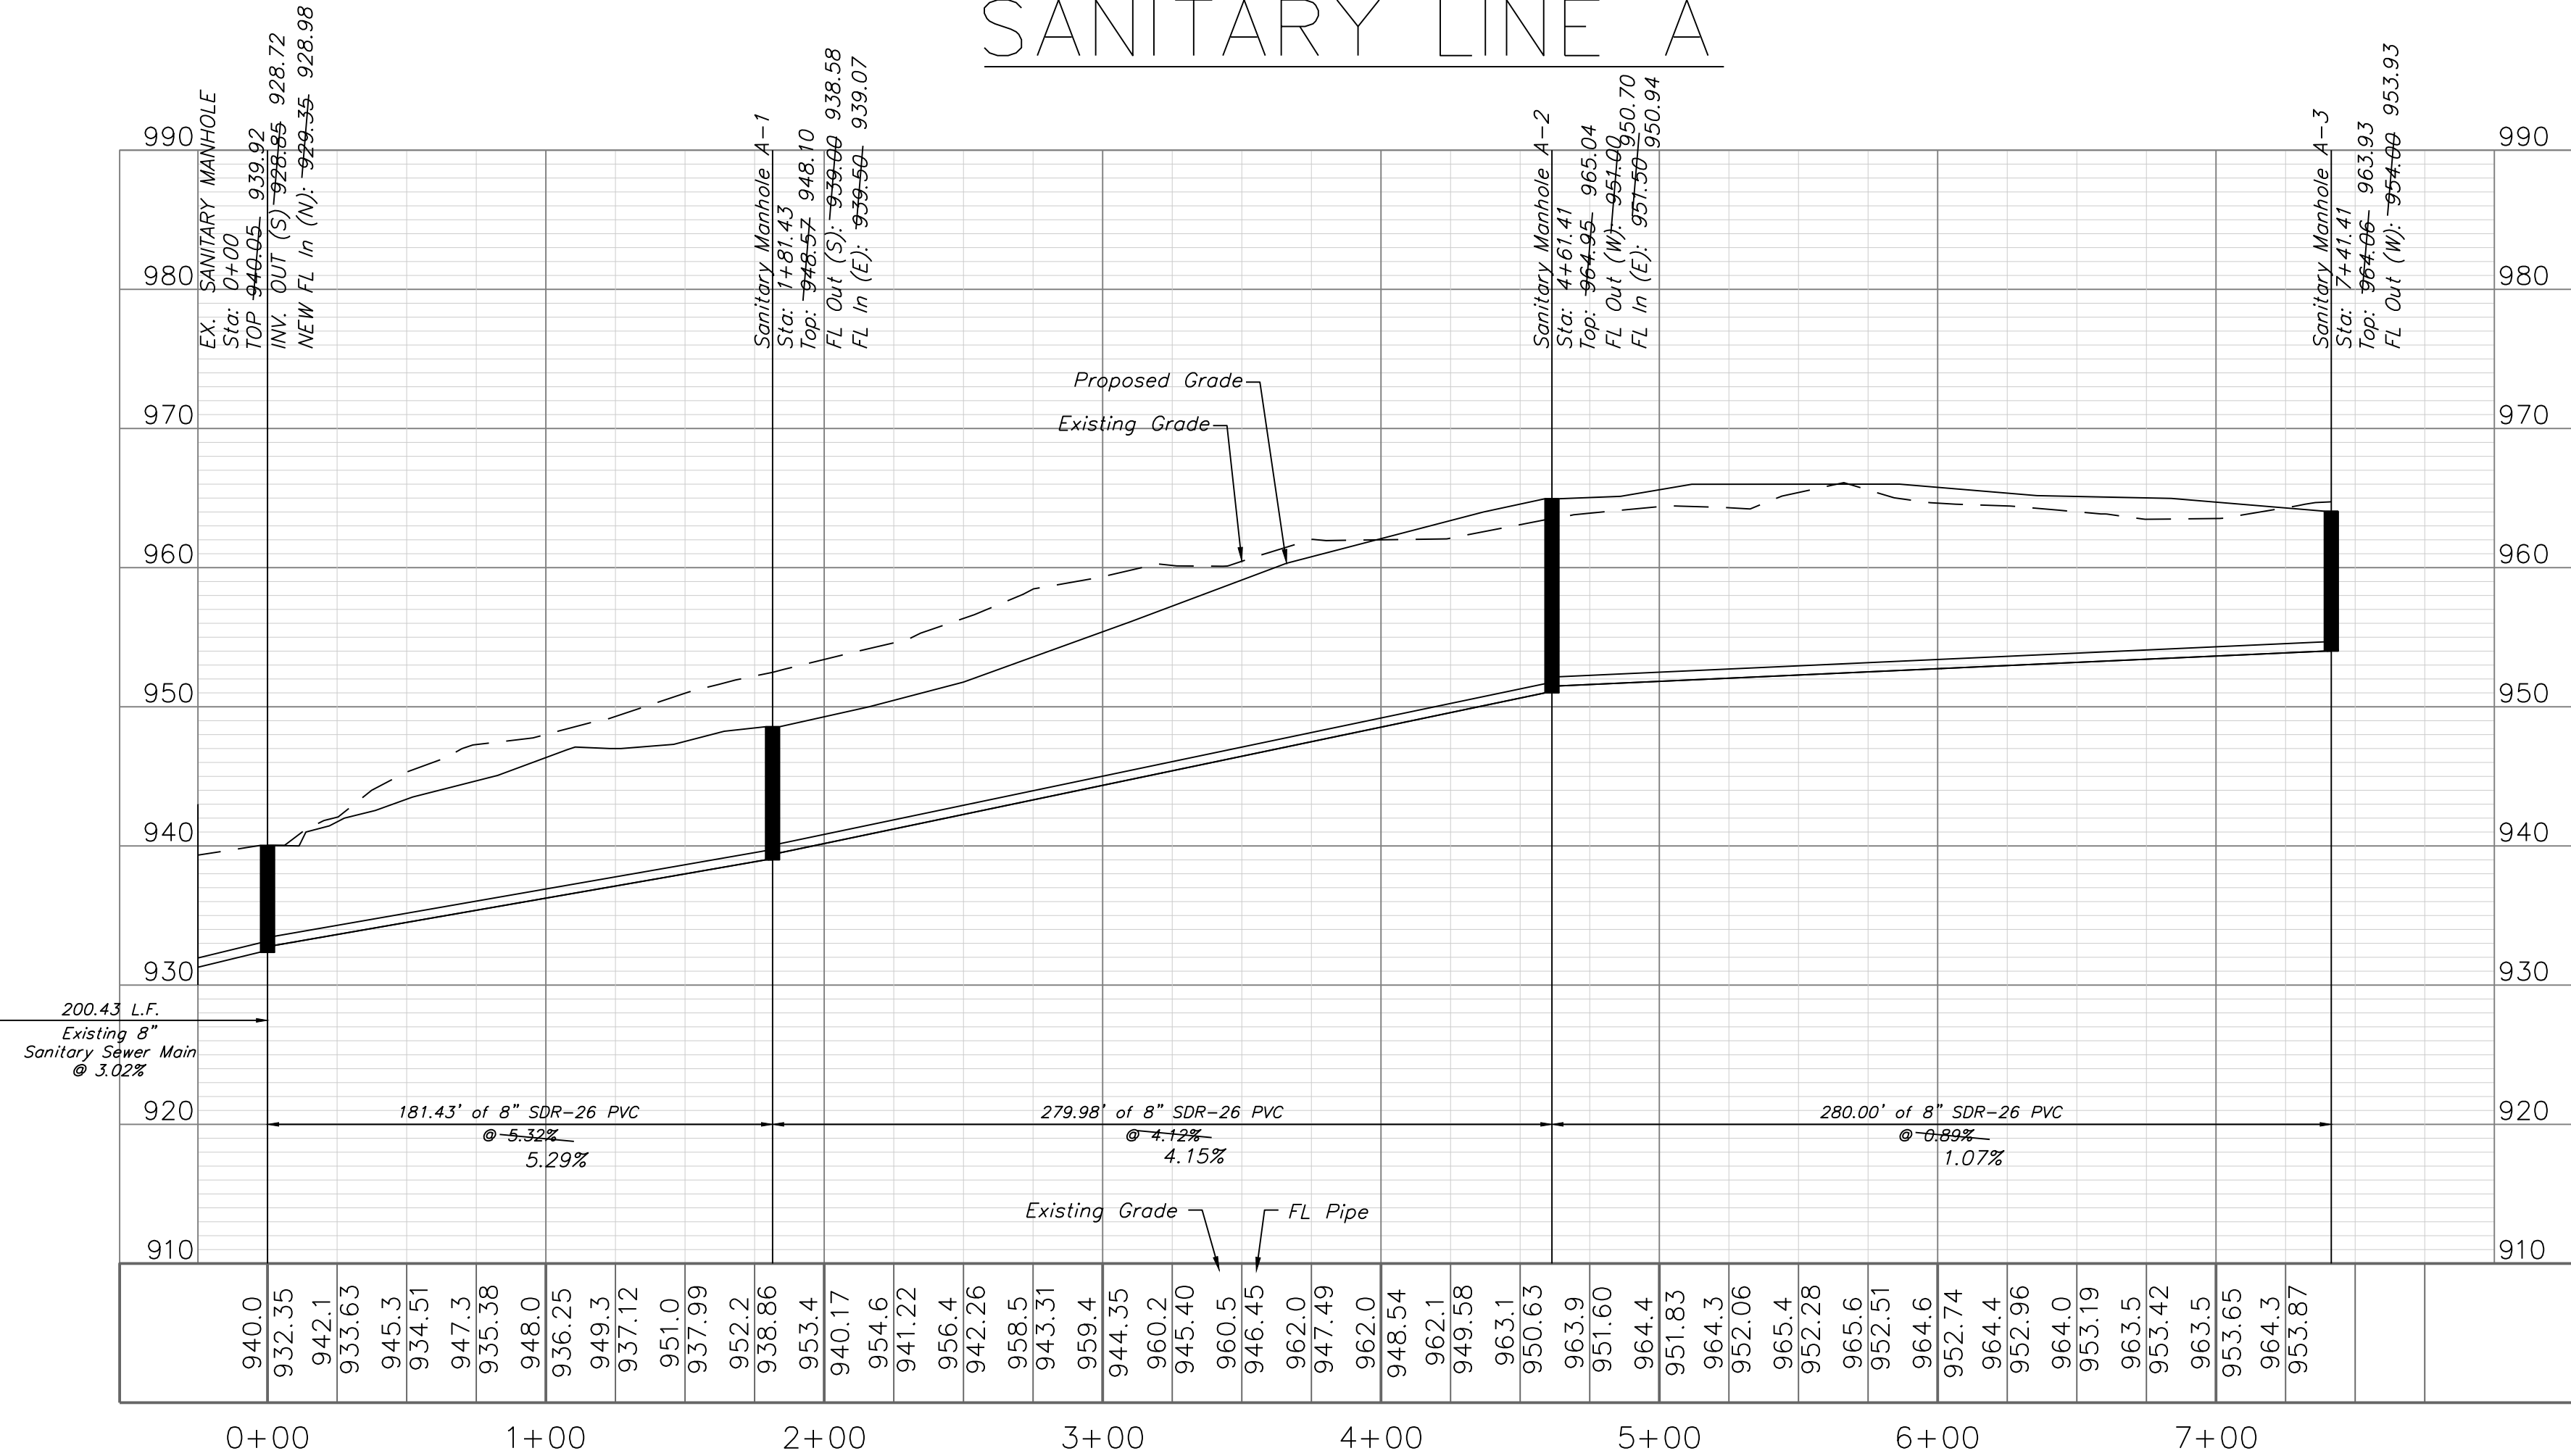

Sewer Stub Table - Line A					
Lot	Station	Main FL	Length	Slope (%)	MSFE
9C	-126.55	925.03	42.68	2	928.93
9B	-116.55	925.33	41.8	2	928.93
9A	-96.55	925.93	45	2	928.93
23	0+24.62	933.62	70.26	2	937.62
24	1+08.65	936.55	85.47	2	940.55
19A	1+97.92	940.09	10	2	943.09
10A	2+01.90	940.25	78.16	2	944.25
19B	2+36.92	941.72	10	2	944.72
10B	2+40.90	941.88	70.63	2	945.88
19C	2+75.92	943.35	10	2	946.35
10C	2+79.90	943.51	70	2	947.51
18A	3+37.92	945.94	10	2	948.94
11A	3+41.90	946.11	70	2	950.11
18B	3+76.92	947.57	10	2	950.57
11B	3+80.90	947.74	70	2	951.74
18C	4+15.92	949.20	10	2	952.20
11C	4+19.90	949.37	70	2	953.37
17A	4+77.92	951.63	10	2	954.63
12A	4+81.90	951.66	70	2	955.66
17B	5+16.92	951.98	10	2	954.98
12B	5+20.90	952.02	70	2	956.02
17C	5+55.92	952.34	10	2	955.34
12C	5+59.90	952.37	70	2	956.37
16A	6+53.92	953.23	10	2	956.23
13A	6+58.27	953.27	70	2	957.27
16B	6+92.92	953.58	10	2	956.58
13B	6+97.07	953.62	70	2	957.62
16C	7+31.92	953.94	10	2	956.94
13C	7+36.07	953.97	70	2	957.97

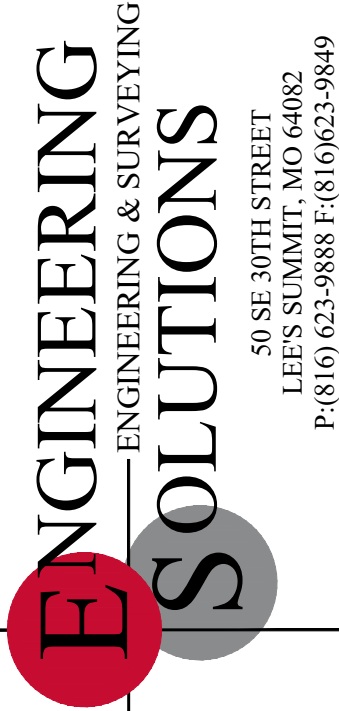


Professional Registration
Missouri
Engineering 2005002186-D
Surveying 2005008319-D
Kansas
Engineering E-1695
Surveying LS-218
Oklahoma
Engineering 6284
Nebraska
Engineering CA2821

THE TOWNHOMES OF CHAPEL RIDGE-2ND PLAT
LOTS 9-19 & TRACTS A-D
Lee's Summit, Jackson County, Missouri

Project:
VILLAS OF CHAPEL
RIDGE-LSMO
Issue Date:
April 10, 2020

Sanitary Plan and Profile
Construction Plans for:
THE TOWNHOMES OF CHAPEL RIDGE-2ND PLAT
LOTS 9-19 & TRACTS A-D
Lee's Summit, Jackson County, Missouri

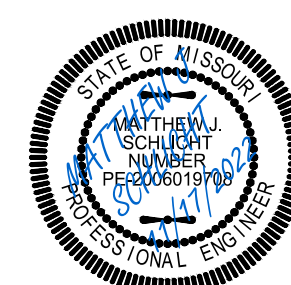

Matthew J. Schlicht
MO PE 0006019708
KS PE 19071
OK PE 25226
NE PE E-14335

REVISIONS
11/17/2022 As-Built

 

Record Drawing

RECORD DRAWING
The information provided on this drawing conforms to construction records; it is not intended for construction, implementation or recording purposes; and it is solely based on information obtained by my firm.


"100-00 100 100", "4-00% 1.15% slope", or "8-inch HDPE-PVC pipe" are all typical examples of revisions that indicate that design data has been replaced with "as-built" information. All other data is as designed and has not been field verified.

Date: 11/17/2022
Certified by: Matthew J. Schlicht
Title: Engineer
Firm: Engineering Solutions

GENERAL NOTE:
1 ~ ALL CONSTRUCTION SHALL CONFORM TO THE CITY OF LEE'S SUMMIT DESIGN AND CONSTRUCTION MANUAL AS ADOPTED BY ORDINANCE 5813.
2 ~ TRENCH CHECKS SHALL BE INSTALLED AT ALL SANITARY WYES LOCATION.
3 ~ COMPACTED FILL SHALL BE PLACED TO A MINIMUM 18" ABOVE THE TOP OF THE PIPE PRIOR TO INSTALLATION.

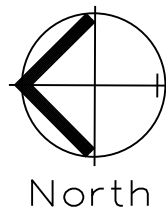


Sanitary Plan & Profile
SCALE: 1" = 50'

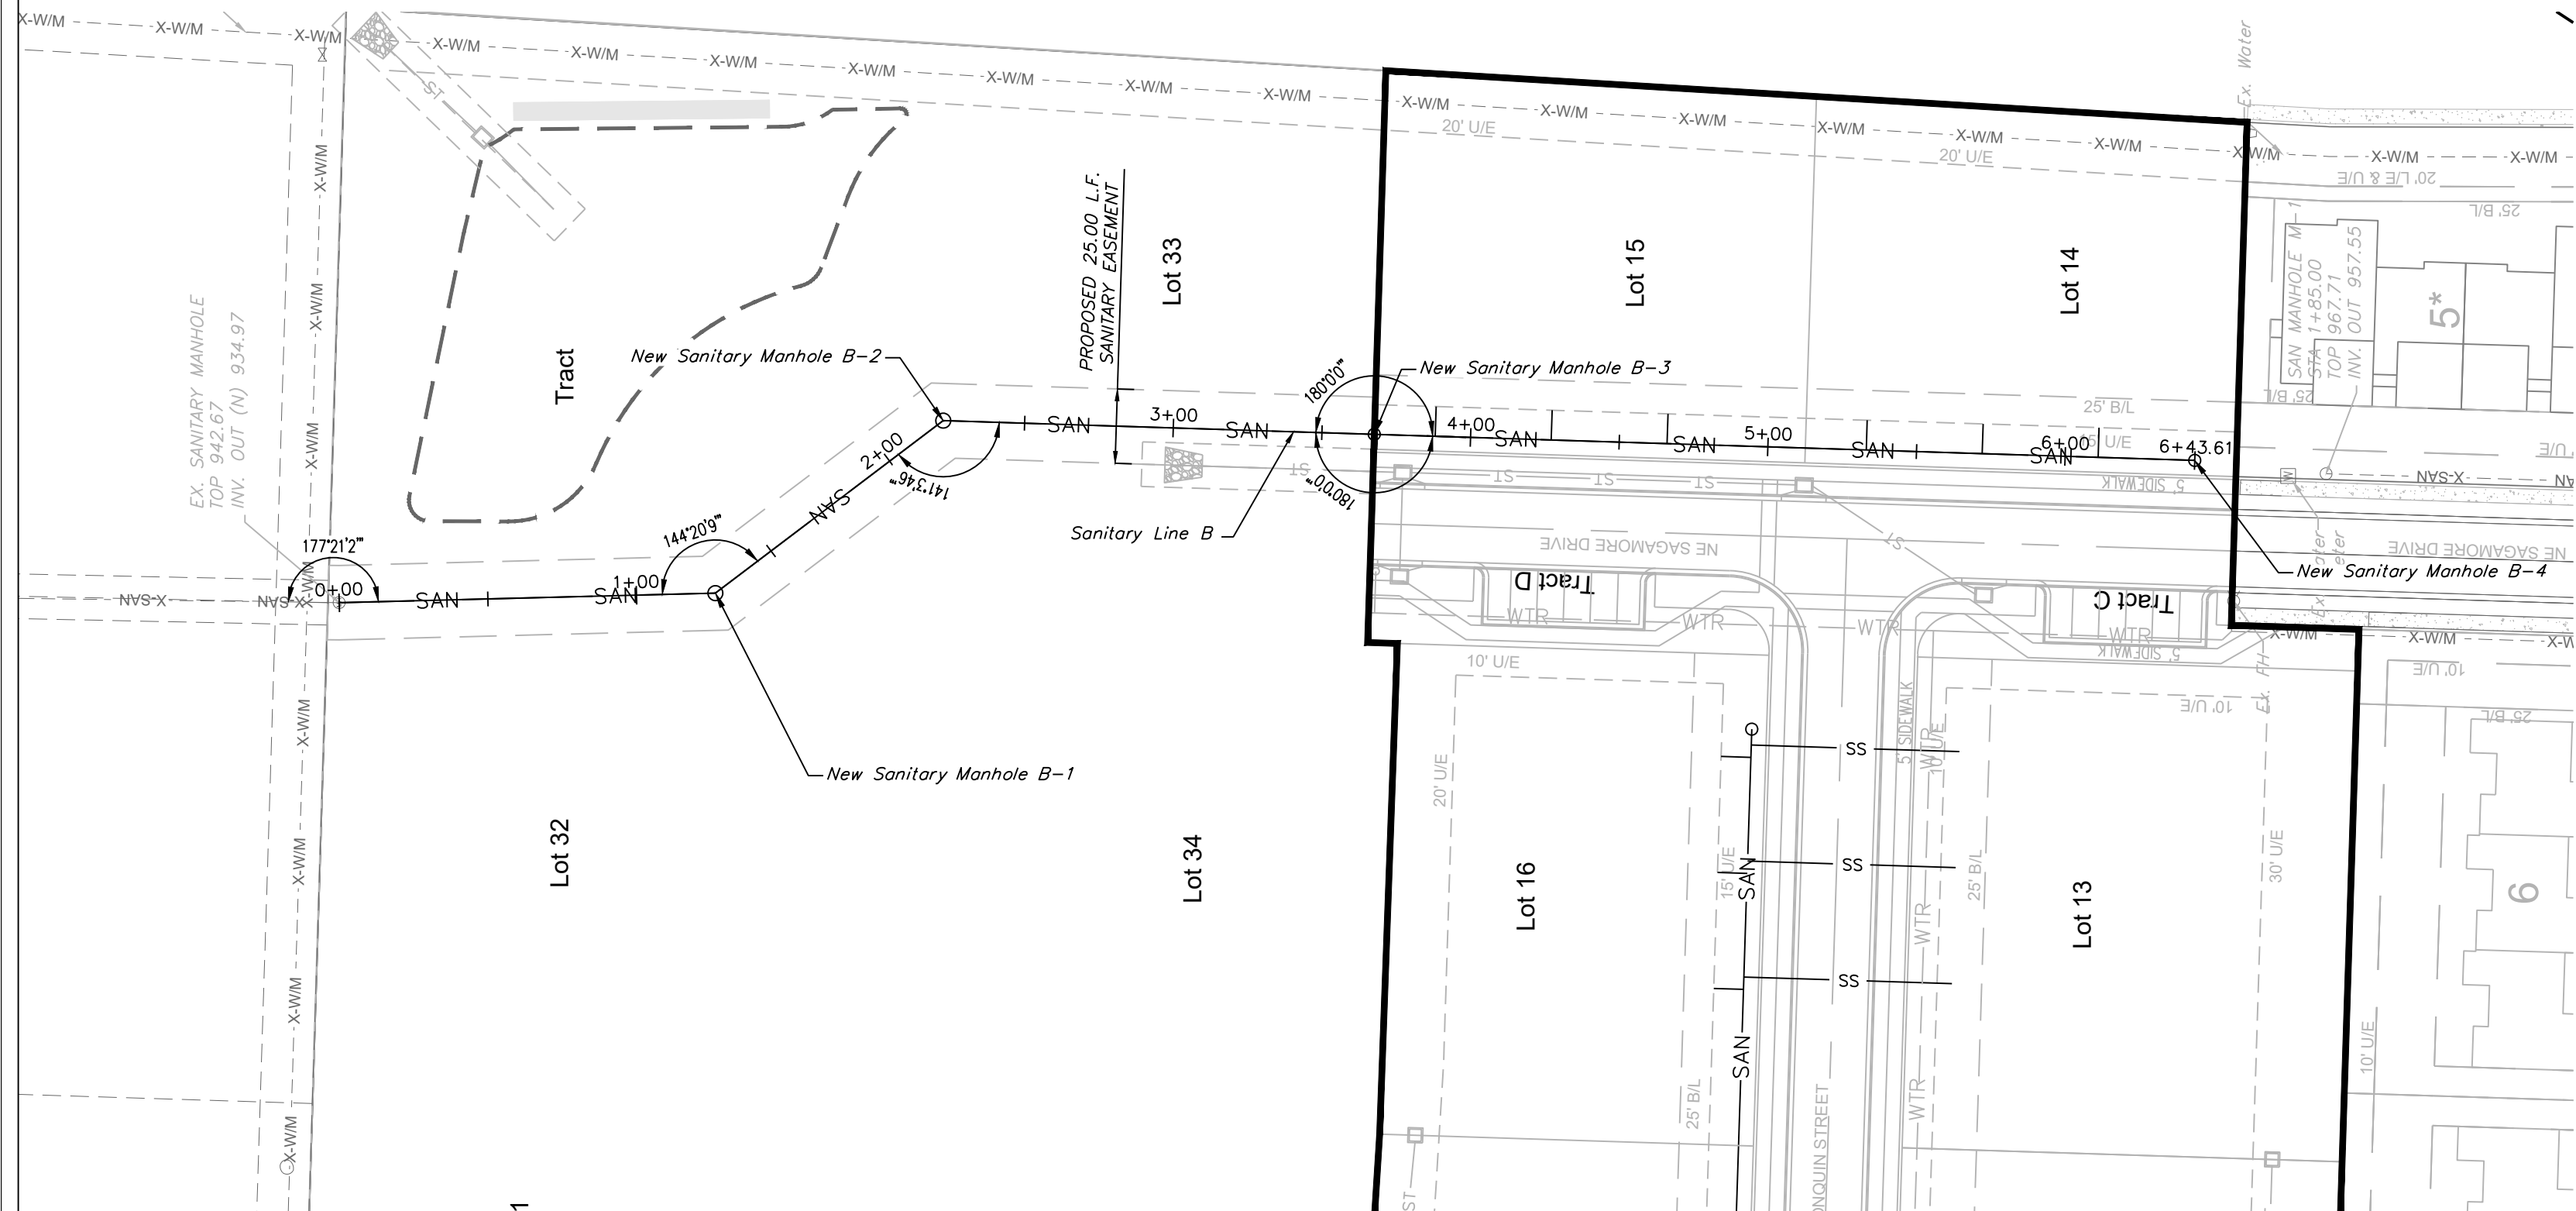

Sewer Stub Table - Line B					
Lot	Station	Main FL	Length	Slope	MSFE
15A	3+88.11	947.88	10	2	950.88
15B	4+27.11	949.20	10	2	952.2
15C	4+66.11	950.53	10	2	953.53
14A	5+33.11	952.81	10	2	955.81
14B	5+72.11	954.14	10	2	957.14
14C	6+11.11	955.48	10	2	958.48

SANITARY LINE B

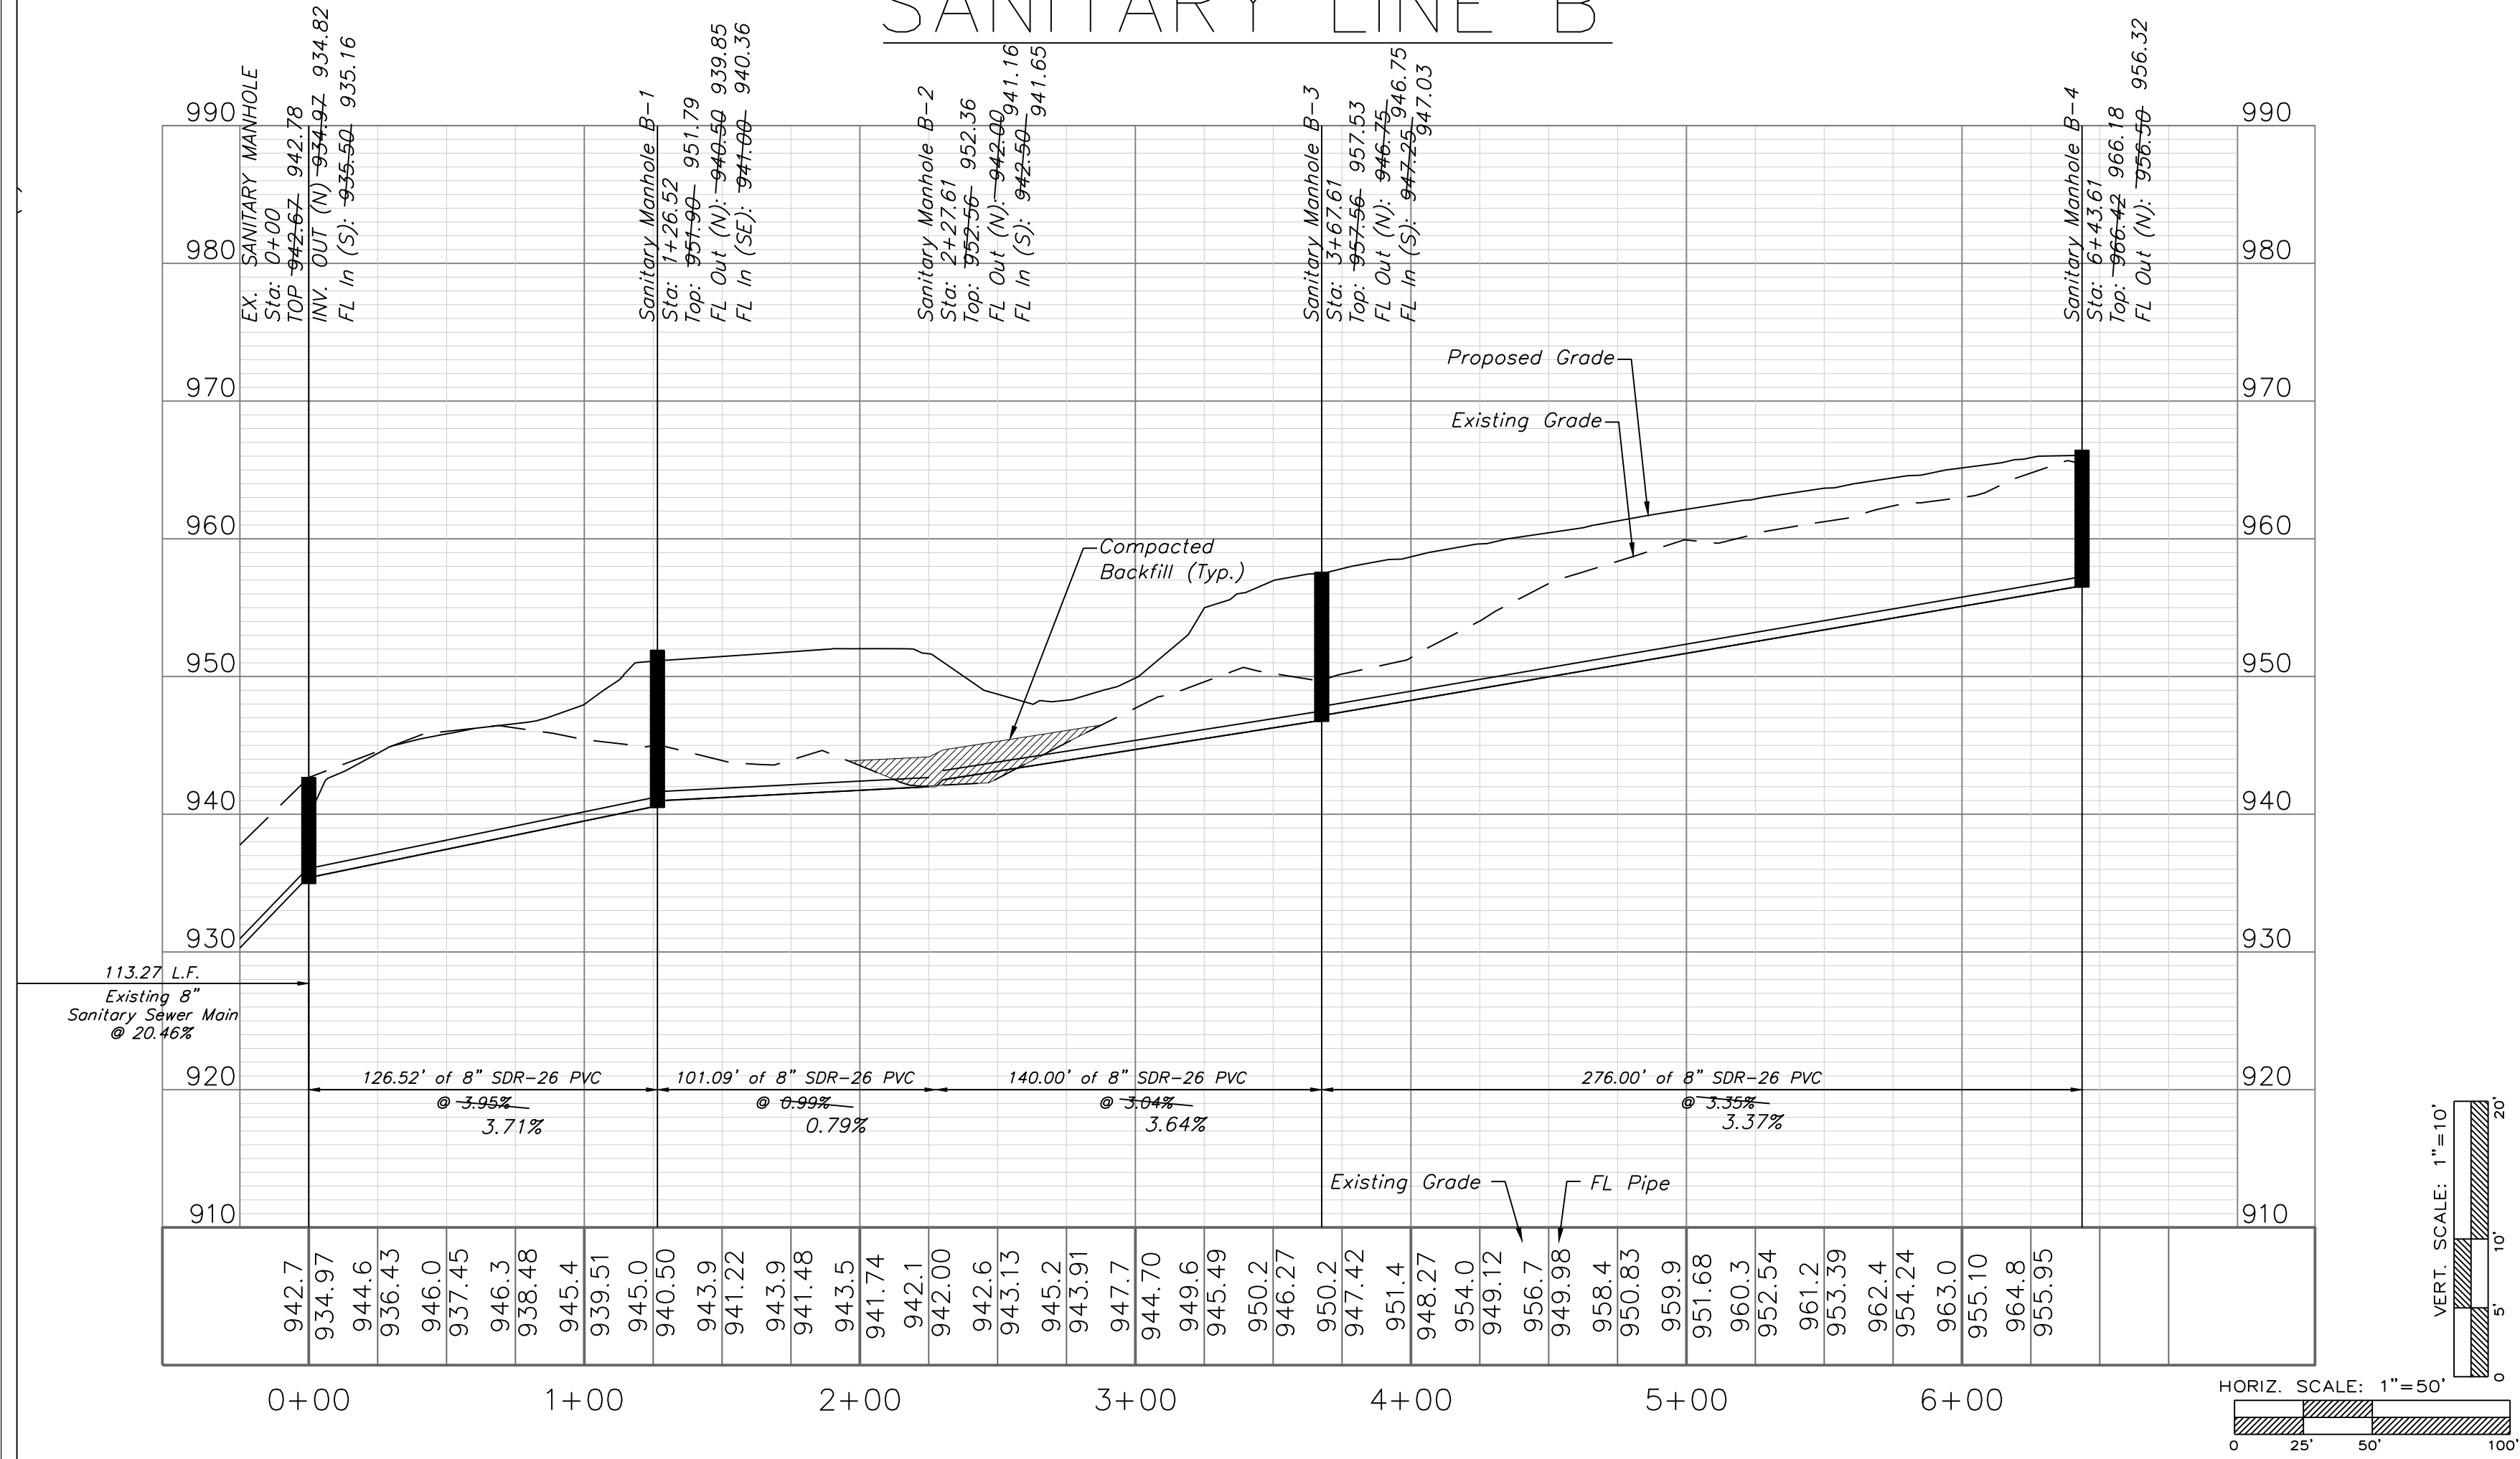

Record Drawing

RECORD DRAWING
The information provided on this drawing conforms to construction records; it is not intended for construction, implementation or recording purposes; and it is solely based on information obtained by my firm.

"100-00 100.10", "4-00% 1.15% slope", or "8-inch HDPE-PVC pipe" are all typical examples of revisions that indicate that design data has been replaced with "as-built" information. All other data is as designed and has not been field verified.

Date: 11/17/2022
Certified by: Matthew J. Schlicht
Title: Engineer
Firm: Engineering Solutions




Professional Registration
Missouri
Engineering 2005002186-D
Surveying 2005008319-D
Kansas
Engineering E-1685
Surveying LS-218
Oklahoma
Engineering 6254
Nebraska
Engineering CA2821

THE TOWNHOMES OF CHAPEL RIDGE-2ND PLAT
LOTS 9-19 & TRACTS A-D
Lee's Summit, Jackson County, Missouri





Project:
VILLAS OF CHAPEL
RIDGE-LSMO
Issue Date:
April 10, 2020

Sanitary Plan and Profile
Construction Plans for:
THE TOWNHOMES OF CHAPEL RIDGE-2ND PLAT
LOTS 9-19 & TRACTS A-D
Lee's Summit, Jackson County, Missouri

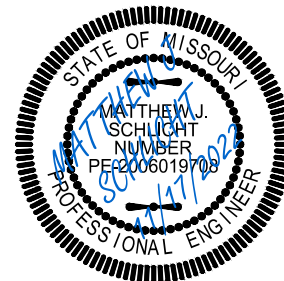

Matthew J. Schlicht
MO PE 2006019708
KS PE 19071
OK PE 25226
NE PE E-14335

REVISIONS
11/17/2022 As-Built

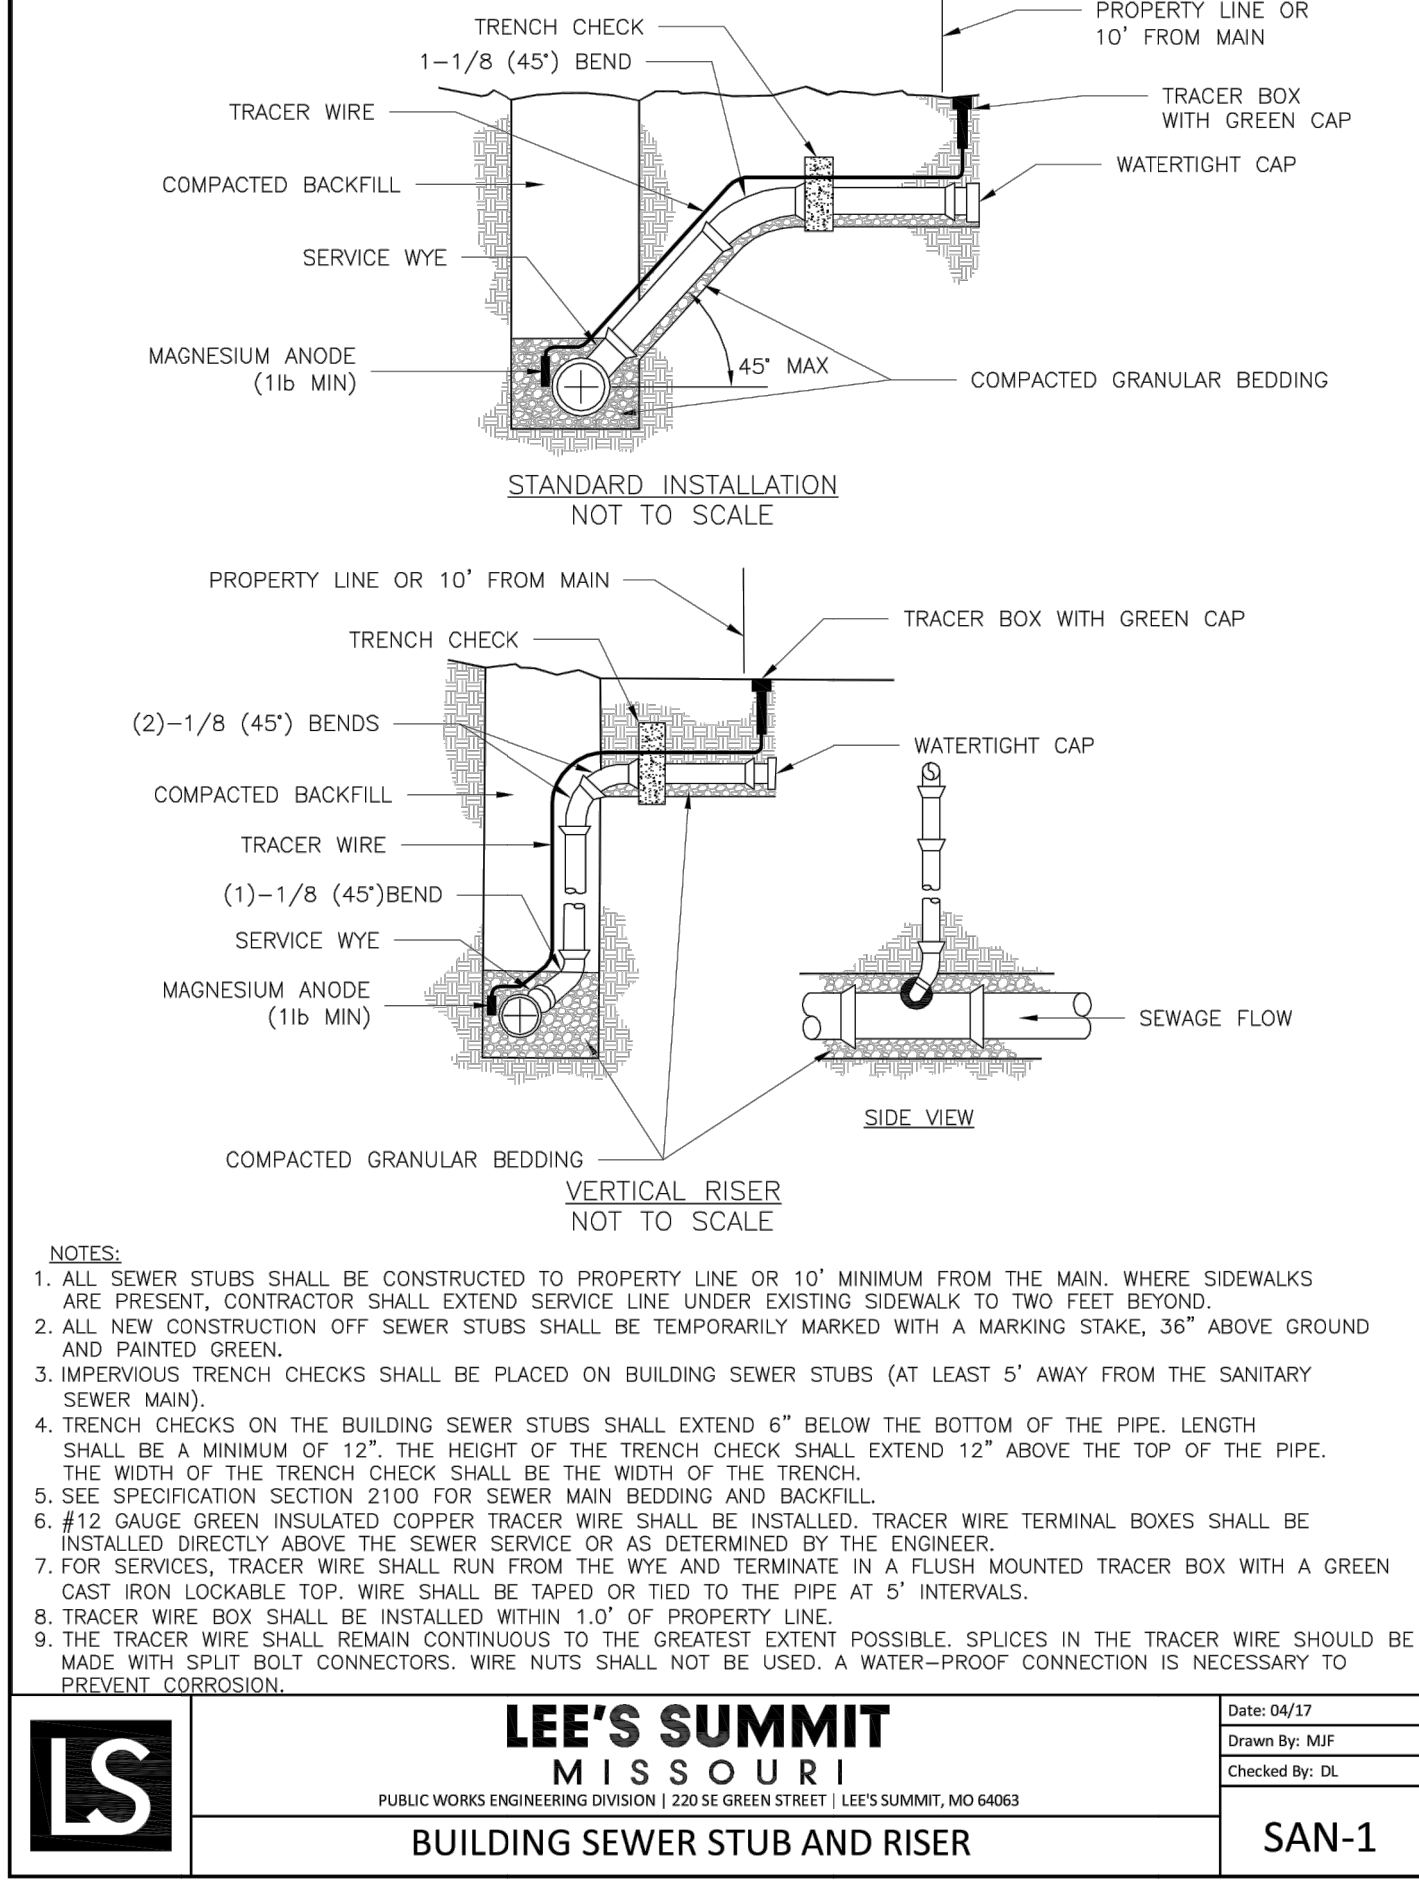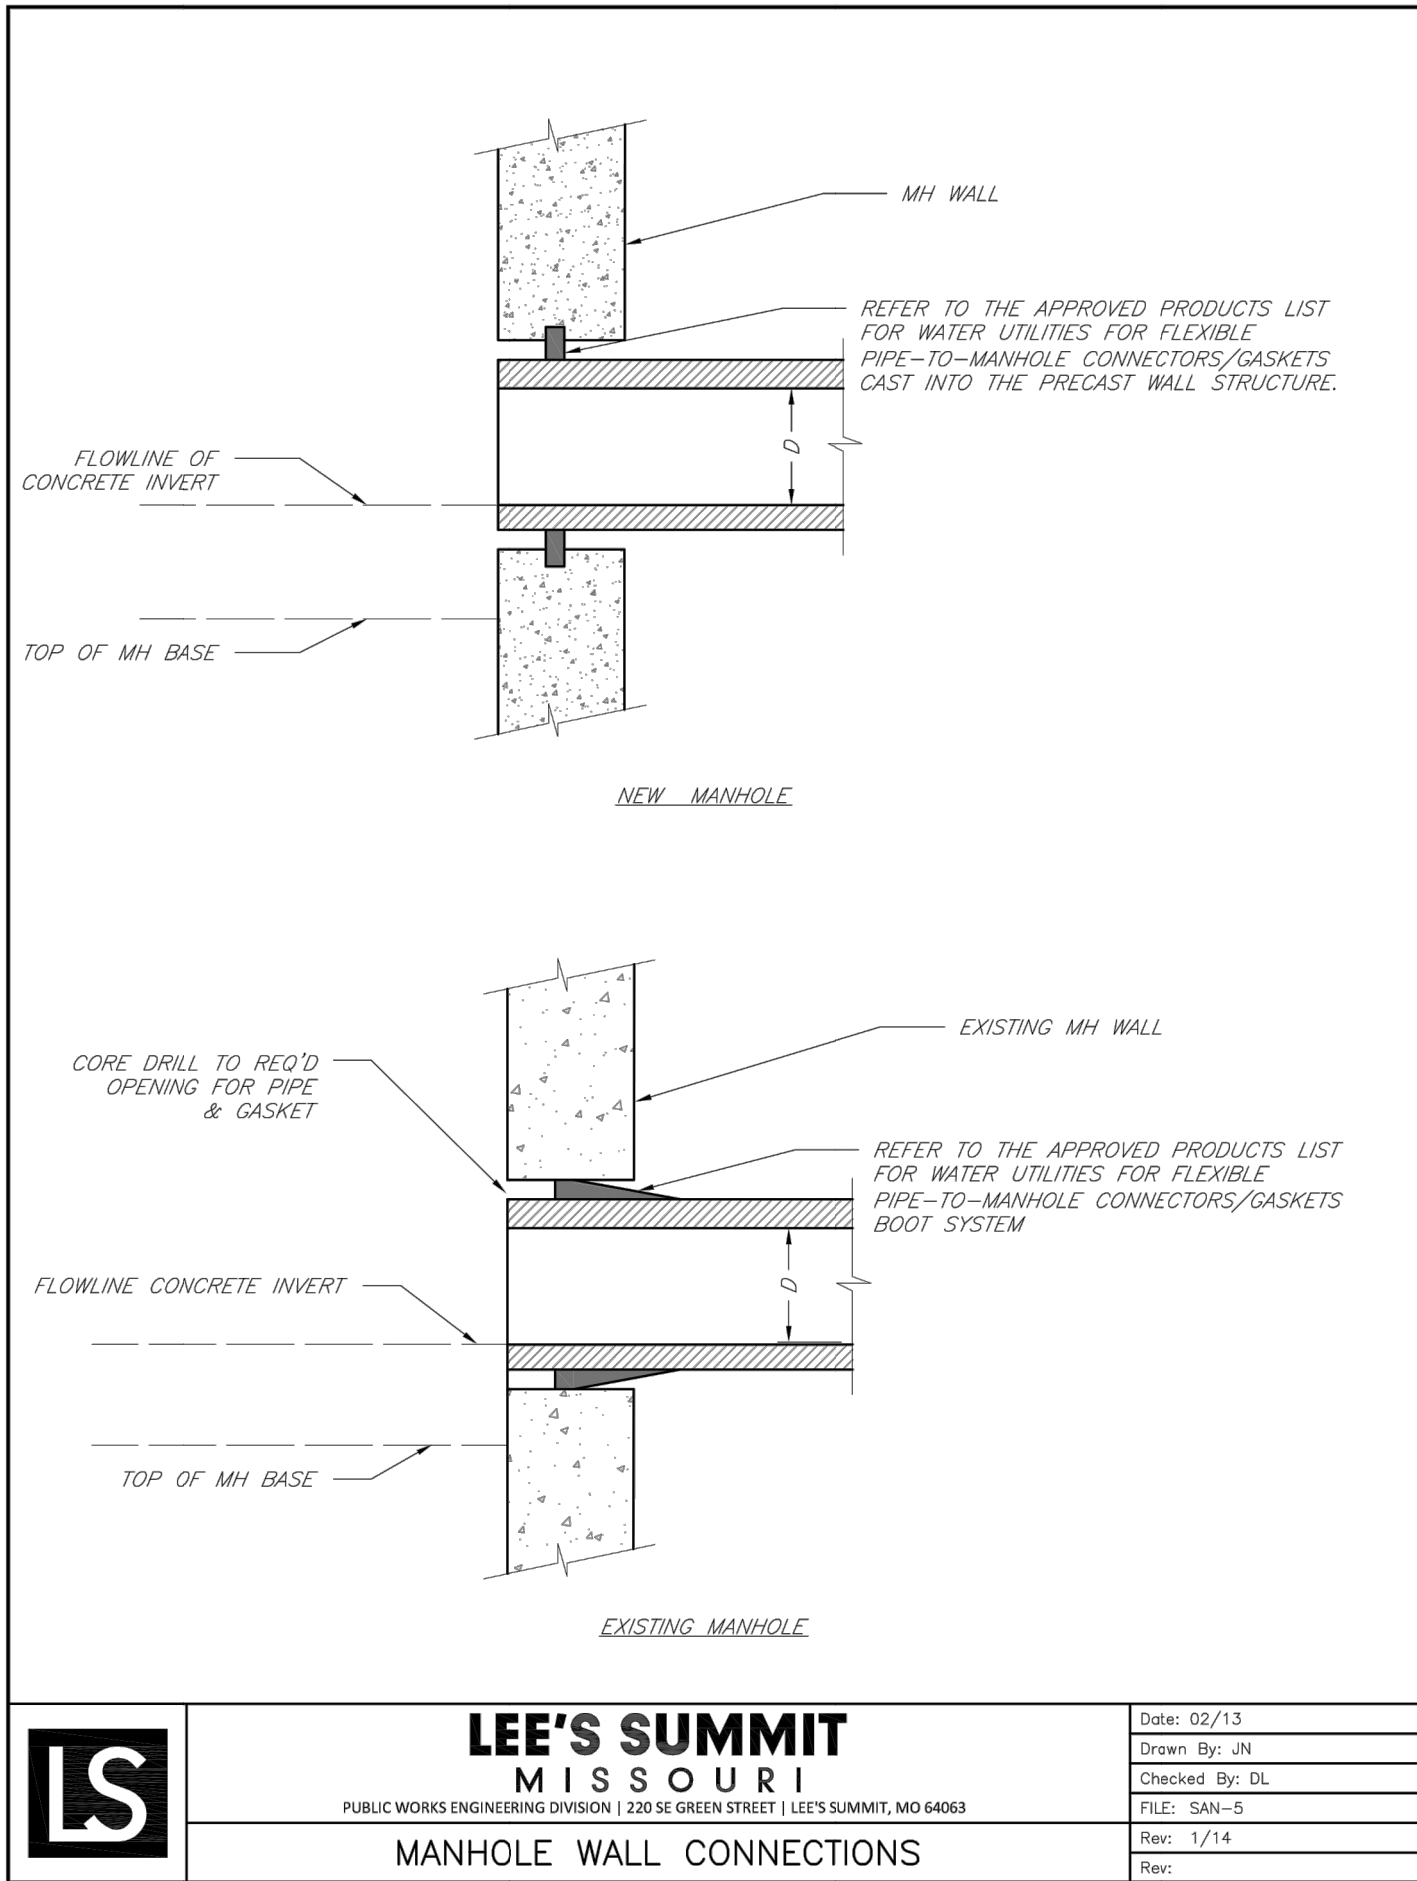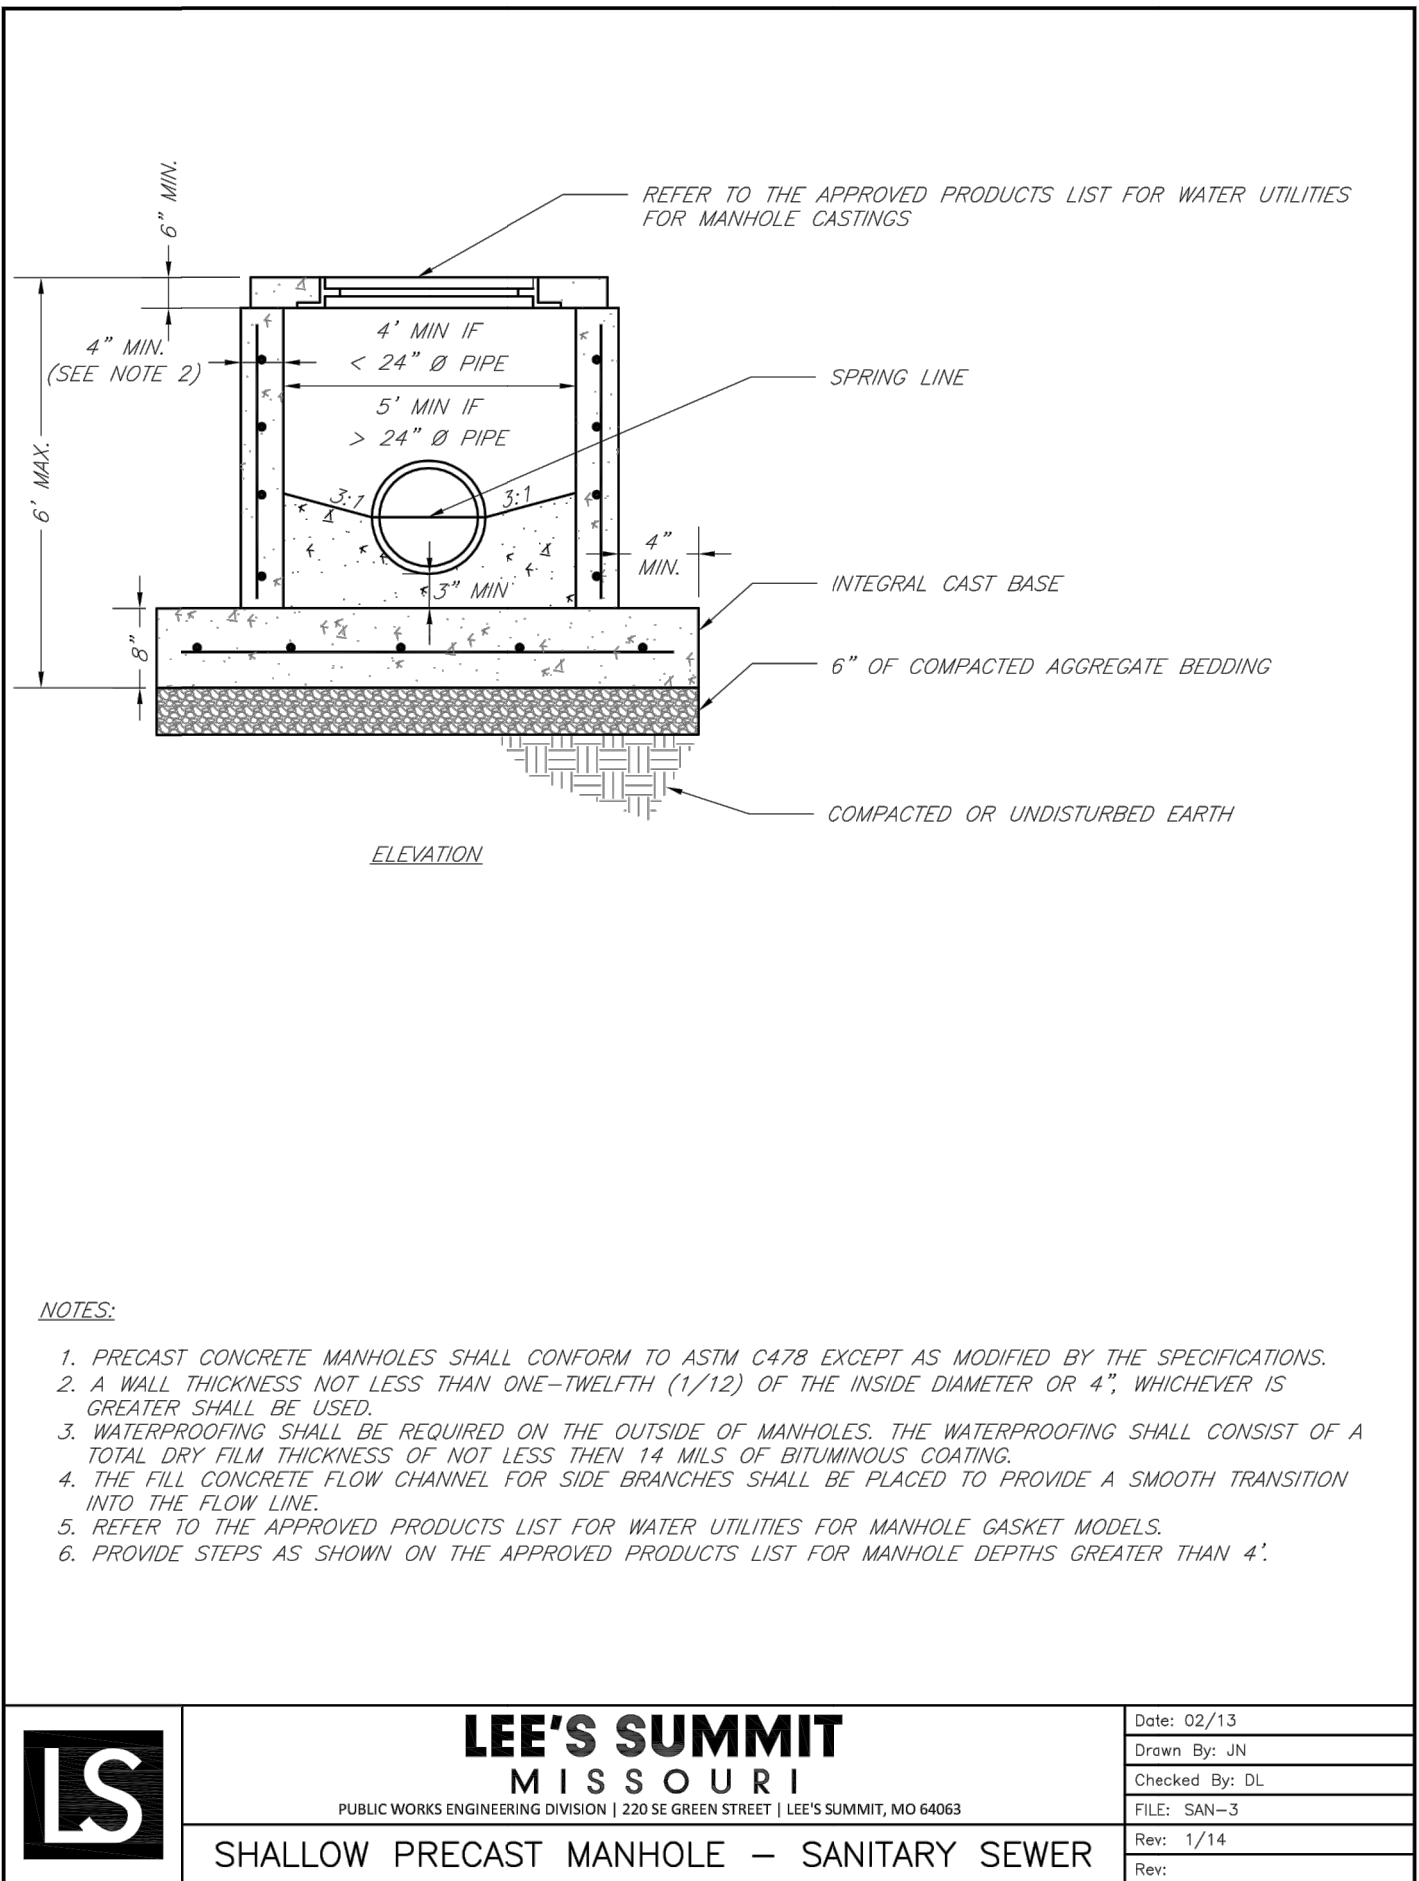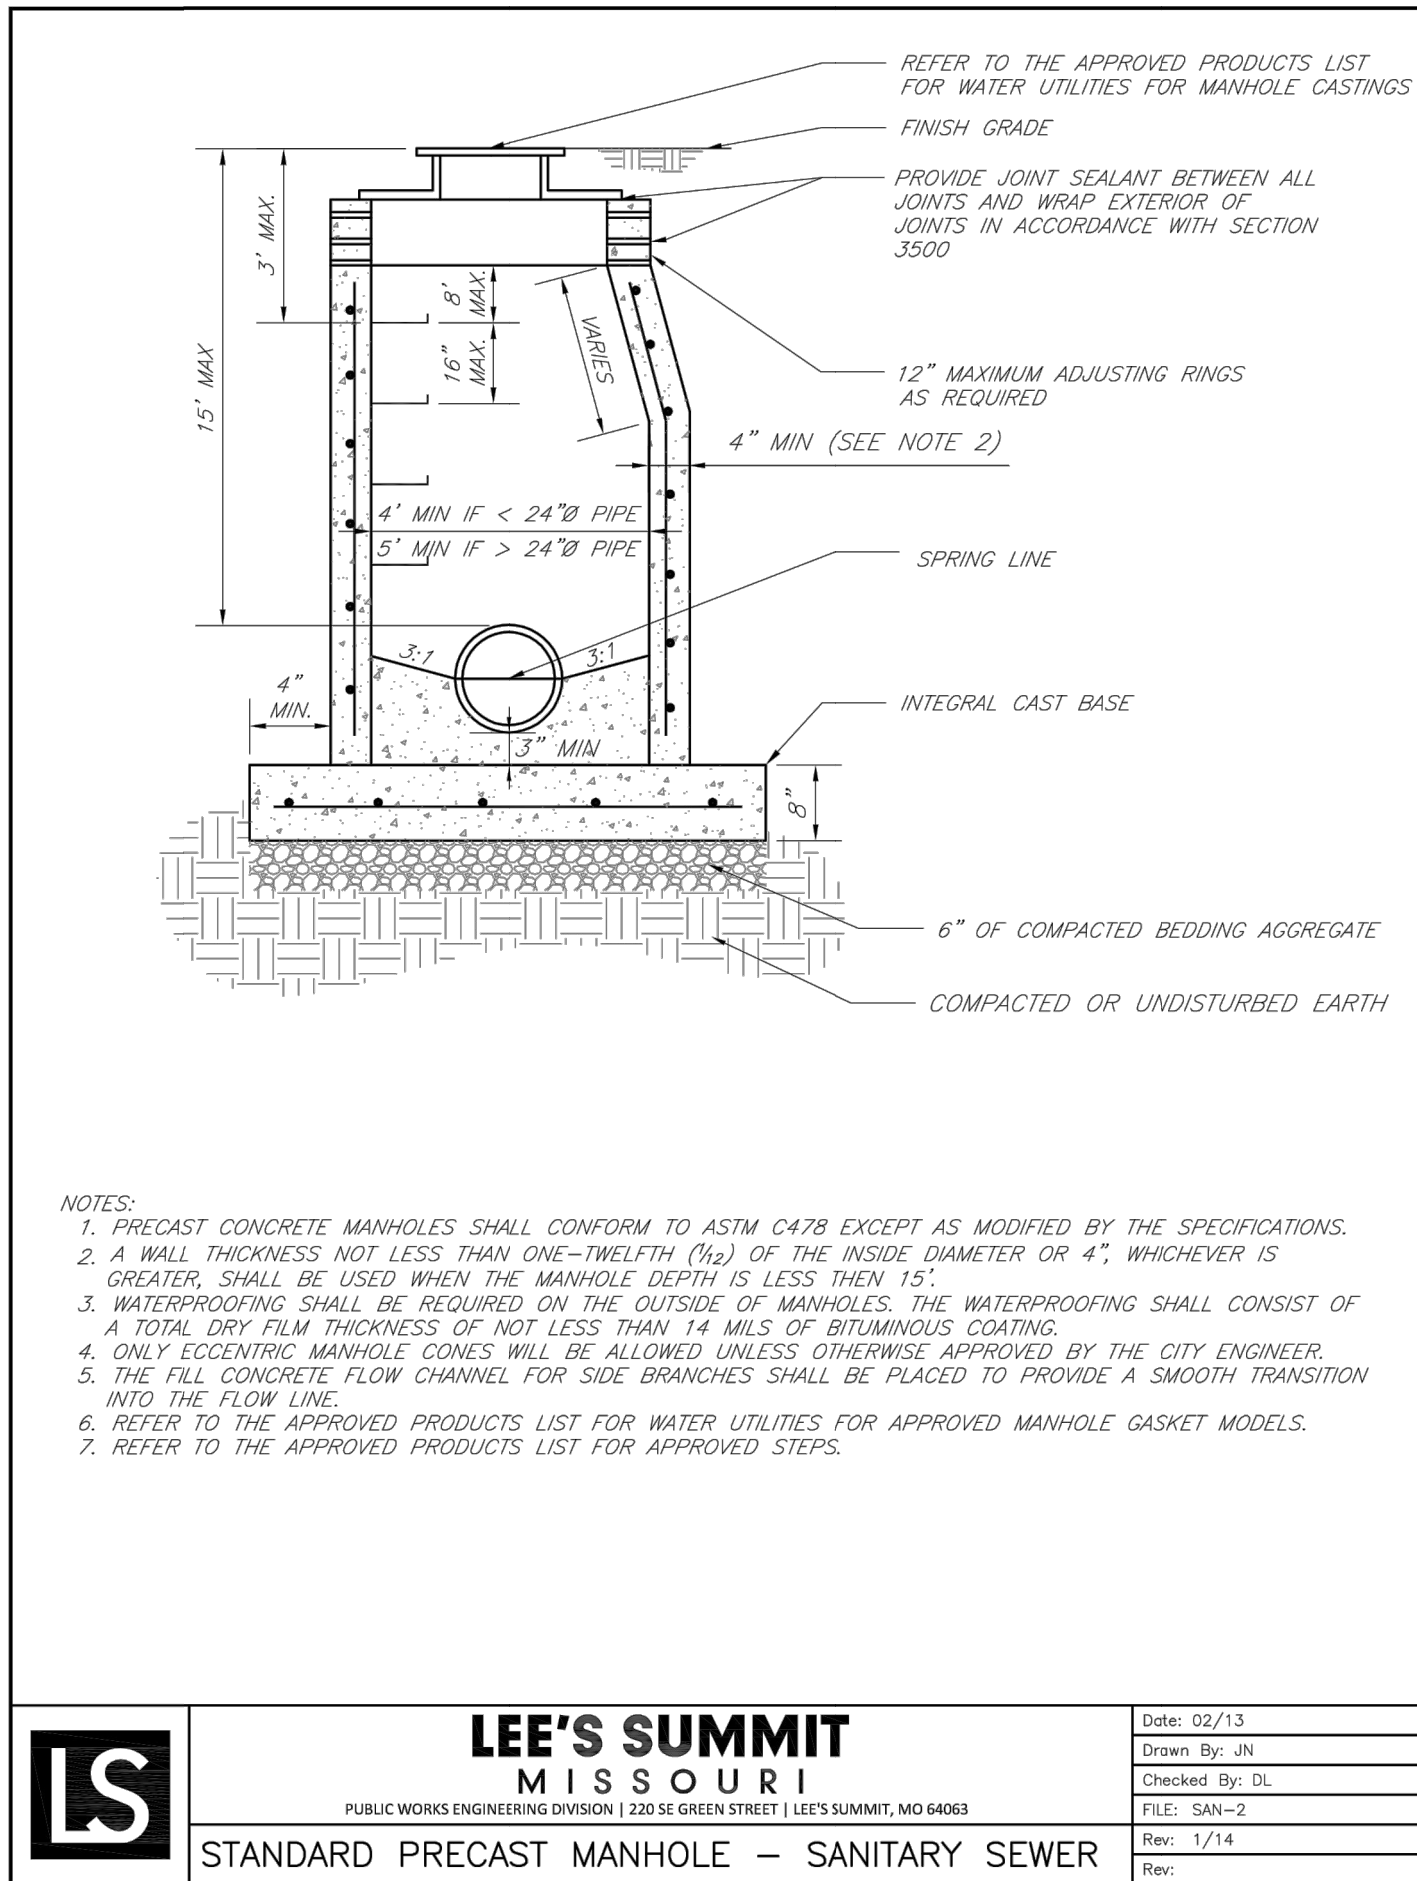

GENERAL NOTE:

1 - ALL CONSTRUCTION SHALL CONFORM TO THE CITY OF LEE'S SUMMIT DESIGN AND CONSTRUCTION MANUAL AS ADOPTED BY ORDINANCE 5813.

2 - TRENCH CHECKS SHALL BE INSTALL AT ALL SANITARY WYES LOCATION.

Record Drawing

RECORD DRAWING

The information provided on this drawing conforms to construction records; it is not intended for construction, implementation or recording purposes; and it is solely based on information obtained by my firm.

"100-00 100.10", "4-00% 1.15% slope", or "8-inch HDPE-PVC pipe" are all typical examples of revisions that indicate that design data has been replaced with "as-built" information. All other data is as designed and has not been field verified.

Date: 11/17/2022

Certified by: Matthew J. Schlicht

Title: Engineer

Firm: Engineering Solutions