


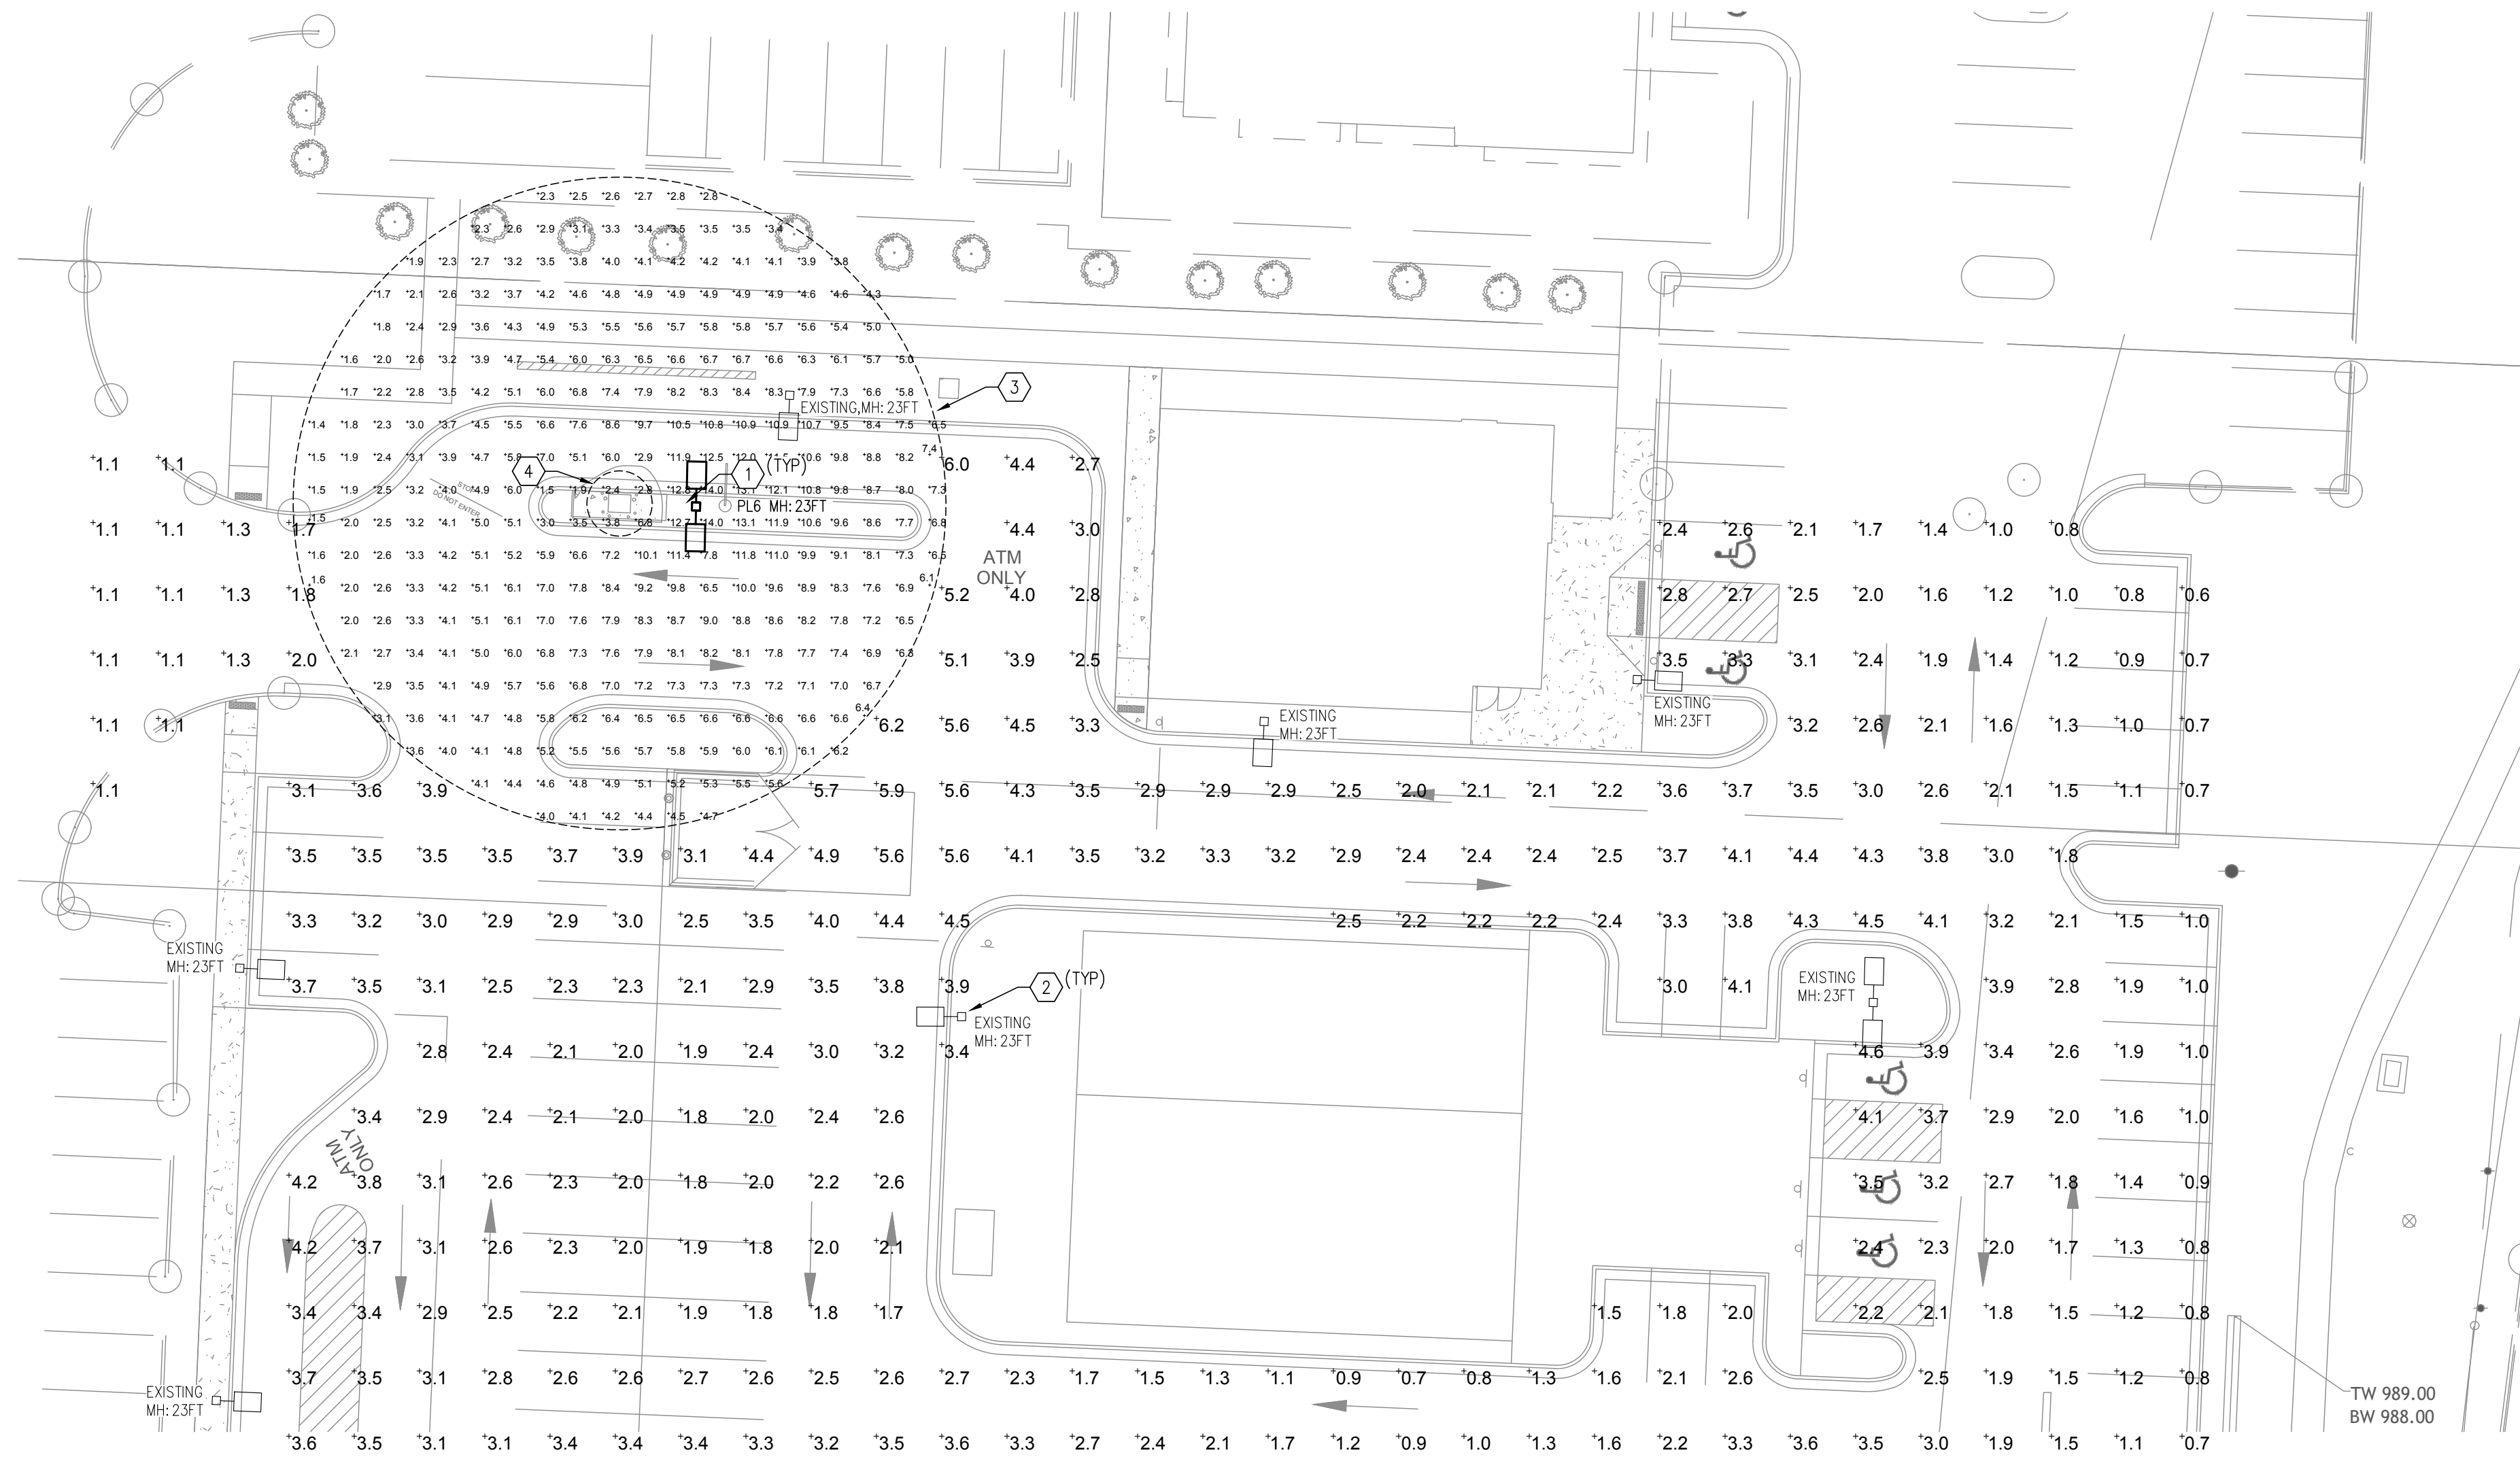

1 LOT 9 SITE LIGHTING
SCALE: 1:20

PLAN NOTES:

- 1 NEW POLE MOUNTED LIGHT FIXTURE SHALL BE INSTALLED IN APPROXIMATE LOCATION SHOWN. RE: LIGHTING FIXTURE SCHEDULE ON SHEET SL200
- 2 EXISTING POLE LIGHT TO REMAIN.
- 3 50FT. OWNER RADIUS LIGHTING CALCULATION
- 4 5FT OWNER RADIUS LIGHTING CALCULATION

CALCULATION SUMMARY

AREA	AVE	MAX	MIN	MAX/MIN	AVE/MIN
LOT 9	2.59	6.2	0.6	10.33	4.32
LOT 9 - ATM 50' RADIUS	3.95	6.8	2.4	2.83	1.65
LOT 9 - ATM 50' RADIUS	5.75	14.0	1.4	10.00	4.11

NOTES

1) ATM CALCULATIONS FROM 3FT ABOVE FINISHED GRADE.

MEP ENGINEER



InSite Group


DEDICATION. DESIRE. INTEGRITY.
3540 NE RALPH POWELL RD, STE. B
LEE'S SUMMIT, MO 64064
PHONE: (816) 228-3377

STREETS OF WEST PRYOR
LOT 9 ATM
SITE LIGHTING

LEE'S SUMMIT, MO
JACKSON COUNTY

THIS DRAWING is provided as an instrument of service by the Engineer, and is intended for use on this Project ONLY. This Drawing Remains the Property of the Engineer and shall be Returned to him upon completion of the construction work. All Drawings, Specifications, Ideas, Designs and Arrangements appearing herein constitute the original and unpublished Work of the Engineer. Any Reproductions, Use or Disclosure of the Proprietary Information contained herein Without the PRIOR Written Consent of the Engineer is strictly Prohibited.
© Copyright 2023 InSite Group, Inc.

SEAL

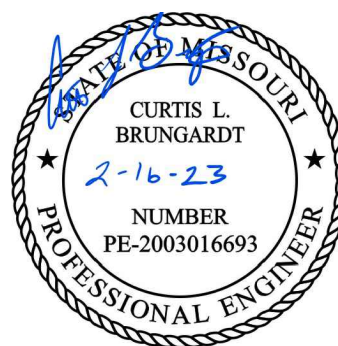

REV	DESCRIPTION	DATE

ISSUE DATE:	02/03/2023
REASON FOR ISSUE:	PERMIT
PROJECT NUMBER:	20-6828-2
PROJECT PHASE:	CD
DRAWN BY:	AWN
CHECKED BY:	CLB

SHEET TITLE:

PHOTOMETRIC
PLAN

SHEET NUMBER:

SL101

- WaveLinx
- Enlighted

NOTES:
1. Visit <https://www.designlights.org/search/> to confirm qualification. Not all product variations are DLC qualified.
2. IBA Certified for 3000K CCT and warmer only.

[illegible]

Product Family	Camera Type	Data Backhaul
LumenSafe Technology LumenSafe Technology	D =Standard Dome Camera H =Hi-Res Dome Camera Z =Remote PTZ Camera	C =Cellular, Rogers A =Cellular, AT&T V =Cellular, Verizon S =Cellular, Sprint R =Cellular, Rogers W =Wi-Fi Networking w/ Omni Directional Antenna E =Ethernet Networking



* OR PRIOR APPROVED EQUAL



SL200