




LIGHT FIXTURE SCHEDULE							
PLAN MARK	MANUFACTURER	MODEL NUMBER	MOUNTING	FINISH	LAMP CODE	LAMP QUANTITY	NOTES
AA	MCGRAW-EDISON	GALN-SA2C-740-U-T4FT-20180 DEG	20" POLE	BRONZE	216 LED PER HEAD	2	1,2,3
BB	MCGRAW-EDISON	GALN-SA2C-740-U-T4FT	20" POLE	BRONZE	216 LED PER HEAD	1	1,2,3
A	LITHONIA	WPX1-LED-P2-30K-1MVOLT-E14WC-DDBXD	WALL/SURFACE	BRONZE	24W LED	-	1,2,3
B	GREEN CREATIVE	12NCDDL6DIM/930/EXT	RECESSED	BLACK	12W LED	-	1,2,3,6
B1	GREEN CREATIVE	12NCDDL6DIM/930/EXT-EM	RECESSED	BLACK	12W LED	-	1,2,3,4,6

NOTES LEGEND

- 1 - PROVIDE WET LOCATION RATED FIXTURE
- 2 - PROVIDE COLD LOCATION RATED BALLAST
- 3 - PROVIDE SQUARE STRAIGHT STEEL POLE RATED FOR 100 MPH WIND GUSTS, PRIMED AND PAINTED TO MATCH FIXTURE
- 4 - PROVIDE EMERGENCY BATTERY
- 5 - PROVIDE ALL ACCESSORIES FOR A COMPLETE INSTALLATION.
- 6 - PROVIDE WEATHER PROOF JUNCTION BOX FOR DRIVERS AND ELECTRICAL CONNECTIONS ABOVE SOFFIT.

GENERAL NOTES

- 1 - POLE LIGHTING SHALL BE IN SCALE WITH TENANT'S BUILDING HEIGHT, AND NEVER TALLER THAN THE BUILDING (18 FEET)

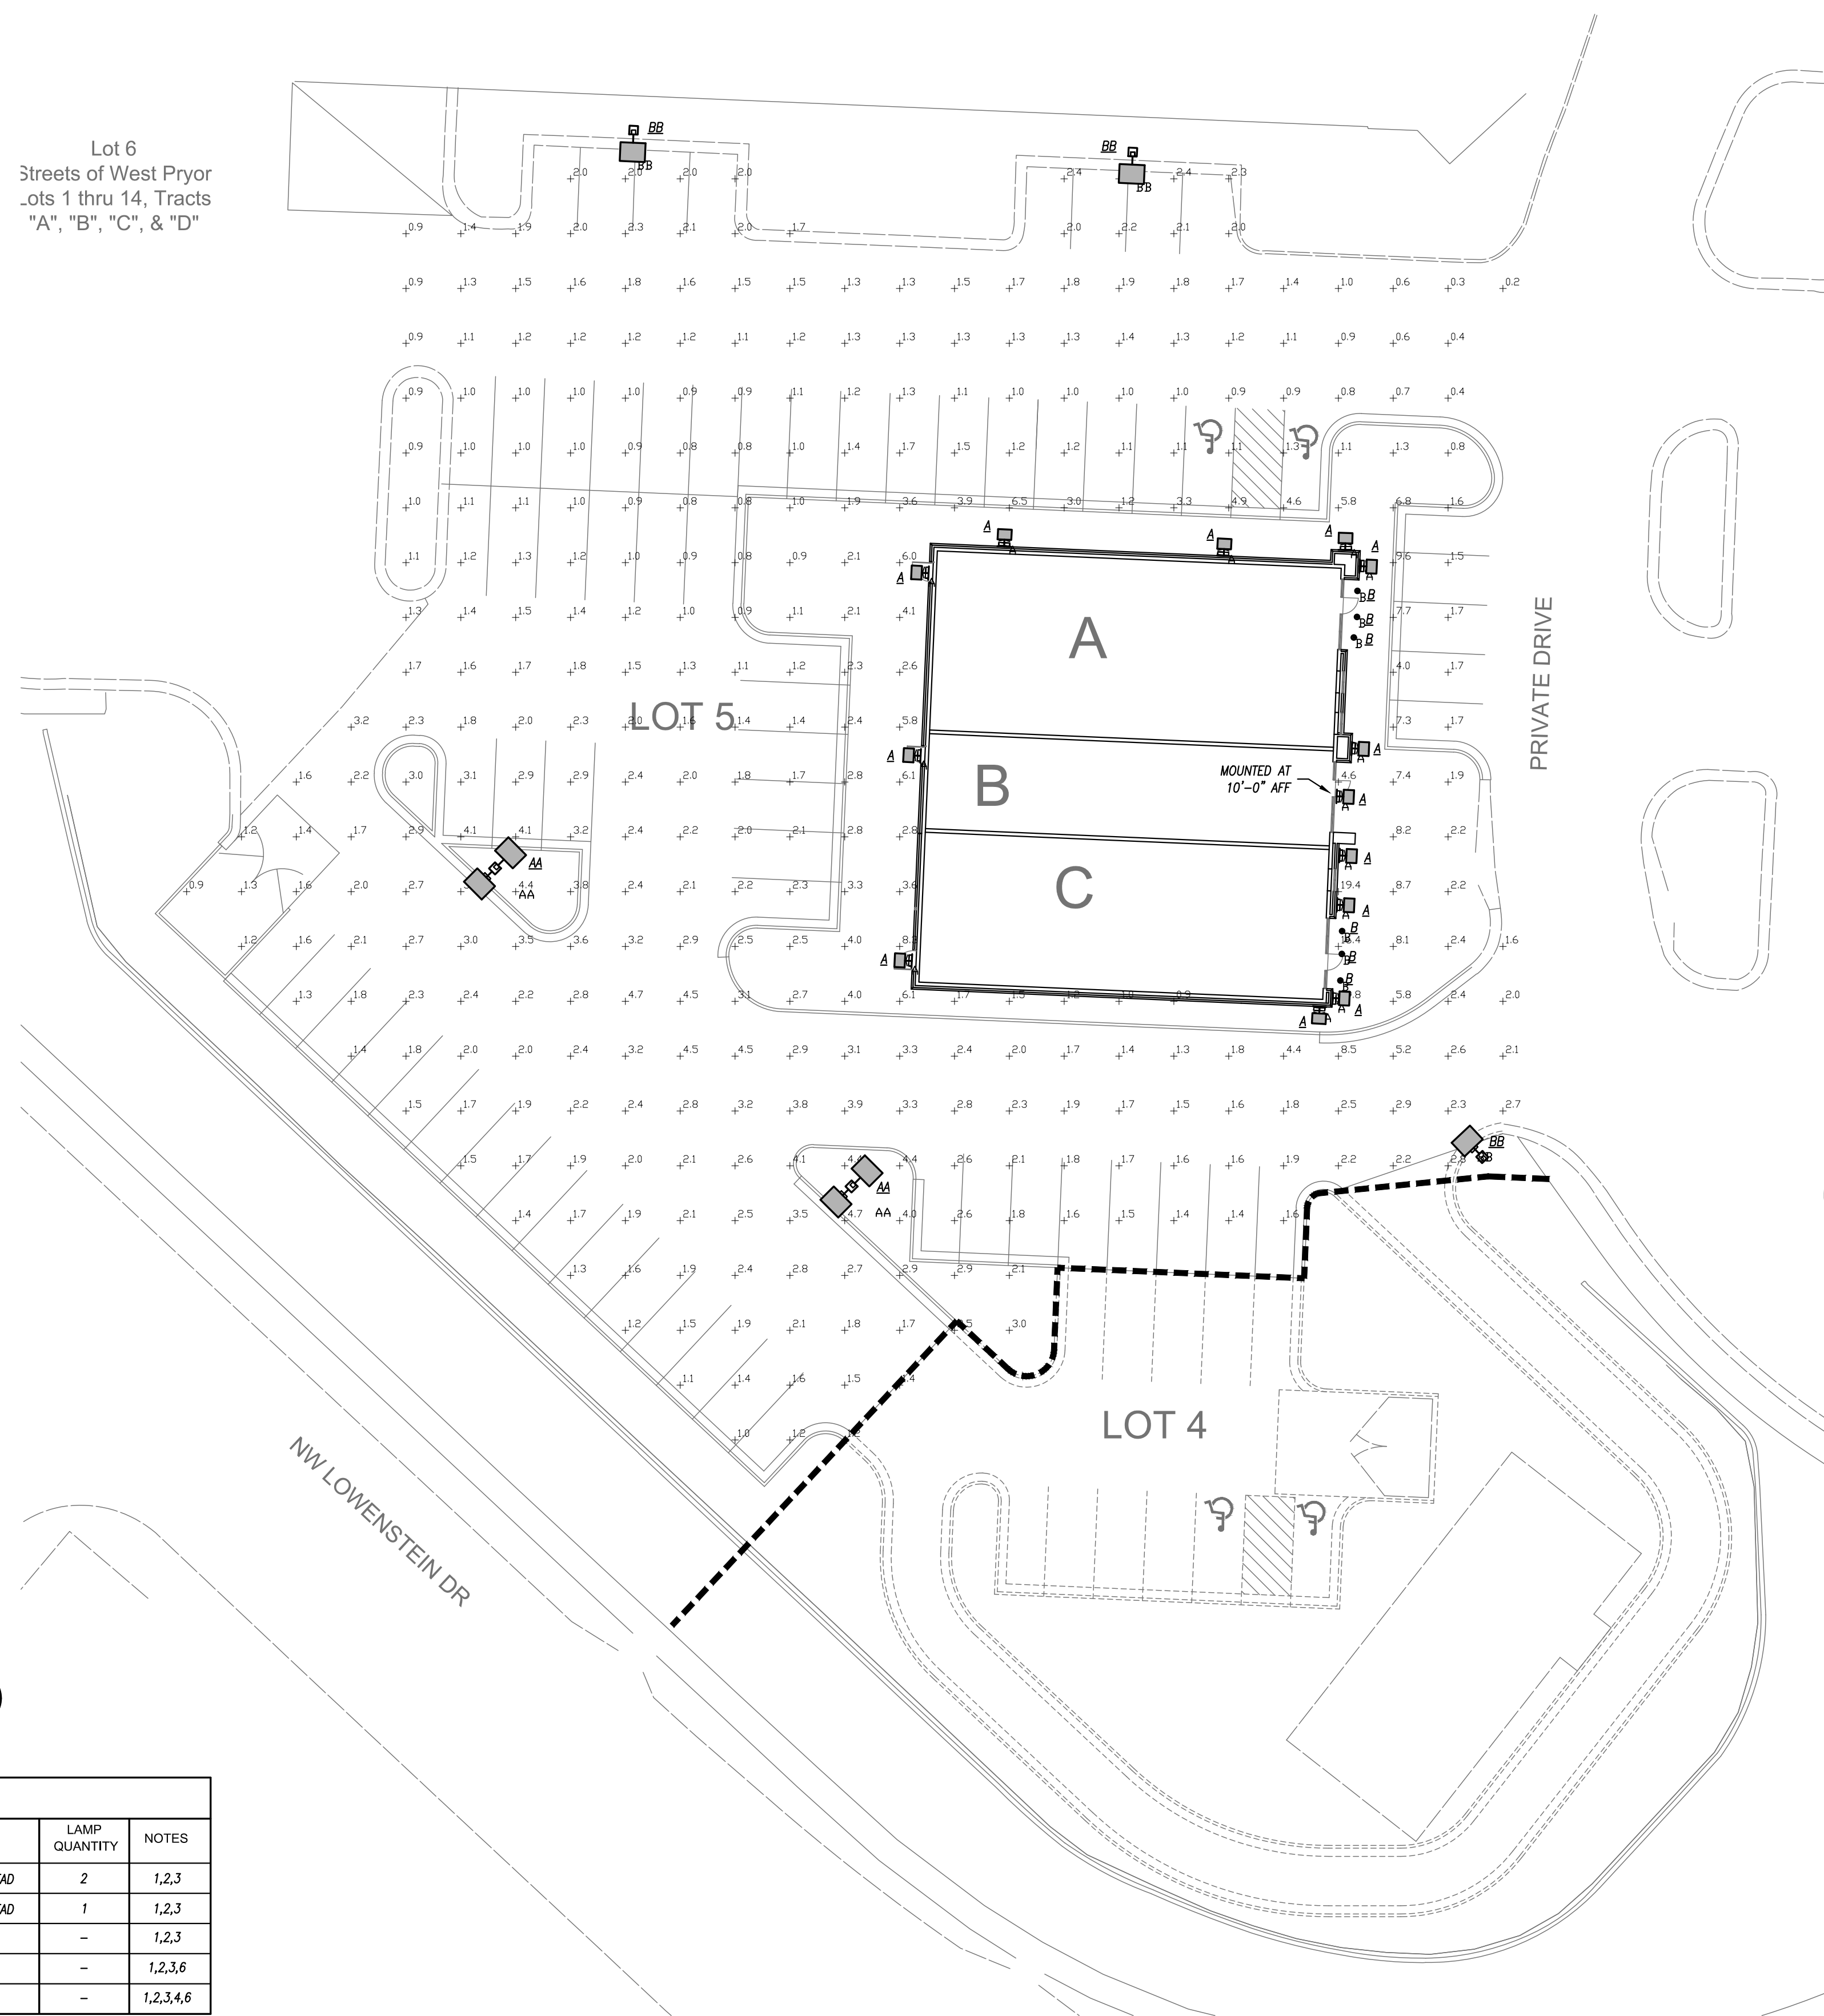

schwerdt design group
architecture interiors
planning
500 north broadway
oklahoma city, ok 73102
phone: 405.231.3105
fax: 405.231.3115

PRELIMINARY
NOT FOR CONSTRUCTION

PROJECT - TOP LINE - DESCRIPTION
SOWP LOT 5
 CITY, STATE ZIP

SUBMISSION DATES
MAY 2ND, 2023

SHEET TITLE
SITE PHOTOMETRIC
PLAN

PROJECT NUMBER
230117

SHEET NUMBER
ME-101

FILE PATH:
DATE:
DRAWN BY: