


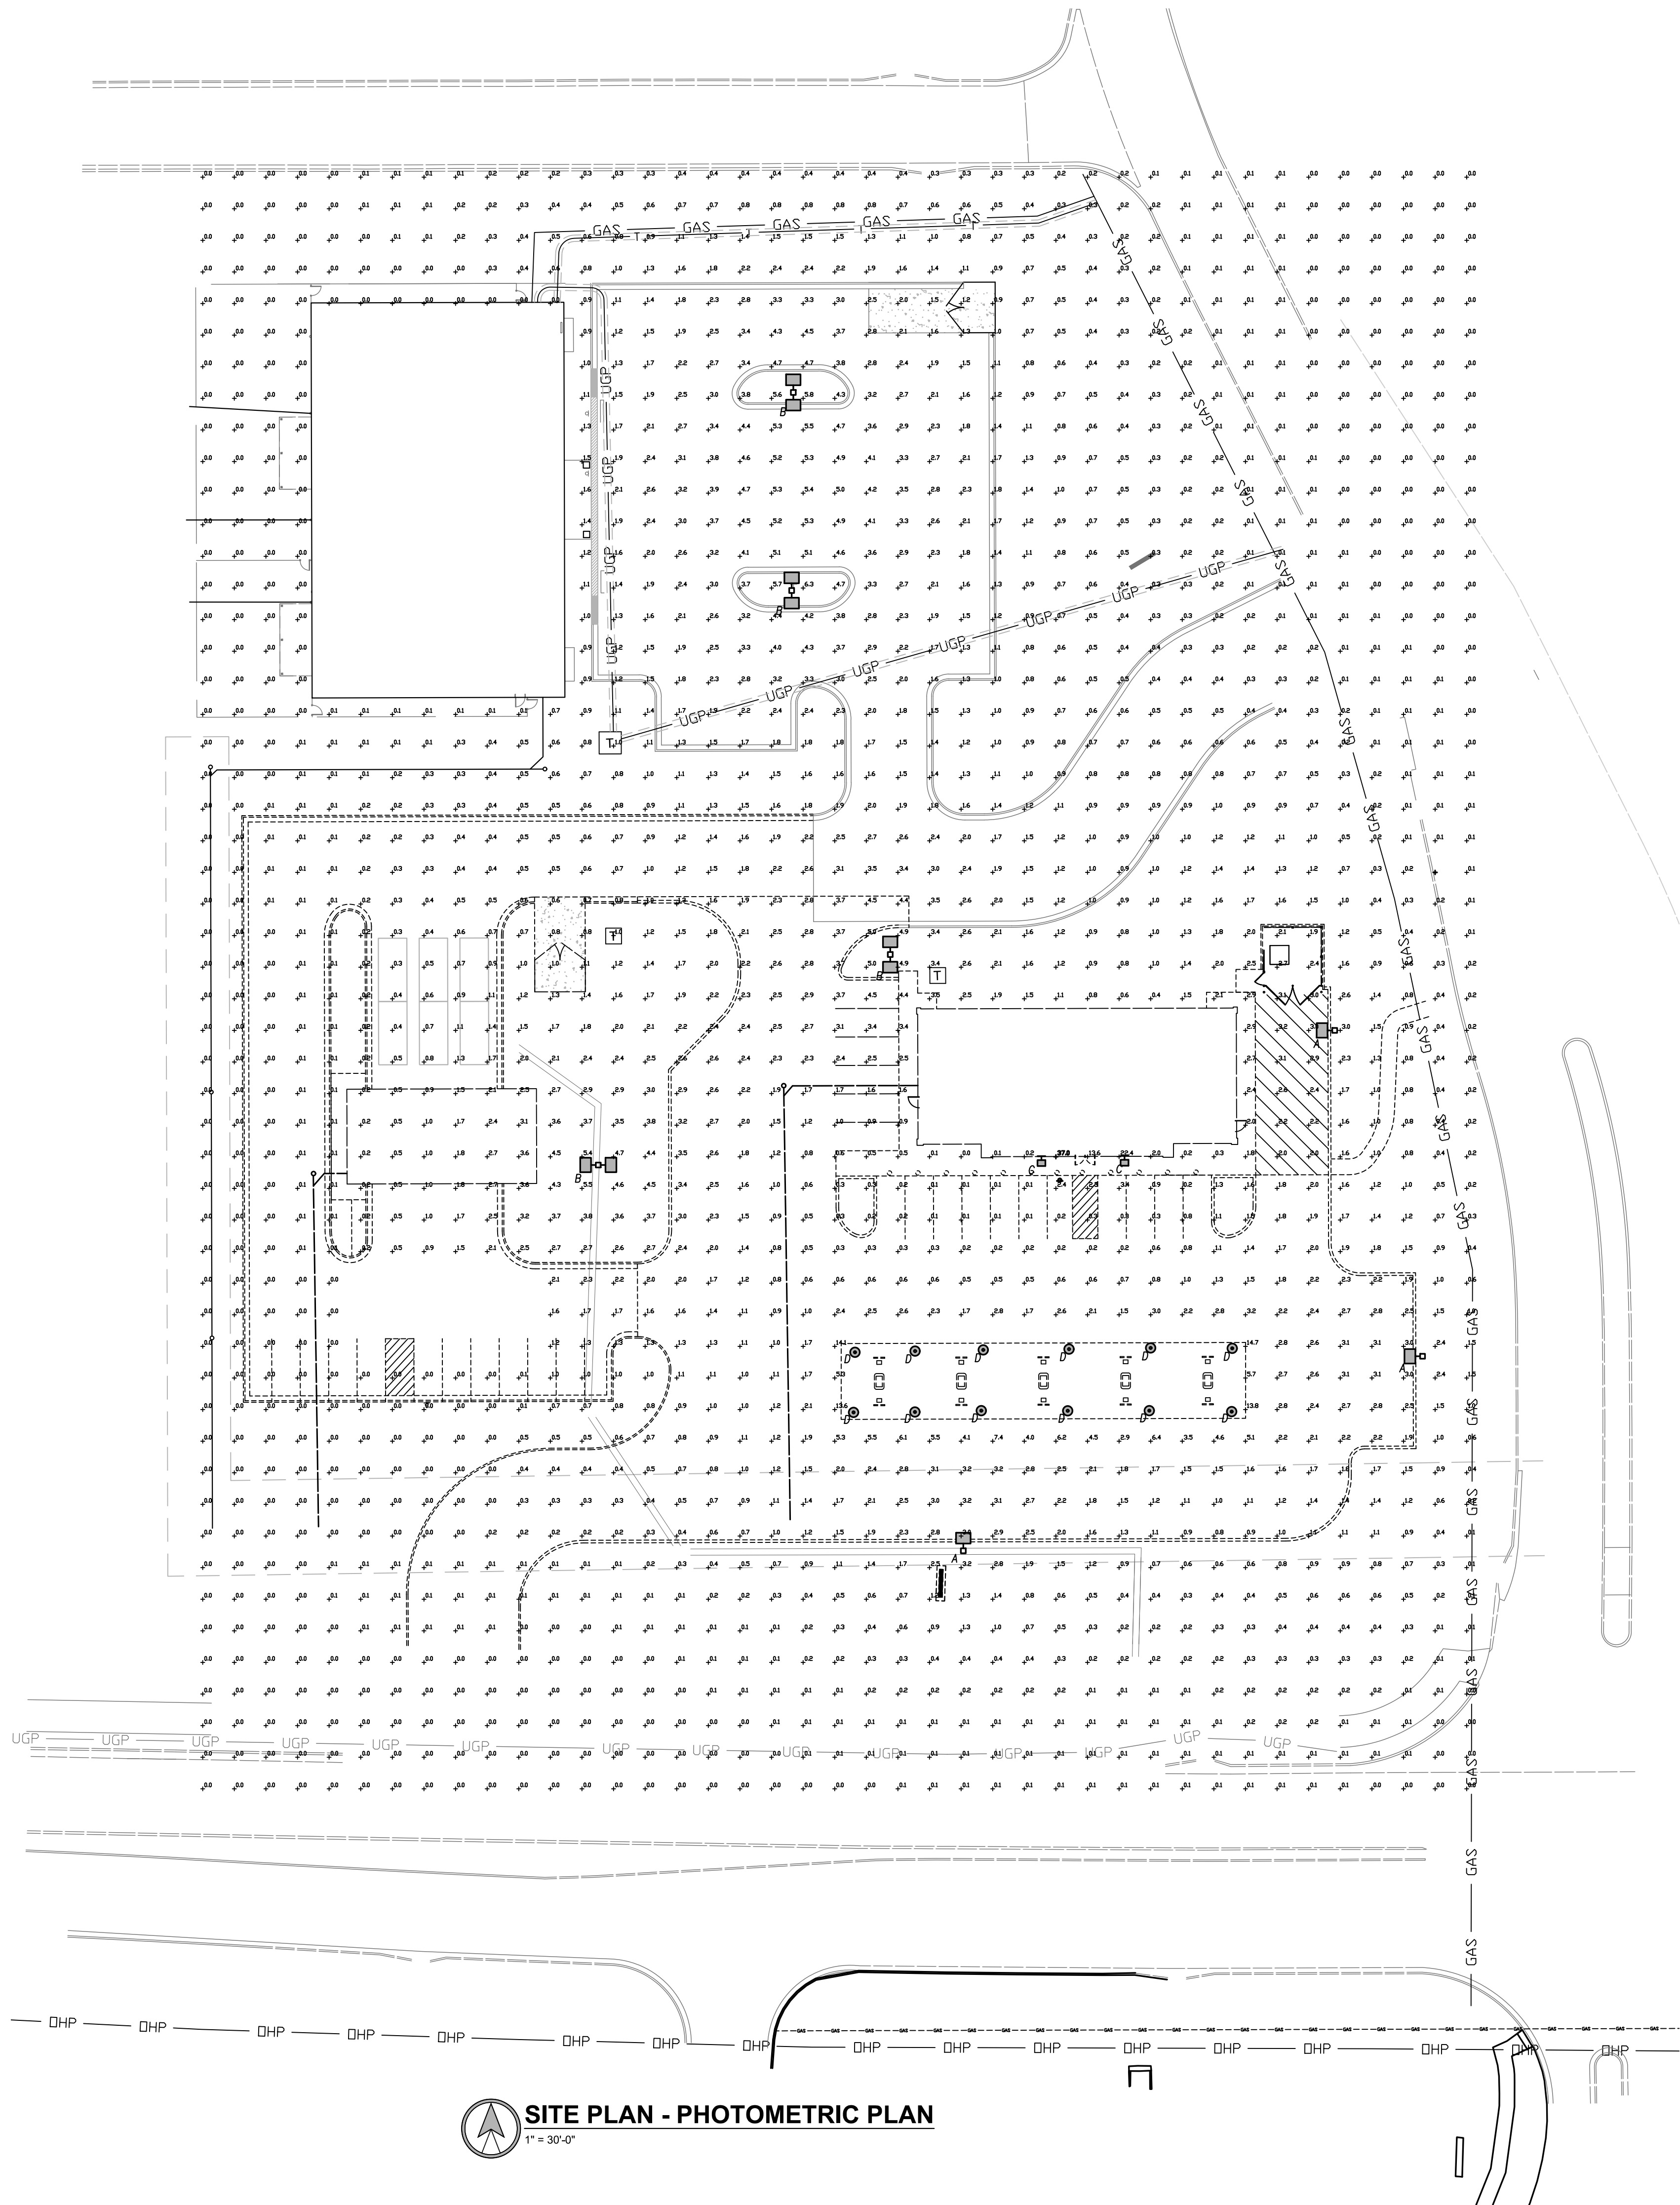

LIGHT FIXTURE SCHEDULE							
PLAN MARK	MANUFACTURER	MODEL NUMBER	MOUNTING	FINISH	LAMP CODE	LAMP QUANTITY	NOTES
A	LITHONIA	DSX1 LED P7 40K 80CRI T3M MVOLT SPA	27" POLE	BRONZE	188W LED	1	1,2,3
B	LITHONIA	DSX1 LED P7 40K 80CRI T3M MVOLT SPA	27" POLE	BRONZE	188W LED--PER HEAD	2	1,2,3
C	EATON-LUMARK	XTOR-4B	WALL MOUNT	BRONZE	250W/PMH	1	4
D	LITHONIA	CNY LED P1 40K MVOLT	CANOPY	BRONZE	58W LED	1	4

NOTES LEGEND
1 - PROVIDE WET LOCATION RATED FIXTURE
2 - PROVIDE COLD LOCATION RATED BALLAST
3 - PROVIDE SQUARE STRAIGHT STEEL POLE RATED FOR 100 MPH WIND GUSTS, PRIMED AND PAINTED TO MATCH FIXTURE
4 - REFER TO TENANT PLANS FOR FINAL FIXTURE SELECTION.



PEARSON KENT MCKINLEY RAAF ENGINEERS LLC
2933 SW WOODSIDE DR., SUITE C TOPEKA, KS 66614
785.273.2447 WWW.PKMRENG.COM
MO State Certificate of Authority #E-2002020886

ARBORWALK WEST

LEE'S SUMMIT MO

ISSUED FOR:	
DESCRIPTION	DATE
1	
2	
3	
4	
5	
6	
7	
8	
© PEARSON KENT MCKINLEY RAAF ENGINEERS, LLC	
DRAWN BY:	DMS
CHECKED BY:	BSL
SHEET TITLE:	
PHOTOMETRIC PLAN	
DATE:	PKMR PROJECT:
8/28/23	23.056
SHEET NUMBER:	
E0.1	