

TM FIELDHOUSE

1600 SE HAMBLÉN ROAD
LEE'S SUMMIT, MISSOURI 64081

PERMIT SET

2 MAY 2023

COLLINS WEBB #: 22103

06/21/2023

P302	PLUMBING RISERS
PLUMBING RISERS	
PLUMBING WATER AND GAS PLAN	
PLUMBING WASTE AND VENT PLAN	

SHEET INDEX		
SHEET NUMBER	SHEET NAME	REV
GENERAL INFORMATION		
CS	COVER SHEET	
G001	GENERAL INFORMATION	06/21/2023
G002	ACCESSIBILITY GUIDELINES	
G003	LIFE SAFETY PLANS AND PROJECT INFO.	06/21/2023
G141	UL LISTINGS	06/21/2023
G500	GENERAL PROJECT SPECIFICATIONS	
G501	GENERAL PROJECT SPECIFICATIONS	06/21/2023
G502	GENERAL PROJECT SPECIFICATIONS	
STRUCTURAL		
S001	STRUCTURAL GENERAL NOTES	
S030	TYPICAL DETAILS - CONCRETE	
S031	TYPICAL DETAILS - CONCRETE	
S040	TYPICAL DETAILS - MASONRY	
S054	TYPICAL DETAILS - CFS & STEEL	
S100	FOUNDATION PLAN	06/21/2023
S101	MEZZANINE PLAN	
ARCHITECTURAL		
A101	1ST FLOOR & MEZZ. PLAN	06/21/2023
A102	ENLARGED PLANS AND DETAILS	06/21/2023
A104	ROOF PLAN	06/21/2023
A201	EXTERIOR ELEVATIONS	06/21/2023
A325	WALL SECTIONS	06/21/2023
A501	DOOR SCHEDULE AND DETAILS	06/21/2023
A606	RCP - 1ST FLOOR	06/21/2023
A901	FINISH FLOOR PLANS	06/21/2023

SHEET INDEX		
SHEET NUMBER	SHEET NAME	REV
MEP		
E101	ELECTRICAL NOTES, SYMBOLS & ABBREVIATIONS	
E102	ELECTRICAL DETAILS	
E103	ELECTRICAL SITE PLAN	
E201	PARTIAL POWER PLAN	
E202	PARTIAL POWER PLAN	
E203	ENLARGED POWER PLANS	06/21/2023
E301	PARTIAL LIGHTING PLAN	
E302	PARTIAL LIGHTING PLAN	
E303	ENLARGED LIGHTING PLANS	06/21/2023
E401	ELECTRICAL ONE-LINE DIAGRAM & SCHEDULES	06/21/2023
E402	ELECTRICAL SCHEDULES	06/21/2023
E403	ELECTRICAL LIGHTING SCHEDULES	
E501	ELECTRICAL SPECIFICATIONS	
E502	ELECTRICAL SPECIFICATIONS	
M101	MECHANICAL NOTES, SYMBOLS & ABBREVIATIONS	
M201	PARTIAL MECHANICAL PLAN	06/21/2023
M202	PARTIAL MECHANICAL PLAN	06/21/2023
M203	ENLARGED MECHANICAL PLANS	06/21/2023
M301	MECHANICAL SCHEDULES AND DETAILS	06/21/2023
M401	MECHANICAL SPECIFICATIONS	
M501	HOOD AND FAN DRAWINGS	06/21/2023
P101	PLUMBING NOTES, SYMBOLS AND ABBREVIATIONS	
P102	PLUMBING DETAILS AND SCHEDULES	
P201	PLUMBING OVERALL PLAN	
P301		



OWNER

TAILOR MADE EXTERIORS
1610 SE HAMBLÉN ROAD
LEE'S SUMMIT, MO 64081
P: 816.347.8328
www.TailorMadeExteriors.com

ARCHITECT

COLLINS | WEBB ARCHITECTURE
307B SW MARKET STREET
LEE'S SUMMIT, MISSOURI 64063
P: 816.249.2270
www.collinsandwebb.com

CIVIL ENGINEER








ENGINEERING SOLUTIONS
50 SE 30TH STREET
LEE'S SUMMIT, MO 64082
P: 816.623.9888
www.es-kc.com


STRUCTURAL ENGINEER

STAND STRUCTURAL ENGINEERING INC.
8234 ROBINSON ST.
OVERLAND PARK, KS 66204
P: 913.214.2169
www.stand-sei.com

MEP ENGINEER

ENGINEERED BUILDING SOLUTIONS
P.O. BOX #11101
OVERLAND PARK, KS 66207
P: 913.735.5654
www.EBSolutionsKC.com

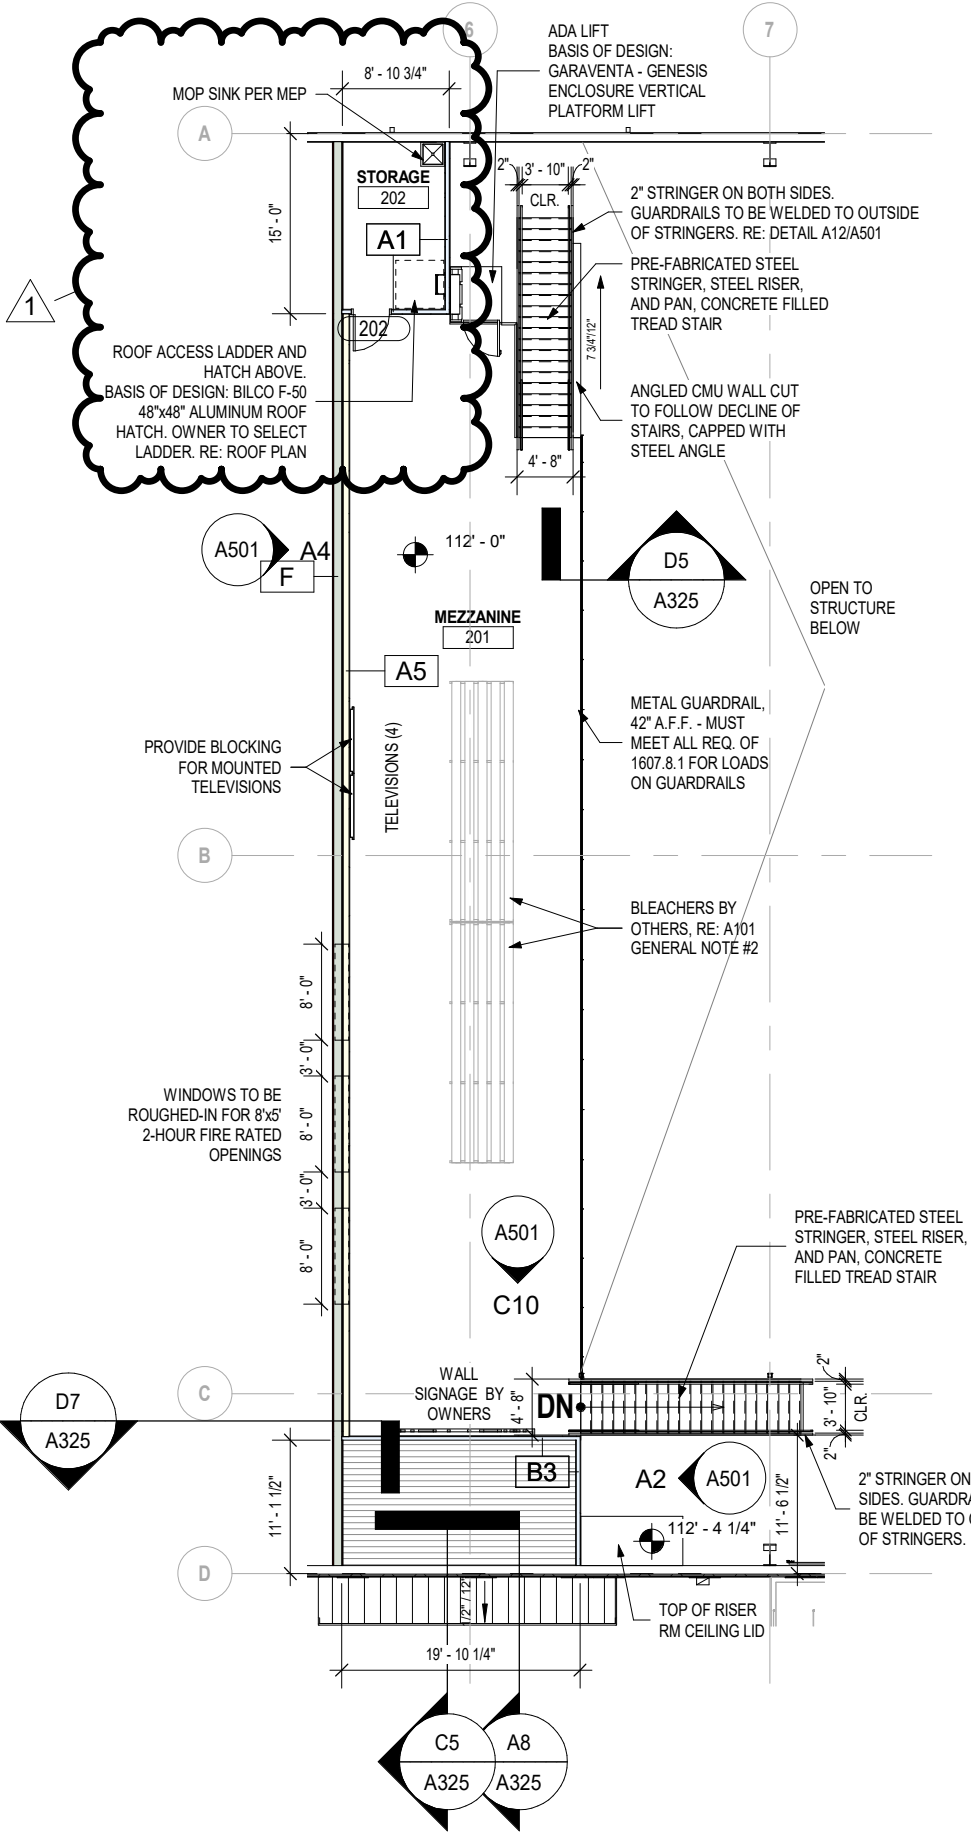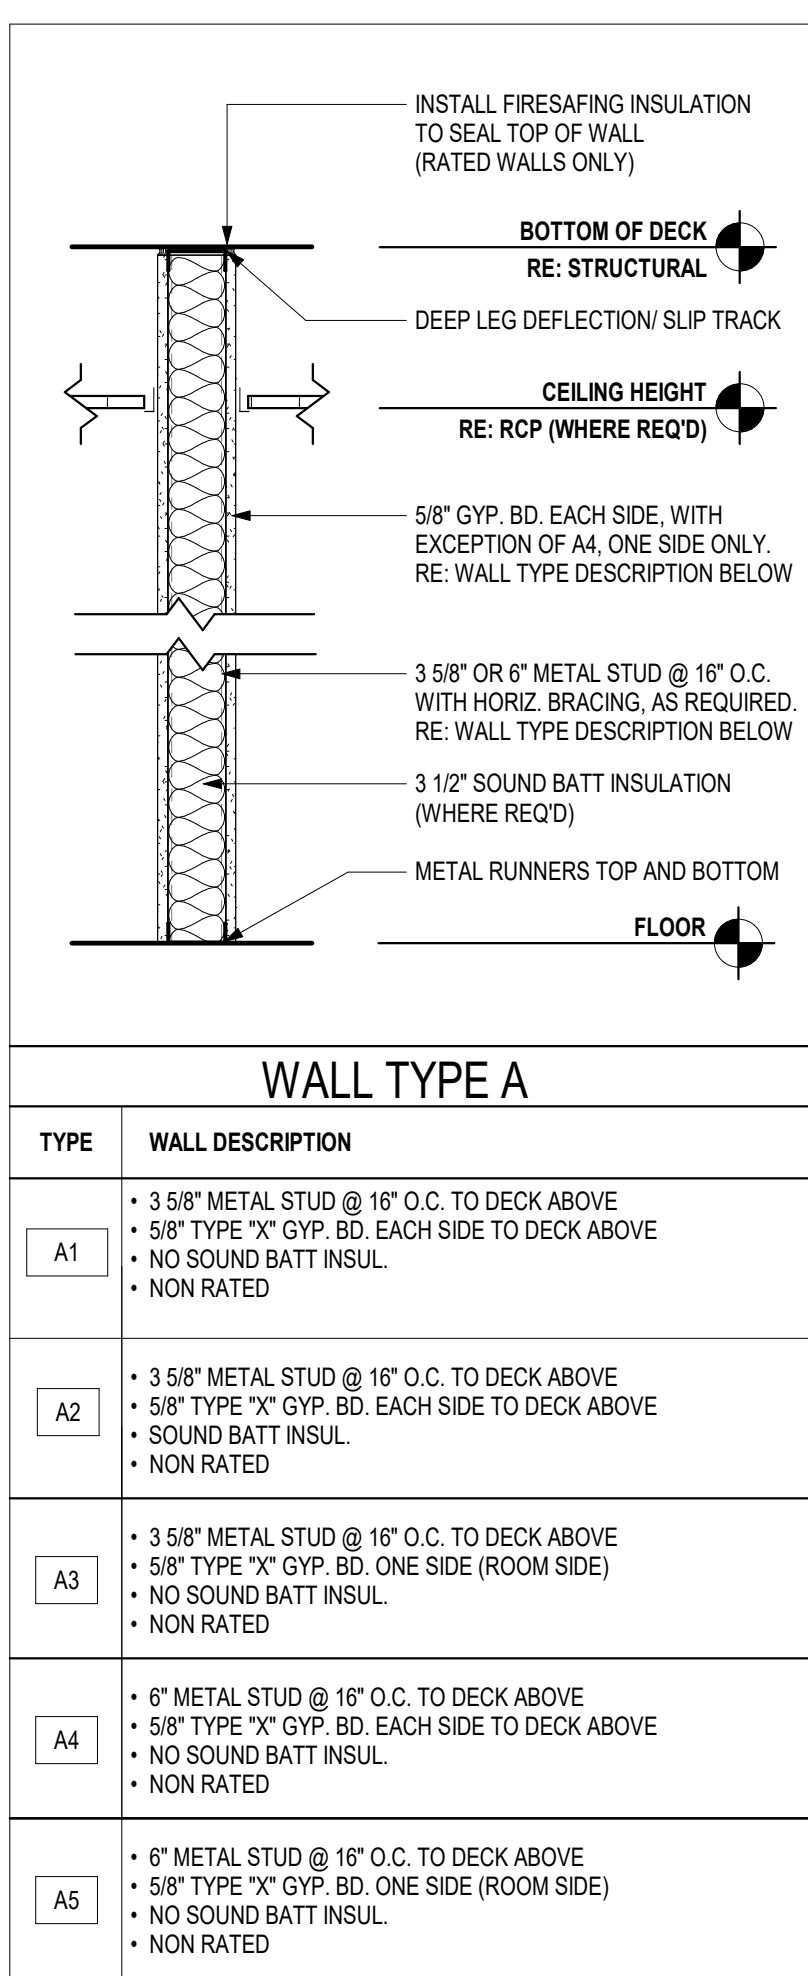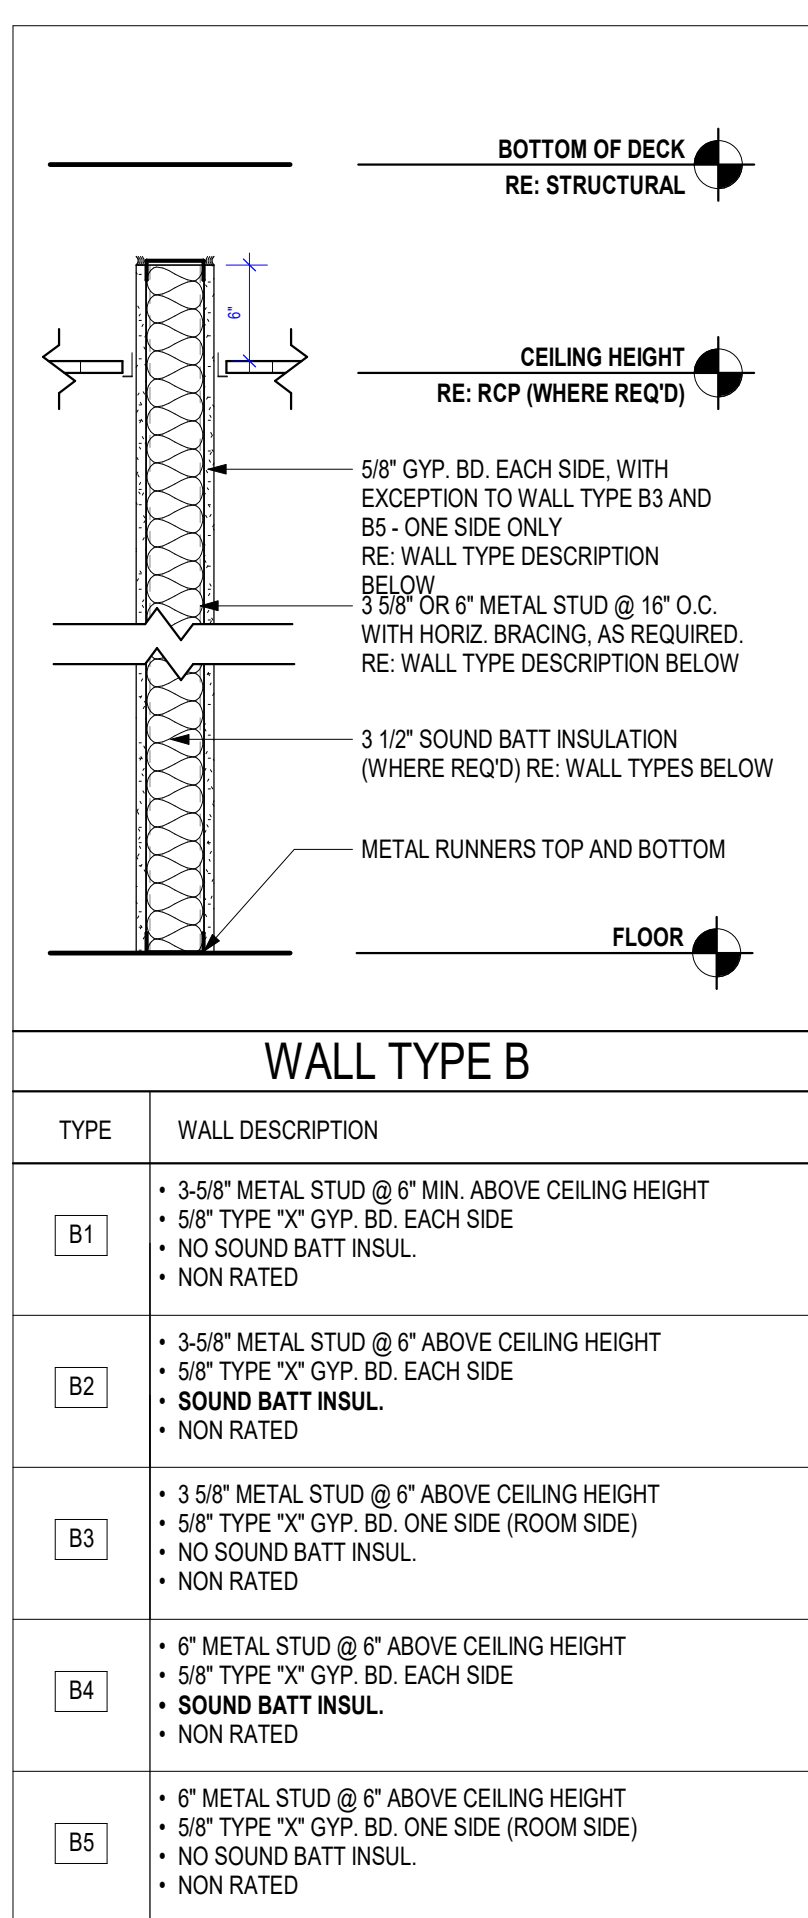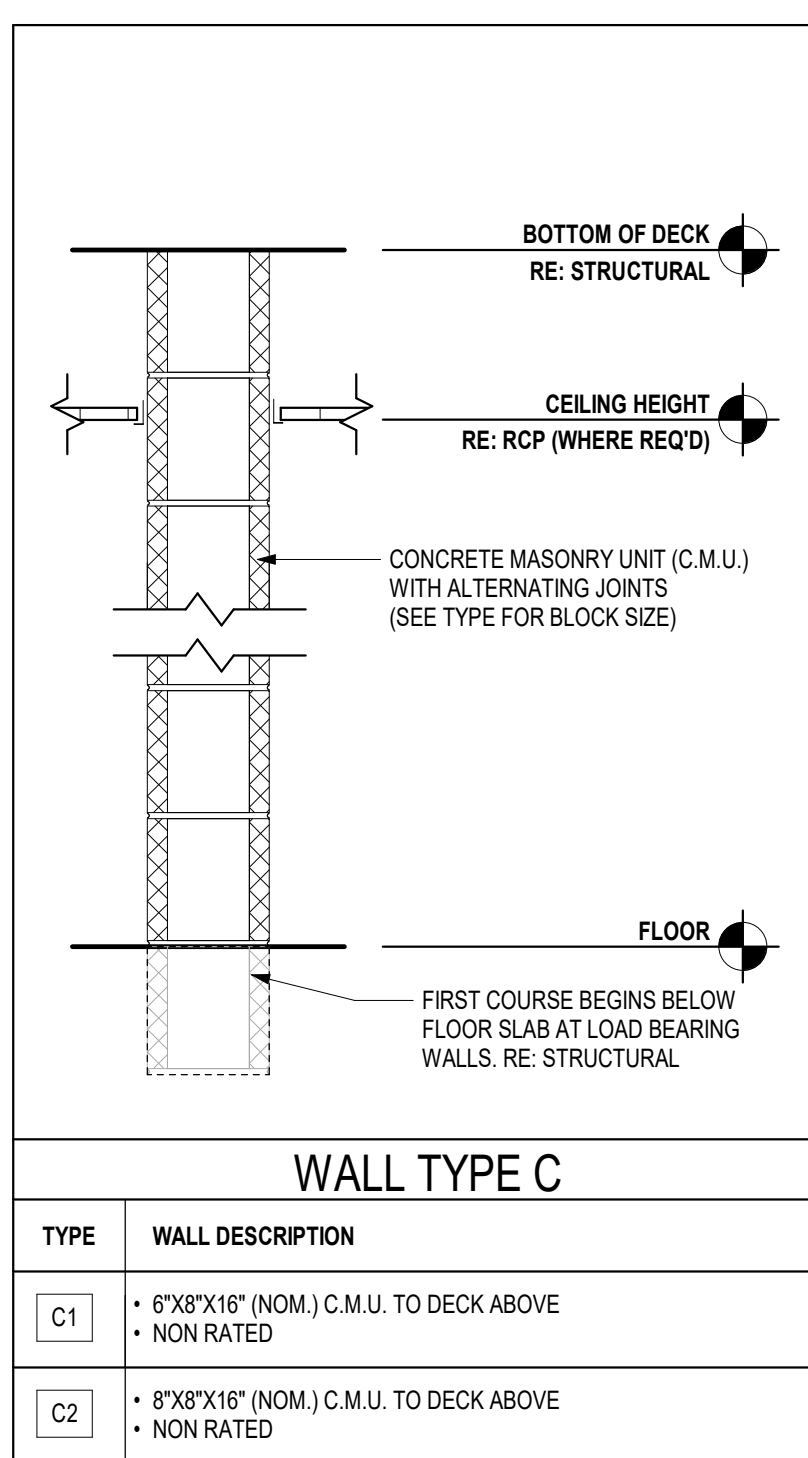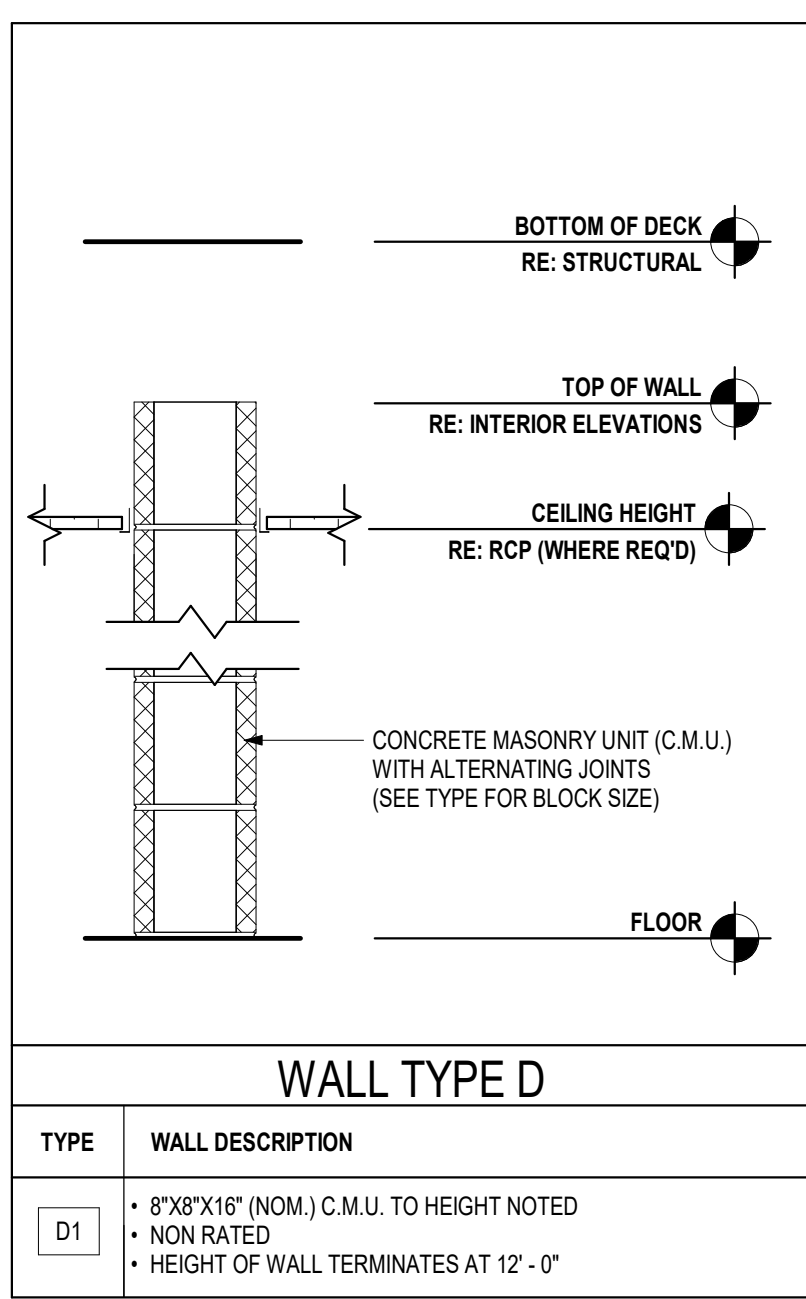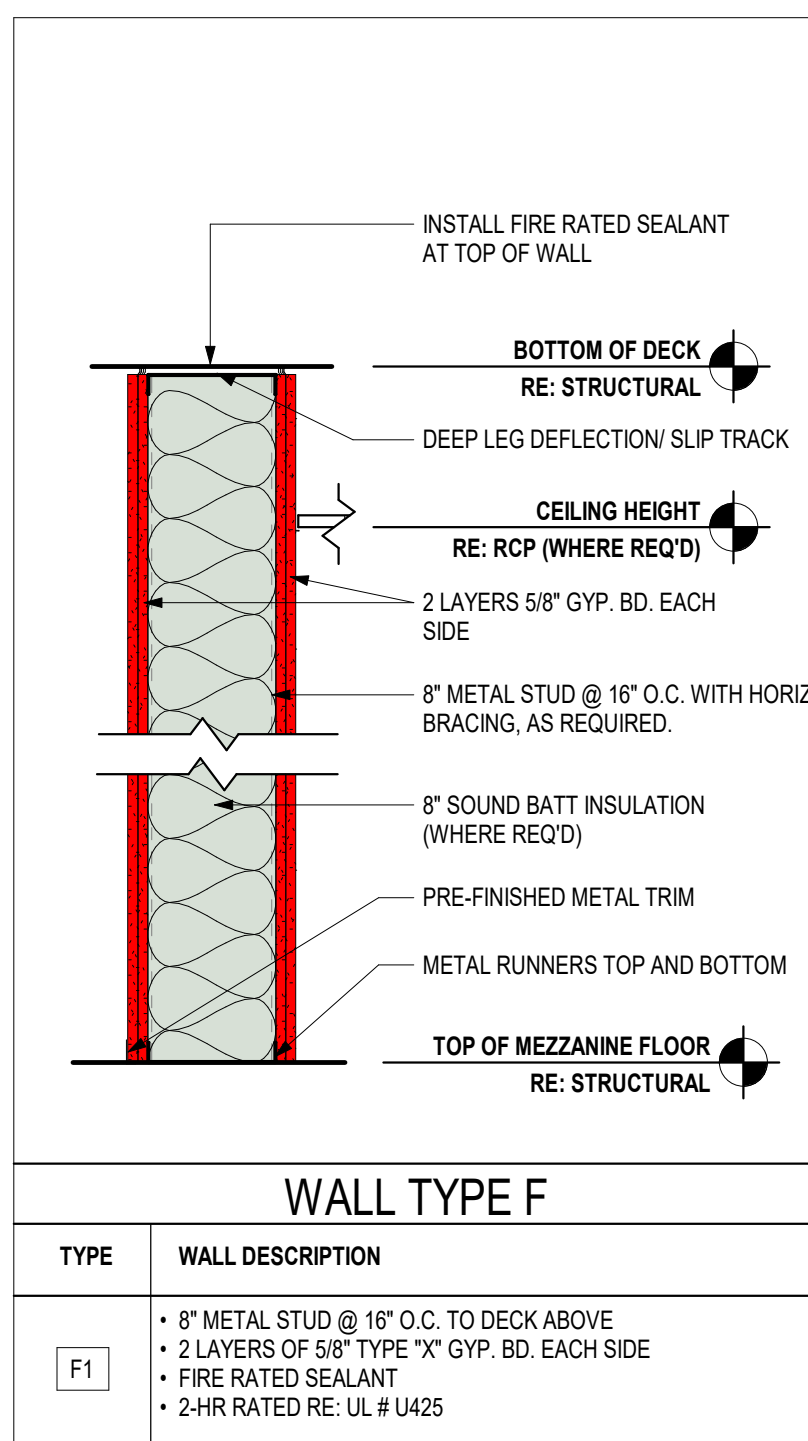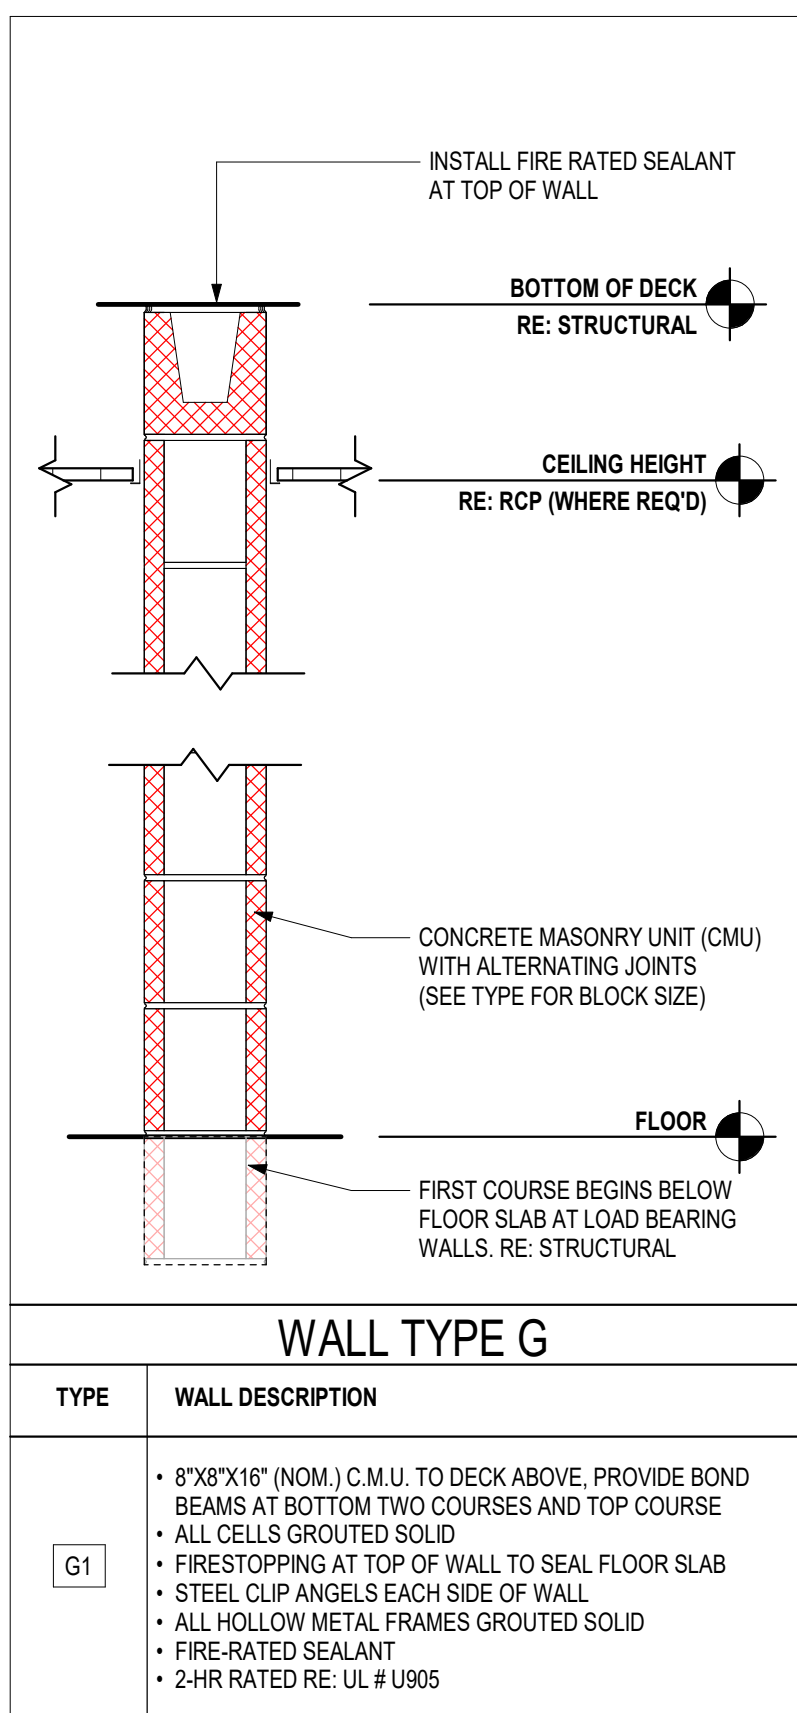

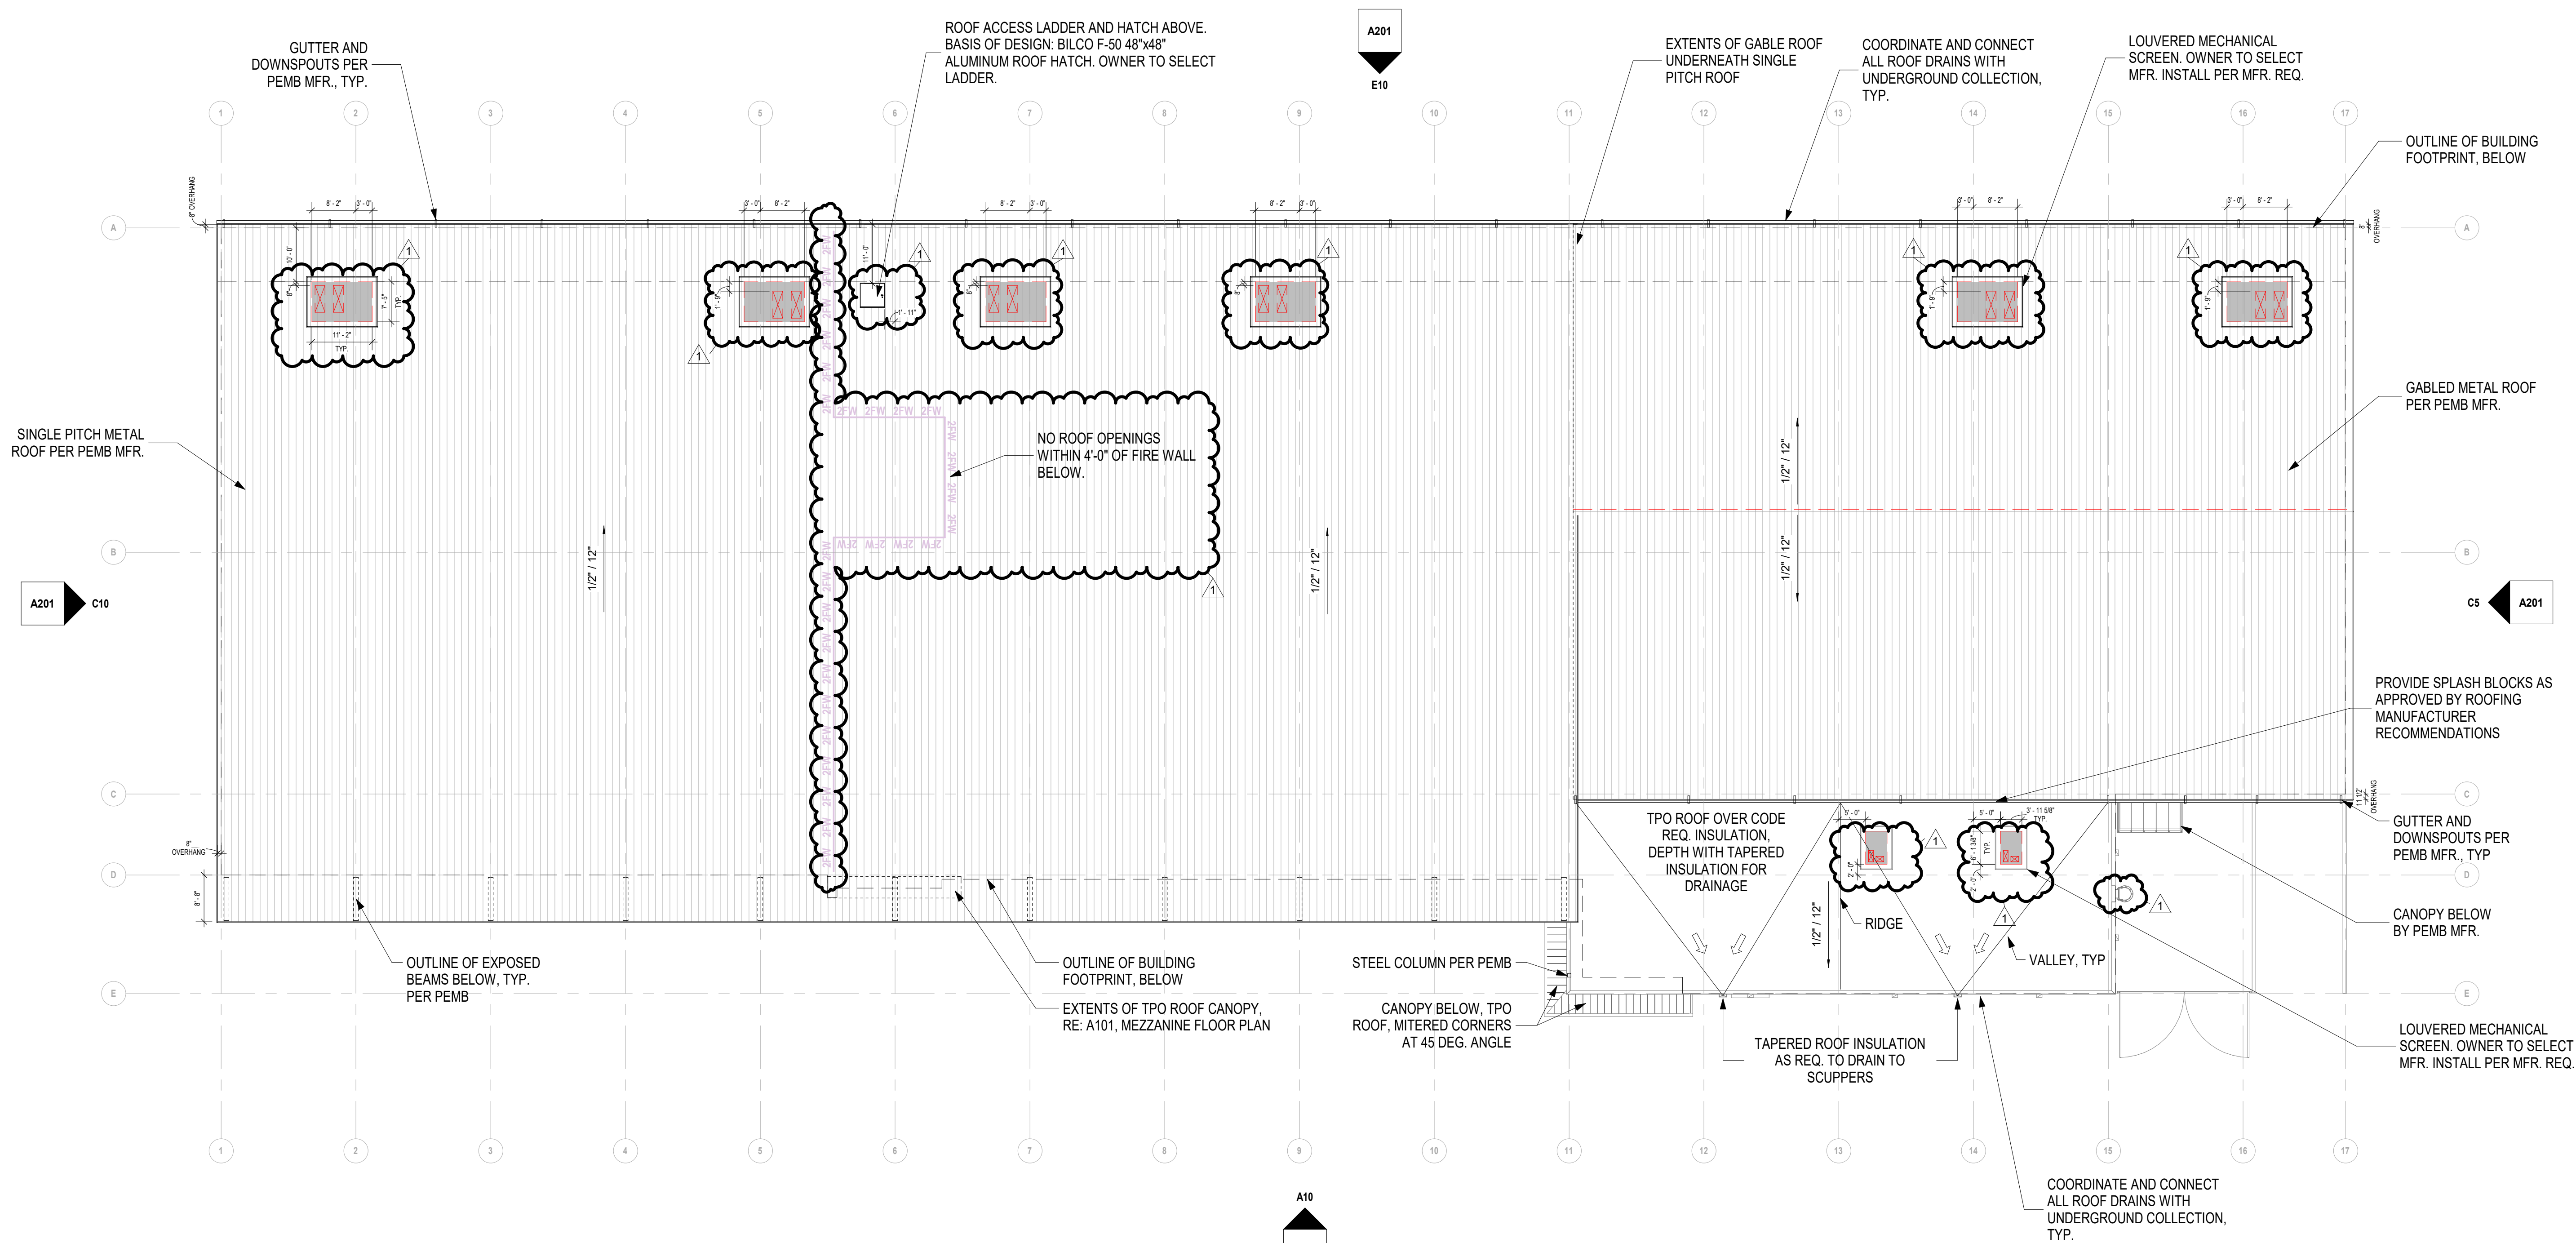

A10 ROOF PLAN
1/16" = 1'-0"

GENERAL NOTES:
ROOF PLANS

1. RE: SHEET G001 FOR ADDITIONAL GENERAL NOTES THAT ARE APPLICABLE.
2. DIMENSIONS SHOWN ON THE ROOF PLAN ARE TO THE FACE OF EXTERIOR WALL, FACE OF MASONRY (FOM), FACE OF CONCRETE WALLS (FCW), AND COLUMN GRID LINES, UNLESS NOTED OR SHOWN OTHERWISE.
3. PROVIDE 1/2" FT. TAPERED INSULATION AT ALL ROOF CURBS AND AT EQUIPMENT WHICH EXCEEDS 18 INCHES IN WIDTH.

ROOF PLAN LEGEND

- SLOPE DIRECTION
- TAPERED INSULATION CRICKET OVERBUILD
- ROOF WALKING PAD
- ROOF DRAIN

TM FIELDHOUSE

1600 SE HAMBLEN ROAD
LEE'S SUMMIT, MISSOURI 64081

COPYRIGHT © BY
COLLINS WEBB
ARCHITECTURE, LLC

REVISION DATES:
1 CITY COMMENTS 06/21/2023



PROFESSIONAL SEAL

A104

ISSUE DATE: 2 MAY 2023
COLLINS WEBB # 22103

ROOF PLAN



307B SW Market St., Lee's Summit, Missouri 64003 | 816.249.2270 | www.collinswebb.com

PERMIT SET

