

2751 NORTHEAST DOUGLAS STREET  
LEE'S SUMMIT, MISSOURI 64064

SANITARY SEWER  
CONSTRUCTION PLANS  
FOR  
LEE'S SUMMIT  
MUNICIPAL AIRPORT

CITY PROJECT NO. 47732472

LXT EASTSIDE DEVELOPMENT

ISSUED-FOR-BID PLAN SET

JANUARY 04, 2024

CALL MISSOURI ONE-CALL SYSTEMS  
BEFORE EXCAVATING  
1-800-DIG-RITE

DESIGN AIRCRAFT - GEOMETRY  
CANADAIR CL-600  
AIRCRAFT APPROACH CATEGORY C  
AIRPLANE DESIGN GROUP II  
DESIGN AIRCRAFT - STRUCTURE  
GRUMMAN GULFSTREAM IV  
GROSS WEIGHT - 71,800 LBS  
EQUIVALENT ANNUAL DEPARTURES - 651

MAXIMUM EQUIPMENT HEIGHT: 100'

UNICOM/CTAF FREQUENCY - 122.80


**CMT**

22001238


© Copyright CMT, Inc.  
PROFESSIONAL ENGINEERING - 000631  
CRAWFORD MURPHY & TILLY, INC.  
CONSULTING ENGINEERS

■ SPRINGFIELD, IL ■ AURORA, IL ■ ST. LOUIS, MO  
■ EDWARDSVILLE, IL ■ CHICAGO, IL ■ PEORIA, IL ■ ROCKFORD, IL  
■ INDIANAPOLIS, IN ■ COLUMBUS, OH ■ SPRINGFIELD, MO  
■ KANSAS CITY, MO ■ LA BELLE, FL ■ MOLINE, IA  
SUBMITTED BY TYLER HORN, PE

DATE JANUARY 04, 2024

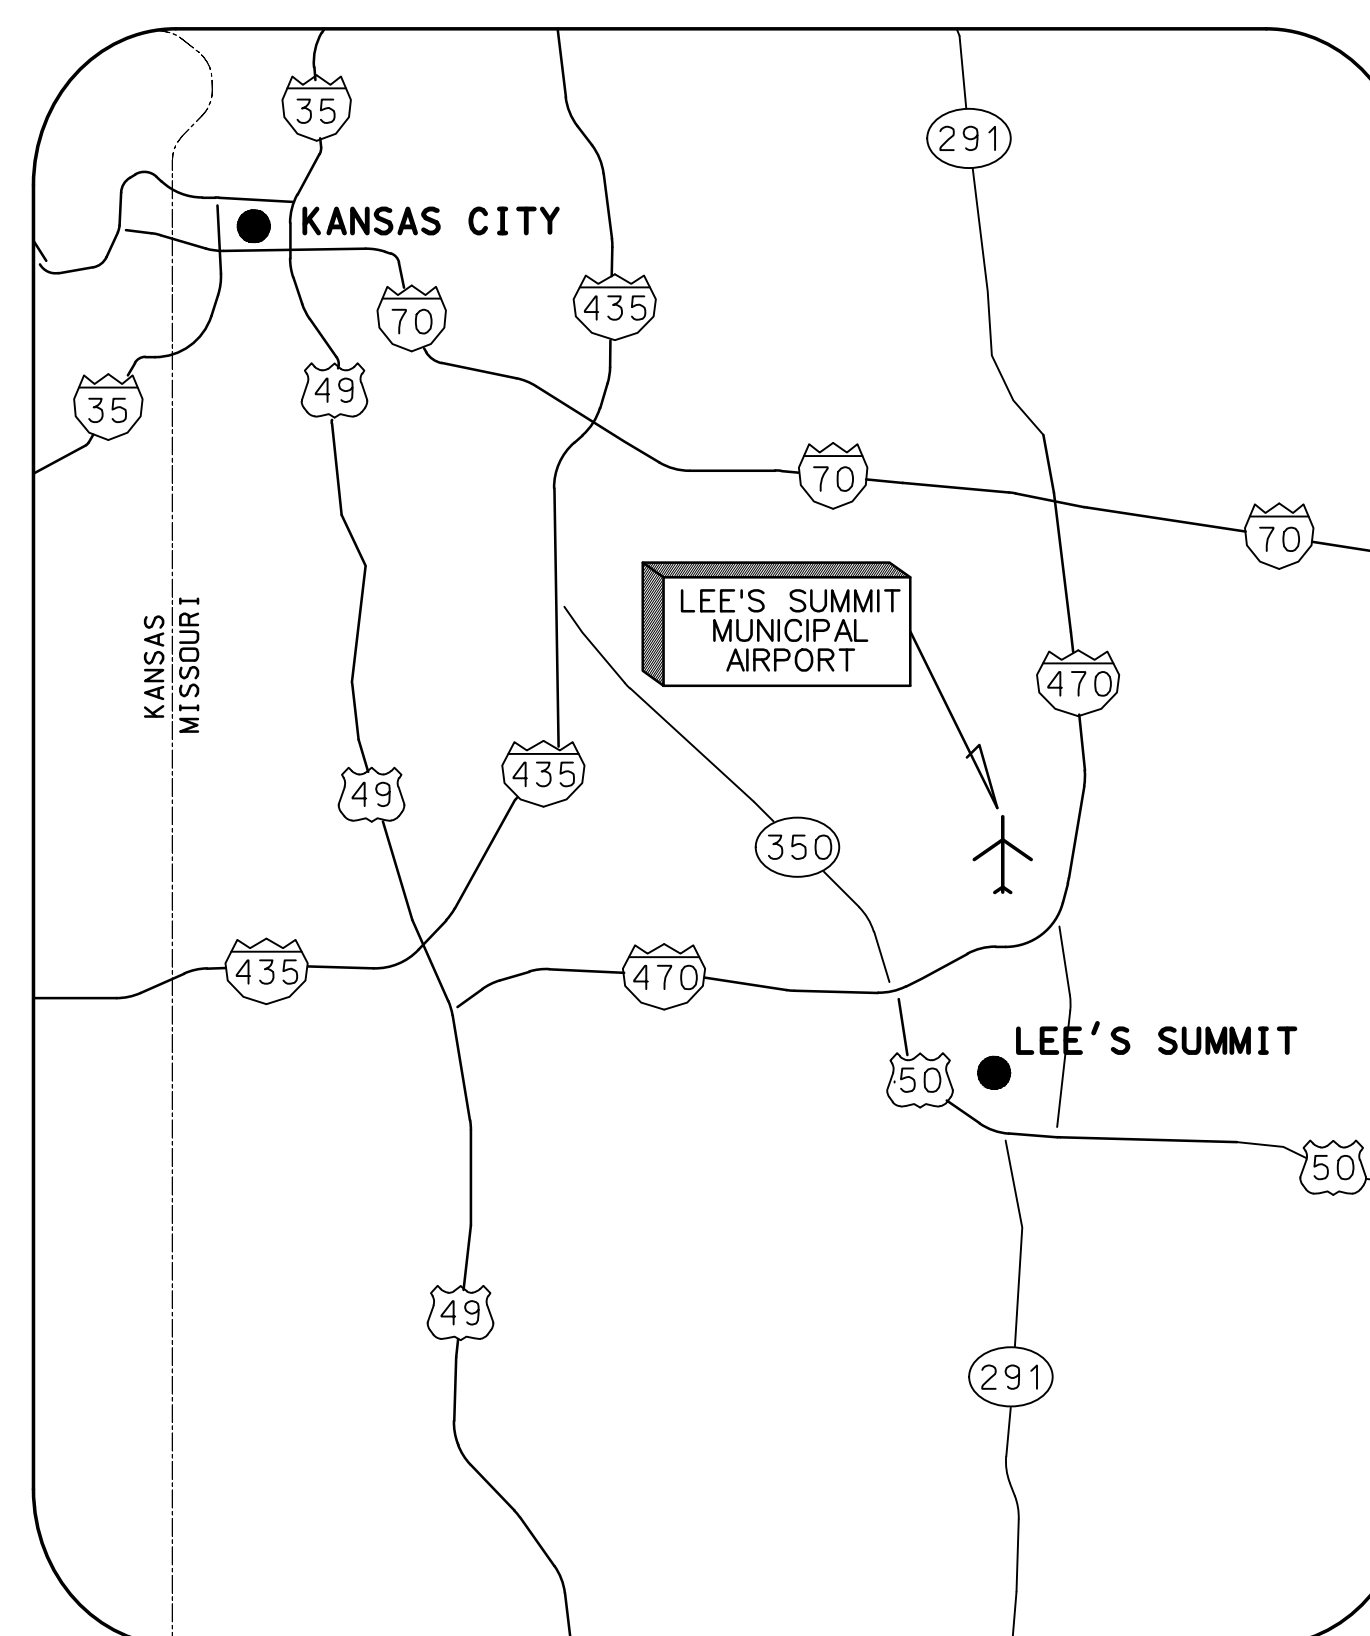

LOCATION MAP

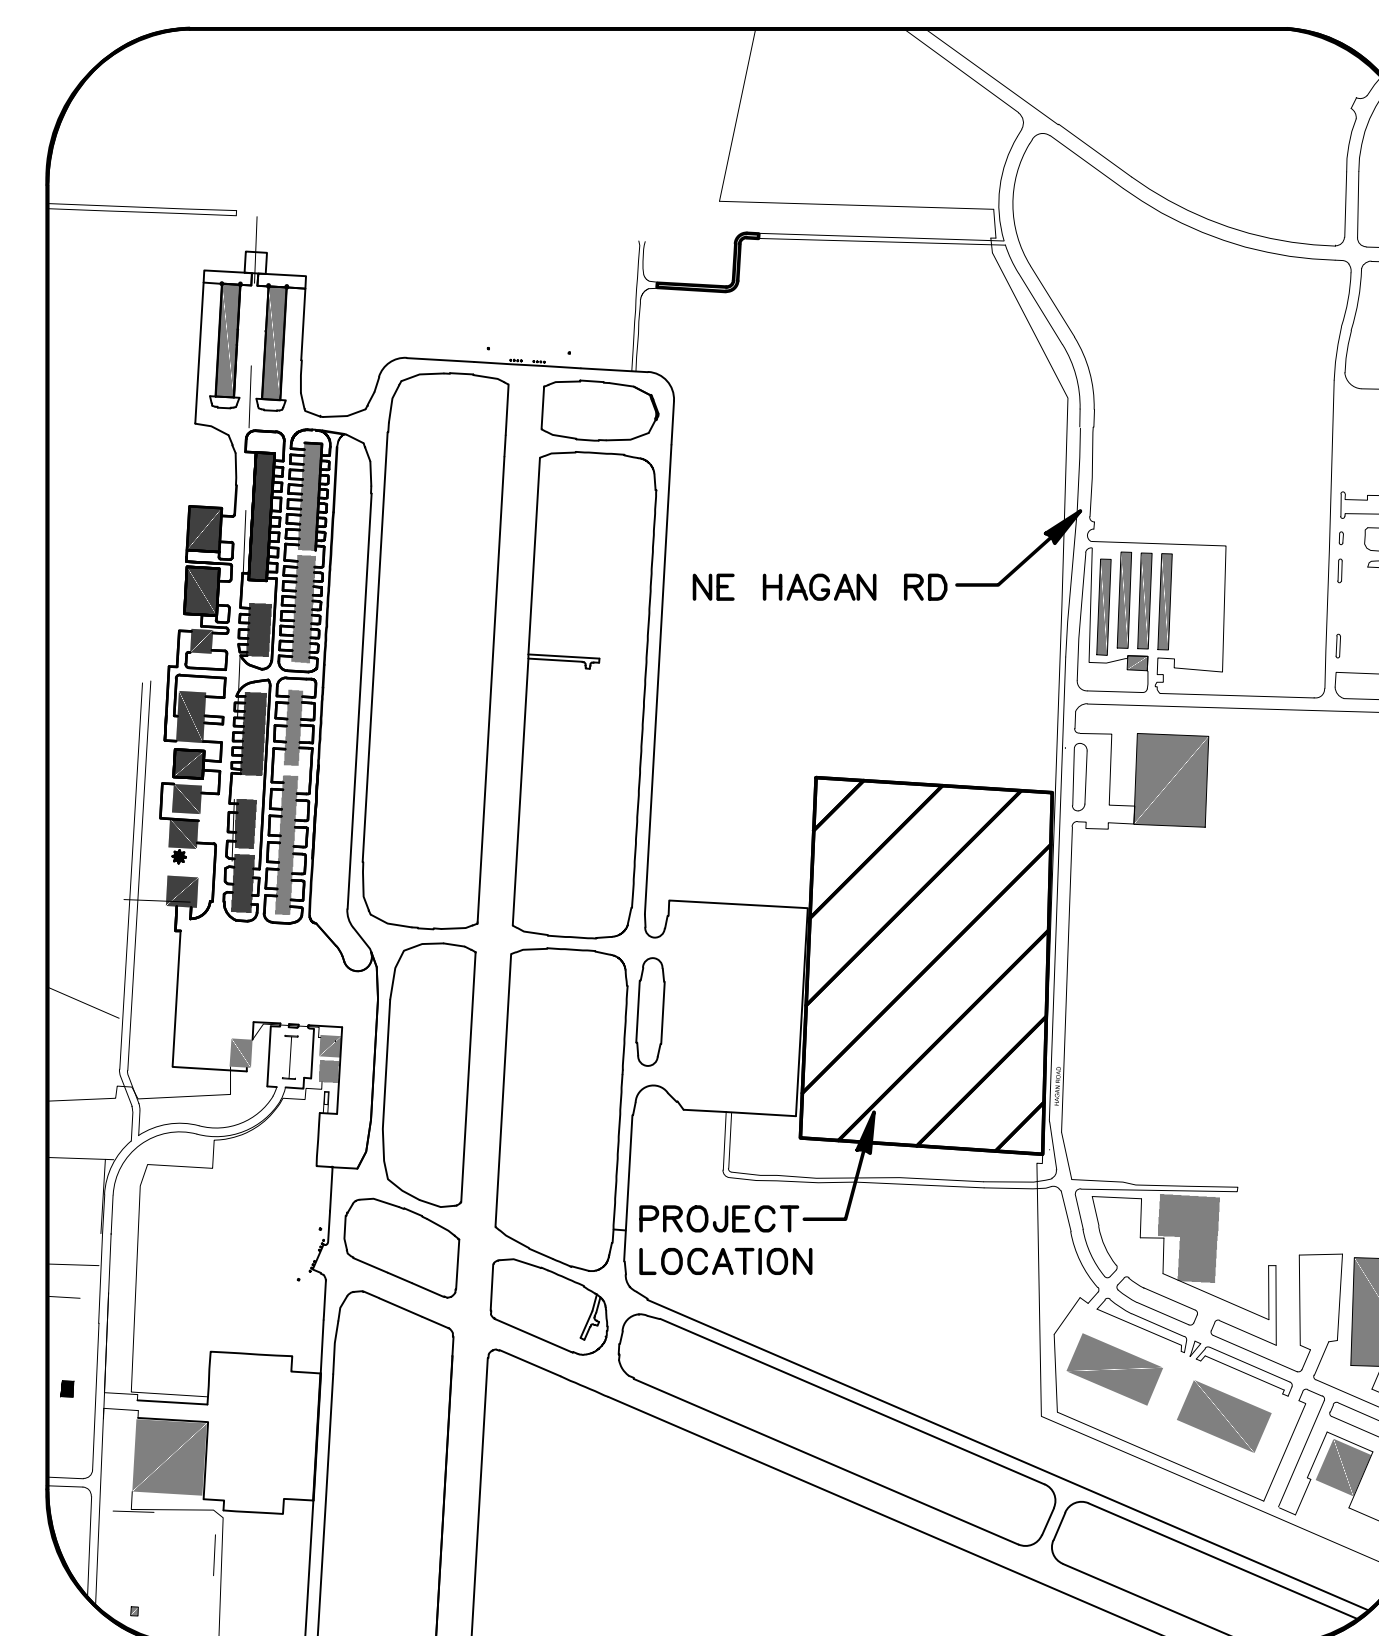

SITE PLAN









0 30 60 FEET

PLAN LEGEND

- - - - - EXISTING CONTOUR
- 1400 — PROPOSED CONTOUR
- - - - - PROPOSED SANITARY SEWER
- - - - - PROPOSED STORM SEWER
- PROPOSED STORM STRUCTURE

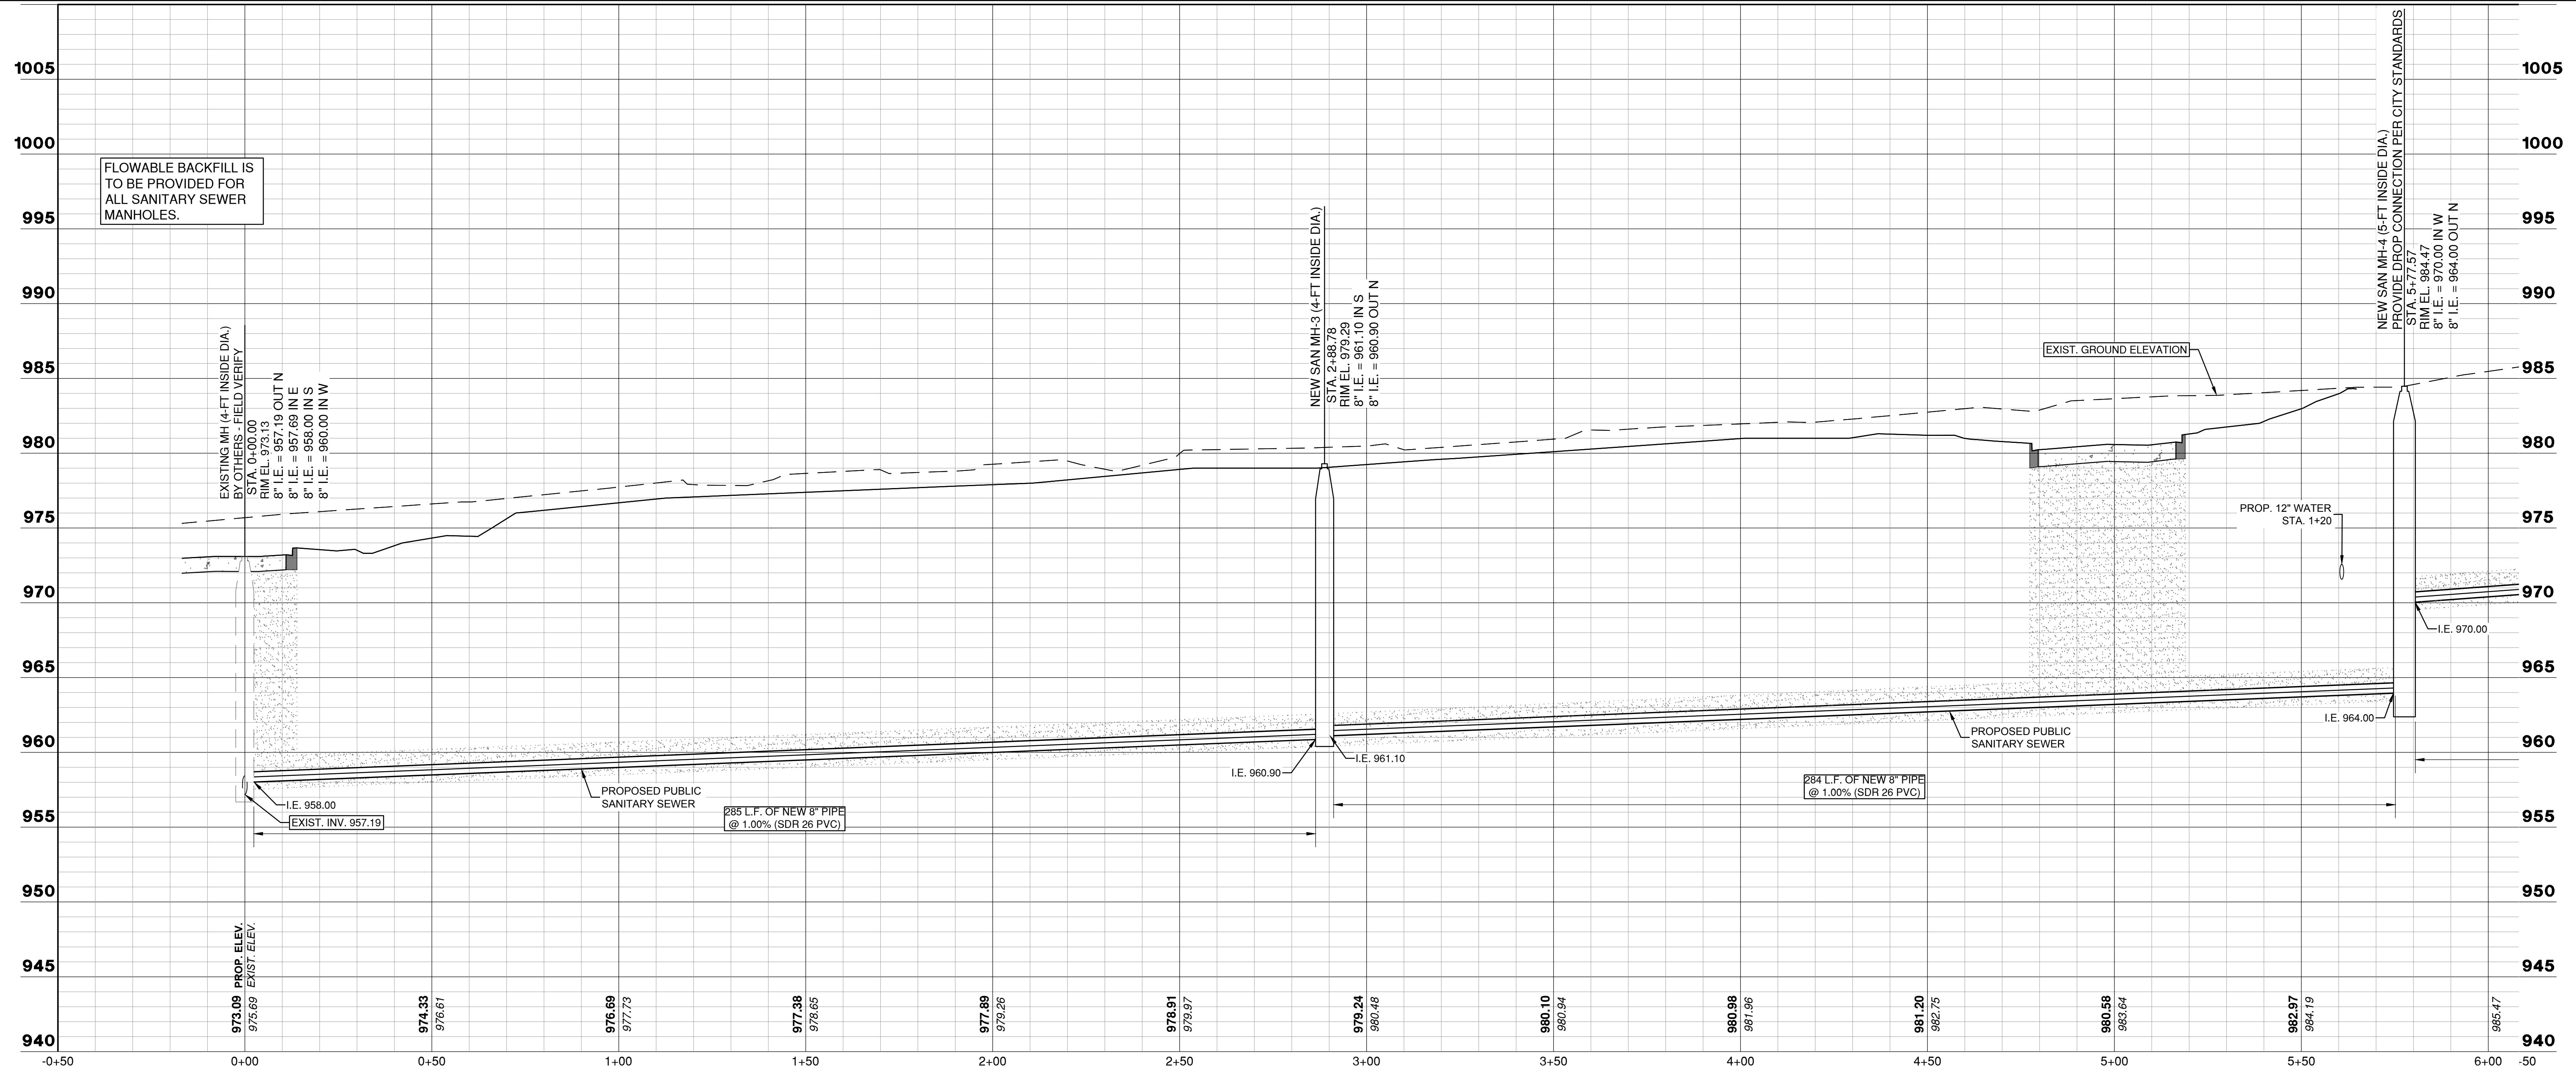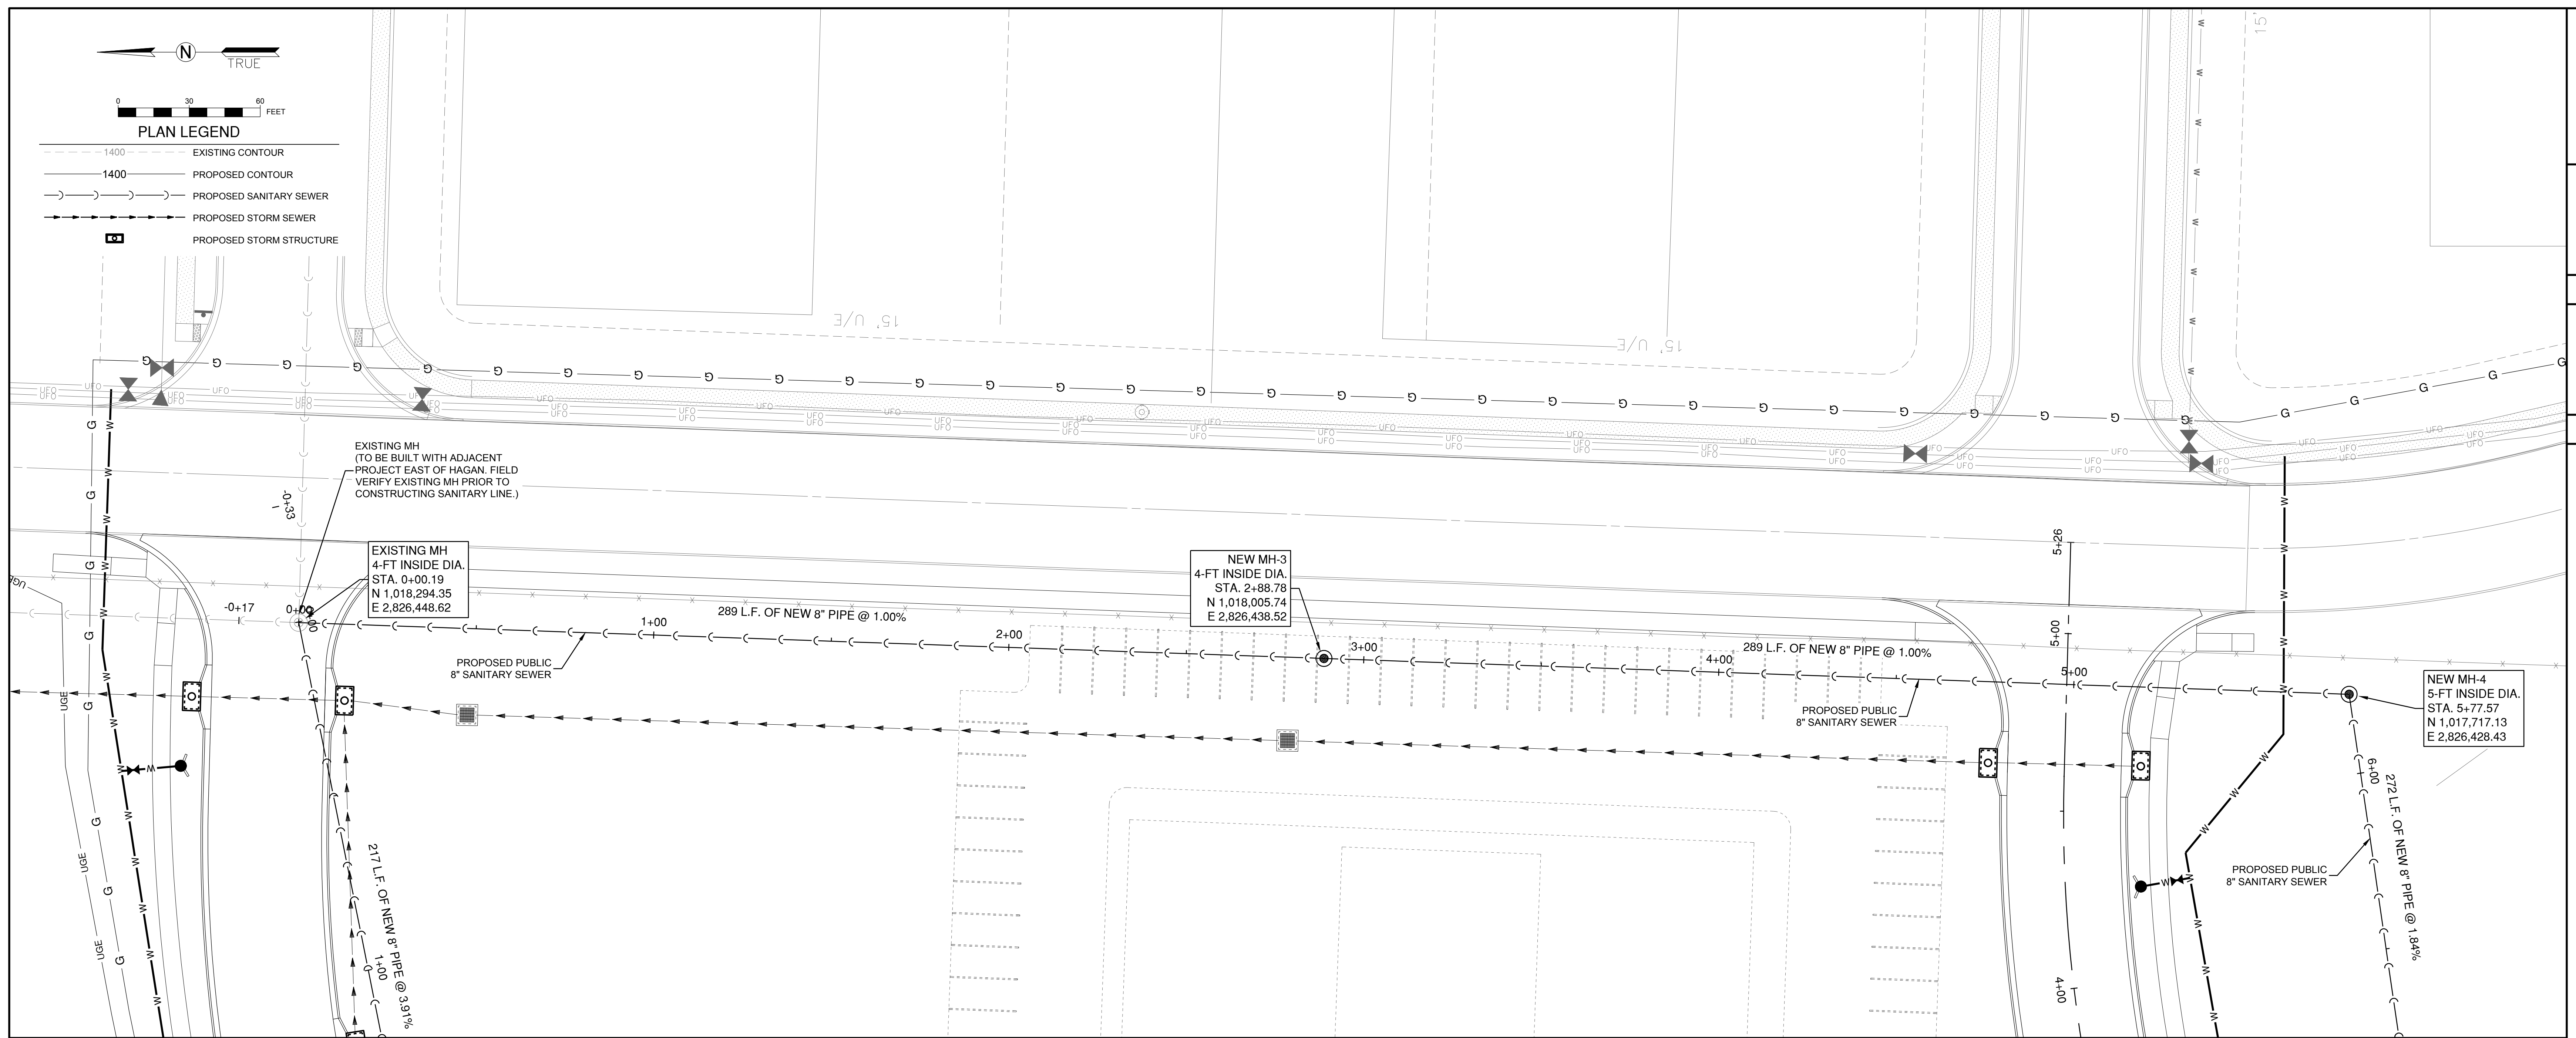

Path: K:\Users\SummitMO\2020\2386\00\Draw\Sheets\Sanitary Sewer\_Sst\Sanitary Plan & Profiles.dwg  
Date: Wednesday, January 3, 2024 10:28:12



1627 MAIN STREET, SUITE 600  
KANSAS CITY, MO 64108




1627 MAIN STREET, #100  
KANSAS CITY, MO 64108



1301 BURLINGTON STREET  
NORTH KANSAS CITY, MO 64116

LEE'S SUMMIT MUNICIPAL AIRPORT  
LEE'S SUMMIT, MISSOURI

EASTSIDE DEVELOPMENT  
CITY PROJECT NO. - 47732472

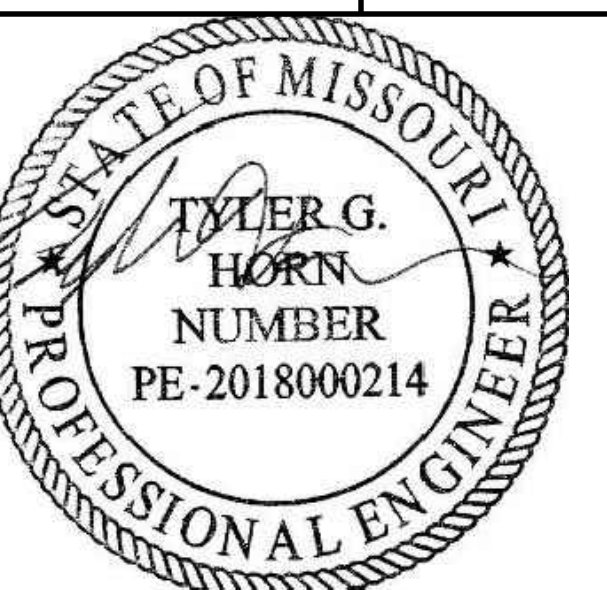

SEALED DIGITALLY  
JANUARY 4, 2024

LEE'S SUMMIT MUNICIPAL AIRPORT  
LEE'S SUMMIT, MO

MARK DATE DESCRIPTION



PROJECT NO: 47732472  
 CAD DWG FILE: SANITARY PLAN & PROFILES  
 DESIGNED BY: WLC  
 DRAWN BY: WLC  
 CHECKED BY: JRC  
 APPROVED BY: TGH  
 COPYRIGHT

SHEET TITLE

SANITARY PLAN &  
PROFILE - SHEET 2

C101

SHEET 2 OF 4

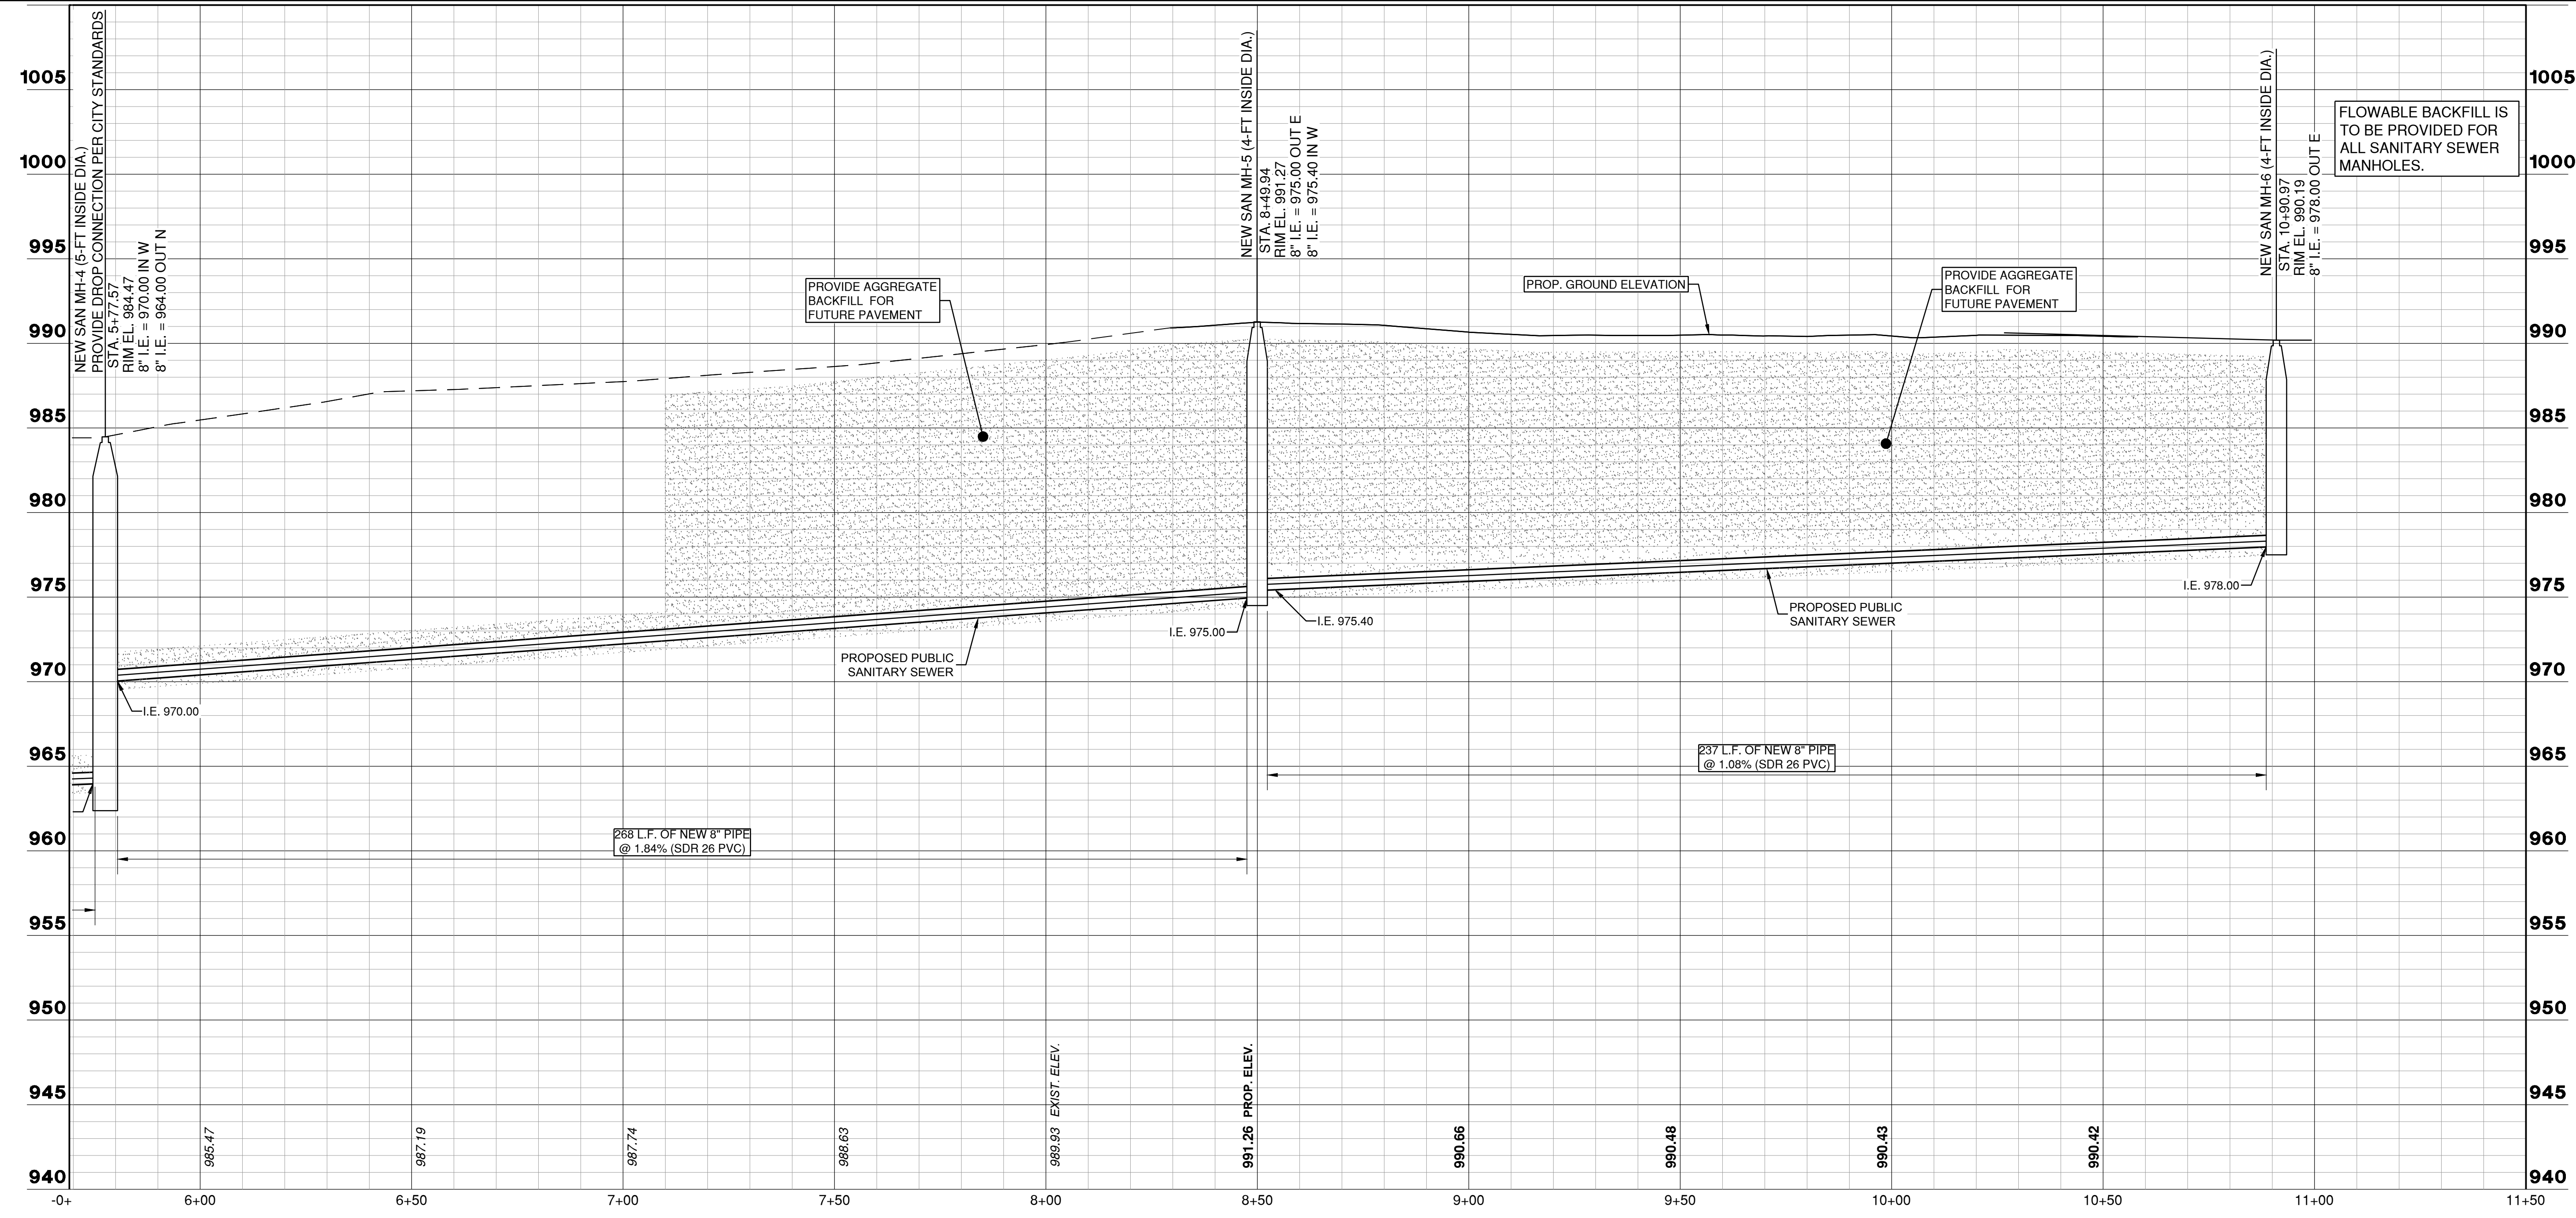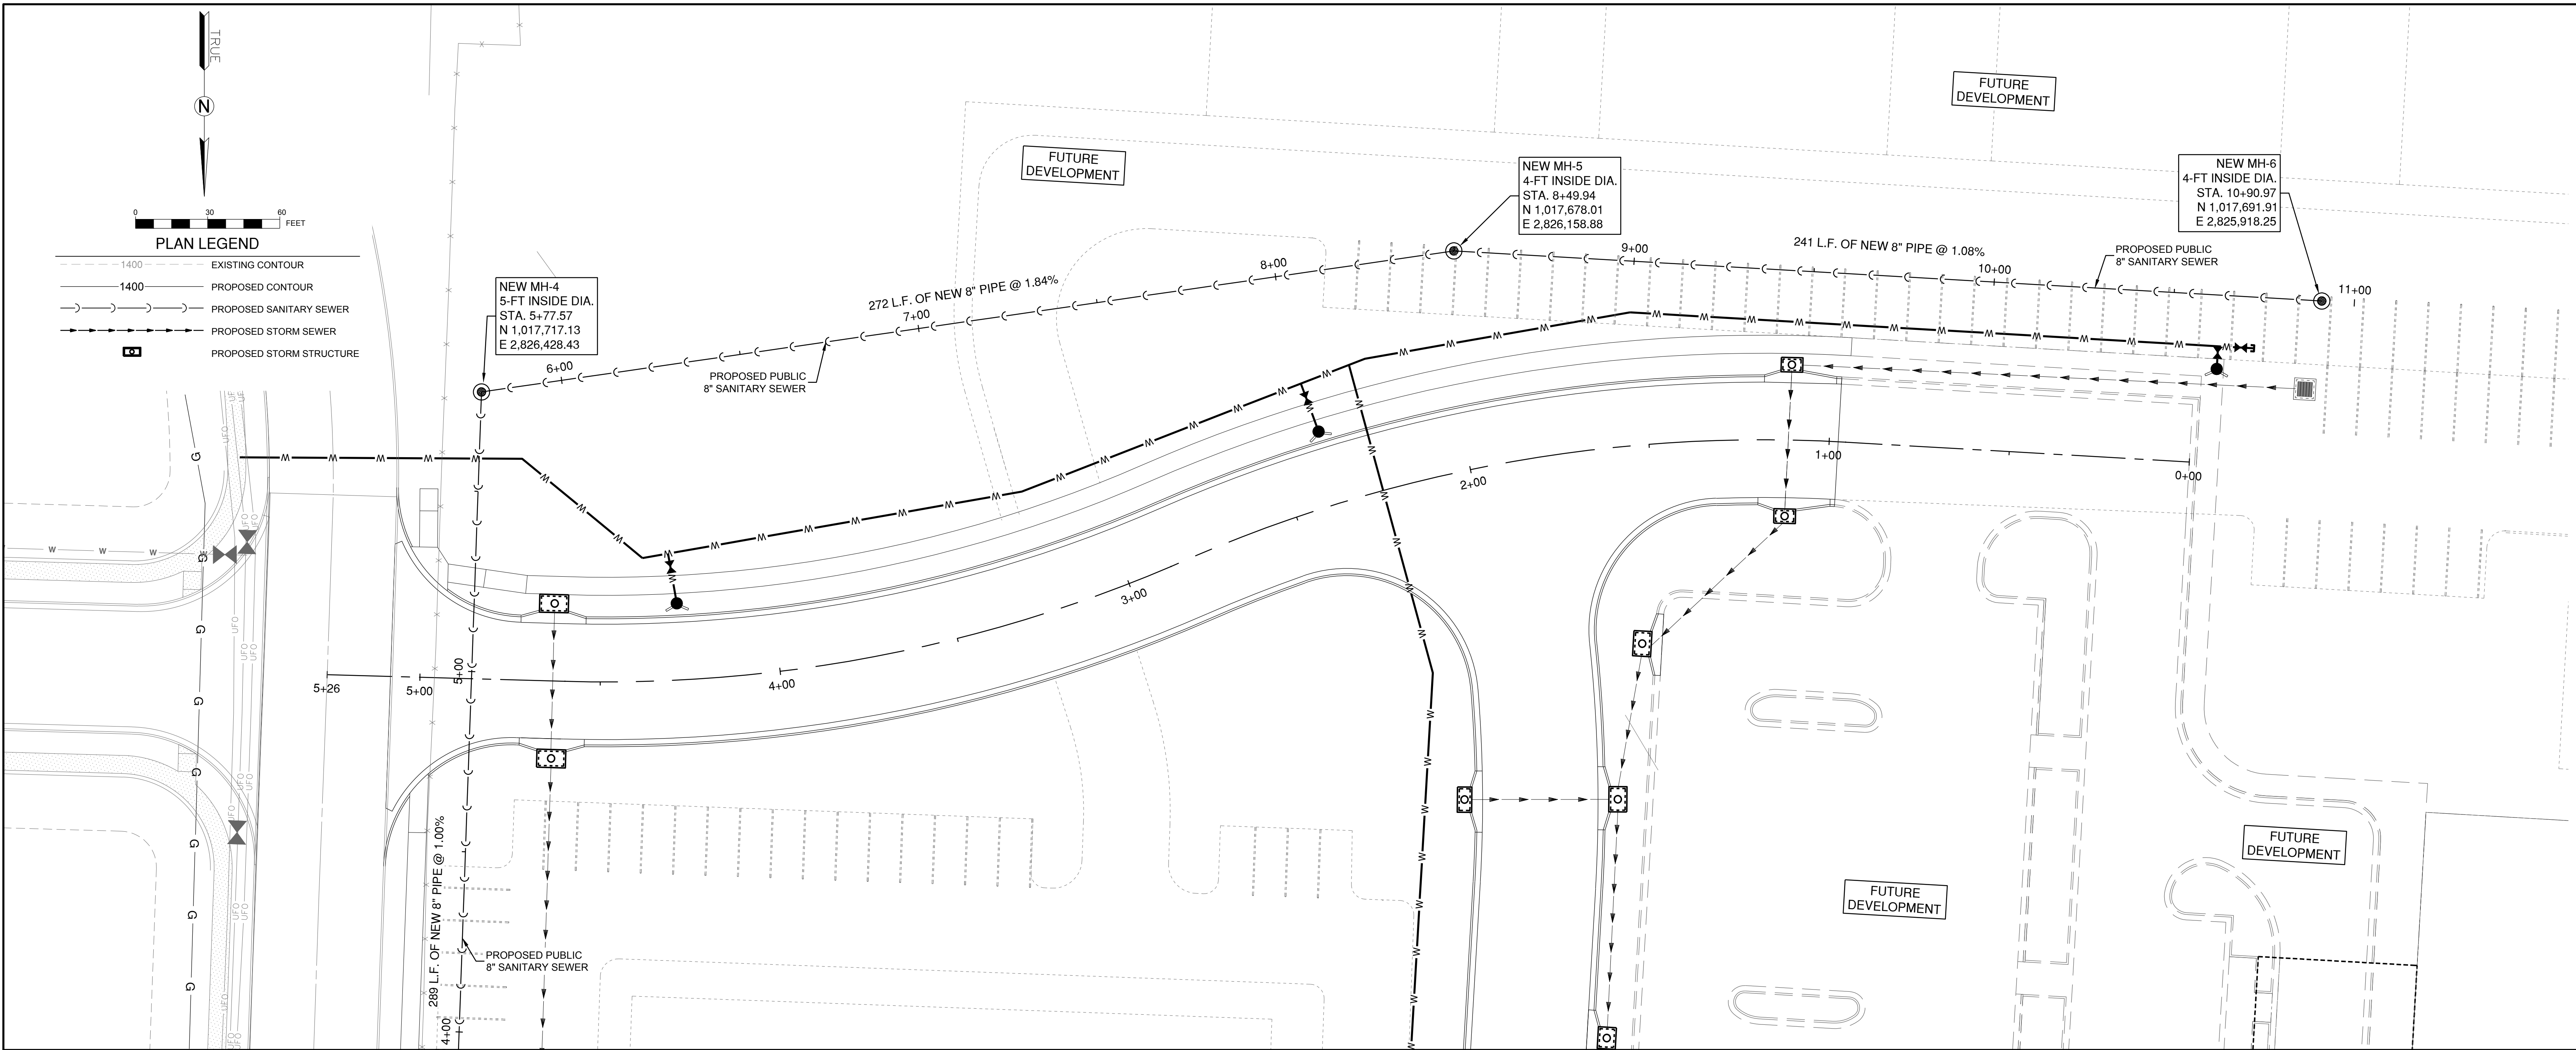

1627 MAIN STREET, SUITE 600  
KANSAS CITY, MO 64108



1627 MAIN STREET, #100  
KANSAS CITY, MO 64108



1301 BURLINGTON STREET  
NORTH KANSAS CITY, MO 64116

**LEE'S SUMMIT MUNICIPAL AIRPORT**  
**LEE'S SUMMIT, MISSOURI**  
**EASTSIDE DEVELOPMENT**  
**CITY PROJECT NO. - 47732472**



LEE'S SUMMIT MUNICIPAL AIRPORT  
LEE'S SUMMIT, MO

MARK	DATE	DESCRIPTION

PROJECT NO: 47732472  
CAD DWG FILE: SANITARY PLAN & PROFILES  
DESIGNED BY: WLC  
DRAWN BY: WLC  
CHECKED BY: JRC  
APPROVED BY: TGH  
COPYRIGHT

SHEET TITLE  
**SANITARY PLAN & PROFILE - SHEET 3**

Path: K:\LinesSummitMO\22001238-00\DrawSheets\Sanitary Sewer\_Sheet\Sanitary Plan & Profiles.dwg  
Date: Wednesday, January 3, 2024 10:28:16

