




MAYER
DESIGN
GROUP
P.C.

4400 South Lindbergh Blvd.
Suite 3
St. Louis, Missouri
63127-1603

Telephone: (314) 849-8777
Facsimile: (314) 849-4743

Email Address
mayerdesigngroup@earthlink.net

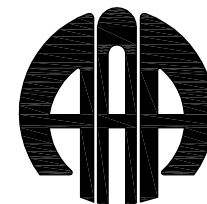

**Adams
Architectural
Associates**

P.O. BOX 230
CHESTERFIELD, MO
63306-0230
(636)537-9333
(536)537-1267 -FAX

ADAMS ARCHITECTURAL ASSOCIATES, P.C.
MISSOURI STATE CERTIFICATE OF
AUTHORITY # W00399708

THE PROFESSIONAL WHOSE SIGNATURE AND PERSONAL SEAL APPEARS ON THIS SHEET ASSUMES RESPONSIBILITY ON OR FOR WHAT APPEARS ON THIS SHEET AND DISCLAIMS (PURSUANT TO SECTION 327.411 (RSMO)) ANY RESPONSIBILITY FOR ALL OTHER PLANS, SPECIFICATIONS AND ESTIMATES, REPORTS OR OTHER DOCUMENTS OR INSTRUMENTS NOT SEALED BY THE UNDERSIGNED PROFESSIONAL RELATING OR INTENDED TO BE USED FOR ANY PART OR PARTS OF THE PROJECT TO WHICH THIS SHEET REFERS. RESPONSIBILITY FOR PORTIONS OF THE PROJECT NOT PREPARED UNDER SUPERVISION IS DISCLAIMED. REVISIONS BY CONTRACTOR, OWNER, OR OTHERS ARE NOT A PART OTHER PROJECT WHICH THIS SEAL INDICATES RESPONSIBILITY.

Seal

Project Code

CCW-2201

Project Title

New Car Wash

for

COWBOY
EXPRESS
CARWASH

210 MO-150
LEE SUMMIT, MISSOURI
64082


Drawing Title

Site Lighting Plan

Date	Drawn	Checked
03-15-23	DB/mm	MM/MA

Drawing Number

SL-1

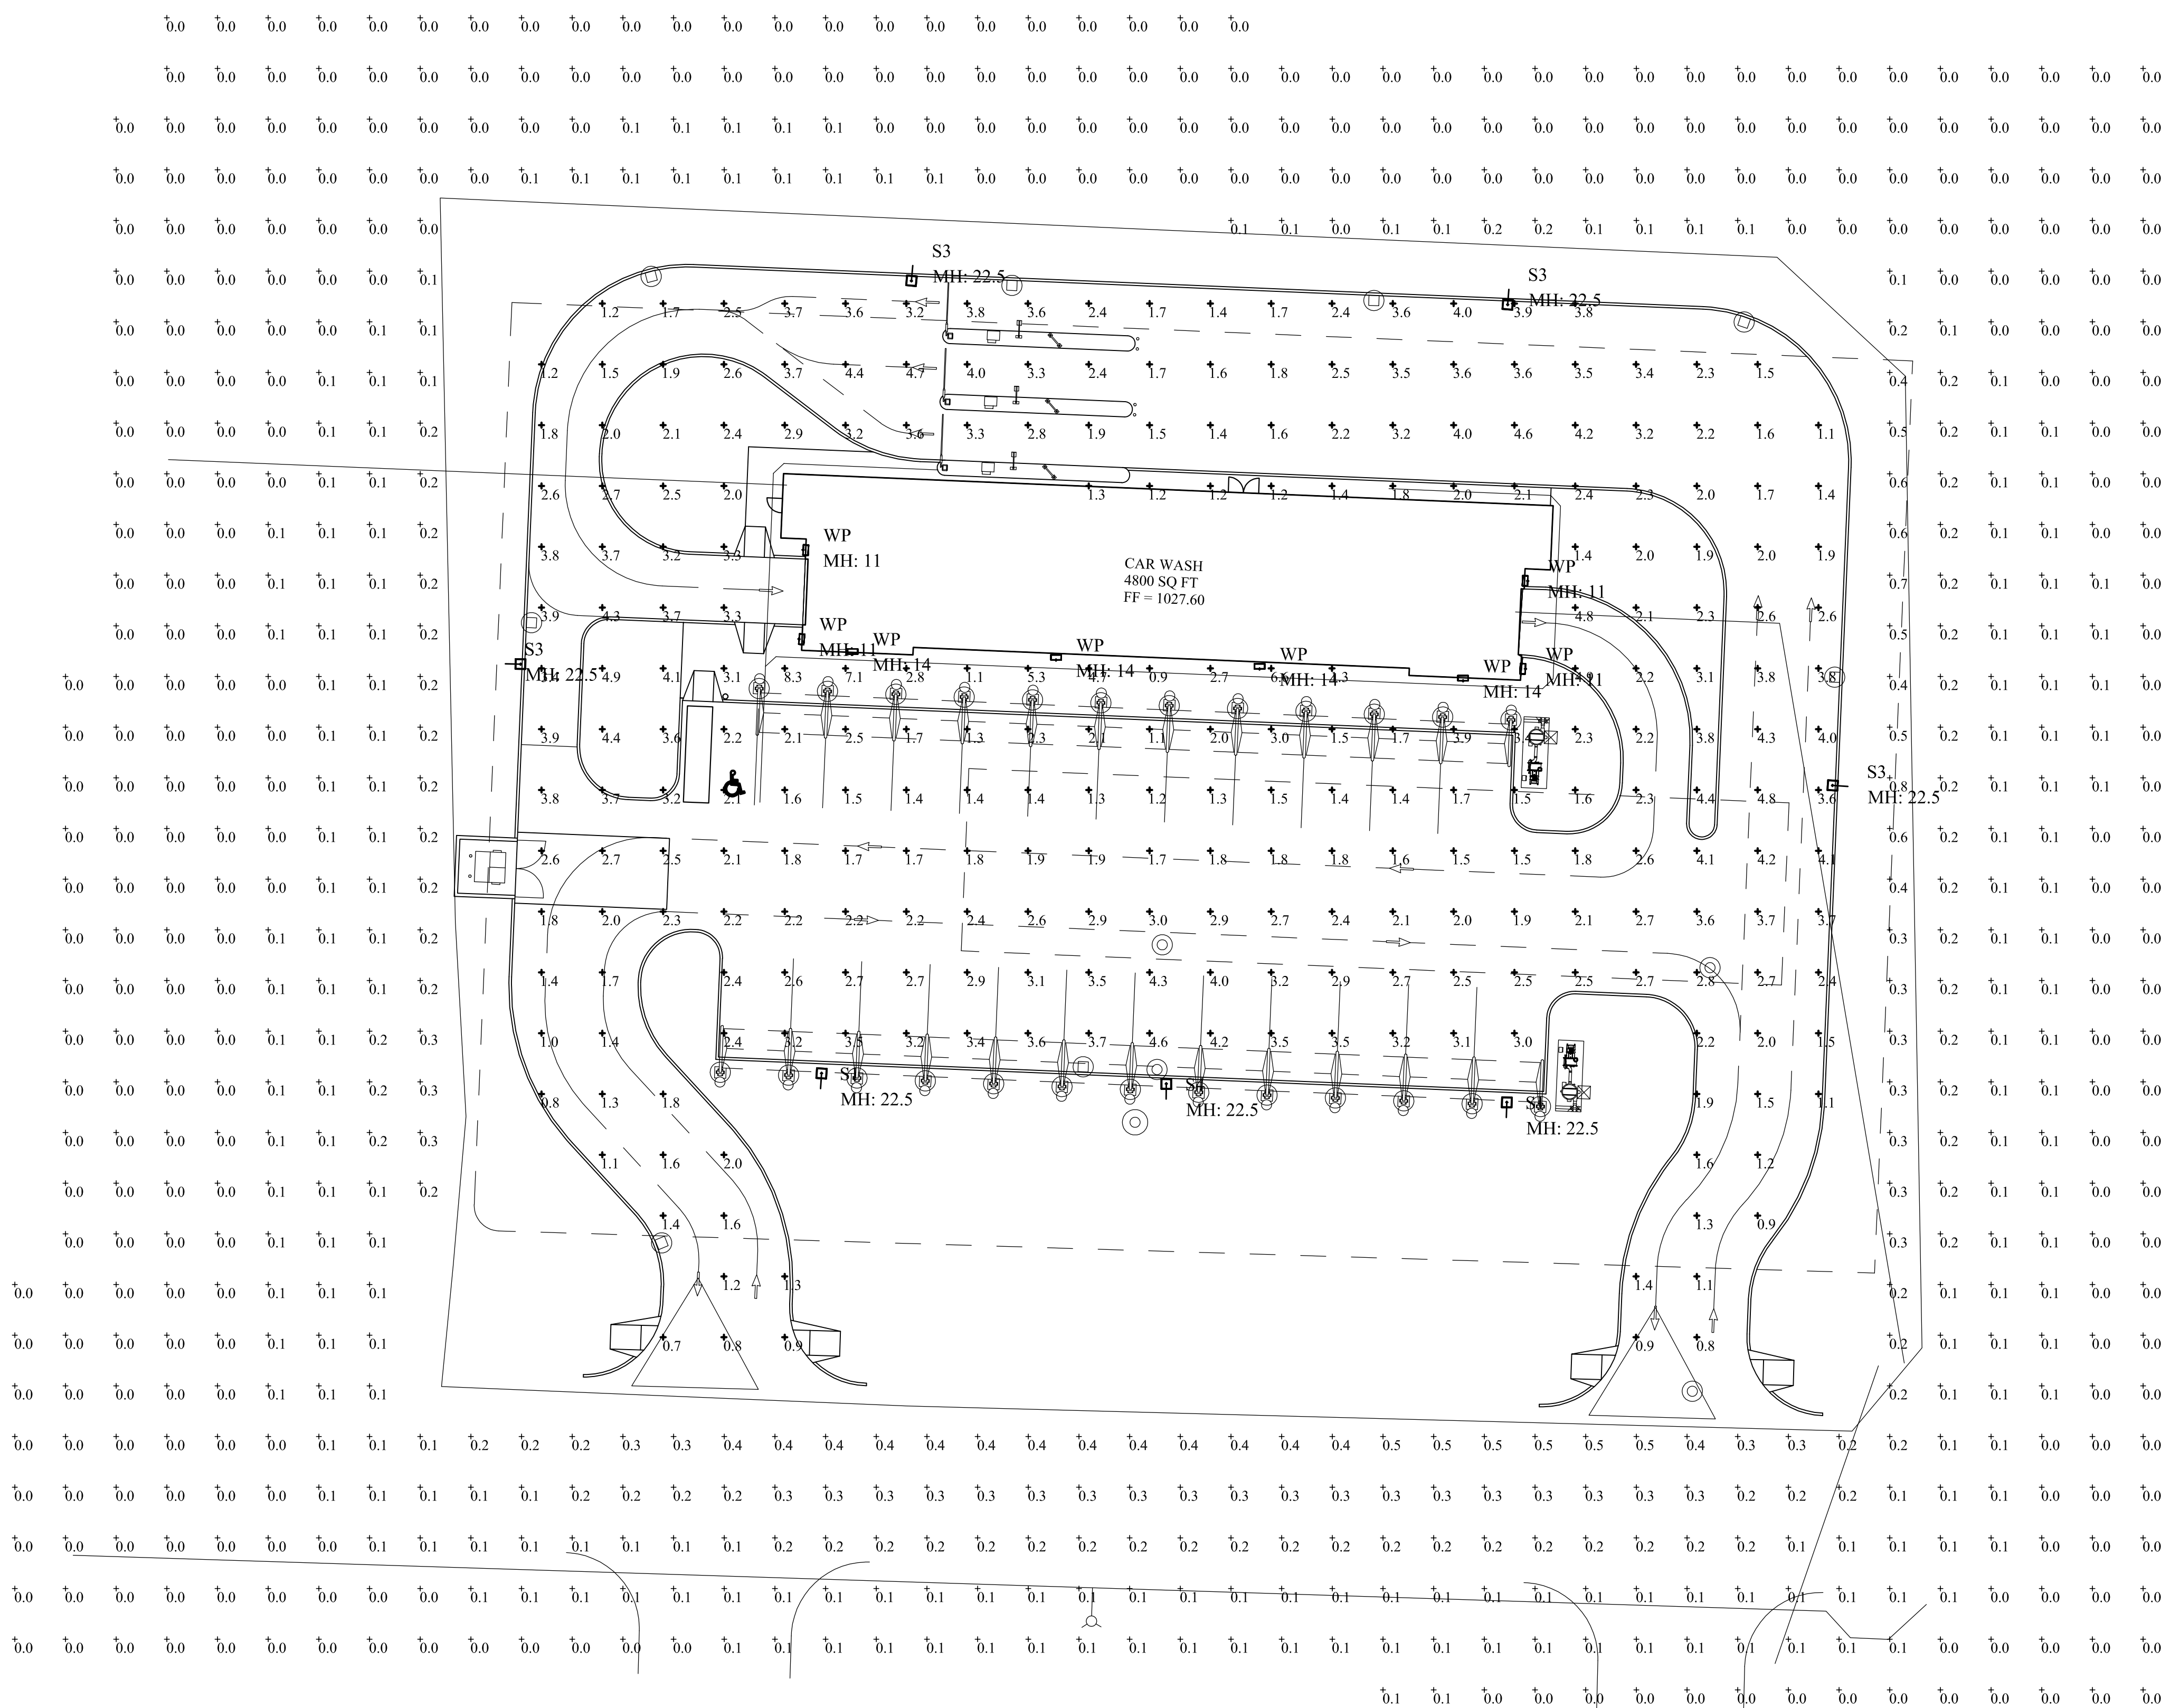

POLE FIXTURES MOUNTED ON 20' POLE & 2.5' BASE
LIGHT LEVEL CALCULATED ON THE GROUND

Calculation Summary							
Label	CalcType	Units	Avg	Max	Min	Avg/Min	Max/Min
S	Illuminance	Fc	0.08	0.8	0.0	N.A.	N.A.
SITE	Illuminance	Fc	2.55	8.3	0.7	3.6	11.9

Luminaire Schedule							
Symbol	Qty	Label	Arrangement	LLF	Lum. Watts	Total Watts	Description
	2	S1	SINGLE	0.900	172	344	PRV-XL-PA3A-740-U-5WQ
	4	S3	SINGLE	0.900	172	688	PRV-XL-PA3A-740-U-T3-ISS
	1	S4	SINGLE	0.900	172	172	PRV-XL-PA3A-740-U-T4W-ISS
	8	WP	SINGLE	0.900	25.5	204	XTOR3B-W

DESIGN IS BASED ON CURRENT INFORMATION PROVIDED AT THE TIME OF REQUEST. ANY CHANGES IN MOUNTING HEIGHT OR LOCATION, LAMP WATTAGE, LAMP TYPE, AND EXISTING FIELD CONDITIONS, THAT EFFECT ANY OF THE PREVIOUSLY MENTIONED, WILL VOID CURRENT LAYOUT AND REQUIRE A CHANGE REQUEST AND RECALCULATION.

A

SITE LIGHTING PLAN

SITEPLN.DWG

$$I'' = 2\phi' - \phi'$$