



1627 MAIN STREET, SUITE 600
KANSAS CITY, MO 64108



1627 MAIN STREET, #100
KANSAS CITY, MO 64108

KANSAS CITY - LEE'S SUMMIT
REGIONAL AIRPORT
LEE'S SUMMIT, MISSOURI
GENERAL AVIATION TERMINAL
CITY PROJECT NO. - 17932172



LEE'S SUMMIT MUNICIPAL AIRPORT
LEE'S SUMMIT, MO

2/12/25 CODE RESUBMITTAL

MARK DATE DESCRIPTION



PROJECT NO.: 17932172
CAD DWG FILE: UTILITY PLAN
DESIGNED BY: WLC
DRAWN BY: WLC
CHECKED BY: PHN
APPROVED BY: BB
COPYRIGHT

SHEET TITLE

UTILITY PLAN 1 OF 2

C119

SHEET 026 OF 133

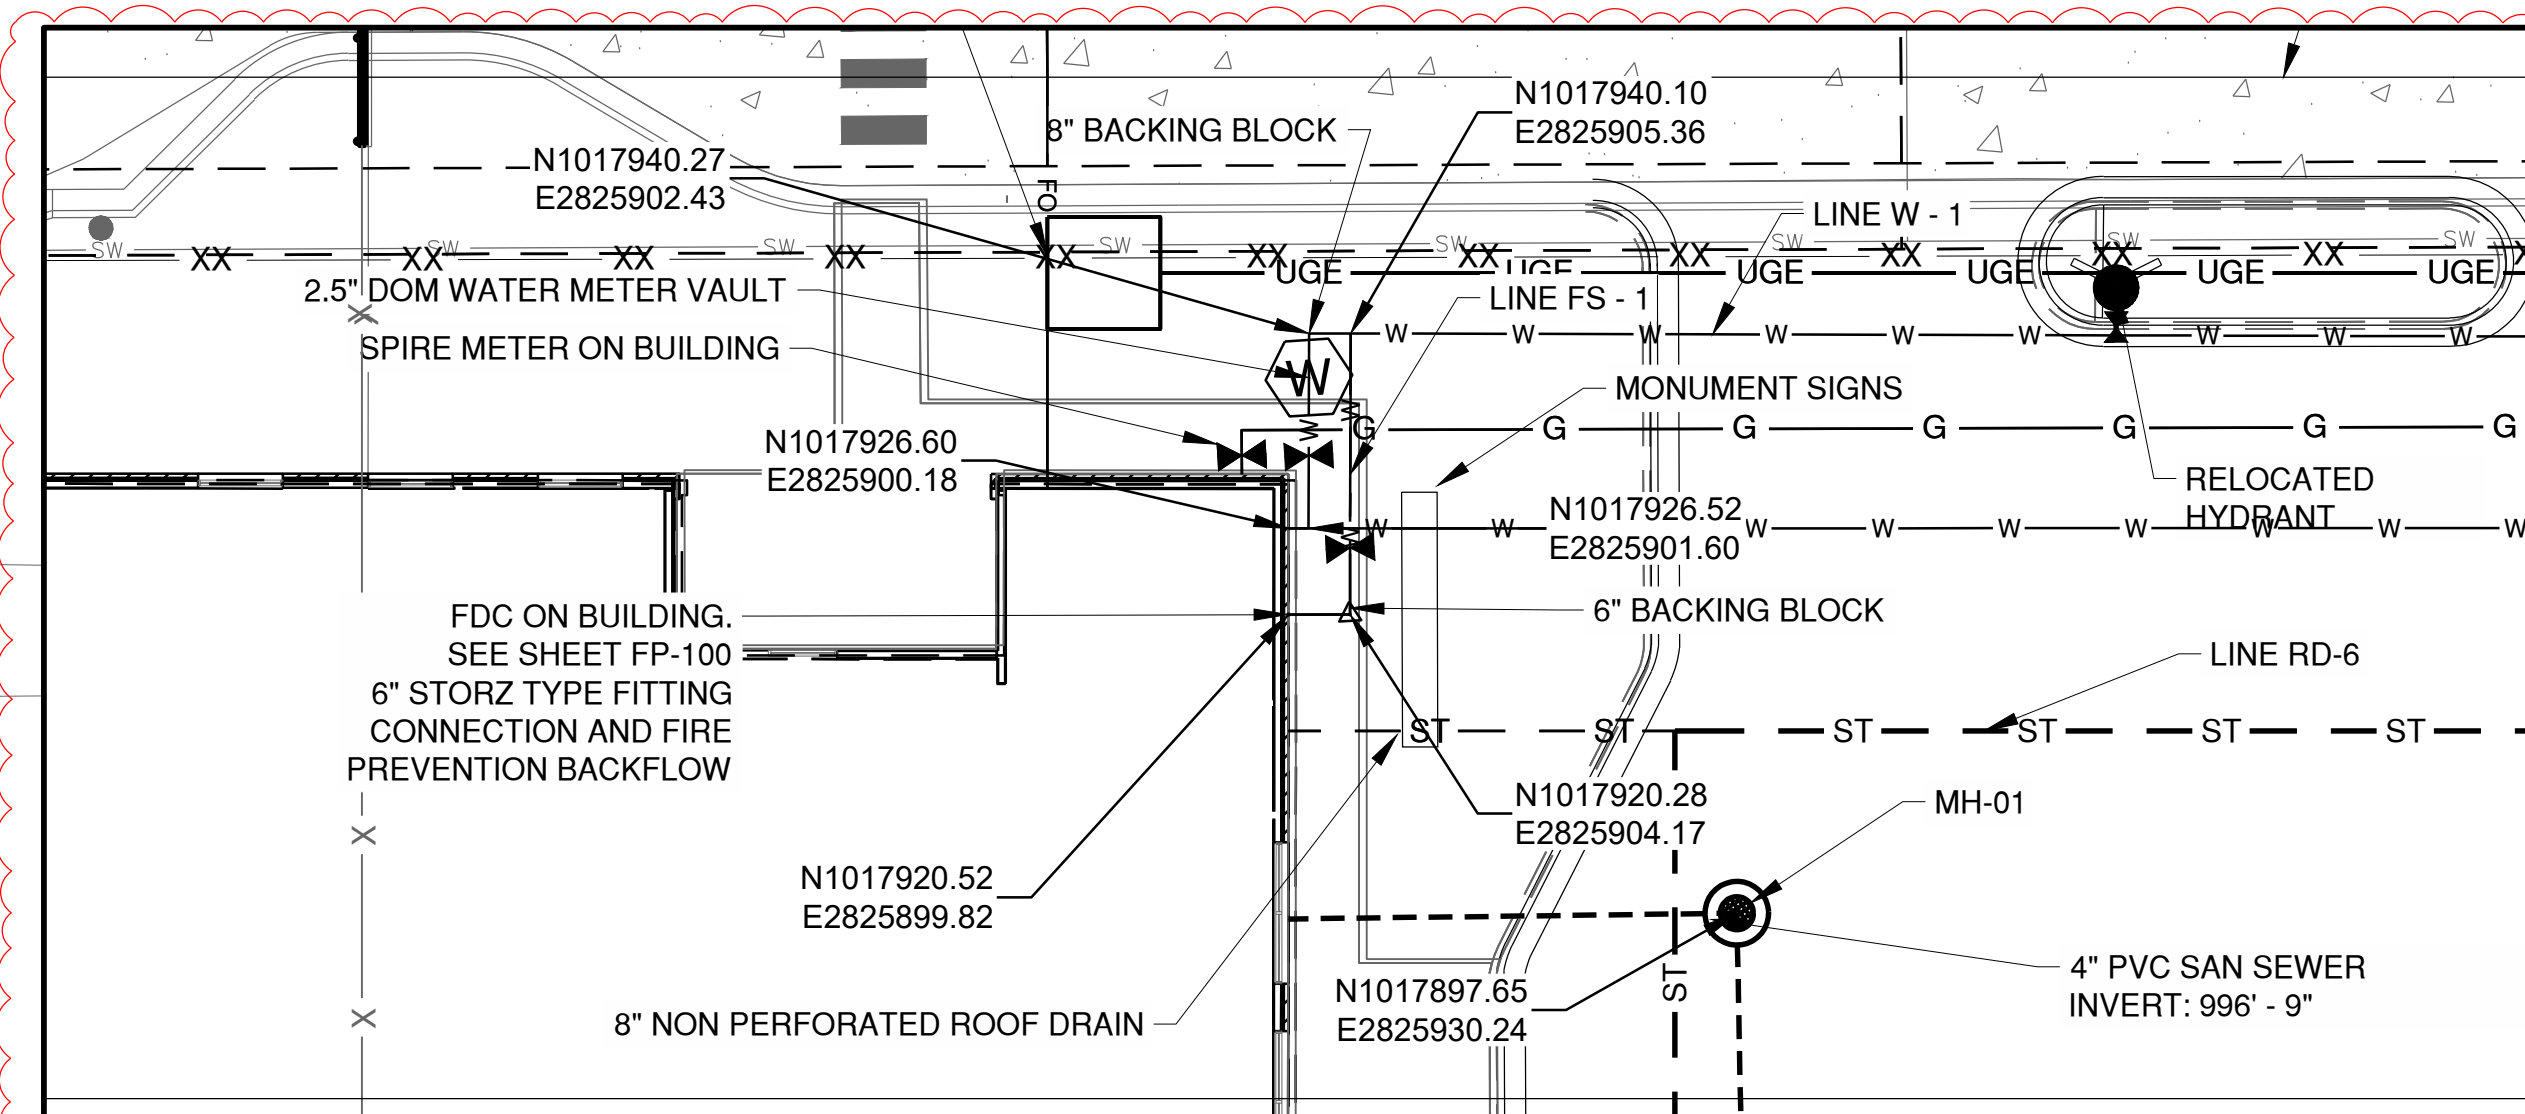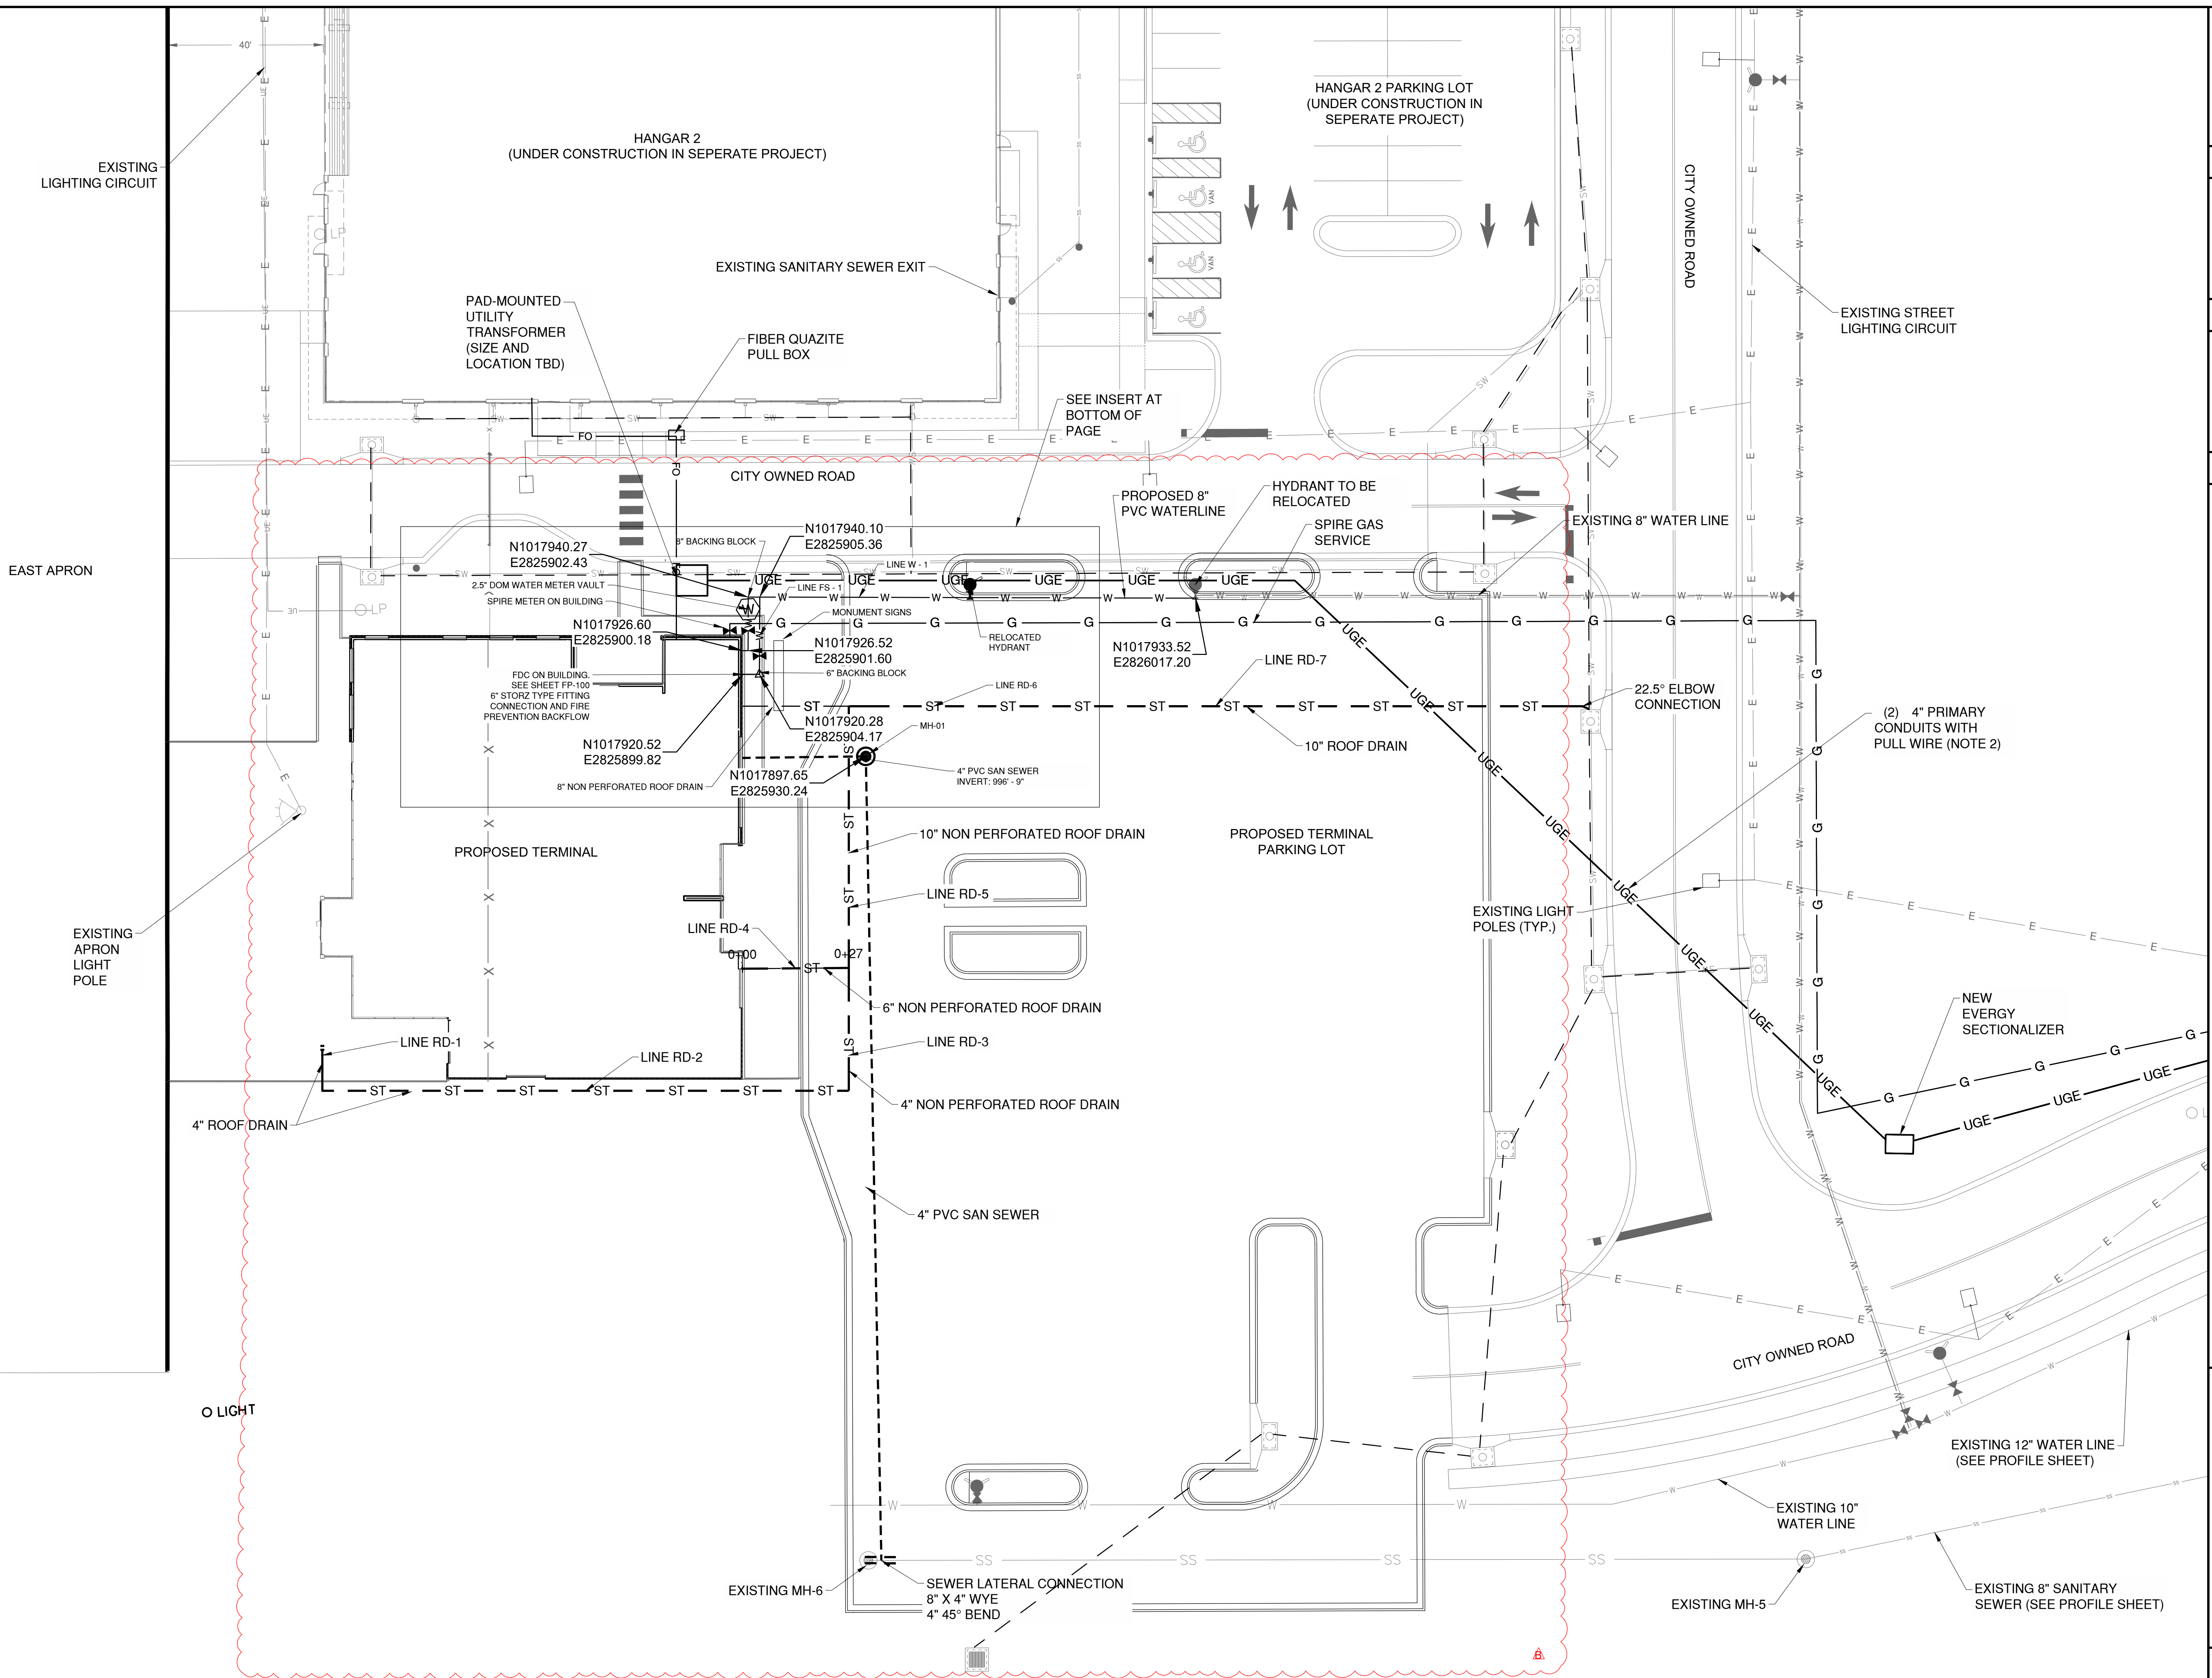

UTILITY PLAN LEGEND

UGE	UGE	EXISTING UNDERGROUND ELECTRIC
FO	FO	EXISTING FIBER OPTIC LINE
G	G	EXISTING GAS
W	W	EXISTING SANITARY SEWER
C	C	EXISTING WATER MAIN
W	W	EXISTING COMMUNICATIONS LINE
W	W	PROPOSED WATER SERVICE
W	W	PROPOSED SANITARY SEWER SERVICE
FO	FO	PROPOSED FIBER OPTIC LINE
ST	ST	PROPOSED STORM SEWER
UGE	UGE	PROPOSED UNDERGROUND ELECTRIC
E	E	PROPOSED STREET LIGHT CIRCUIT
G	G	PROPOSED GAS SERVICE
S	S	EXISTING STORM INLET
SM	SM	EXISTING SANITARY SEWER MANHOLE
LP	LP	EXISTING LIGHTPOLE
FD	FD	PROPOSED FIRE HYDRANT
V	V	PROPOSED VALVE
WM	WM	PROPOSED WATER METER
H	H	PROPOSED HANDHOLE
LP	LP	PROPOSED LIGHT POLE

UTILITY NOTES


- CONTRACTOR SHALL COORDINATE ALL ELECTRIC SERVICE INSTALLATION WORK WITH EVERGY.
- CONTRACTOR TO INSTALL PRIMARY CONDUITS WITH PULL STRING FOR NEW ELECTRIC SERVICE. EVERGY TO INSTALL PRIMARY CONDUCTORS AND TERMINATE AT NEW PAD-MOUNTED TRANSFORMER.
- TO FEDERAL, STATE, AND LOCAL STATUTES, NOTIFY MISSOURI ONE-CALL SYSTEM, INC. AT LEAST 48 HOURS PRIOR TO ANY DIGGING, TRENCHING, EXCAVATION, ETC.
- FIELD VERIFY LOCATION OF ALL UTILITIES PRIOR TO BEGINNING WORK. ANY INTERFERENCE SHALL BE BROUGHT TO ATTENTION OF THE ARCHITECT AND ENGINEER FOR DIRECTION.



UTILITY DISCLAIMER

INFORMATION SHOWN ON THIS DRAWING CONCERNING TYPE AND LOCATION OF UNDERGROUND AND OTHER UTILITIES IS NOT GUARANTEED TO BE ACCURATE OR ALL INCLUSIVE. CONTRACTORS ARE RESPONSIBLE FOR MAKING THEIR OWN DETERMINATION AS TO THE TYPE AND LOCATION OF UTILITIES AS MAY BE NECESSARY TO AVOID DAMAGE THERETO. INFORMATION SHOWN IS FROM MAPS PROVIDED OR DISCOVERED FROM UTILITY PROVIDERS.

Path: K:\leessummit\mo2201236-00\Draw Sheets\ga terminal design sheets\Utility Profiles - GA.dwg
Date: Monday, April 15, 2024 2:13:05 PM

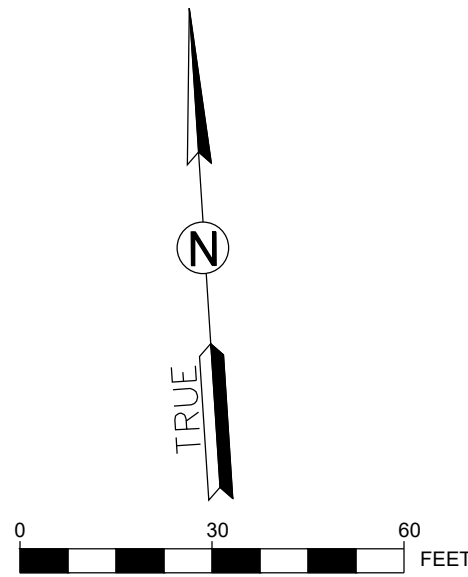

1627 MAIN STREET, SUITE 600
KANSAS CITY, MO 64108



WELLNER
ARCHITECTS, INC

1627 MAIN STREET, #100
KANSAS CITY, MO 64108

KANSAS CITY - LEE'S SUMMIT
REGIONAL AIRPORT
LEE'S SUMMIT, MISSOURI
GENERAL AVIATION TERMINAL
CITY PROJECT NO. - 17932172



LEE'S SUMMIT MUNICIPAL AIRPORT
LEE'S SUMMIT, MO

2/12/25 CODE RESUBMITTAL

MARK	DATE	DESCRIPTION
------	------	-------------

PROJECT NO:	17932172
CAD DWG FILE:	UTILITY PROFILES - GA
DESIGNED BY:	WLC
DRAWN BY:	WLC
CHECKED BY:	PHN
APPROVED BY:	BB
COPYRIGHT	

SHEET TITLE


UTILITY PROFILE 1
OF 3

C121

SHEET 133 OF 133

LINE W - 1

Alignment - Terminal Building Water Line PROFILE

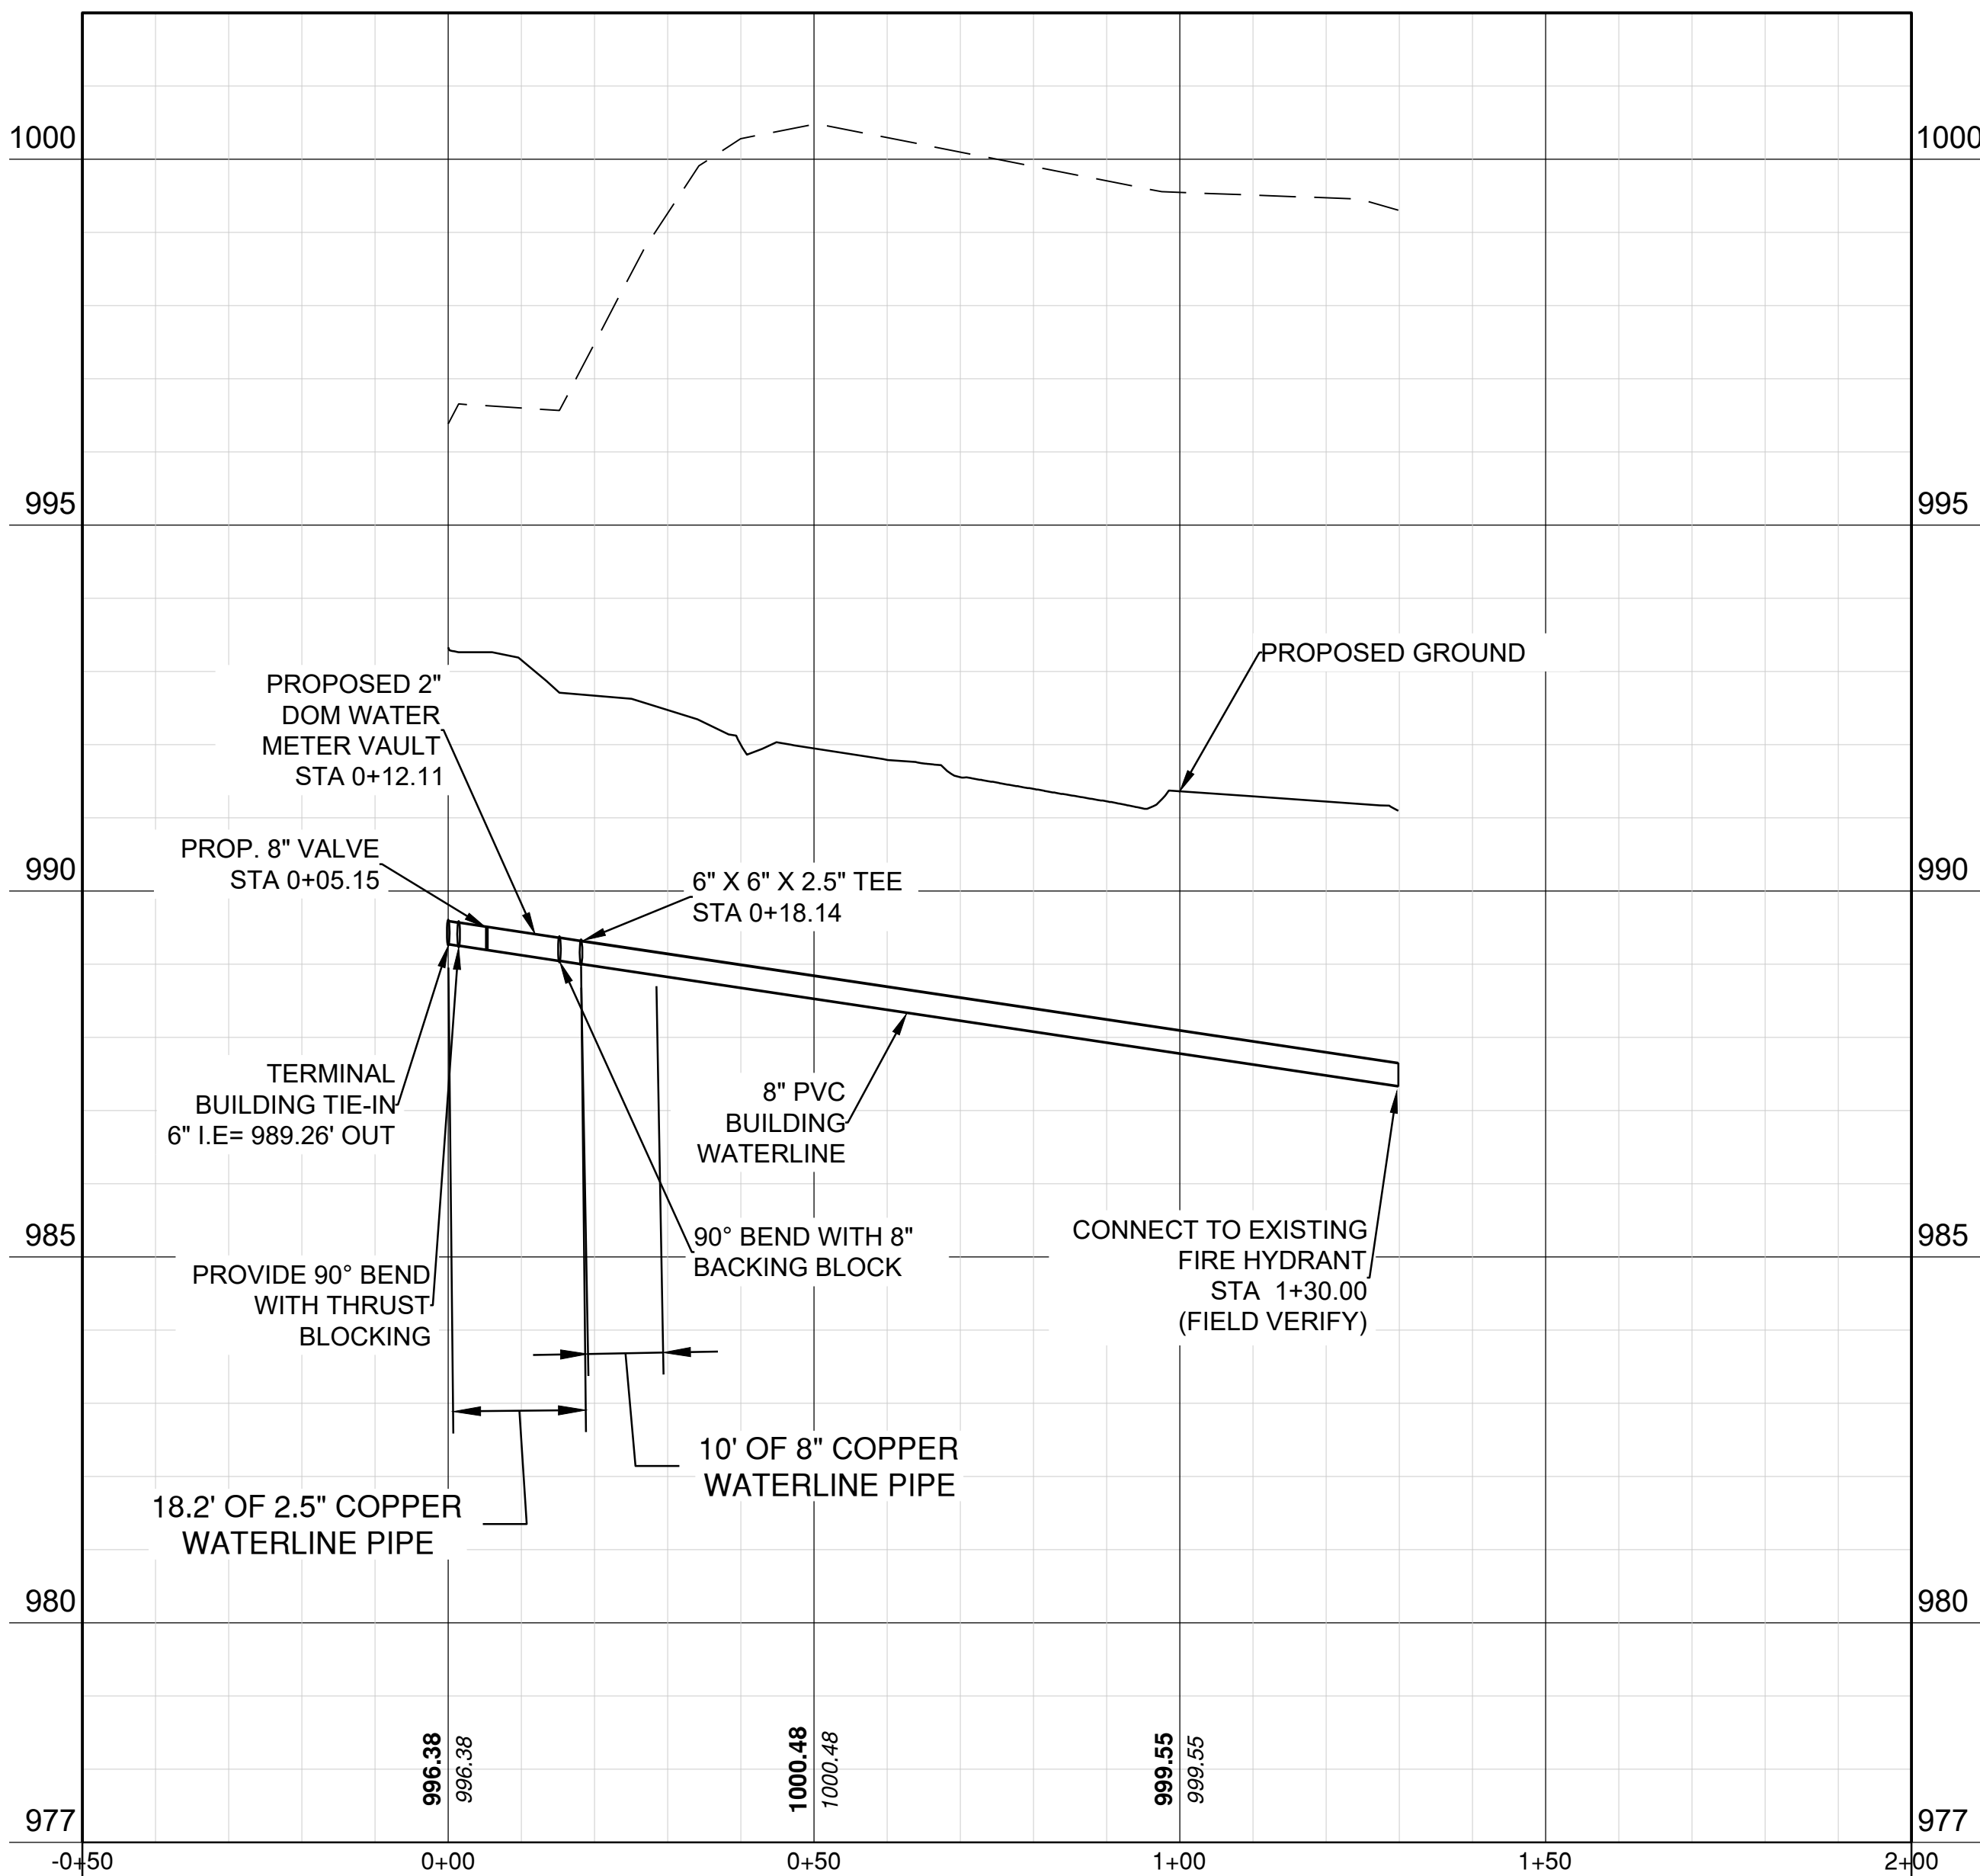

LINE FS - 1

Alignment - Fire Sprinkler PROFILE

